
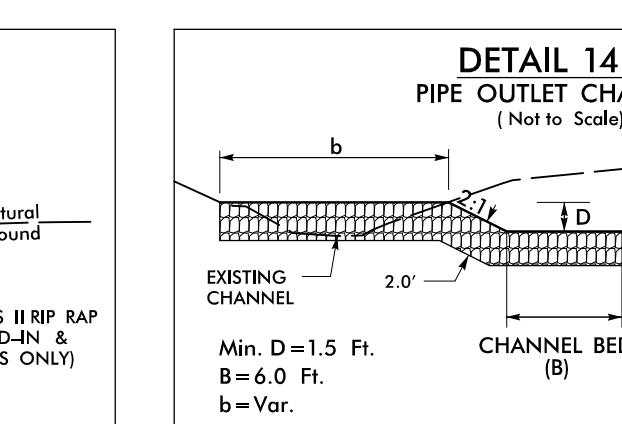
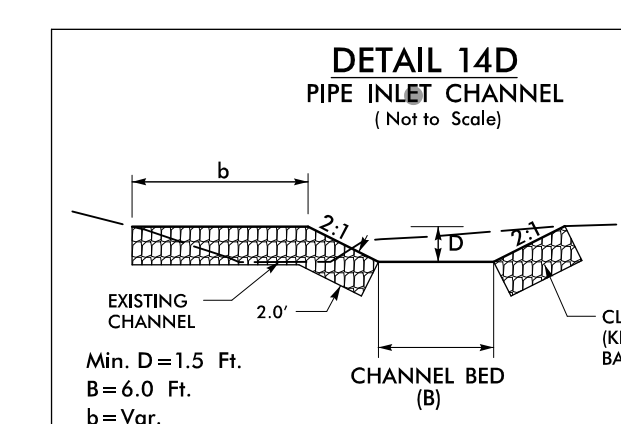
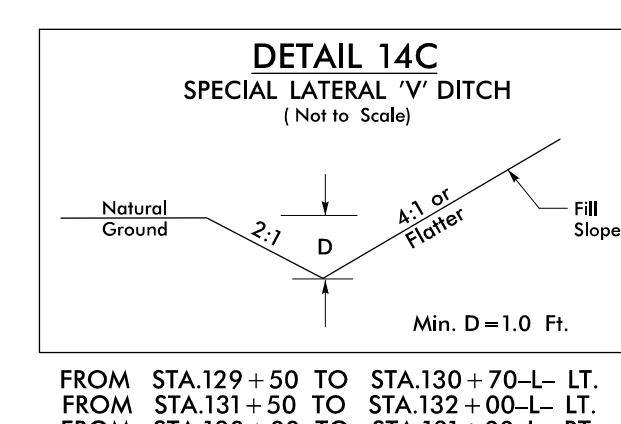
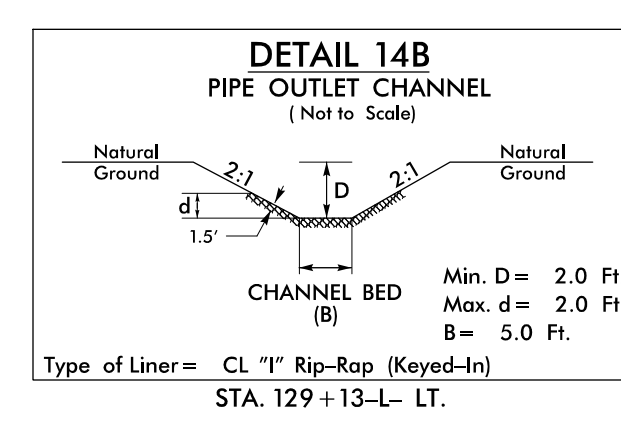
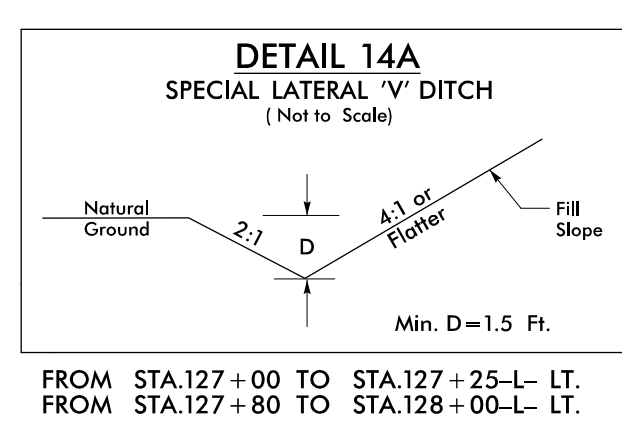




PROJECT REFERENCE NO.	SHEET NO.
A-0009CA	EC-14/CONST.14
RW SHEET NO.	
ROADWAY DESIGN ENGINEER	HYDRAULICS ENGINEER
 TGS ENGINEERS 201 W. MARION ST. STE 200 SHELBY, NC 28150 PH (704) 476-0003 CORP. LICENSE NO.: C-0275	

NAD 83 2017



MATCH LINE STA -L- 124+00.00
MATCH TO SHEET NO.13

MATCH LINE STA -L- 138+00.00
MATCH TO SHEET NO.15

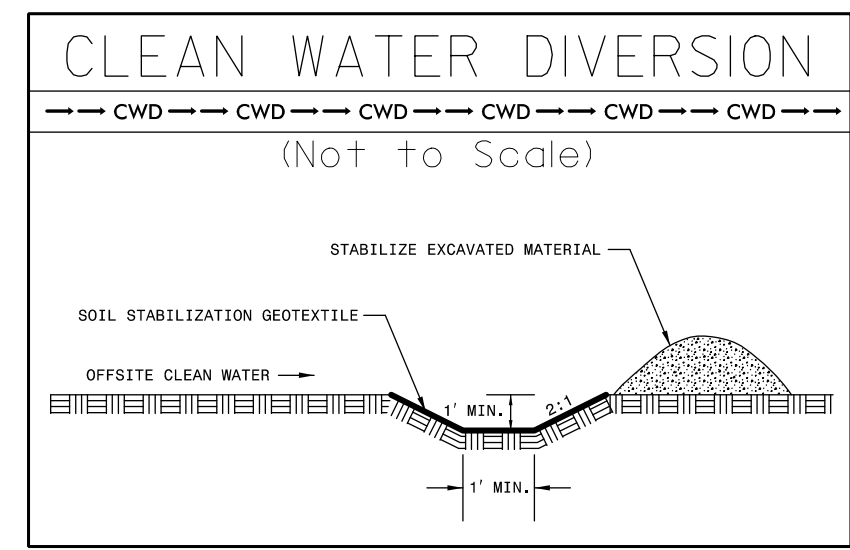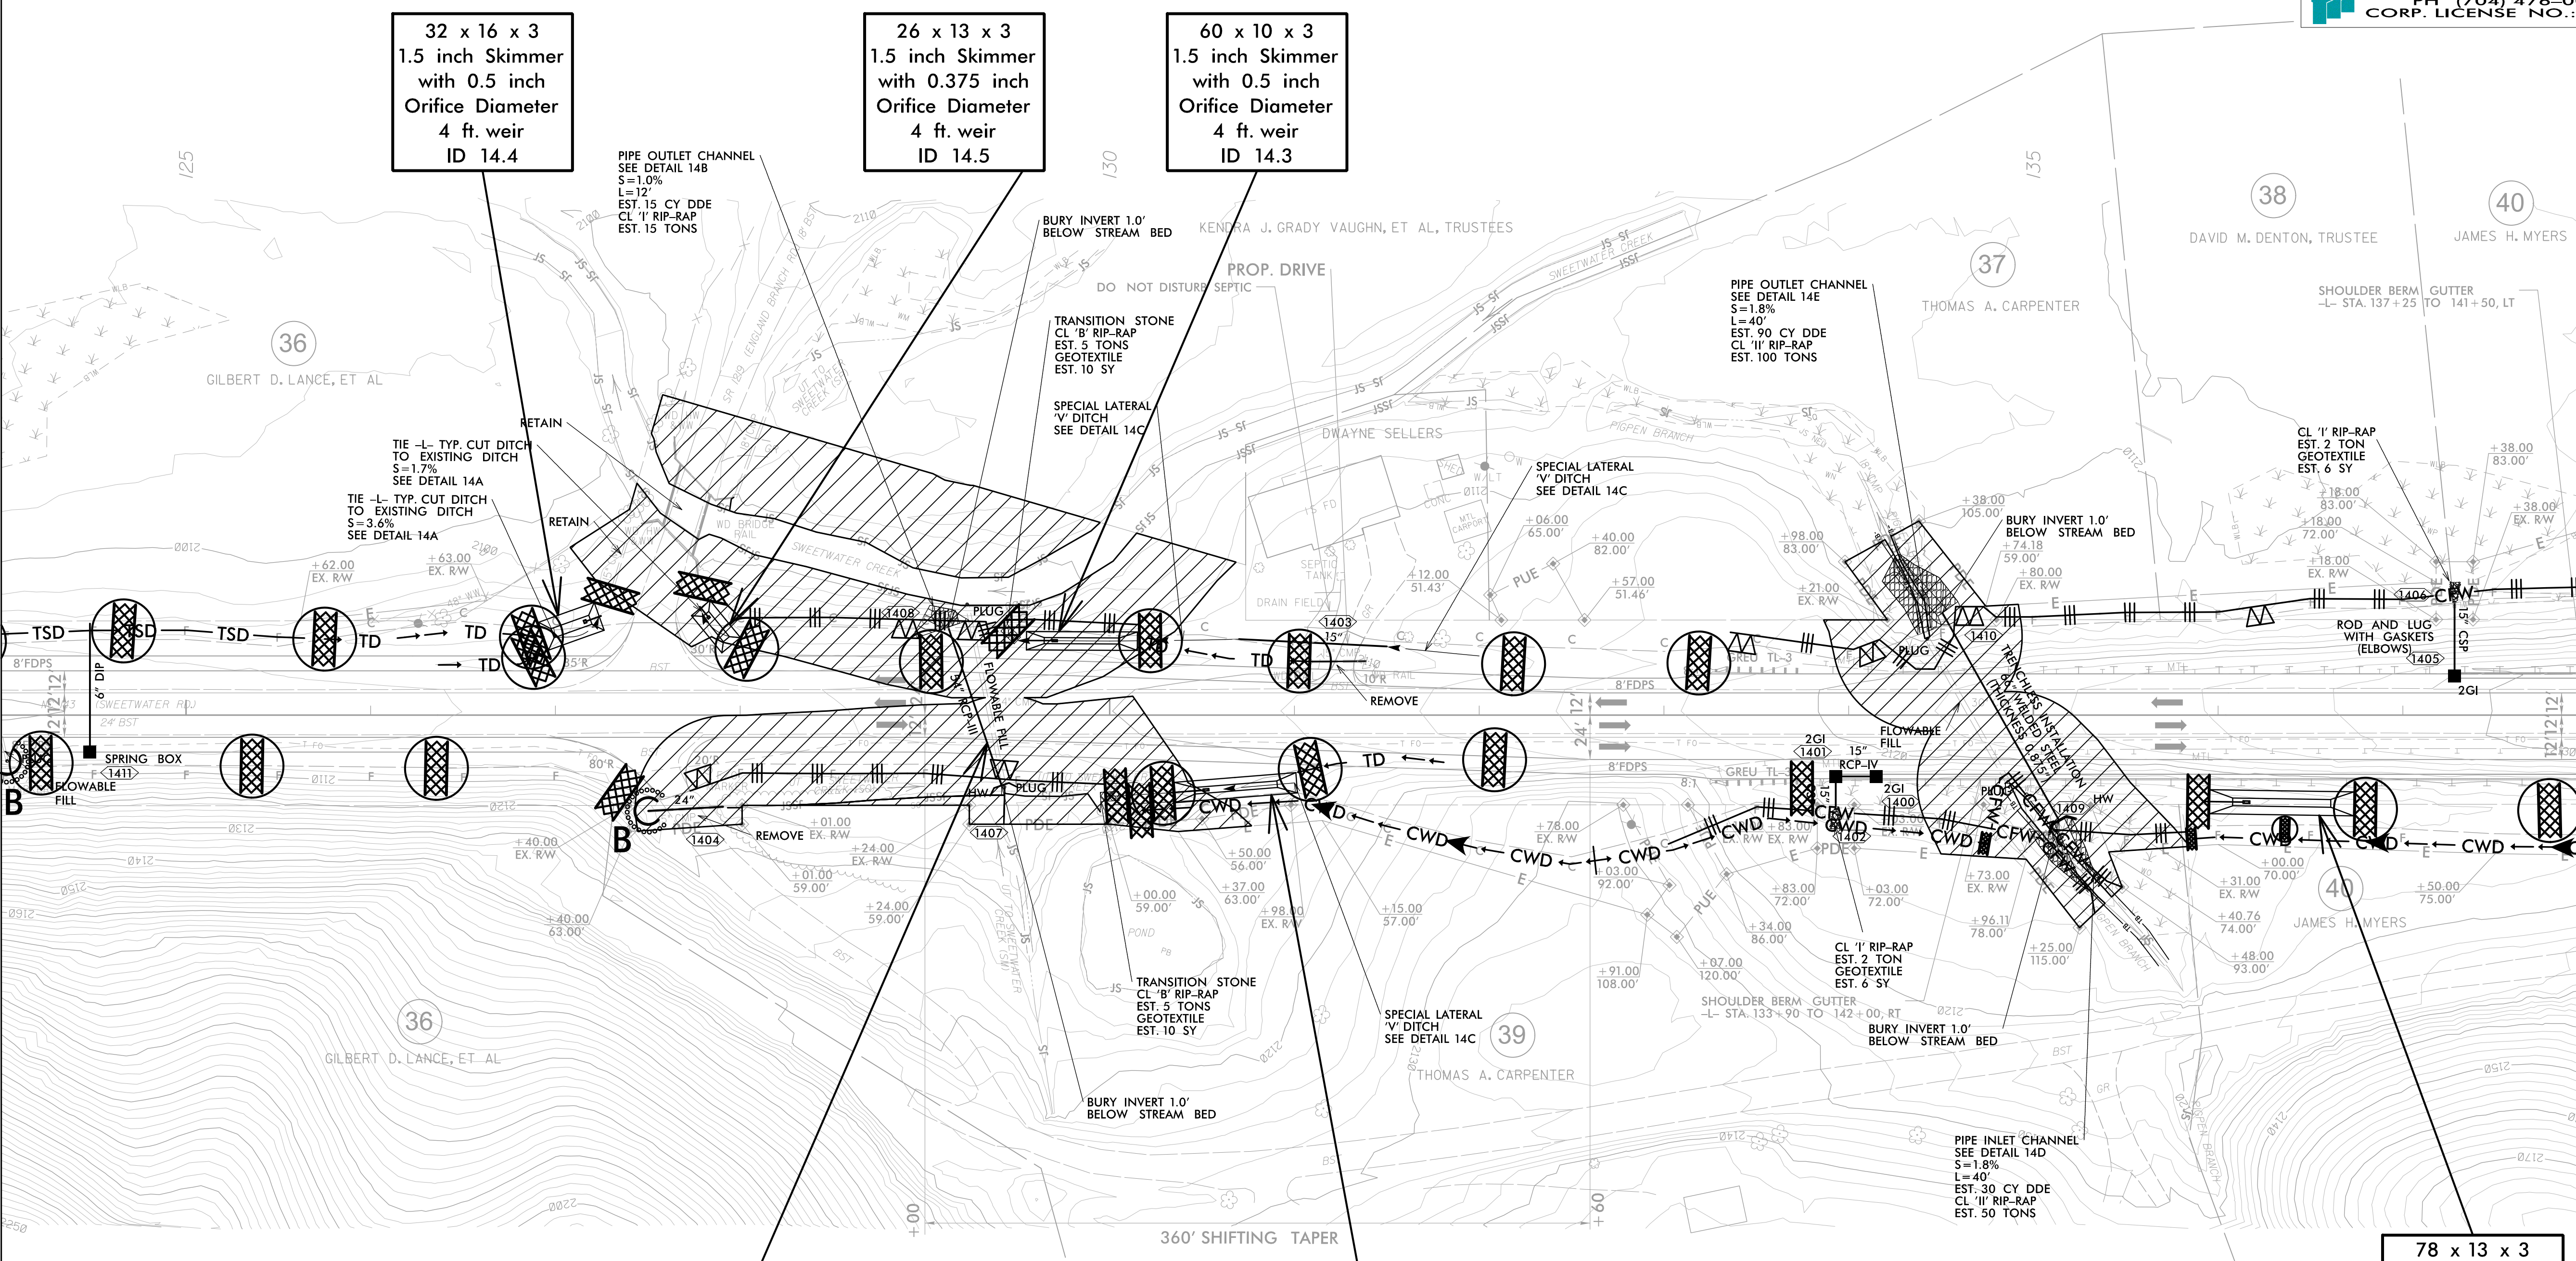

INSTALL PIPE PER THE PUMP
AROUND EXAMPLE (SHEET EC-2E)

66 x 11 x 3
1.5 inch Skimmer
with 0.625 inch
Orifice Diameter
4 ft. weir
ID 14.1

78 x 13 x 3
1.5 inch Skimmer
with 0.75 inch
Orifice Diameter
4 ft. weir
ID 14.2

CLEARING AND GRUBBING
EROSION CONTROL FOR
CONSTRUCTION SHEET 14

INSTALL PIPE(S) IN JURISDICTIONAL AREAS WITHOUT IMPACTING STREAM UNTIL
AREA STABILIZED AND ACCORDING TO NCDOT BEST MANAGEMENT
PRACTICES FOR CONSTRUCTION AND MAINTENANCE ACTIVITIES MANUAL.

NOTE:
PLACE TEMPORARY ROCK SEDIMENT DAMS TYPE - B
AND TEMPORARY ROCK SILT CHECKS TYPE - A AT
DRAINAGE OUTLETS.

 ENVIRONMENTALLY SENSITIVE AREA
SEE PROJECT SPECIAL PROVISIONS