
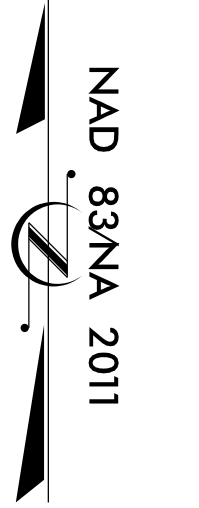


09/08/19

TIP PROJECT: A-0009CA

CONTRACT:

Project No. A-0009CA	Sheet No. Sig. 1.0
--------------------------------	------------------------------

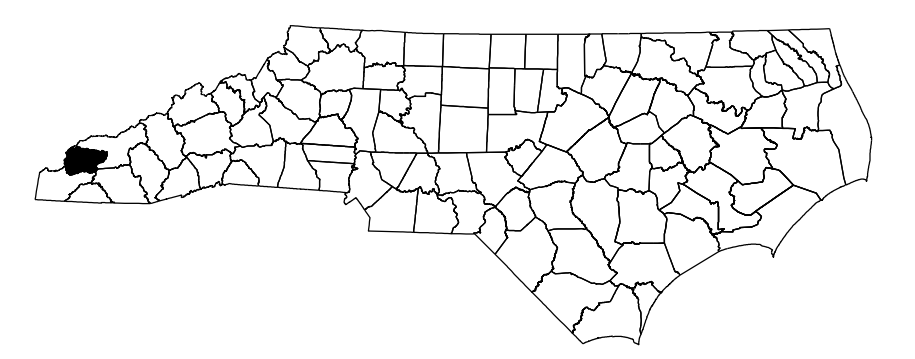


STATE OF NORTH CAROLINA
DIVISION OF HIGHWAYS


GRAHAM COUNTY

**LOCATION: NC 143 (SWEETWATER ROAD) IMPROVEMENTS
FROM US 129 (RODNEY ORR BYPASS)
TO SR 1223 (BEECH CREEK ROAD)**

TYPE OF WORK: TRAFFIC SIGNALS AND SIGNAL COMMUNICATION

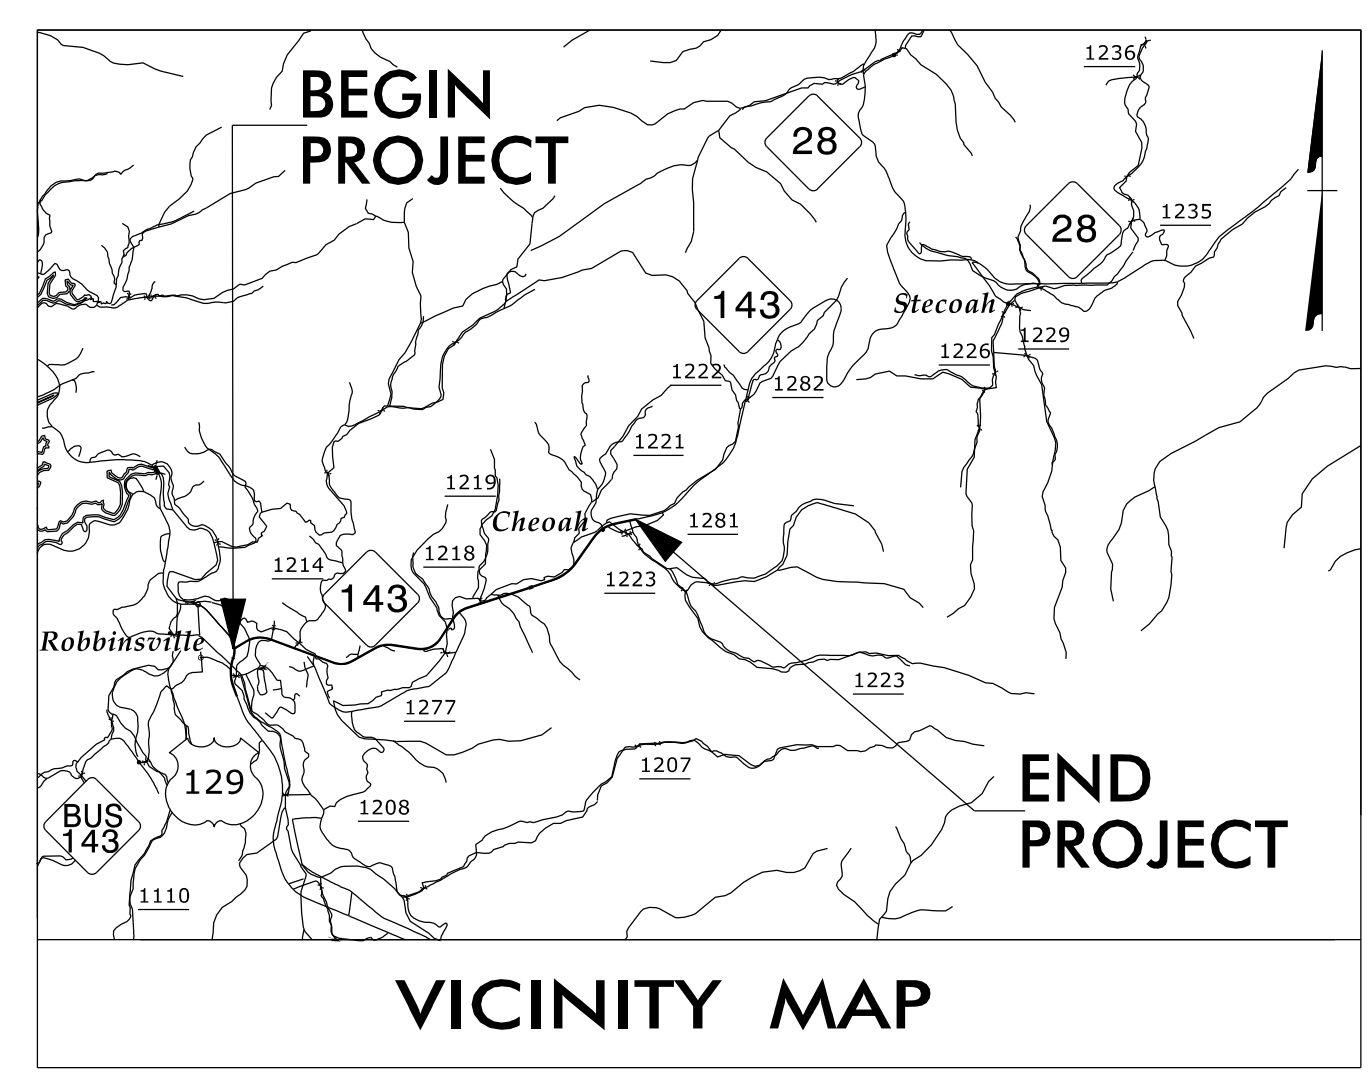

VICINITY MAP

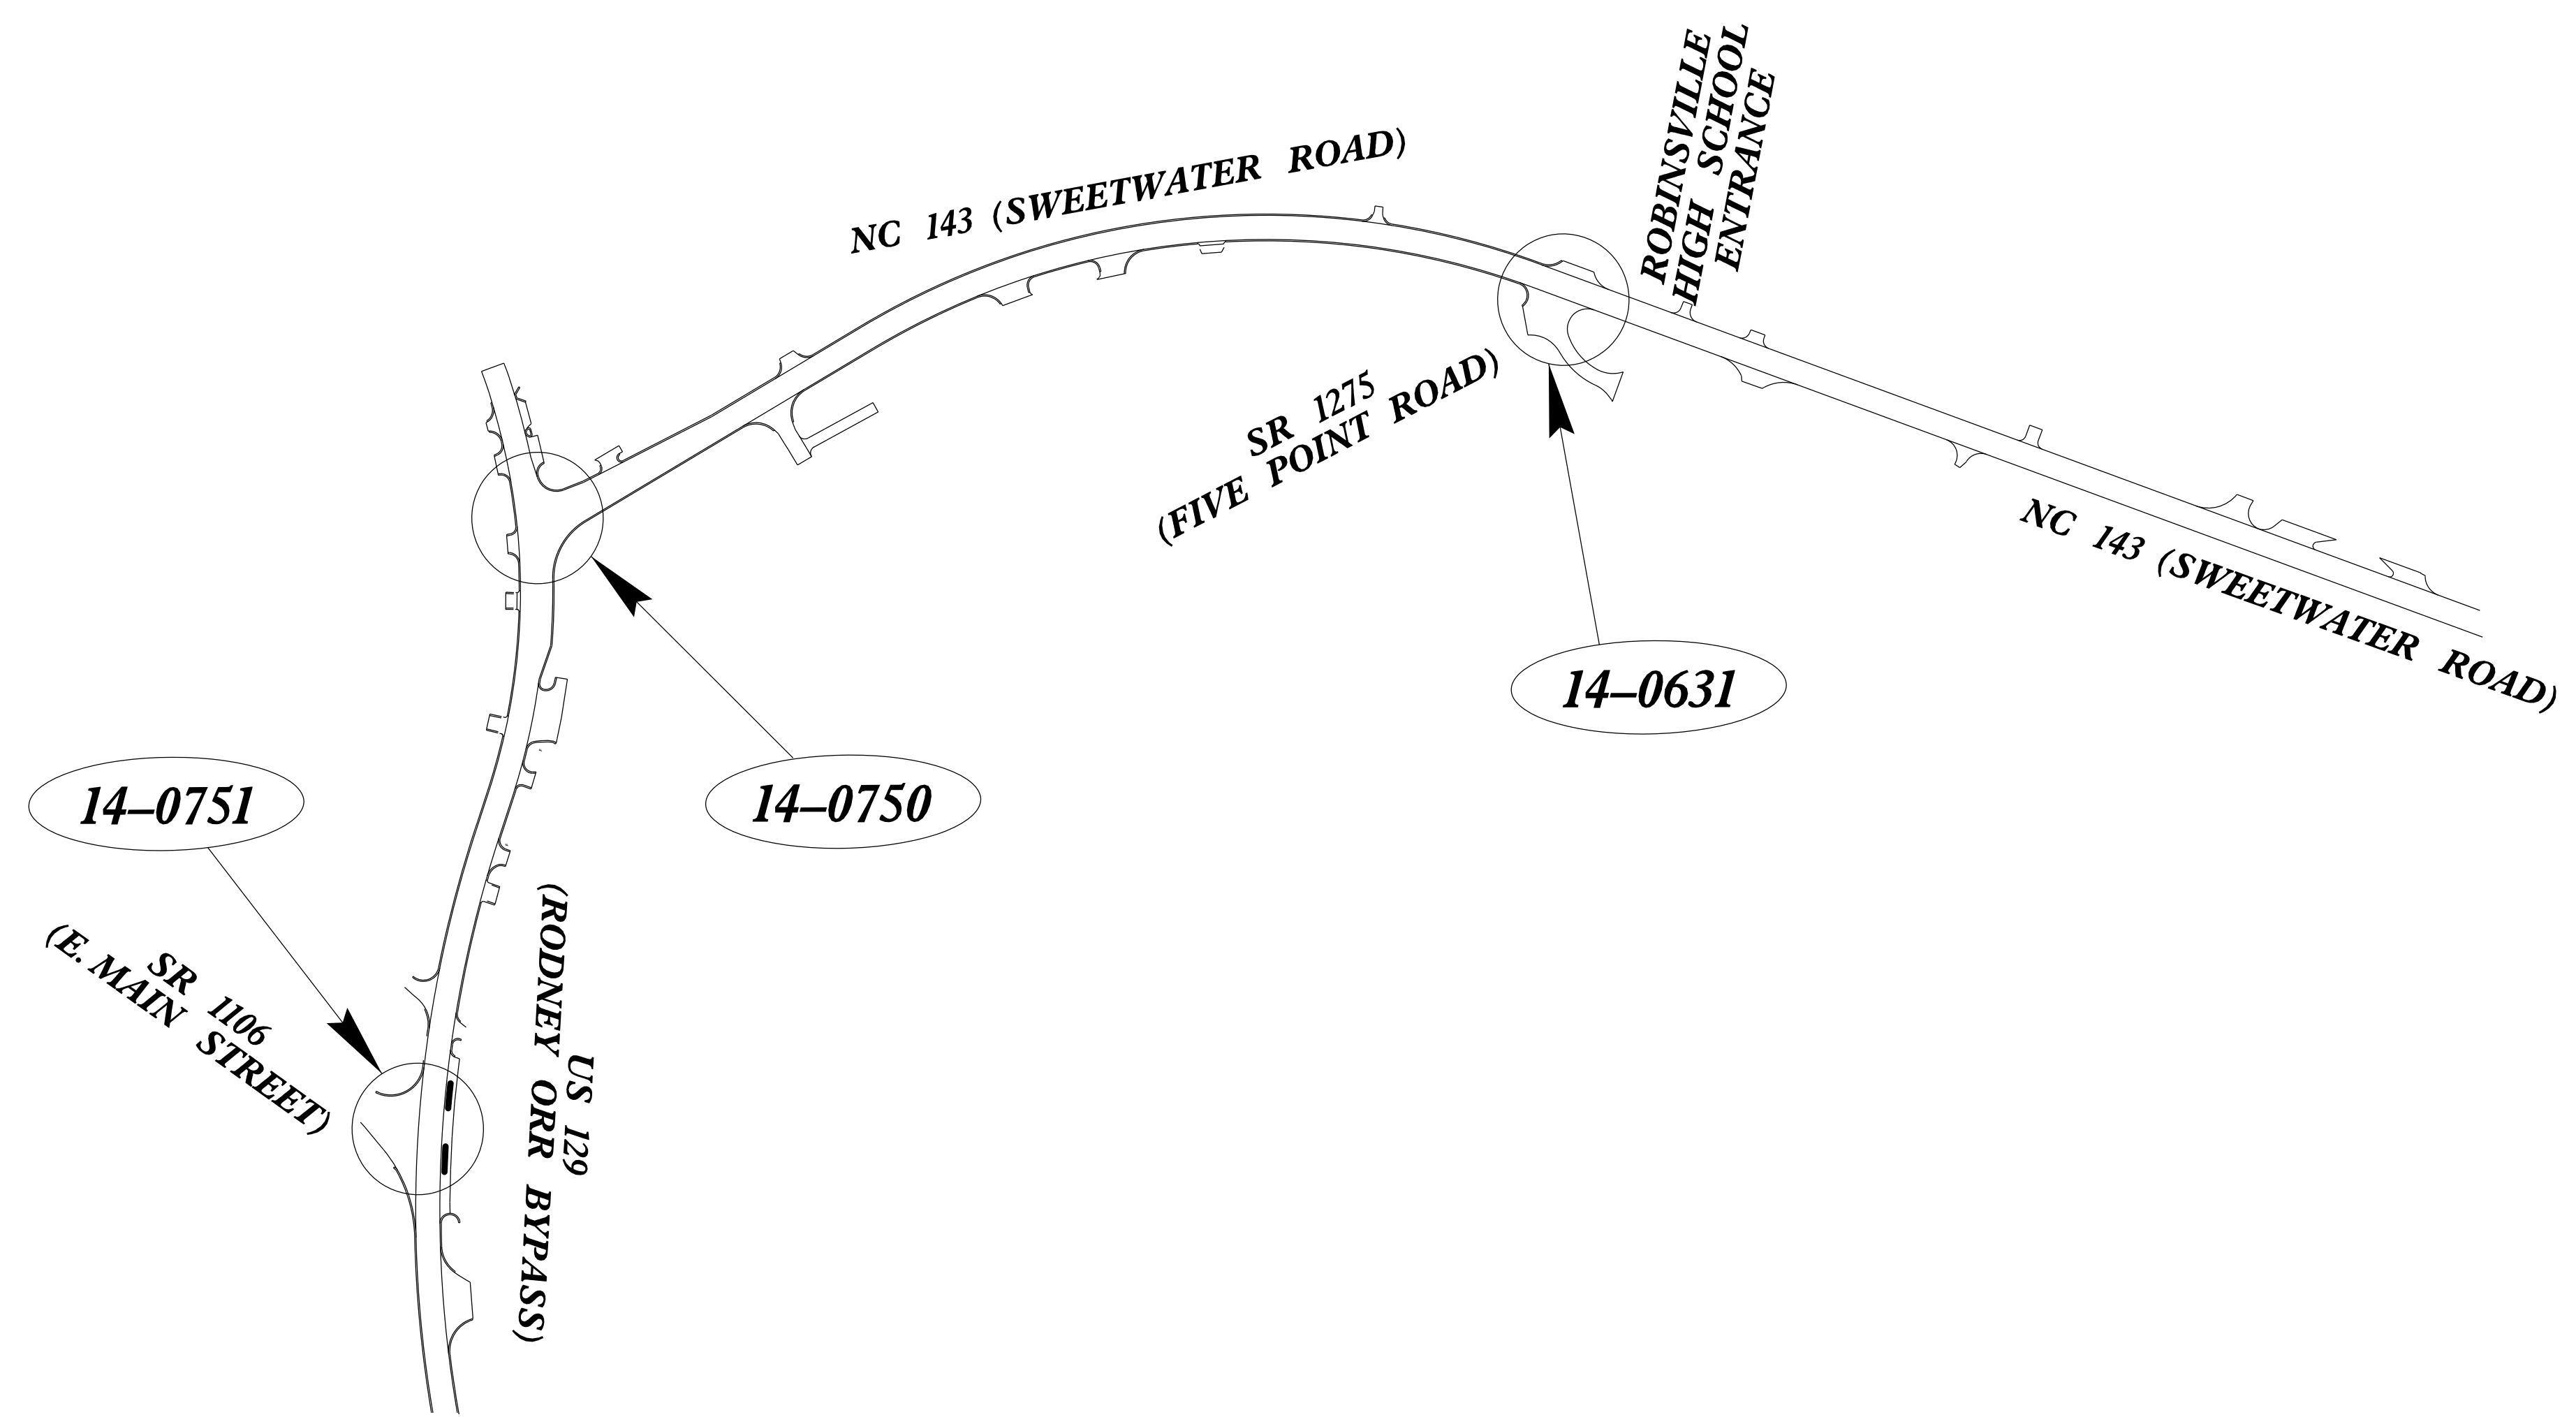

INDEX OF PLANS		
Sheet #	Reference #	Location /Description
Sig. 1.0	-----	Title Sheet
Sig. 1.1-1.2	-----	Revised Standard Drawings
Sig. 2.0-2.10	14-0751	US 129 at SR 1106 (E. Main St)
Sig. 3.0-3.14	14-0750	US 129 at NC 143 (Sweetwater Rd) / Kerr Drug Entr
Sig. 4.0-4.11	14-0631	NC 143 at SR 1275 (Five Points Rd) / Robbinsville High School Entr
MI-M8	-----	Standard Metal Pole Details
SCP. 1-5	-----	Signal Communication Plans

LEGEND


- #### SIGNAL INVENTORY NUMBER

INTELLIGENT TRANSPORTATION AND SIGNALS UNIT

Contacts:

Timothy J. Williams, PE - Central Region Signals Engineer
Todd Joyce, PE - Signal Equipment Design Engineer
Gregory A. Green - Signal Communications Project Engineer
Heidi Berggren, EI- Signal Communications Project Design Engineer

Prepared for the North Carolina Department of Transportation
In the Office of:




Refer to Roadway Standard Drawings NCDOT" dated January 2018 and Standard Specifications for Roads and Structures" dated January 2018.

Jimmy Terry, PE
PROJECT ENGINEER


Jianxin(Justine) Ma, PE PTOE
PROJECT DESIGN ENGINEER

SEAL



Jianxin Ma
5/10/2022
DATE

DIVISION OF HIGHWAYS
TRANSPORTATION MOBILITY AND SAFETY DIVISION

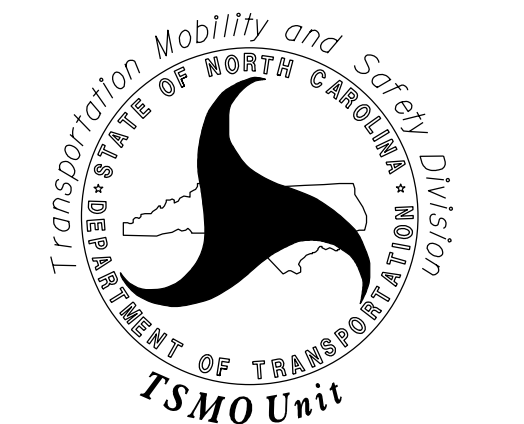

750 N. Greenfield Parkway, Garner, NC 27529