


STATE OF NORTH CAROLINA
DIVISION OF HIGHWAYS


Project No. R-3830
Sheet No. SIG-1.0

LEE COUNTY

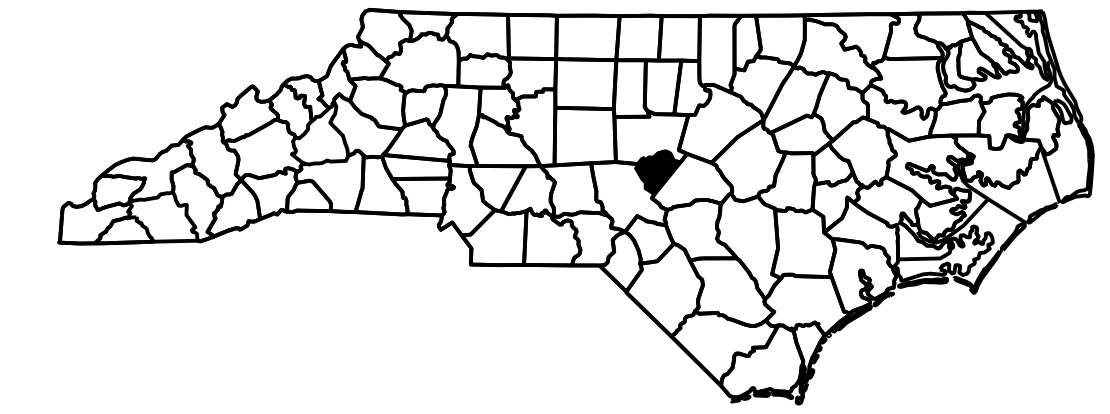


LOCATION: NC 42 (E. MAIN STREET) FROM US 421 BUSINESS/NC 78-87 (HORNER BLVD.) IN SANFORD TO SR 1529 (COX MILL ROAD)

TYPE OF WORK: TRAFFIC SIGNALS & SIGNAL COMMUNICATIONS

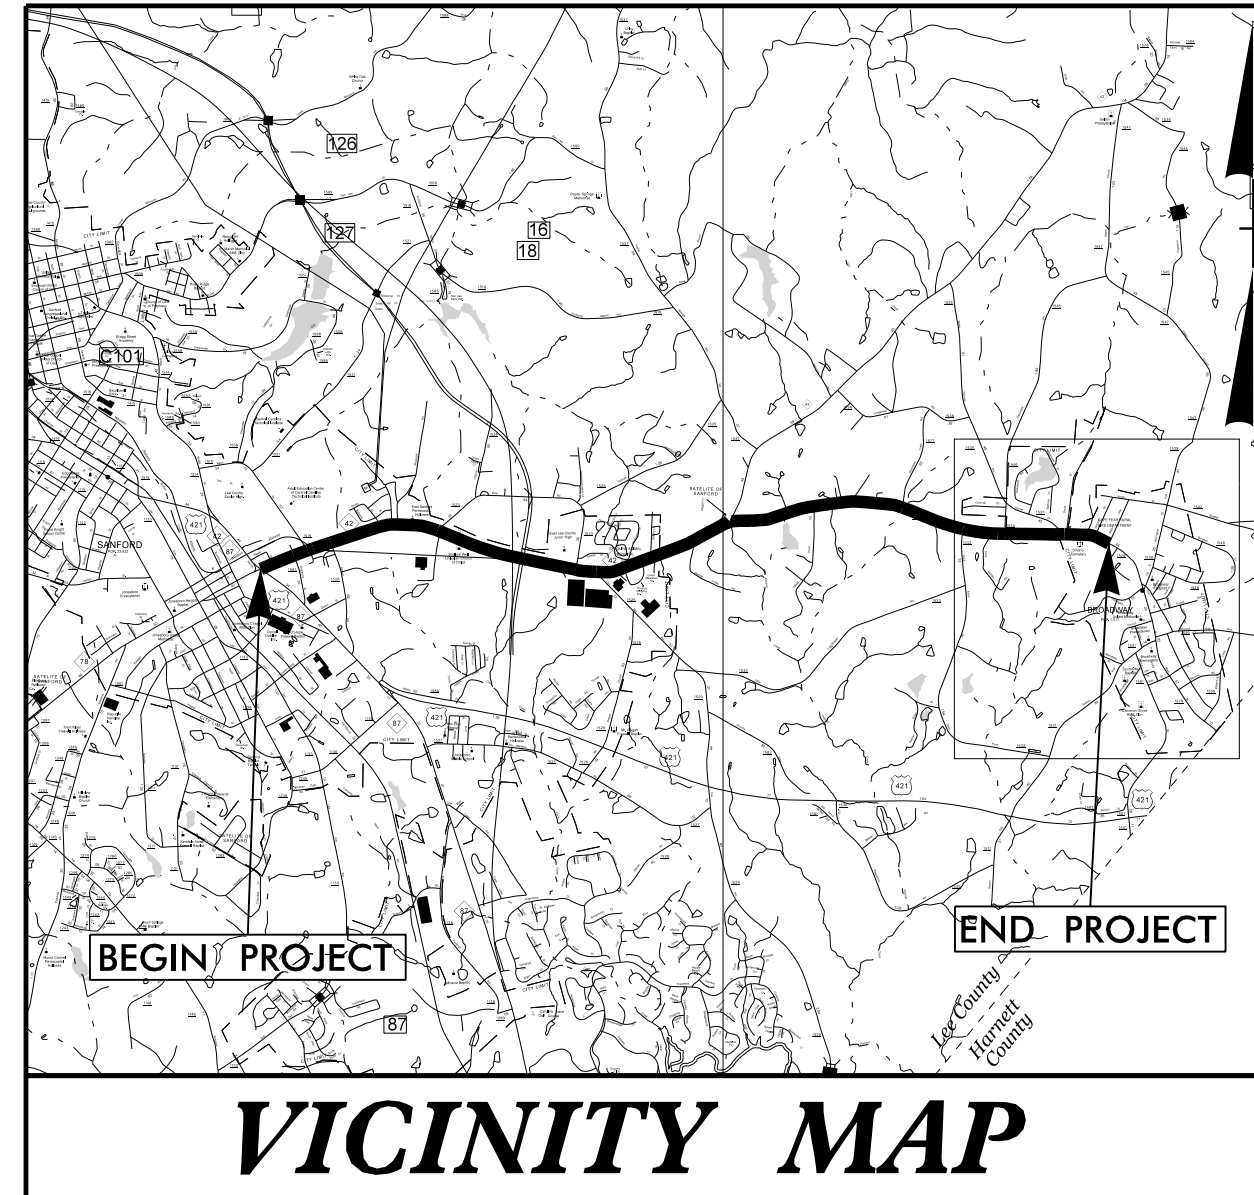


VICINITY MAP

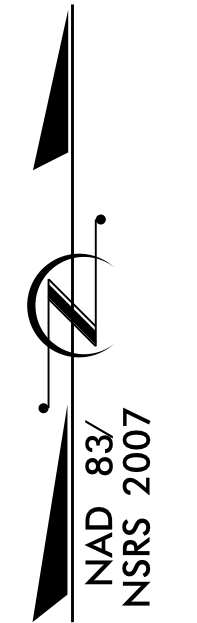

TIP PROJECT: R-3830

CONTRACT: C204369

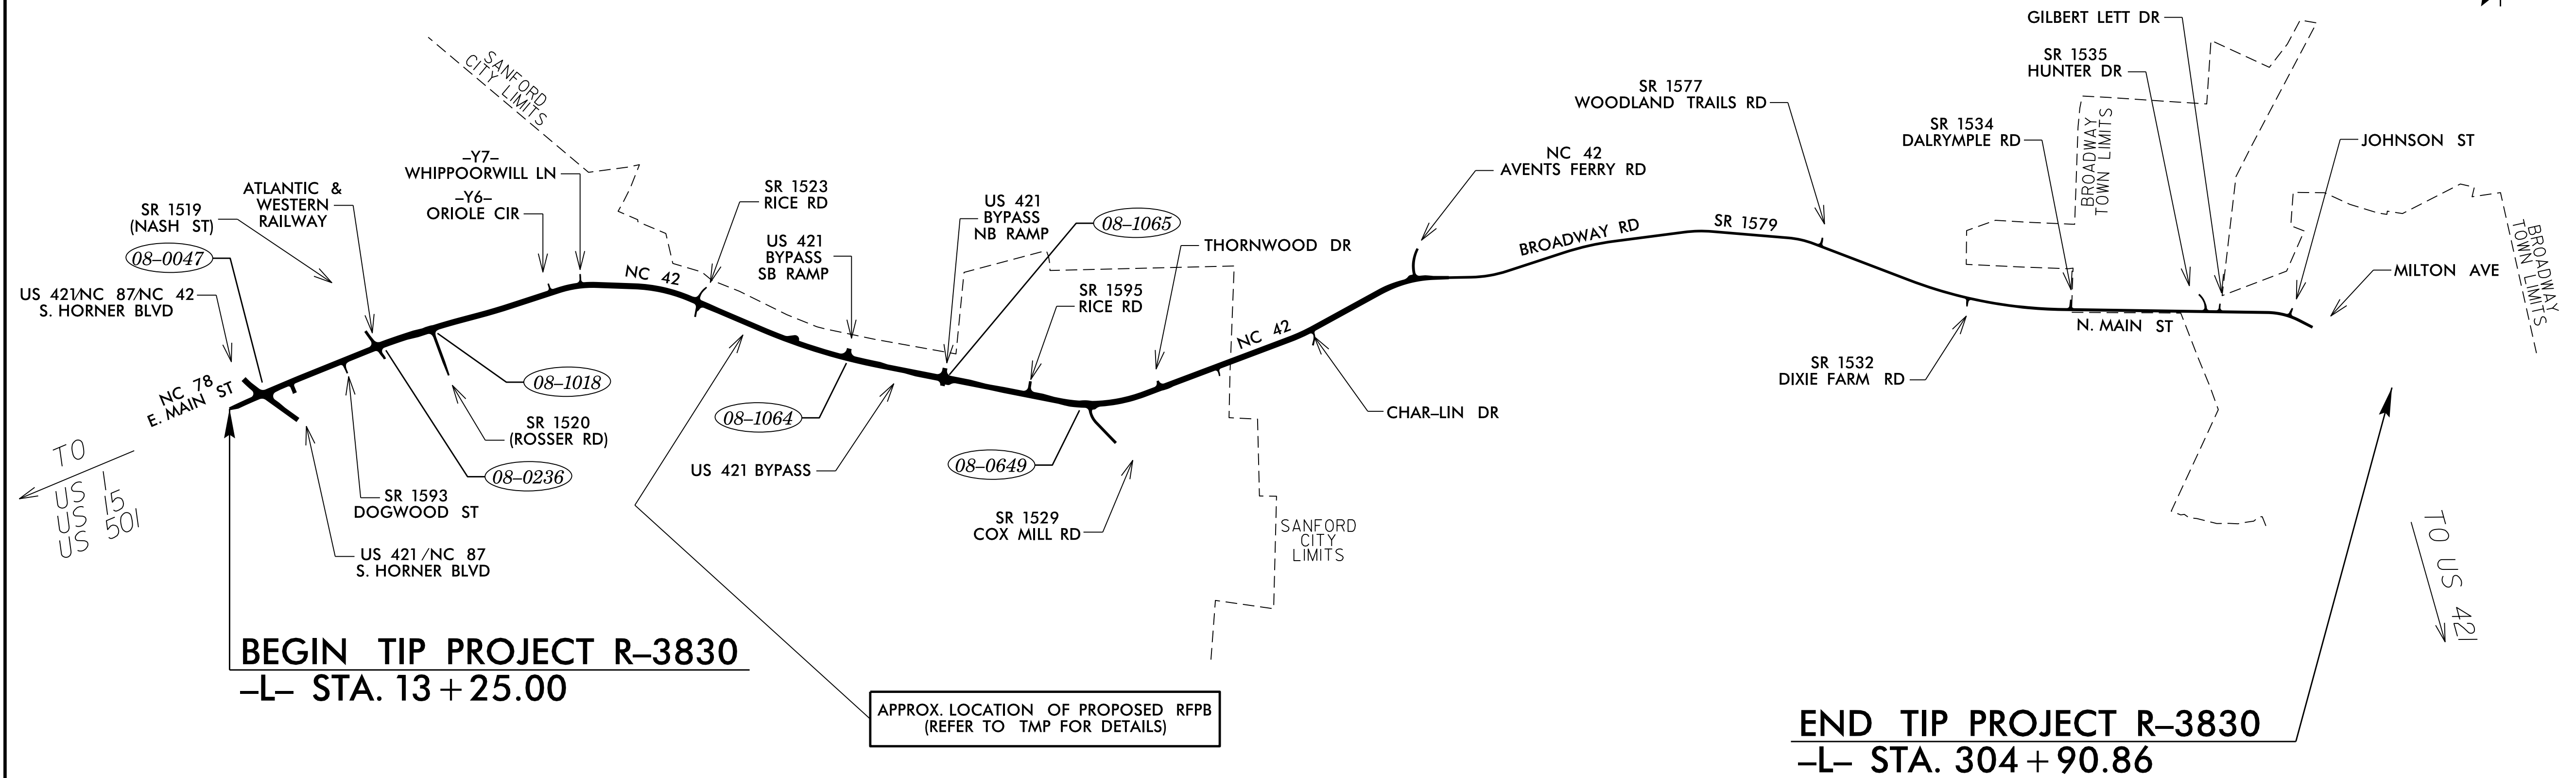

LEGEND

XX-XXXX - SIGNAL INVENTORY NUMBER

INDEX OF PLANS

SHEET NO.	SIG. INV. #	DESCRIPTION
SIG 1.0		Title Sheet
SIG 1.1 - 1.2		Standard Plate Sheets
SIG 2.0 - 4.5	08-0047	US 421 Business/NC 42-87 (S. Horner Blvd.) @ NC 42-78 (E. Main Street)
SIG 5.0 - 7.7	08-0236	NC 42 (E. Main Street) @ SR 1519 (Nash Street)
SIG 8.0 - 11.7	08-1018	NC 42 (E. Main Street) @ SR 1520 (Rosser Road)
SIG 12.0 - 14.4	08-1064	NC 42 (Broadway Road) @ US 421-NC 87 Bypass Southbound Ramps
SIG 15.0 - 17.6	08-1065	NC 42 (Broadway Road) @ US 421-NC 87 Bypass Northbound Ramps/Coty Plant Entrance
SIG 18.0 - 22.6	08-0649	NC 42 (Broadway Road) @ SR 1529 (Cox Mill Road)
MI - M8		Metal Pole Standard Drawings
SCP-1 - SCP-17		Signal Communication Plans


**TRANSPORTATION SYSTEMS
MANAGEMENT AND OPERATIONS UNIT**
Contacts:

Rob Ziemba, PE
Central Region Signals Engineer

Todd Joyce, PE
Signal Equipment Design Review Engineer

Gregg Green
Signal Communications Project Engineer

Plans Prepared for:
**DIVISION OF HIGHWAYS
TRANSPORTATION MOBILITY AND SAFETY
DIVISION**

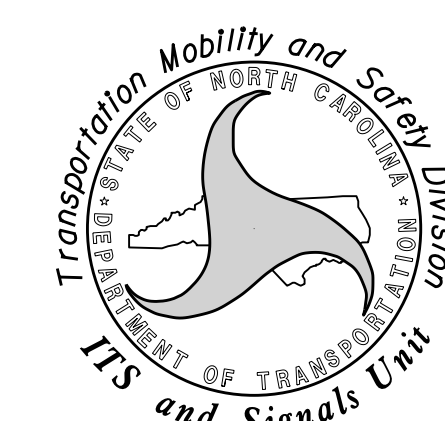

750 N. Greenfield Parkway, Garner, NC 27529



Stantec Consulting Services Inc.
801 Jones Franklin Rd-Suite 300
Raleigh, NC 27606
Tel. 919.851.6866
Fax. 919.851.7024
www.stantec.com
License No. F-0672

Betsy L. Watson, PE
Senior Principal

Dean Harris
Senior Transportation Designer

Regina Muncey, PE
Transportation Engineer