

TIP PROJECT: R-3830

STATE OF NORTH CAROLINA DIVISION OF HIGHWAYS

UTILITY CONSTRUCTION PLANS LEE COUNTY

T.I.P. NO.	SHEET NO.
R-3830	UC-1

UTILITY AGREEMENT PLANS




EXHIBIT "A"

COST BREAKDOWN LEGEND

STATE COST	75%
CITY OF SANFORD COST	25%

LOCATION: NC 42 FROM US 421 TO SR 1579 (MAIN STREET) IN SANFORD AND ALONG SR 1579 FROM NC 42 TO SR 1538 (E. HARRINGTON AVE) IN BROADWAY

TYPE OF WORK: WATER AND SEWER RELOCATION

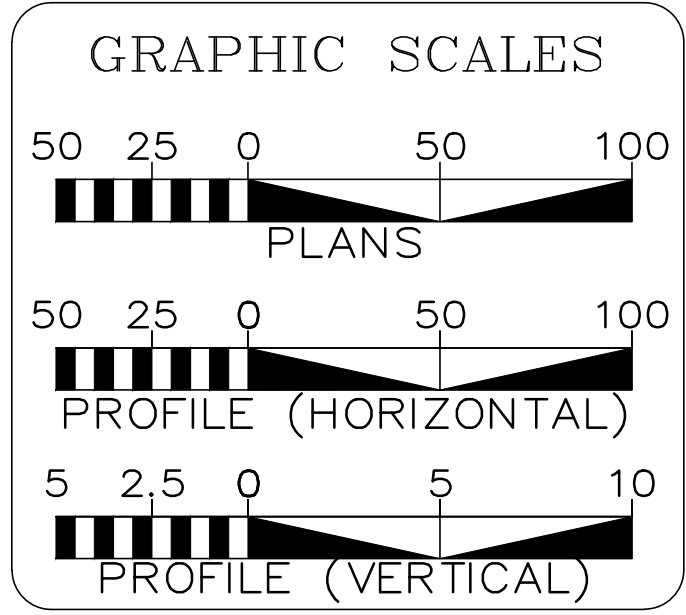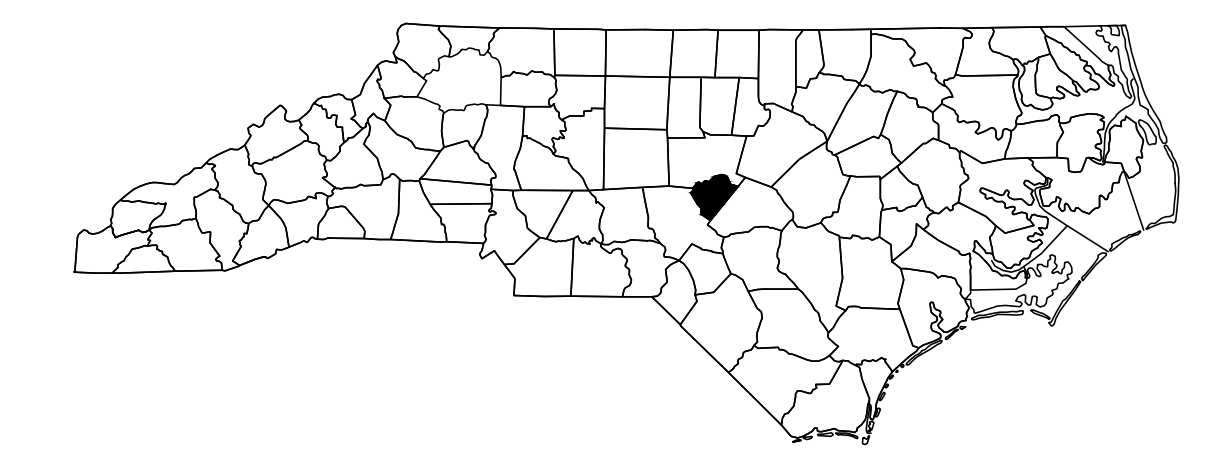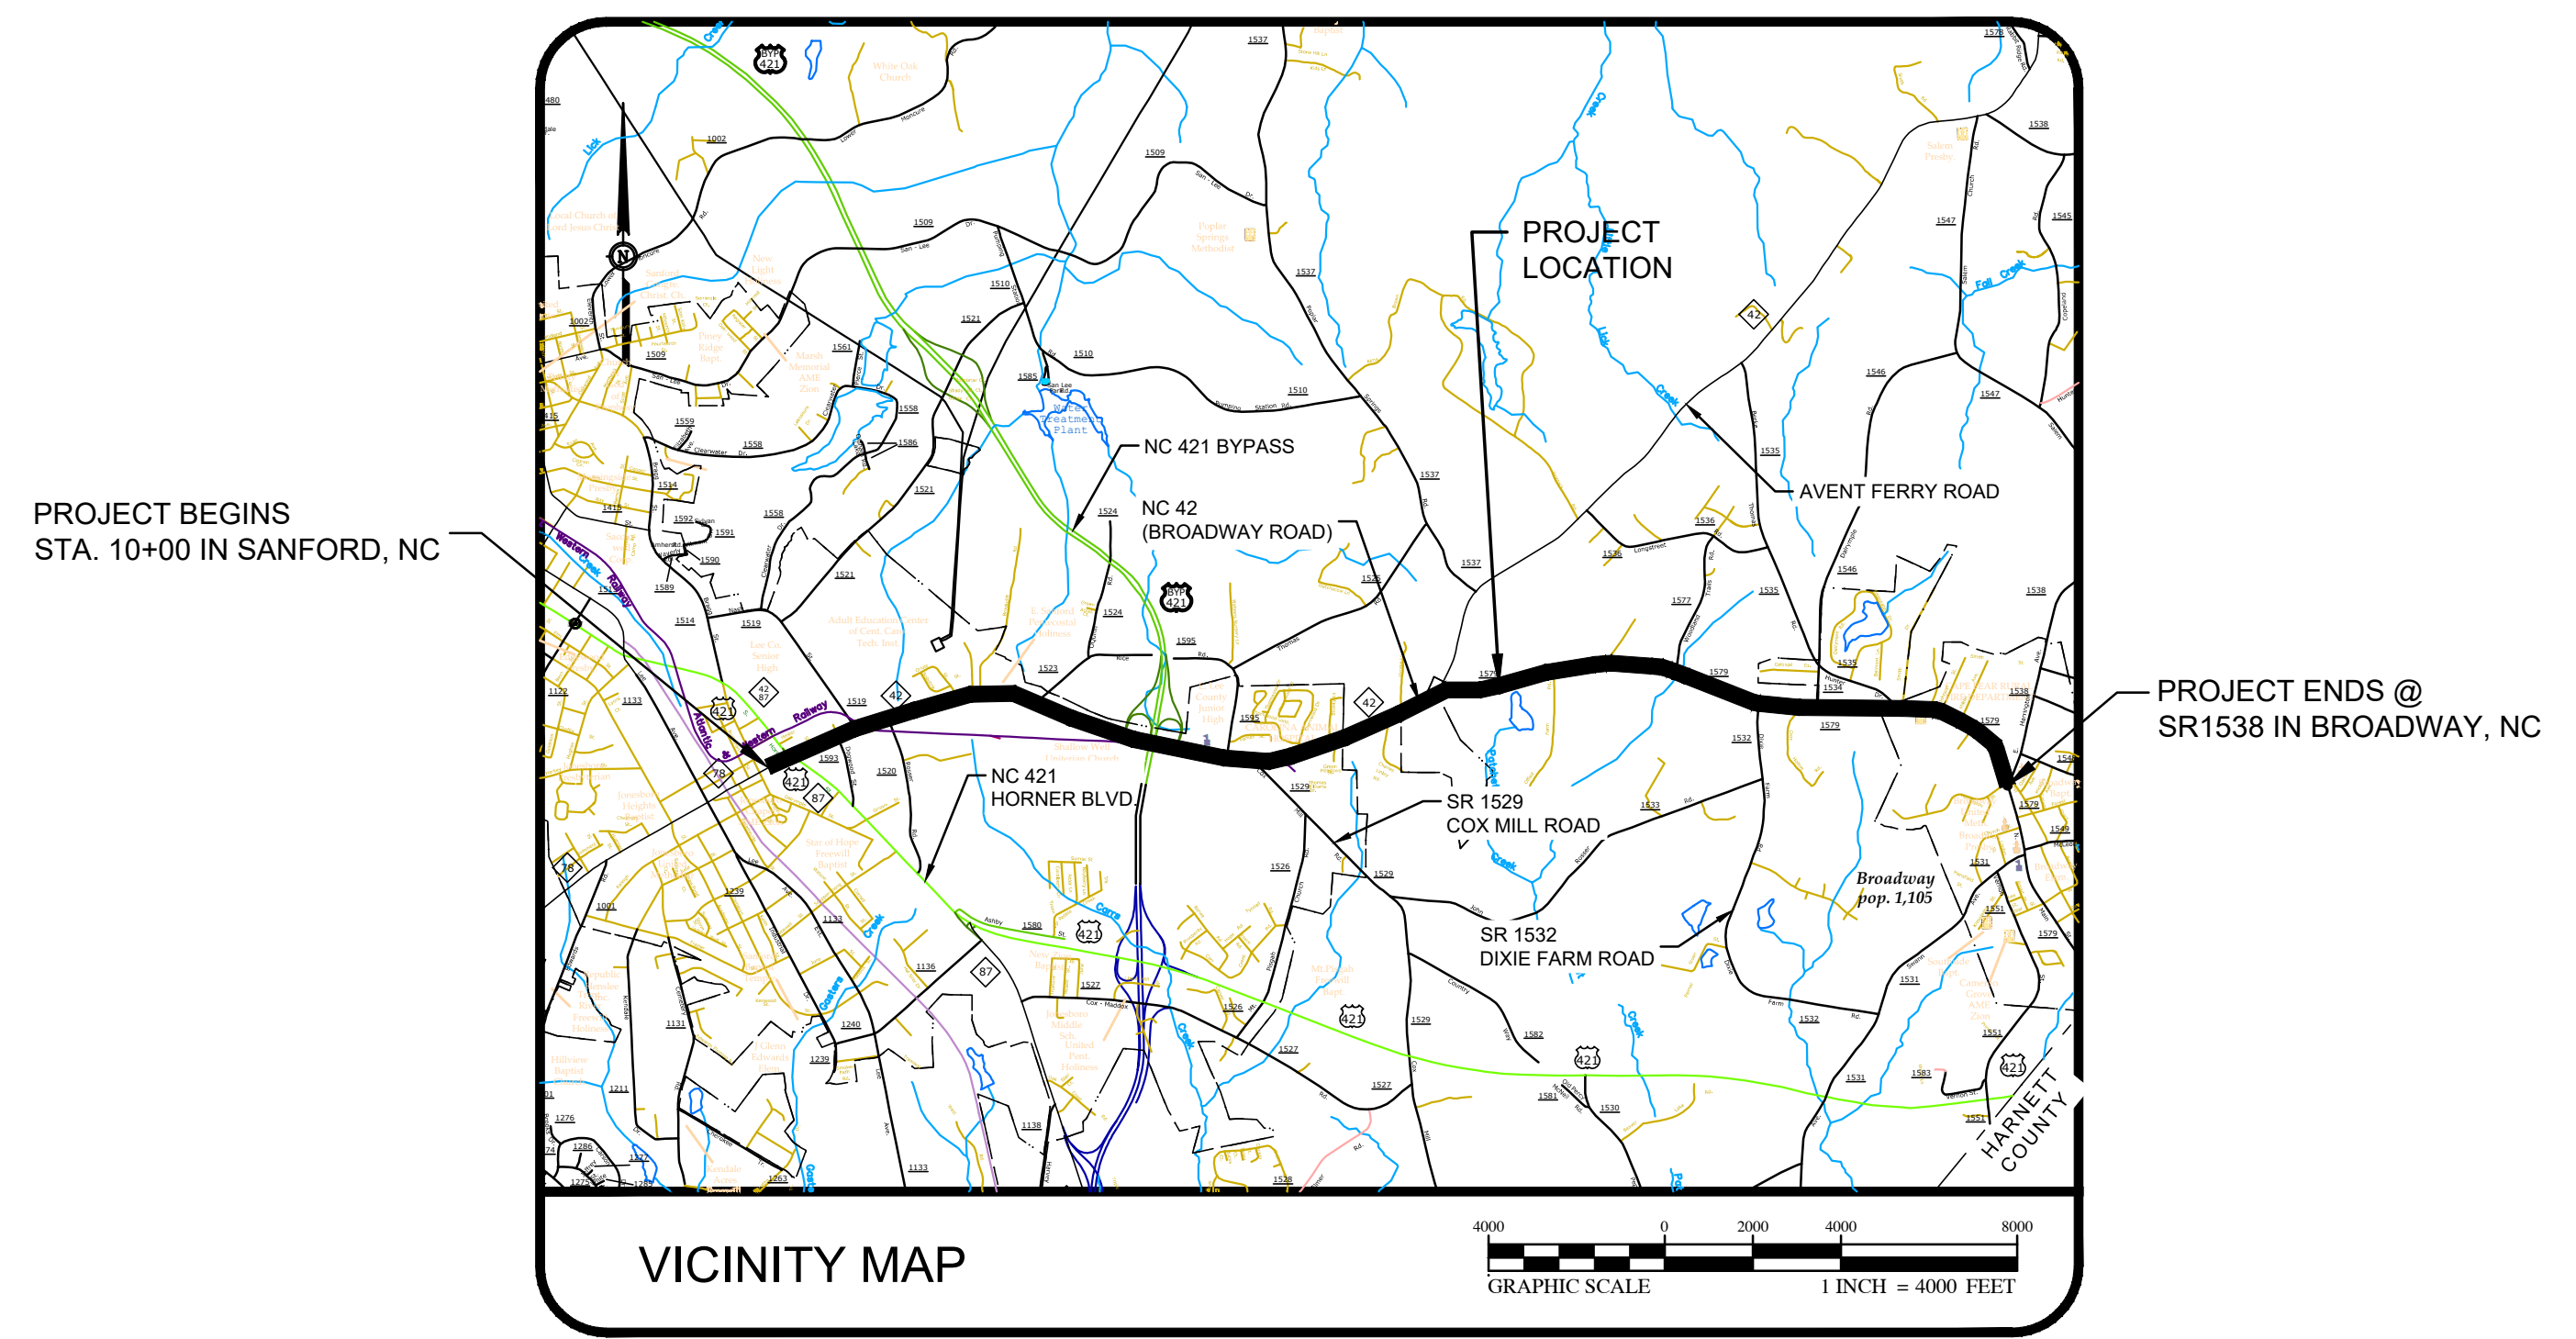

INDEX OF SHEETS

SHEET NO.:	DESCRIPTION:
UC-1	TITLE SHEET
UC-2	UTILITY SYMBOLOGY
UC-3	NOTES
UC-3A THRU UC-3B	DETAILS
UC-4	SHEET REFERENCE
UC-5 THRU UC-25	PLAN AND PROFILE SHEETS


WATER AND SEWER OWNERS ON PROJECT

(A) WATER: CITY OF SANFORD
 (B) SANITARY SEWER: CITY OF SANFORD
 Water Dept.: 919-775-8215
 Emergency: 919-775-8268 After Hours
 Public Works: 919-777-1118


PREPARED IN THE OFFICE OF

CONSULTANT INFO
 McGill Associates, P.A.
 5 REGIONAL CIRCLE, SUITE A
 PINEHURST, NC 28374
 910-295-3159

DAVID HONEYCUTT CONSULTANT CONTACT #1
 MATTHEW JONES CONSULTANT CONTACT #2

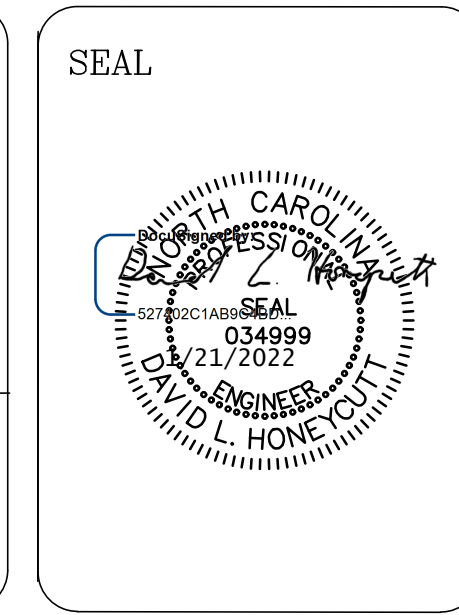

DOCUMENT NOT CONSIDERED FINAL UNTIL ALL SIGNATURES ARE COMPLETED

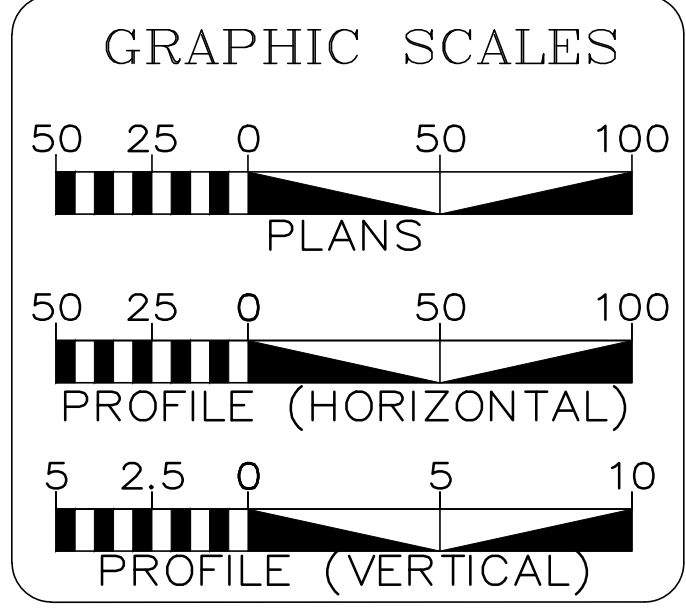

INDEX OF SHEETS

SHEET NO.:	DESCRIPTION:
UC-3C THRU UC-3D	DETAILS
UC-26 THRU UC-30	PLAN SHEETS
UC-31 THRU UC-35	PROFILE SHEETS


WATER AND SEWER OWNERS ON PROJECT

(A) WATER: TOWN OF BROADWAY
 (B) SANITARY SEWER: TOWN OF BROADWAY
 Water Dept.: 919-258-9922
 Public Works: 919-258-9922
 117 South Main Street

PREPARED IN THE OFFICE OF

CONSULTANT INFO
 WithersRavenel
 115 MacKenan Drive
 CARY, NC 27511
 919-469-3340

MICHAEL WICKER CONSULTANT CONTACT #1
 MARK WU CONSULTANT CONTACT #2

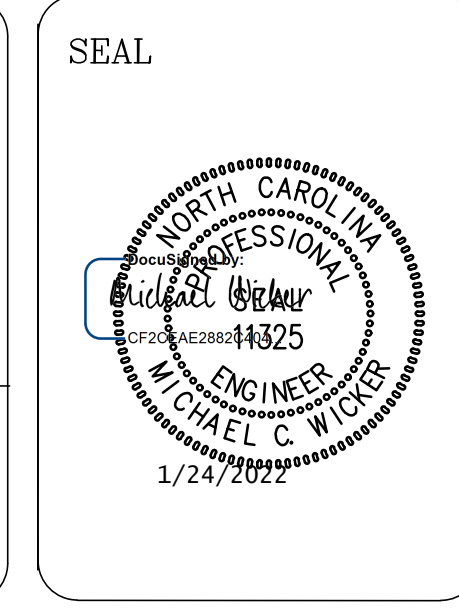

DIVISION OF HIGHWAYS
 UTILITIES UNIT
 1555 MAIL SERVICES CENTER
 RALEIGH, NC 27699-1555
 PHONE (919) 707-6690
 FAX (919) 250-4151

ALI KOUCHEKI, P.E. UTILITIES REGIONAL ENGINEER
 JON LOUGHRY UTILITIES ENGINEER
 DAYTON MARTIN, III UTILITIES AREA COORDINATOR
 XXXX UTILITIES COORDINATOR