


8/17/99

PROJECT REFERENCE NO. 1-5950	SHEET NO. 9
R/W SHEET NO. ROADWAY DESIGN ENGINEER	HYDRAULICS ENGINEER
DOCUMENT NOT CONSIDERED FINAL UNLESS ALL SIGNATURES COMPLETED	

NOTES: THROUGHOUT PROJECT, FOLLOWING RE-SURFACING, THE CONTRACTOR SHALL INSTALL NEW THERMOPLASTIC PAVEMENT MARKINGS ON ASPHALT + POLYUREA MARKINGS ON CONCRETE STRUCTURES (SAME AS EXISTING) AND TIE INTO EXISTING PAVEMENT MARKINGS



REVISIONS

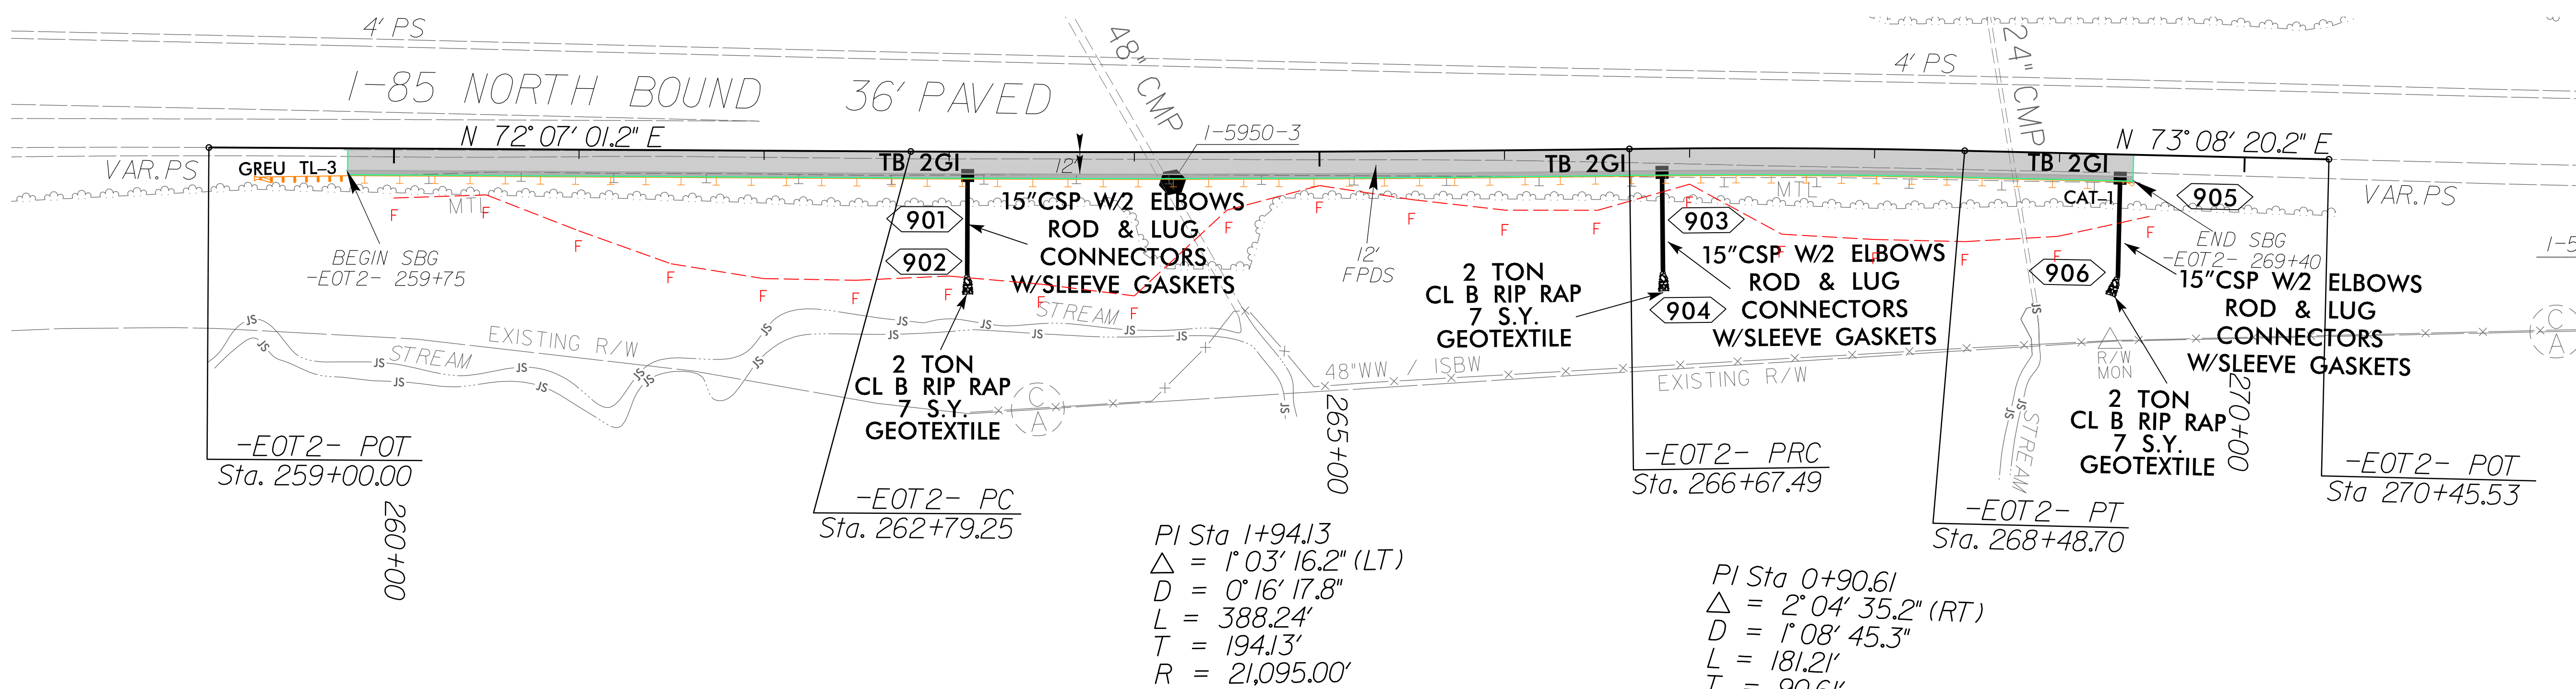

DETAIL OF SHOULDER BERM GUTTER AREA

NOTE:
SEE SHEET X-6 TO X-15
FOR CROSS SECTIONS

27-JUN-2022 15:42
 S:\Projects\Development\1-5950-1\1-5950-1\1-5950-1\Roadway\1-5950-1-ddc.psh3.dgn
 8/17/99