
 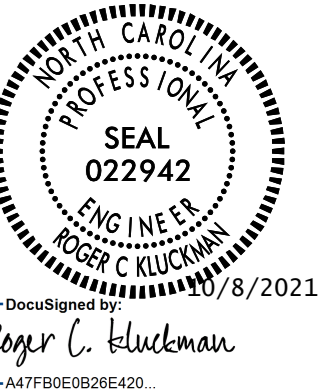



SEE MATCHLINE 2 - THIS SHEET



DOCUMENT NOT CONSIDERED FINAL  
UNLESS ALL SIGNATURES COMPLETED

SEE MATCHLINE 2 - THIS SHEET

MATCHLINE 1 - STA. 21+92  
SEE SHEET E2

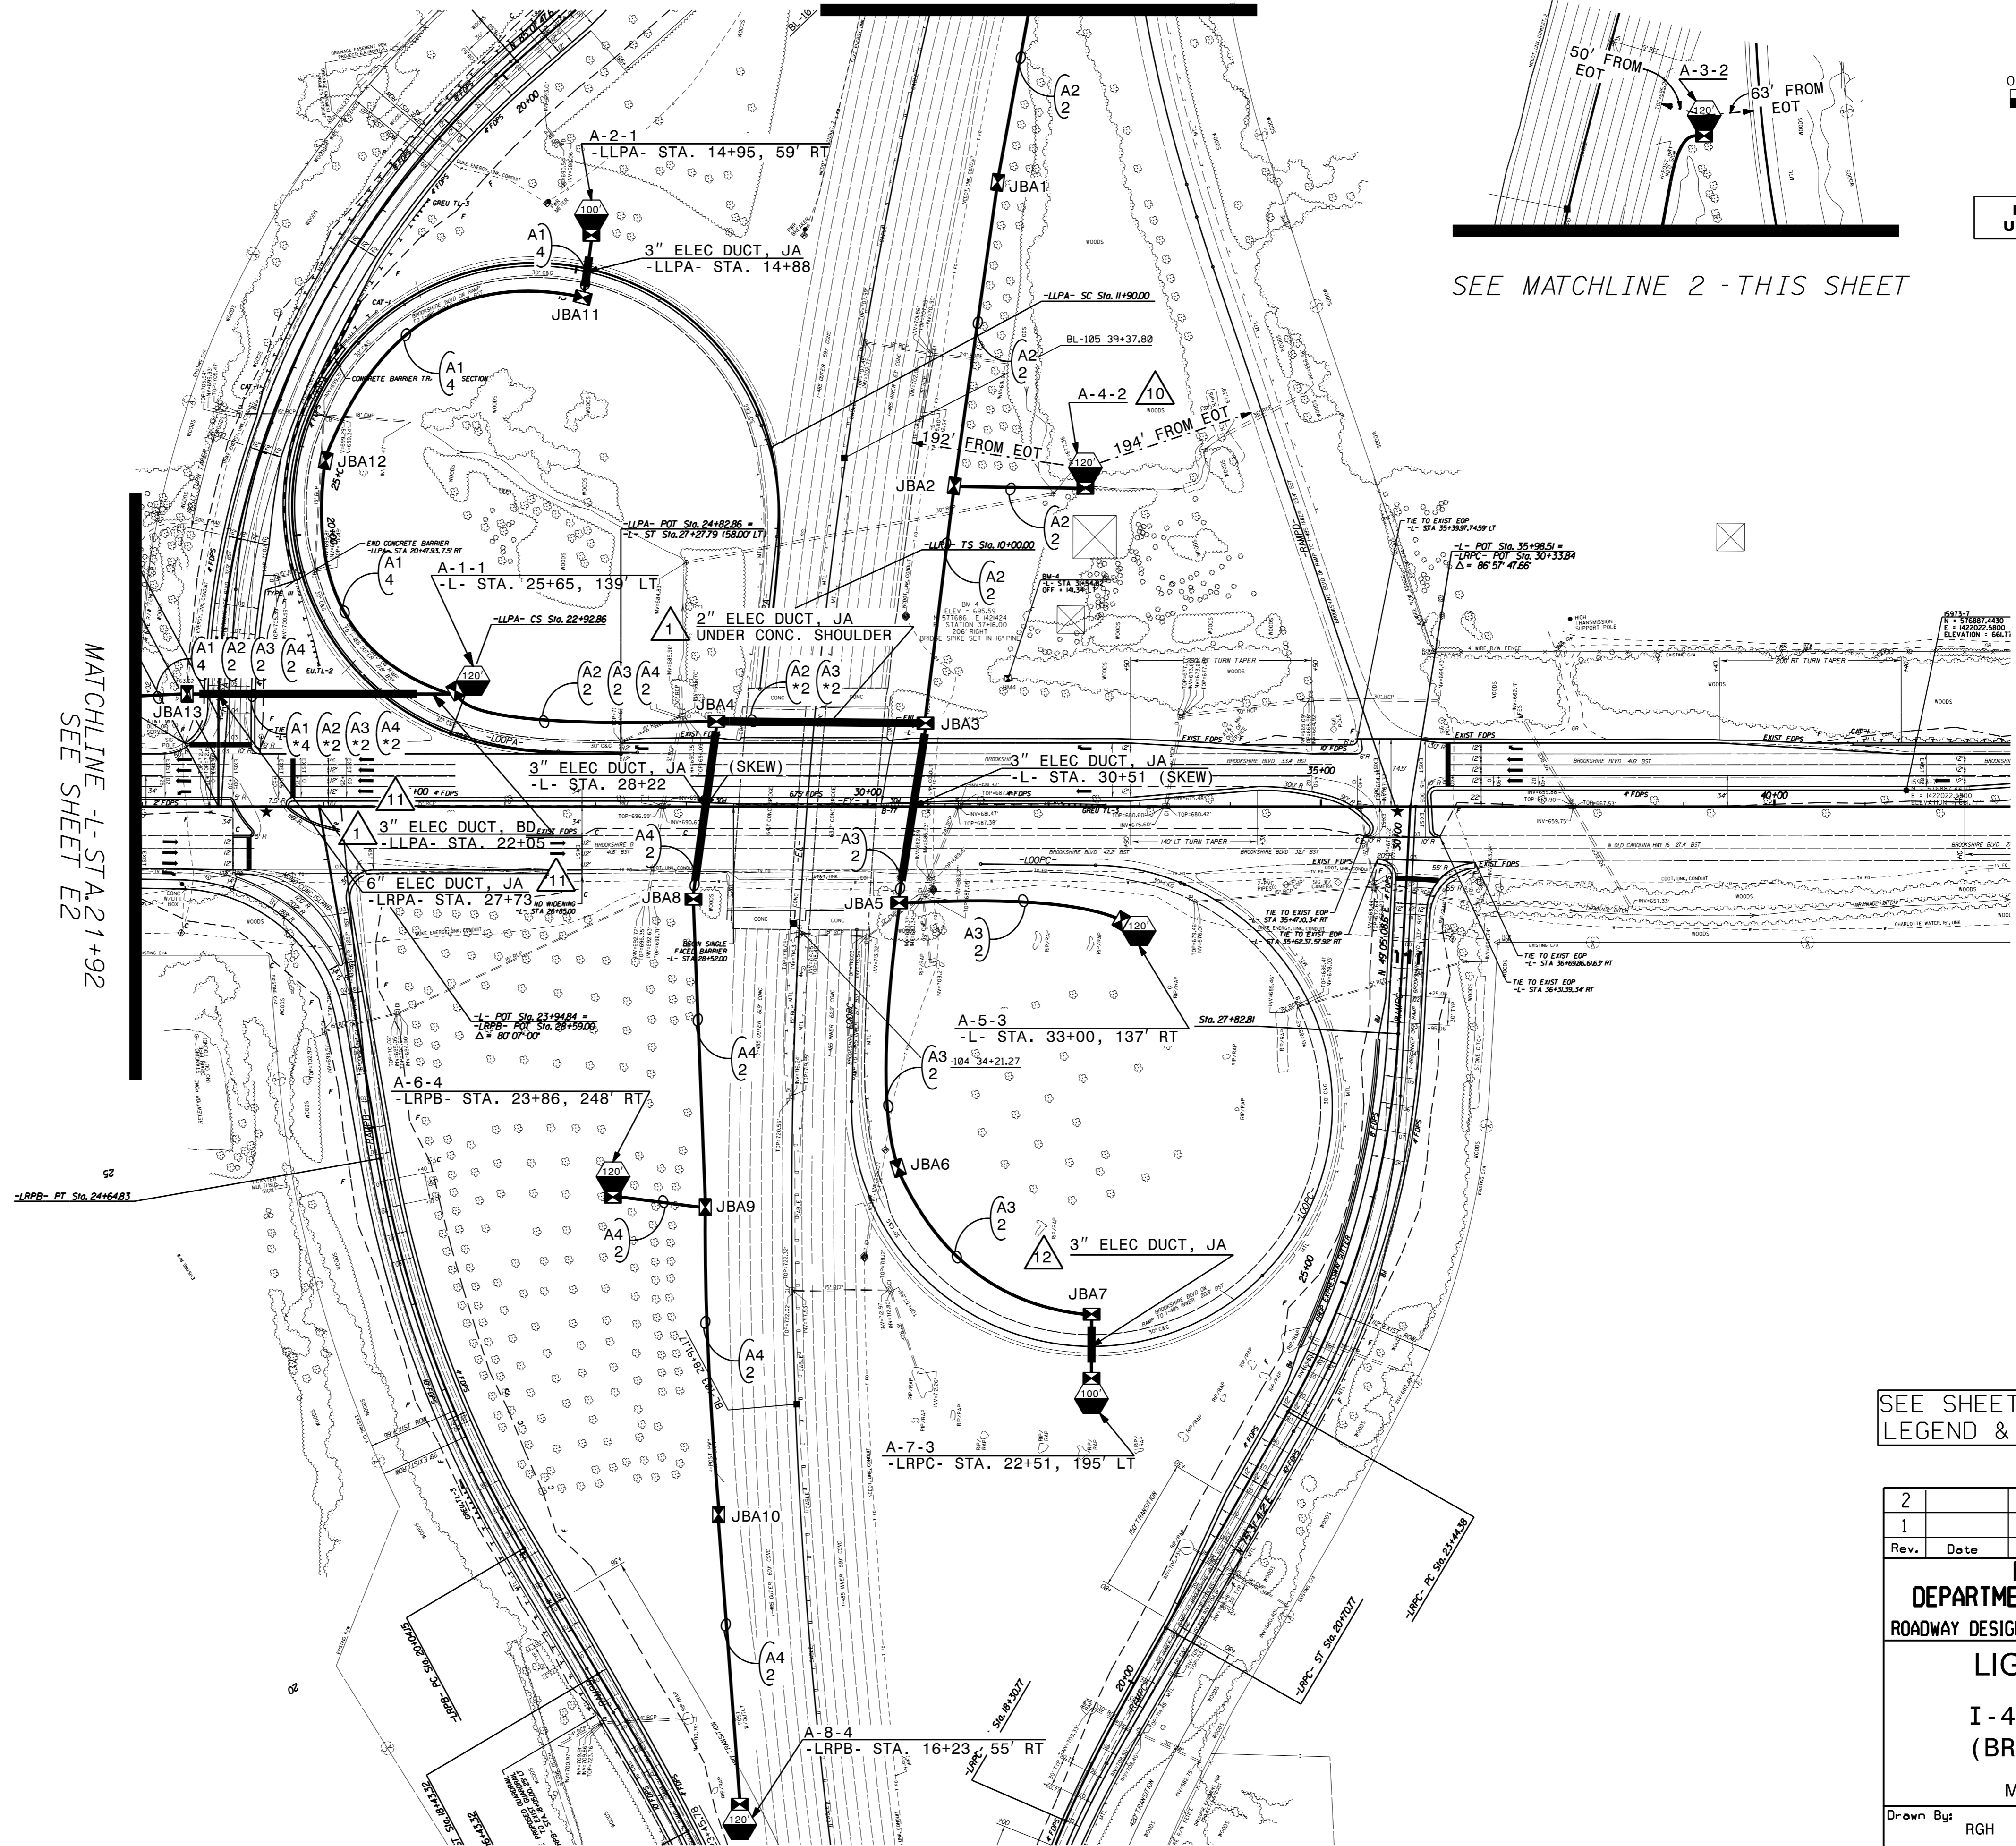

SEE SHEET "E-1" FOR  
LEGEND & △ NOTES

2			
1			
Rev.	Date	Description	Approved
<b>NORTH CAROLINA DEPARTMENT OF TRANSPORTATION</b> ROADWAY DESIGN    LIGHTING/ELECTRICAL SECTION <b>LIGHTING LAYOUT</b> <b>I-485 / NC 16 (BROOKSHIRE BLVD)</b> MECKLENBURG COUNTY			
Drawn By:	RGH	Approved By:	Dwg No.:

07-OCT-2021 13:20  
 R:\Lighting\Lighting Design\Lighting\220\_008-1-5973-LE-E3.dgn  
 rgh.1    AT: RD-303048L