


**DOCUMENT NOT CONSIDERED FINAL  
UNLESS ALL SIGNATURES COMPLETED**

USE FOR LIGHTING CONSTRUCTION ONLY

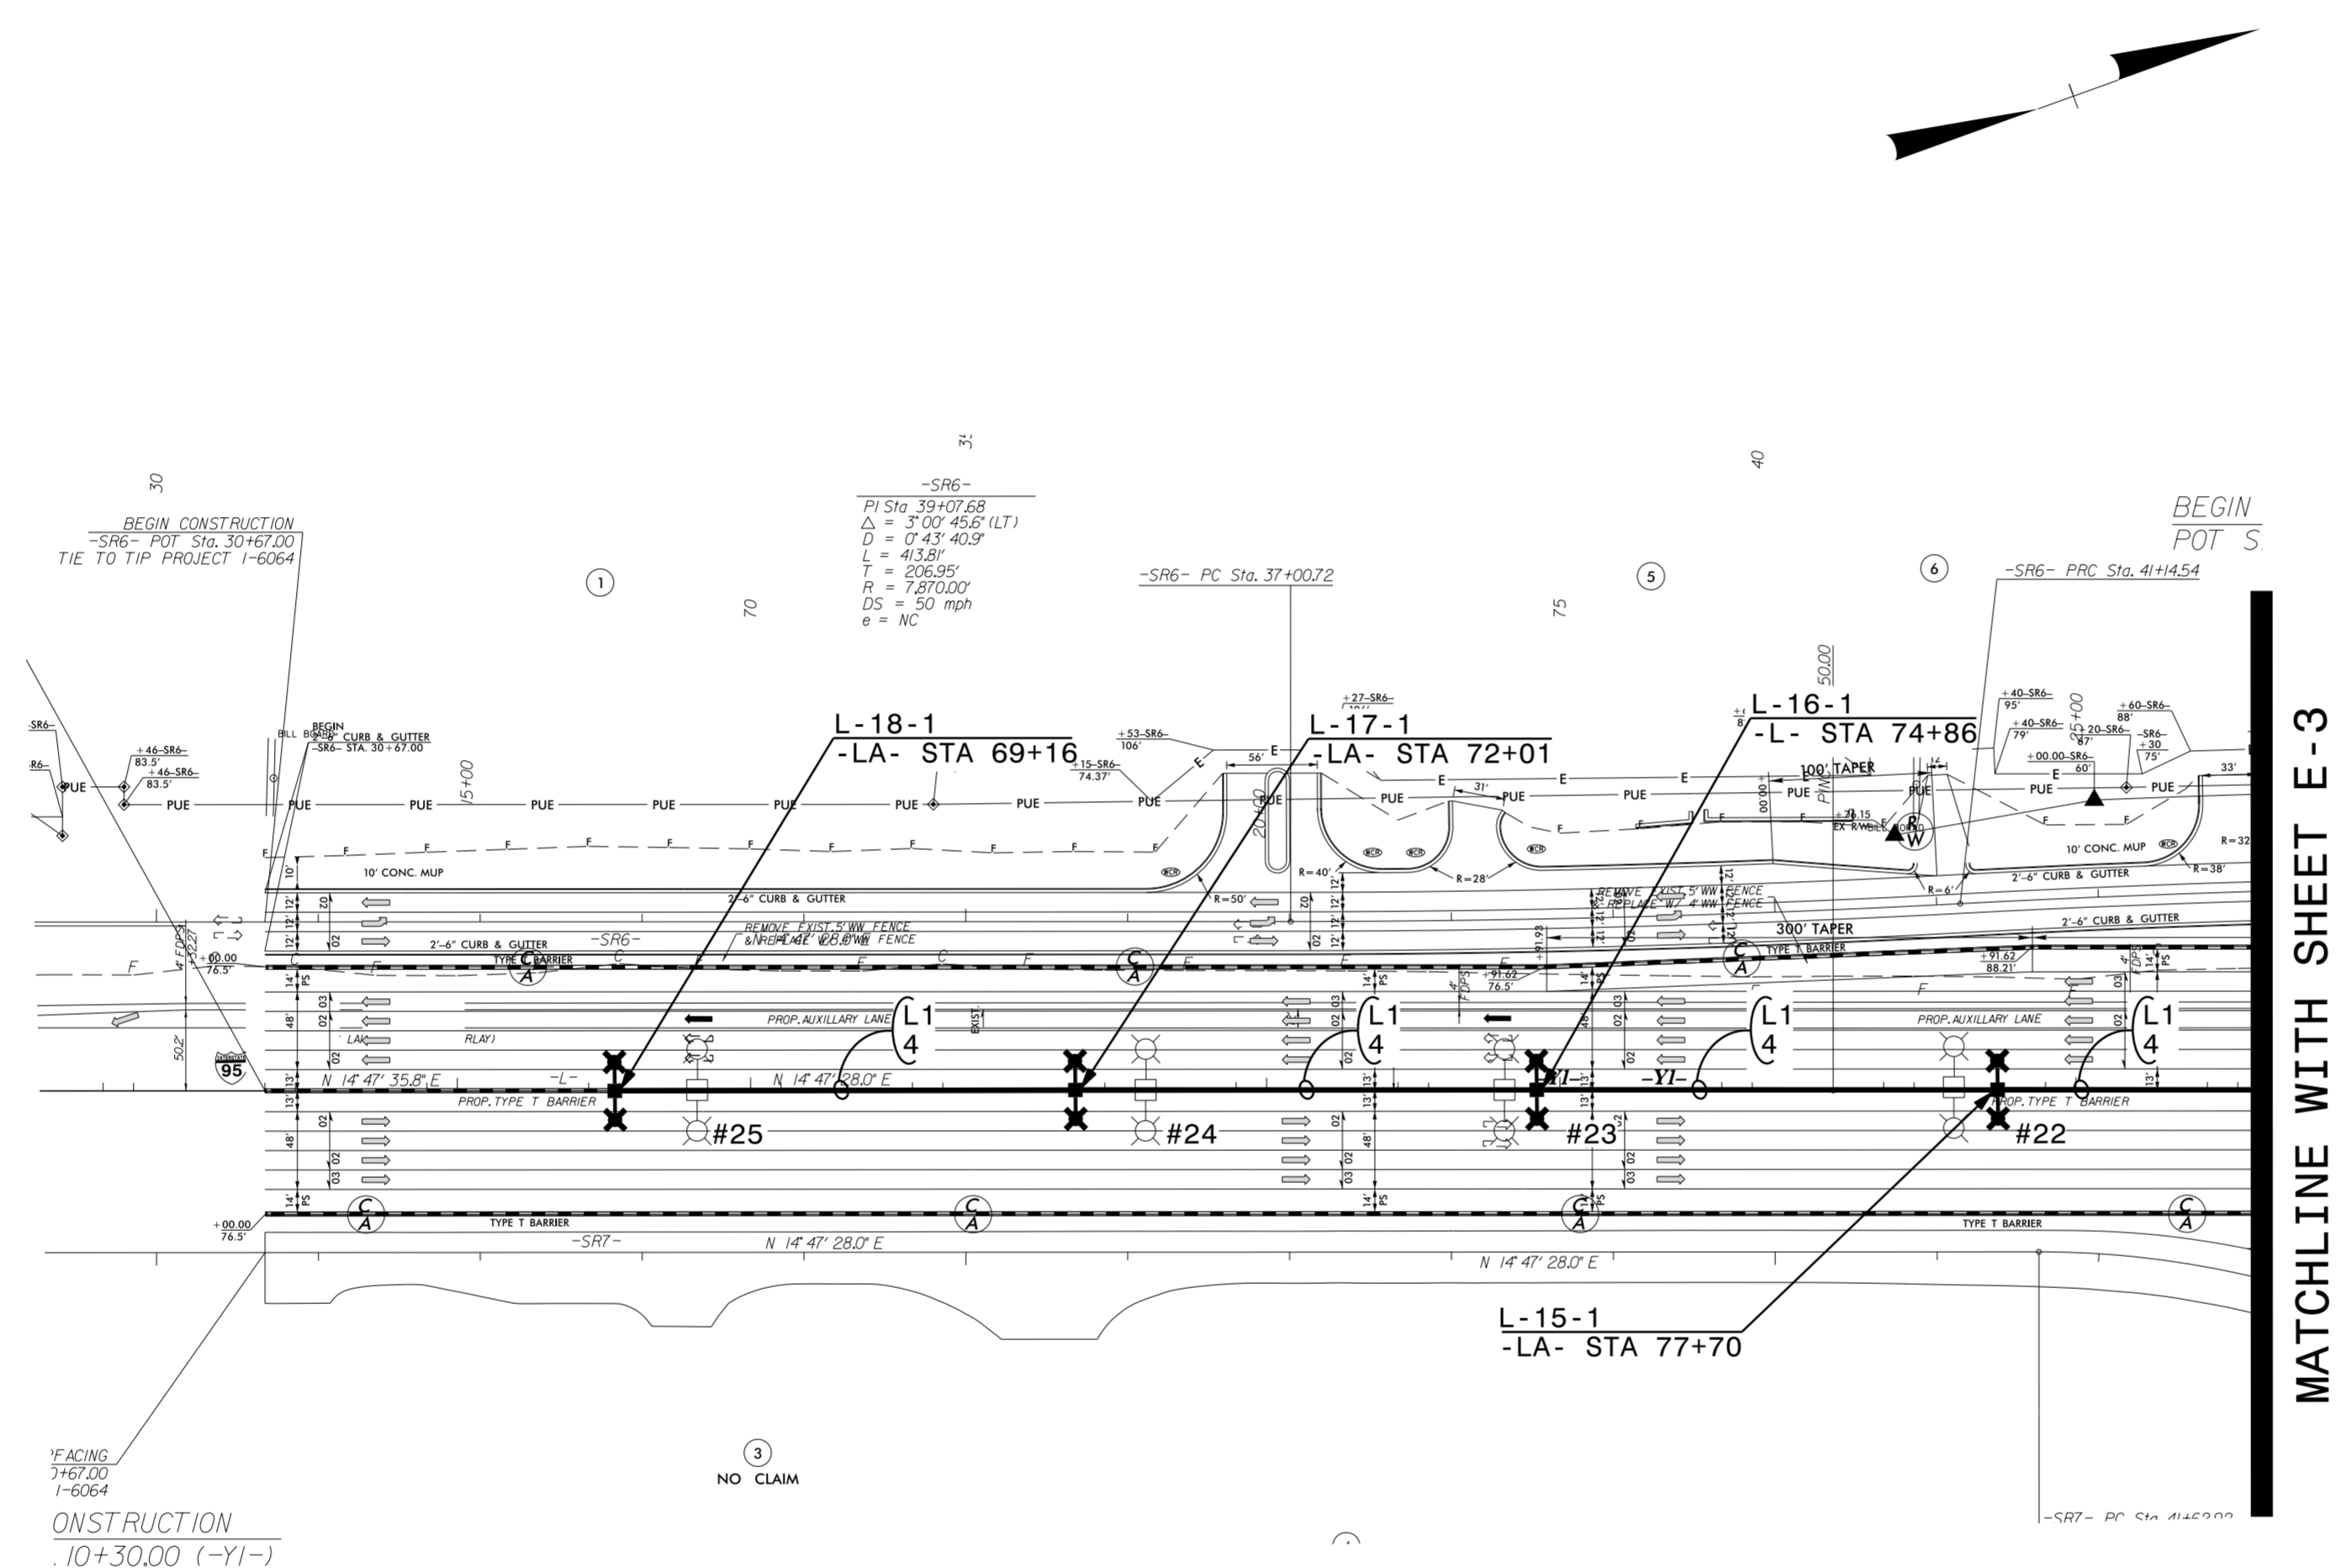

08-MAR-2022 10:27  
 R:\Lighting\Lighting Design\I-5987A CS - L & M\I5987A.LE\_PSH\_E-2.dgn  
 somehtk AT RD-304555

SEE SHEET "E-1" FOR  
LEGEND & △ NOTES

2			
1			
Rev.	Date	Description	Approved
<b>NORTH CAROLINA DEPARTMENT OF TRANSPORTATION</b> ROADWAY DESIGN LIGHTING/ELECTRICAL SECTION  <b>LIGHTING LAYOUT</b>  <b>I-95, SOUTH OF EXIT-22</b>  ROBESON COUNTY			
Drawn By:	SAM	Approved By:	RGH
		Dwg No.:	