


USE FOR LIGHTING CONSTRUCTION ONLY

PROJECT REFERENCE NO. 1-5987A SHEET NO. E-7

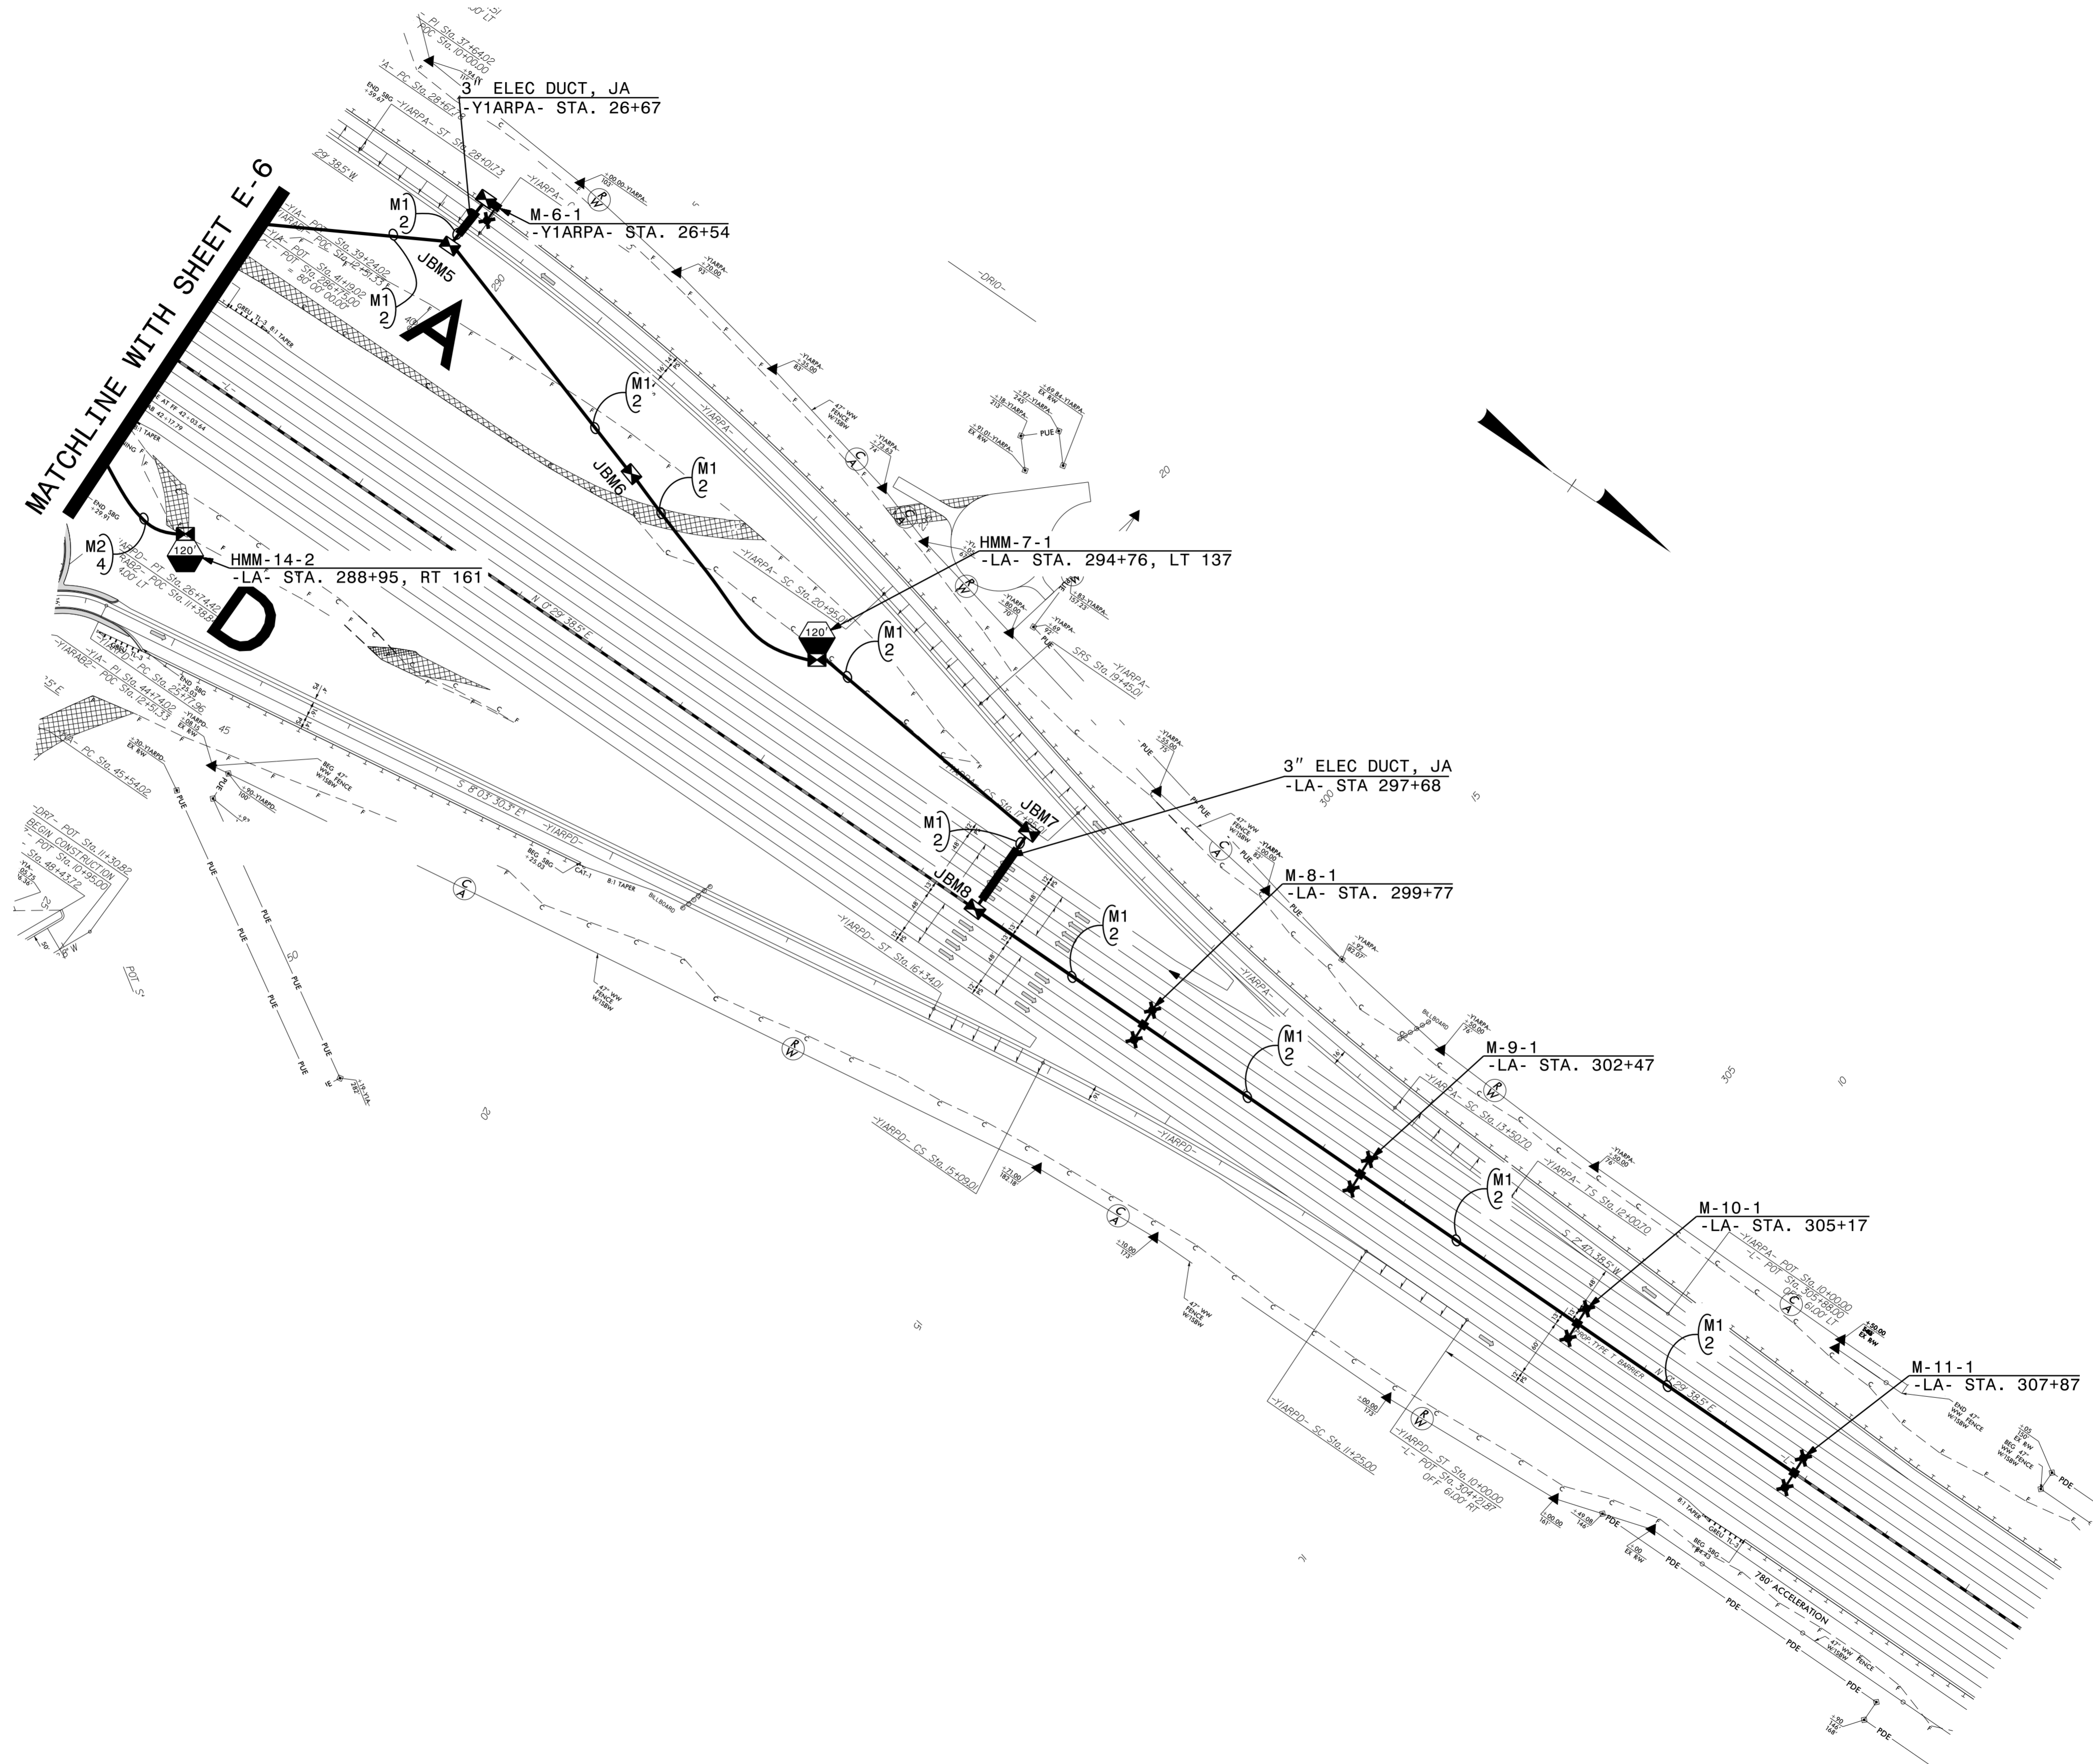

DOCUMENT NOT CONSIDERED FINAL
UNLESS ALL SIGNATURES COMPLETED



SEE SHEET "E-1" FOR
LEGEND & △ NOTES

2			
1			
Rev.	Date	Description	Approved
NORTH CAROLINA DEPARTMENT OF TRANSPORTATION ROADWAY DESIGN LIGHTING/ELECTRICAL SECTION LIGHTING LAYOUT I-95/US 301 INTERCHANGE (EXIT 25) ROBESON COUNTY			
Drawn By:	SAM	Approved By:	RGH
		Dwg No.:	

08-MAR-2022 10:40
 R:\Lighting\Lighting Design\I-5987A CS - L & M\I5987A.LE_PSH.E-7.dgn
 somehtk AT RD-307555