


09_08/21

TIP PROJECT: B-5318

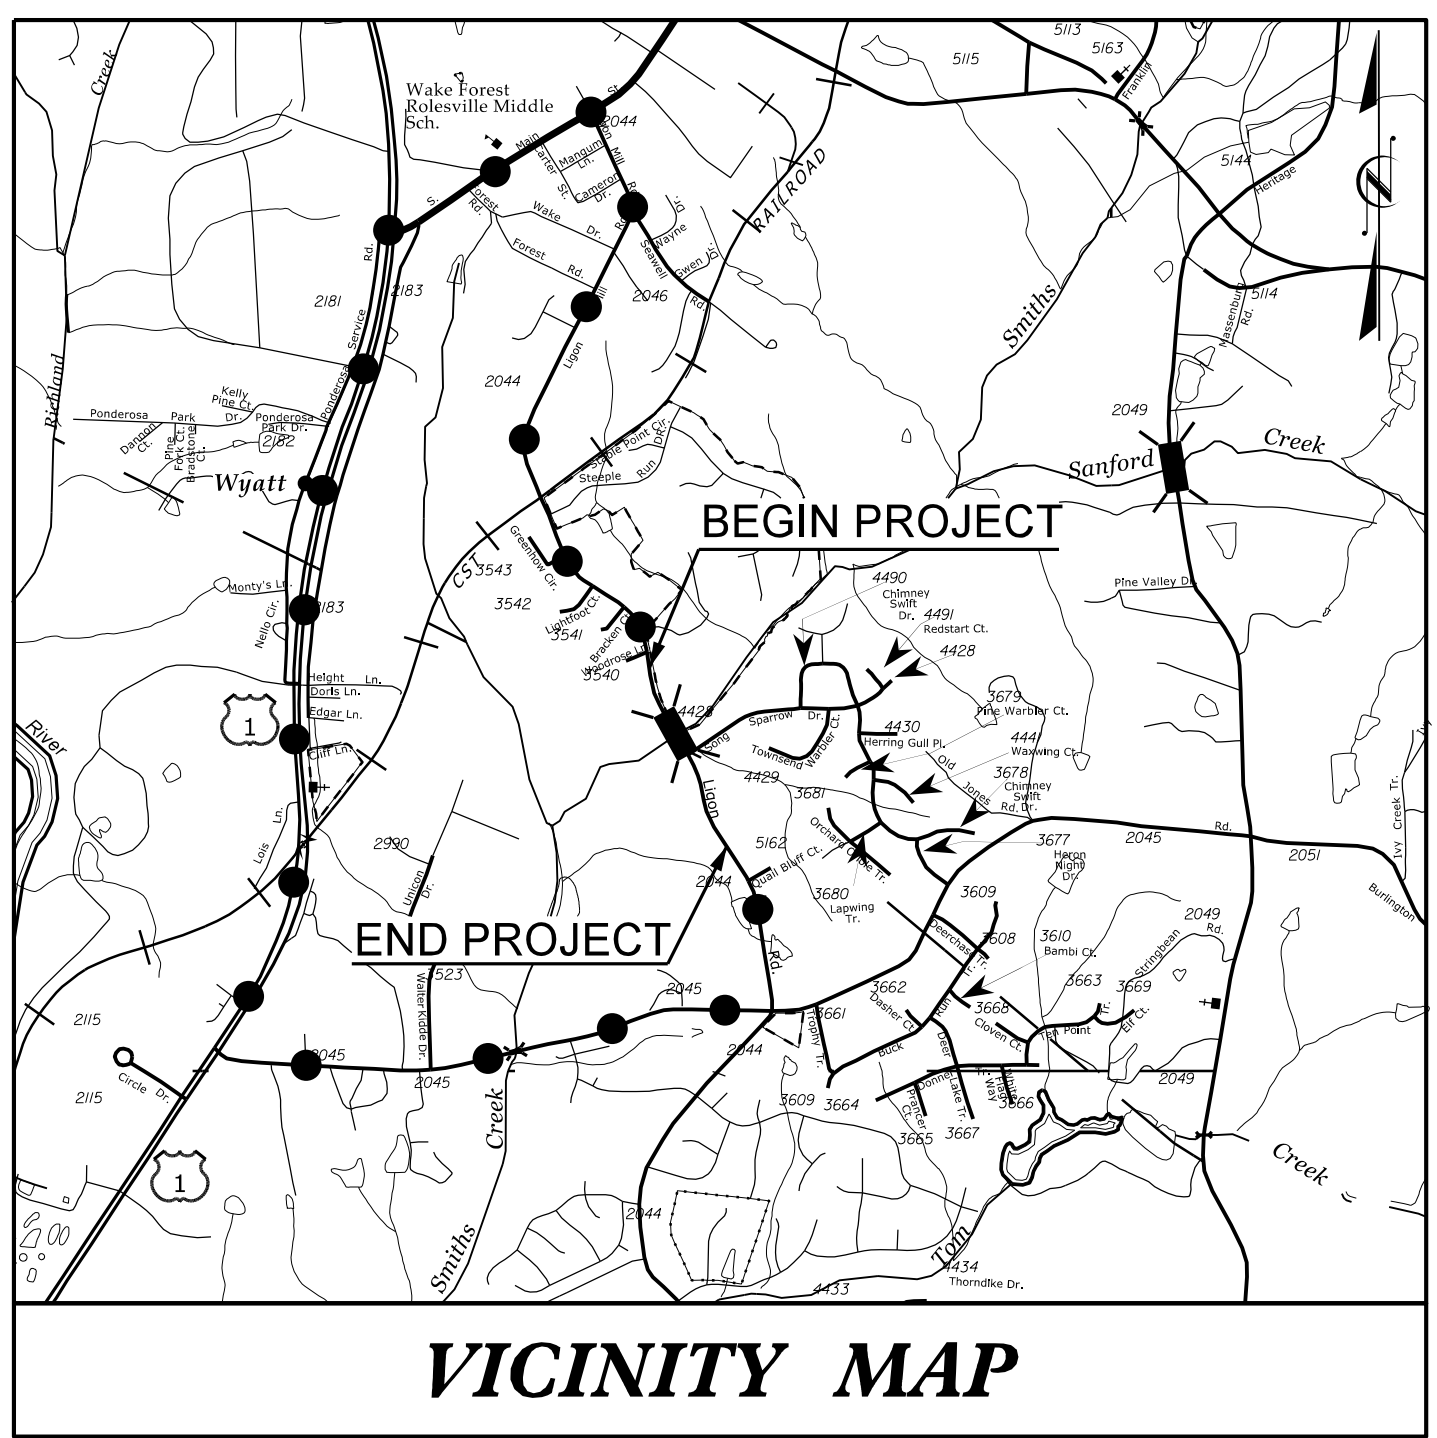

STATE OF NORTH CAROLINA
DIVISION OF HIGHWAYS

**UTILITY CONSTRUCTION PLANS
WAKE COUNTY**

LOCATION: SMITH CREEK ON SR 2044 (LIGON MILL ROAD)

TYPE OF WORK: WATER & SEWER RELOCATION

T.I.P. NO.	SHEET NO.
B-5318	UC-1

SITE PERMITTING APPROVAL

Water and Sewer Permits (if applicable)
The City of Raleigh consents to the connection and extension of the City's Public Sewer System as shown on this plan. The material and construction methods used for this project shall conform to the standards and specifications of the City's Public Utilities Handbook. City of Raleigh Public Utilities Department Permit # S-4929
The City of Raleigh consents to the connection and extension of the City's Public Water System as shown on this plan. The material and construction methods used for this project shall conform to the standards and specifications of the City's Public Utilities Handbook. City of Raleigh Public Utilities Department Permit # WV-3587
The City of Raleigh consents to the connection to its public sewer system and extension of the private sewer collection system as shown on this plan. The material and construction methods used for this project shall conform to the standards and specifications of the City's Public Utilities Handbook.
City of Raleigh Public Utilities Department Permit # N/A

CITY OF RALEIGH - PLANS AUTHORIZED FOR CONSTRUCTION

Plans for the proposed use have been reviewed for general compliance with applicable codes. This limited review, and authorization for construction is not to be considered to represent total compliance with all legal requirements for development and construction. The property owner, design consultants, and contractors are each responsible for compliance with all applicable City, State and Federal laws. This specific authorization below is not a permit, nor shall it be construed to permit any violation of City, State or Federal Law. All construction must be in accordance with all Local, State, and Federal Rules and Regulations.




Electronic Approval: This approval is being issued electronically. This approval is valid only upon the signature of a City of Raleigh Review Officer below. The City will retain a copy of the approved plans. Any work authorized by this approval must proceed in accordance with the plans kept on file with the City. This electronic approval may not be edited once issued. Any modification to this approval once issued will invalidate this approval.

These plans have been electronically approved for construction by the Town of Wake Forest Planning Department. This approval may not be edited once issued.

Patrick Reidy
Patrick Reidy 11/04/2024
Planning

These plans have been electronically approved for construction by the Town of Wake Forest Public Works and Engineering Department. This approval may not be edited once issued.

Carlie Mitchell
Carlie Mitchell 11/08/2021
Public Works/Engineering

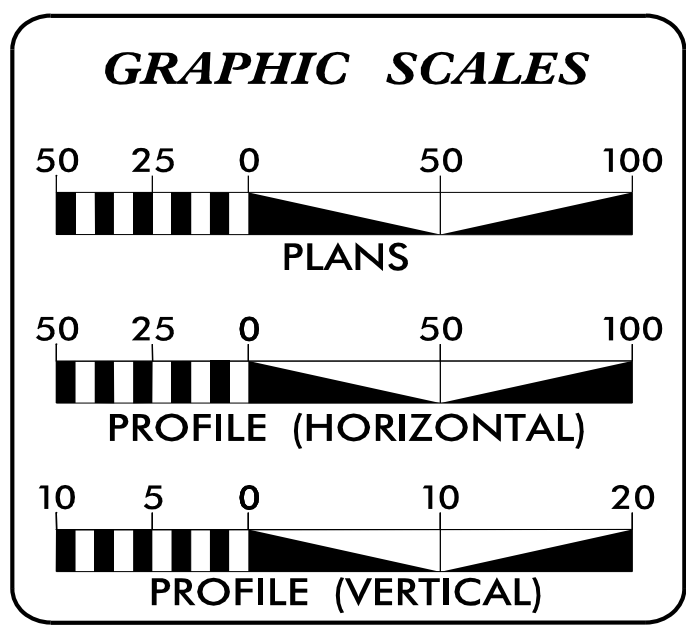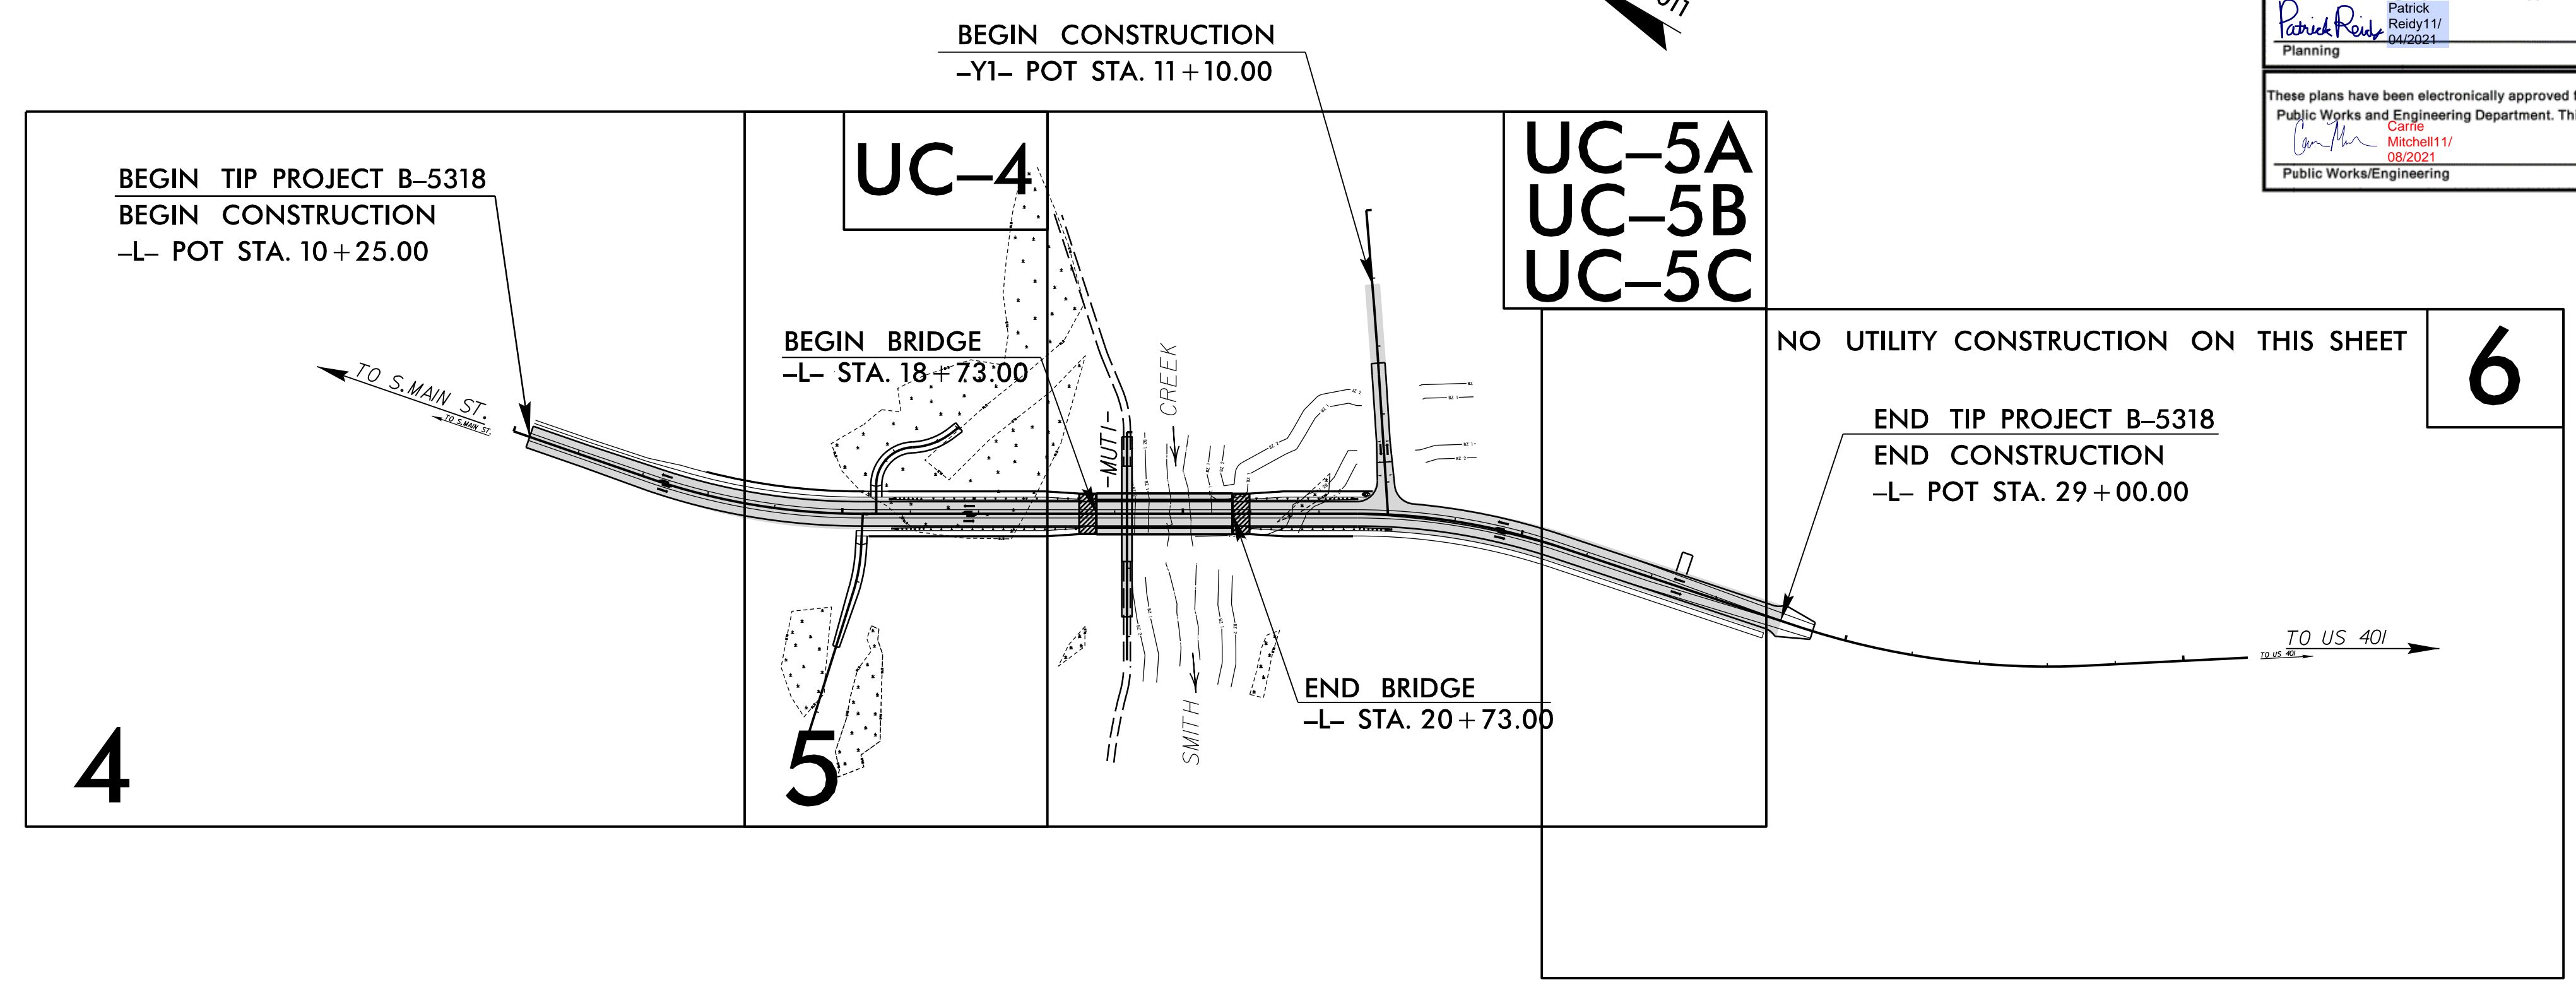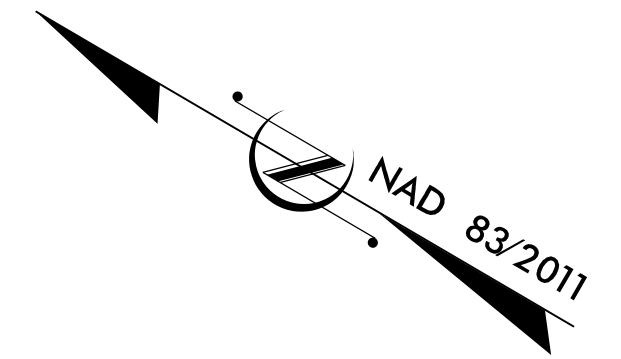

INDEX OF SHEETS

SHEET NO.:	DESCRIPTION:
UC-1	TITLE SHEET
UC-2	UTILITY SYMBOLOGY
UC-3	NOTES
UC-3A THRU UC-3D	DETAILS
UC-4 THRU UC-5B	UTILITY PLAN & PROFILE
UC-5C	TEMPORARY BYPASS PUMPING PLAN

WATER AND SEWER OWNERS ON PROJECT

(A) WATER CITY OF RALEIGH
(B) SANITARY SEWER CITY OF RALEIGH

PREPARED IN THE OFFICE OF

Dewberry

2610 WYCLIFF ROAD
SUITE 410
RALEIGH, NC 27607
PHONE: 919.981.9939
NC COA No. F-0929

LARRY MITCHELL, P.E. PROJECT MANAGER
TIMOTHY RITACCO, P.E. PROJECT ENGINEER
DUSTIN JAMES DESIGNER

SEAL

11/1/2021

**DIVISION OF HIGHWAYS
DIVISION 5
PROJECT DELIVERY UNIT
2612 N. DUKE STREET
DURHAM, NC 27704**

TRACY PARROT PROJECT DELIVERY ENGINEER
LISA GILCRIST, EI BRIDGE PROGRAM MANAGER
DON PROPER DIV. 5 UTILITY ENGINEER
MONROE BROWN DIV. 5 UTILITY COORDINATOR

28-OCT-2021 15:14
C:\CAD\B-5318\Utilities\Engineering\UC\Proj\280_000_B5318_UT_RDY01_UC-1_TSH.dgn
\$\$\$\$\$SERVNAME\$\$\$\$\$