


CONTRACT: TIP PROJECT: BP7.R006

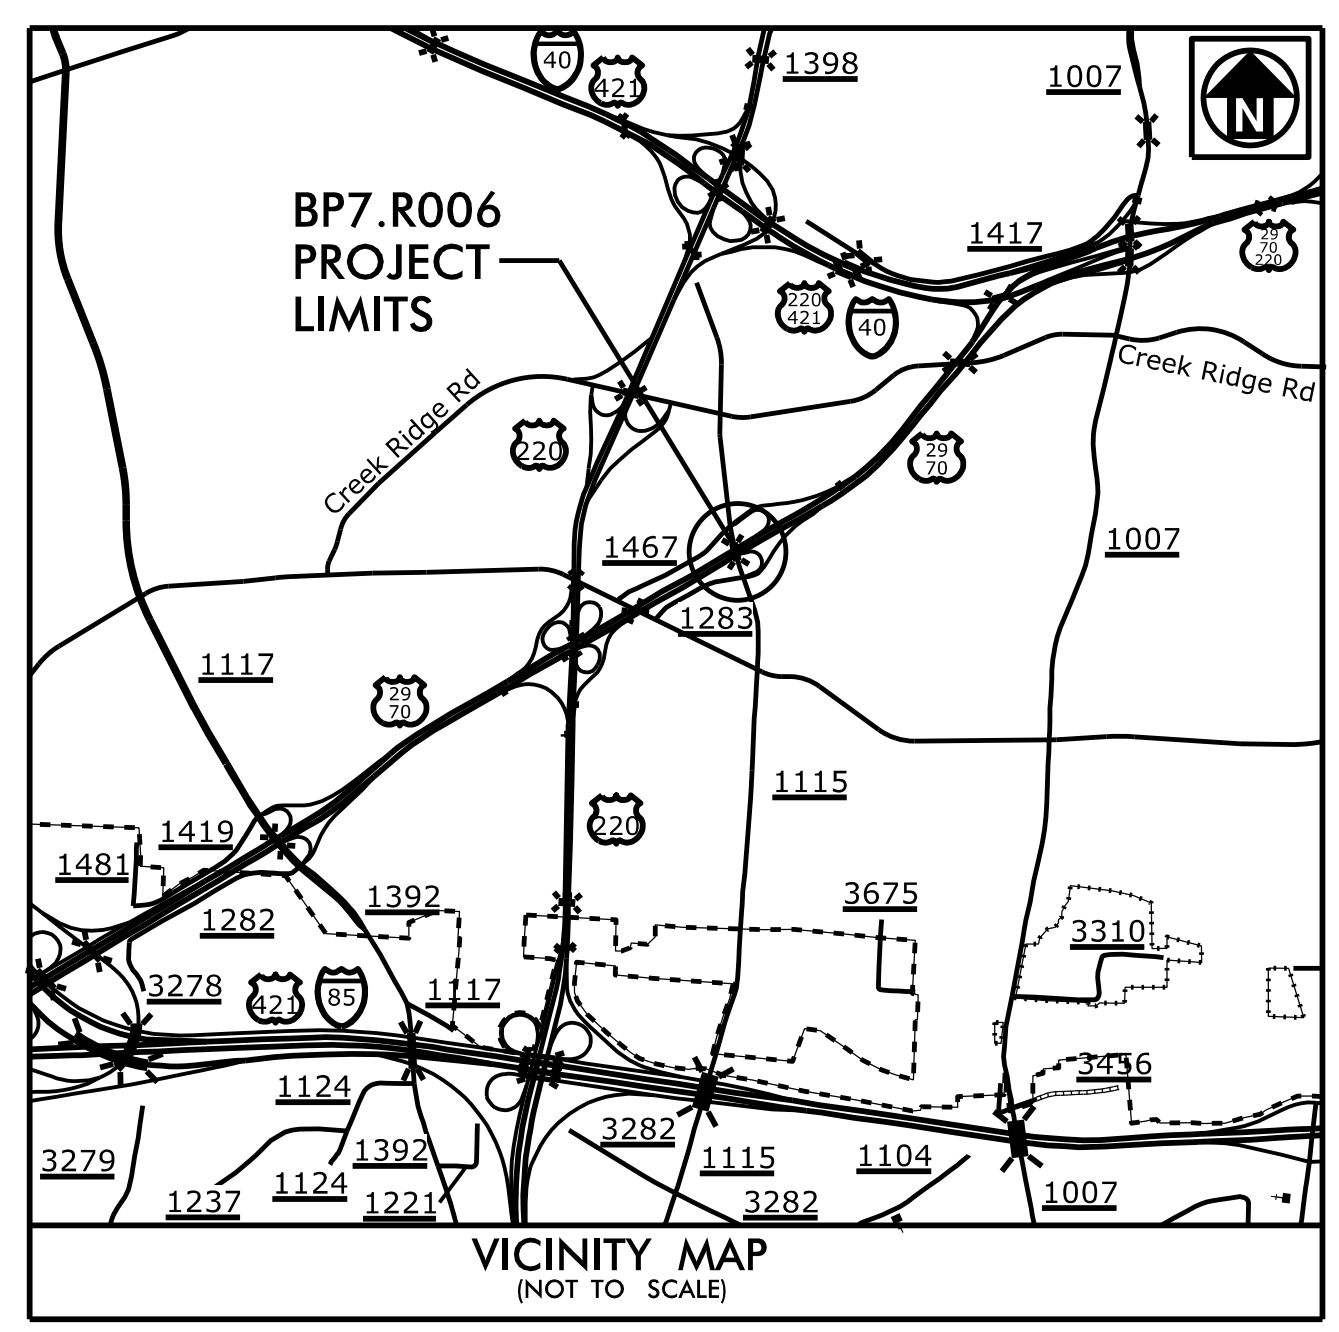


STATE OF NORTH CAROLINA  
 DIVISION OF HIGHWAYS  
**GUILFORD COUNTY**

**LOCATION: BRIDGE NO. 225 OVER US 29/70 ON SR 1115  
 (REHOBETH CHURCH ROAD) IN GREENSBORO**

**TYPE OF WORK: GRADING, PAVING, DRAINAGE, SIGNAL, ITS AND STRUCTURE**

STATE	STATE PROJECT REFERENCE NO.	SHEET NO.	TOTAL SHEETS
N.C.	BP7.R006	1	
STATE PROJ. NO.	F.A. PROJ. NO.	DESCRIPTION	
BP7.R006.1		PE	
BP7.R006.2		ROW	
BP7.R006.3		CONSTRUCTION	

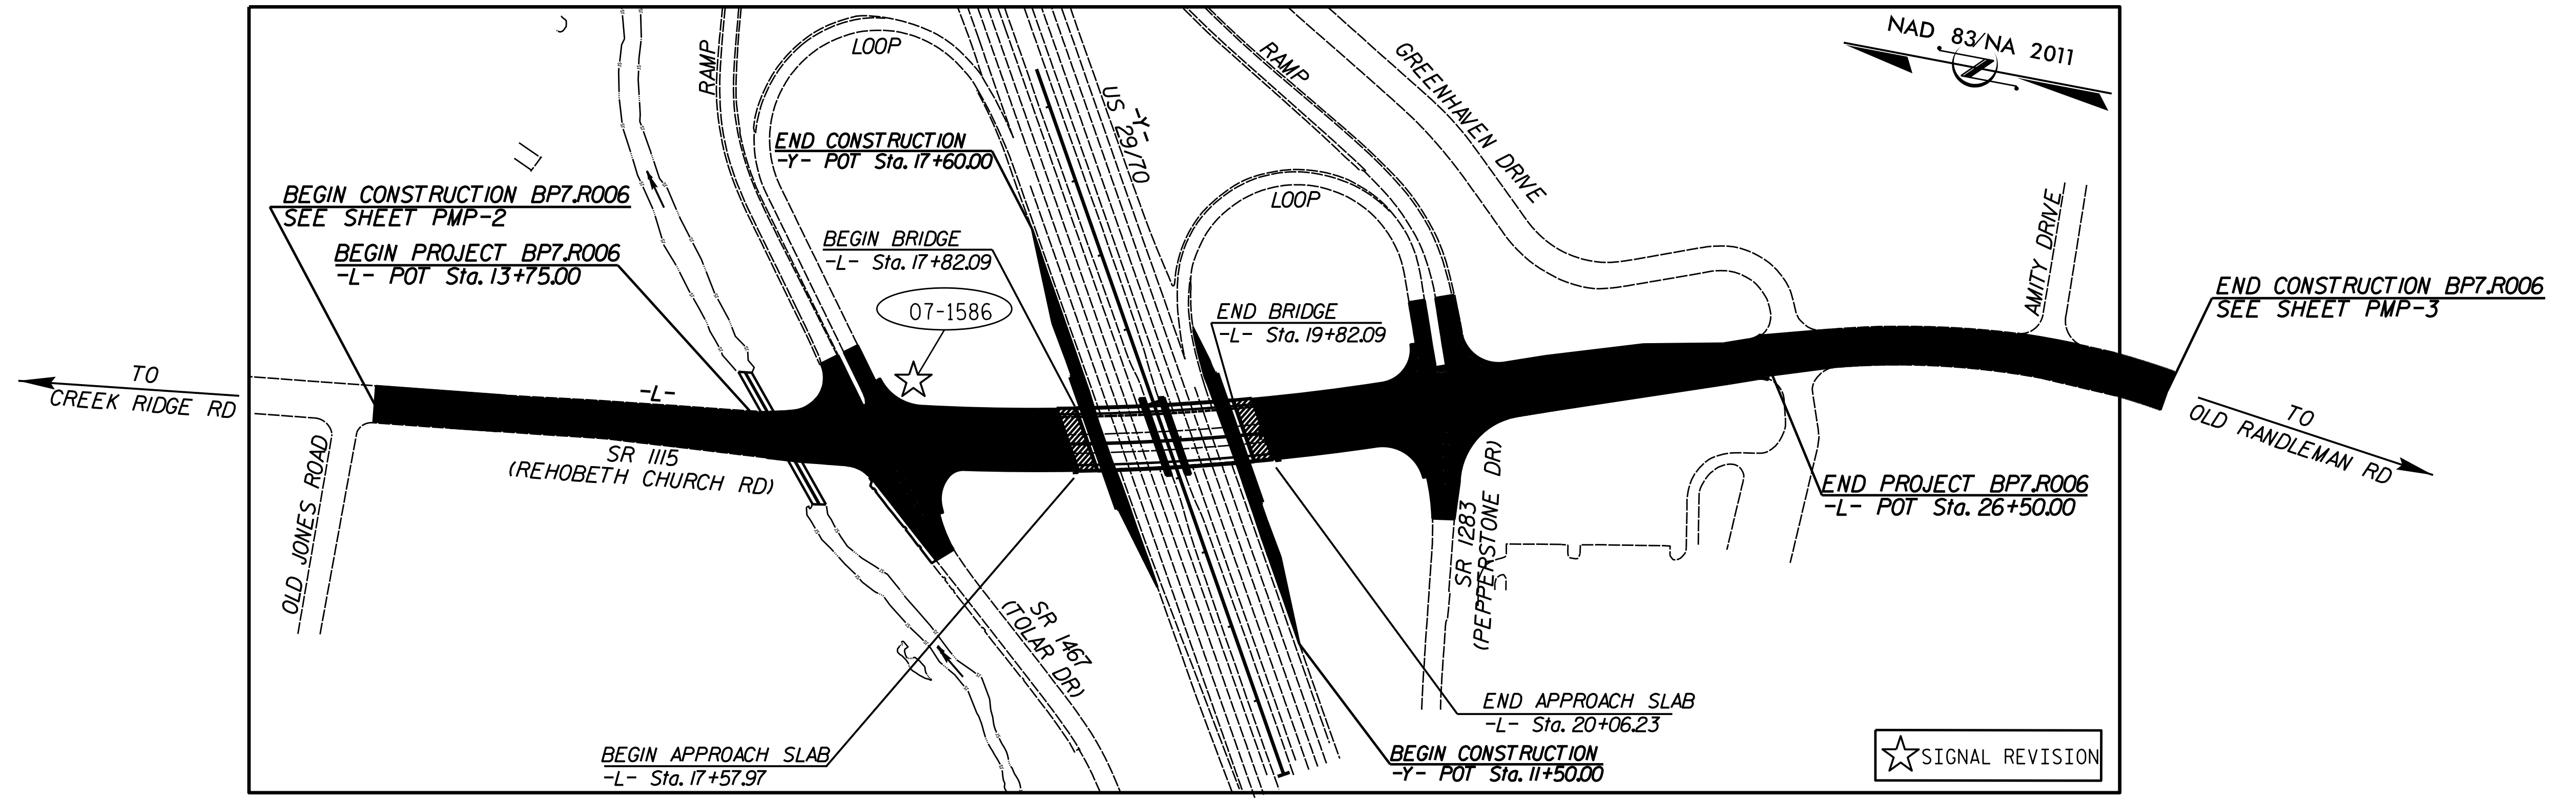

CLEARING ON THIS PROJECT SHALL BE PERFORMED TO THE LIMITS ESTABLISHED BY METHOD II.

Sheet #	Reference #	Location/Description
Sheet #		
Fig. 1.0	-----	Title Sheet
Fig. 1.1-1.2	-----	Std. Plate Sheets
Fig. 2.0-4.1	07-2026	SR 1115 (Rehobeth Church Road) at I-85 Bus.
Fig. M1-M8	-----	SB Ramp/SR 1467 (Tolar Drive)
SCP 1-11	-----	Std. Metal Pole Sheets
		Signal Communication Plan

Prepared for the Office of:  
 DIVISION OF HIGHWAYS  
**TRANSPORTATION MOBILITY AND SAFETY**  
 DIVISION

**TRANSPORTATION SYSTEMS MANAGEMENT  
 AND OPERATIONS UNIT**

NCDOT Contacts:  
**Rob Ziemba, PE - Central Region Signals Engineer**  
**Keith Mims, PE - Signal Equipment Design Engineer**  
**Gregg Green - Signal Communication Project Engineer**

750 N. Greenfield Parkway, Garner, NC 27529

Refer to Roadway Standard Drawings  
 NCDOT dated January 2018 and  
 Standard Specifications for Roads  
 and Structures dated January 2018.

**M M**  
**MOTT MACDONALD**  
 7621 Purfoy Rd Suite 115  
 Fuquay-Varina, NC 27526  
 www.mtm.com  
 License No. F-0669

**Rusty Thompson, PE - Mott MacDonald Project Manager**  
**Neil Avery - Senior Specialist ITS**

DOCUMENT NOT CONSIDERED FINAL  
 UNLESS ALL SIGNATURES COMPLETED