


T.I.P. NO. U-5826	SHEET NO. UC-1
-----------------------------	--------------------------

TIP PROJECT: U-5826

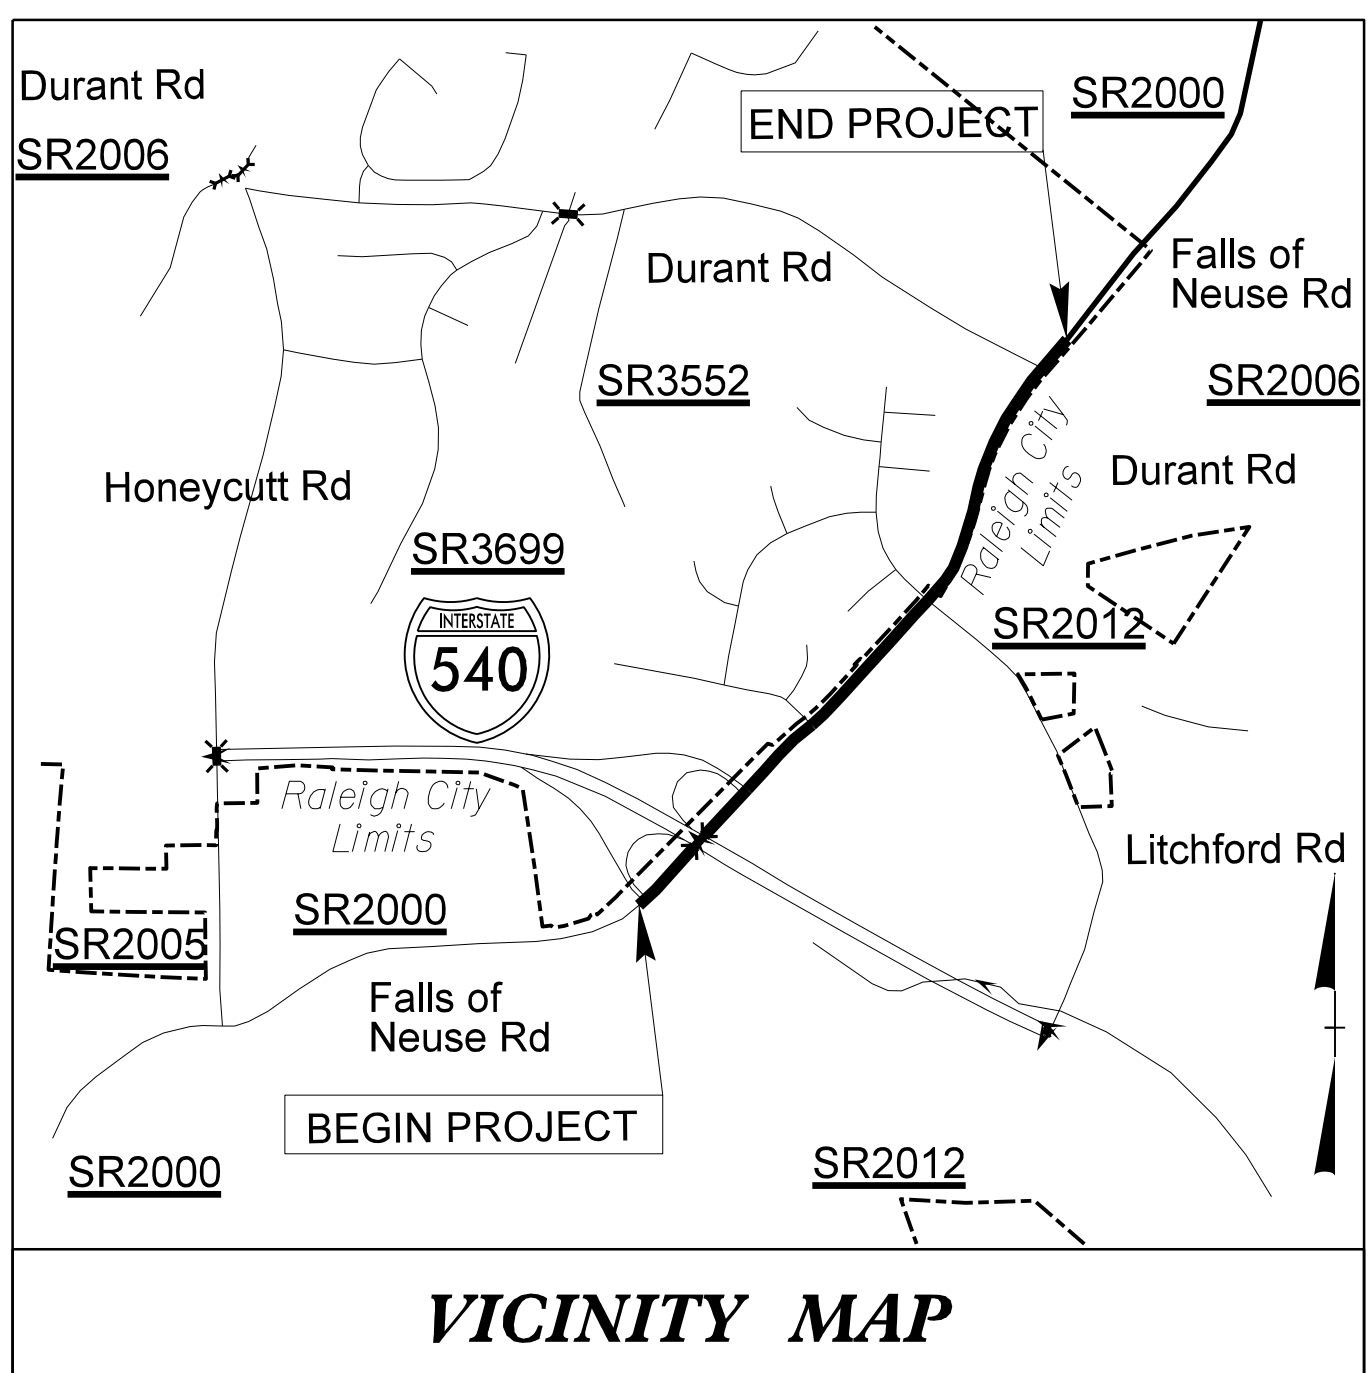

STATE OF NORTH CAROLINA
DIVISION OF HIGHWAYS

**UTILITY CONSTRUCTION PLANS
WAKE COUNTY**

**LOCATION: FALLS OF NEUSE ROAD (SR 2000)
FROM I-540 TO DURANT ROAD (SR 2006)**

**TYPE OF WORK: WATER LINE, WATER SERVICE,
AND FIRE HYDRANT RELOCATION**

ATTENTION CONTRACTORS
The *Construction Contractor* responsible for the extension of water, sewer, and/or reuse, as approved in these plans, is responsible for *contacting the Public Works Department* at (919) 996-2409, and the *Public Utilities Department* at (919) 996-4540 at least *twenty four hours* prior to beginning any of their construction.

 
Failure to notify both *City Departments* in advance of beginning construction, will result in the issuance of *monetary fines*, and require reinstallation of any water or sewer facilities not inspected as a result of this notification failure.


Failure to call for *Inspection, Install a Downstream Plug*, have *Permitted Plans* on the *Jobsite*, or any other *Violation of City of Raleigh Standards* will result in a *Fine and Possible Exclusion* from future work in the *City of Raleigh*.

SITE PERMITTING APPROVAL

Water and Sewer Permits (if applicable)
The City of Raleigh consents to the connection and extension of the City's Public Water System as shown on this plan. The material and construction methods used for this project shall conform to the standards and specifications of the City's Public Utilities Handbook, City of Raleigh Public Utilities Department Permit # W-3228.


CITY OF RALEIGH - PLANS AUTHORIZED FOR CONSTRUCTION
Electronic Approval: This approval is being issued electronically. This approval is valid only upon the signature of a City of Raleigh Review Officer below. The City will retain a copy of the approved plans. Any work authorized by this approval must proceed in accordance with the plans kept on file with the City. This electronic approval may not be edited once issued. Any modification to this approval once issued will invalidate this approval.

City of Raleigh Development Approval: 
Rene Haagen
Raleigh Water Review Officer

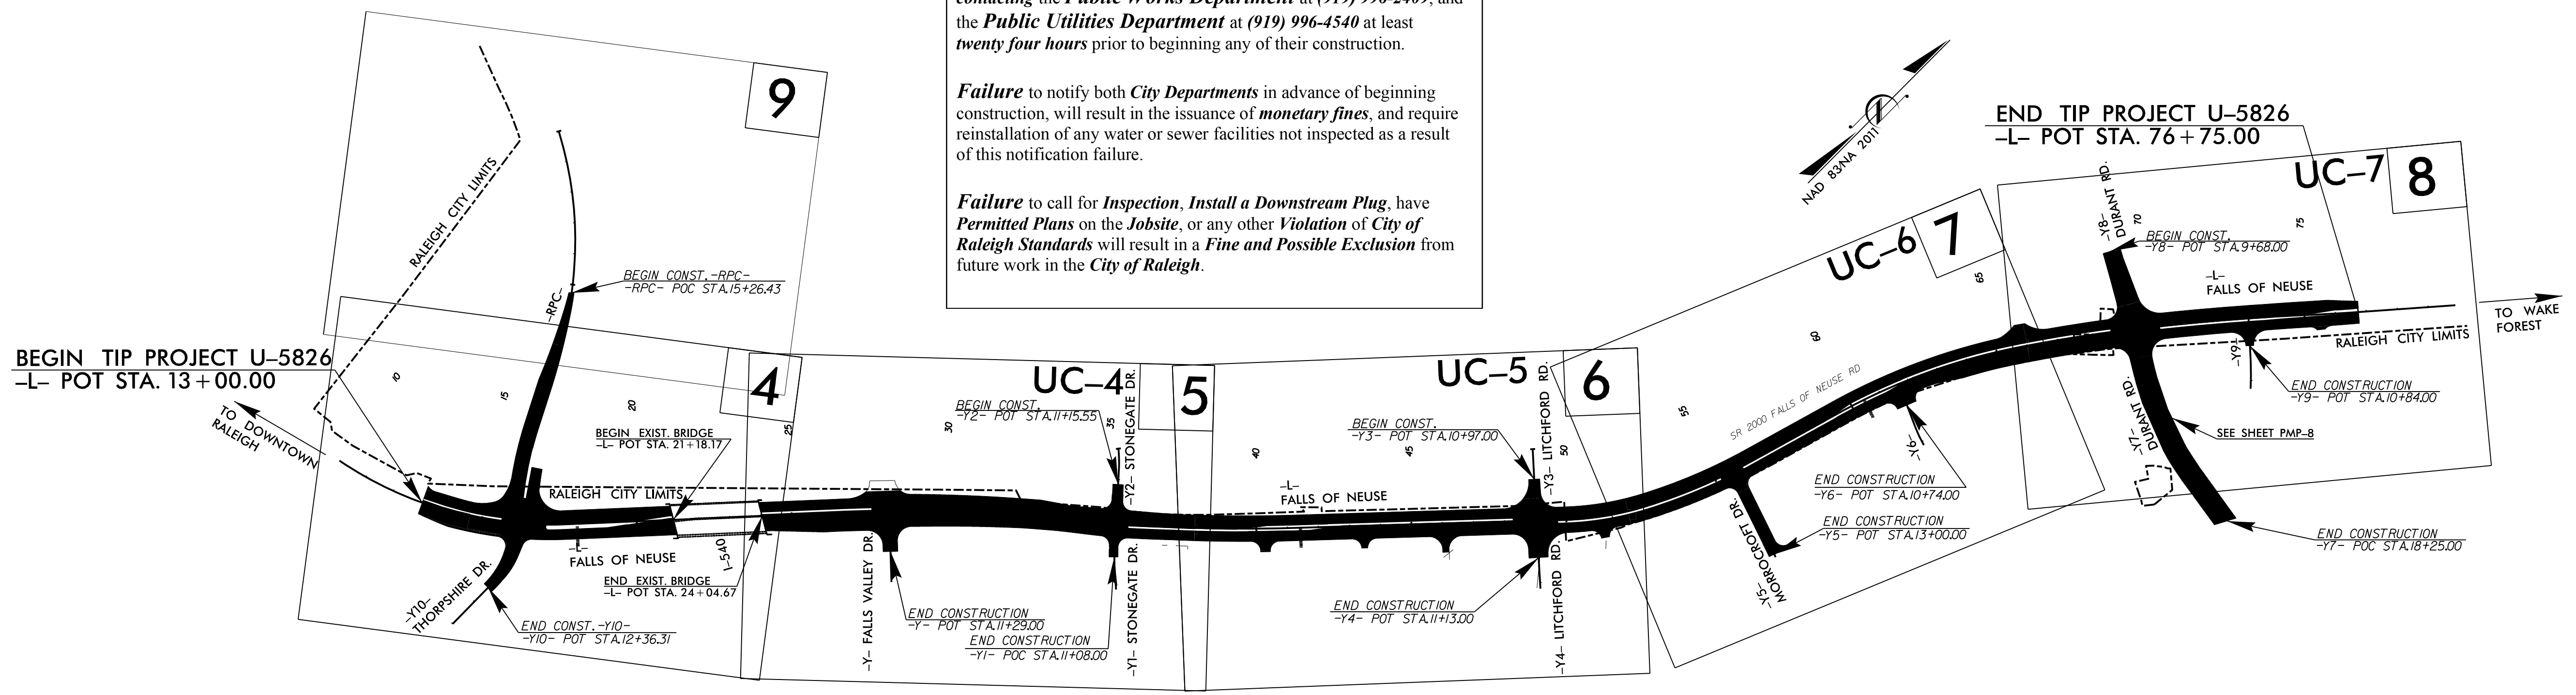

07-FEB-2023 10:34 MA_2019_1201906027_01U-5826 Falls of Neuse TO #3\Water-Wastewater\U-5826.ut_tsh_uc01.psh.dgn \$\$\$USERNAME\$\$\$

DOCUMENT NOT CONSIDERED FINAL UNTIL ALL SIGNATURES ARE COMPLETED

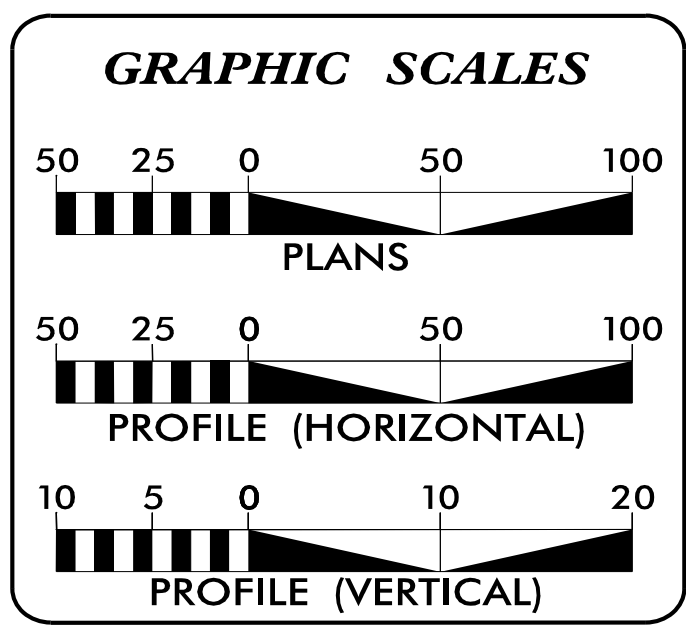


INDEX OF SHEETS

SHEET NO.:	DESCRIPTION:
UC-1	TITLE SHEET
UC-2	UTILITY SYMBOLOGY
UC-3	NOTES
UC-3A, 3B, 3C	DETAILS
UC-4 THRU UC-7	PLAN SHEETS
UC-8	PROFILE SHEET

WATER OWNER ON PROJECT

CITY OF RALEIGH PUBLIC UTILITIES DEPARTMENT
ONE EXCHANGE PLAZA
BOX #620
RALEIGH, NC 27601



PREPARED IN THE OFFICE OF



Engineers • Planners • Scientists • Construction Managers
4505 Falls of Neuse Road, Suite 400
Raleigh, NC 27609
Phone (919) 783-9214 • Fax (919) 783-9266
License No. C-764

MARCO MENENDEZ, PE PROJECT ENGINEER
MARCO MENENDEZ, PE PROJECT MANAGER
CHARLES SHEARON PROJECT DESIGNER

SEAL

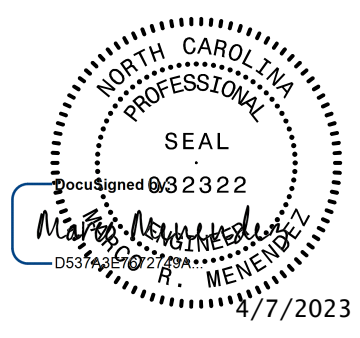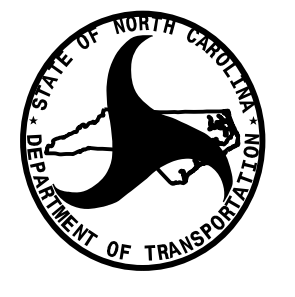DIVISION OF HIGHWAYS UTILITIES UNIT
1555 MAIL SERVICES CENTER
RALEIGH, NC 27699-1555
PHONE (919) 707-6690
FAX (919) 250-4151

BEN UPSHAW, P.E. TEAM LEAD
S. REID DAVIDSON, P.E. DDC ENGINEER
DON PROPER DIV. 5 UTILITIES ENGINEER
MONROE BROWN DIV. 5 UTILITIES COORDINATOR