


09.08/99  
 22-AUG-2022 10:31  
 MA\2013\213335\03 NCDOT U-5826 Falls of the Neuse Rd\Utilities\290\_00\U-5826\_ut\_tsh\_U001\_psh.dgn  
 \$\$\$SERVERNAME\$\$\$

**TIP PROJECT: U-5826**

**CONTRACT: C204380**

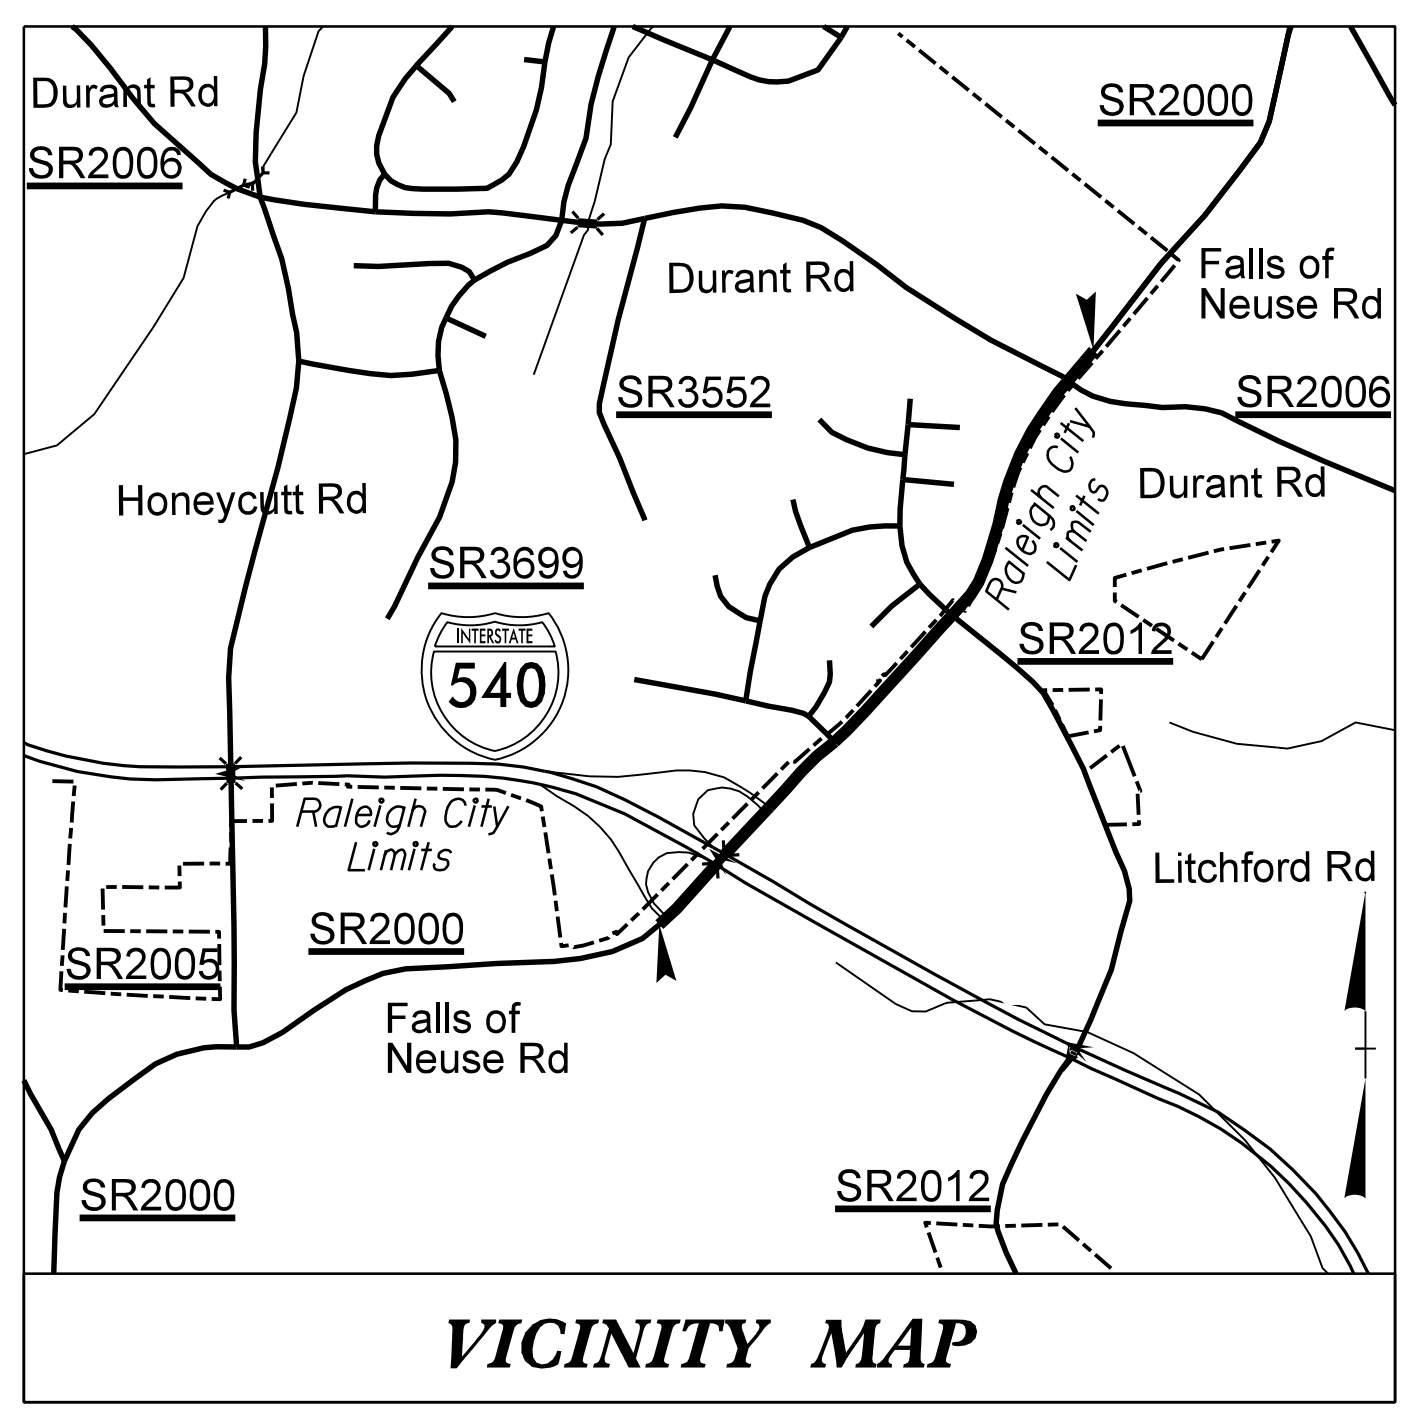



STATE OF NORTH CAROLINA  
DIVISION OF HIGHWAYS

**UTILITIES BY OTHERS PLANS  
WAKE COUNTY**

**LOCATION: U-5826 FALLS OF NEUSE ROAD (SR 2000)  
 FROM I-540 TO DURANT ROAD (SR 2006)**  
**TYPE OF WORK: AERIAL/BURIED POWER (DISTRIBUTION)  
 AERIAL/BURIED COMMUNICATION**

T.I.P. NO.	SHEET NO.
<b>U-5826</b>	<b>UO-1</b>

**NOTE:**  
 ALL UTILITY WORK SHOWN ON THIS SHEET WILL BE DONE BY OTHERS. NO PAYMENT WILL BE MADE TO THE CONTRACTOR FOR UTILITY WORK SHOWN ON THIS SHEET.

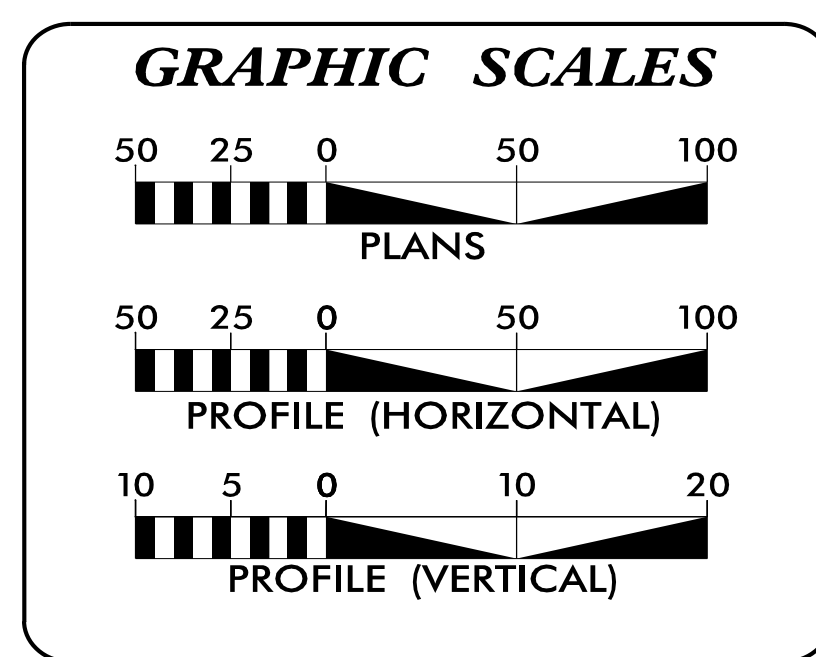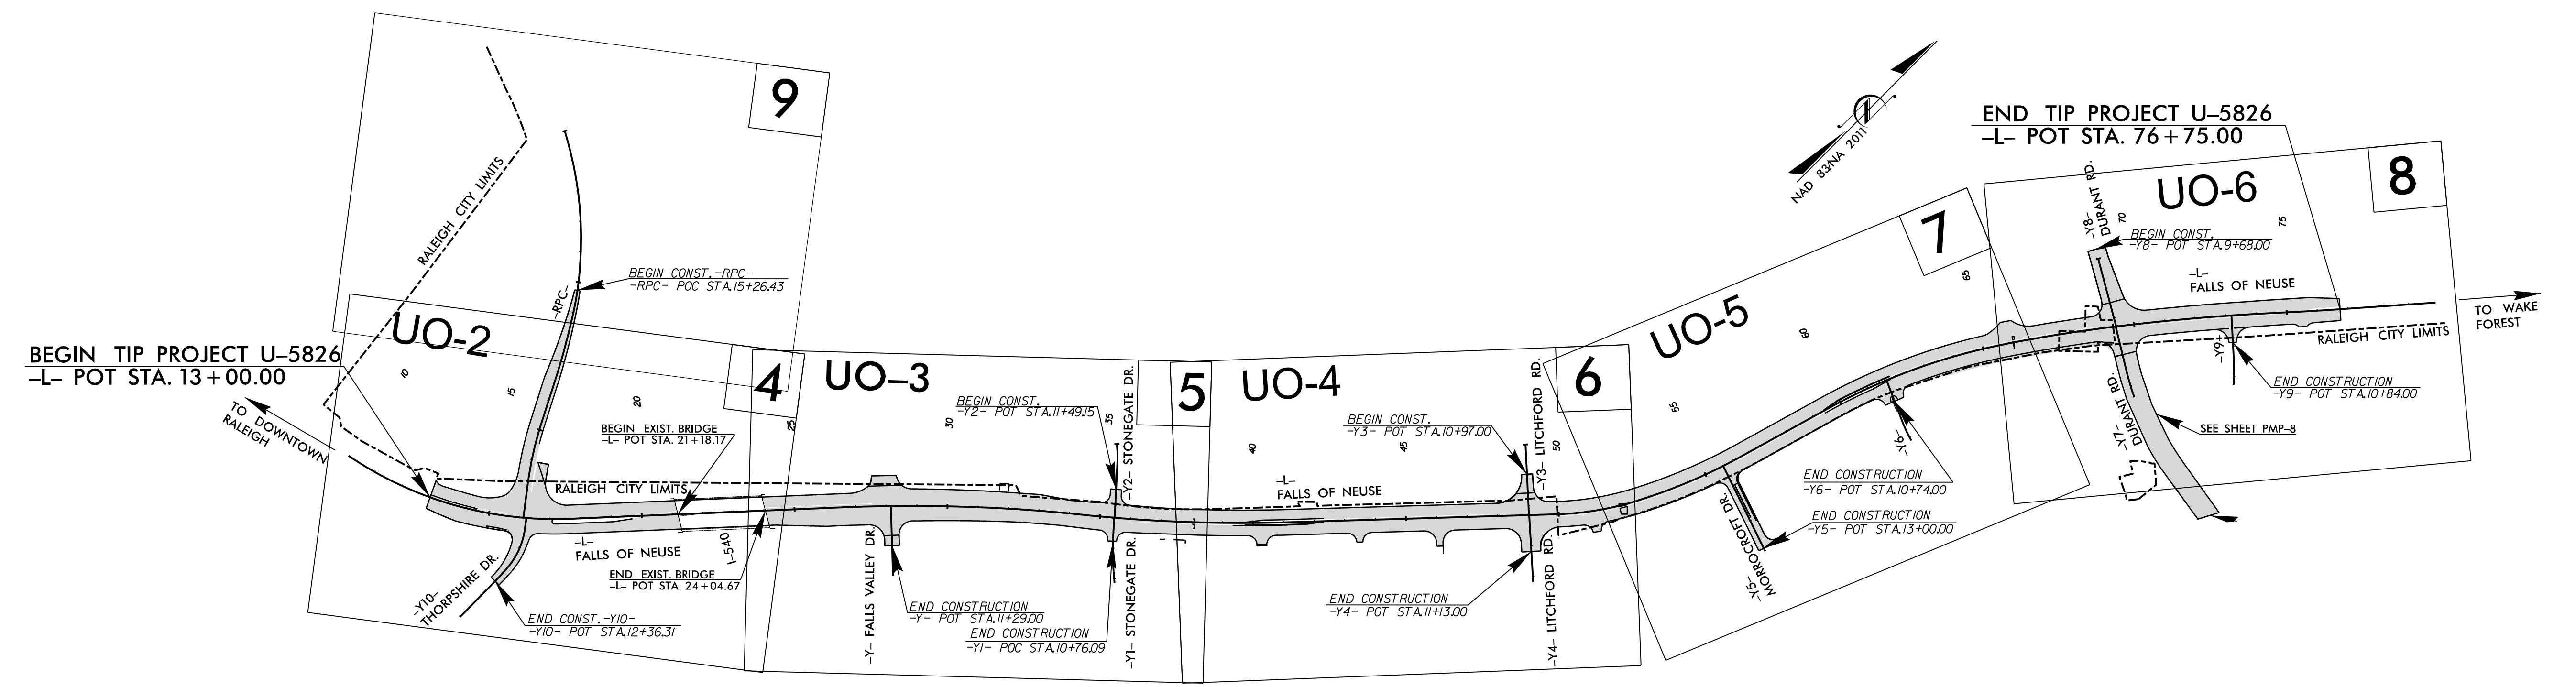

**INDEX OF SHEETS**

SHEET NO.:	DESCRIPTION:
UO-1	TITLE SHEET
UO-2 THRU UO-6	UBO PLAN SHEETS

- UTILITY OWNERS WITH CONFLICTS**
- (A) DUKE ENERGY - POWER (DISTRIBUTION)
  - (B) CITY OF RALEIGH - FIBER /ITS
  - (C) CHARTER /SPECTRUM - COMMUNICATIONS
  - (D) VERIZON BUSINESS /MCI - COMMUNICATIONS
  - (E) AT&T - COMMUNICATIONS
  - (F) DOMINION ENERGY - GAS

PREPARED IN THE OFFICE OF:

KCI ASSOCIATES OF N.C., P.A.  
 4505 FALLS OF NEUSE RD, SUITE 400  
 RALEIGH, NC 27609  
 Phone (919) 783-9214  
 Fax (919) 783-9266

JOHN FAISON	UTILITY PROJECT MANAGER
JOHN FAISON	PROJECT UTILITY COORDINATOR
DANIEL ALLEN	PROJECT UTILITY DESIGNER

**DIVISION OF HIGHWAYS  
 DIVISION 5**

PROJECT DELIVERY UNIT  
 815 STADIUM DRIVE  
 DURHAM, NC 27704

BETH QUINN, PE	TEAM LEAD
S. REID DAVIDSON, PE	DDC ENGINEER
DON PROPER	DIV. UTILITIES ENGINEER
MONROE BROWN	DIVISION COORDINATOR