


STATE	STATE PROJECT REFERENCE NO.	SHEET NO.	TOTAL SHEETS
N.C.	U-5824	RW01	24

STATE OF NORTH CAROLINA
DIVISION OF HIGHWAYS


SURVEY CONTROL, EXISTING CENTERLINES,
RIGHT OF WAY, EASEMENTS AND PROPERTY TIES

FORSYTH COUNTY

TIP PROJECT: U-5824

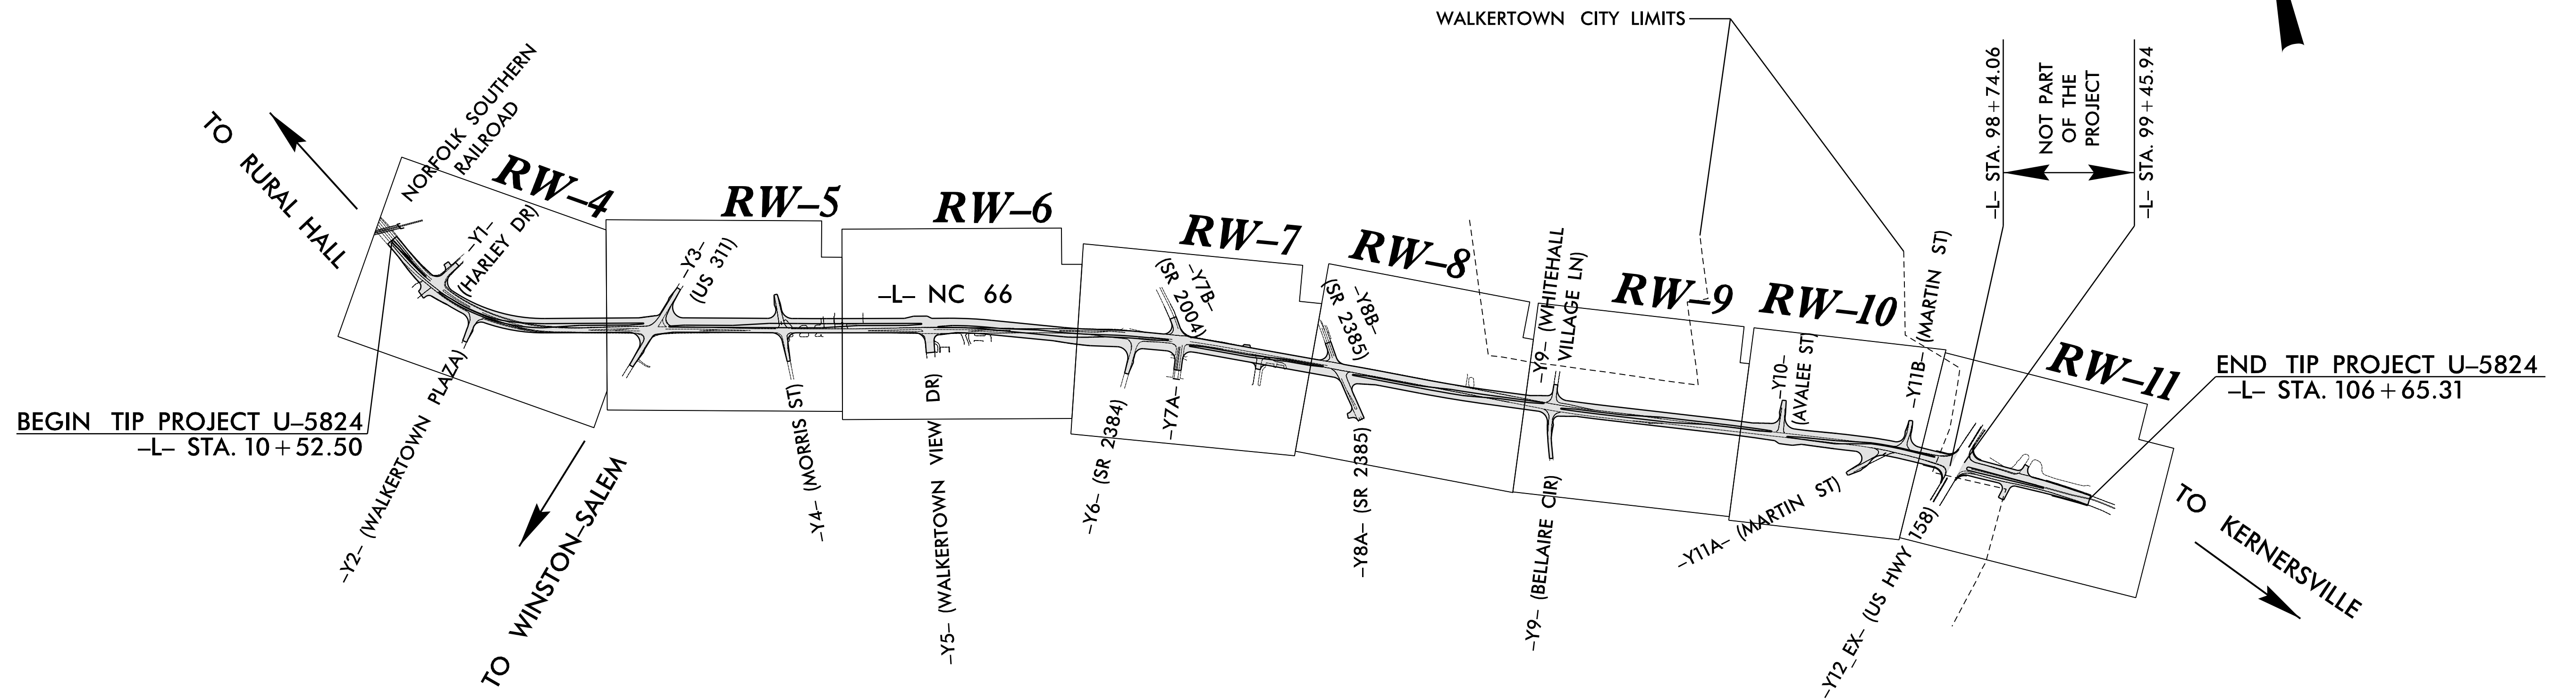

16-AUG-2023 13:08 S:\Project_Development\TIP_Projects_U-U-5824-NC66\Surveys\ControlSheets\U5824-ddc-rw01.dgn \$\$\$USERNAME\$\$\$

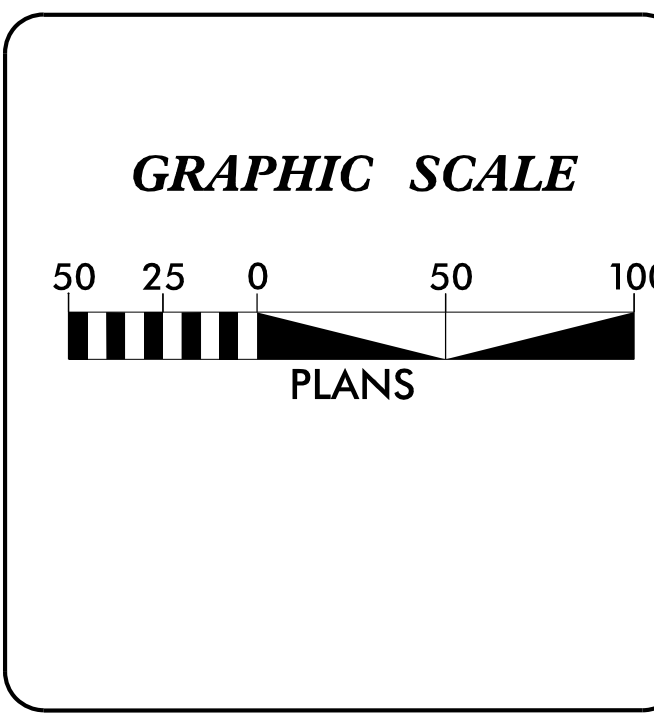

DATUM DESCRIPTION

THE LOCALIZED COORDINATE SYSTEM DEVELOPED FOR THIS PROJECT IS BASED ON THE STATE PLANE COORDINATES ESTABLISHED BY NCDOT FOR MONUMENT "U5824-4" WITH NAD 83/NSRS 2011 STATE PLANE GRID COORDINATES OF NORTHING: 882,418.740(ft) EASTING: 1,660,181.131(ft) ELEVATION: 1,003.380(ft)

THE AVERAGE COMBINED GRID FACTOR USED ON THIS PROJECT (GROUND TO GRID) IS: 0.999957903

THE N.C. LAMBERT GRID BEARING AND LOCALIZED HORIZONTAL GROUND DISTANCE FROM "U5824-4" TO -L- STATION 10+00.00 IS N 72° 11' 41.3" W 4,360.613(ft)

ALL LINEAR DIMENSIONS ARE LOCALIZED HORIZONTAL DISTANCES VERTICAL DATUM USED IS NAVD 88

Prepared in the Office of:

DIVISION OF HIGHWAYS
NINTH DIVISION DESIGN\CONSTRUCT
375 SILAS CREEK PARKWAY WINSTON-SALEM, N.C. 27127

2018 STANDARD SPECIFICATIONS

RIGHT OF WAY DATE: FEBRUARY 22, 2020	LETTING DATE: NOVEMBER 21, 2023
--	---

PROFESSIONAL LAND SURVEYOR

DocuSigned by:
Jeremy Keaton
SIGNATURE

Date: 08/16/2023

