 





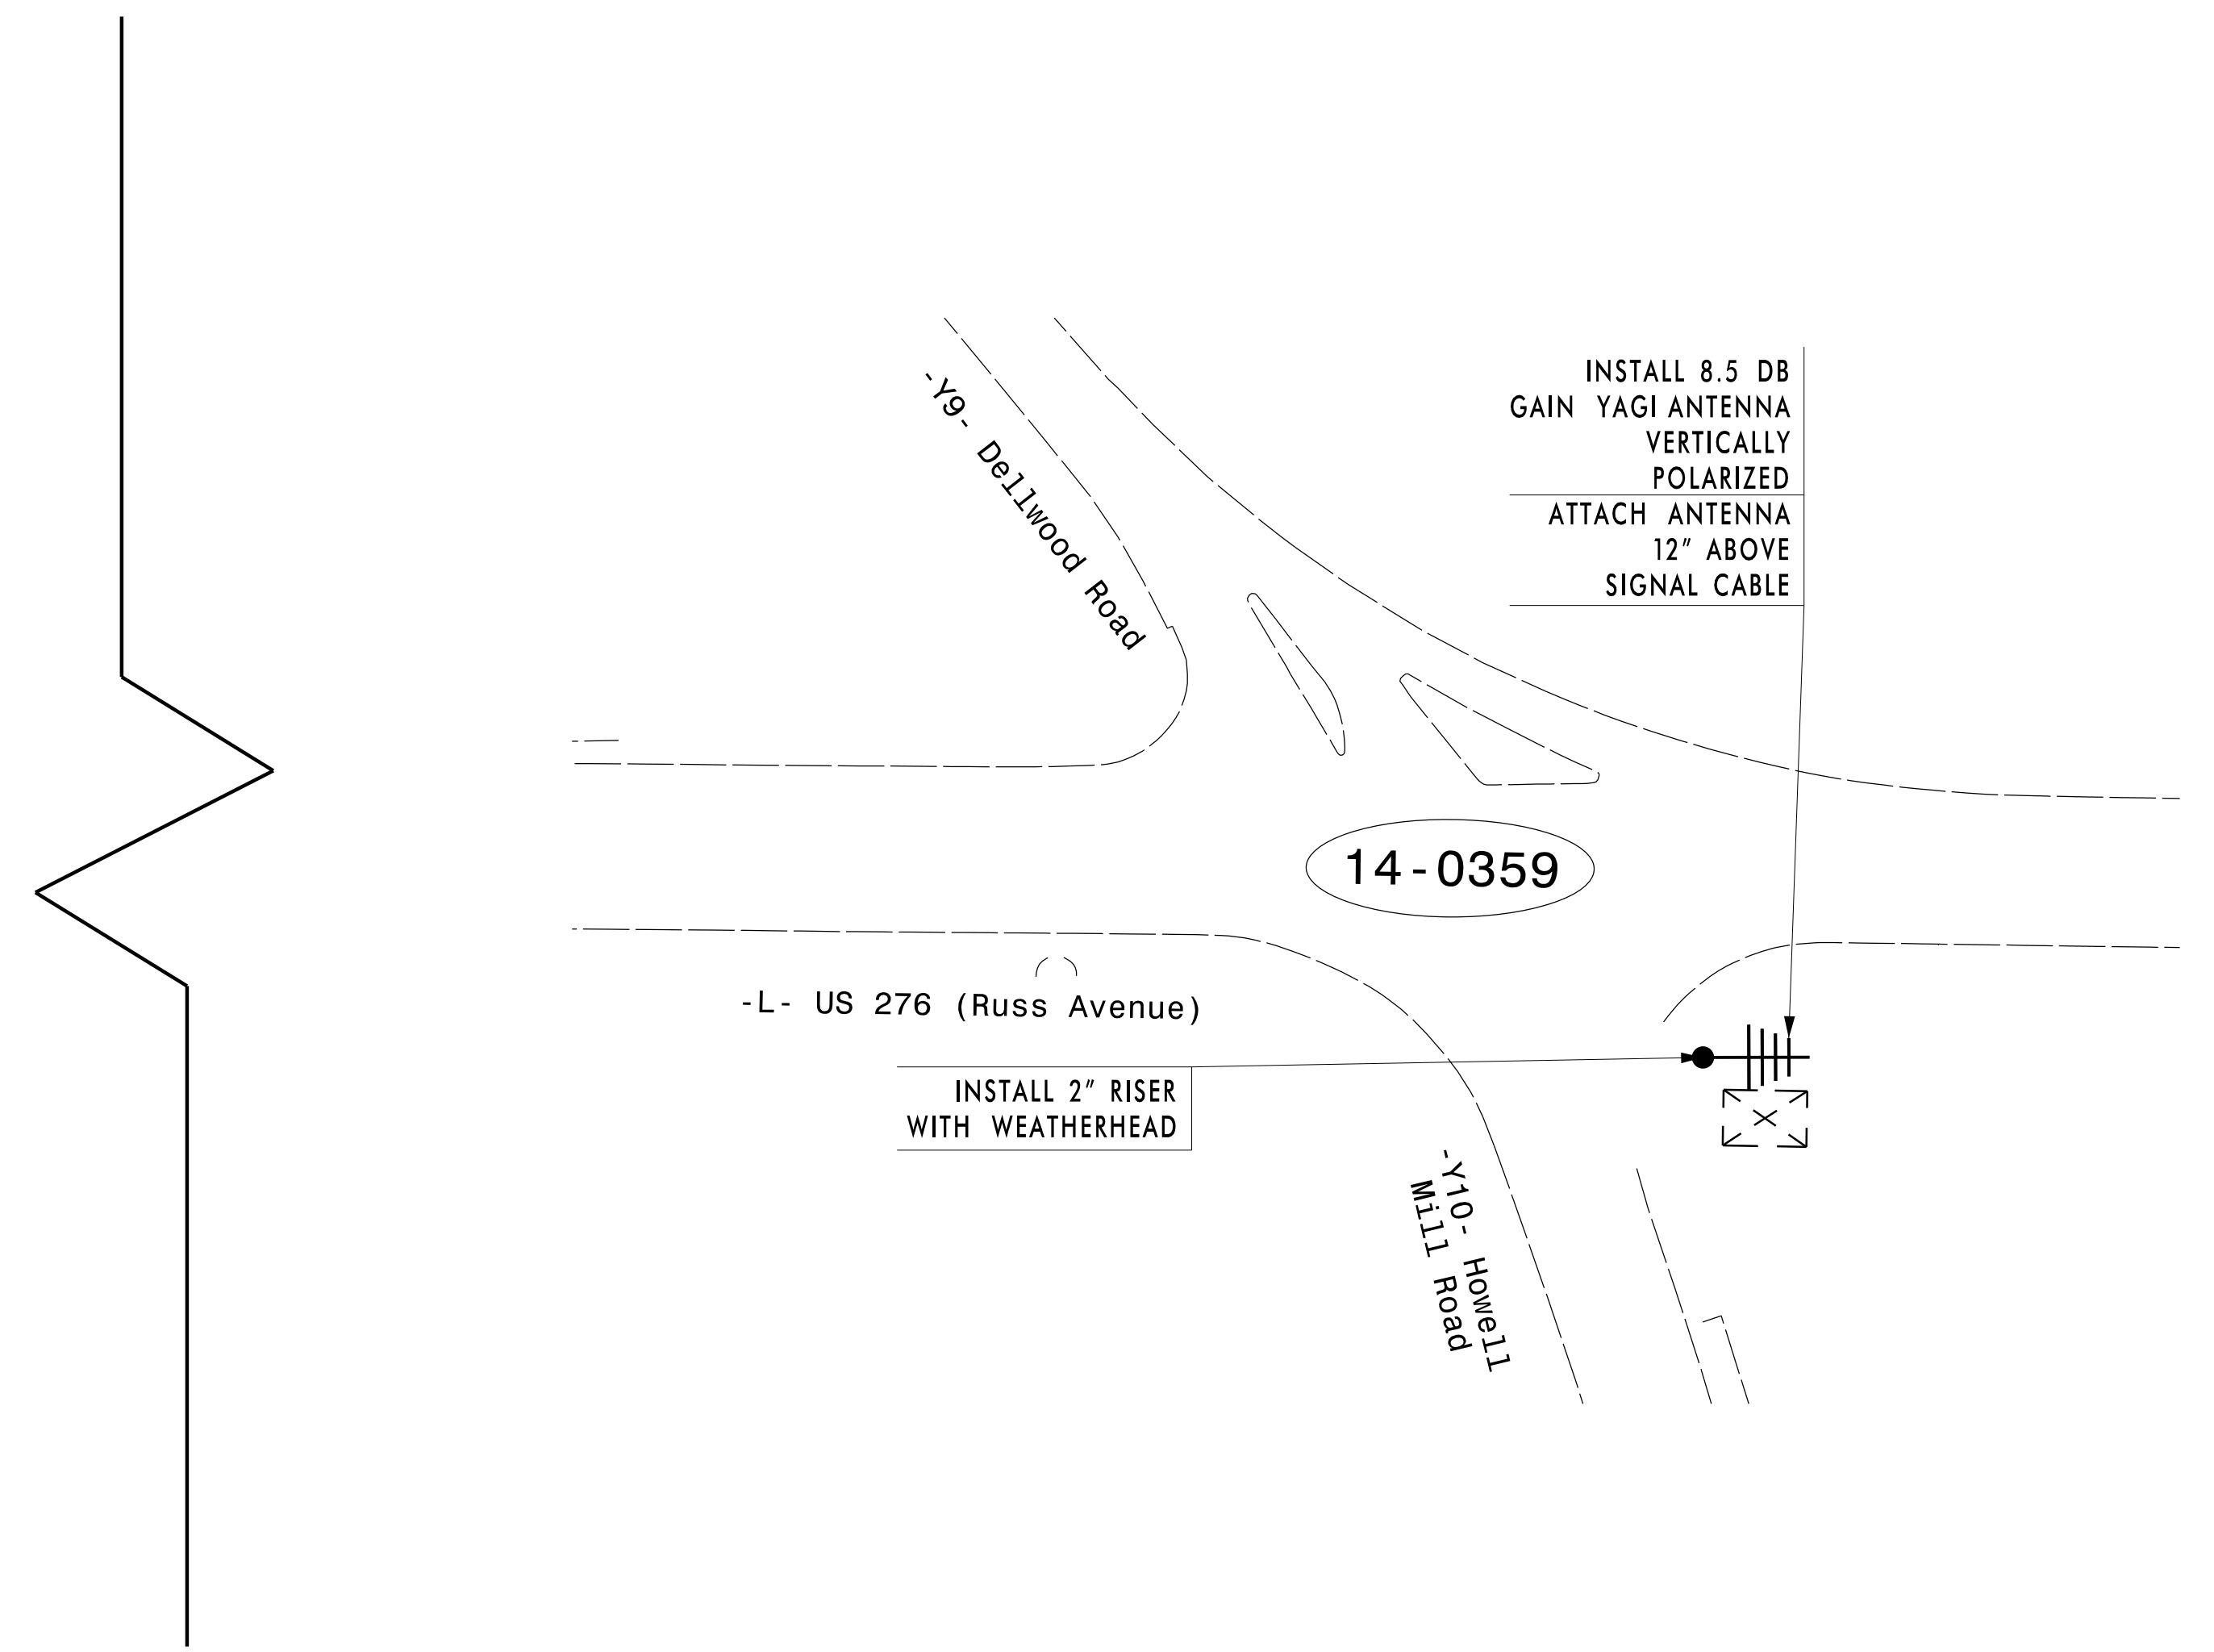
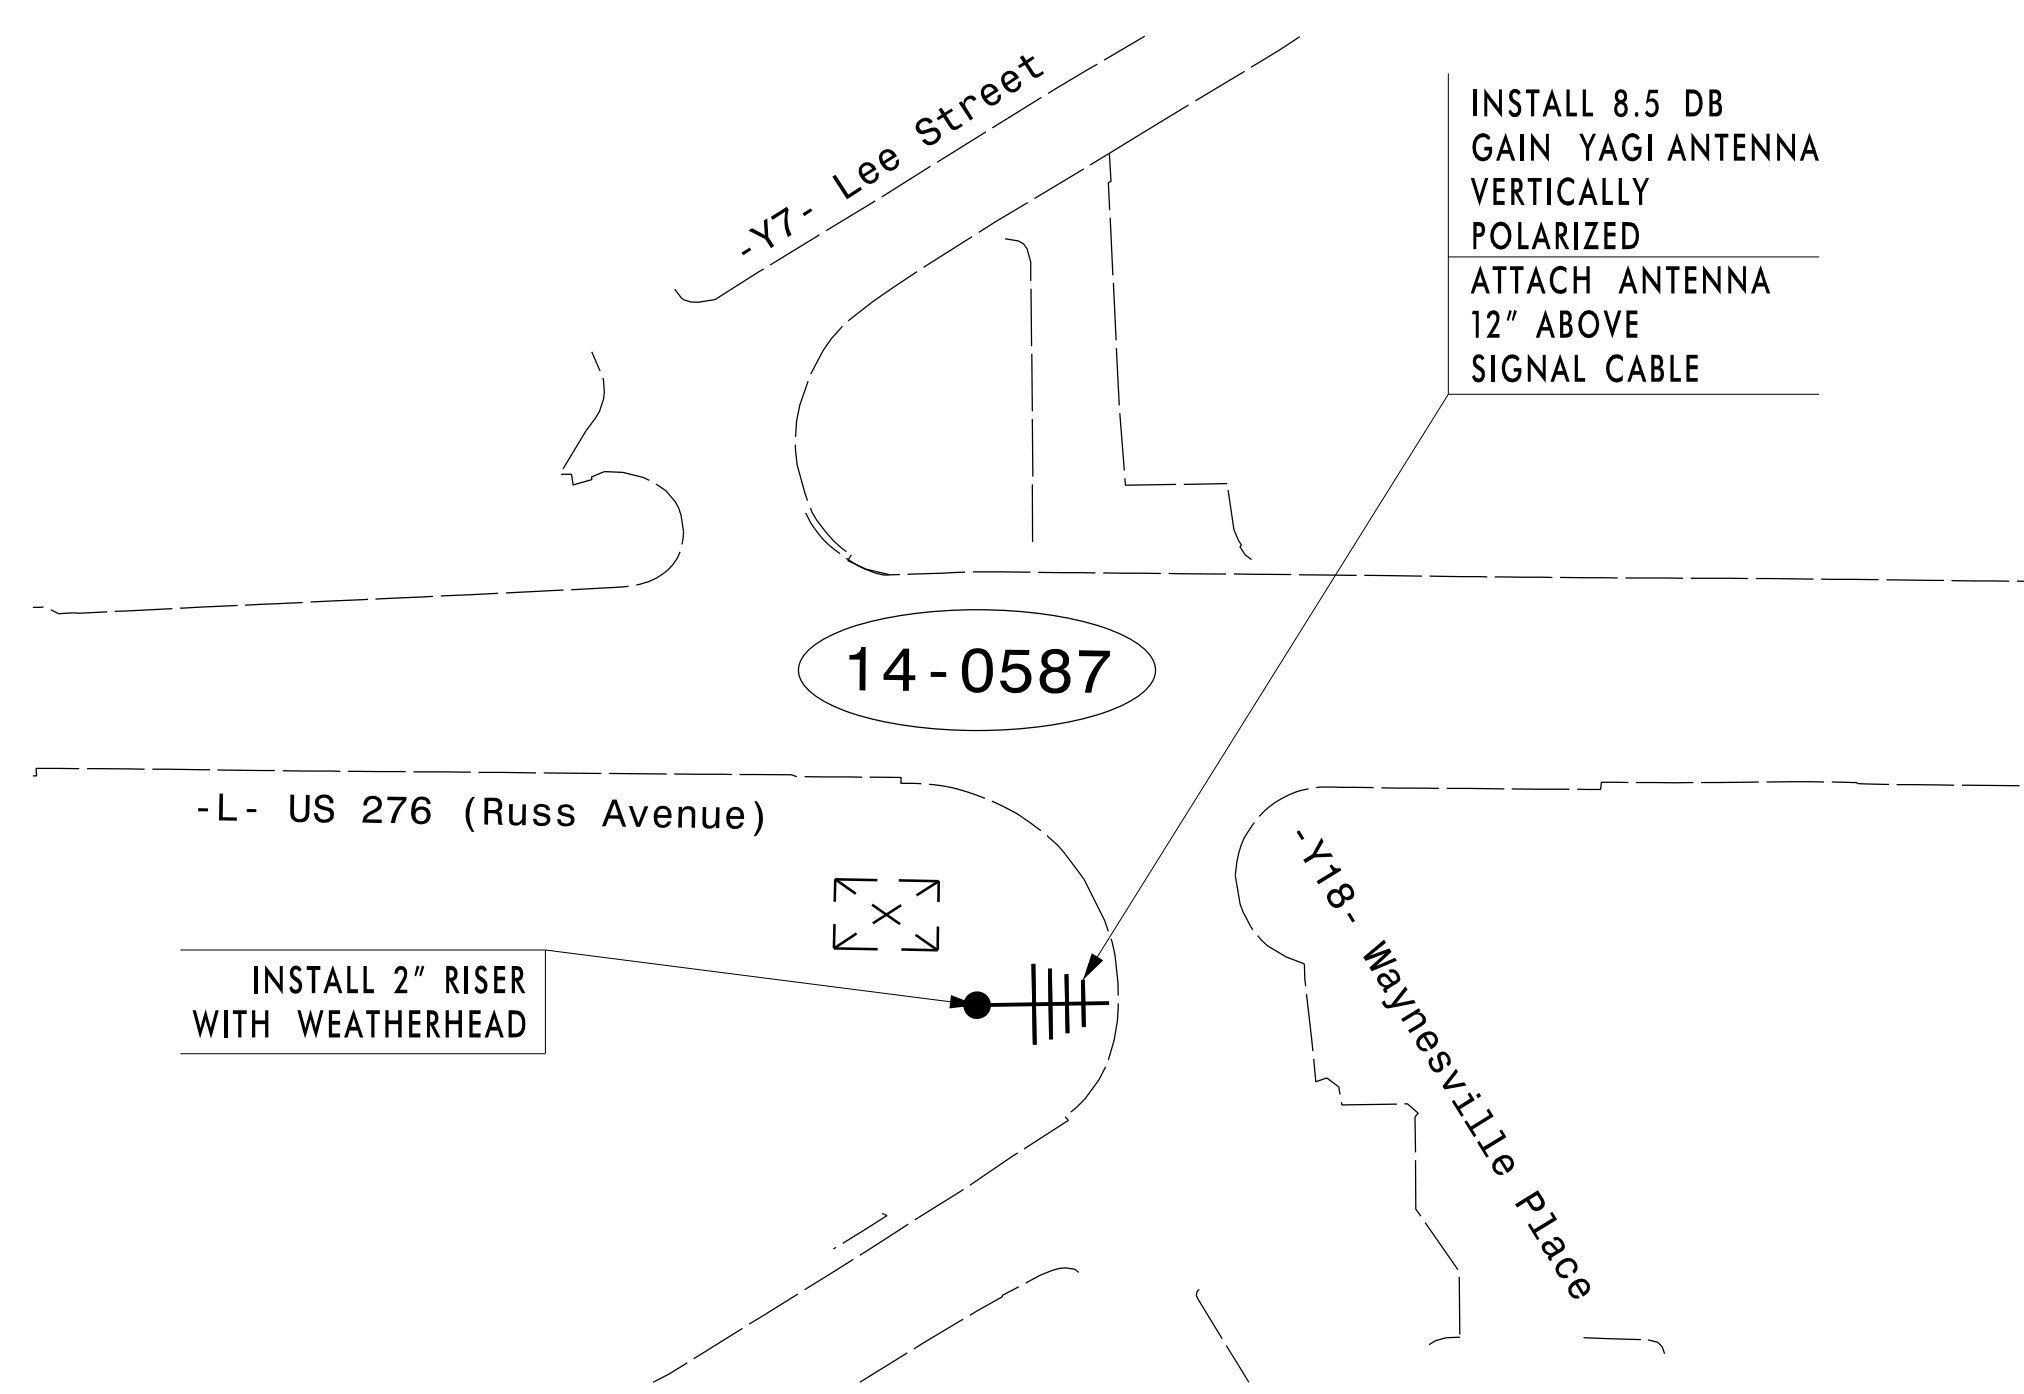


LEGEND

	YAGI ANTENNA (SINGLE)
	EXISTING CONTROLLER AND CABINET
	EXISTING GATEWAY RADIO LOCATION
	SIGNAL INVENTORY NUMBER
	EXISTING METAL POLE W/MAST ARM
	EXISTING WOOD POLE



WIRELESS NOTES:

- 1) INSTALL COAXIAL CABLE
 - A. ON WOOD POLE, REQUIRING A NEW RIGID GALVANIZED STEEL RISER INSTALL A 2" RISER WITH WEATHERHEAD AND ROUTE THE COAXIAL CABLE TO THE ANTENNA.
- 2) IF AN EXISTING 2" SPARE RIGID GALVANIZED STEEL RISER IS AVAILABLE, INSTALL THE COAXIAL CABLE IN THE SPARE RISER WITHIN 2" WEATHERHEAD.
- 3) INSTALL WIRELESS ANTENNA ON POLE WITH RF WARNING SIGN. (NOTE: RF WARNING SIGN NOT REQUIRED WHEN ANTENNA IS INSTALLED ON AN NCDOT-OWNED POLE.)
- 4) INSTALL WIRELESS RADIO WITH EXTERIOR DISCONNECT SWITCH LOCATED ON CABINET. (NOTE: RF ANTENNA DISCONNECT SWITCH AND DECAL ARE NOT REQUIRED WHEN THE ANTENNA IS INSTALLED ON AN NCDOT-OWNED POLE.)
- 5) MAINTAIN PROPER CLEARANCE FROM ALL UTILITIES PER THE MANUAL ELECTRICAL SAFETY CODE.
- 6) REFERENCE "WIRELESS RADIO ANTENNA TYPICAL DETAILS."

14-0587: 14-0587-1, 14-0587-2, 14-0587-3, 14-0587-99, 14-0587-100


Infrastructure Consulting Services, Inc.



RKA
RAMEY KEMP ASSOCIATES

8219 University Executive Park Drive Suite 200 Charlotte, North Carolina 28262
Phone: 704-549-4280 | www.rkainc.com | NC License No. F-1489

TMP Phase I

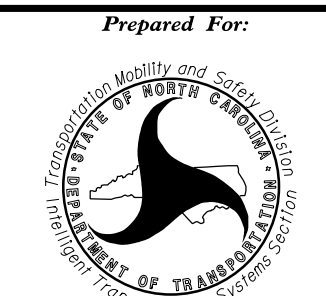

750 N. Greenfield Pkwy., Garner, NC 27529

Prepared For:


D14-12_Waynesville Wireless Communication Plans

Division 14 Haywood County Waynesville


PLAN DATE: April 2023	REVIEWED BY: WJ Hamilton
PREPARED BY: TS Popelka	RKA PROJ. NO.: 16085 (041)

REVISIONS	INIT.	DATE

DOCUMENT NOT CONSIDERED FINAL UNLESS ALL SIGNATURES COMPLETED

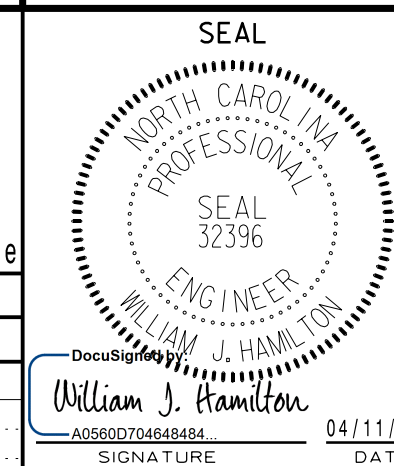

SEAL
NORTH CAROLINA
PROFESSIONAL ENGINEER
WILLIAM J. HAMILTON
04/11/2023



SCALE
0 50
1" = 50'