


DATE: 1/19/2023
TIME: 9:26:07 AM
USER: jmorris@wme.com
DRAWING: USRAL3\Legacy\Projects\60436195-B-465A-000\Wor\K910\CAD\YO_MCDOT_TIP\Structures\04_Drawing\400_23_512_B465A_SIMU_LFP.dgn

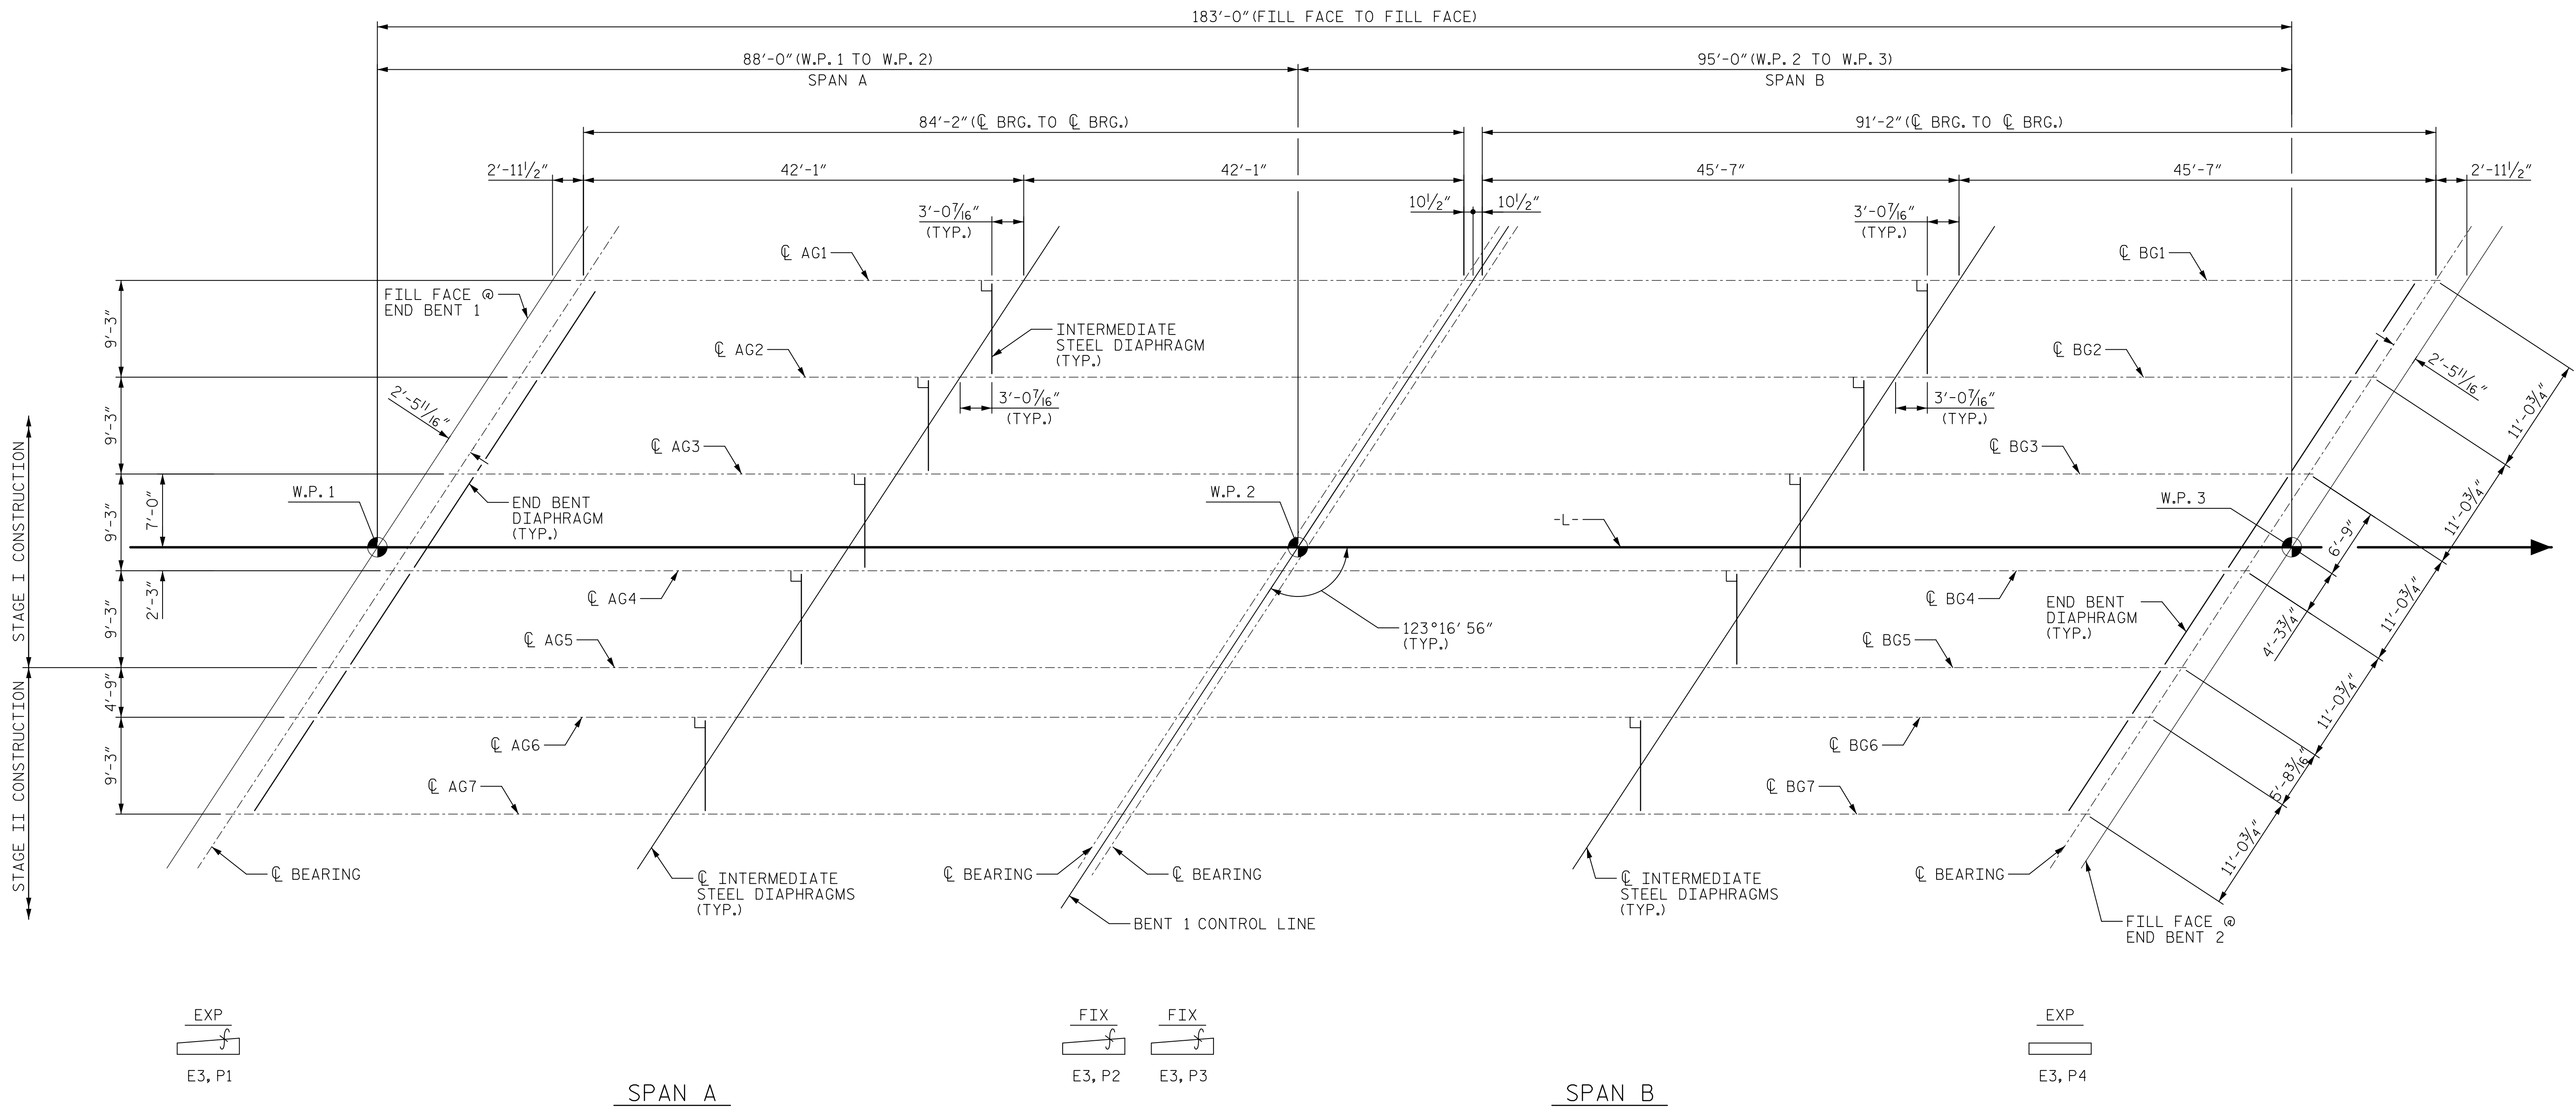

FRAMING PLAN

PROJECT NO. B-4654
WAKE COUNTY
 STATION: 22+71.80 -L-

DRAWN BY : K. MUENCH DATE : 05/2022
 CHECKED BY : J.C. MORRISON DATE : 05/2022
 DESIGNED BY : D. RITACCO DATE : 05/2022
 DESIGN CHECKED BY : J.C. MORRISON DATE : 05/2022

DOCUMENT NOT CONSIDERED
 FINAL UNLESS ALL
 SIGNATURES COMPLETED

AECOM
AECOM TECHNICAL SERVICES OF NC, INC.
 5438 WADE PARK BOULEVARD, SUITE 200
 RALEIGH, NC 27607
 (919) 854-6200 www.aecom.com
 AECOM License No. F-0342

PROFESSIONAL SEAL
 JOHN C. MORRISON
 ENGINEER
 1/19/2023

STATE OF NORTH CAROLINA DEPARTMENT OF TRANSPORTATION RALEIGH					
SUPERSTRUCTURE					
FRAMING PLAN					
REVISIONS					
NO.	BY:	DATE:	NO.	BY:	DATE:
1			3		
2			4		
SHEET NO.					S-12
TOTAL SHEETS					49