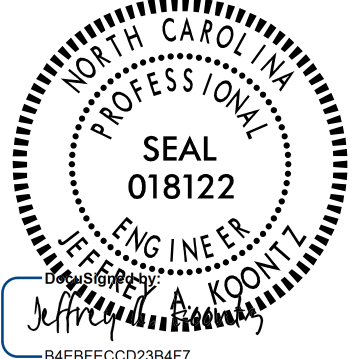


PROJECT REFERENCE NO. B-4654	SHEET NO. SIGN-1
APPROVED: _____ DATE: 1/11/2024	
SEAL 	
DOCUMENT NOT CONSIDERED FINAL UNLESS ALL SIGNATURES COMPLETED	

**STATE OF NORTH CAROLINA
DEPARTMENT OF TRANSPORTATION**

**SIGNING PLAN
WAKE COUNTY**

LOCATION: REPLACE BRIDGE 69 OVER US 70 ON NC 50 (BENSON ROAD)

T.I.P.: B-4654

CONTRACT: C204410

ROADWAY STANDARD DRAWING

THE FOLLOWING ROADWAY STANDARDS AS APPEAR IN "ROADWAY STANDARD DRAWINGS" - PROJECT SERVICES UNIT - N.C. DEPARTMENT OF TRANSPORTATION - RALEIGH, N.C., DATED JANUARY 2024 ARE APPLICABLE TO THIS PROJECT AND BY REFERENCE HEREBY ARE CONSIDERED A PART OF THESE PLANS:

901.20	TYPE 'B' SIGNS
901.50	ARROWS AND SHIELDS
901.80	SIGN MOUNTING DETAILS - FOR TYPE A AND TYPE B SIGNS
902.10	FOUNDATIONS FOR GOUND MOUNTED SIGNS
903.10	GROUND MOUNTED SIGN SUPPORTS
904.10	ORIENTATION OF GROUND MOUNTED SIGNS
904.50	MOUNTING OF TYPE 'D', 'E' AND 'F' SIGNS ON 'U' CHANNEL POSTS

GENERAL NOTES

- . SIGNS FURNISHED BY STATE
- . ALL TYPE 'D' SIGNS SHALL BE MOUNTED ON TWO U-CHANNEL POSTS UNLESS OTHERWISE INDICATED ON THE PLANS.
- . IF REMOVAL OR RELOCATION OF SIGNS ON PRIVATE STREET (NON-STATE MAINTAINED) IS REQUIRED DUE TO CONSTRUCTION, THE CONTRACTOR SHALL INFORM THE ENGINEER. THE WORK WILL BE COMPLETED BY OTHERS.
- . WHEN NOT STATIONED OR DIMENSIONED ON PLANS, ALL 'E' AND 'F' SIGNS SHALL BE FIELD LOCATED BY THE ENGINEER
- . ALL EXISTING SIGNS ON "U" CHANNEL POST WITHIN THE PROJECT LIMITS SHALL BE REMOVED AND DISPOSED OF UNLESS OTHERWISE NOTED ON PLANS.
- . THE BACKGROUND FOR TYPE E & F SIGNS SHALL BE TYPE C REFLECTIVE SHEETING.
- . IF GROUNDWATER IS ENCOUNTERED AT A DEPTH SHALLOWER THAN 7 FEET, THE SIGN FOUNDATION MUST BE REDESIGNED BASED UPON THE ACTUAL FIELD CONDITIONS. THE FOUNDATION DESIGN DOES NOT APPLY TO VERY SOFT OF LOOSE SOIL, MUCK, WEATHERED ROCK, OR HARD ROCK.

SUMMARY OF QUANTITIES

ITEM NO.		ITEM DESCRIPTION	QUANTITY	UNIT
DESC. NO.	SECT. NO.			
4054000000	902	PLAIN CONCRETE SIGN FOUNDATION	1	CY
4060000000	903	SUPPORTS, BREAKAWAY STEEL BEAM	449	LB
4072000000	903	SUPPORTS, 3 LB STEEL U-CHANNEL	860	LF
4096000000	904	SIGN ERECTION, TYPE D	6	EA
4102000000	904	SIGN ERECTION, TYPE E	25	EA
4108000000	904	SIGN ERECTION, TYPE F	10	EA
4110000000	904	SIGN ERECTION, TYPE B (GROUND MOUNTED)	3	EA
4116100000	904	SIGN ERECTION, RELOCATE TYPE D (GROUND MOUNTED)	1	EA
4155000000	907	DISPOSAL OF SIGN SYSTEM, U-CHANNEL	51	EA

PROJECT NOTES

1. DISPOSAL OF SIGN SYSTEM, U-CHANNEL
 2. RELOCATE SIGN, TYPE D
- ★ SIGNALIZED INTERSECTION

INDEX

SIGN-1	TITLE SHEET, NOTES, QUANTITY SUMMARY, STANDARD DRAWINGS
SIGN-2	SUPPORT CHART
SIGN-2A	TYPE "B" GROUND MOUNTED SIGNS
SIGN-3 THRU SIGN-4	TYPE "D" SHEETS
SIGN-5	TYPE "E" AND "F" SHEETS
SIGN-6 THRU SIGN-8	EXISTING SIGNS SHEETS
SIGN-9 THRU SIGN-11	PROPOSED SIGNS SHEETS


PLAN PREPARED BY: AECOM

JEFFREY KOONTZ, PE PROJECT ENGINEER

NICK BLUME, EI PROJECT DESIGNER



NC FIRM LICENSE No: F-3042
5438 Wade Park Blvd., Ste 200
Raleigh, NC 27607
919.854.6200

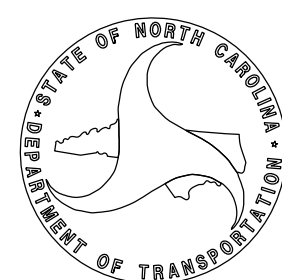


PROJECT REFERENCE NO. B-4654	SHEET NO. SIGN-02
APPROVED: _____	
DATE: 1/11/2024	
SEAL	
DOCUMENT NOT CONSIDERED FINAL UNLESS ALL SIGNATURES COMPLETED	



Version: 3.2 Posted: 7/5/2023

NUMBER	TYPE	SIGN			ROADWAY STATION	NUMBER OF SUPPORTS	BEAM SECTION	SUPPORT TYPE BA or S	OMNI COUPLER	ATTACHMENT METHOD	MOUNTING METHOD	HORIZONTAL CLEARANCE* (ft.)	SUPPORT SPACING	LENGTH (ft)			LEFT SUPPORT (ft)			CENTER SUPPORT (ft)			RIGHT SUPPORT (ft)			SUPPORT WEIGHTS		FOOTINGS				FIELD VERIFIED SEE NOTE 2 (mm/dd/yy)
		w	x	h										SNS HT "H"	MTG HT "C"	EMBED-MENT	S	L	LENGTH	S	L	LENGTH	S	L	LENGTH	B/A (lbs.)	SIMPLE (lbs.)	DIAMETER (ft.)	DEPTH (ft.)	REINFORCED (c.y.)	PLAIN (c.y.)	
201	A	72	x	60	Y1 22+75 RT	2	S3x5.7	BA	N/A	N/A	N/A	Δ	3.52	5.00	7.00	2.5	0.75	12.75	15.25	0.00	0.00	0.00	0.75	12.75	15.25	209.85	0	1.0	3	0.00	0.17	_____
202 & 203	A B	72 72	x x	60 24	Y1 23+58 LT	2	S3x5.7	BA	N/A	N/A N/A	N/A II	Δ	3.52	7.00	7.00	3.0	0.88	14.88	17.88	0.00	0.00	0.00	0.64	14.64	17.64	238.46	0	1.0	3.5	0.00	0.20	_____

TOTAL	448.31	TOTAL	0.00	TOTAL	0.00	TOTAL	0.38
USE:	449.00		0.00		0.00		1.00

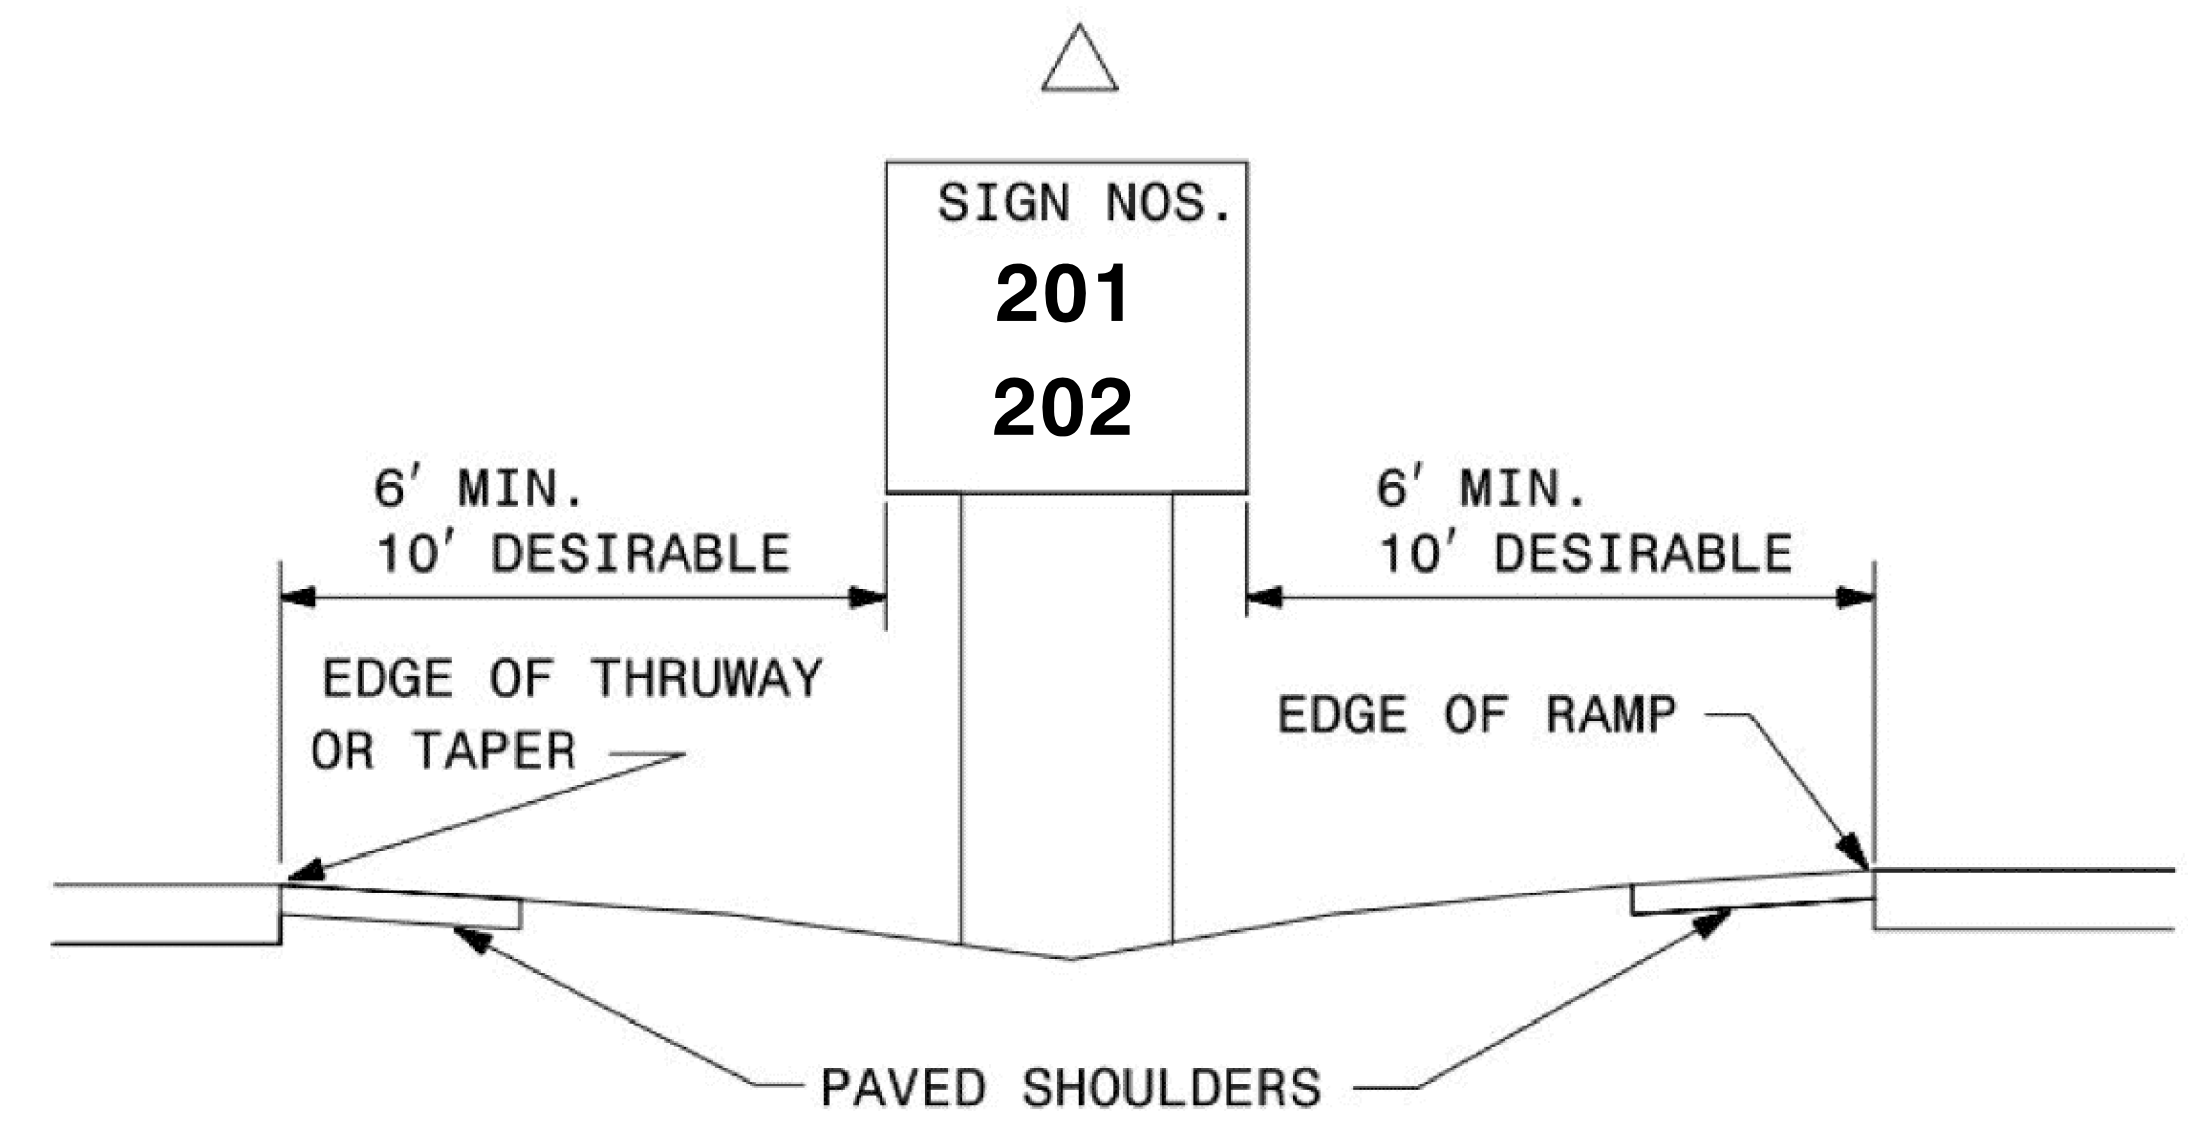

SUPPORT CHART

I:\2024\Legacy\Projects\60436195-B-4654\900-Work\910-CAD\70-NC001_TIP\Traffic\TrafficControl\TCP\current_files\B4654-sign-02-supports.dgn
 01/11/2024
 J. P. KOUNTZ

PROJECT REFERENCE NO.	SHEET NO.
B-4654	SIGN-02A
APPROVED: _____	DATE: 1/11/2024
SEAL	

DOCUMENT NOT CONSIDERED FINAL UNLESS ALL SIGNATURES COMPLETED

AECOM

NC FIRM LICENSE No: F-3042
5438 Wade Park Blvd., Ste 200
Raleigh, NC 27607
919.854.6200

SIGN NUMBER: 201, 202 TYPE: B QUANTITY: 1 SIGN WIDTH: 6'-0" HEIGHT: 5'-0" TOTAL AREA: 30.0 Sq.Ft. BORDER TYPE: FLUSH RECESS: 0" WIDTH: 1.5" RADII: 6" NO. Z BARS: 2 LENGTH: 64.0	BACKG COLOR: Green COPY COLOR: White SYMBOLOGY TABLE: <table border="1"> <thead> <tr> <th>SYMBOL</th> <th>X</th> <th>Y</th> <th>WID</th> <th>HT</th> </tr> </thead> <tbody> <tr> <td>Exit Arrow (Type A) 2012</td> <td>24.5</td> <td>6</td> <td>18.3</td> <td>29.3</td> </tr> <tr><td> </td><td> </td><td> </td><td> </td><td> </td></tr> <tr><td> </td><td> </td><td> </td><td> </td><td> </td></tr> <tr><td> </td><td> </td><td> </td><td> </td><td> </td></tr> <tr><td> </td><td> </td><td> </td><td> </td><td> </td></tr> </tbody> </table> MAT'L: 0.125" (3.2 mm) ALUMINUM	SYMBOL	X	Y	WID	HT	Exit Arrow (Type A) 2012	24.5	6	18.3	29.3																					DESIGN BY: NICK BLOME, EI PROJECT ID: B-4654 CHECKED BY: JEFFREY KOONTZ, PE LOCATION: WAKE COUNTY Sep 12, 2023 DIV: 5
SYMBOL	X	Y	WID	HT																												
Exit Arrow (Type A) 2012	24.5	6	18.3	29.3																												

BORDER R=6" TH=1.5"

Spacing Factor is 1 unless specified otherwise

USE NOTES: 1, 2

- Legend and border (except those that are colored black) shall be direct applied Grade C sheeting.
- Background shall be Grade C reflective sheeting.
- Shields; A, B, and C type arrows shall be on 0.032" (0.8mm) aluminum with Grade C reflective sheeting and demountable.

LETTER POSITIONS

Letter spacings are to start of next letter

Series/Size Text Length	E	X	I	T
E 2000	13.9	12.7	15.7	6.7
44.1				9

FILENAME: B4654_sign_TYPE_D

NORTH CAROLINA D.O.T. SIGN DETAIL

SIGN DETAIL 1:30

SIGN NUMBER	203
WIDTH x HIGHT.	6'-0" x 2'-0"
BORDER WIDTH	2"
CORNER RADIUS	3.25"
MOUNTING	Ground
BACKGROUND	TYPE: Reflective COLOR: Yellow
LEGEND/BORDER	TYPE: Reflective COLOR: Black/Black

Panel Styl: tab2.bsi
Dimensions are inches, tenths
Letter locations are panel edge to lower left corner


LETTER POSITIONS (X)

Length	Series/Size
4.1	E 2000
63.9	12

TYPE 'B' SIGNS

L:\2024\Legacy\Projects\60436195-B-4654\900-Work\910-CAD\70-NCDDT_TIP\TrafficControl\TCP\current_files\B4654_sign-02A.dsign.dgn
L:\2024\Legacy\Projects\60436195-B-4654\900-Work\910-CAD\70-NCDDT_TIP\TrafficControl\TCP\current_files\B4654_sign-02A.dsign.dgn
L:\2024\Legacy\Projects\60436195-B-4654\900-Work\910-CAD\70-NCDDT_TIP\TrafficControl\TCP\current_files\B4654_sign-02A.dsign.dgn

APPROVED: _____
DATE: 1/11/2024

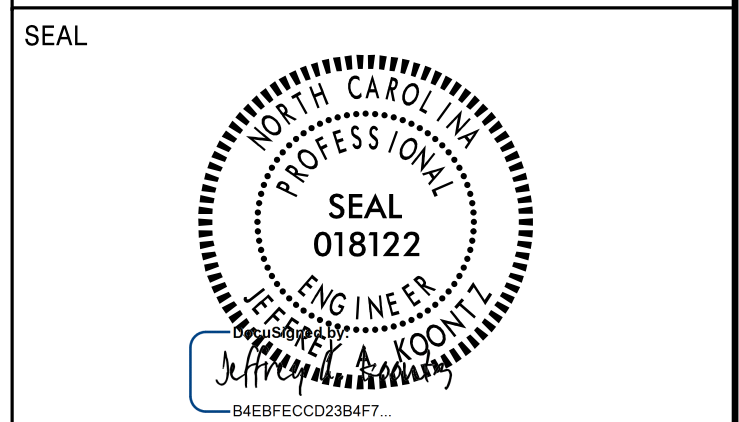

**DOCUMENT NOT CONSIDERED FINAL
UNLESS ALL SIGNATURES COMPLETED**



SIGN NUMBER: 301 TYPE: D QUANTITY: 1 SIGN WIDTH: 4'-6" HEIGHT: 2'-6" TOTAL AREA: 11.3 Sq.Ft. BORDER TYPE: FLUSH RECESS: 0" WIDTH: 0.75" RADI: 2.25" NO. Z BARS: LENGTH:	BACKG COLOR: Green COPY COLOR: White SYMBOL X Y WID HT AR_Type A 37.5 10 8.1 12.7	DESIGN BY: NICK BLOME, EI PROJECT ID: B-4654	CHECKED BY: JEFFREY KOONTZ, PE LOCATION: WAKE COUNTY	Sep 11, 2023 DIV: 5
--	--	---	---	------------------------

MAT'L: 0.125" (3.2 mm) ALUMINUM

USE NOTES: 1, 2
1. Legend and border(except those that are colored black) shall be direct applied Grade C sheeting.
2. Background shall be Grade A, B, or C reflective sheeting.
3. Shields; A, B, and C type arrows shall be on 0.032" (0.8mm) aluminum with Grade C reflective sheeting and demountable.

LETTER POSITIONS

Letter spacings are to start of next letter										Series/Size	Text Length	
G	a	r	n	e	r						D 2000	23.6
22	27	31.6	34.6	39	43.4							6/4.5
B	e	n	s	o	n						D 2000	25
7	11.8	16.1	20.5	23.8	28.4							6/4.5

FILENAME: B4654_sign_TYPE_D NORTH CAROLINA D.O.T. SIGN DETAIL

SIGN NUMBER: 302
SIGN DETAIL
1:15

SIGN NUMBER	D1-2 (2 Dest - Arrows LR)
WIDTH x HGT.	4' -6" x 2' -6"
BORDER WIDTH	0.75"
CORNER RADIUS	2.25"
MOUNTING	Ground
BACKGROUND	TYPE: Reflective
	COLOR: Green
LEGEND/BORDER	TYPE: Reflective
	COLOR: White/White

SYMBOL	ROT	X	Y	WID	HT
AR_Type D	90	7	19.3	6	9
AR_Type D	270	38	4.7	6	9

Panel Stylguide.con.destination.ssi
Dimensions are inches, tenths Letter locations are panel edge to Lower left corner

LETTER POSITIONS (X)

Letter positions										LENGTH	SERIES/SIZE	
G	a	r	n	e	r						D 2000	23.6
22	27	31.6	34.6	39	43.4							6/4.5
B	e	n	s	o	n						D 2000	25
7	11.8	16.1	20.5	23.8	28.4							6/4.5

SIGN NUMBER: 303
SIGN DETAIL
1:15

SIGN NUMBER	D1-2 (2 Dest - Arrows LR)
WIDTH x HGT.	4' -6" x 2' -6"
BORDER WIDTH	0.75"
CORNER RADIUS	2.25"
MOUNTING	Ground
BACKGROUND	TYPE: Reflective
	COLOR: Green
LEGEND/BORDER	TYPE: Reflective
	COLOR: White/White

SYMBOL	ROT	X	Y	WID	HT
AR_Type D	90	7	19.3	6	9
AR_Type D	270	38	4.7	6	9

Panel Stylguide.con.destination.ssi
Dimensions are inches, tenths Letter locations are panel edge to Lower left corner

LETTER POSITIONS (X)

Letter positions										LENGTH	SERIES/SIZE	
G	a	r	n	e	r						D 2000	23.6
22	27	31.6	34.6	39	43.4							6/4.5
B	e	n	s	o	n						D 2000	25
7	11.8	16.1	20.5	23.8	28.4							6/4.5

SIGN NUMBER: 304
SIGN DETAIL
1:15

SIGN NUMBER	D1-2 (2 Dest - Arrows LR)
WIDTH x HGT.	4' -6" x 2' -6"
BORDER WIDTH	0.75"
CORNER RADIUS	2.25"
MOUNTING	Ground
BACKGROUND	TYPE: Reflective
	COLOR: Green
LEGEND/BORDER	TYPE: Reflective
	COLOR: White/White

SYMBOL	ROT	X	Y	WID	HT
AR_Type B	0	6.6	18.9	6	6.8
AR_Type D	270	38.4	4.7	6	9

Panel Stylguide.con.destination.ssi
Dimensions are inches, tenths Letter locations are panel edge to Lower left corner


LETTER POSITIONS (X)

Letter positions										LENGTH	SERIES/SIZE	
C	l	a	y	t	o	n					D 2000	28.9
18.6	23.9	25.7	29.8	34.5	37.3	41.9						6/4.5
R	a	i	e	i	g	h					D 2000	25.8
6.6	11.3	15.8	17.8	22.1	24.1	28.9						6/4.5

TYPE "D" SIGNS

I/1/2024 L:\Legacy\Projects\60436195-B-4654\900_Work\910_CAD\70_NCDOT_TIP\TrafficControl\TCP\current_files\B4654_sign-03_inventory.dgn

APPROVED: _____
 DATE: 1/11/2024

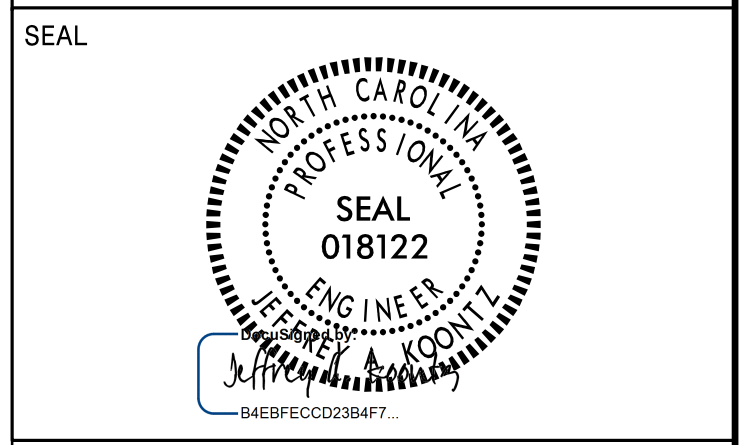

**DOCUMENT NOT CONSIDERED FINAL
 UNLESS ALL SIGNATURES COMPLETED**



SIGN NUMBER : 305
 SIGN DETAIL
 1:15

SIGN NUMBER	D1-2 (2 Dest - Arrows RR)
WIDTH x HGT.	4' -6" x 2' -6"
BORDER WIDTH	0.75"
CORNER RADIUS	2.25"
MOUNTING	Ground
BACKGROUND	TYPE: Reflective COLOR: Green
LEGEND/BORDER	TYPE: Reflective COLOR: White/White

SYMBOL	ROT	X	Y	WID	HT
AR_Type D	360	37.9	17.8	6	9
AR_Type D	270	39	4.7	6	9

Panel Stylguide.con.destination.ssi
 Dimensions are inches, tenths Letter locations are panel edge to Lower Left corner

LETTER POSITIONS (X)										LENGTH	SERIES/SIZE		
R	a	i	e	i	g	h						D 2000	
6.1	10.8	15.3	17.2	21.6	23.5	28.3						25.8	6/4.5
C	l	a	y	t	o	n						D 2000	
6.1	11.4	13.2	17.3	22	24.8	29.4						26.9	6/4.5
SIGN NUMBER: 305													

SIGN NUMBER : 306
 SIGN DETAIL
 1:15

SIGN NUMBER	D1-1 (1 Dest - Arrow L or R)
WIDTH x HGT.	4' -5" x 1' -6"
BORDER WIDTH	0.75"
CORNER RADIUS	1.5"
MOUNTING	Ground
BACKGROUND	TYPE: Reflective COLOR: Green
LEGEND/BORDER	TYPE: Reflective COLOR: White/White

SYMBOL	ROT	X	Y	WID	HT
AR_Type D	90	6.1	6	6	9


Panel Stylguide.con.destination.ssi
 Dimensions are inches, tenths Letter locations are panel edge to Lower Left corner

LETTER POSITIONS (X)										LENGTH	SERIES/SIZE		
R	a	i	e	i	g	h						D 2000	
21.1	25.8	30.3	32.3	36.6	38.6	43.4						25.8	6/4.5
SIGN NUMBER: 306													

L:\2024\Legacy\Projects\60436195-B-4654\900-Work\910-CAD\70-NC001_TIP\Traffic\TrafficControl\TCP\current_files\B4654_sign-04_inventory.dgn
 01/11/2024 10:58:11 AM
 J. HARRIS


TYPE "D" SIGNS

APPROVED: DATE: 1/11/2024

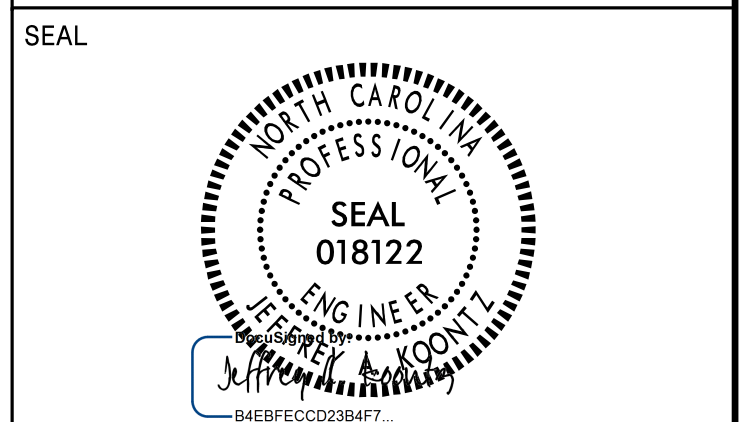


DOCUMENT NOT CONSIDERED FINAL UNLESS ALL SIGNATURES COMPLETED

501 QUANTITY REQ'D 1

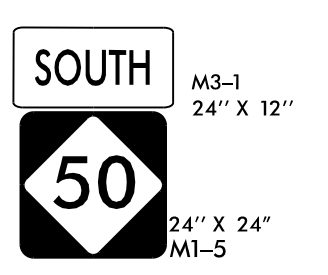


ONE "U" POST PER SIGN

505 QUANTITY REQ'D 1

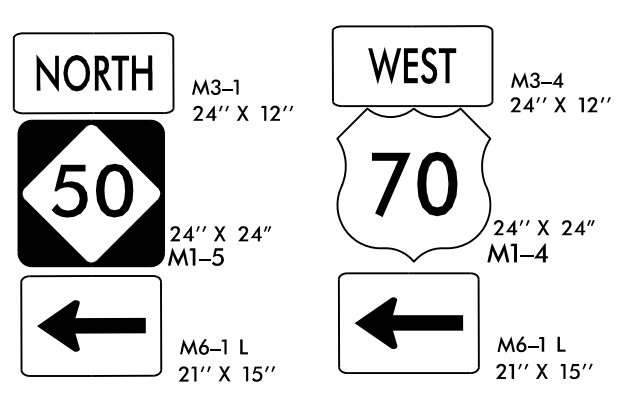


TWO "U" POSTS PER SIGN

510 QUANTITY REQ'D 1

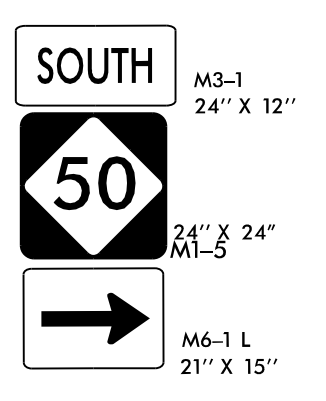


ONE "U" POST PER SIGN

401 QUANTITY REQ'D 3

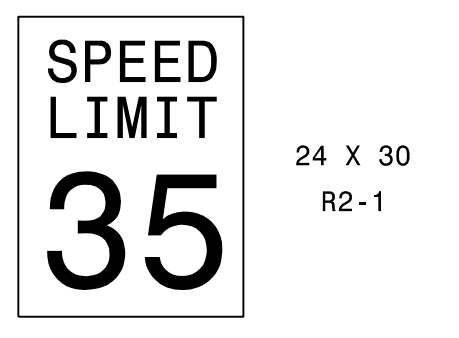


ONE "U" POST PER SIGN

406 QUANTITY REQ'D 2

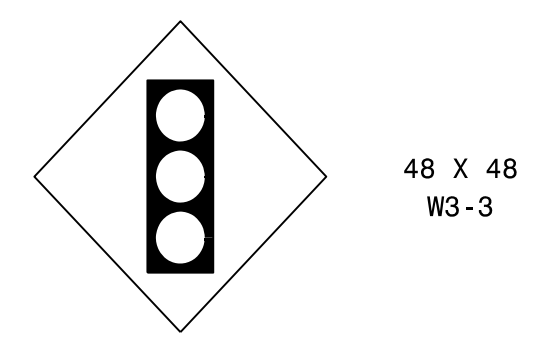


TWO "U" POSTS PER SIGN

502 QUANTITY REQ'D 1

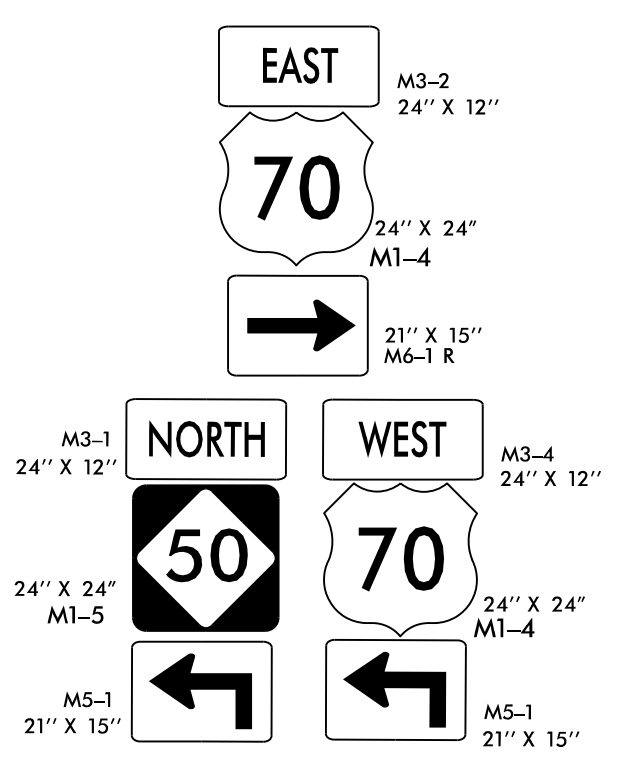


TWO "U" POSTS PER SIGN

506 QUANTITY REQ'D 1

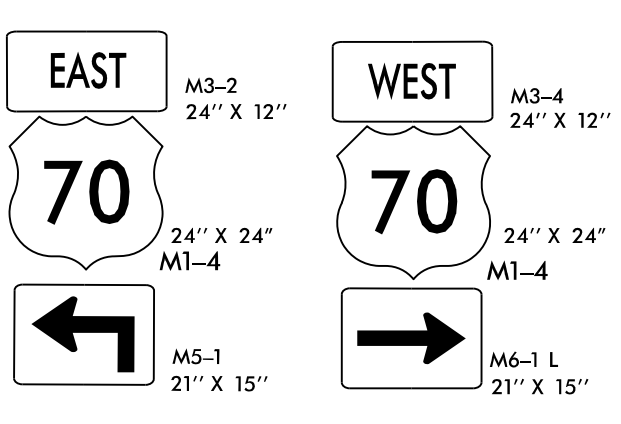


TWO "U" POSTS PER SIGN

402 QUANTITY REQ'D 1

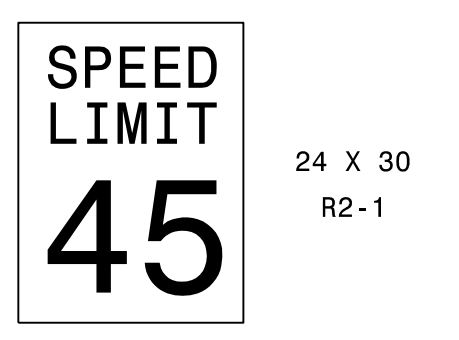


ONE "U" POST PER SIGN

407 QUANTITY REQ'D 1

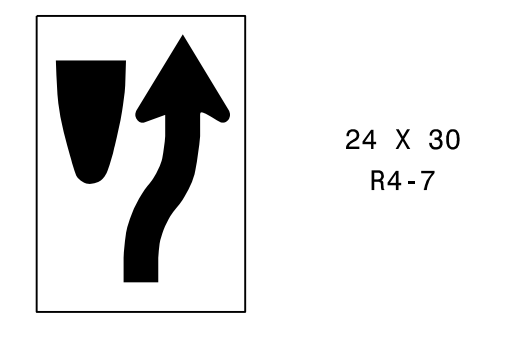


ONE "U" POST PER SIGN

410 QUANTITY REQ'D 3

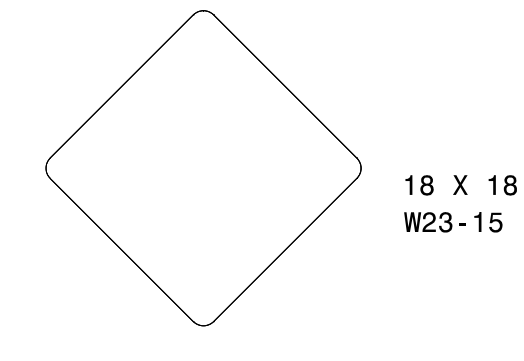


ONE "U" POSTS PER SIGN

507 QUANTITY REQ'D 2

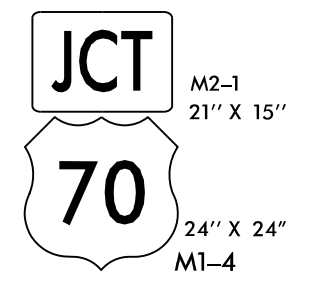


ONE "U" POST PER SIGN

403 QUANTITY REQ'D 4

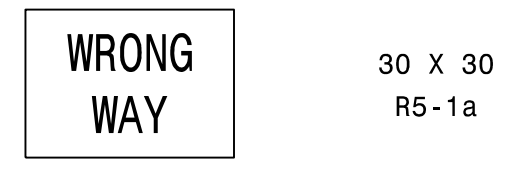


ONE "U" POST PER SIGN

408 QUANTITY REQ'D 3

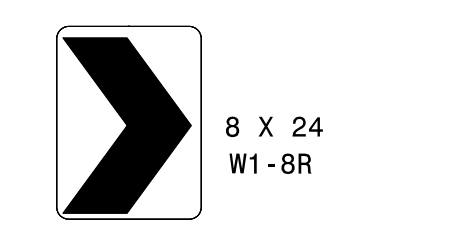


ONE "U" POSTS PER SIGN

503 QUANTITY REQ'D 1

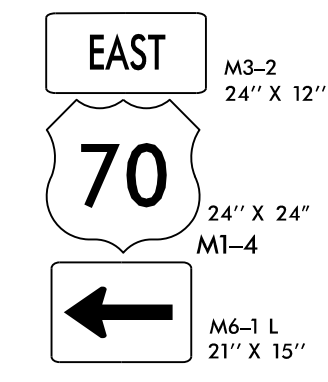


ONE "U" POST PER SIGN

508 QUANTITY REQ'D 1

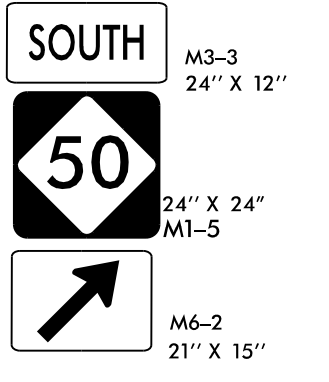


ONE "U" POST PER SIGN

404 QUANTITY REQ'D 3

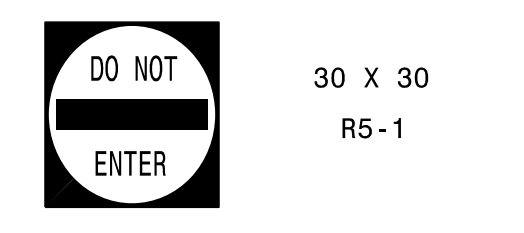


ONE "U" POST PER SIGN

409 QUANTITY REQ'D 4

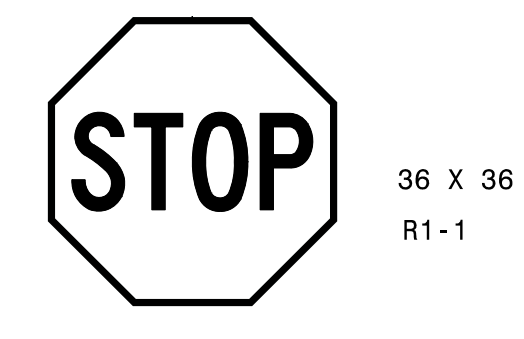


ONE "U" POST PER SIGN

504 QUANTITY REQ'D 1

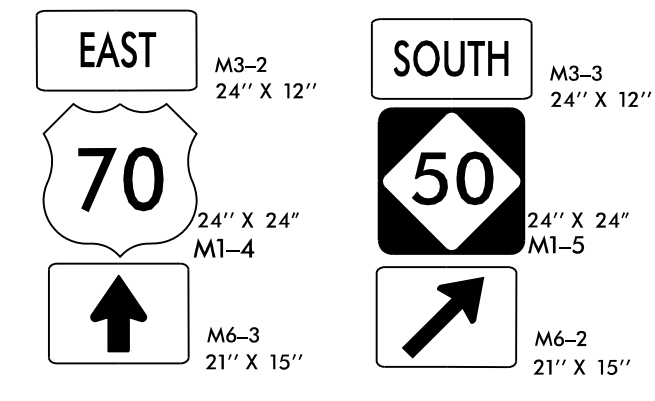


TWO "U" POSTS PER SIGN

509 QUANTITY REQ'D 1

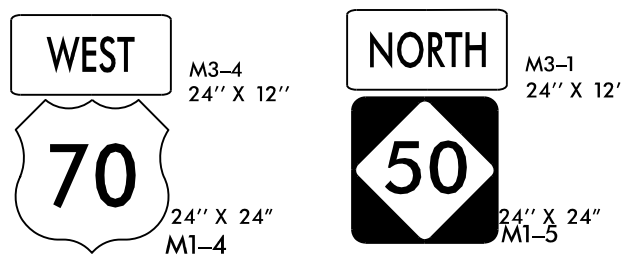

TWO "U" POSTS PER SIGN

405 QUANTITY REQ'D 1

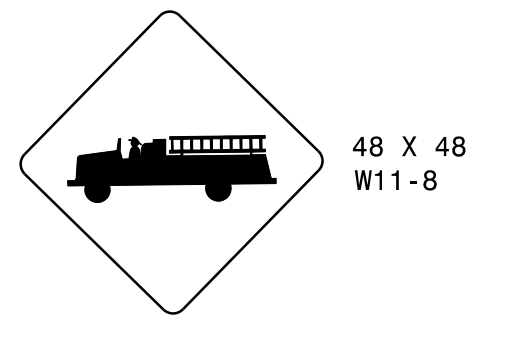


TWO "U" POST PER SIGN

AECOM NC FIRM LICENSE No: F-3042 5438 Wade Park Blvd., Ste 200 Raleigh, NC 27607 919.854.6200

TYPE 'E' & 'F' SIGNS

L:\Legacy\Projects\60436195-B-4654\900-Work\910-CAD\70-NC001-TIP\Traffic\TraficControl\TCP\current_files\B4654-sign-05_inventory.dgn

APPROVED: _____
DATE: 1/11/2024

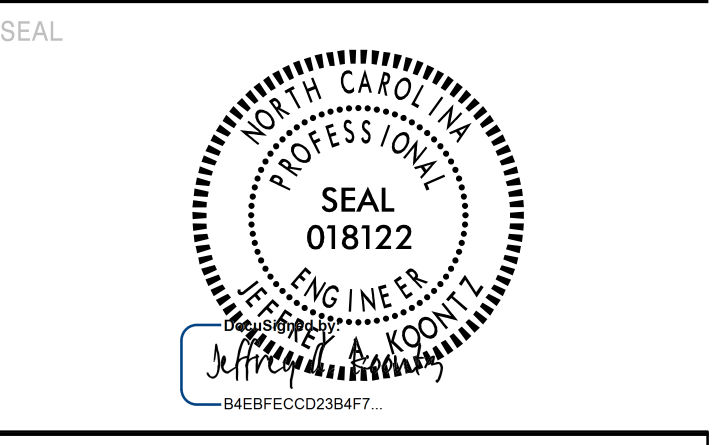


**DOCUMENT NOT CONSIDERED FINAL
UNLESS ALL SIGNATURES COMPLETED**



NC FIRM LICENSE No: F-3042
5438 Wade Park Blvd., Ste 200
Raleigh, NC 27607
919.854.6200

MATCHLINE STA. -L- 25+00
SEE SHEET SIGN-07

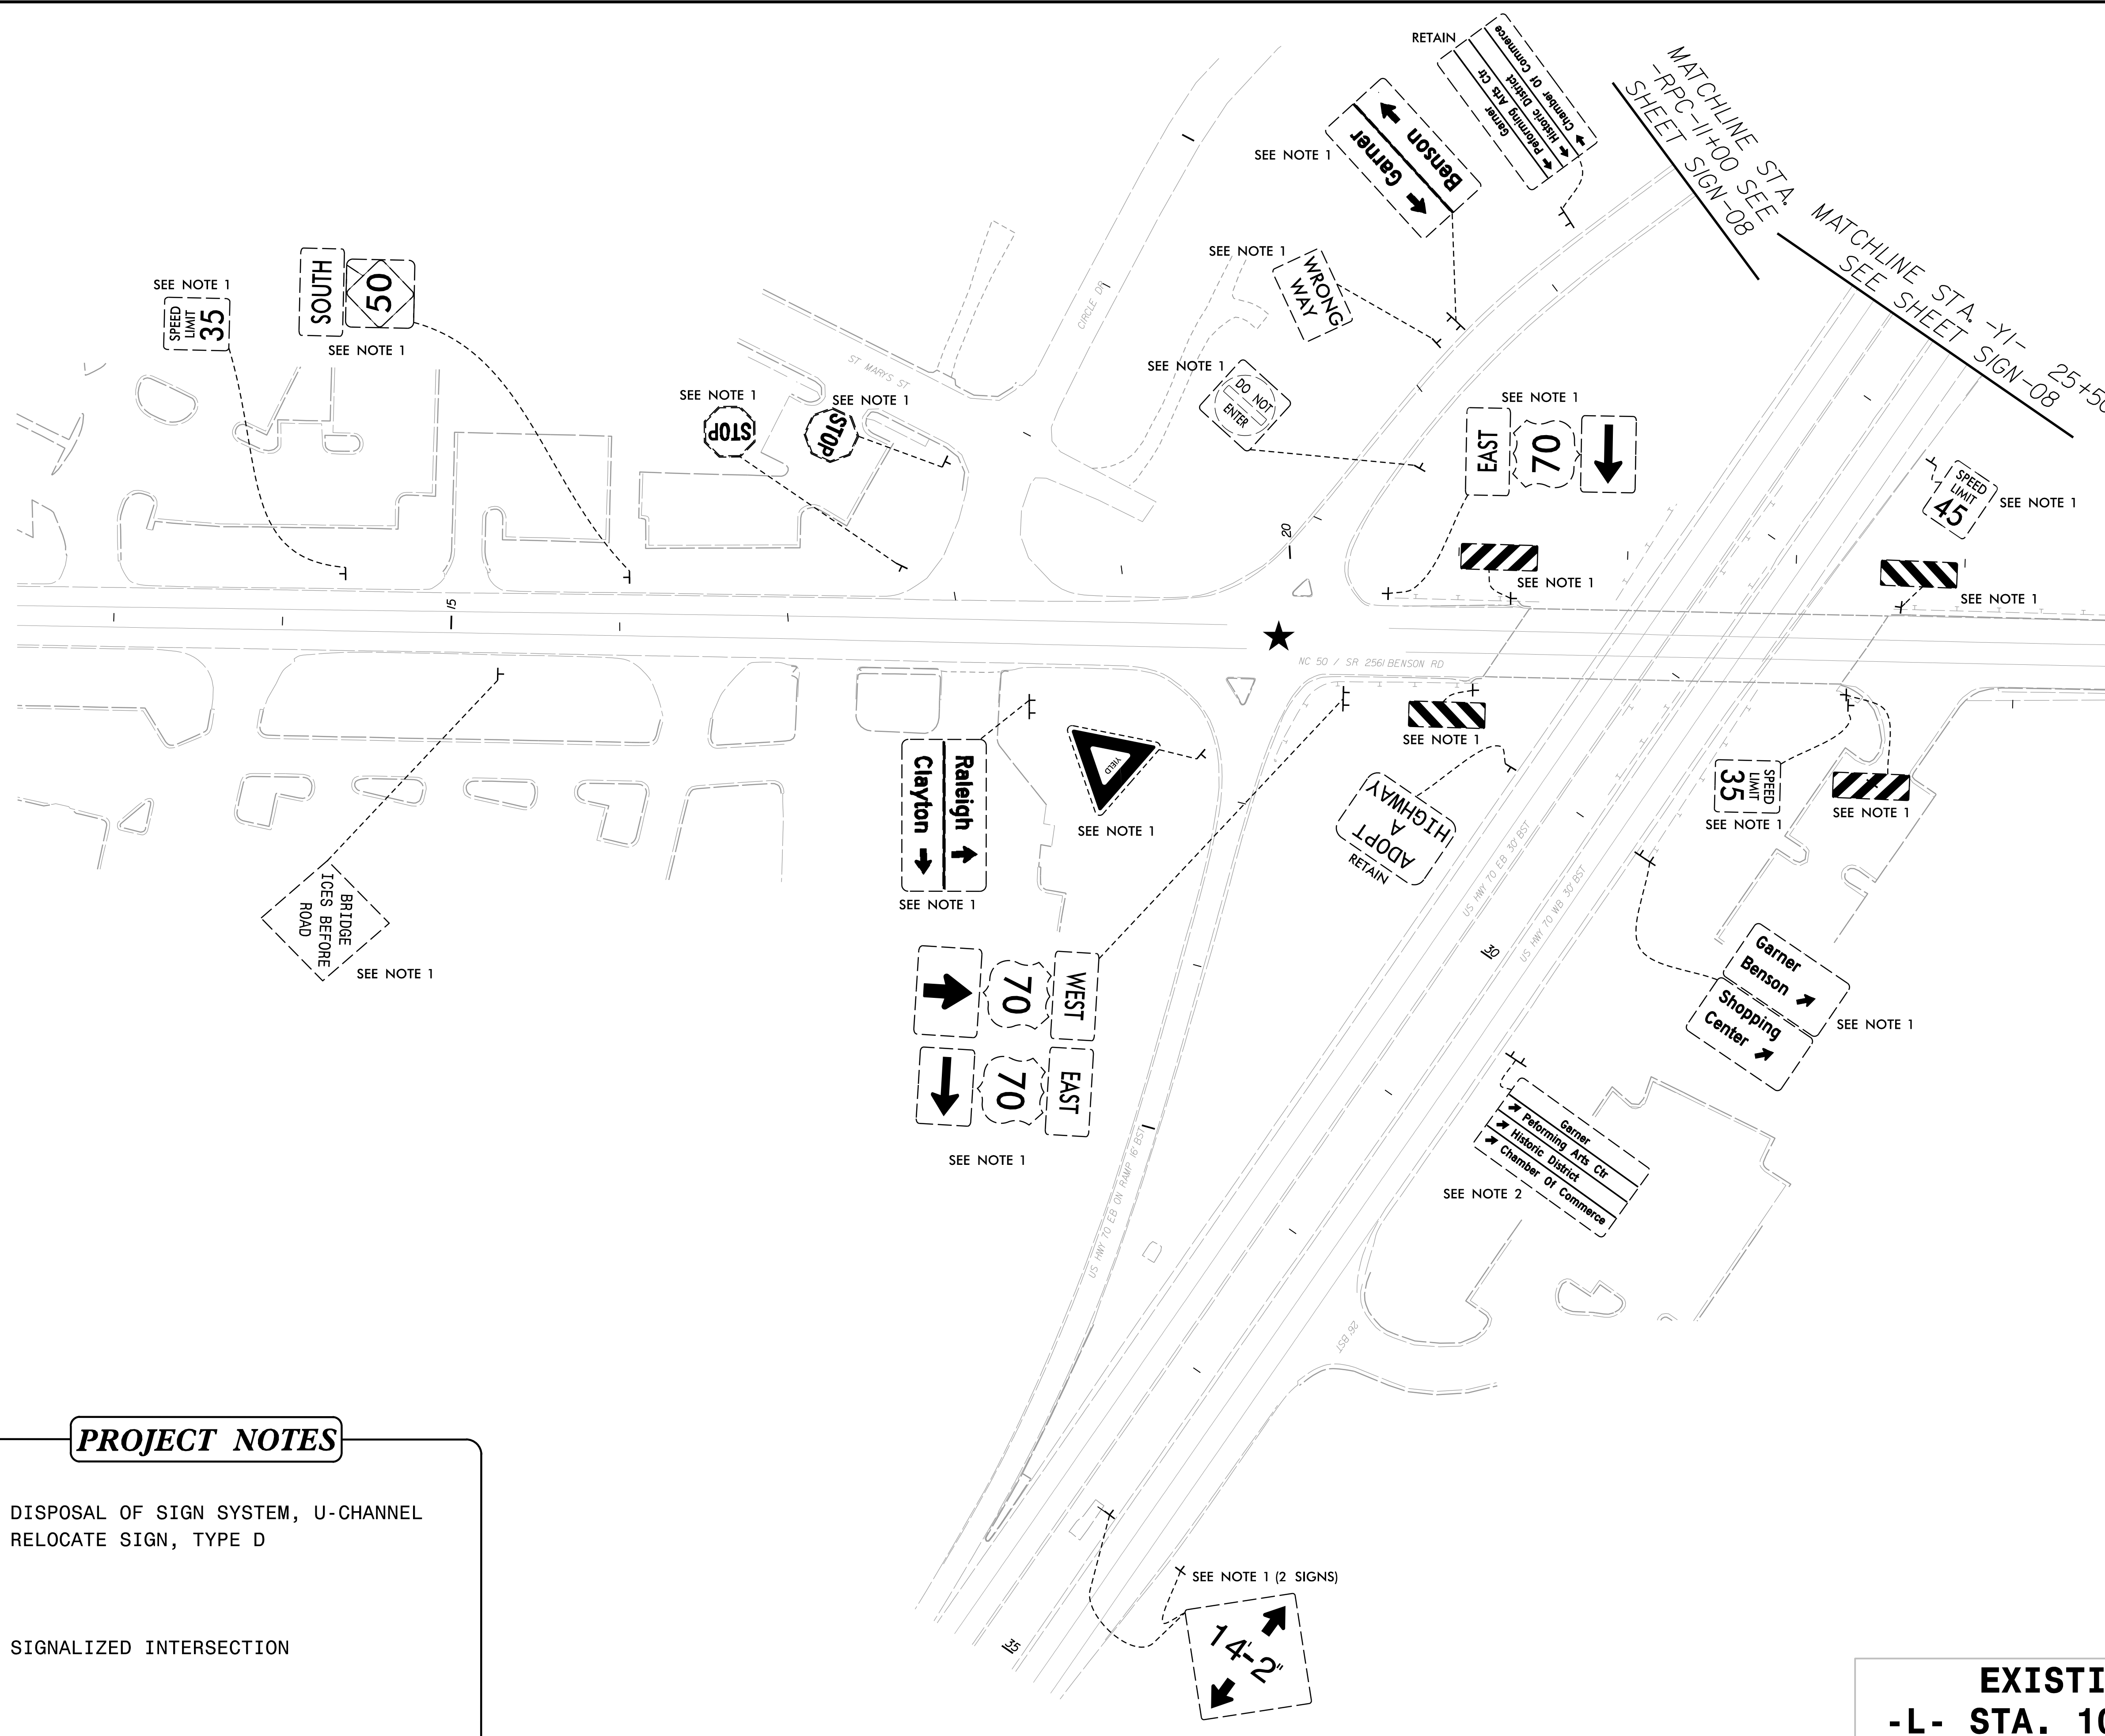

PROJECT NOTES

1. DISPOSAL OF SIGN SYSTEM, U-CHANNEL
2. RELOCATE SIGN, TYPE D


★ SIGNALIZED INTERSECTION

**EXISTING SIGNS
-L- STA. 10+00 TO 25+00
NC 50 AND US 70**

1/11/2024
 C:\projects\B-4654\3000 - Work\3010 - CAD\70 - NC001 - TPA - Traffic - Treat - Fun - Control\TPA\Work\3010 - CAD\70 - NC001 - TPA - Traffic - Treat - Fun - Control - Files\B4654 - signs-06.dgn
 J:\p\j\m\p\h\er\son

PROJECT REFERENCE NO. B-4654	SHEET NO. SIGN-07
---------------------------------	----------------------


APPROVED: _____
DATE: 1/11/2024

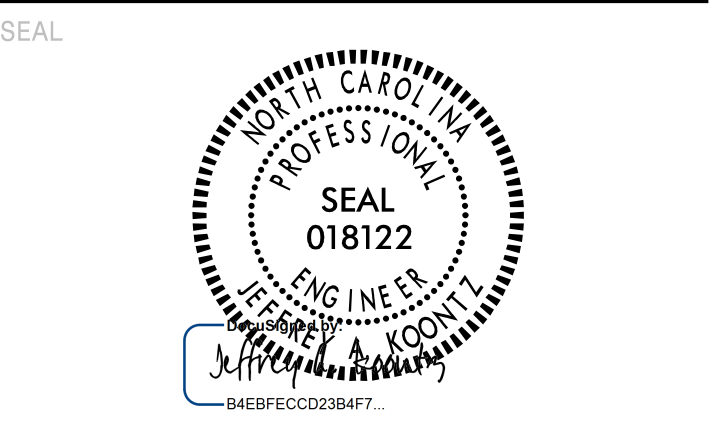

**DOCUMENT NOT CONSIDERED FINAL
UNLESS ALL SIGNATURES COMPLETED**



NC FIRM LICENSE No: F-3042
5438 Wade Park Blvd., Ste 200
Raleigh, NC 27607
919.854.6200

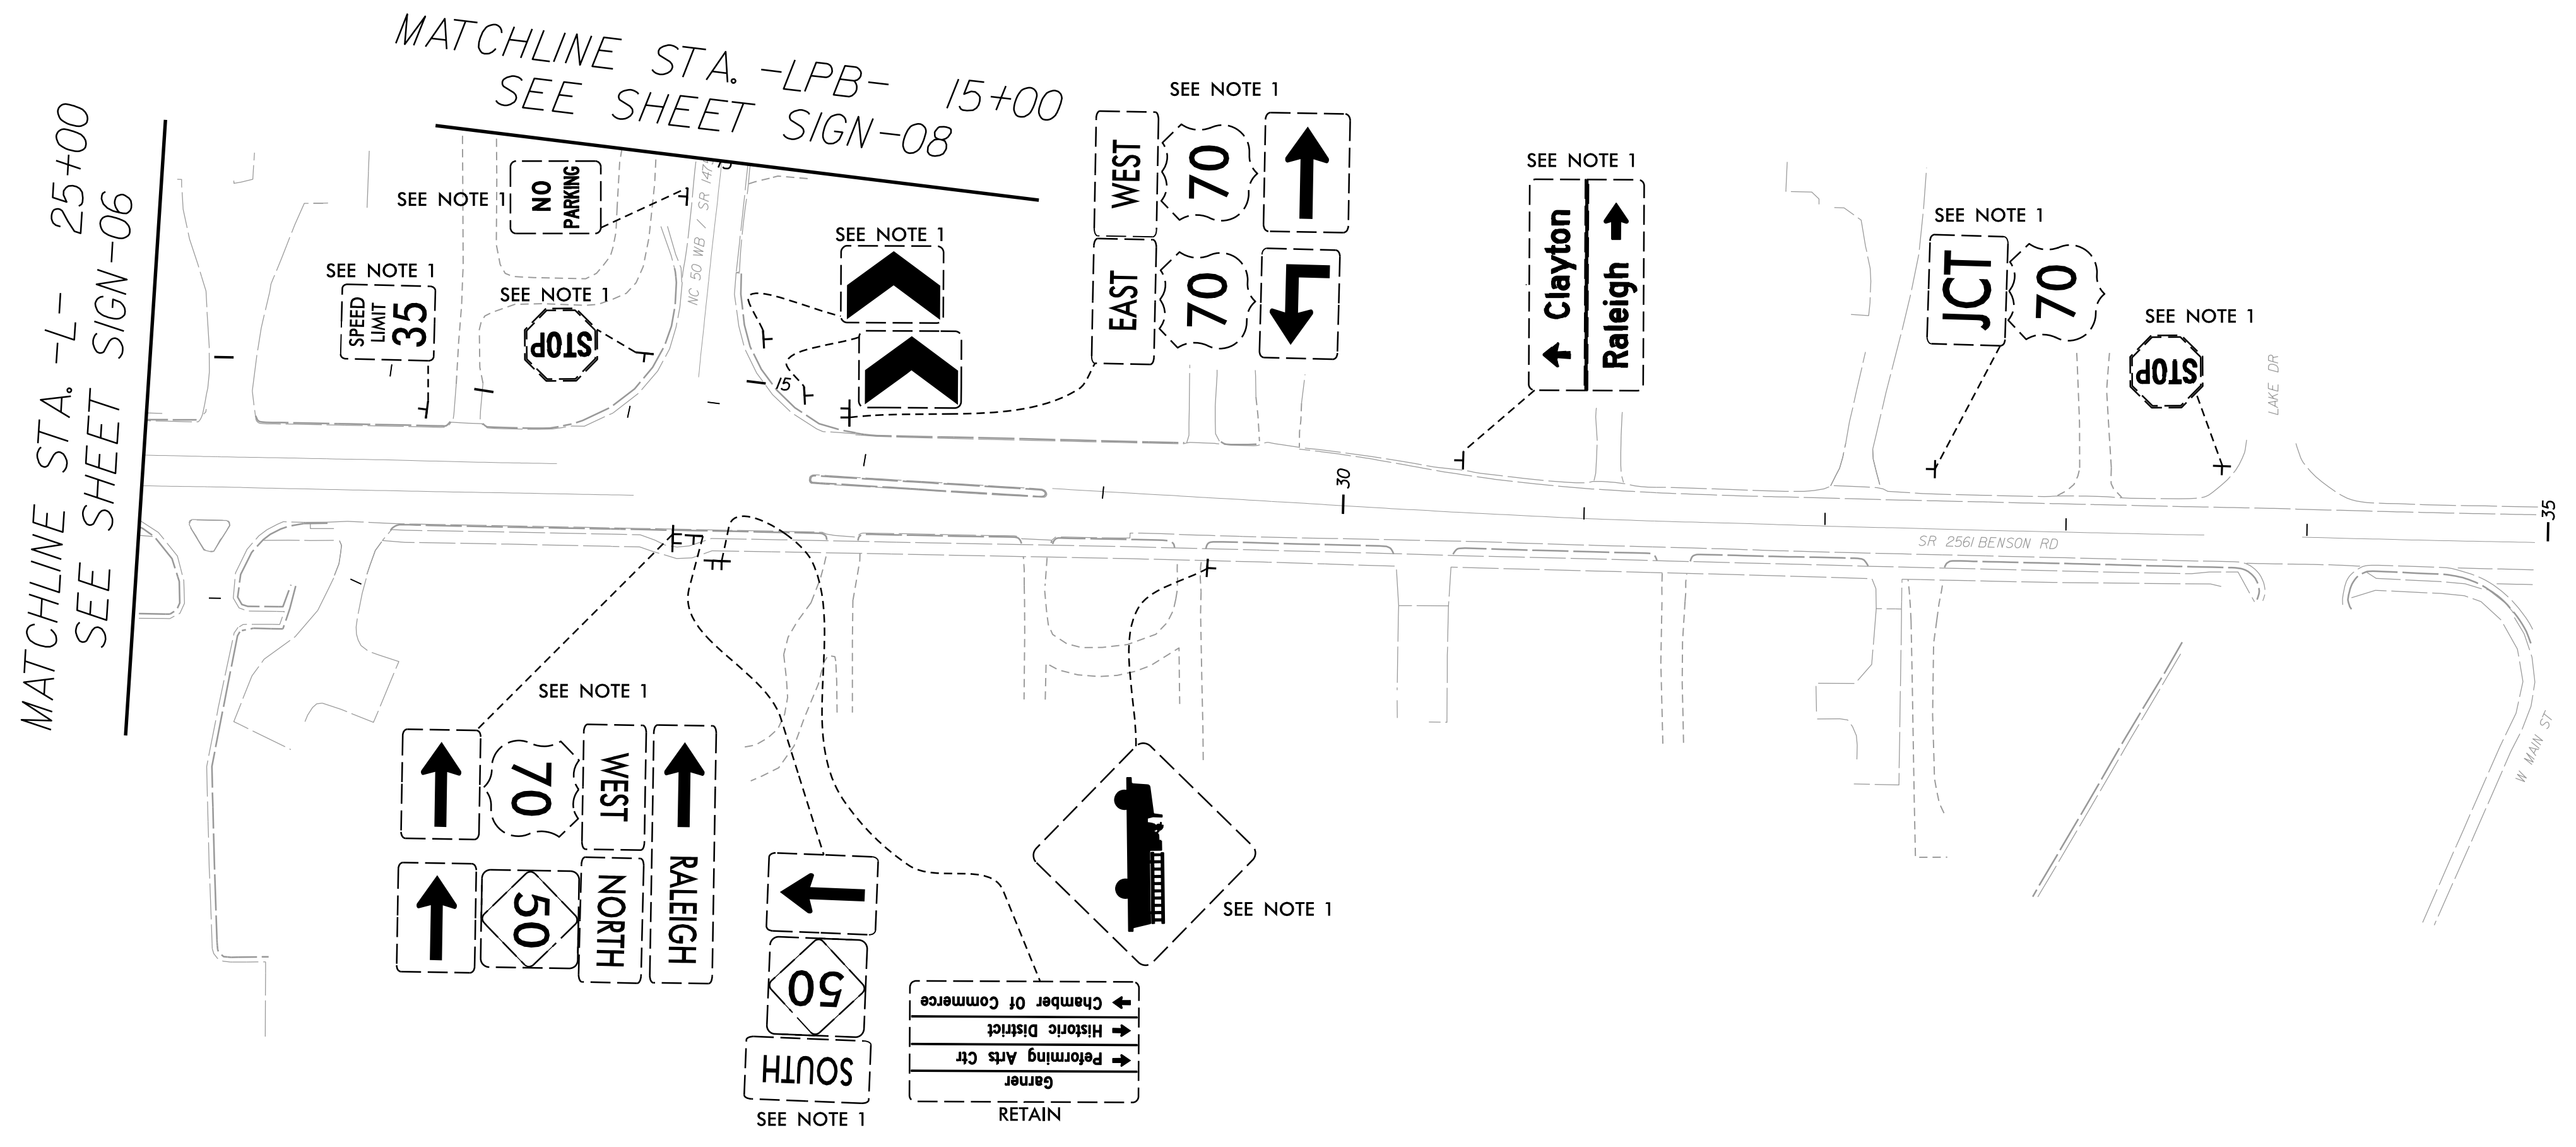


PROJECT NOTES

- DISPOSAL OF SIGN SYSTEM, U-CHANNEL
- RELOCATE SIGN, TYPE D

★ SIGNALIZED INTERSECTION

**EXISTING SIGNS
-L- STA. 25+00 TO 35+00
NC 50**


1/11/2024
 C:\projects\B-4654\SR 2561 BENSON RD\2561_BENSON_RD_SIGN-07.dgn
 J:\projects\B-4654\SR 2561 BENSON RD\2561_BENSON_RD_SIGN-07.dgn

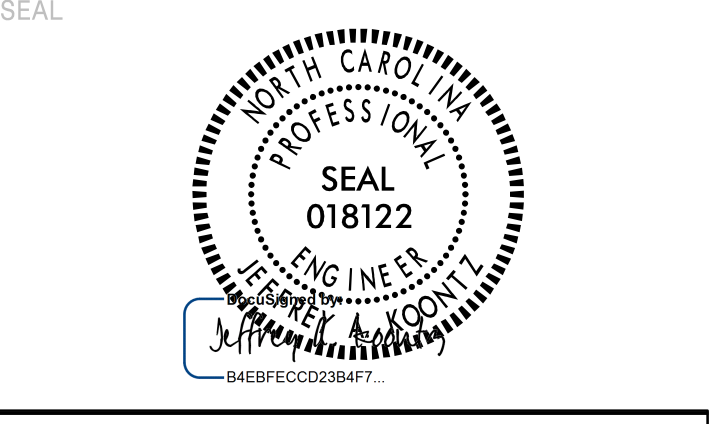

**DOCUMENT NOT CONSIDERED FINAL
UNLESS ALL SIGNATURES COMPLETED**

AECOM

NC FIRM LICENSE No: F-3042
 5438 Wade Park Blvd., Ste 200
 Raleigh, NC 27607
 919.854.6200

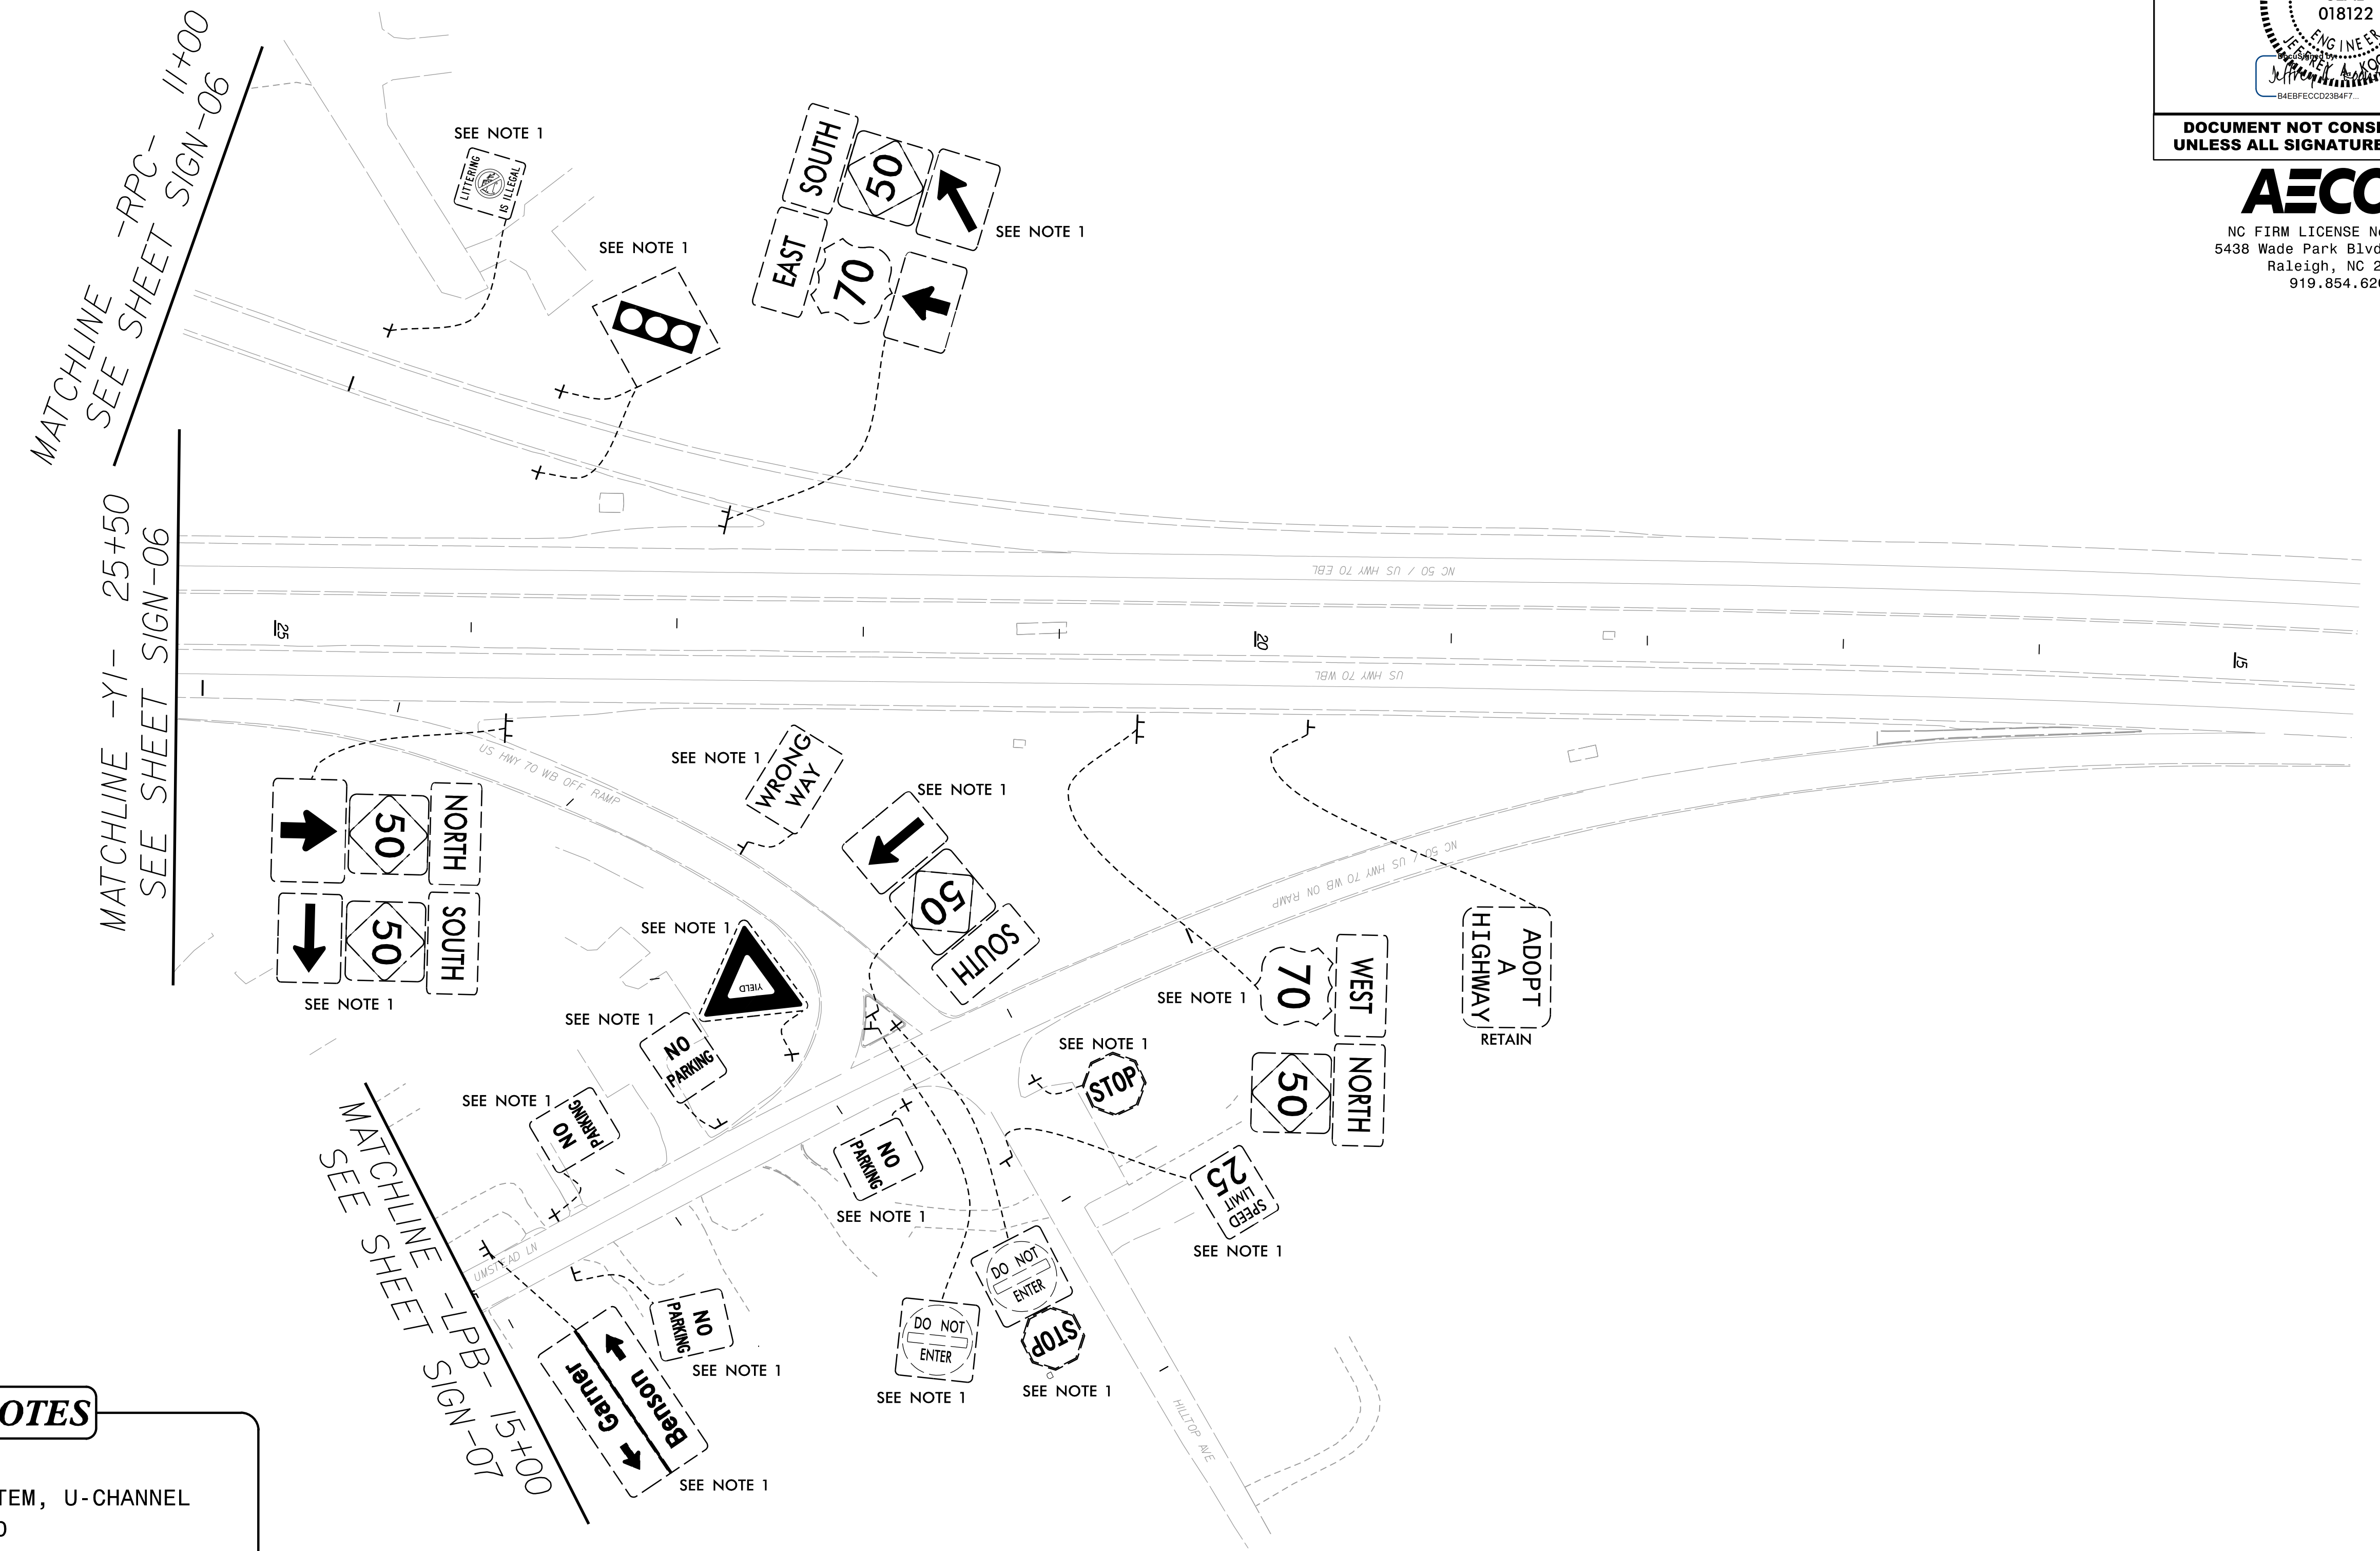


PROJECT NOTES

- DISPOSAL OF SIGN SYSTEM, U-CHANNEL
- RELOCATE SIGN, TYPE D

★ SIGNALIZED INTERSECTION

**EXISTING SIGNS
-Y1- 15+00 TO 25+50
US 70**


1/11/2024
 C:\projects\B-4654\300 - Match 010 - CAD\70 - MCDOT - IIPV - Traffic - Treat For Control\IIPV\Signment - Files\B4654 - signs-08.dgn
 J:\p\jtk\mp\jtk-son

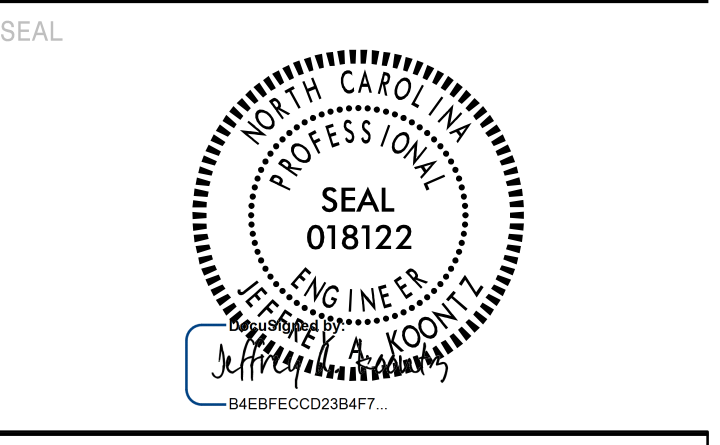

DOCUMENT NOT CONSIDERED FINAL
UNLESS ALL SIGNATURES COMPLETED



NC FIRM LICENSE No: F-3042
5438 Wade Park Blvd., Ste 200
Raleigh, NC 27607
919.854.6200

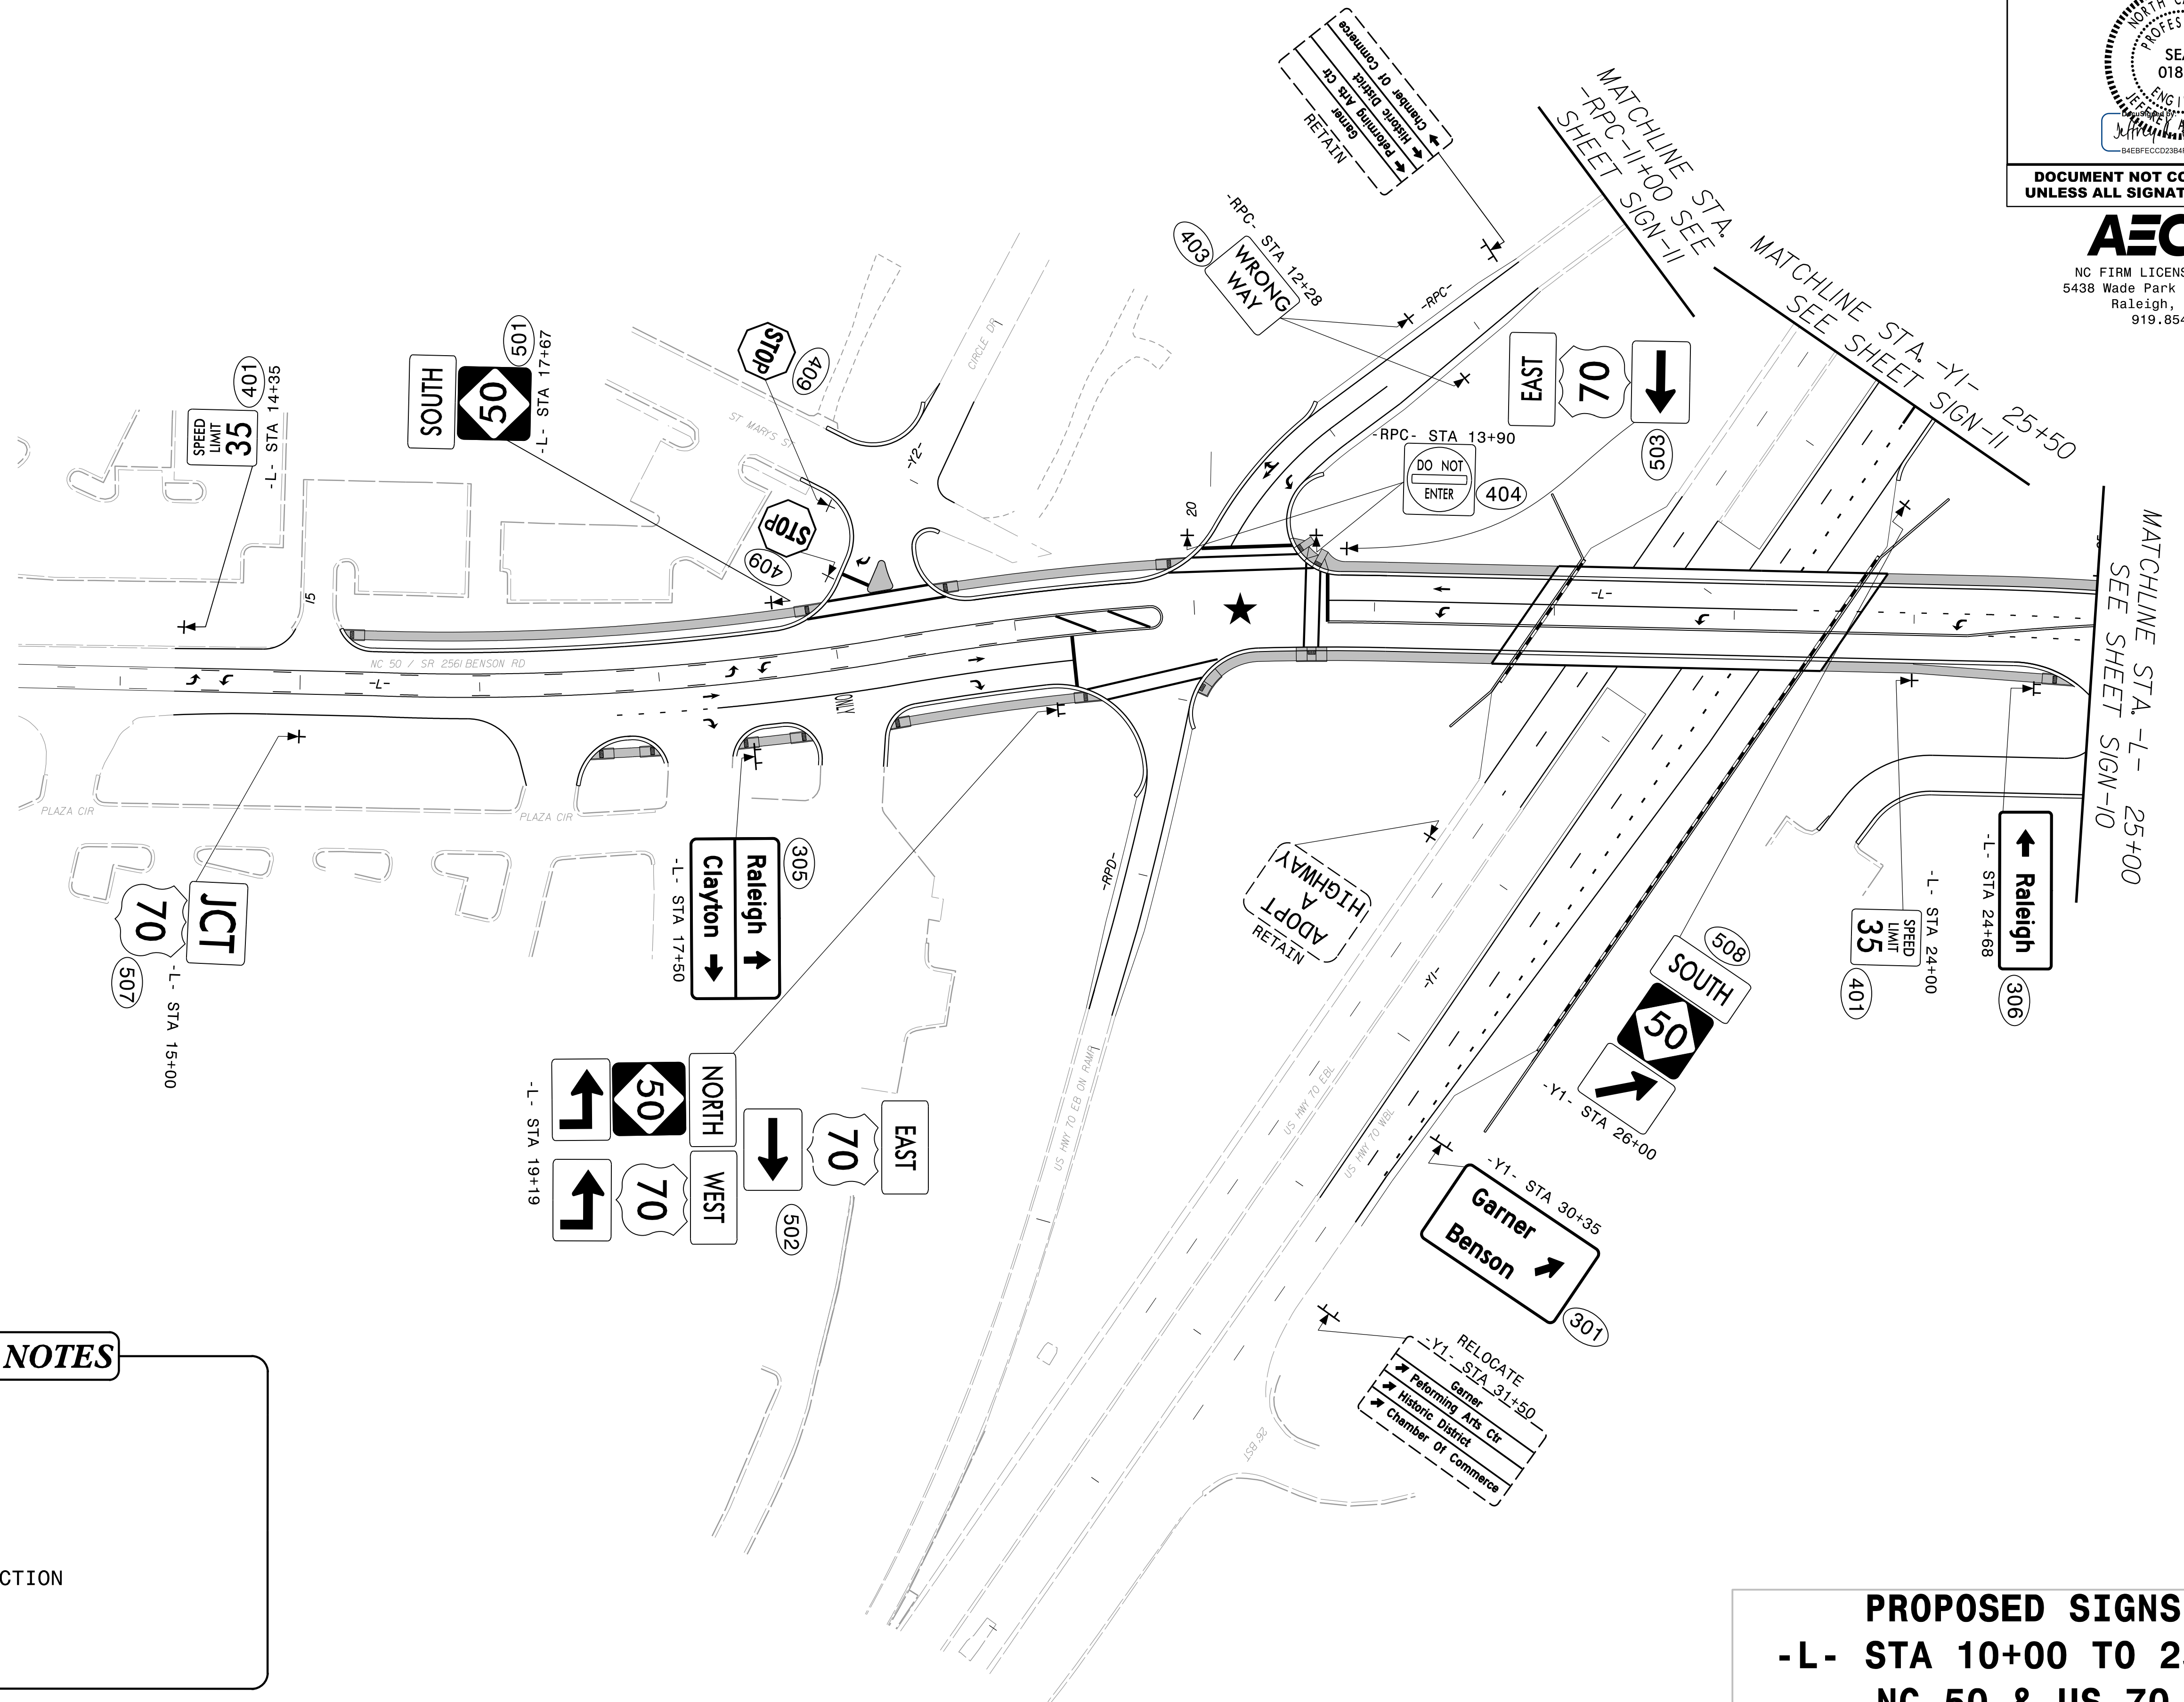


PROJECT NOTES

★ SIGNALIZED INTERSECTION

PROPOSED SIGNS
-L- STA 10+00 TO 25+00
NC 50 & US 70

1/11/2024
 C:\Users\jmcpherson\OneDrive\Documents\Projects\B-4654\300 - Work\5010 - CAD\70 - NC001 - TPA\Traffic\TrafficControl\TPA\Signment_files\B4654_sign-09.dwg
 jmcpherson


APPROVED: _____
DATE: 1/11/2024

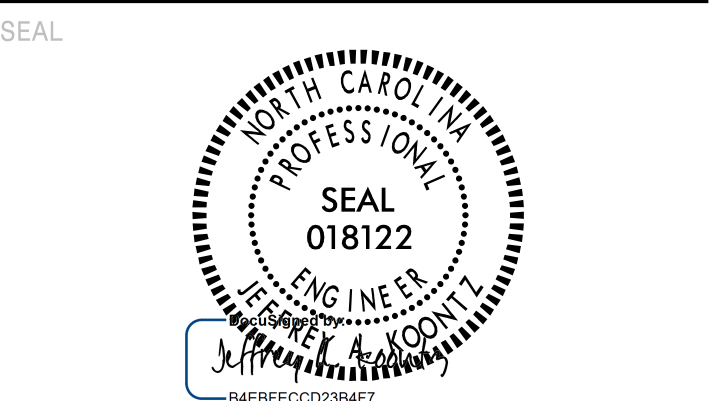

**DOCUMENT NOT CONSIDERED FINAL
UNLESS ALL SIGNATURES COMPLETED**



NC FIRM LICENSE No: F-3042
5438 Wade Park Blvd., Ste 200
Raleigh, NC 27607
919.854.6200

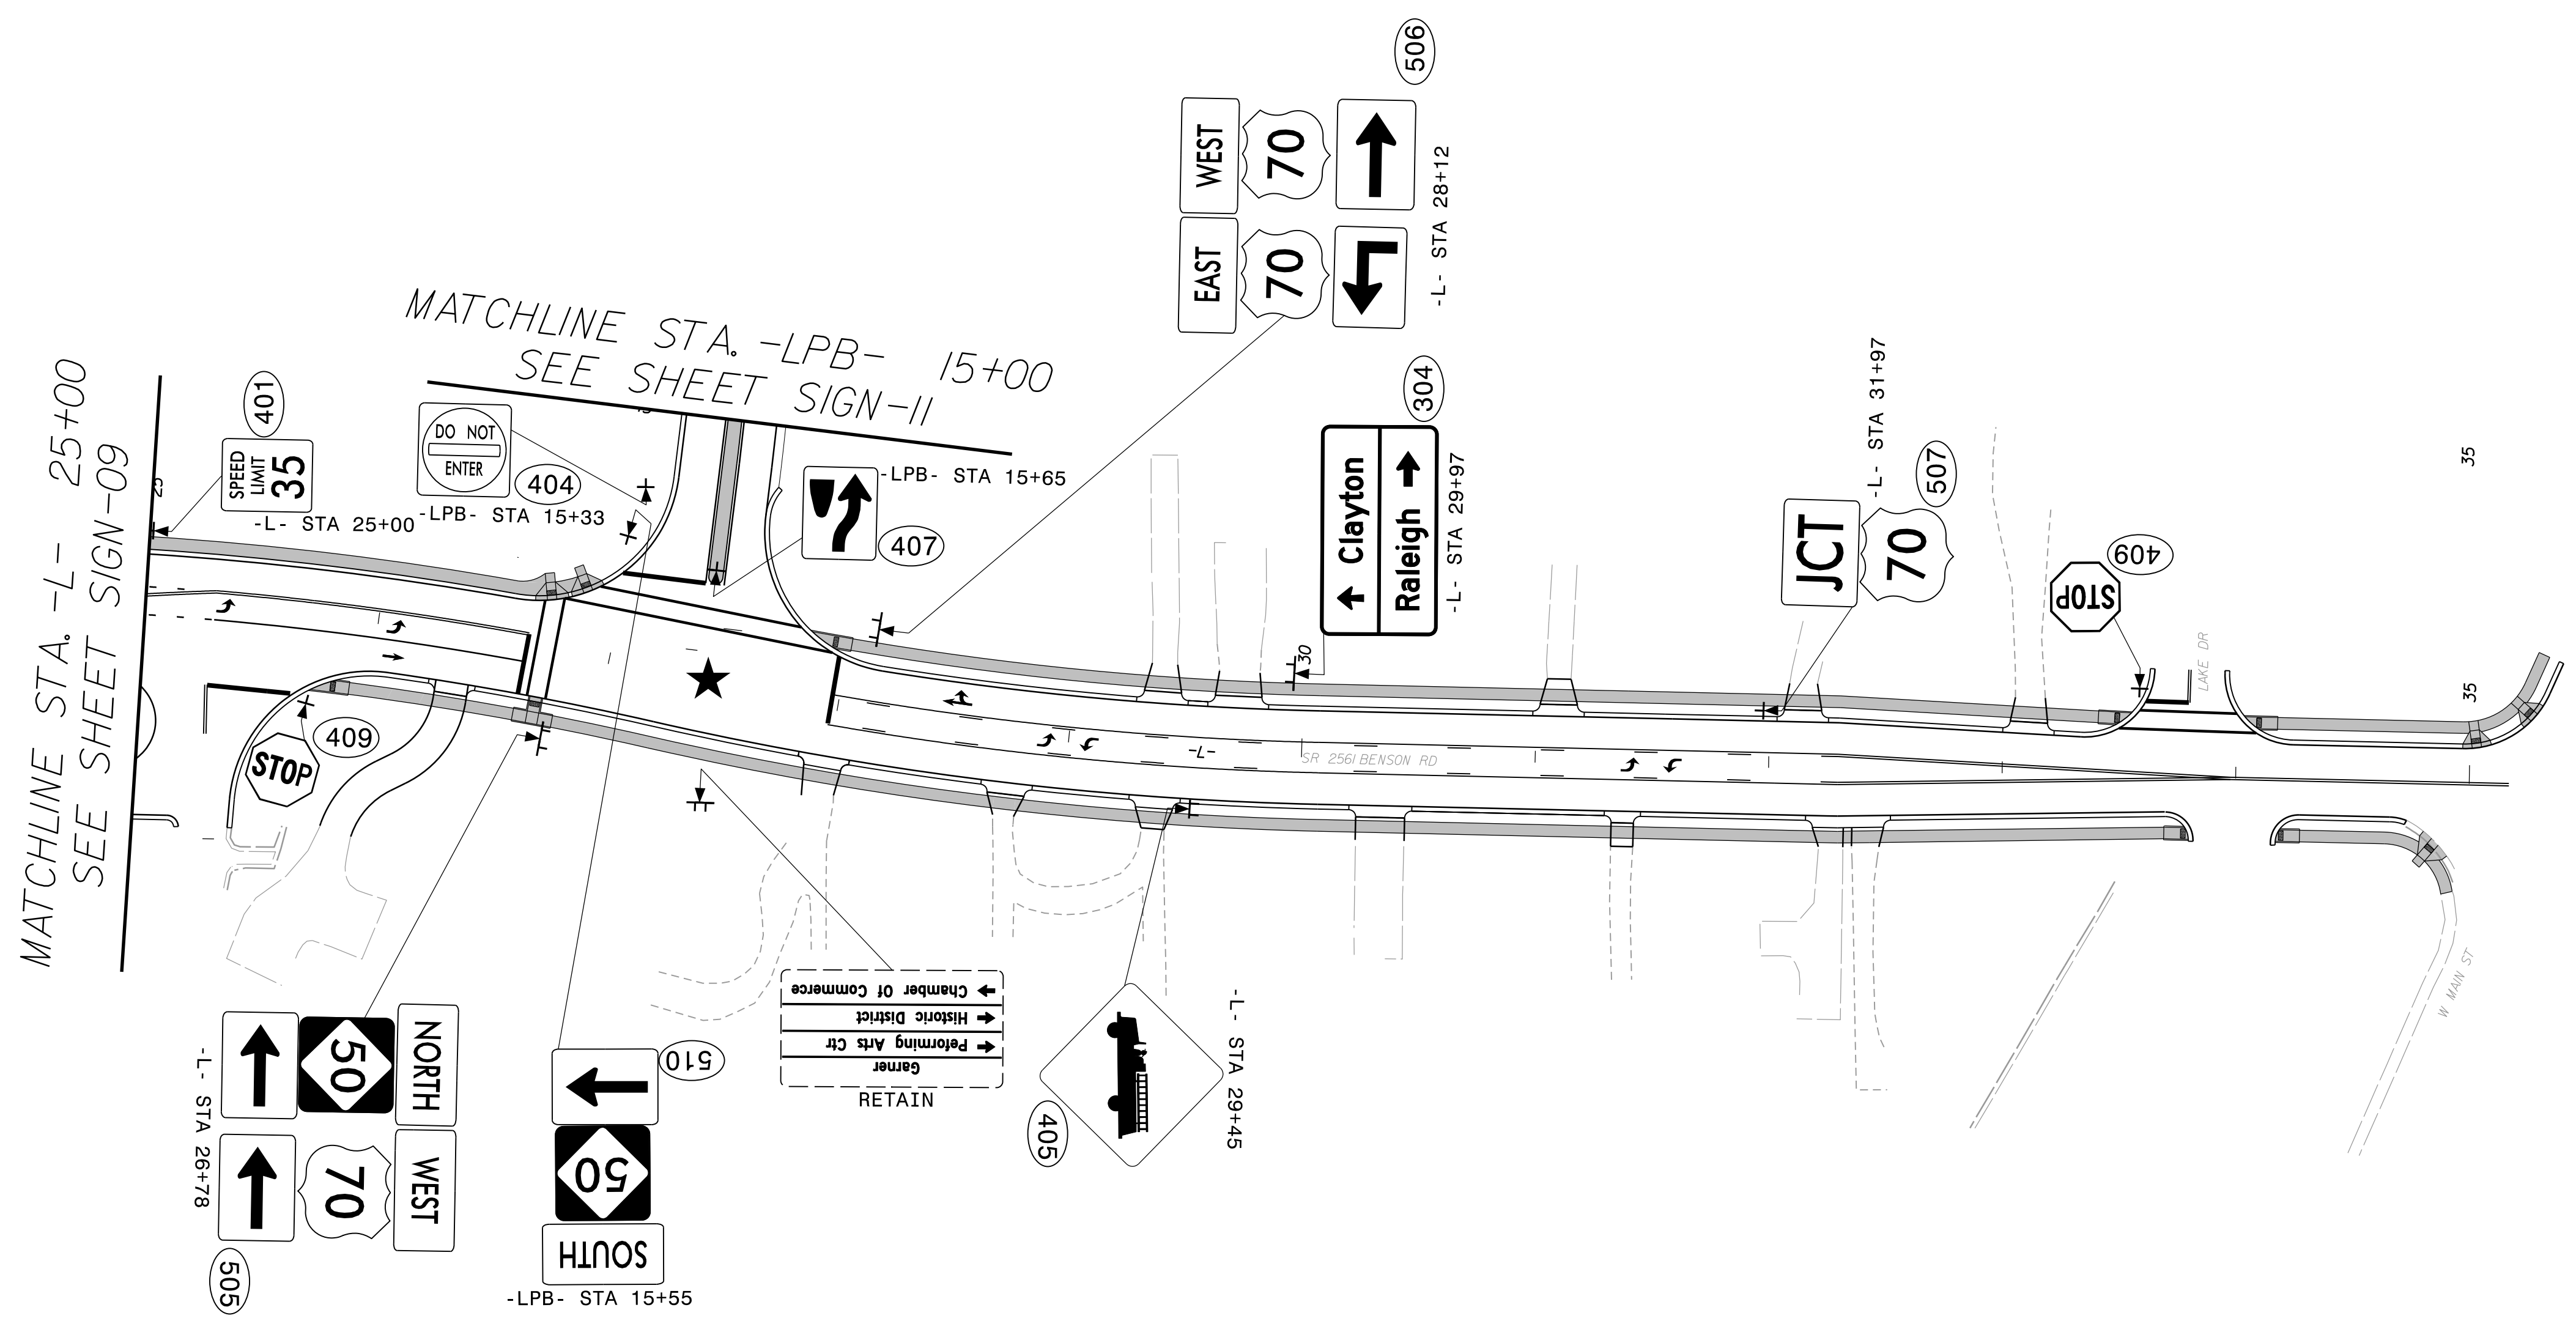


PROJECT NOTES

★ SIGNALIZED INTERSECTION

**PROPOSED SIGNS
-L- STA. 25+00 TO 35+00
NC 50**

1/11/2024
 C:\Users\jmcpherson\OneDrive\Documents\B-4654\3000 - Work\510 - CAD\70 - NC001 - IIP\Traffic\SR 2561 Benson Rd\Control\IIP\Signment\Files\B4654_sgn-10.dgn
 jmcpherson


APPROVED: _____
 DATE: 1/11/2024

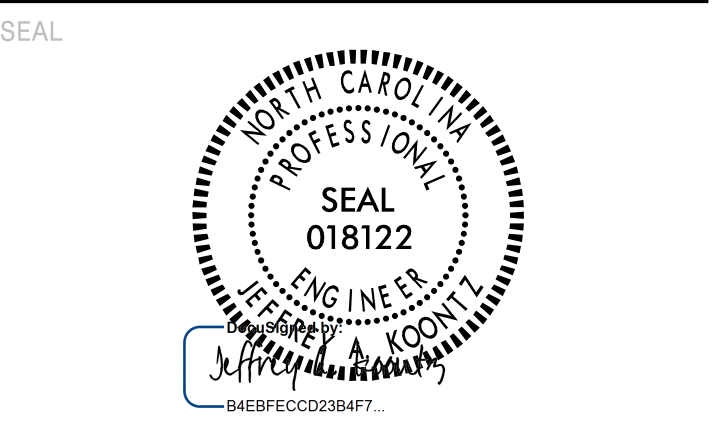

**DOCUMENT NOT CONSIDERED FINAL
 UNLESS ALL SIGNATURES COMPLETED**



NC FIRM LICENSE No: F-3042
 5438 Wade Park Blvd., Ste 200
 Raleigh, NC 27607
 919.854.6200

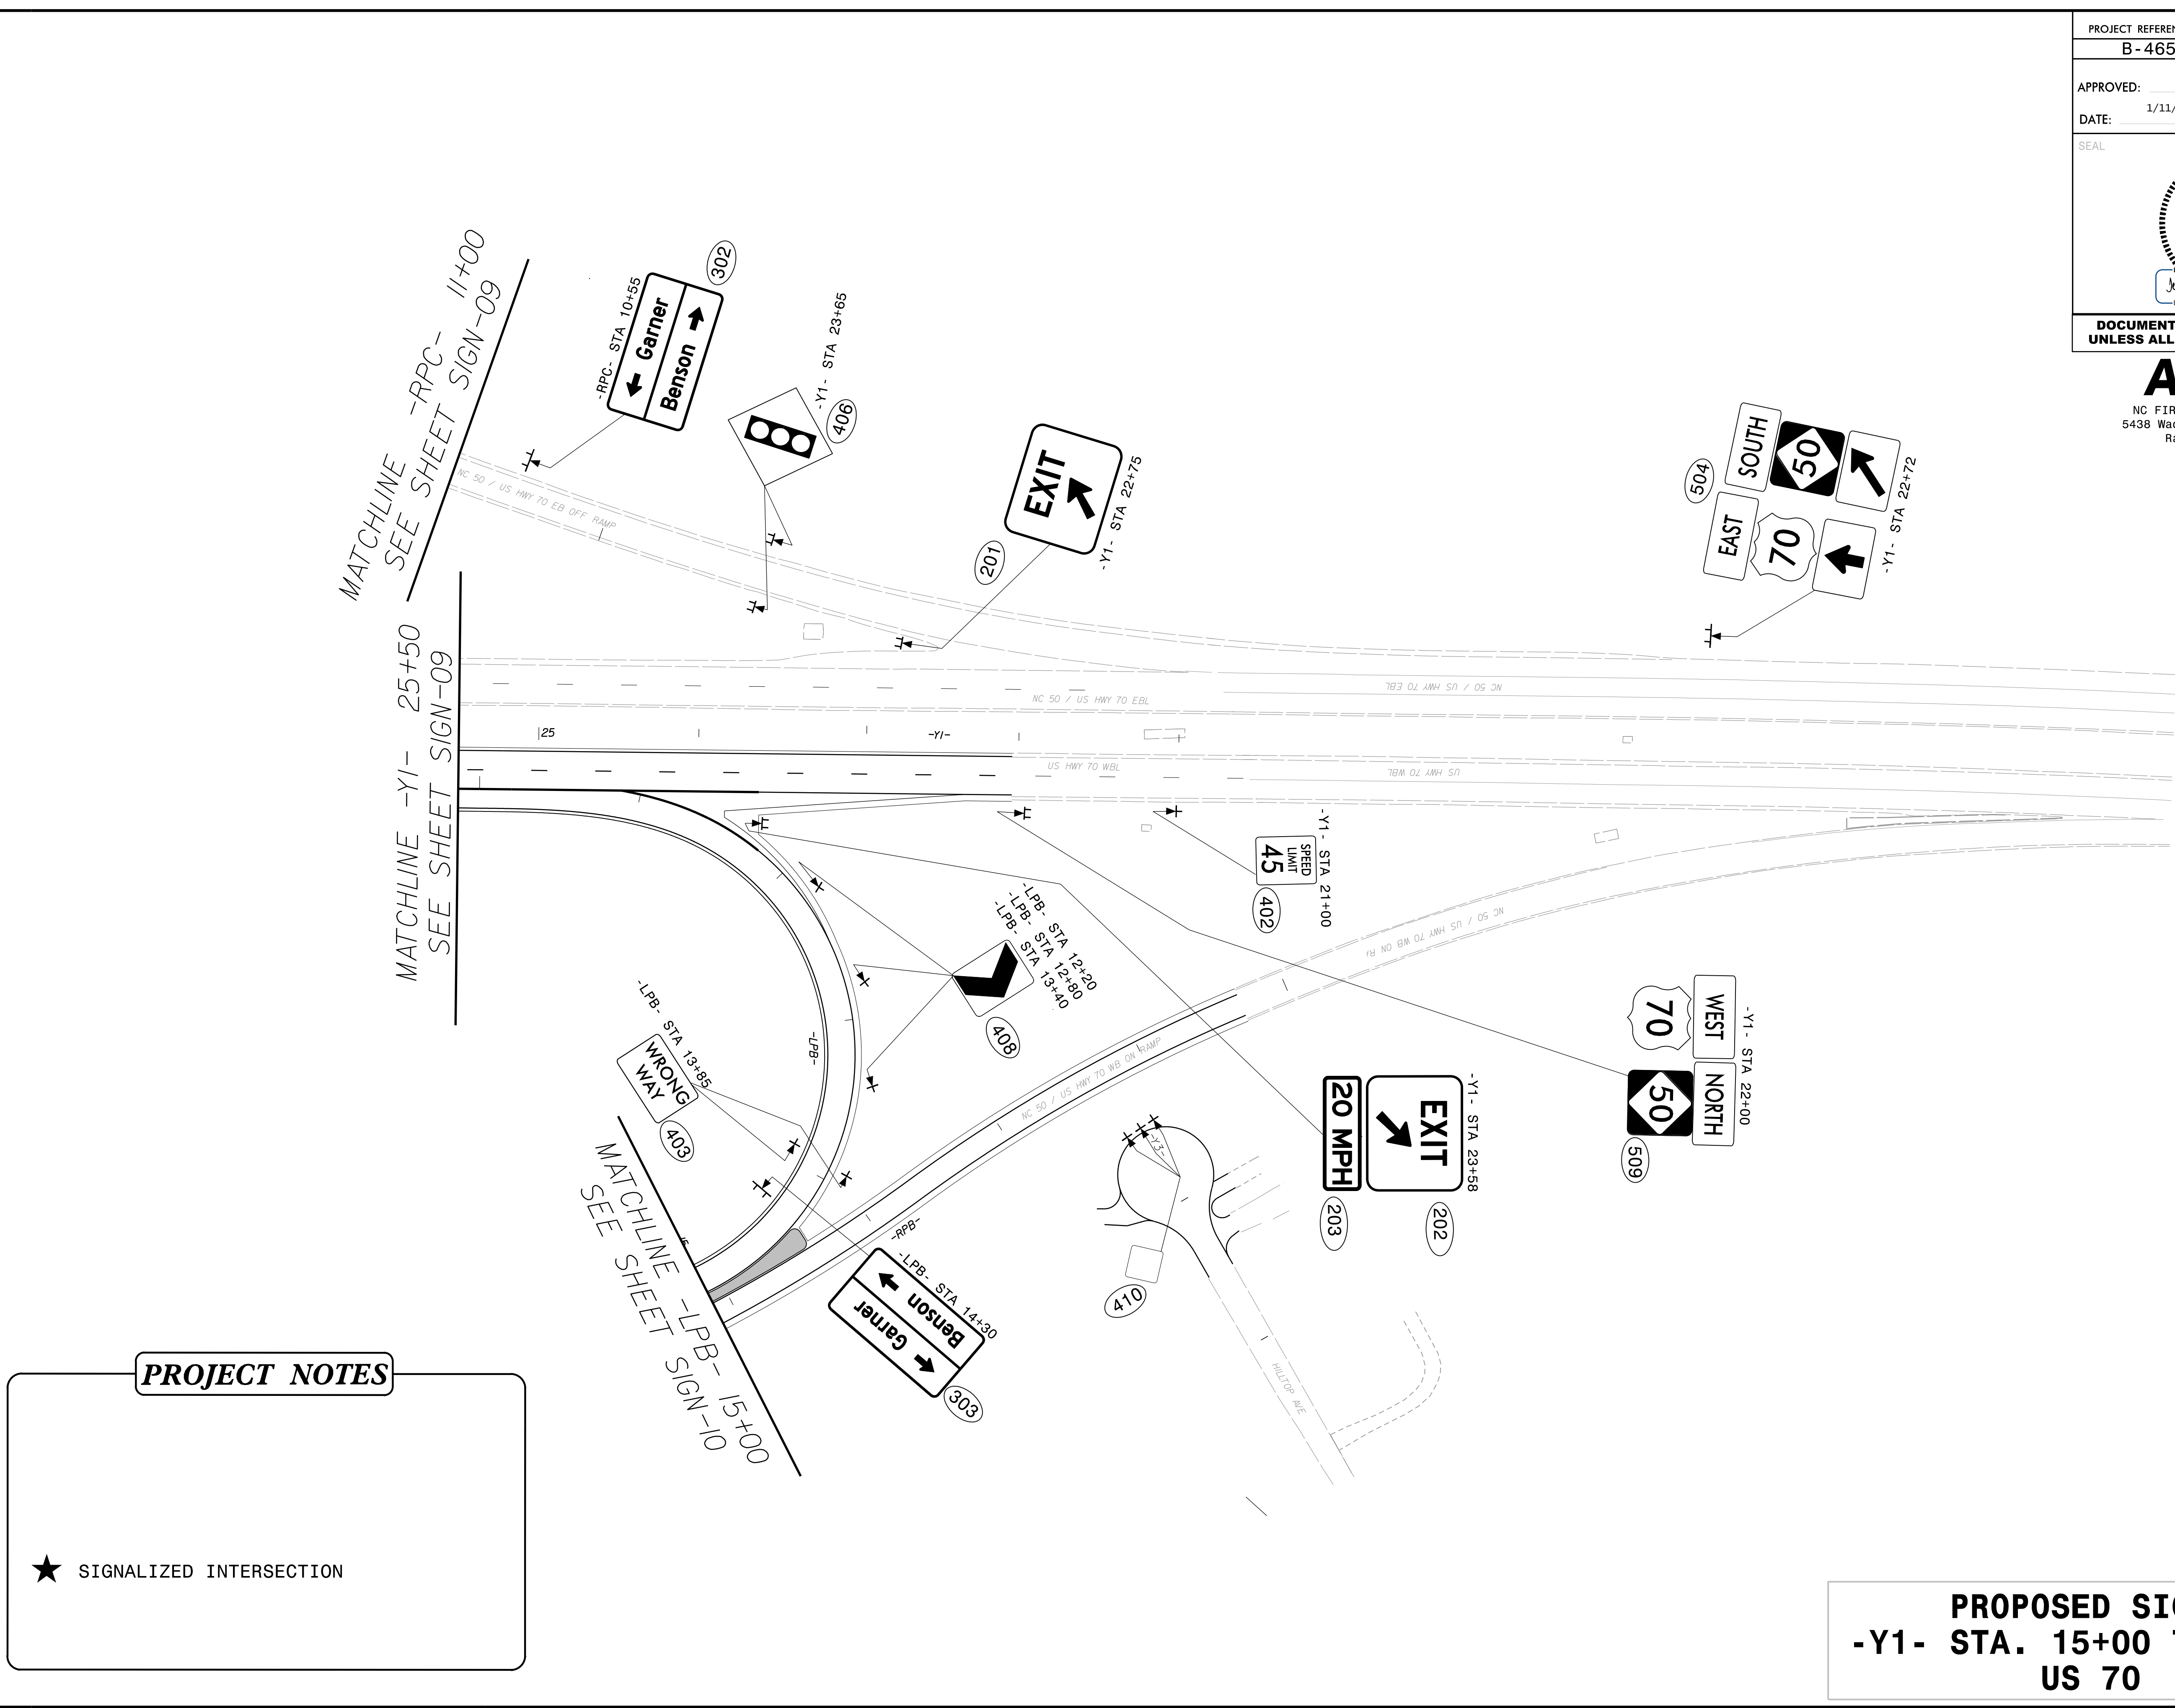

PROJECT NOTES

★ SIGNALIZED INTERSECTION

**PROPOSED SIGNS
 -Y1- STA. 15+00 TO 25+50
 US 70**

1/11/2024
 C:\projects\B-4654\95-B-4654-000-Work\910-CAD\70-MCDDT-FIP\Traffic\Control\TIP\Document-Files\B4654-supp-11.dwg
 jperkins@peter-son.com