
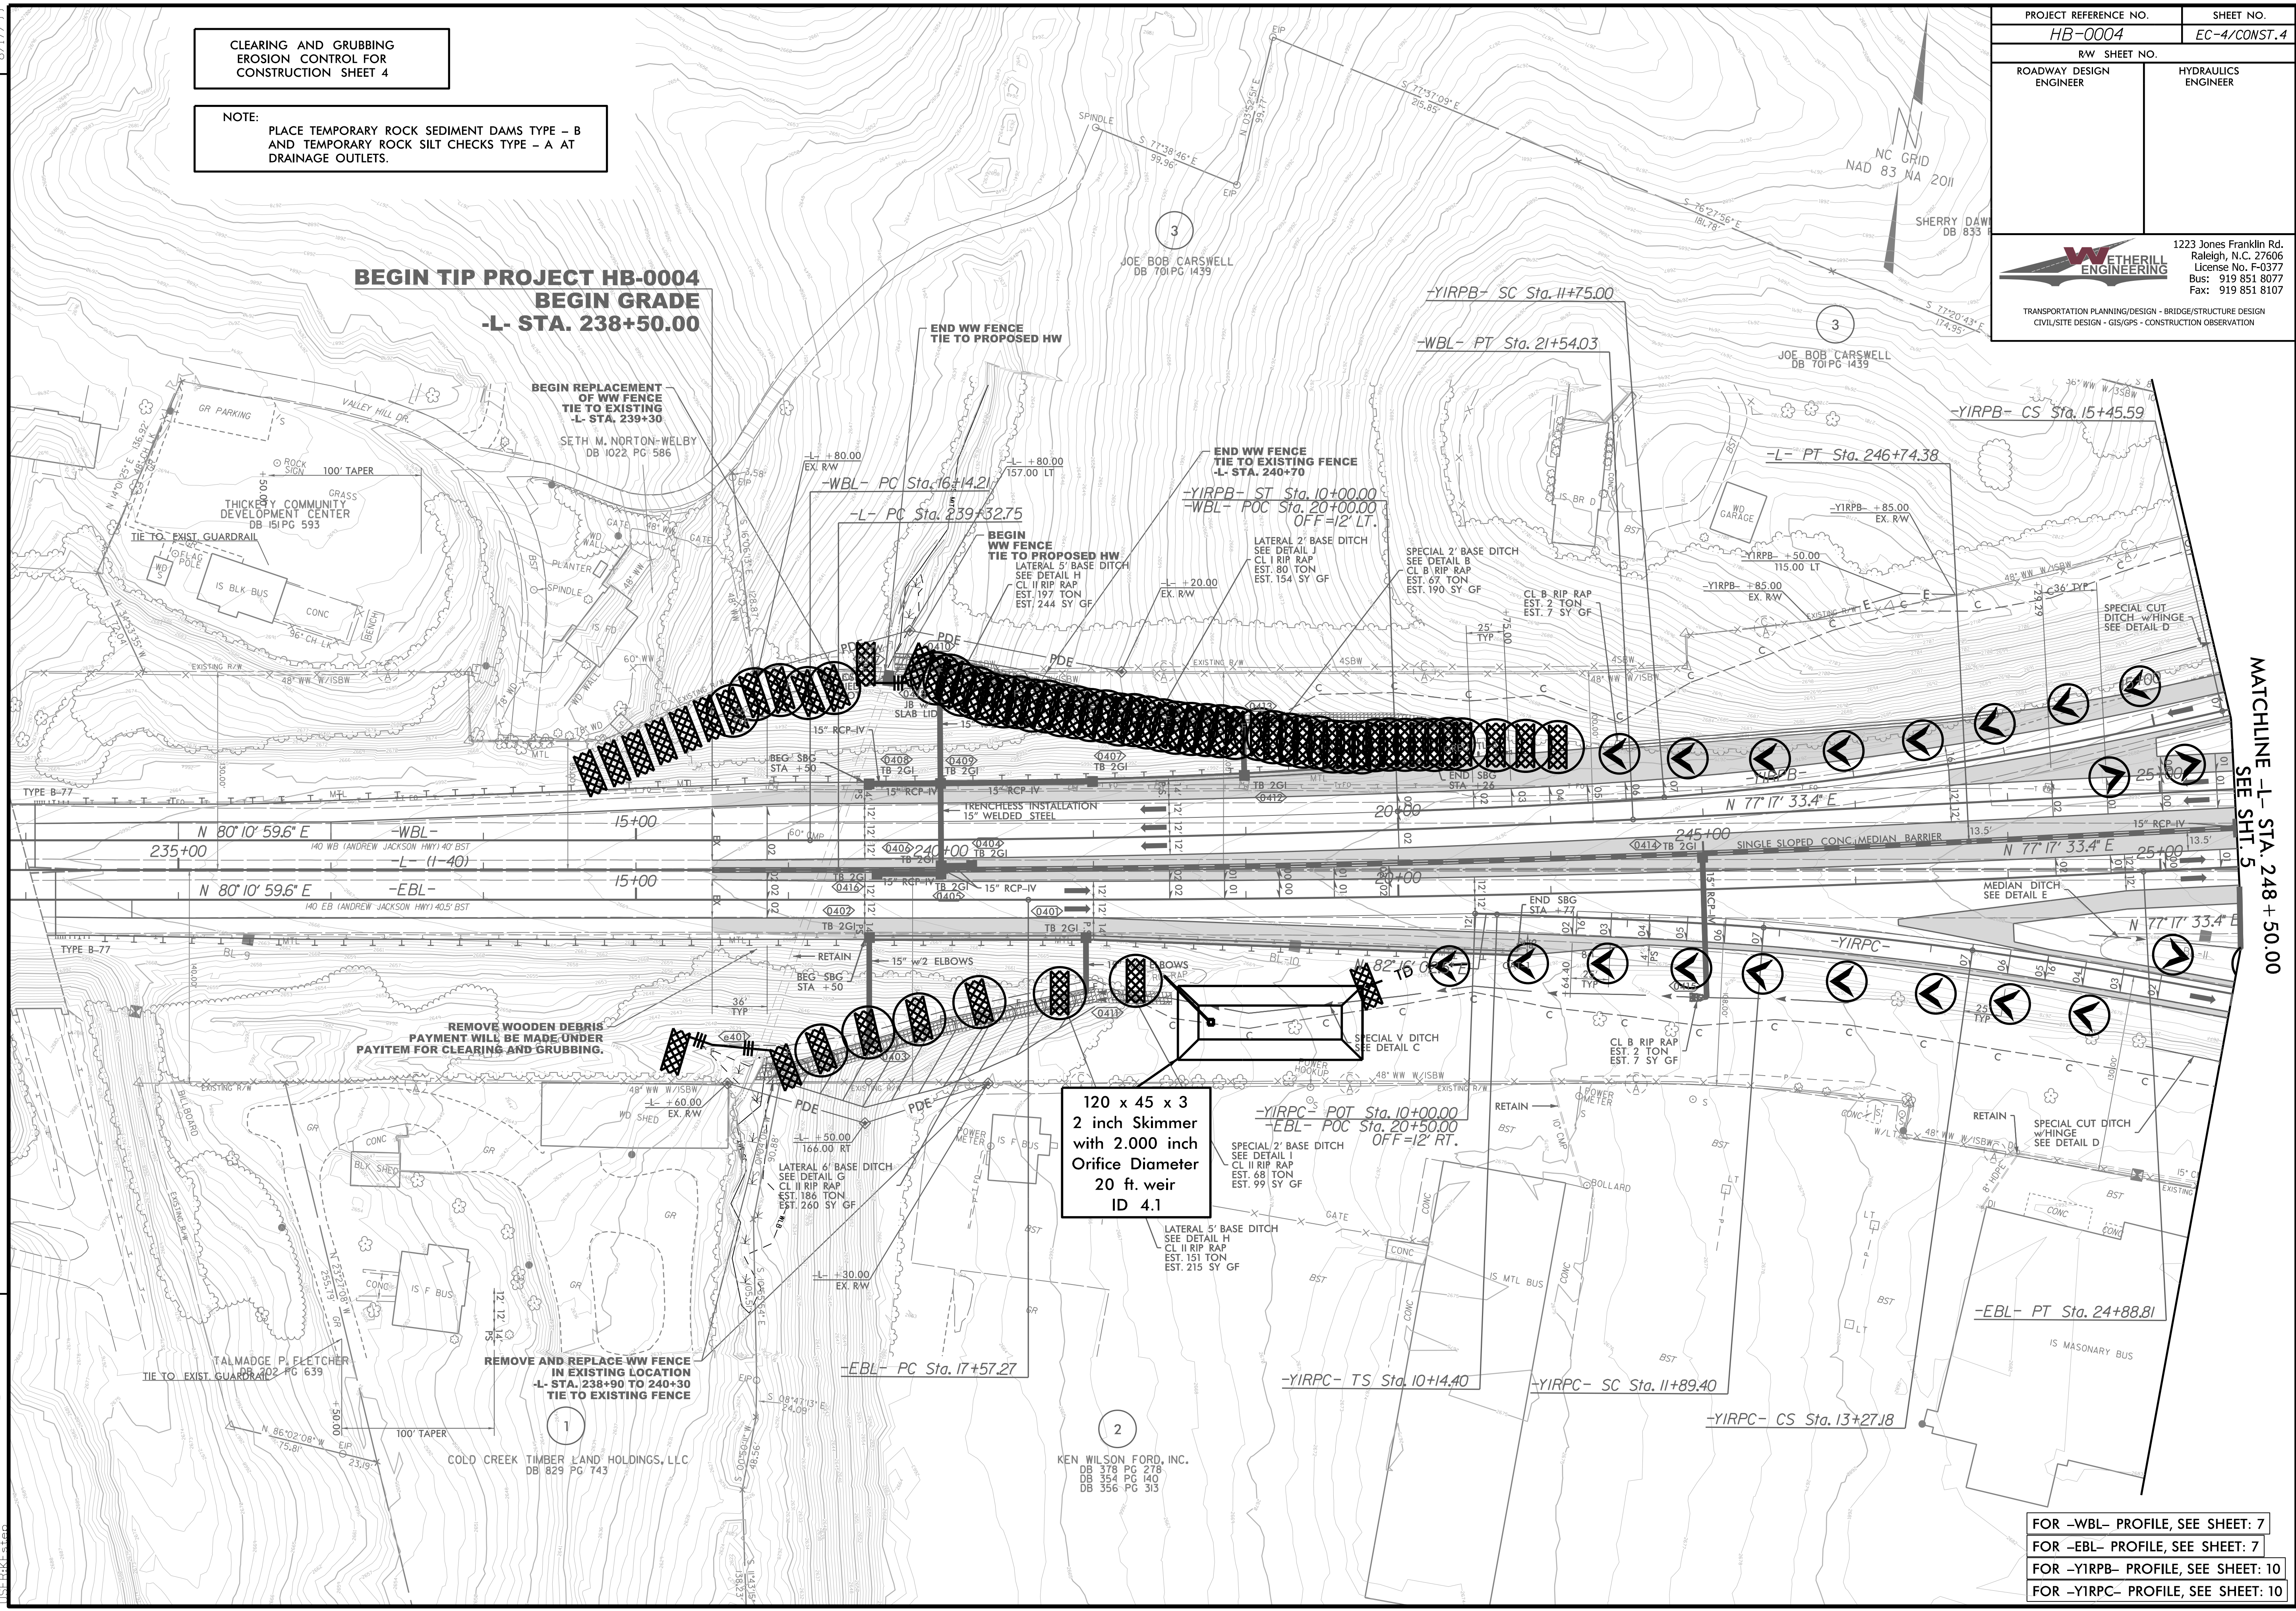


PROJECT REFERENCE NO. HB-0004	SHEET NO. EC-4/CONST.4
RW SHEET NO.	
ROADWAY DESIGN ENGINEER	HYDRAULICS ENGINEER
	
1223 Jones Franklin Rd. Raleigh, N.C. 27606 License No. F-0377 Bus: 919 851 8077 Fax: 919 851 8107	
TRANSPORTATION PLANNING/DESIGN - BRIDGE/STRUCTURE DESIGN CIVIL/SITE DESIGN - GIS/GPS - CONSTRUCTION OBSERVATION	

CLEARING AND GRUBBING
EROSION CONTROL FOR
CONSTRUCTION SHEET 4

NOTE:
PLACE TEMPORARY ROCK SEDIMENT DAMS TYPE - B
AND TEMPORARY ROCK SILT CHECKS TYPE - A AT
DRAINAGE OUTLETS.

BEGIN TIP PROJECT HB-0004
BEGIN GRADE
-L- STA. 238+50.00



REVISIONS

MATCHLINE -L- STA. 248 + 50.00
SEE SH. 5

120 x 45 x 3
2 inch Skimmer
with 2.000 inch
Orifice Diameter
20 ft. weir
ID 4.1

FOR -WBL- PROFILE, SEE SHEET: 7
FOR -EBL- PROFILE, SEE SHEET: 7
FOR -YIRPB- PROFILE, SEE SHEET: 10
FOR -YIRPC- PROFILE, SEE SHEET: 10

3/5/2024 HB0004_EC_psh_04_CG.dgn
11:56:11 AM