


TIP PROJECT: U-5813

See Sheet 1A For Index of Sheets
See Sheet 1B For Conventional Plan Sheet Symbols

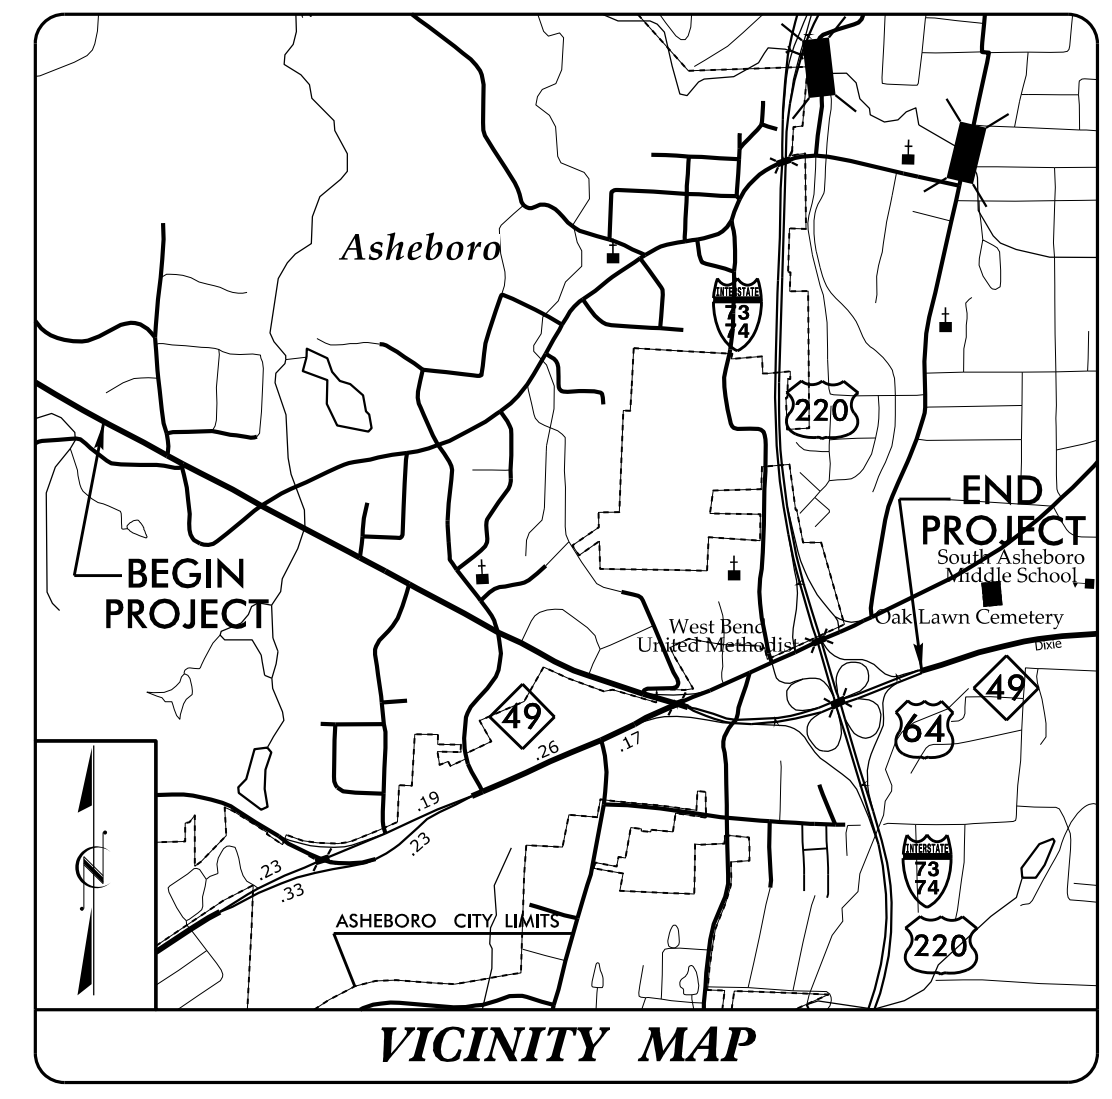

STATE OF NORTH CAROLINA
DIVISION OF HIGHWAYS


**CONDUIT & LIGHTING
RANDOLPH COUNTY**

**LOCATION: US 64 FROM ASHEBORO BYPASS TO
EAST OF I-73/I-74/US 220 TO ASHEBORO**


TYPE OF WORK: DUKE CONDUIT LAYOUT

T.I.P. NO.	SHEET NO.
U-5813	ECS-1

NOTE:
ALL UTILITY WORK SHOWN ON THIS SHEET WILL BE DONE BY OTHERS. NO PAYMENT WILL BE MADE TO THE CONTRACTOR FOR UTILITY WORK SHOWN ON THIS SHEET.

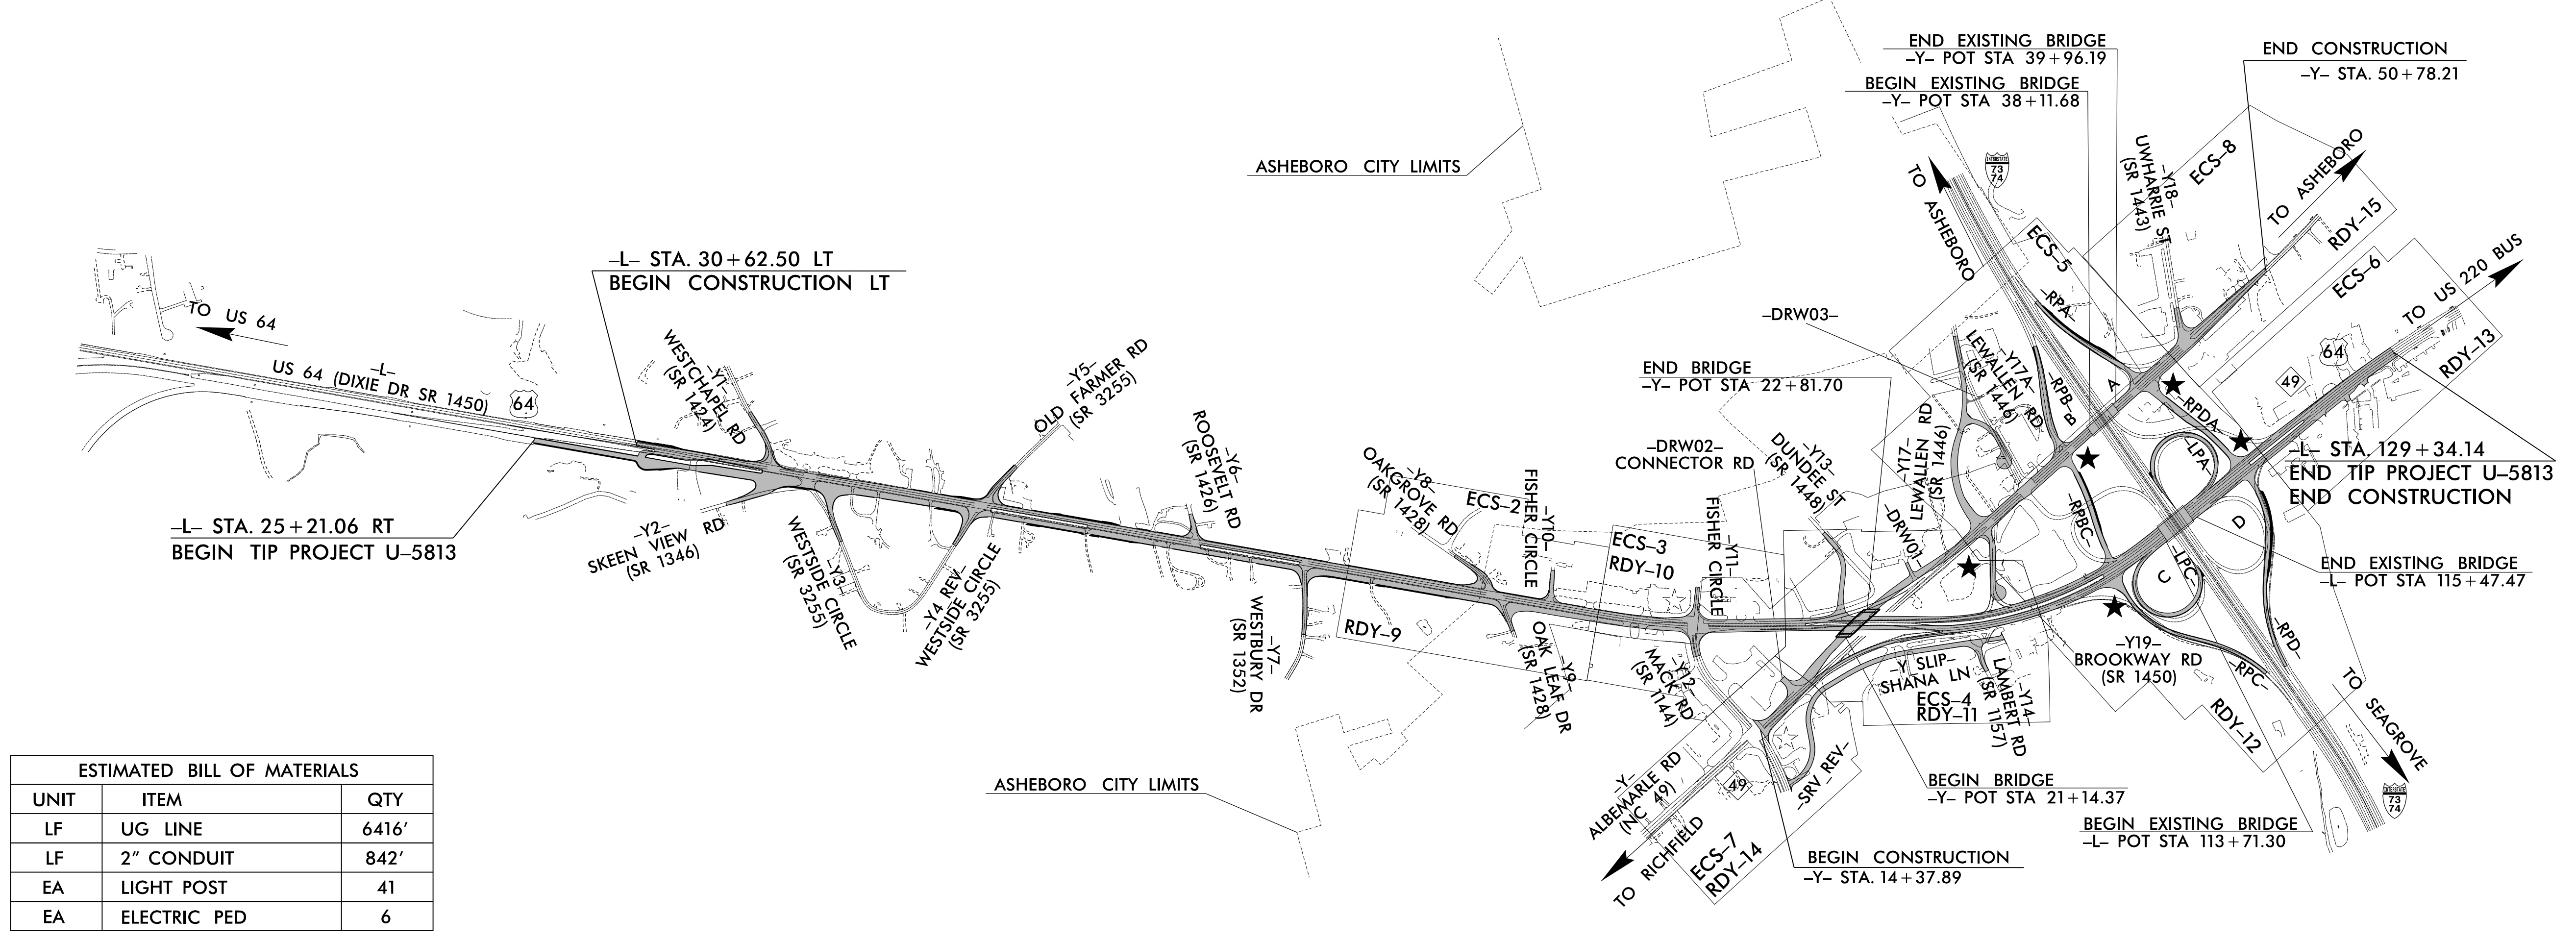

UNIT	ITEM	QTY
LF	UG LINE	6416'
LF	2" CONDUIT	842'
EA	LIGHT POST	41
EA	ELECTRIC PED	6

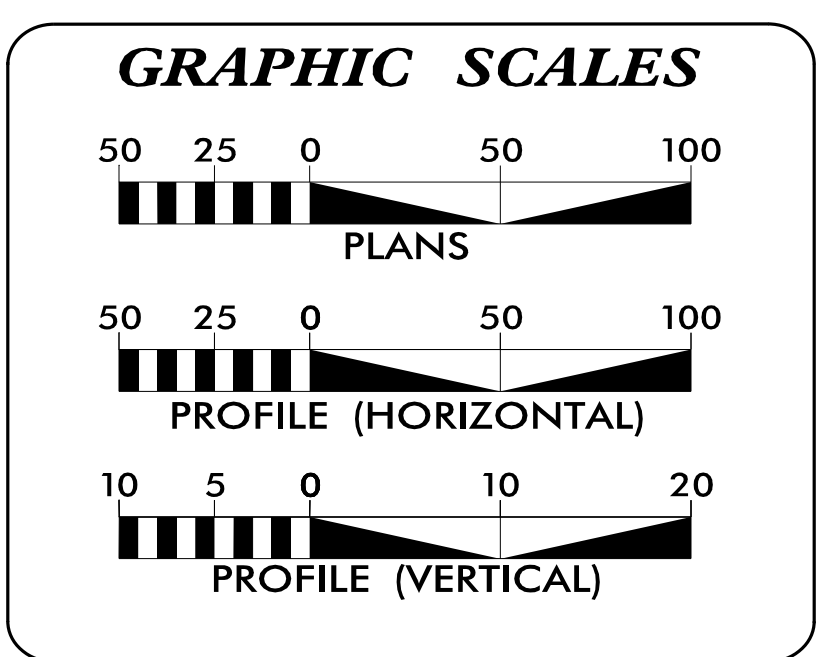

SHEET NO.:	DESCRIPTION:
ECS-1	TITLE SHEET
ECS-2 THRU ECS-8	LIGHTING PLAN SHEETS

(A) POWER - DUKE ENERGY
(B) POWER - RANDOLPH EMC
(C) LIGHTING - CITY OF ASHEBORO

PREPARED IN THE OFFICE OF:

Weston & Sampson
WSE of North Carolina, PC
2052 Energy Drive
Phone: 919.297.0220

NC License: C-4647
Apex, NC 27502
westonandsampson.com

JIM FORBES UTILITY PROJECT MANAGER
D. VONDENHUEVEL PROJECT UTILITY COORDINATOR

**DIVISION OF HIGHWAYS
DIVISION 8**
121 DOT DRIVE
CARTHAGE, NC 28327
PHONE (910) 773-8000
FAX (910) 947-3873

REUBEN BLAKLEY, PE DIVISION CONSTRUCTION ENGR
TRAVIS L. MORGAN, PE DIVISION UTILITY ENGINEER
JAMIE YOW DIVISION UTILITY COORDINATOR