


09/08/99
 5/10/2024
 U-5757_Signals_tsh.dgn
 USER:deFault

TIP PROJECT: U-5757

CONTRACT: C204941

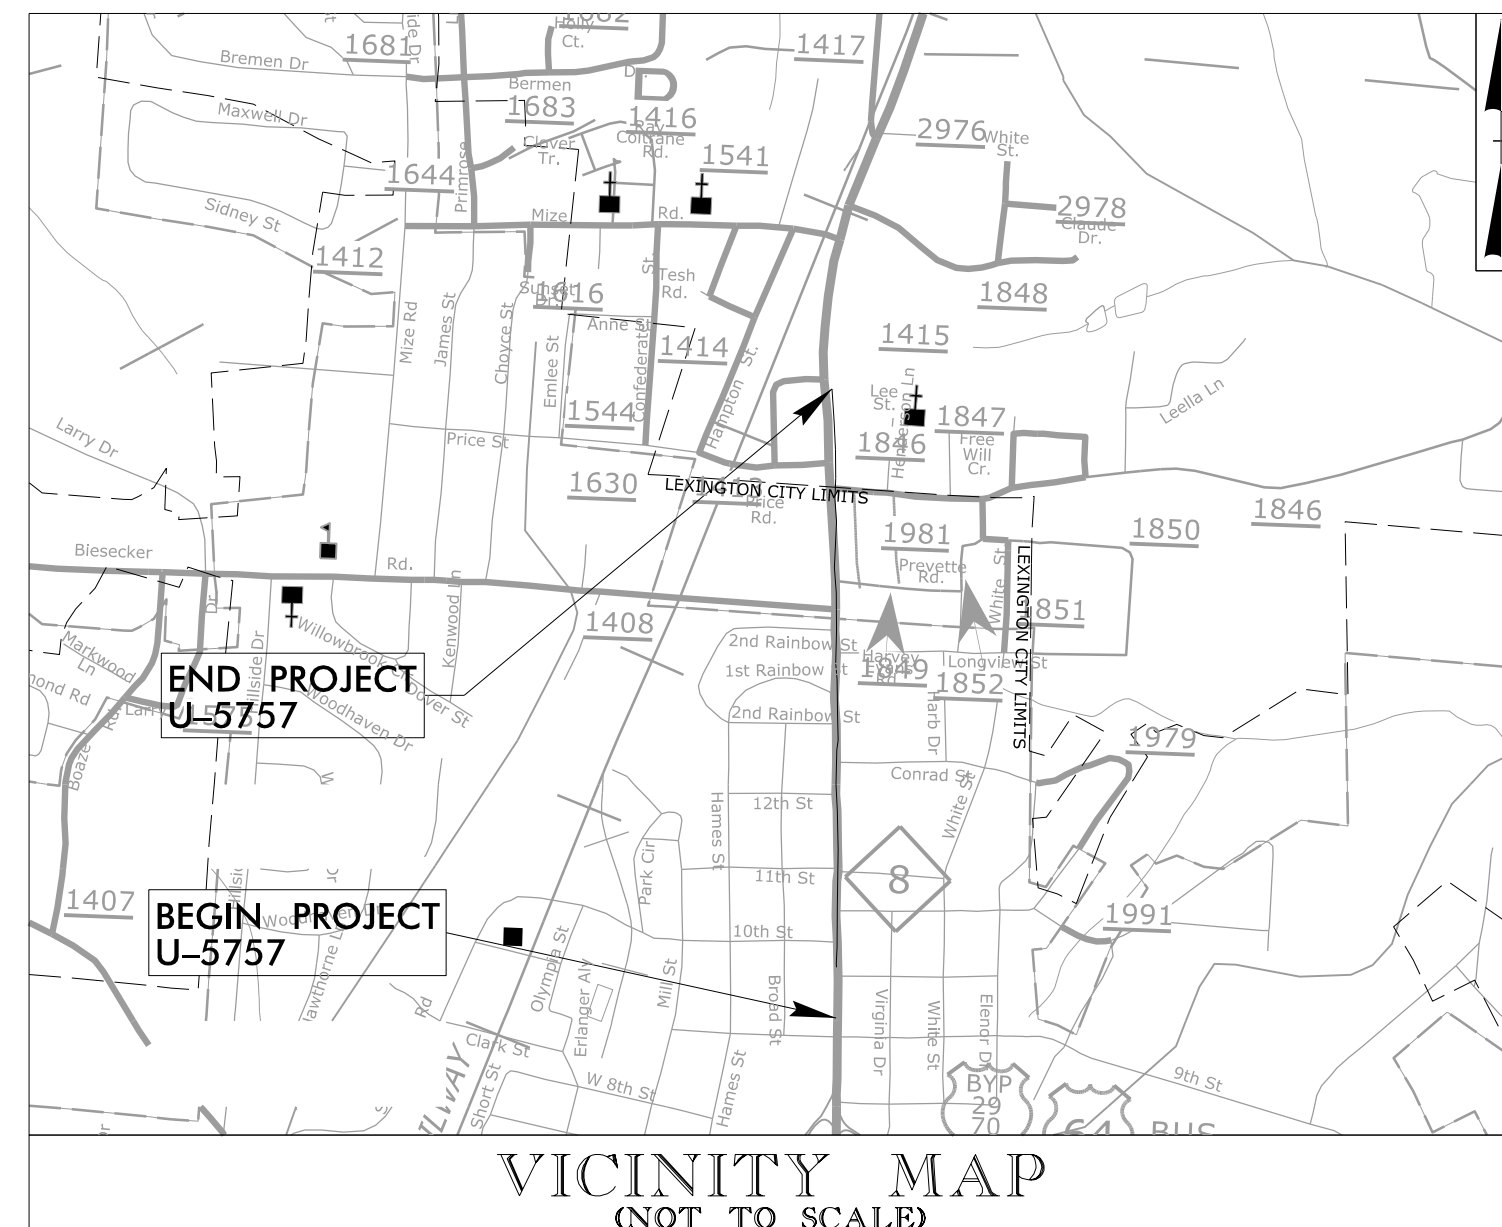


STATE OF NORTH CAROLINA
DIVISION OF HIGHWAYS

DAVIDSON COUNTY

LOCATION: NC 8 (WINSTON ROAD) FROM US 29/US 70 TO SR 1846 (ARRINGTON DRIVE) IN LEXINGTON

TYPE OF WORK: TRAFFIC SIGNALS

Project No.	Sheet No.
U-5757	Sig. 1.0

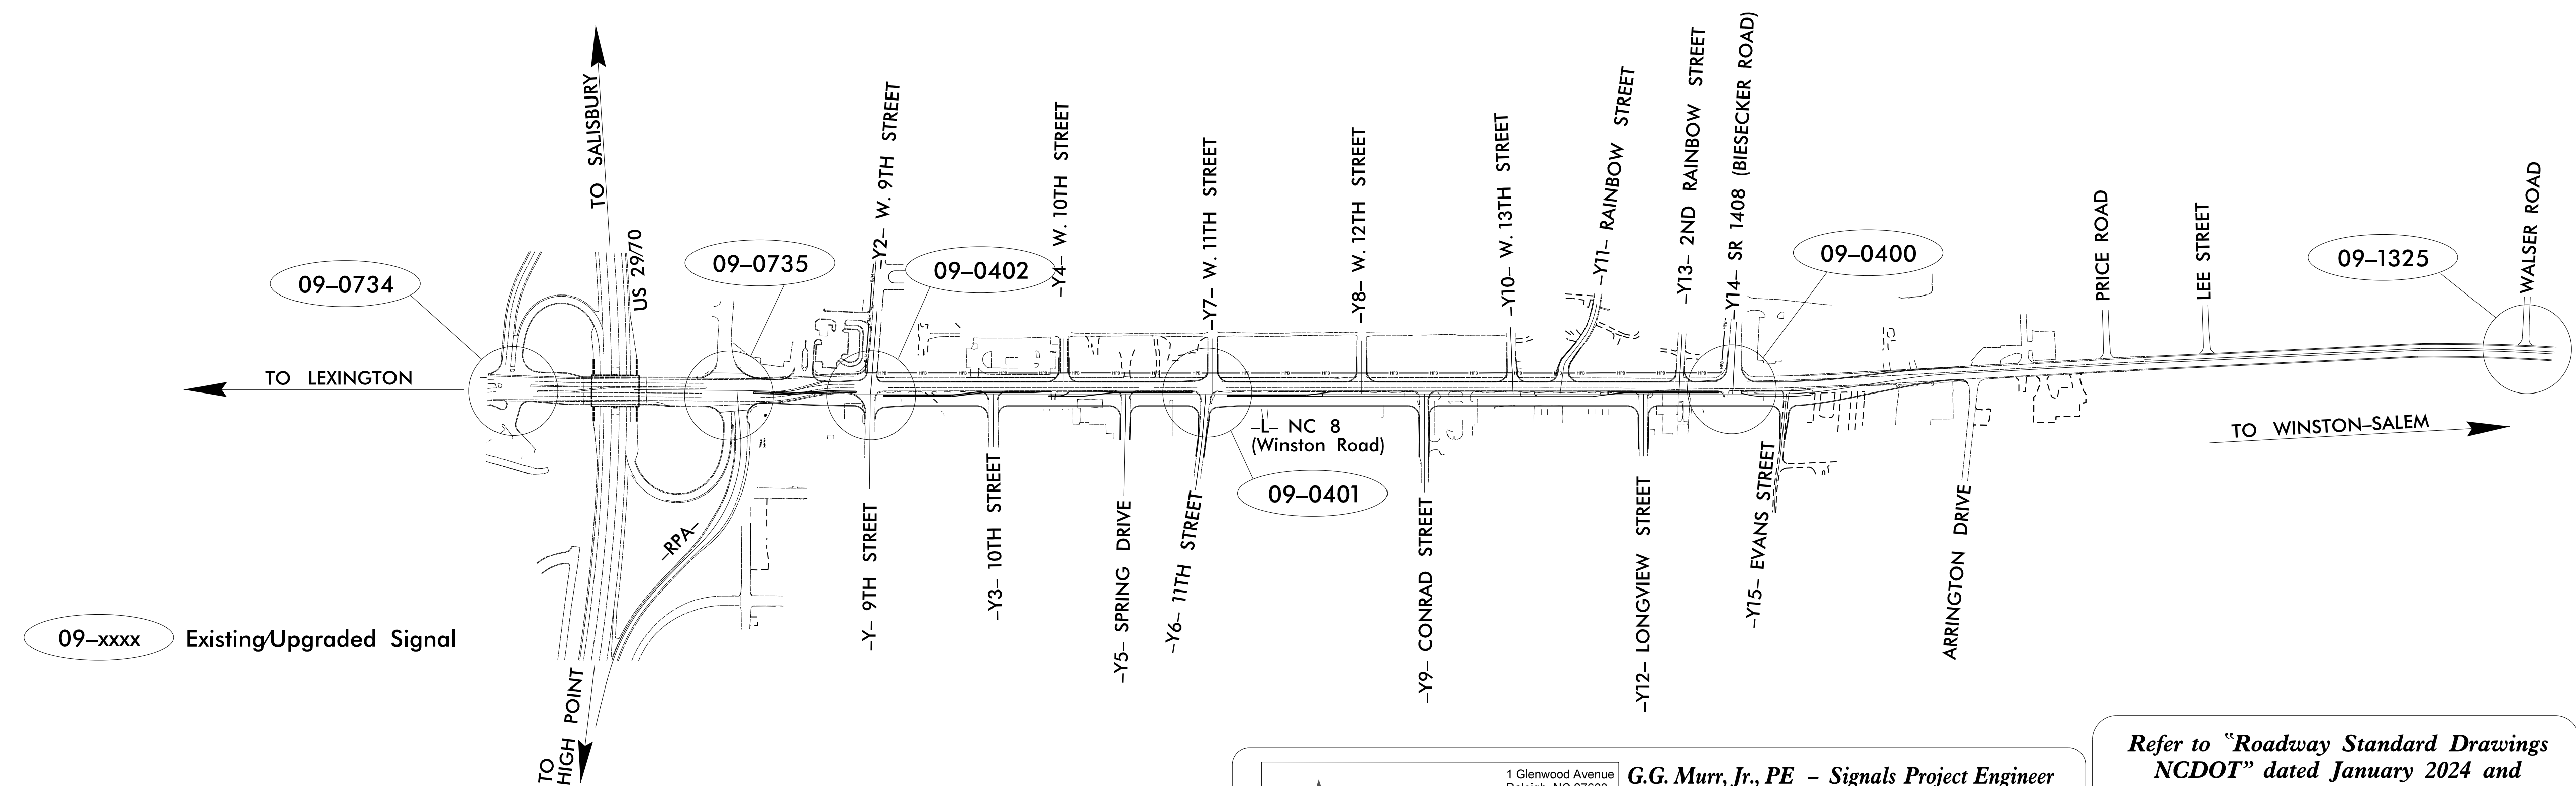

INDEX OF PLANS		
SHEET NUMBER	SIGNAL INV. NUMBER	LOCATION /DESCRIPTION
Sig. 1.0	-	Title Sheet
Sig. 2.0 - Sig. 2.1	09-0734	NC 8 (Winston Rd) at US 29 NB/US 64-70 EB Ramp
Sig. 3.0 - Sig. 5.2	09-0735	NC 8 (Winston Rd) at US 29 SB/US 64-70 WB Ramp
Sig. 6.0 - Sig. 8.4	09-0402	NC 8 (Winston Rd) at 9th Street
Sig. 9.0 - Sig. 11.4	09-0401	NC 8 (Winston Rd) at 11th Street
Sig. 12.0 - Sig. 14.5	09-0400	NC 8 (Winston Rd) at SR 1408 (Biesecker Rd)
Sig. 15.0 - Sig. 15.2	09-1325	NC 8 (Winston Rd) at SR 1412 (Walser Rd)
MIA - M9	-	NCDOT 2024 Metal Pole Standard Drawing Sheets
SCP1 - SCP4	-	Signal Communications Plans

TRANSYSTEMS
 1 Glenwood Avenue
 Raleigh, NC 27603
 Tel: 919.789.9977
 Fax: 919.789.9591
 License: F-0453

G.G. Murr, Jr., PE - Signals Project Engineer
J.T. Rowe, Jr. PE - Electrical Engineer
B.E. Wynn, PE - Signals Design Engineer

TRANSPORTATION SYSTEMS MANAGEMENT & OPERATIONS UNIT

Contacts:

Robert J. Ziemba, P.E. - Central Region Signals Engineer
Keith M. Mims, P.E. - State Signal Equipment Engineer
Gregg Green - Signal Communications Project Engineer
Heidi Berggren, EI - Signal Communications Design Engineer

Refer to "Roadway Standard Drawings NCDOT" dated January 2024 and Standard Specifications for Roads and Structures" dated January 2024

Prepared for the Office of:
 DIVISION OF HIGHWAYS
 TRANSPORTATION MOBILITY AND SAFETY DIVISION
 Transportation Systems Management & Operations Unit

