
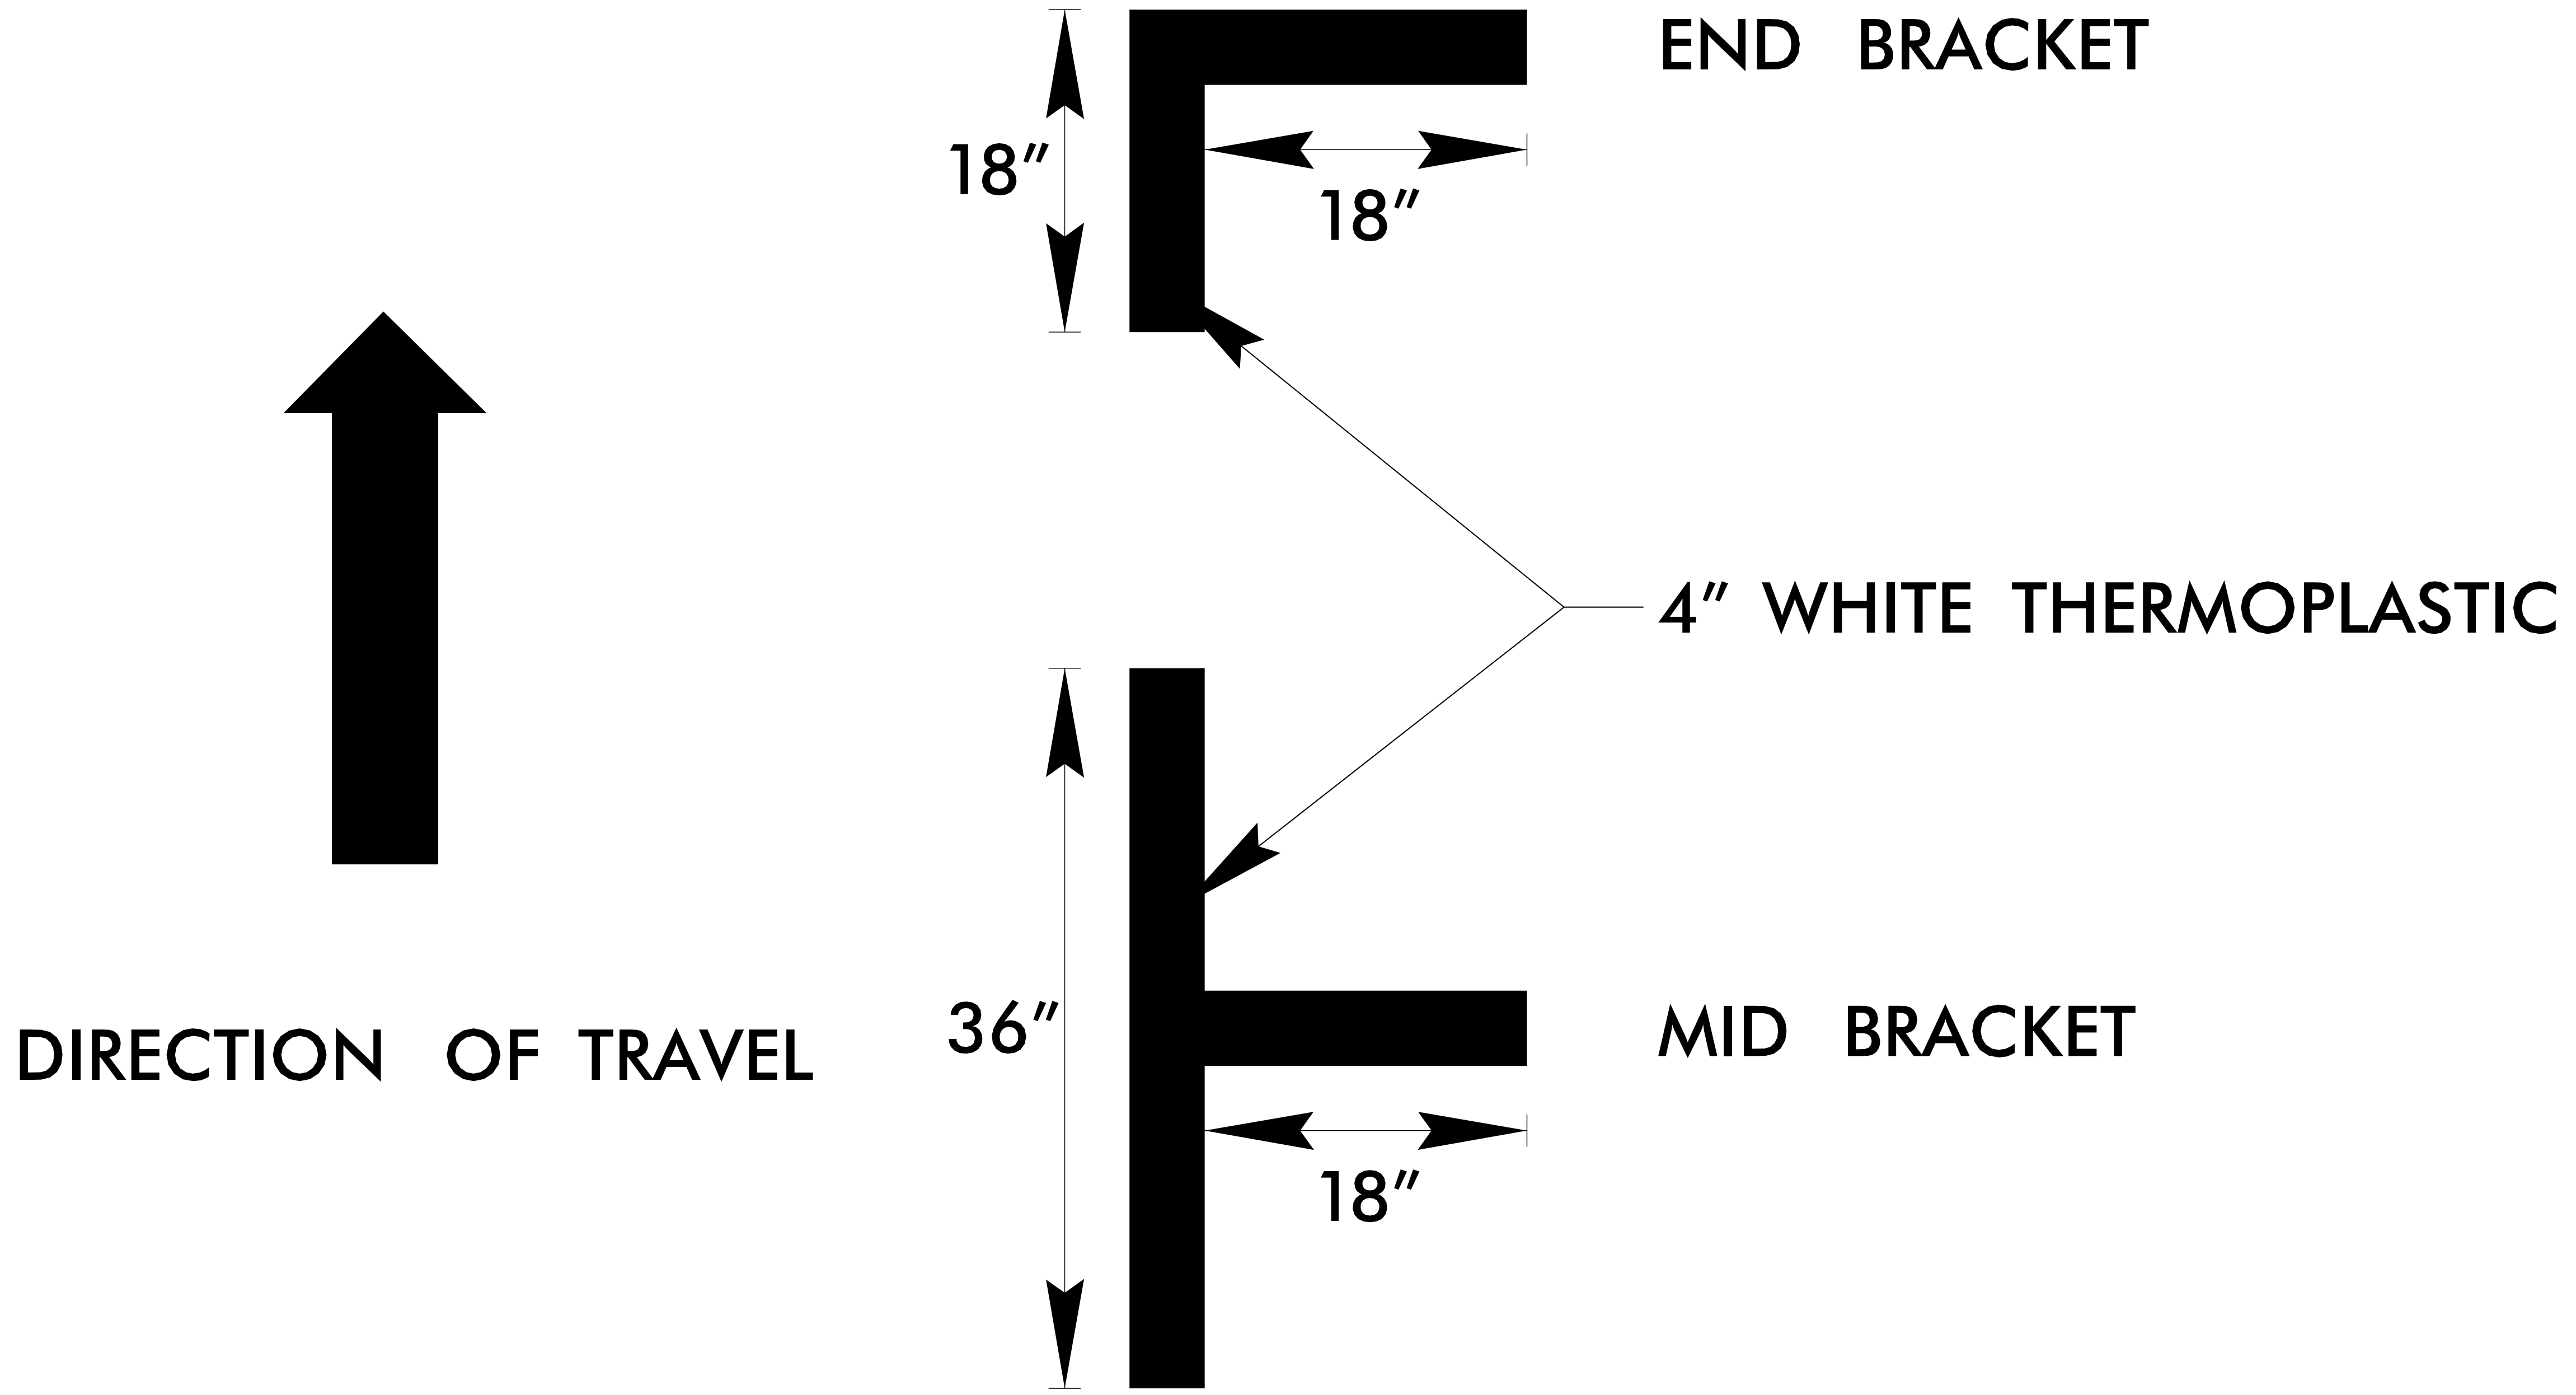


TIP NO. HL-0003	SHEET NO. PMP-1A
APPROVED: <i>William C. Carver</i> 103525AB519349F	
DATE: 07/30/2024	
SEAL	
	
DOCUMENT NOT CONSIDERED FINAL UNLESS ALL SIGNATURES COMPLETED	

# ON-STREET PARALLEL PARKING SPACE TYPICAL BRACKET STRIPING DETAIL



29-JUL-2024 16:12  
 S:\DDC\Projects\Buncombe\SR 3548 Haywood Road\Traffic\Haywood Rd.DDC.tsh.pmp.dgn  
 \$\$\$USERNAME\$\$\$