
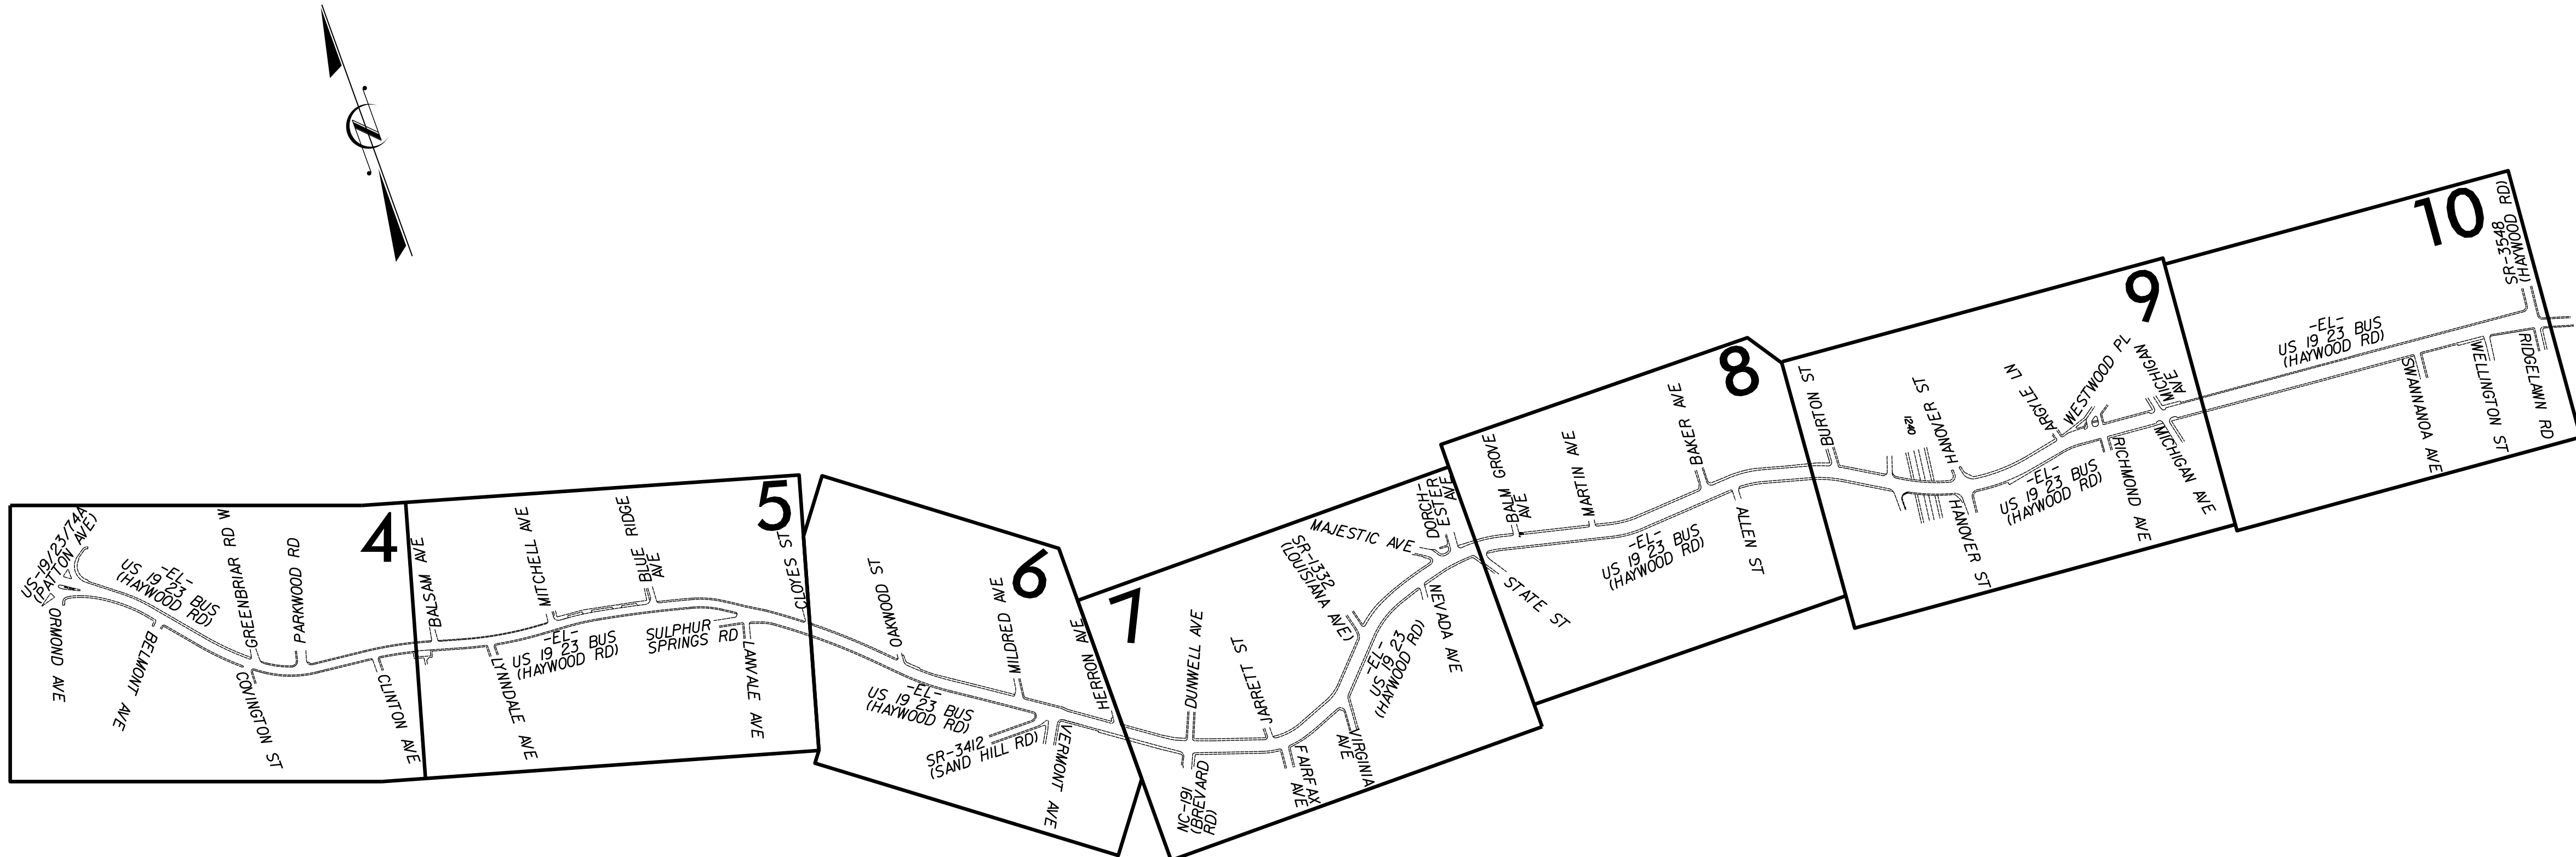


30-JUL-2024 11:11
S:\DDC\Projects\Buncombe\SR 3548 Haywood Road\Traffic\Signing\CADD\Haywood Rd.DDC_sign3.dgn
\$\$\$\$USERNAME\$\$\$

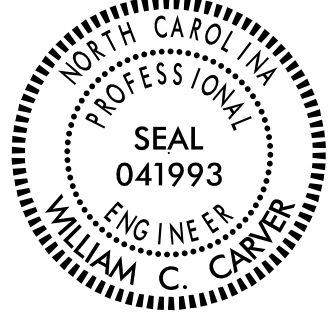

TIP NO.	SHEET NO.
HL-0003	SIGN-3
DocuSigned by: <i>William C. Carver</i> 163525A8519349F	
APPROVED:	
DATE: 07/30/2024	
SEAL	
	
DOCUMENT NOT CONSIDERED FINAL UNLESS ALL SIGNATURES COMPLETED	

KEY SHEET