


STATE OF NORTH CAROLINA  
DIVISION OF HIGHWAYS


**CUMBERLAND COUNTY**

**LOCATION: SR 1003 (CAMDEN ROAD) FROM FUTURE I-295 (FAYETTEVILLE OUTER LOOP) TO APPROX. 0.3 MILES WEST OF SR 1112 (ROCKFISH ROAD)**

**TYPE OF WORK: TRAFFIC SIGNALS AND SIGNAL COMMUNICATIONS**

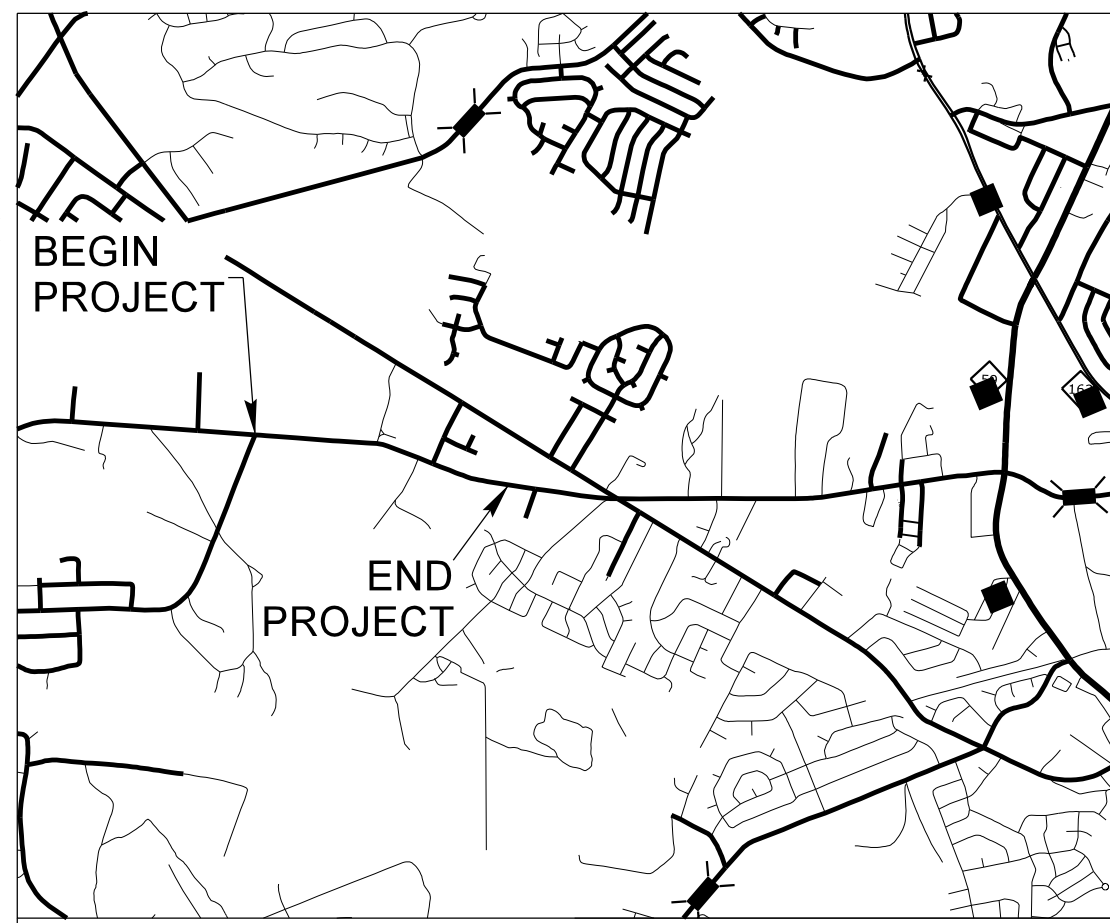


VICINITY MAP

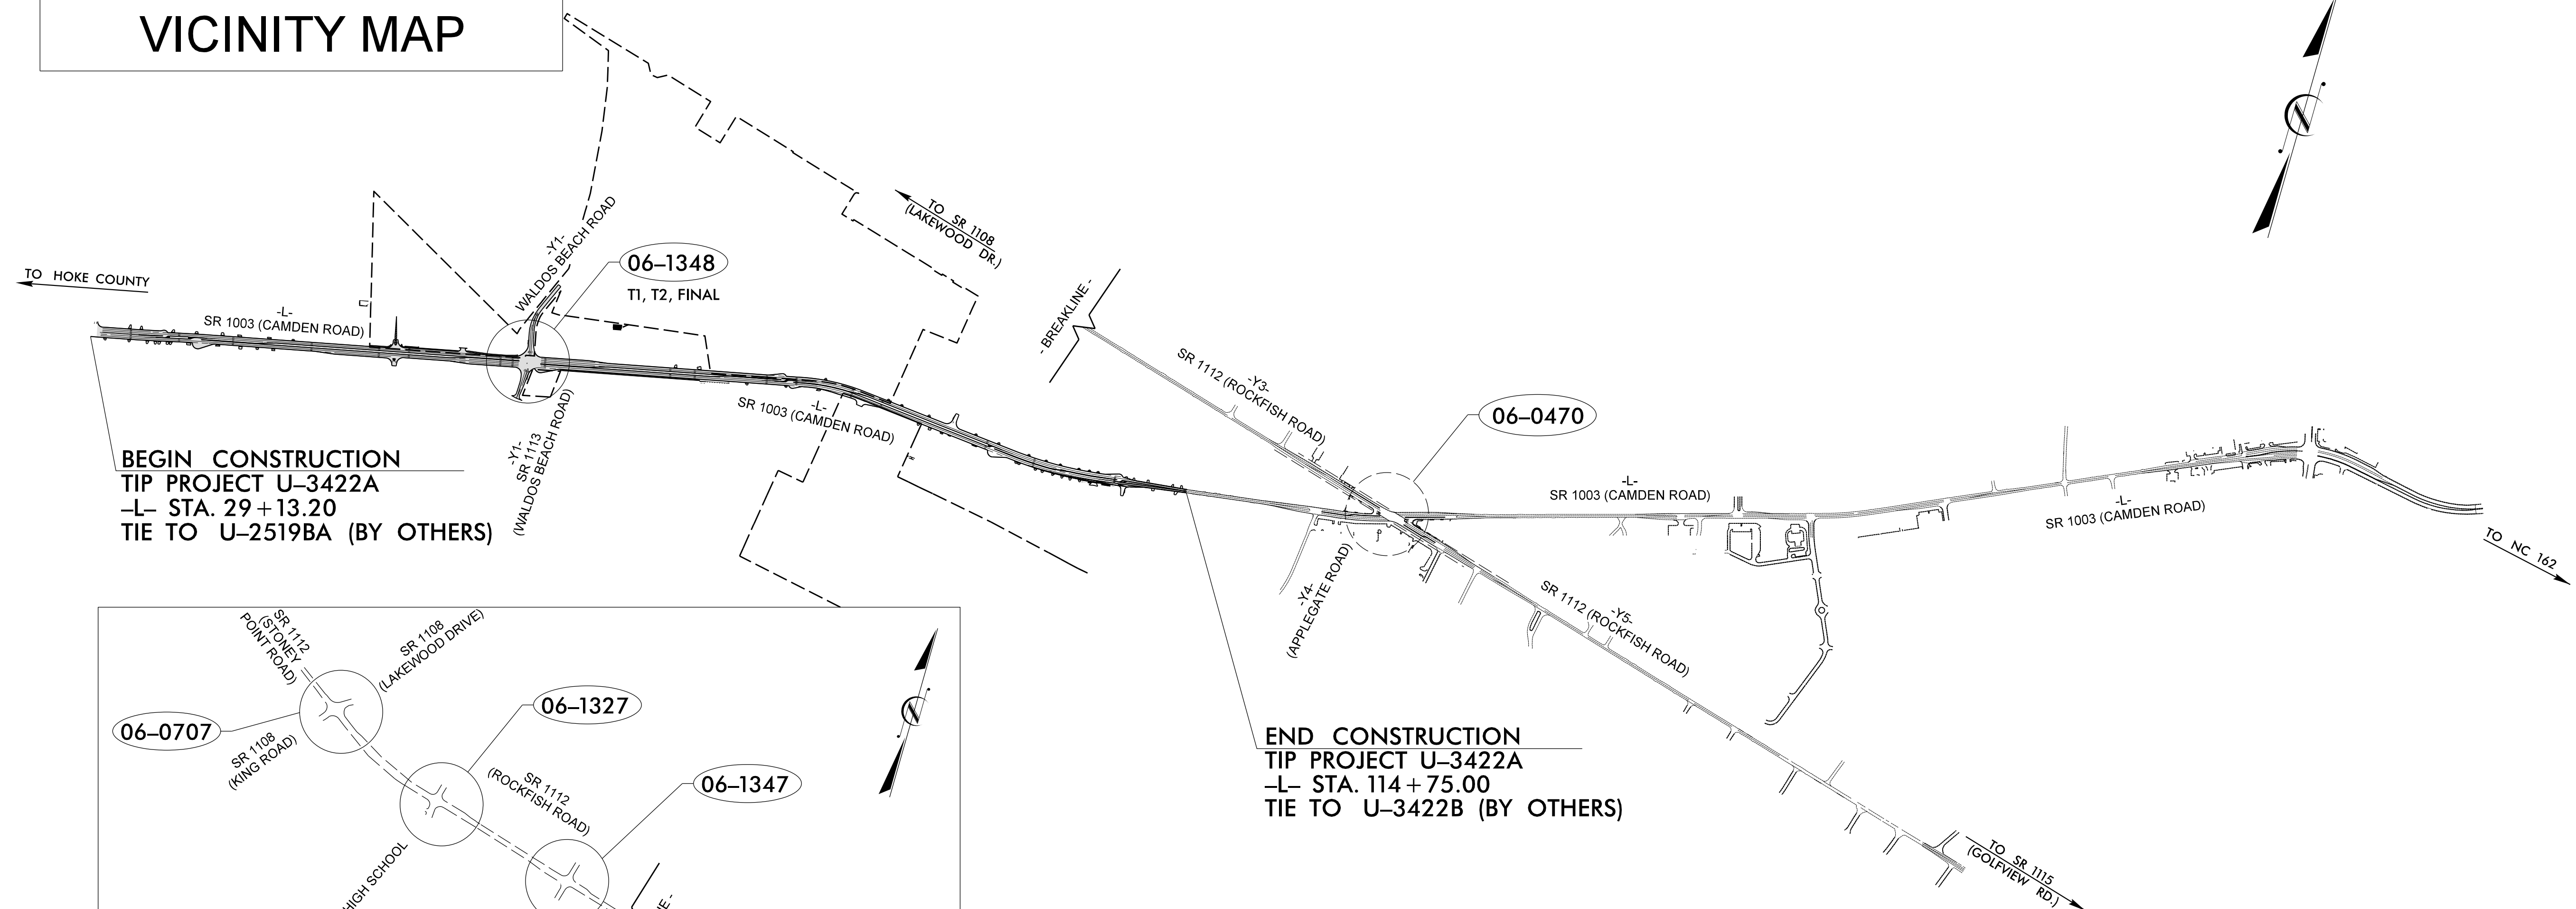

**BEGIN CONSTRUCTION**  
TIP PROJECT U-3422A  
-L- STA. 29+13.20  
TIE TO U-2519BA (BY OTHERS)

**END CONSTRUCTION**  
TIP PROJECT U-3422A  
-L- STA. 114+75.00  
TIE TO U-3422B (BY OTHERS)

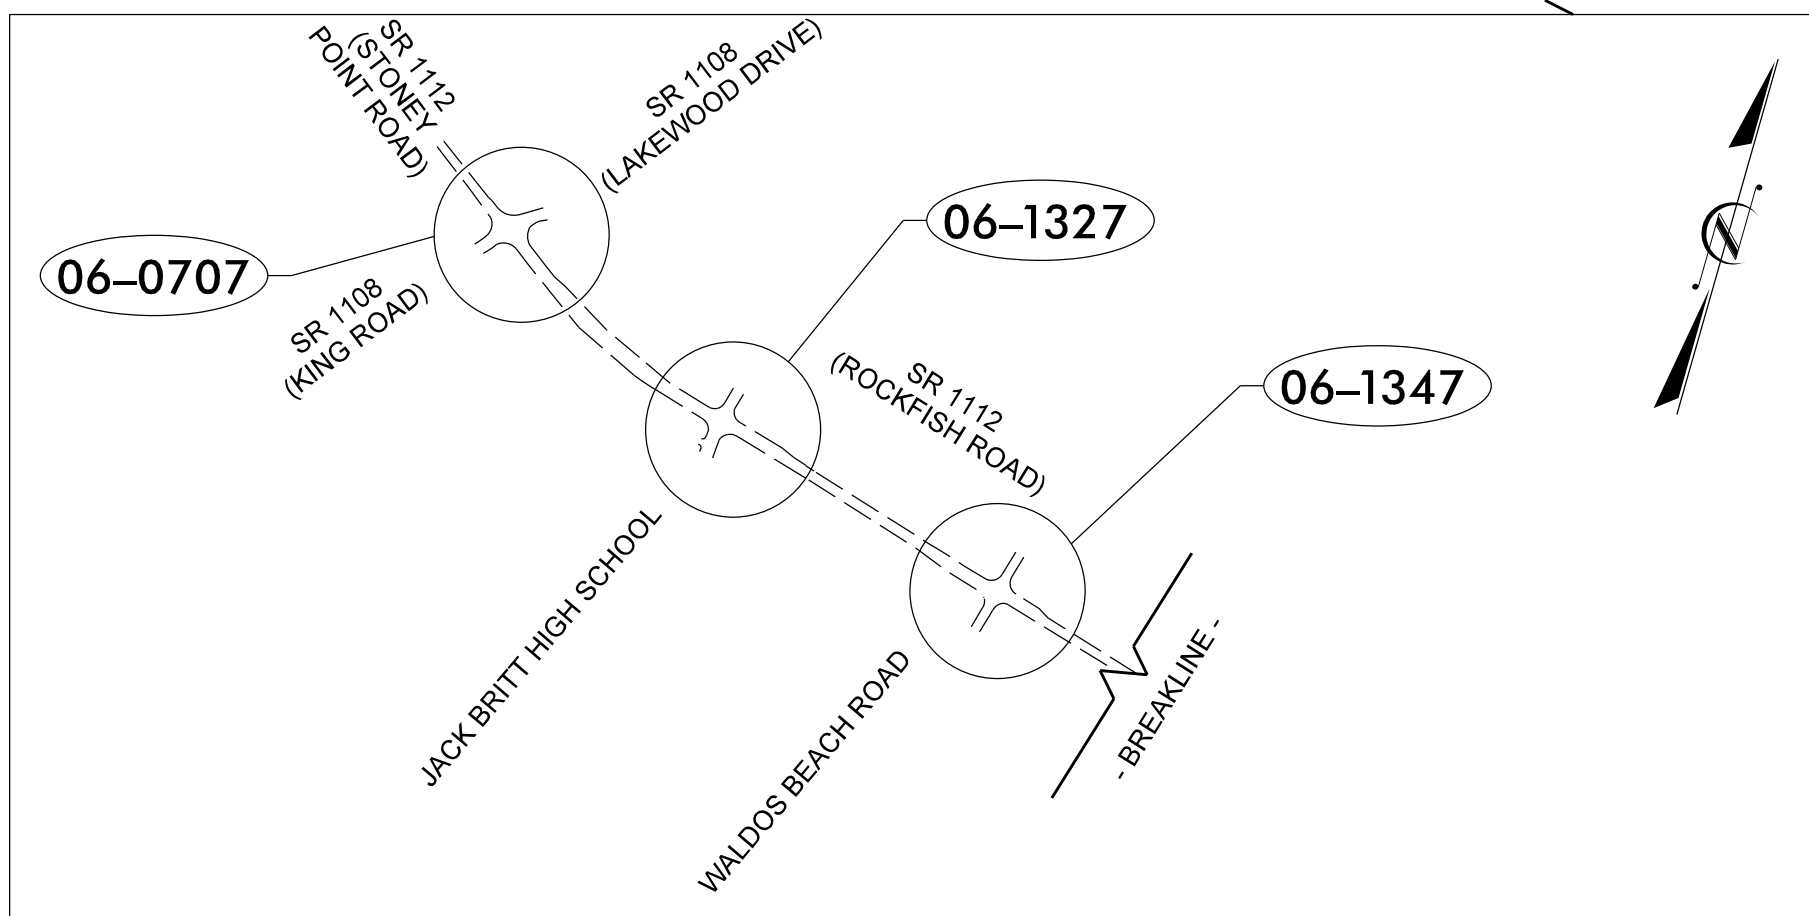

**TIP PROJECT: U-3422A**

PROJECT REFERENCE NO. U-3422A	SHEET NO. Sig 1.0
APPROVED: <i>Lisa Moon</i>	
DATE: 10/3/2024	
SEAL	
DOCUMENT NOT CONSIDERED FINAL UNLESS ALL SIGNATURES COMPLETED	


**PLANS PREPARED BY:**

*Lisa M. Moon, P.E. – Project Manager*  
*Darren J. White – Project Engineer*

**INDEX OF PLANS**

Sheet Number	SIN	Location/Description
Sig. 1.0	-	Project Title Sheet
Sig. 2.0-2.2	06-1348T1	SR 1003 (Camden Road) at SR 1113 (Waldos Beach Road)/Waldos Beach Road - T1
Sig. 3.0-3.4	06-1348T2	SR 1003 (Camden Road) at SR 1113 (Waldos Beach Road)/Waldos Beach Road - T2
Sig. 4.0-4.4	06-1348	SR 1003 (Camden Road) at SR 1113 (Waldos Beach Road)/Waldos Beach Road - Final
Sig. 5.0-5.2	06-0707	SR 1112 (Stoney Point Road/Rockfish Road) at SR 1108 (Lakewood Drive /King Road)
Sig. 6.0-6.2	06-1327	SR 1112 (Rockfish Road) at Jack Britt High School/Traemoor Village Drive
Sig. 7.0-7.2	06-1347	SR 1112 (Rockfish Road) at Waldos Beach Road /Town Center Drive
Sig. 8.0-8.2	06-0470	SR 1112 (Rockfish Road) at SR 1003 (Camden Road)
Sig. M1-M8	-	Standard Metal Pole Drawings
SCP1-SCP11	-	Signal Communication Plans

DIVISION OF HIGHWAYS

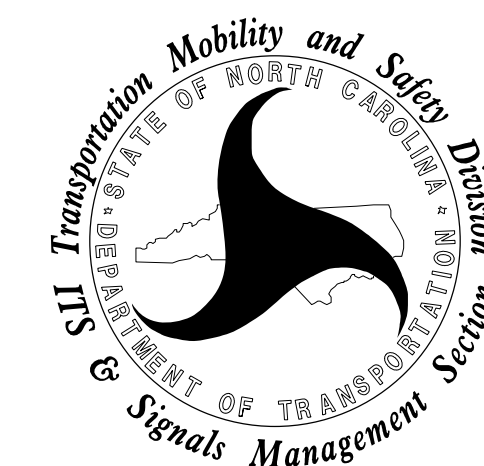

750 N. Greenfield Pkwy, Garner, NC 27529

**LEGEND**

XX-XXXX TRAFFIC SIGNAL

**TRANSPORTATION SYSTEMS  
MANAGEMENT & OPERATIONS**

*Zachary Little, P.E. – Eastern Region Signals Engineer*  
*D. Todd Joyce, P.E. – Signal Equipment Design Review Engineer*  
*Gregory A. Green – Signal Communications Project Engineer*

Refer to "Roadway Standard Drawings  
NCDOT" dated January 2024 and  
"Standard Specifications for Roads  
and Structures" dated January 2024.

Plans Prepared By:

DRMP, Inc.  
8210 University Executive Park Drive, Suite 220  
Charlotte, NC 28262  
NC License No. F-1524 (704) 332-2289  
www.DRMP.com