


09\_08/24

TIP PROJECT: BR-0086

T.I.P. NO.	SHEET NO.
BR-0086	UC-1

FINAL DESIGN NOT FOR CONSTRUCTION

DOCUMENT NOT CONSIDERED FINAL UNLESS ALL SIGNATURES COMPLETED

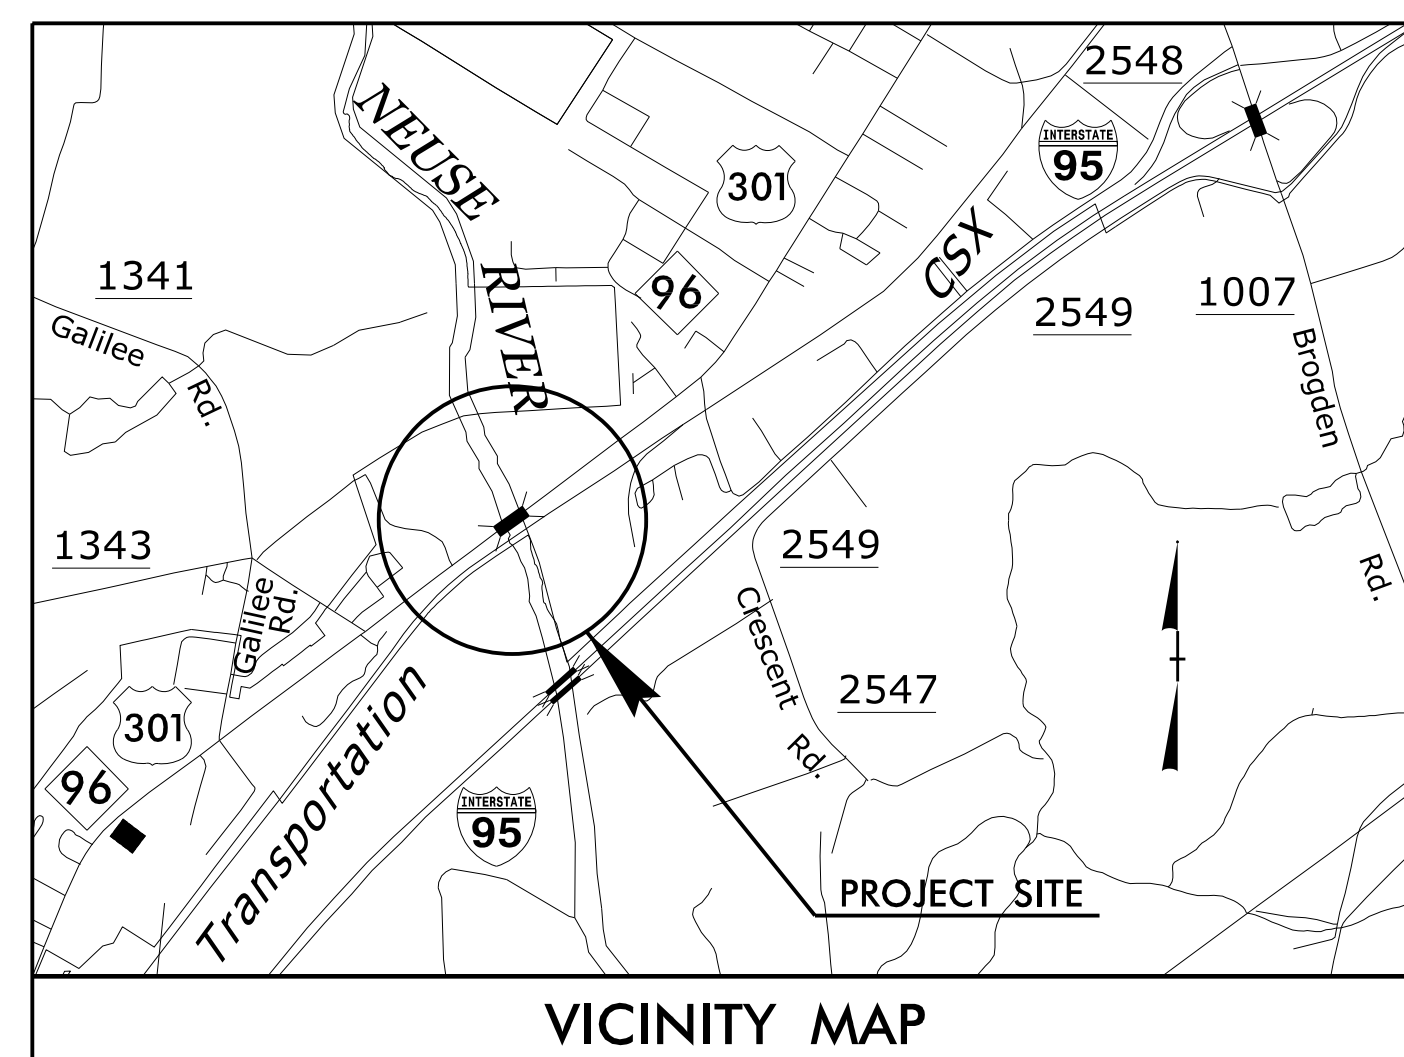


STATE OF NORTH CAROLINA  
DIVISION OF HIGHWAYS


# UTILITY CONSTRUCTION PLANS JOHNSTON COUNTY

LOCATION: REPLACE BRIDGE NO.50070 ON US 301 OVER NEUSE RIVER

TYPE OF WORK: WATER AND SEWER RELOCATIONS

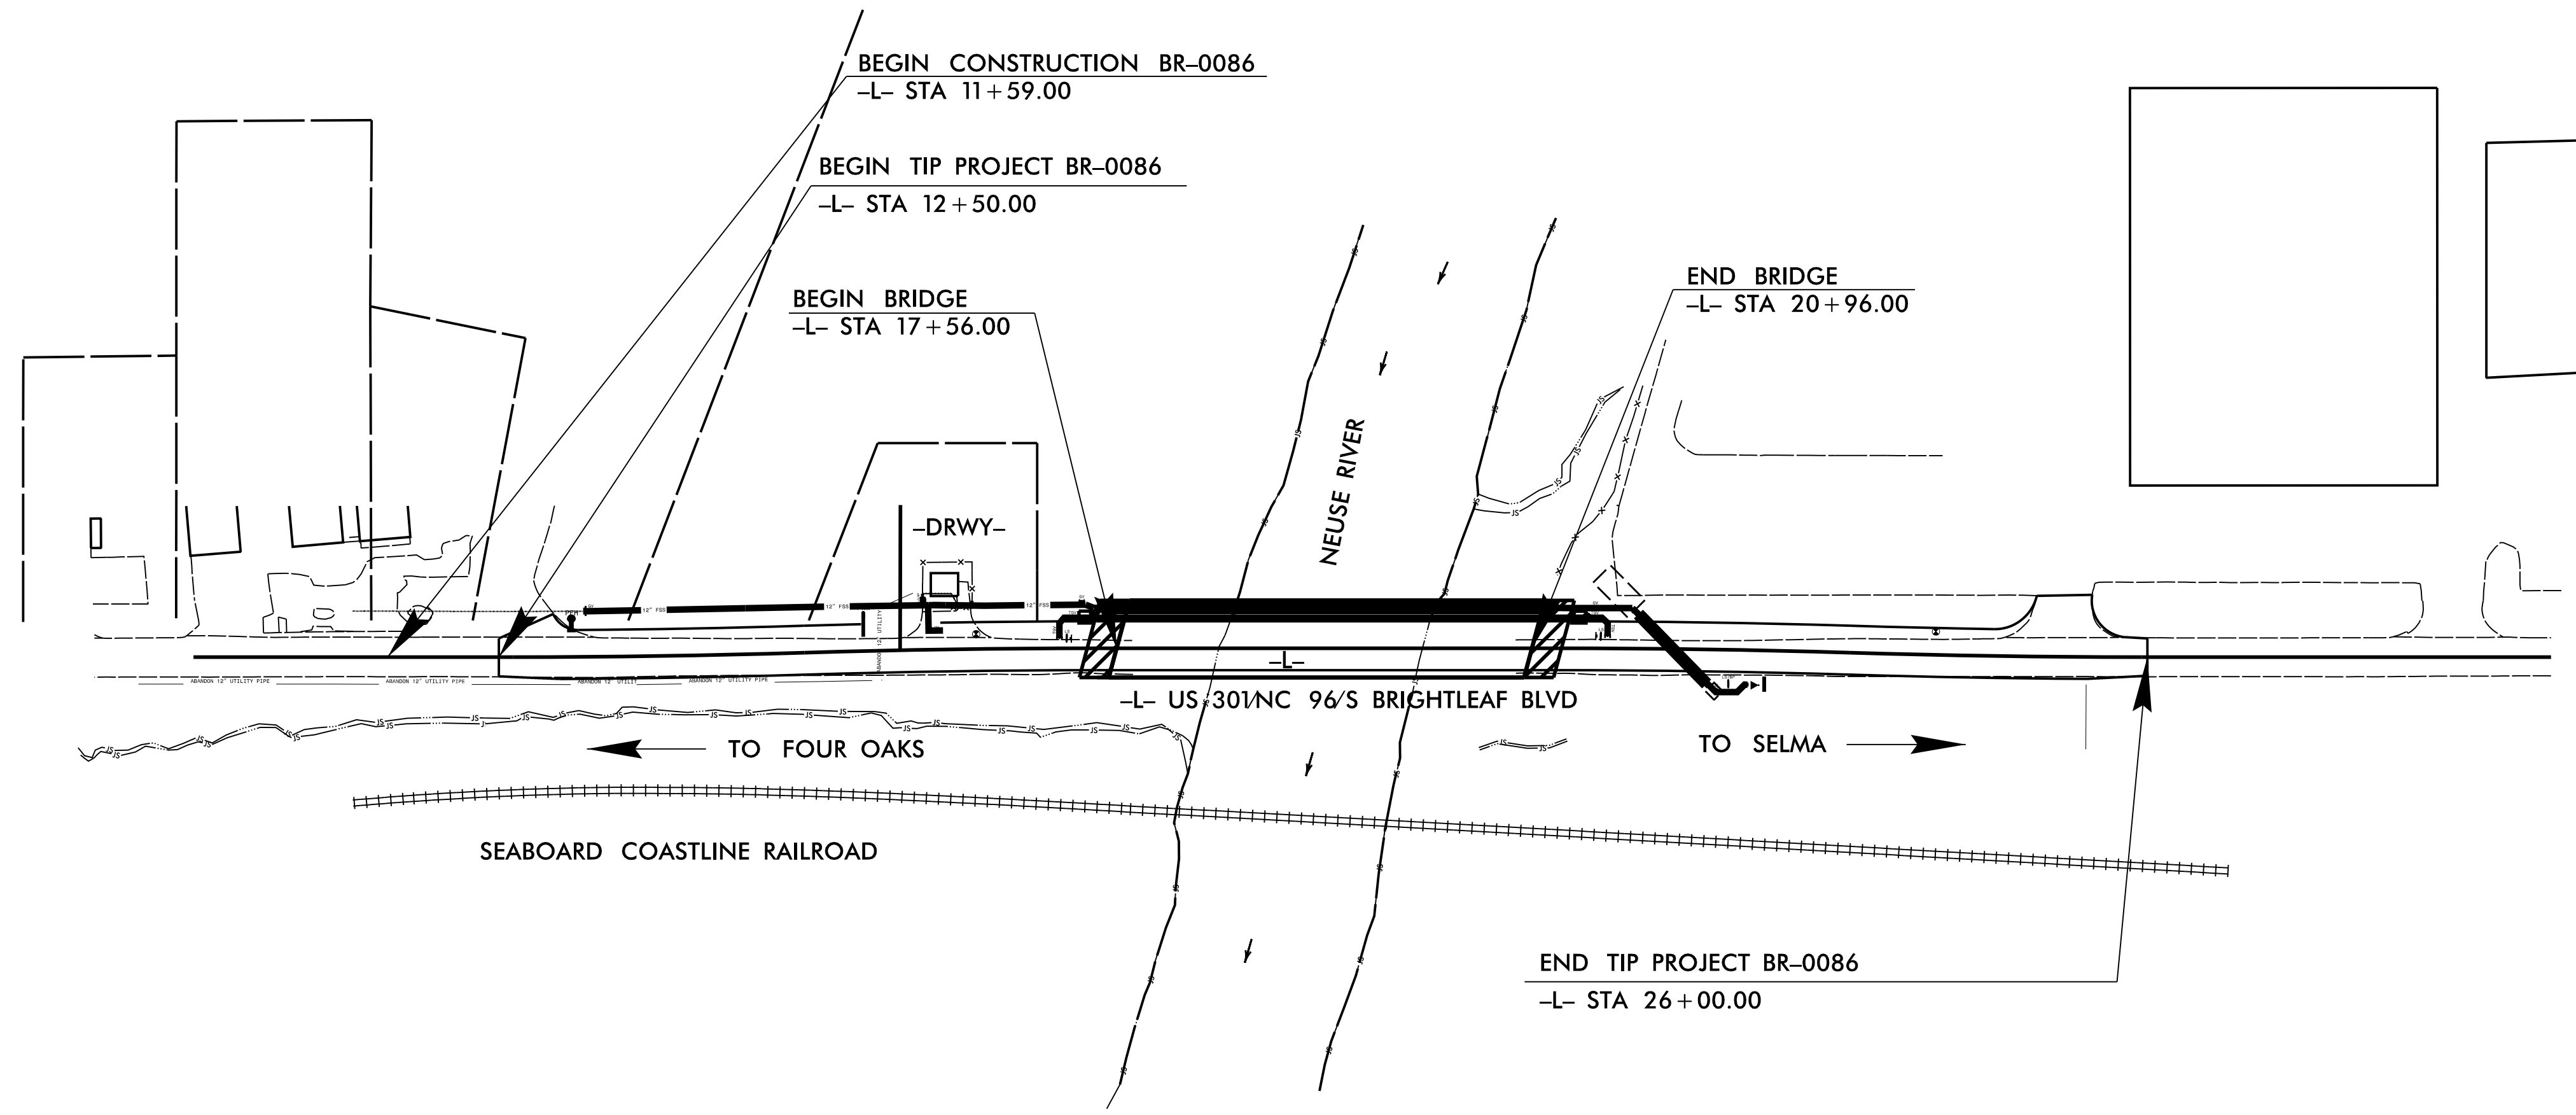

THIS PROJECT HAS NO CONTROLLED ACCESS  
THIS PROJECT IS WITHIN THE MUNICIPAL BOUNDARIES OF THE TOWN OF SMITHFIELD  
CLEARING ON THIS PROJECT SHALL BE PERFORMED TO THE LIMITS ESTABLISHED BY METHOD III

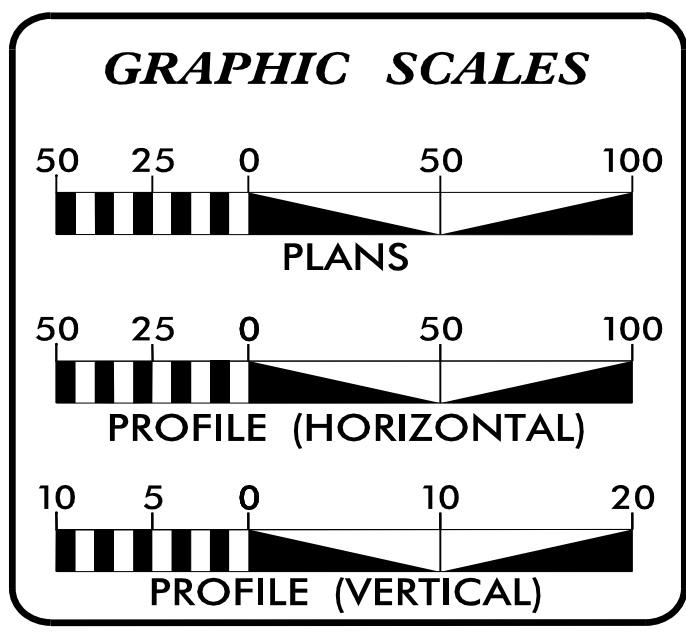

**INDEX OF SHEETS**

SHEET NO.:	DESCRIPTION:
UC-1	COVER SHEET
UC-2	UTILITY SYMBOLOGY
UC-3	UTILITY NOTES
UC-3A THRU UC-3G	UTILITY DETAILS
UC-4A THRU UC-4B	UTILITY CONSTRUCTION PLAN AND PROFILE

**WATER AND SEWER OWNERS ON PROJECT**

(A) WATER - JOHNSTON COUNTY  
(B) SANITARY SEWER - JOHNSTON COUNTY

PREPARED IN THE OFFICE OF

**HDR** HDR Engineering, Inc. of the Carolinas  
555 Fayetteville St. Suite 900 Raleigh, N.C. 27601  
N.C.B.E.L.S. License Number: F-0116

**STEPHANIE HOLLOMAN, PE** UTILITY PROJECT MANAGER  
**KATIE ROUGEOT** PROJECT UTILITY DESIGNER

SEAL

Stephanie Holloman  
NORTH CAROLINA PROFESSIONAL ENGINEER  
STEPHANIE M. HOLLOMAN  
SEAL 040783  
11/21/2024

**DIVISION OF HIGHWAYS UTILITIES UNIT**  
1555 MAIL SERVICES CENTER  
RALEIGH, NC 27699-1555  
PHONE (919) 707-6690  
FAX (919) 250-4151

**NABIL HAMDAN** UTILITIES REGIONAL ENGINEER  
**TEVIN ASAMOAH** UTILITIES ENGINEER  
**TANGA SAMPSON** UTILITIES AREA COORDINATOR  
**TYRON STALLINGS** UTILITIES COORDINATOR

11/21/2024  
S:\BR0086\_ut\_tsh\_LUC01.psh.dgn  
9:30:02 AM