

STATE OF NORTH CAROLINA
DIVISION OF HIGHWAYS

SIGNING PLANS
BUNCOMBE COUNTY

LOCATION: US 19 /23 BUSINESS (HAYWOOD ROAD)
FROM US 19/23/74 (PATTON AVE.) TO RIDGELAWN RD.
TYPE OF WORK: DRAINAGE, PAVING, AND SIGNALS

INDEX OF SHEETS

SHEET NO.	TITLE
SIGN-1	SIGNING PLAN TITLE SHEET
SIGN-2	TYPE "E"
SIGN-3	KEY SHEET
SIGN-4	SIGNING PLAN
SIGN-5	SIGNING PLAN
SIGN-6	SIGNING PLAN
SIGN-7	SIGNING PLAN
SIGN-8	SIGNING PLAN
SIGN-9	SIGNING PLAN
SIGN-10	SIGNING PLAN

ROADWAY STANDARD DRAWINGS

THE FOLLOWING ROADWAY STANDARDS AS APPEAR IN "ROADWAY STANDARD DRAWINGS" - PROJECT SERVICES UNIT - N.C. DEPARTMENT OF TRANSPORTATION - RALEIGH, N.C., DATED JANUARY 2024 ARE APPLICABLE TO THIS PROJECT AND BY REFERENCE HEREBY ARE CONSIDERED A PART OF THESE PLANS:

STD. NO.	TITLE
904.10	ORIENTATION OF GROUND MOUNTED SIGNS
904.50	MOUNTING OF TYPE 'D', 'E' AND 'F' SIGNS ON 'U' CHANNEL POSTS

 
SUMMARY OF QUANTITIES



ITEM NO.		ITEM DESCRIPTION	QUANTITY	UNIT
DESC. NO.	SECT. NO.			
4025000000-E	901	CONTRACTOR FURNISHED, TYPE E SIGN	835	SF
4072000000-E	903	SUPPORTS, 3LB U-CHANNEL	555	LF
4102000000-N	904	SIGN ERECTION, TYPE E	256	EA
4155000000-N	907	DISPOSAL OF SIGN SYSTEM, U-CHANNEL	10	EA

TIP NO.	SHEET NO.
HL-0003	SIGN-1
APPROVED: DocuSigned by: William C. Carver 163525A8519348F...	
DATE: 07/30/2024	
SEAL	
Seal of William C. Carver, Professional Engineer, Seal 041993, State of North Carolina	
DOCUMENT NOT CONSIDERED FINAL UNLESS ALL SIGNATURES COMPLETED	

GENERAL NOTES

- SIGNS FURNISHED BY CONTRACTOR
- ALL TYPE 'E' SIGNS SHALL BE MOUNTED ON ONE U-CHANNEL POST UNLESS OTHERWISE INDICATED ON THE PLANS.
- WHEN NOT STATIONED OR DIMENSIONED ON PLANS, ALL 'E' AND 'F' SIGNS SHALL BE FIELD LOCATED BY THE ENGINEER.
- IF REMOVAL OR RELOCATION OF SIGNS ON PRIVATE STREET (NON-STATE MAINTAINED) IS REQUIRED DUE TO CONSTRUCTION, THE CONTRACTOR SHALL INFORM THE ENGINEER. THE WORK WILL BE COMPLETED BY OTHERS.
- WHEN EXISTING SIGNS ARE REMOVED AND INSTALLED ON NEW SUPPORTS, THE RE-ERECTION SHALL IMMEDIATELY FOLLOW THE REMOVAL
- THE BACKGROUND FOR TYPE E SIGNS SHALL BE TYPE C REFLECTIVE SHEETING.


TIP NO. HL-0003	SHEET NO. SIGN-2
DocuSigned by:  19325A8519349F	
APPROVED: _____ DATE: 07/30/2024 _____	
SEAL 	
DOCUMENT NOT CONSIDERED FINAL UNLESS ALL SIGNATURES COMPLETED	

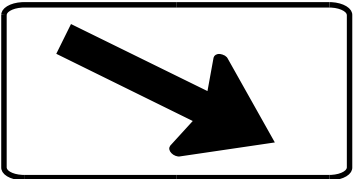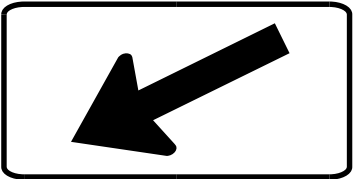QUANTITY REQ'D 84 401  W11-2 30" X 30"	QUANTITY REQ'D 60 405  R10-25 9" X 12"	QUANTITY REQ'D 2 409  W11-1 30" X 30"			
QUANTITY REQ'D 30 402  W16-7pR 21" X 15"	QUANTITY REQ'D 8 406  R3 - 17 24" X 18"	QUANTITY REQ'D 2 410  W16 - 1p 12" X 18"			
QUANTITY REQ'D 30 403  W16-7pR 21" X 15"	QUANTITY REQ'D 4 407  R3 - 17aP 24" X 9"	411  36" MIN. SEE SPECIAL PROVISION			
QUANTITY REQ'D 24 404  W16-9p 24" X 12"	QUANTITY REQ'D 4 408  R3 - 17bP 24" X 9"				

TYPE "E" SIGNS

S:\DPC Projects\Buncombe\SR 3548 Haywood Road\Traffic\Signing\CADD\Haywood Rd-DDC-sign2.dgn
30-JUL-2024 10:54

30-JUL-2024 11:11
S:\DDC\Projects\Buncombe\SR 3548 Haywood Road\Traffic\Signing\CADD\Haywood Rd.DDC_sign3.dgn
\$\$\$\$\$USERNAME\$\$\$\$\$

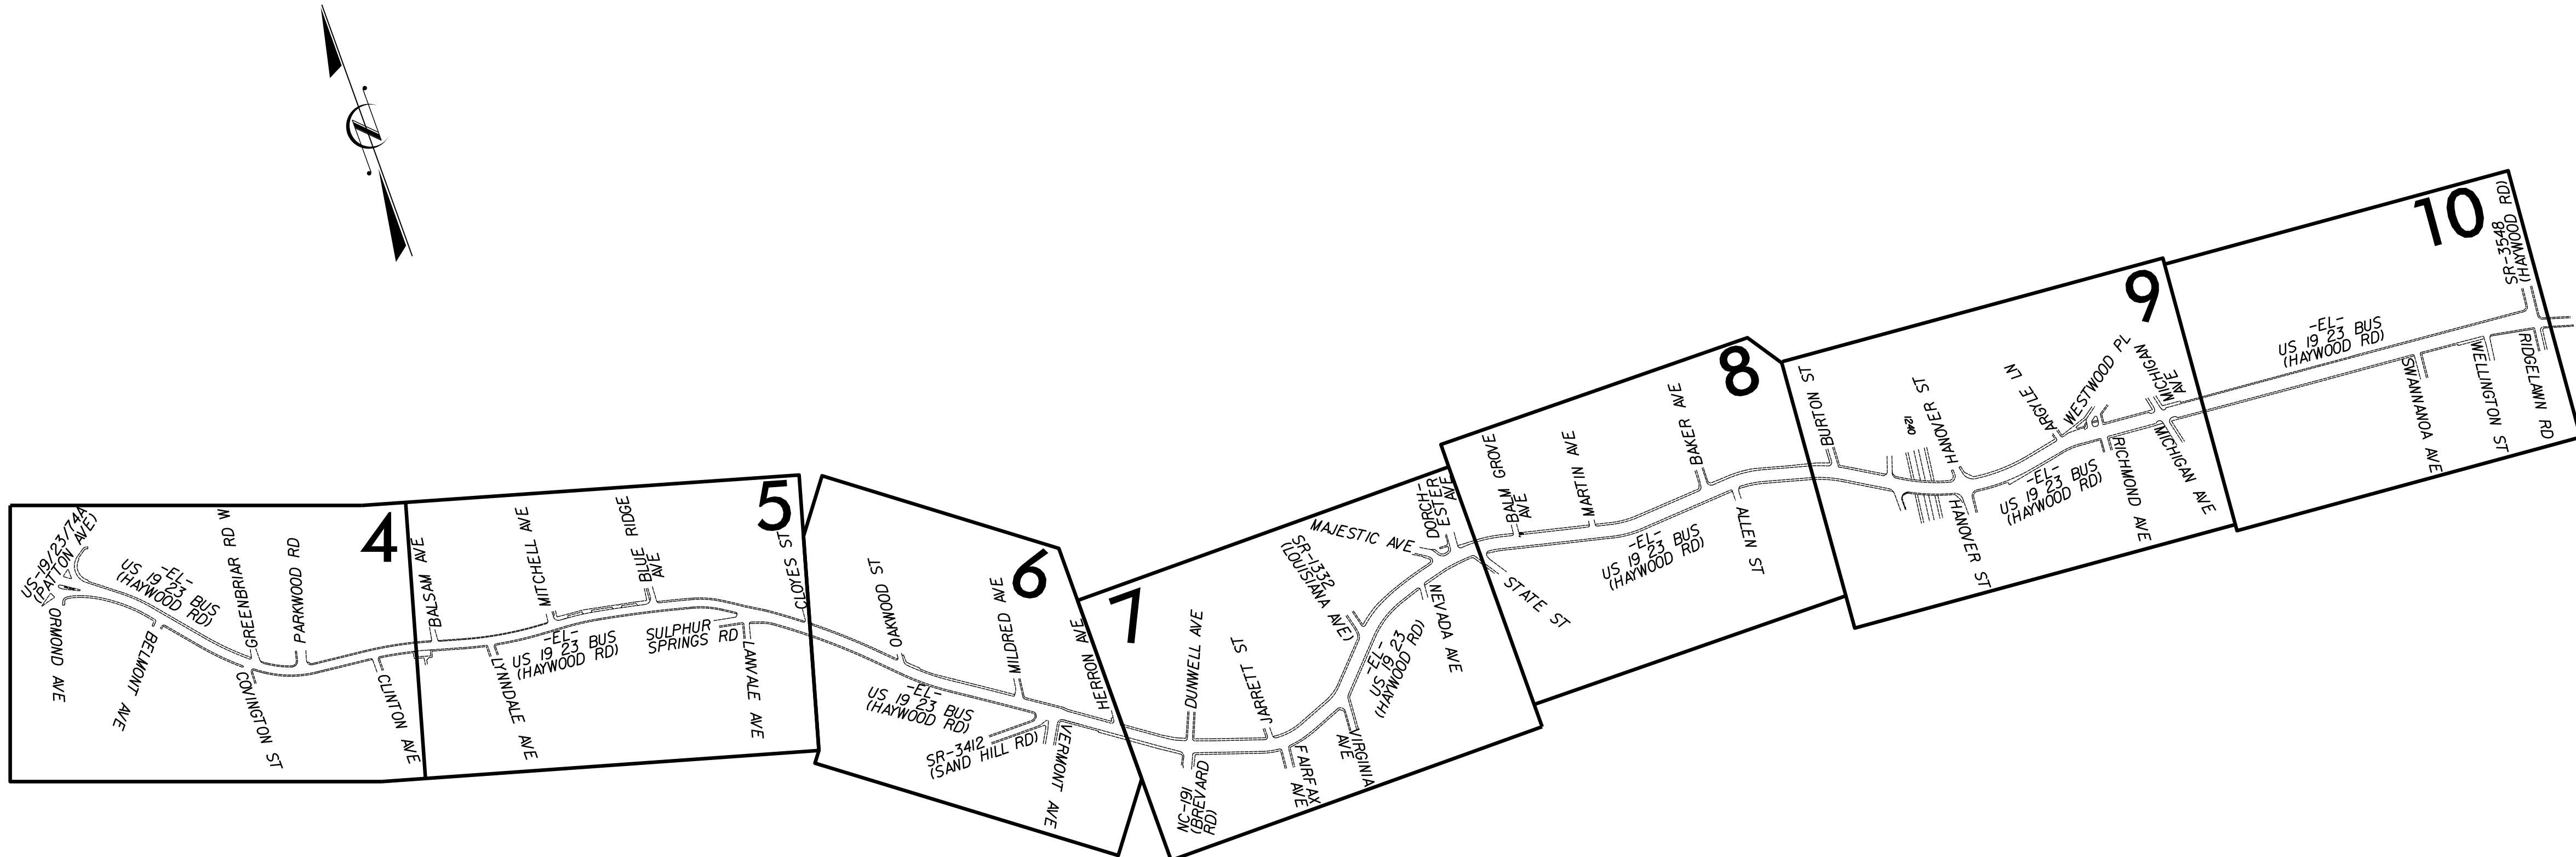

TIP NO.	SHEET NO.
HL-0003	SIGN-3
DocuSigned by: <i>William C. Carver</i> 163525A8519349F	
APPROVED:	
DATE: 07/30/2024	
SEAL	
DOCUMENT NOT CONSIDERED FINAL UNLESS ALL SIGNATURES COMPLETED	

KEY SHEET


TIP NO.
HL-0003

SHEET NO.
SIGN-4


APPROVED: *William C. Carver*

DATE: 07/30/2024

SEAL

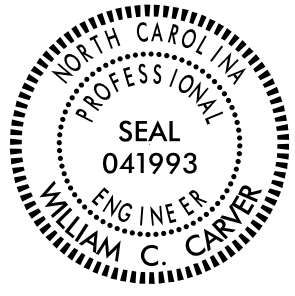


DOCUMENT NOT CONSIDERED FINAL
UNLESS ALL SIGNATURES COMPLETED

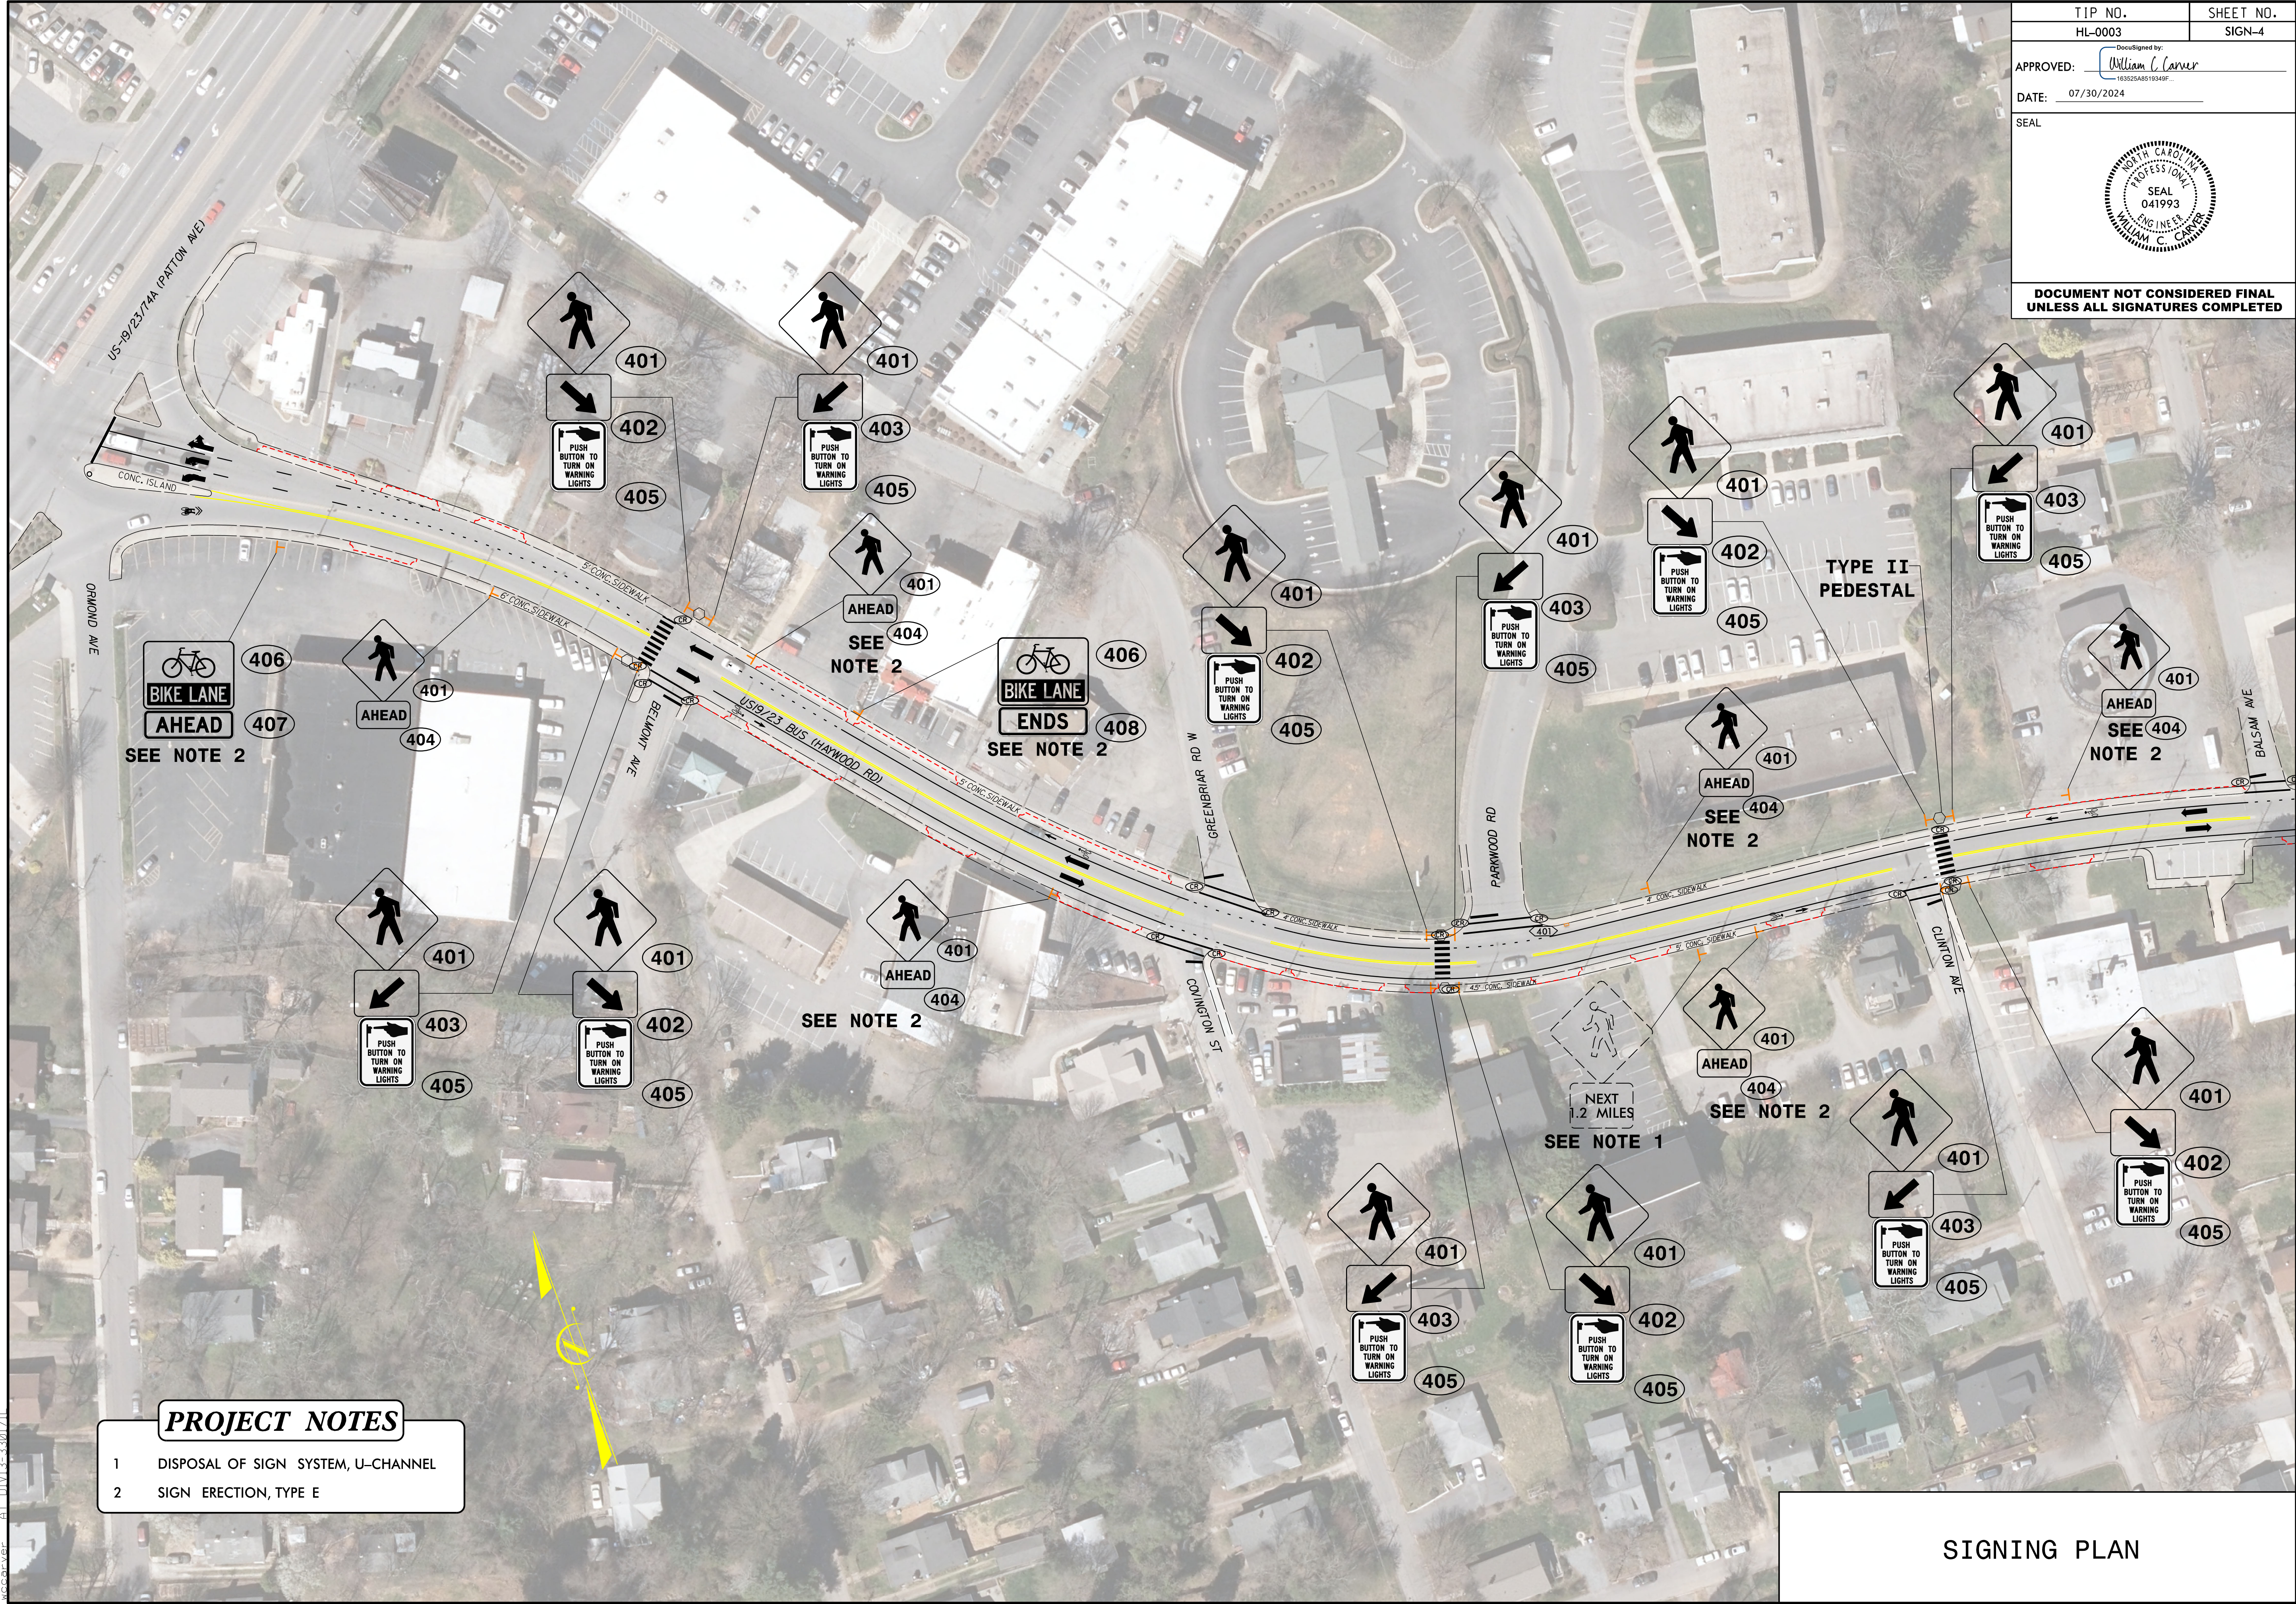

30-JUL-2024 08:41 S:\000\Projects\SR 3548 Haywood Road\Traffic\Signing\CADD\Haywood Rd.DOC.sign4.dgn


TIP NO.
HL-0003

 SHEET NO.
SIGN-5


APPROVED: 

DATE: 07/30/2024

SEAL

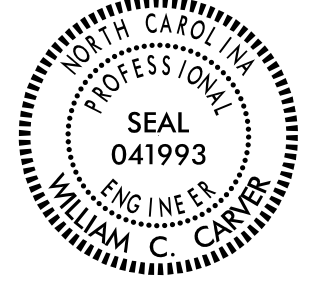

DOCUMENT NOT CONSIDERED FINAL
UNLESS ALL SIGNATURES COMPLETED

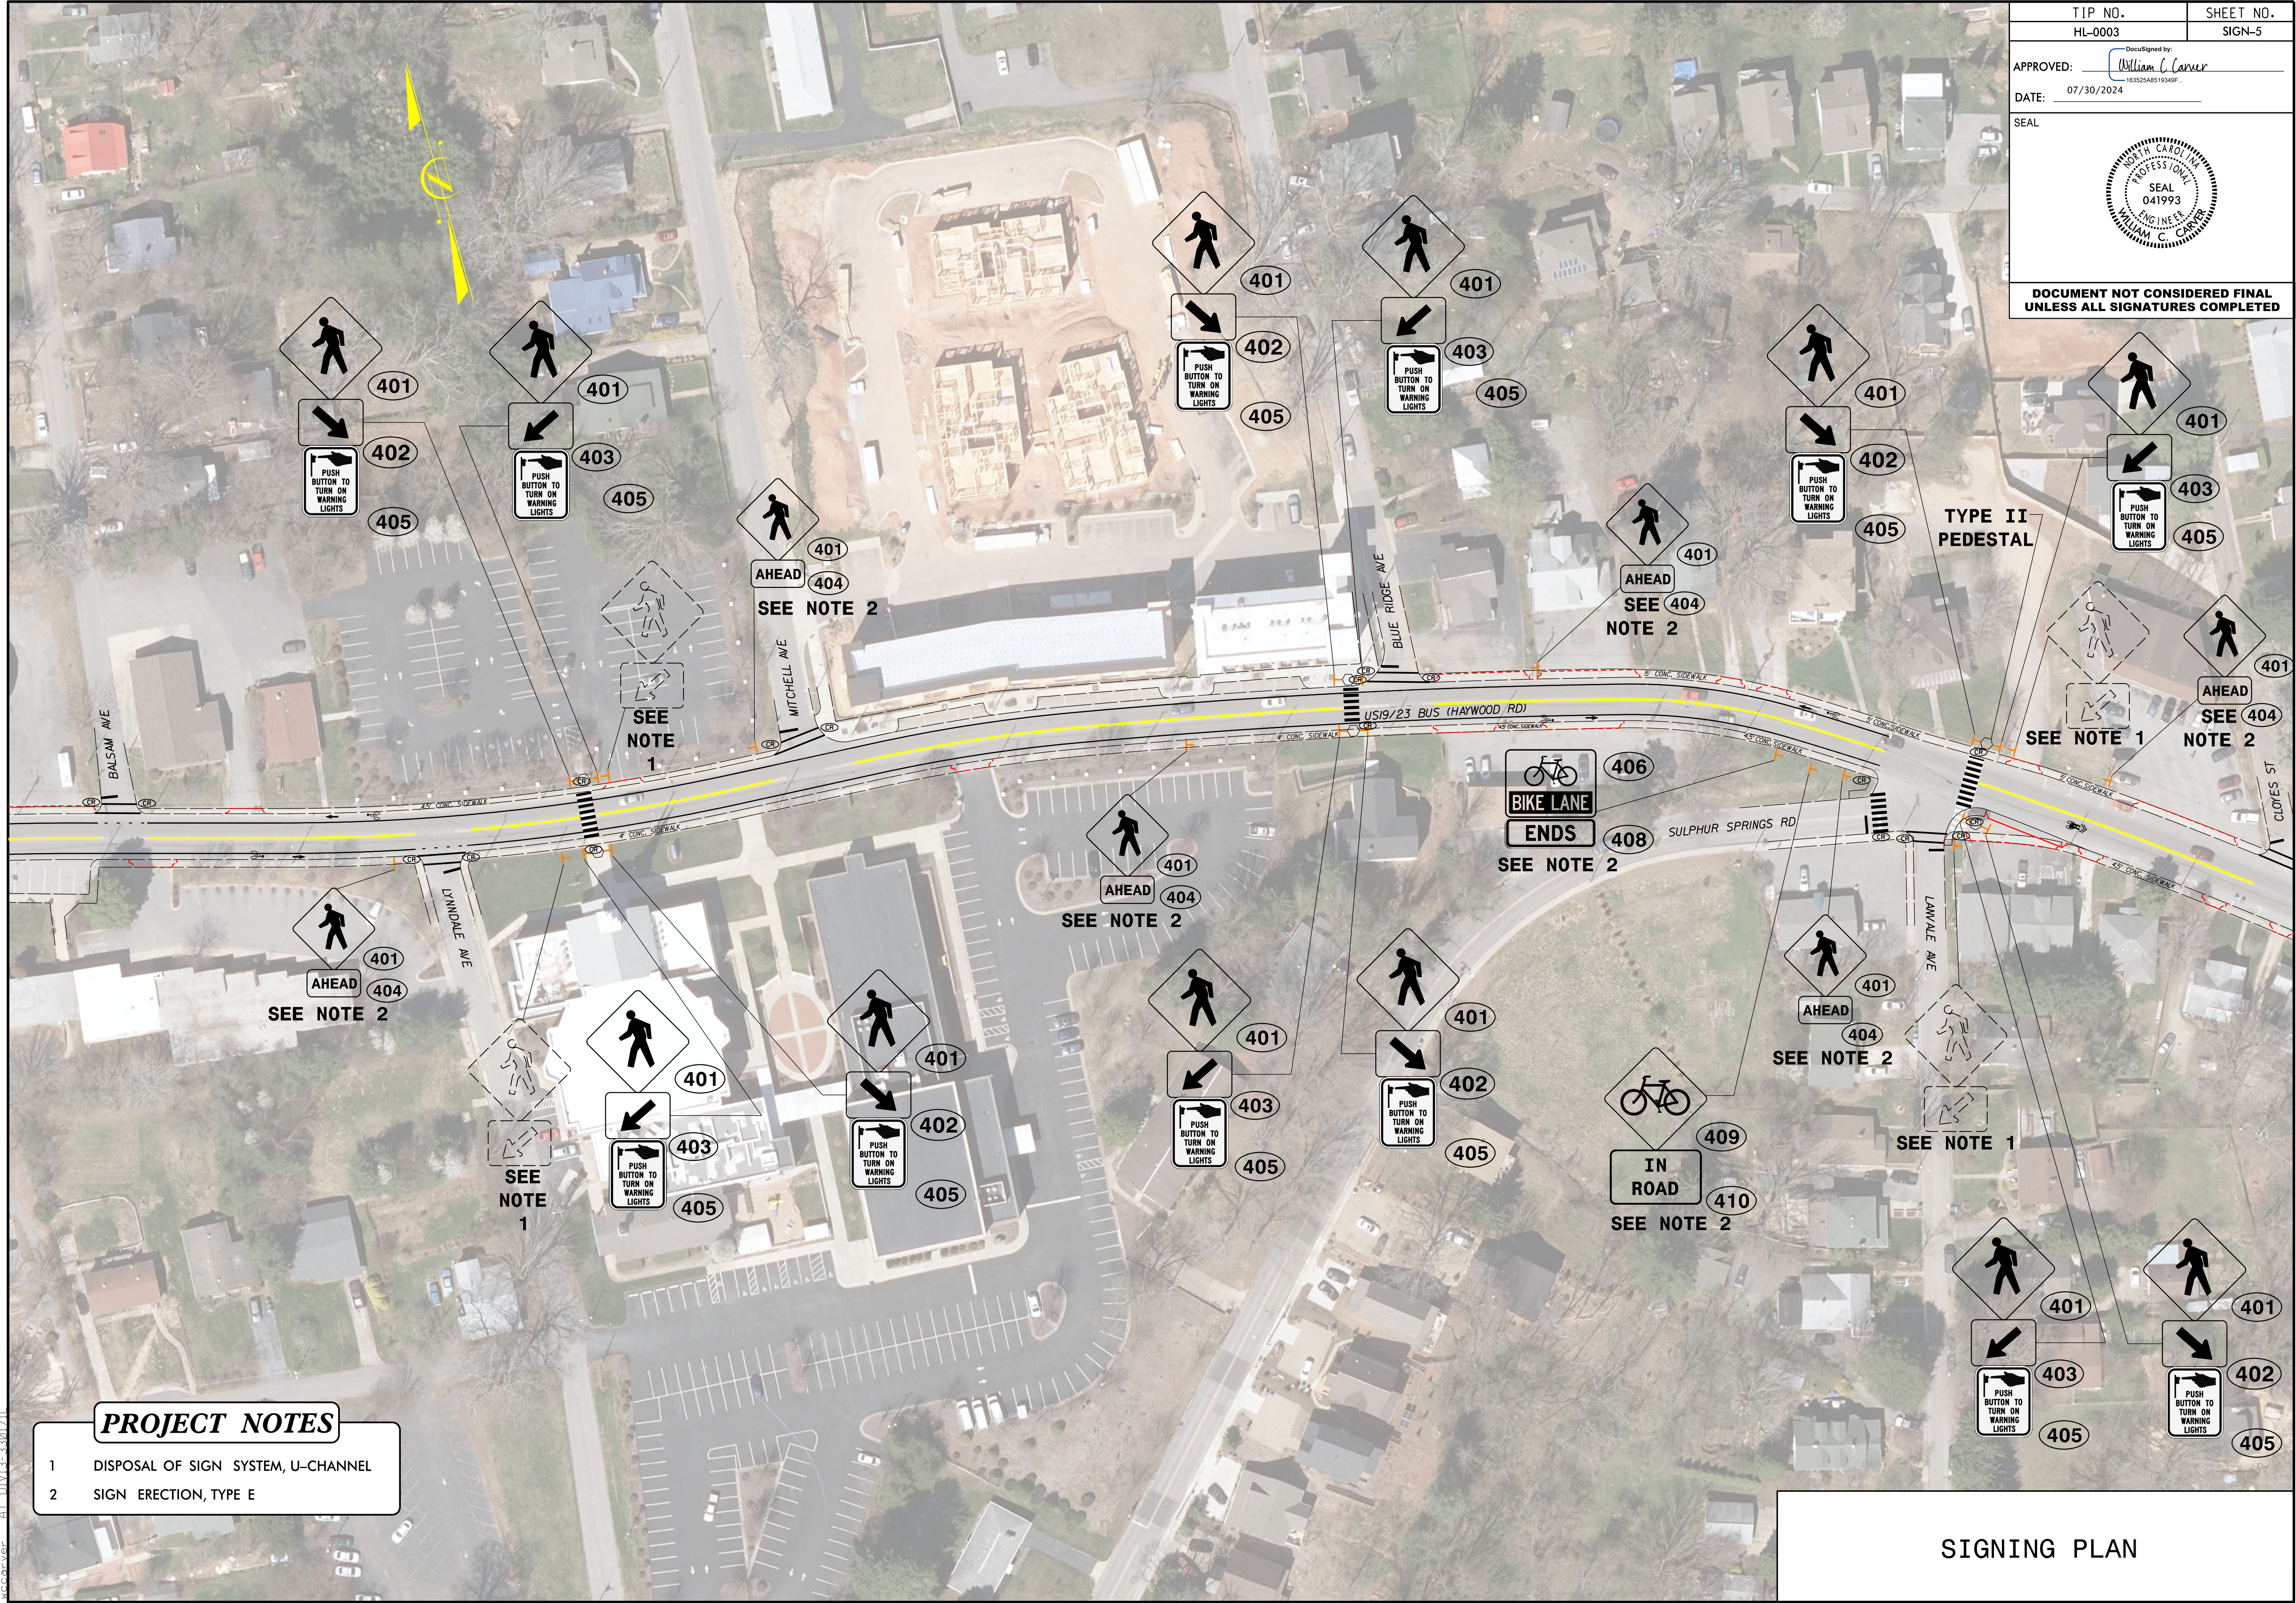

30-JUL-2024 08:45
S:\000\Projects\SR 3548 Haywood Road\Traffic\Signing\CADD\Haywood Rd.DOC-sign5.dgn
SCOTT W. CARVER
07/30/2024

