



STATE OF NORTH CAROLINA
DIVISION OF HIGHWAYS

ALAMANCE COUNTY

LOCATION: US 70 AT HUFFMAN MILL ROAD IN BURLINGTON
TYPE OF WORK: TRAFFIC SIGNALS AND TRAFFIC SIGNAL COMMUNICATIONS

TIP PROJECT: U-6011

See Sheet 1A For Index of Sheets
See Sheet 1B For Conventional Symbols

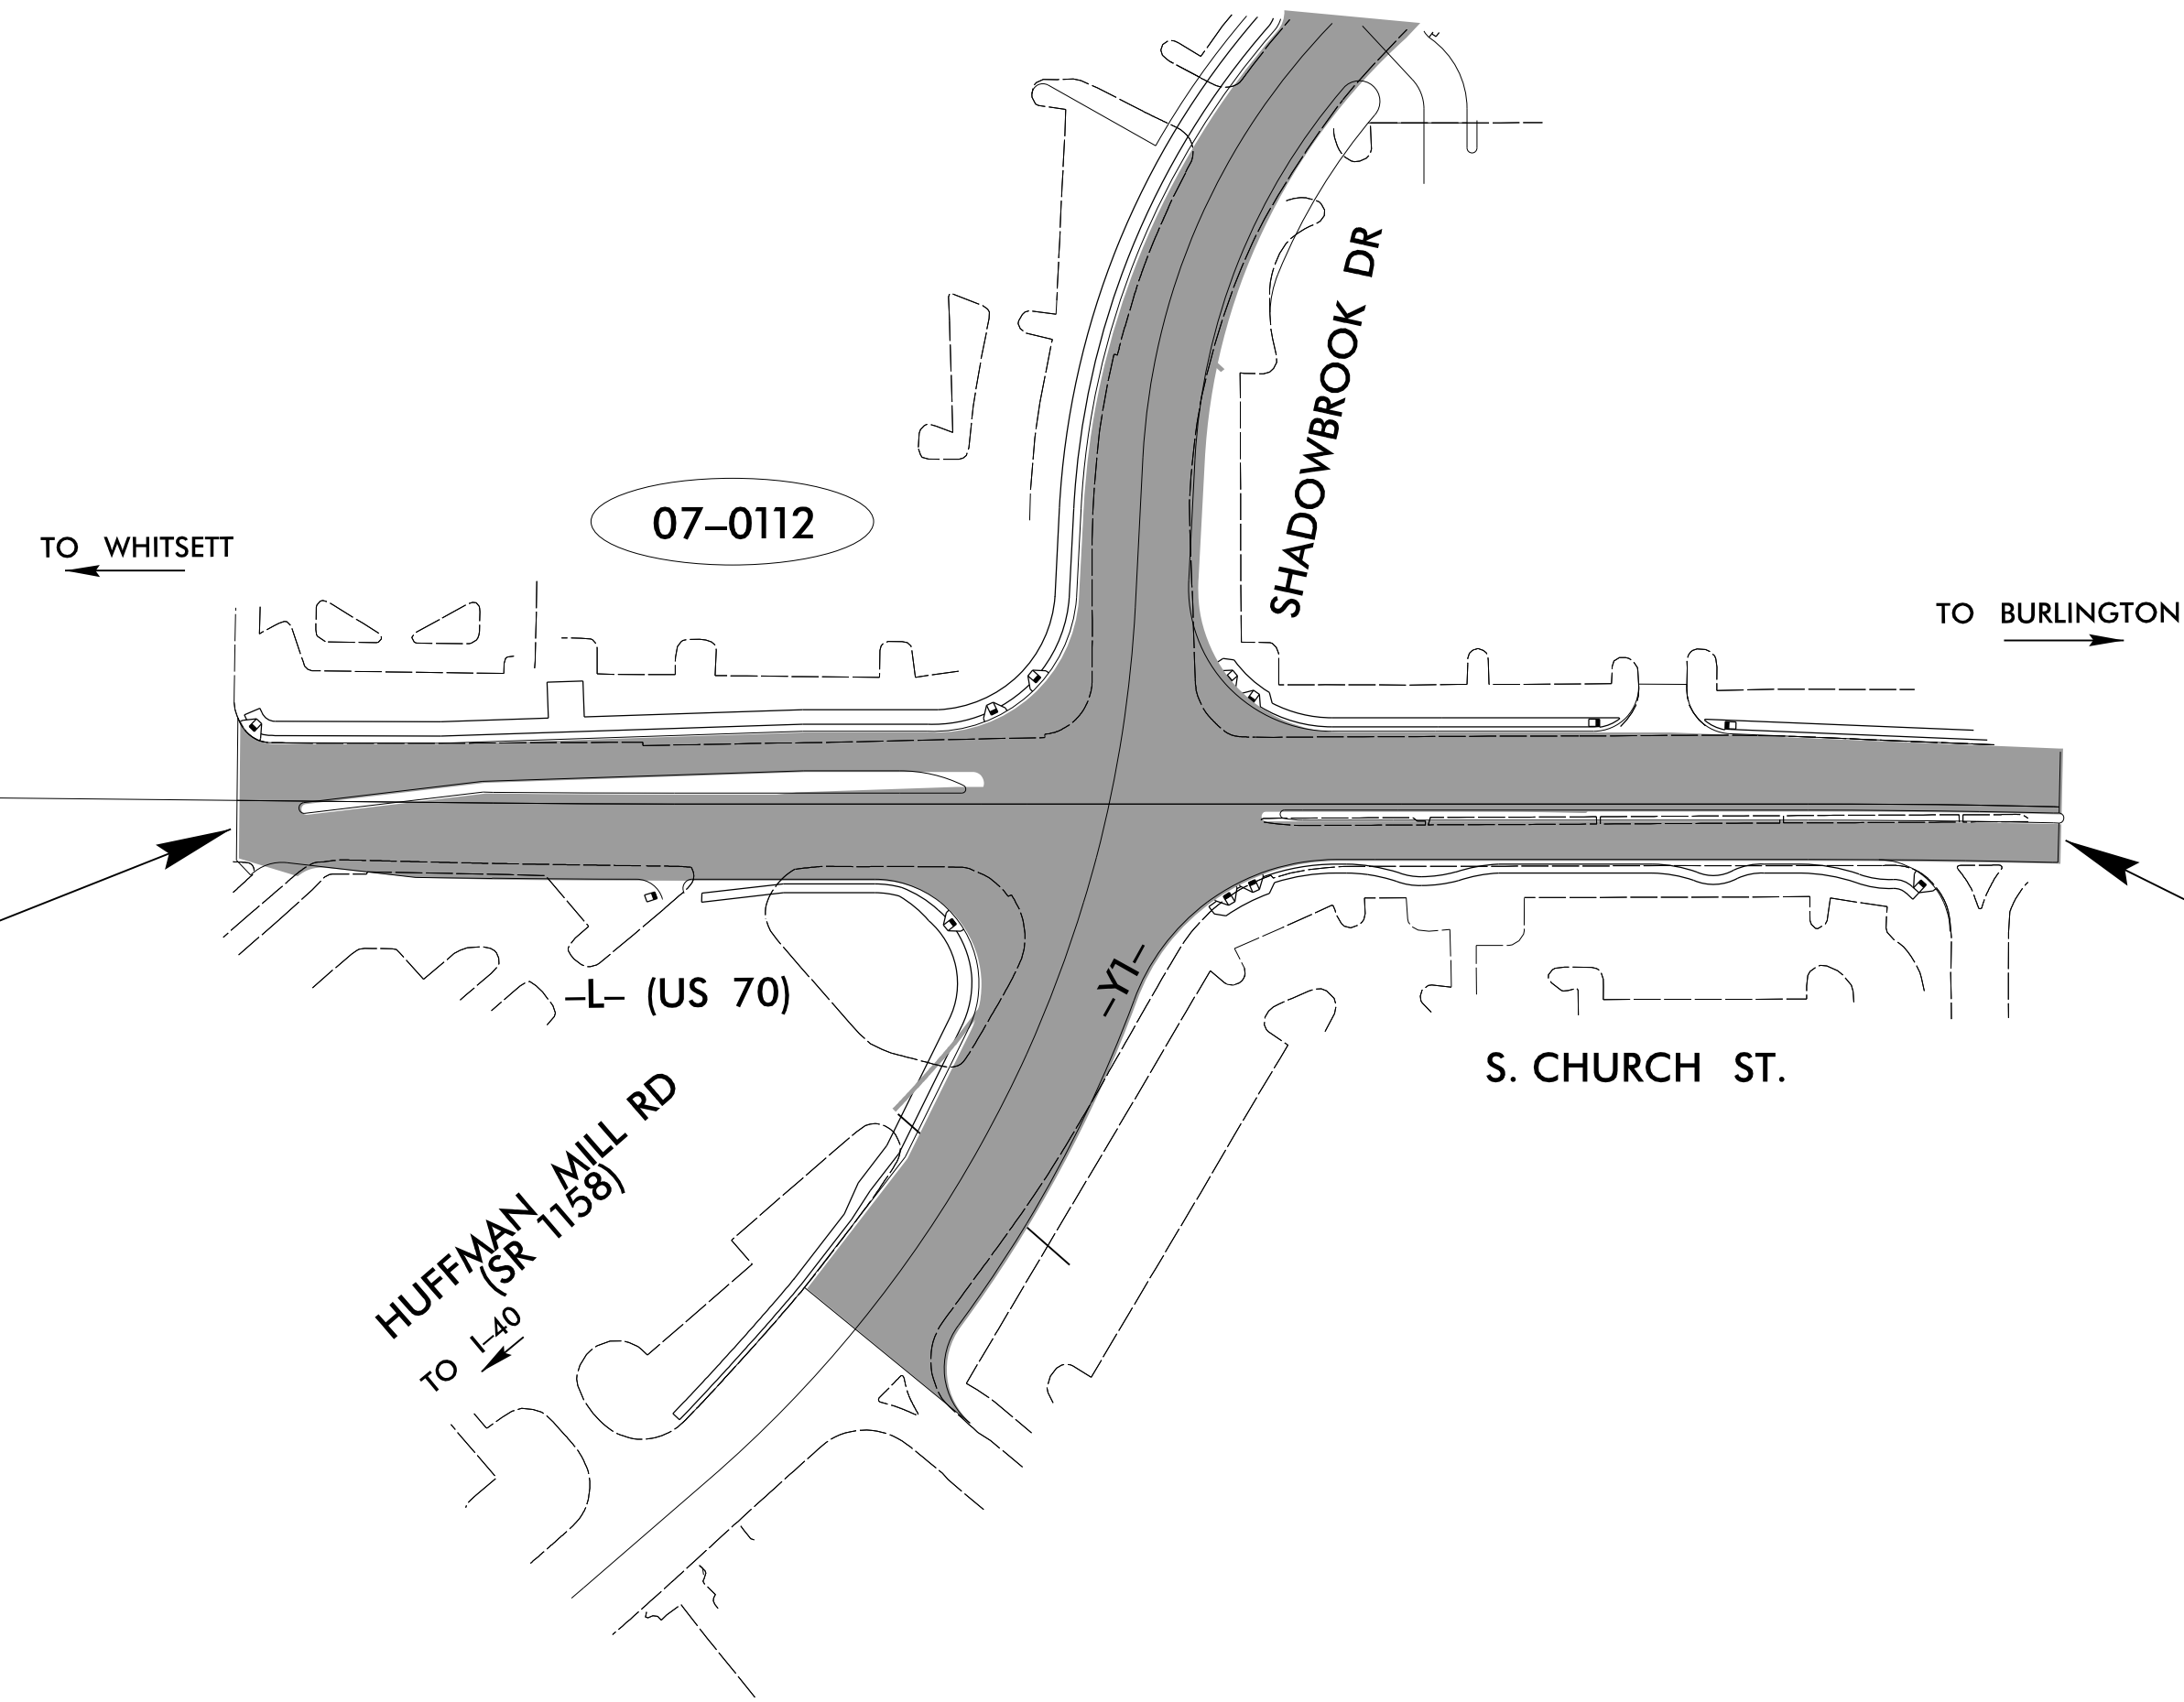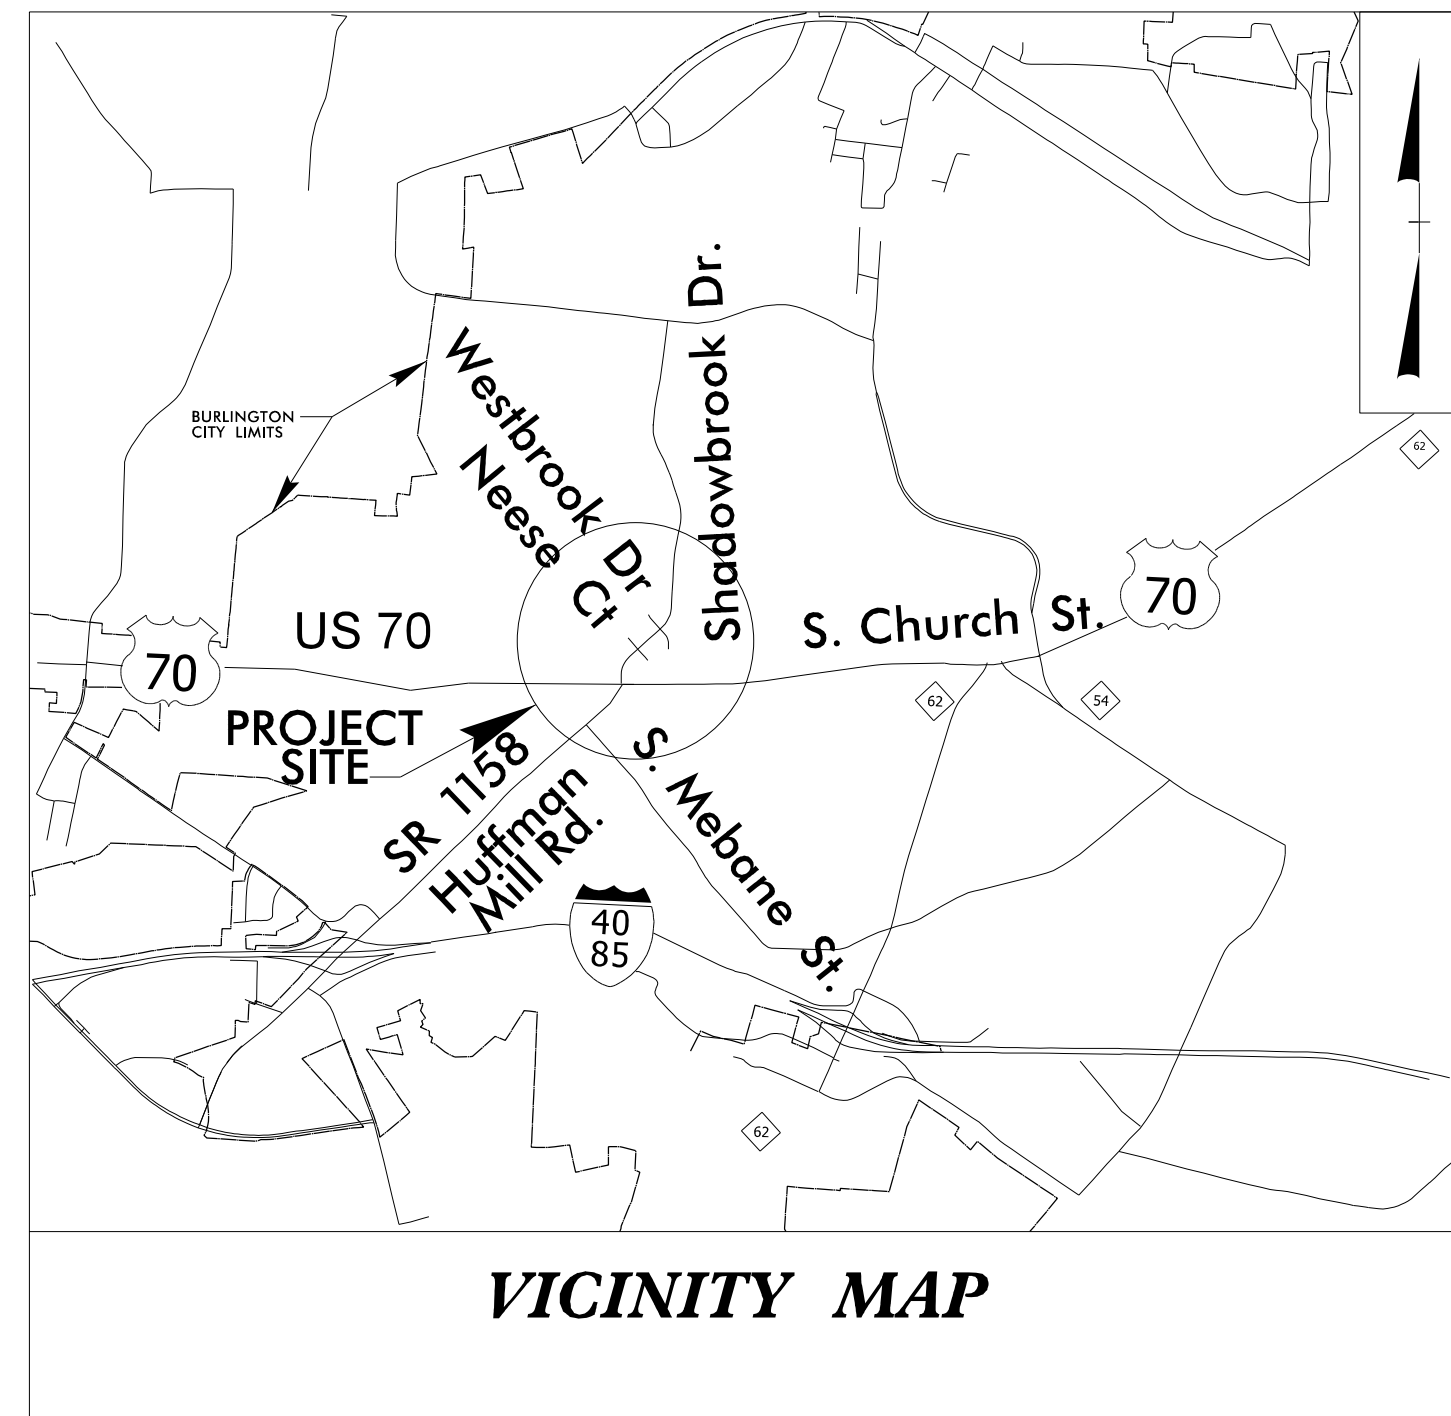

BEGIN TIP PROJECT U-6011
-L- POT STA 10+00.00

END TIP PROJECT U-6011
-L- POT STA 20+15.27

INDEX OF PLANS		
SHEET NUMBER	SIGNAL INV. NUMBER	LOCATION /DESCRIPTION
Sig. 1.0	-	Title Sheet
Sig. 2.0 - Sig. 4.4	07-0112	US 70 (S. Church St.) at SR 1158 (Huffman Mill Rd)/Shadowbrook Dr.
MLA - M9	-	NCDOT 2024 Metal Pole Standard Drawing Sheets
SCPI - SCP5	-	Signal Communications Plans

TRANSYSTEMS
1 Glenwood Avenue
Raleigh, NC 27603
Tel: 919.789.9977
Fax: 919.789.9591
License: F-0453


TRANSPORTATION SYSTEMS MANAGEMENT & OPERATIONS UNIT

Contacts:

Robert J. Ziemba, P.E. - Central Region Signals Engineer
Keith M. Mims, P.E. - Signal Equipment Design Engineer
Gregg Green - Signal Communications Project Engineer
Heidi Berggren, EI - Signal Communications Project Design Engineer

Refer to "Roadway Standard Drawings NCDOT" dated January 2024 and Standard Specifications for Roads and Structures" dated January 2024

Prepared for the Office of:
DIVISION OF HIGHWAYS
TRANSPORTATION MOBILITY AND SAFETY DIVISION
Transportation Systems Management & Operations Unit

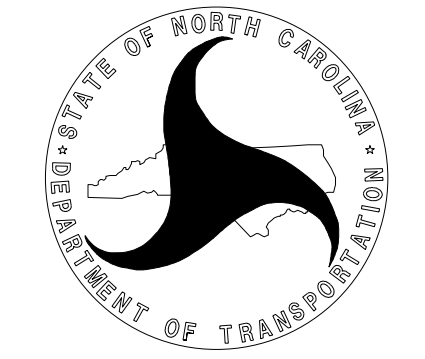

5/5/2024
U-6011_sig_tsh_2022xxxx.dgn
USER:dfault