

K:\RAL_Roadway\01036734 - R-5963A&B\Signing and Delineation\Design\Sheets\R-5963A&B_rdy_sgn_01dgn

1/15/2025

TIP PROJECT: R-5963A

CONTRACT:

STATE OF NORTH CAROLINA
DEPARTMENT OF TRANSPORTATION

SIGNING PLAN
CHATHAM COUNTY

LOCATION: CHATHAM PARK WAY FROM US 15 501 TO US 15-501
64 BYPASS FROM CHATHAM PARK WAY TO NC-87

ROADWAY STANDARD DRAWING

THE FOLLOWING ROADWAY STANDARDS AS APPEAR IN "ROADWAY STANDARD DRAWINGS" -
PROJECT SERVICES UNIT - N.C. DEPARTMENT OF TRANSPORTATION - RALEIGH, N.C.,
DATED JANUARY 2024 ARE APPLICABLE TO THIS PROJECT AND BY REFERENCE HEREBY ARE
CONSIDERED A PART OF THESE PLANS:

STD. NO.	TITLE
901.10	TYPE 'A' SIGNS - WELDED STUD CONSTRUCTION
901.20	TYPE 'B' SIGNS - WELDED STUD CONSTRUCTION
901.50	ARROWS AND SHIELDS
901.70	SIGN STRINGERS AND SUPPORT SPACING
901.80	SIGN MOUNTING DETAILS - TYPE A AND TYPE B SIGNS
902.10	FOUNDATIONS FOR GROUND MOUNTED SIGNS
903.10	GROUND MOUNTED SIGN SUPPORTS
904.10	ORIENTATION OF GROUND MOUNTED SIGNS
904.20	SECONDARY SIGN MOUNTING
904.30	SUPPLEMENTAL SIGN MOUNTING
904.50	MOUNTING OF TYPE 'D', 'E' AND 'F' SIGNS ON 'U' CHANNEL SUPPORTS
910.30	SIGNING UNSIGNALIZED REDUCED CONFLICT INTERSECTION
910D40	SINGLE LANE RURAL ROUNDABOUT SIGNING
1145.01	BARRICADES - TYPE III
1264.01	OBJECT MARKERS - TYPES
1264.02	OBJECT MARKERS - INSTALLATION

GENERAL NOTES

- ALL TYPE 'D' SIGNS SHALL BE MOUNTED ON TWO U-CHANNEL POSTS UNLESS OTHERWISE INDICATED ON THE PLANS.
- WHEN NOT STATIONED OR DIMENSIONED ON PLANS, ALL 'E' AND 'F' SIGNS SHALL BE FIELD LOCATED BY THE ENGINEER.
- WHEN EXISTING SIGNS ARE REMOVED AND INSTALLED ON NEW SUPPORTS, THE RE-ERECTION SHALL IMMEDIATELY FOLLOW THE REMOVAL.
- THE BACKGROUND FOR TYPE E & F SIGNS SHALL BE GRADE C REFLECTIVE SHEETING.
- SEE ROADWAY PLANS FOR GUARD/GUIDE RAIL DETAILS.
- SIGNING PLANS DO NOT INCLUDE TEMPORARY CONSTRUCTION SIGNING OR PAVEMENT MARKINGS. SEE TRAFFIC MANAGEMENT PLANS.

INDEX

SHEET NO.	DESCRIPTION
SIGN-01	TITLE SHEET
SIGN-1A	PROJECT OVERVIEW MAP
SIGN-1B	SINGLE LANE URBAN ROUNDABOUT SIGNING, WITH PEDESTRIANS
SIGN-1C	SUPPORT CHART GROUND MOUNTED SIGNS
SIGN-2 THRU SIGN-2B	TYPE E AND F SIGN DESIGNS
SIGN-3 THRU SIGN-3E	TYPE A, B, AND D SIGN DESIGNS
SIGN-4 THRU SIGN-33	SIGNING PLAN SHEETS

PLAN REVIEWED BY: N.C.D.O.T. SIGNING AND DELINEATION UNIT

M. EATON, PE	SIGNING & DELINEATION REGIONAL ENGINEER
A. SCOTT	SIGNING & DELINEATION PROJECT DESIGN ENGINEER



PLAN PREPARED BY: Kimley-Horn and Associates

CALEB LOWMAN, PE	PROJECT DESIGN ENGINEER
OUSMANE NDIAYE, PE	DESIGNER


Kimley»Horn


TIP NO.	SHEET NO.
R-5963A	SIGN-1
SEAL	
DOCUMENT NOT CONSIDERED FINAL UNLESS ALL SIGNATURES COMPLETED	

PROJECT OVERVIEW MAP




4

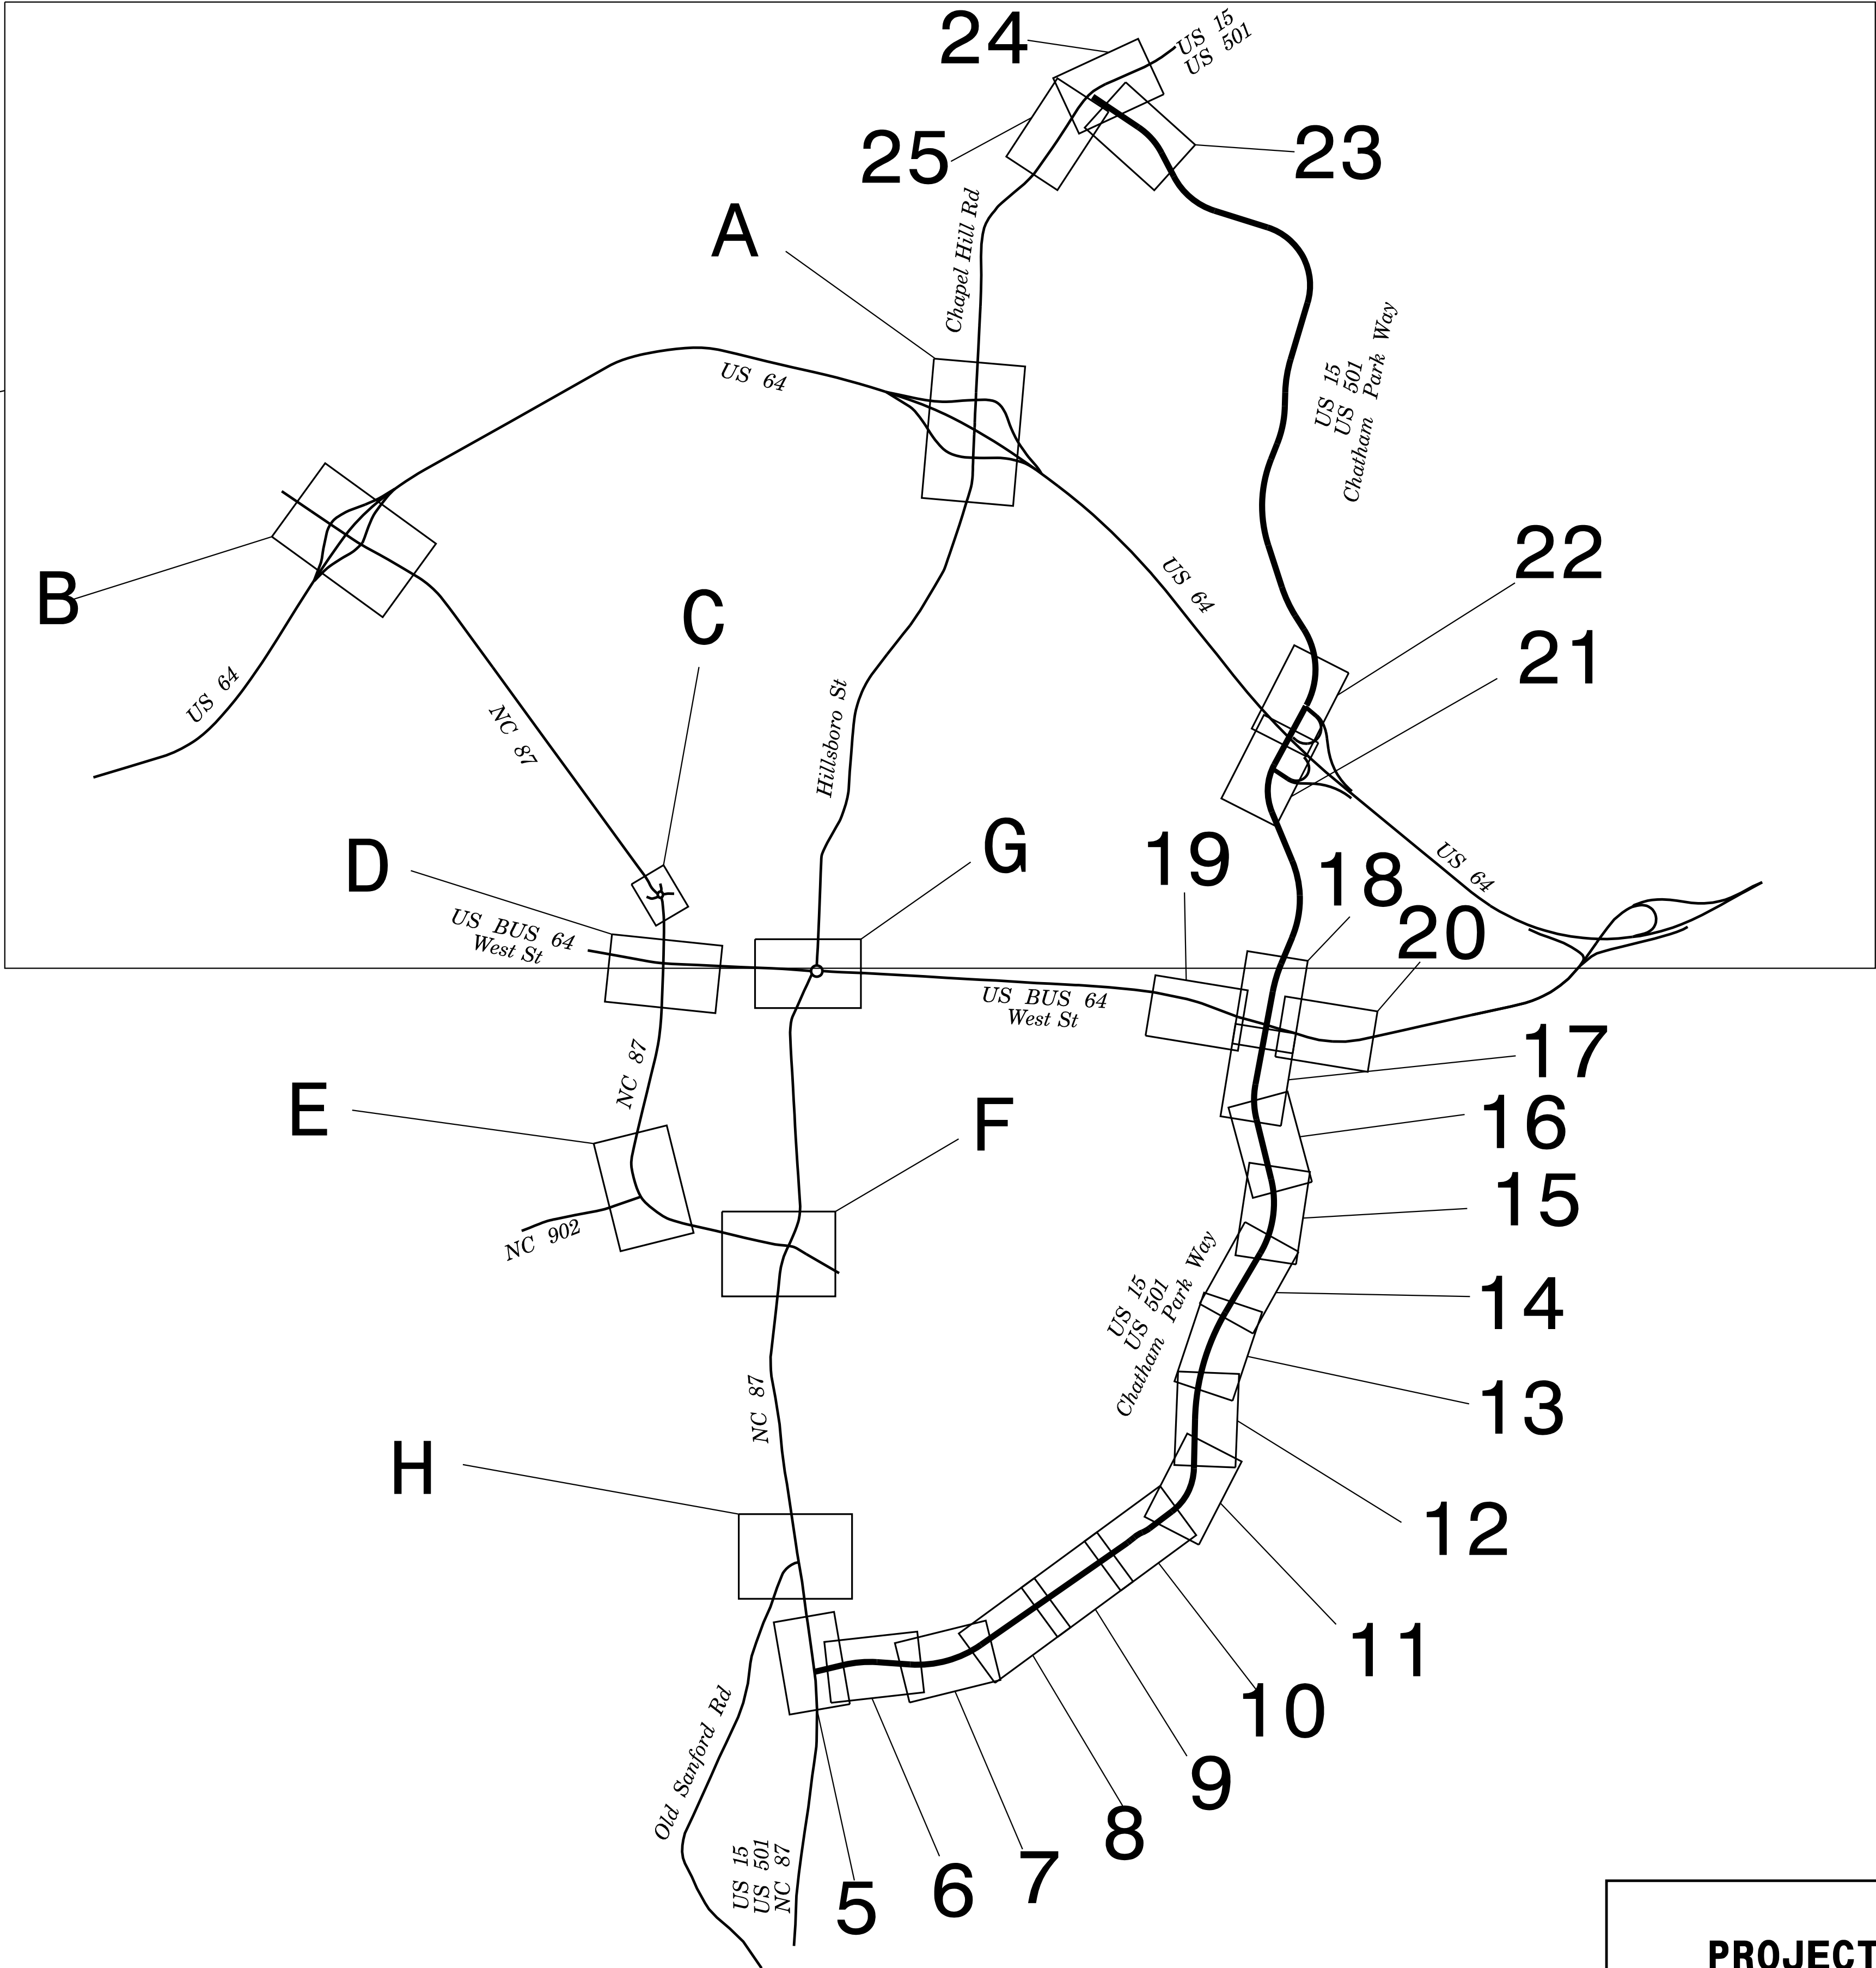

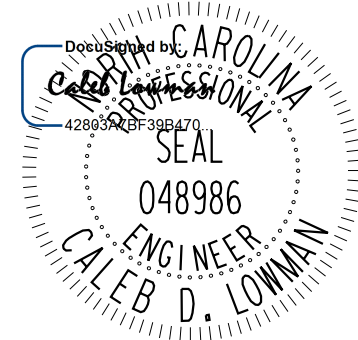TIP NO. R-5963A	SHEET NO. SIGN-1A
SEAL	
	
3/20/2025	
DOCUMENT NOT CONSIDERED FINAL UNLESS ALL SIGNATURES COMPLETED	

PROJECT OVERVIEW MAP

SECTION 01000 - GENERAL NOTES

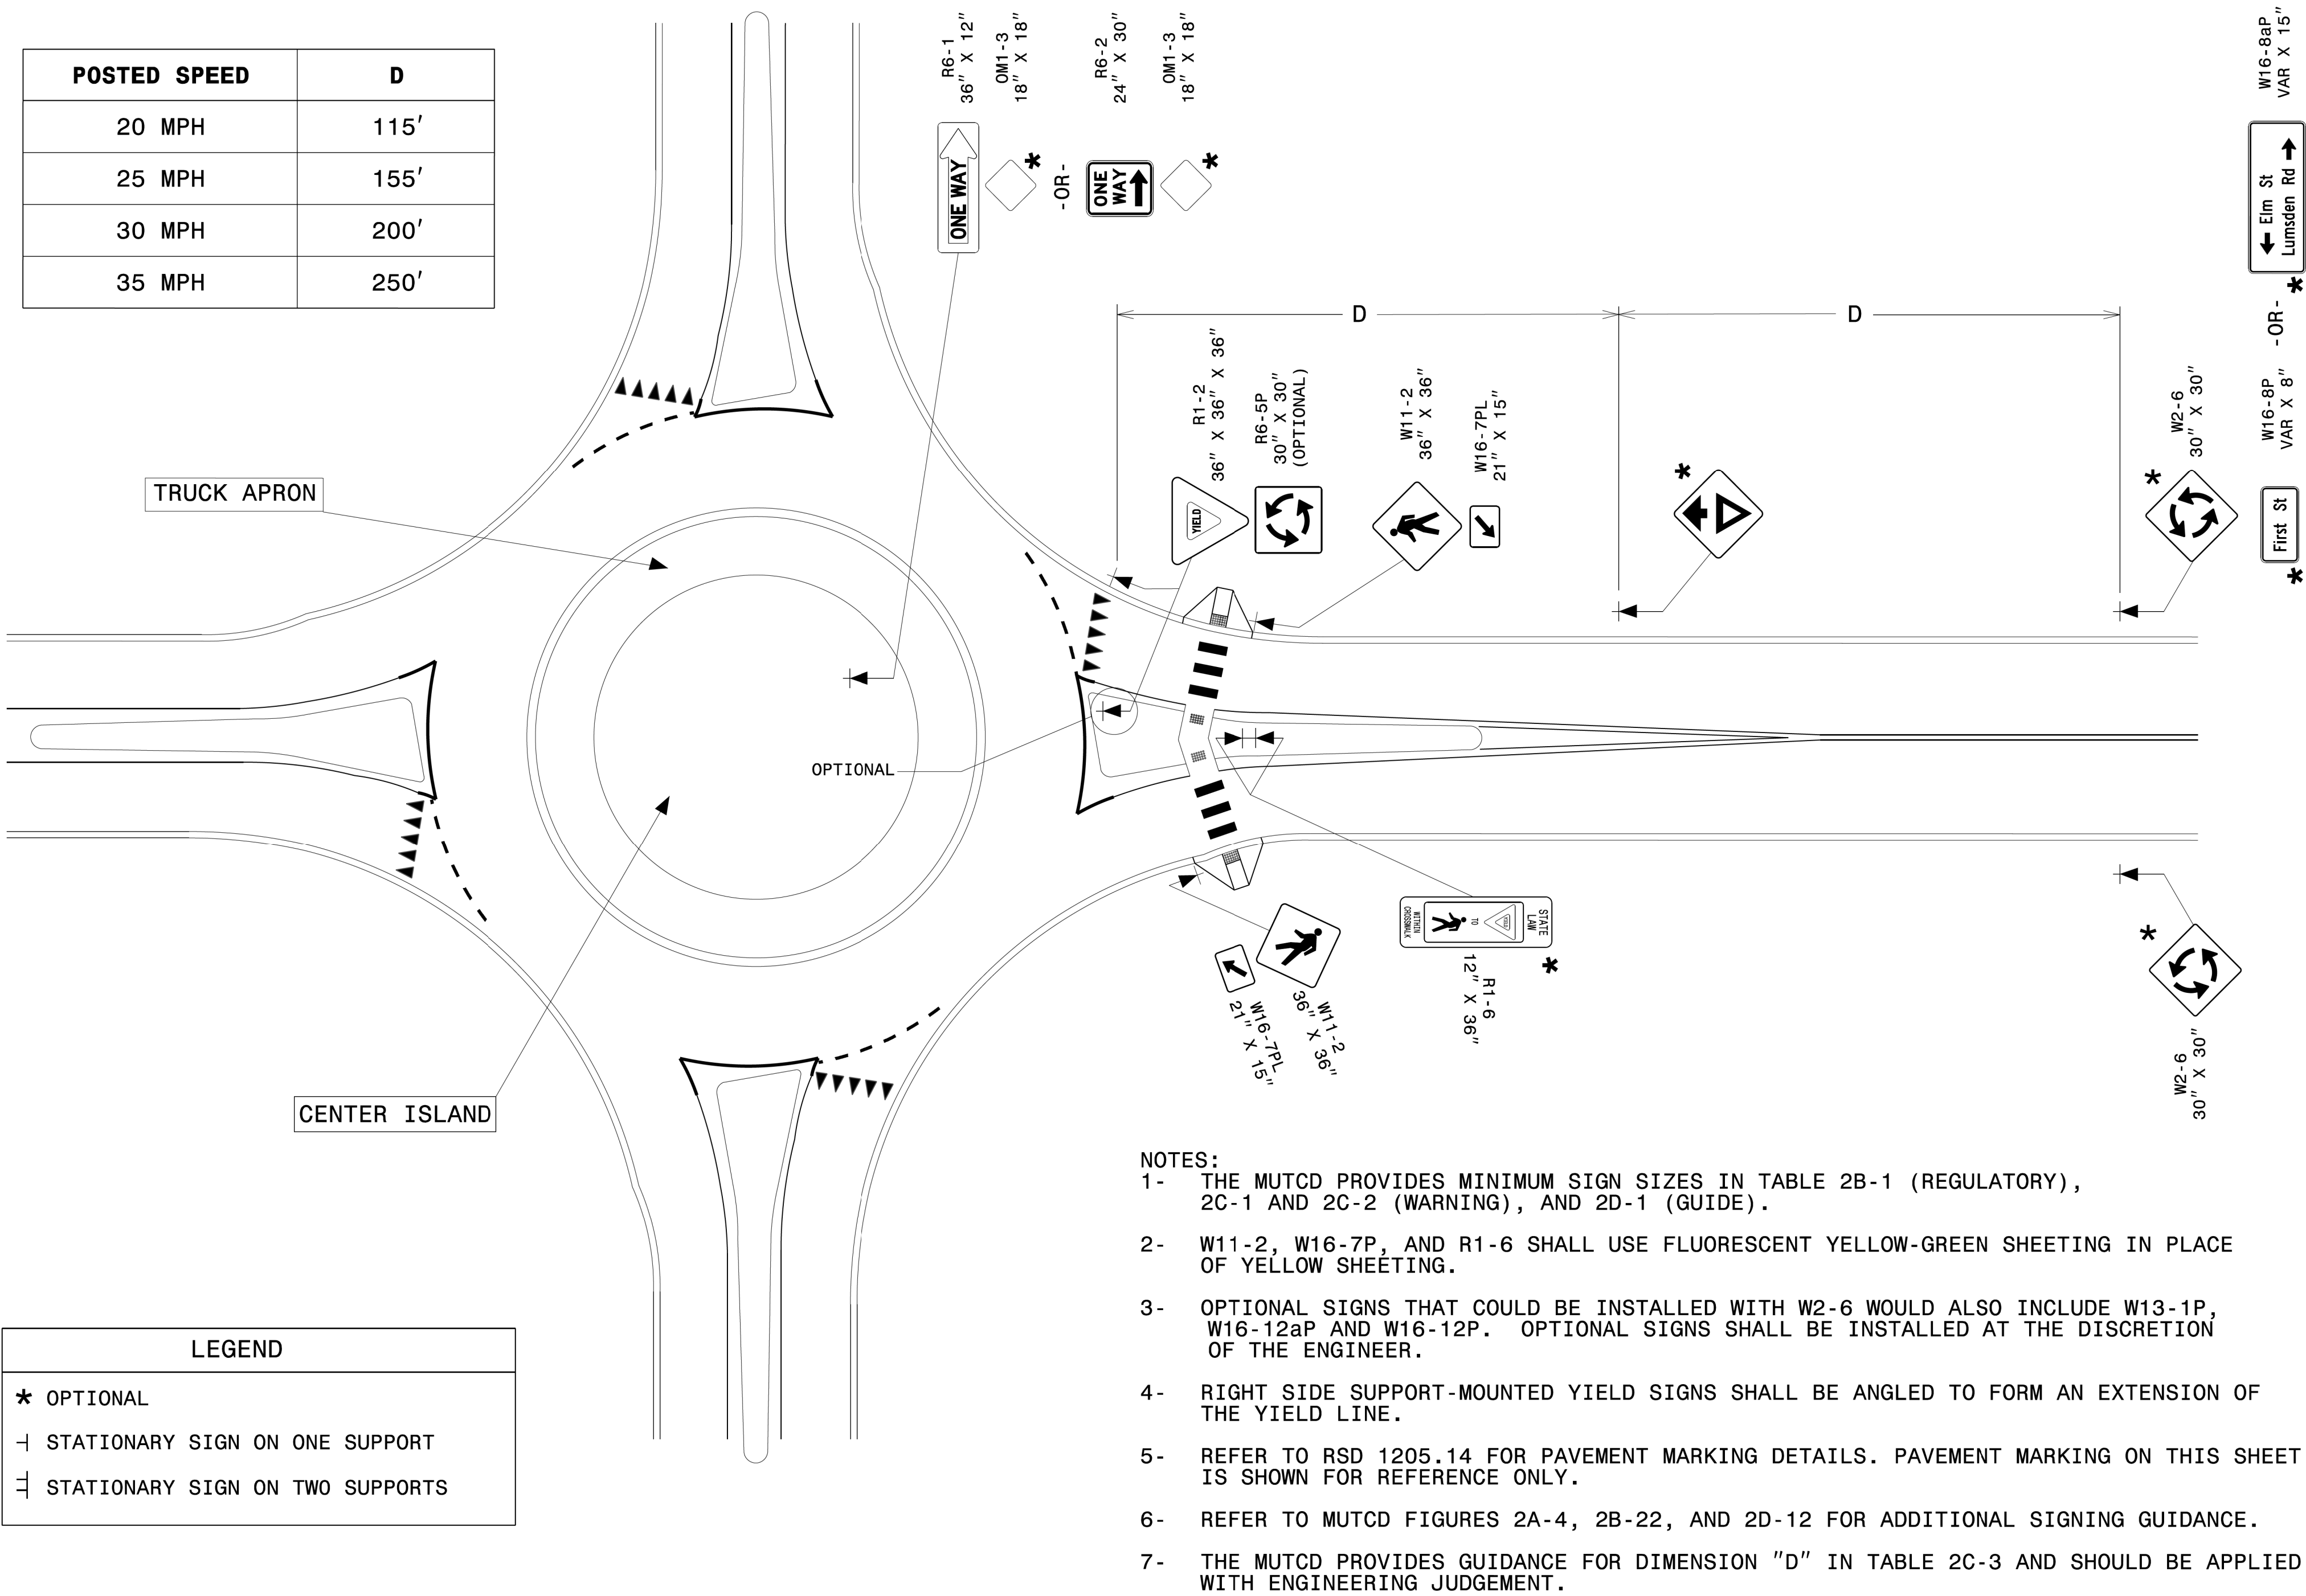

STATE OF
NORTH CAROLINA
DEPT. OF TRANSPORTATION
DIVISION OF HIGHWAYS
RALEIGH, N.C.

ROADWAY DETAIL DRAWING FOR
**SINGLE LANE URBAN ROUNDABOUT
SIGNING, WITH PEDESTRIANS**

SHEET 1B OF 2
910D40

Kimley »Horn

421 FAYETTEVILLE STREET, SUITE 600
RALEIGH, N.C. 27601. NC LICENSE #F-0102


TIP NO.

R-5963A

SHEET NO.

SIGN-1C

SEAL

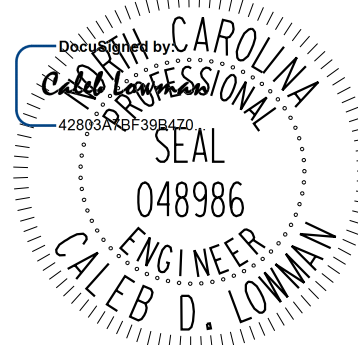

3/20/2025


DOCUMENT NOT CONSIDERED FINAL
UNLESS ALL SIGNATURES COMPLETED

Version: 3.2 Posted: 7/5/2023

SIGN					ROADWAY STATION	NUMBER OF SUPPORTS	BEAM SECTION	SUPPORT TYPE BA or S	OMNI COUPLER	ATTACHMENT METHOD	MOUNTING METHOD	HORIZONTAL CLEARANCE* (ft.)	SUPPORT SPACING	LENGTH (ft)			LEFT SUPPORT (ft)			CENTER SUPPORT (ft)			RIGHT SUPPORT (ft)			SUPPORT WEIGHTS		FOOTINGS				FIELD VERIFIED SEE NOTE 2 (mm/dd/yy)			
NUMBER	TYPE	SIZE (in.)												SNS HT	MTG HT	EMBED- MENT										B/A (lbs.)	SIMPLE (lbs.)	DIAMETER (ft.)	DEPTH (ft.)	REINFORCE D (c.y.)	PLAIN (c.y.)				
		w	x	h													"H"	"C"																	
101A	B	132	x	30	Field Locate at Exist Sign Location	2	W6x16	BA	N/A	1-R N/A	N/A N/A	30.00	9.08	12.00	7.00	5.0	0.00	19.00	24.00	0.00	0.00	0.00	0.00	19.00	24.00	862.00	0	1.5	5.5	0.72	0.00	_____			
101B	A	186	x	144	Field Locate at Exist Sign Location	2	W6x16	BA	N/A	1-R N/A	N/A N/A	30.00	9.08	12.00	7.00	5.0	0.00	19.00	24.00	0.00	0.00	0.00	0.00	19.00	24.00	862.00	0	1.5	5.5	0.72	0.00	_____			
102A	B	132	x	30	Field Locate at Exist Sign Location	2	W6x16	BA	N/A	1-R N/A	N/A N/A	30.00	9.08	12.00	7.00	5.0	0.00	19.00	24.00	0.00	0.00	0.00	0.00	19.00	24.00	862.00	0	1.5	5.5	0.72	0.00	_____			
102B	A	186	x	144																															
103A	B	132	x	30	-Y1- STA 49+20	2	W10x22	BA	N/A	1-R N/A	N/A N/A	30.00	9.08	12.50	7.14	4.5	3.37	23.01	27.51	0.00	0.00	0.00	-0.14	19.50	24.00	1371.22	0	2.5	5	1.82	0.00	_____			
103B	A	186	x	150																															
104A	B	132	x	30	Field Locate at Exist Sign Location	2	W6x16	BA	N/A	1-R N/A	N/A N/A	30.00	9.08	12.00	7.00	5.0	0.00	19.00	24.00	0.00	0.00	0.00	0.00	19.00	24.00	862.00	0	1.5	5.5	0.72	0.00	_____			
104B	A	186	x	144	Field Locate at Exist Sign Location	2	W6x16	BA	N/A	1-R N/A	N/A N/A	30.00	9.08	12.00	7.00	5.0	0.00	19.00	24.00	0.00	0.00	0.00	0.00	19.00	24.00	862.00	0	1.5	5.5	0.72	0.00	_____			
105A	B	132	x	30	Field Locate at Exist Sign Location	2	W6x16	BA	N/A	1-R N/A	N/A N/A	30.00	9.08	12.00	7.00	5.0	0.00	19.00	24.00	0.00	0.00	0.00	0.00	19.00	24.00	862.00	0	1.5	5.5	0.72	0.00	_____			
105B	A	186	x	144																															
106A	B	132	x	30	-Y1- STA 22+65	2	W14x30	BA	N/A	1-R N/A	N/A N/A	30.00	9.08	12.50	7.00	4.5	5.66	25.16	29.66	0.00	0.00	0.00	8.33	27.83	32.33	2269.70	0	3.0	5	2.62	0.00	_____			
106B	A	186	x	150																															
107	A	126	x	114	-Y11- STA 29+20	2	W6x12	BA	N/A	N/A	N/A	12.00	6.15	9.50	7.00	3.5	1.80	18.30	21.80	0.00	0.00	0.00	0.50	17.00	20.50	585.60	0	1.5	4	0.52	0.00	_____			
108	A	150	x	156	-Y11- STA 17+23	2	W6x16	BA	N/A	N/A	N/A	12.00	7.33	13.00	7.00	4.5	1.50	21.50	26.00	0.00	0.00	0.00	1.00	21.00	25.50	918.00	0	1.5	5	0.65	0.00	_____			
																								TOTAL		TOTAL						TOTAL		TOTAL	
																								8592.52		0.00						8.49		0.00	
USE:																								8593.00		0.00						9.00		0.00	

NOTES










- DIMENSION "S" REPRESENTS AN INCREASE (+), OR A DECREASE (-) IN POLE LENGTH, RELATIVE TO THE ELEVATION OF THE EDGE OF TRAVEL LANE.
- FIELD VERIFICATIONS SHALL BE REQUIRED FOR ALL SUPPORTS, SEE (*) ARTICLE 903-3. FABRICATORS SHALL BE AISC CERTIFIED IN CATEGORY 1, SEE (*) ARTICLE 1072-1. (*) = N.C.D.O.T. STANDARD SPECIFICATIONS FOR ROADS AND STRUCTURES
- PLAN LOCATIONS FOR EXISTING UTILITIES ARE BASED ON THE BEST AVAILABLE INFORMATION AND, THEREFORE MAY NOT BE PRECISELY ACCURATE. THEREFORE, IT IS INCUMBENT UPON THE CONTRACTOR TO DETERMINE THE EXACT LOCATION OF UTILITIES BEFORE BEGINNING WORK IN A LOCATION.

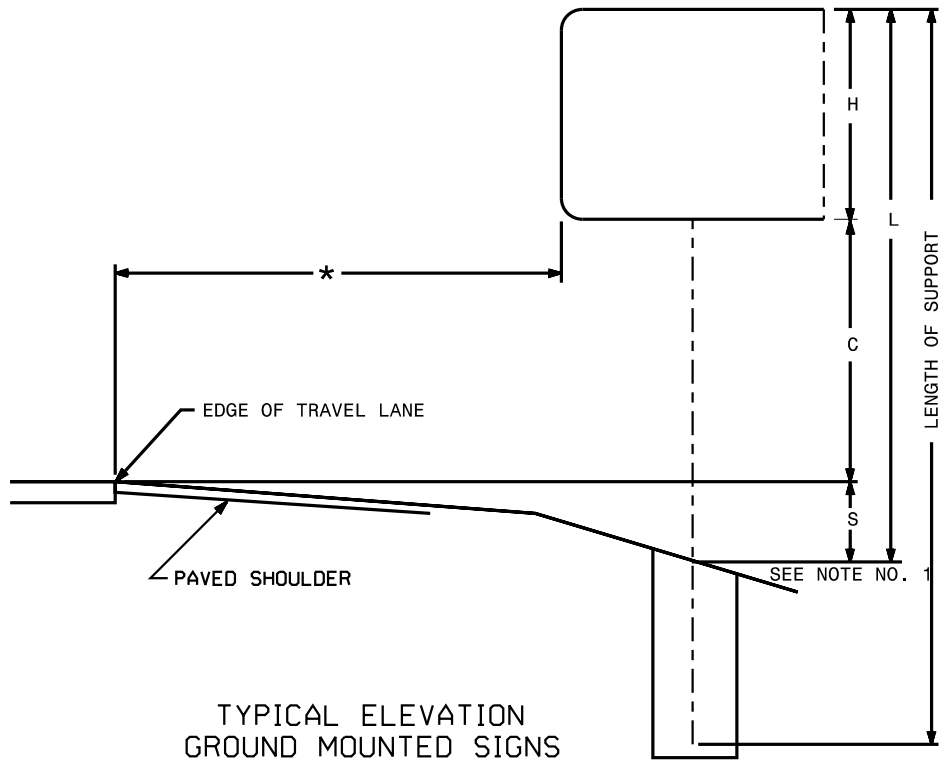

SUPPORT CHART
GROUND MOUNTED SIGNS

K:\RAL_Roadway\01036734 - R-5963A&B\Signing and Delineation\Design\Sheets\R-5963A&B_rdy_sgn_02.dgn

1/15/2025

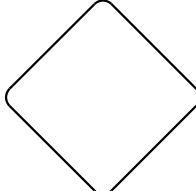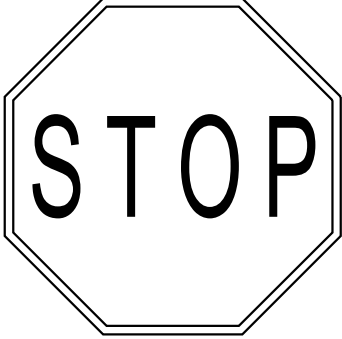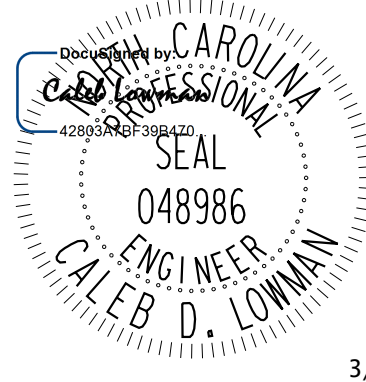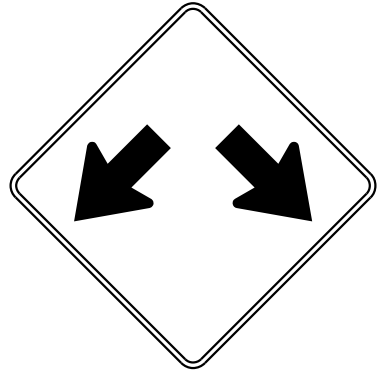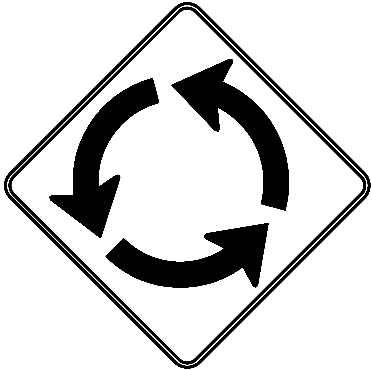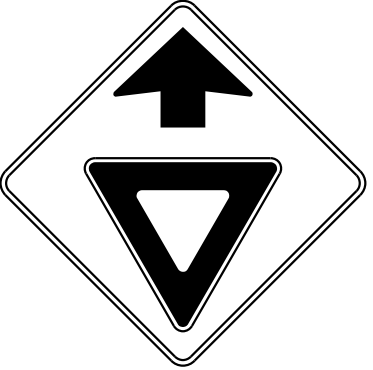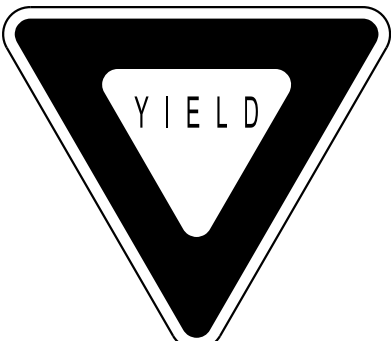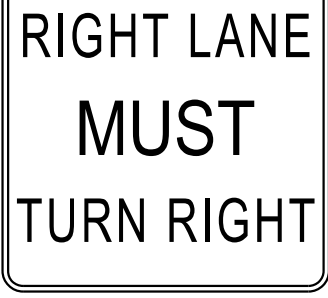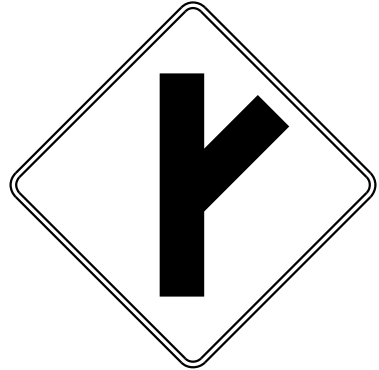401 QUANTITY REQ'D 22 24" x 30"  R4-7 ONE "U" POST PER SIGN	402 QUANTITY REQ'D 22 18" x 18"  OM1-3 ONE "U" POST PER SIGN	403 QUANTITY REQ'D 8 24" x 30"  R2-1 ONE "U" POST PER SIGN	404 QUANTITY REQ'D 1 36" x 36"  R1-1 ONE "U" POST	405 QUANTITY REQ'D 36 48" x 30"  R11-2 ONE "U" POST PER SIGN	406 QUANTITY REQ'D 8 36" x 36"  W11-2 (FYG) ONE "U" POST PER SIGN	TIP NO. R-5963A SHEET NO. SIGN-2 SEAL  3/20/2025 DOCUMENT NOT CONSIDERED FINAL UNLESS ALL SIGNATURES COMPLETED
407 QUANTITY REQ'D 18 24 X 12"  W16-7P (FYG) ONE "U" POST PER SIGN	408 QUANTITY REQ'D 10 30" x 30"  W11-2 (FYG) ONE "U" POST PER SIGN	409 QUANTITY REQ'D 1 24" x 24"  R3-4 ONE "U" POST	410 QUANTITY REQ'D 6 36" x 12"  R6-1R ONE "U" POST PER SIGN	411 QUANTITY REQ'D 3 30" x 30"  W12-1 ONE "U" POST PER SIGN	412 QUANTITY REQ'D 4 30" x 30"  R6-5P ONE "U" POST PER SIGN	413 QUANTITY REQ'D 4 18" x 18"  W13-1P ONE "U" POST PER SIGN
414 QUANTITY REQ'D 4 30" x 30"  W3-2 ONE "U" POST PER SIGN	415 QUANTITY REQ'D 4 36" x 36" x 36"  R1-2 ONE "U" POST PER SIGN	416 QUANTITY REQ'D 2 30" x 36"  R2-1 ONE "U" POST PER SIGN	417 QUANTITY REQ'D 5 36" x 36"  R3-7R ONE "U" POST PER SIGN	418 QUANTITY REQ'D 2 30" x 30"  W2-3 ONE "U" POST PER SIGN	419 QUANTITY REQ'D 5 30" x 30"  R1-1 ONE "U" POST PER SIGN	420 QUANTITY REQ'D 2 36" x 24"  R5-1A ONE "U" POST PER SIGN
421 QUANTITY REQ'D 2 30" x 30"  R5-1 ONE "U" POST PER SIGN	422 QUANTITY REQ'D 1 24" x 24"  R3-2 ONE "U" POST PER SIGN	423 QUANTITY REQ'D 1 30" x 36"  R3-5 ONE "U" POST PER SIGN				
				Kimley»Horn		TYPE "E" SIGNS



K:\RAL_Roadway\01036734 - R-5963A&B\Signing and Delination\Design\Sheets\R-5963A&B\ray_sgn_02A.dgn 1/15/2025

501501527545 M3-1P NORTH 15 501 M1-4 15 M1-4 501 ONE "U" POST PER SIGN	502 M2-1P JCT 15 501 87 M1-4 15 M1-4 501 M1-5 87 ONE "U" POST	503 M3-3P SOUTH 15 501 87 M1-4 15 M1-4 501 M1-5 87 M5-1P 87 M3-1P NORTH 15 501 87 M1-4 15 M1-4 501 M1-5 87 M5-1P 87 TWO "U" POSTS	504 M3-3P SOUTH 15 501 87 M1-4 15 M1-4 501 M1-5 87 M6-1P 87 M3-1P NORTH 15 501 87 M1-4 15 M1-4 501 M1-5 87 M6-1P 87 TWO "U" POSTS	505509517519537539554557 M2-1P JCT 15 501 M1-4 15 M1-4 501 ONE "U" POST PER SIGN	506 M3-1P NORTH 15 501 87 M1-4 15 M1-4 501 M1-5 87 M6-3P 87 M3-1P NORTH 15 501 87 M1-4 15 M1-4 501 M1-5 87 M6-3P 87 TWO "U" POSTS	TIP NO. R-5963A SHEET NO. SIGN-2A SEAL Seal of the State of North Carolina Professional Engineer CALEB D. LOWMAN 048986 3/20/2025 DOCUMENT NOT CONSIDERED FINAL UNLESS ALL SIGNATURES COMPLETED
507 M3-1P NORTH 15 501 87 M1-4 15 M1-4 501 M1-5 87 M6-3P 87 M3-1P NORTH 15 501 87 M1-4 15 M1-4 501 M1-5 87 M6-3P 87 TWO "U" POSTS	508 M3-1P NORTH 87 M1-5 87 ONE "U" POST	510 M3-1P SOUTH 15 501 87 M1-4 15 M1-4 501 M1-4 87 M5-1P 87 M3-3P SOUTH 15 501 87 M1-4 15 M1-4 501 M1-5 87 M6-3P 87 TWO "U" POSTS	511 M3-1P SOUTH 15 501 87 M1-4 15 M1-4 501 M1-4 87 M6-1P 87 M3-3P SOUTH 15 501 87 M1-4 15 M1-4 501 M1-5 87 M6-3P 87 TWO "U" POSTS	512 M3-3P SOUTH 15 501 87 M1-4 15 M1-4 501 M1-5 87 ONE "U" POST	513540541544 M3-1P NORTH 15 501 87 M1-4 15 M1-4 501 M1-4 87 M6-3P 87 M3-1P NORTH 15 501 87 M1-4 15 M1-4 501 M1-5 87 M6-3P 87 ONE "U" POST PER SIGN	514 M3-3P SOUTH 15 501 87 M1-4 15 M1-4 501 M1-4 87 M6-2P 87 M3-3P SOUTH 15 501 87 M1-4 15 M1-4 501 M1-4 87 M6-2P 87 ONE "U" POST
515 M3-1P NORTH 15 501 87 M1-4 15 M1-4 501 M1-4 87 M6-2P 87 M3-1P NORTH 15 501 87 M1-4 15 M1-4 501 M1-4 87 M6-2P 87 ONE "U" POST	516525551 M3-3P SOUTH 15 501 87 M1-4 15 M1-4 501 M1-4 87 M6-2P 87 M3-3P SOUTH 15 501 87 M1-4 15 M1-4 501 M1-4 87 M6-2P 87 ONE "U" POST PER SIGN	518 M3-3P SOUTH 15 501 87 M1-4 15 M1-4 501 M1-4 87 M5-3P 87 M3-3P NORTH 15 501 87 M1-4 15 M1-4 501 M1-4 87 M5-1P 87 TWO "U" POSTS	520 M3-1P NORTH 15 501 87 M1-4 15 M1-4 501 M1-4 87 M5-3P 87 M3-3P SOUTH 15 501 87 M1-4 15 M1-4 501 M1-4 87 M5-3P 87 TWO "U" POSTS	522542549 M3-3P SOUTH 15 501 87 M1-4 15 M1-4 501 M1-4 87 M6-3P 87 M3-3P SOUTH 15 501 87 M1-4 15 M1-4 501 M1-4 87 M6-3P 87 ONE "U" POST PER SIGN	523528 M2-1P JCT 15 501 87 M4-3P 15 M1-4 501 M1-4 87 M2-1P JCT 15 501 87 M4-3P 15 M1-4 501 M1-4 87 ONE "U" POST PER SIGN	524 M3-1P NORTH 15 501 87 M3-4P WEST 15 M4-3P BUSINESS 64 M1-4 64 M5-1P 64 M3-1P NORTH 15 501 87 M3-2P EAST 15 M4-3P BUSINESS 64 M1-4 64 M5-1P 64 THREE "U" POSTS
526 M3-1P NORTH 15 501 87 M3-4P WEST 15 M4-3P BUSINESS 64 M1-4 64 M6-1P 64 M3-1P NORTH 15 501 87 M3-2P EAST 15 M4-3P BUSINESS 64 M1-4 64 M6-1P 64 THREE "U" POSTS	529 M3-3P SOUTH 15 501 87 M3-2P EAST 15 M4-3P BUSINESS 64 M1-4 64 M5-1P 64 M3-3P SOUTH 15 501 87 M3-4P WEST 15 M4-3P BUSINESS 64 M1-4 64 M5-1P 64 THREE "U" POSTS	530 M3-3P SOUTH 15 501 87 M3-2P EAST 15 M4-3P BUSINESS 64 M1-4 64 M6-1P 64 M3-3P SOUTH 15 501 87 M3-4P WEST 15 M4-3P BUSINESS 64 M1-4 64 M6-1P 64 THREE "U" POSTS	531 M3-3P SOUTH 15 501 87 M1-4 15 M1-4 501 M1-4 87 M5-1P 87 M3-4P WEST 15 M3-3P NORTH 15 501 87 M1-4 15 M1-4 501 M1-4 87 M5-1P 87 THREE "U" POSTS	532 M3-3P SOUTH 15 501 87 M1-4 15 M1-4 501 M1-4 87 M6-1P 87 M3-4P WEST 15 M3-3P NORTH 15 501 87 M1-4 15 M1-4 501 M1-4 87 M6-1P 87 THREE "U" POSTS	533538 M3-4P WEST 15 M4-3P BUSINESS 64 M1-4 64 M3-4P WEST 15 M4-3P BUSINESS 64 M1-4 64 M3-4P WEST 15 M4-3P BUSINESS 64 M1-4 64 ONE "U" POST PER SIGN	534 M3-1P NORTH 15 501 87 M3-2P EAST 15 M4-3P BUSINESS 64 M1-4 64 M5-1P 64 M3-1P NORTH 15 501 87 M3-2P SOUTH 15 M4-3P BUSINESS 64 M1-4 64 M5-1P 64 THREE "U" POSTS
535 M3-1P NORTH 15 501 87 M1-4 15 M1-4 501 M1-4 87 M6-1P 87 M3-2P EAST 15 M4-3P BUSINESS 64 M1-4 64 M6-3P 64 M3-1P SOUTH 15 501 87 M1-4 15 M1-4 501 M1-4 87 M6-1P 87 THREE "U" POSTS	536 M3-2P EAST 15 M4-3P BUSINESS 64 M1-4 64 M3-2P EAST 15 M4-3P BUSINESS 64 M1-4 64 ONE "U" POST	543550 M3-3P SOUTH 15 501 87 M1-4 15 M1-4 501 M1-4 87 M6-1P 87 M3-1P NORTH 15 501 87 M1-4 15 M1-4 501 M1-4 87 M6-1P 87 TWO "U" POSTS PER SIGN	546559 M2-1P JCT 15 501 87 M1-4 15 M1-4 501 M1-4 87 M6-1P 87 M2-1P JCT 15 501 87 M1-4 15 M1-4 501 M1-4 87 M6-1P 87 ONE "U" POST PER SIGN	Kimley»Horn		TYPE "F" SIGNS


[illegible]

SIGN NUMBER:704, 707		BACKG COLOR: Green		DESIGN BY: O. NDIAYE		CHECKED BY: C. LOWMAN		Nov 20, 2024																																								
TYPE: A		COPY COLOR: White		PROJECT ID: R-5963A		LOCATION: VARIES		DIV: 8																																								
QUANTITY: 2		<table><tr><td>SYMBOL</td><td>X</td><td>Y</td><td>WID</td><td>HT</td></tr><tr><td></td><td></td><td></td><td></td><td></td></tr><tr><td></td><td></td><td></td><td></td><td></td></tr><tr><td></td><td></td><td></td><td></td><td></td></tr><tr><td></td><td></td><td></td><td></td><td></td></tr><tr><td></td><td></td><td></td><td></td><td></td></tr><tr><td></td><td></td><td></td><td></td><td></td></tr><tr><td></td><td></td><td></td><td></td><td></td></tr></table>		SYMBOL	X	Y	WID	HT																																				12'-0" 15" 16"EM 15" 10"ET 16" 14.5" 115" 14.5" 6'-0" 4.3.5" 15"ET 13.5" BORDER R=9" TH=2" Pittsboro 1 MILE Panel Style: guide_exp_advance_oss M.U.T.C.D.: 2009 Edition				
SYMBOL	X	Y	WID	HT																																												
SIGN WIDTH: 12'-0"																																																
HEIGHT: 6'-0"																																																
TOTAL AREA: 72.0 Sq.Ft.																																																
BORDER TYPE: FLUSH																																																
RECESS: 0"																																																
WIDTH: 2"																																																
RADII: 9"																																																
NO. Z BARS: 2		MAT'L: 0.063" (1.6 mm) ALUMINUM																																														
LENGTH: 136.0		0.080" (2.0 mm) ALUMINUM																																														
0.125" (3.2 mm) ALUMINUM																																																
USE NOTES: 1 & 2																																																
1. Legend and border(except those that are colored black) shall be direct applied Grade C sheeting.																																																
2. Background shall be Grade C reflective sheeting.																																																
Spacing Factor is 1 unless specified otherwise																																																
LETTER POSITIONS																																																
Letter spacings are to start of next letter																																																
Series/Size Text Length																																																
EM 2000 115																																																
E 2000 52.6																																																
FILENAME: R-5963A&8_GuideSign																																																
NORTH CAROLINA D.O.T. SIGN DETAIL																																																

[illegible][illegible]

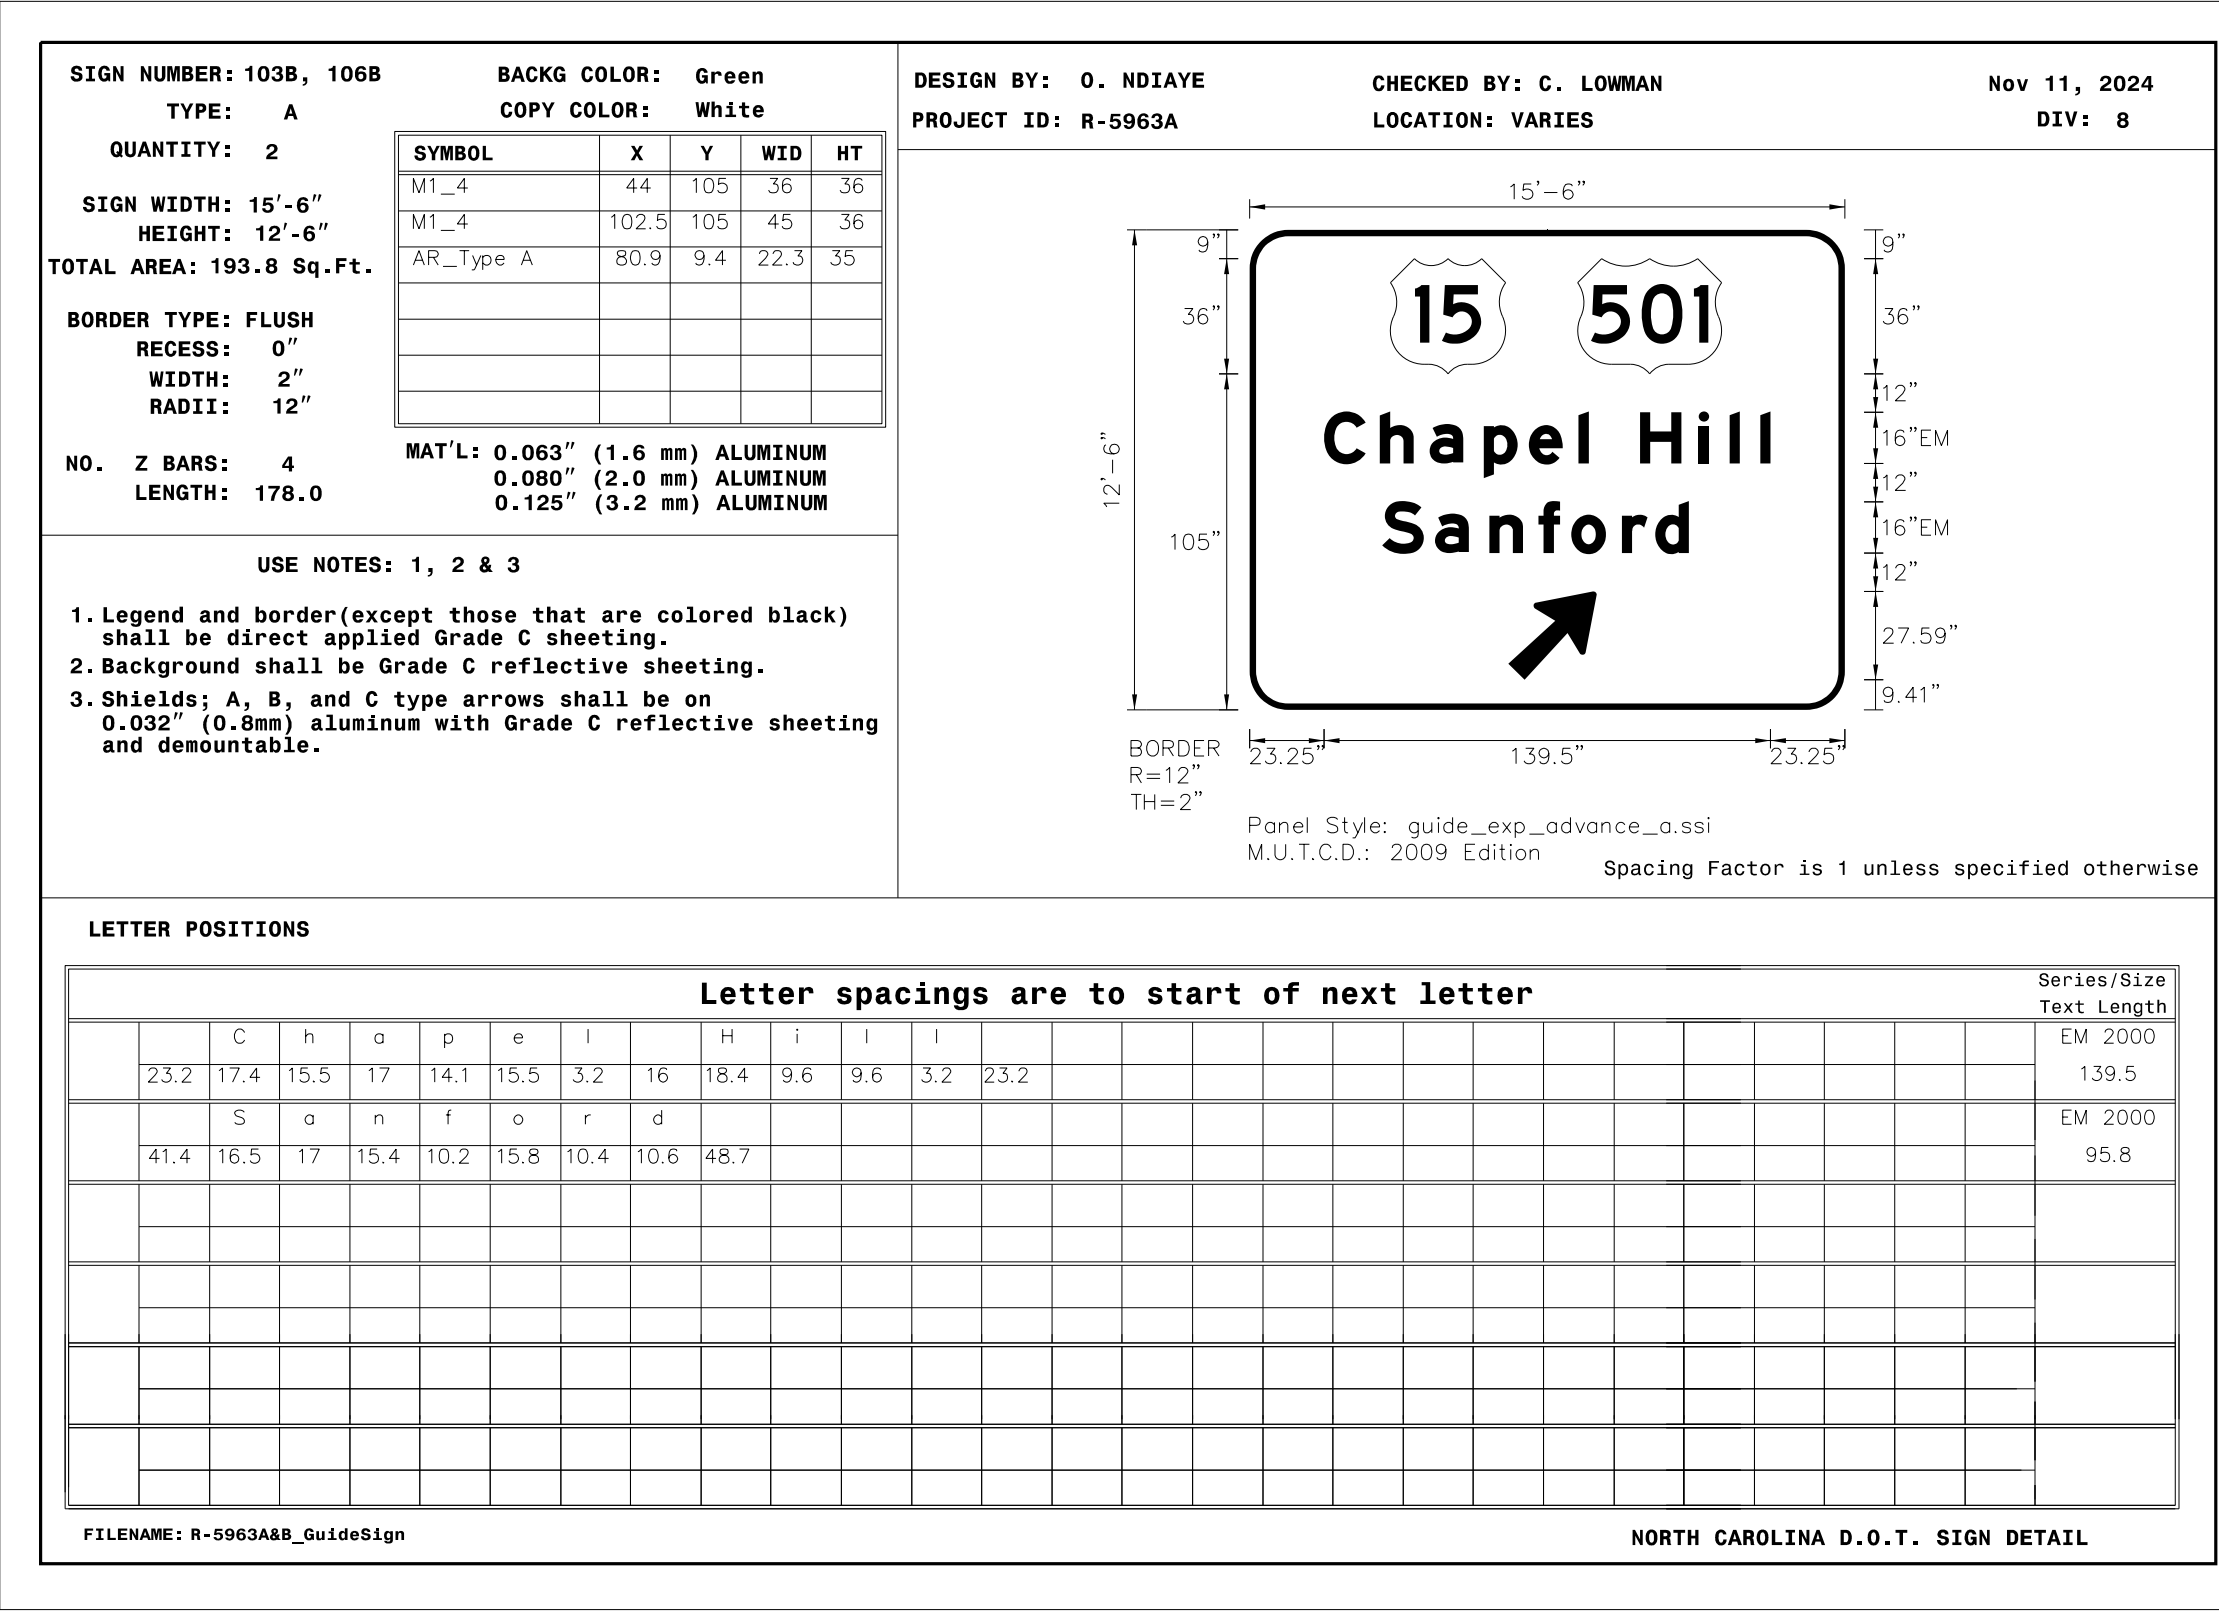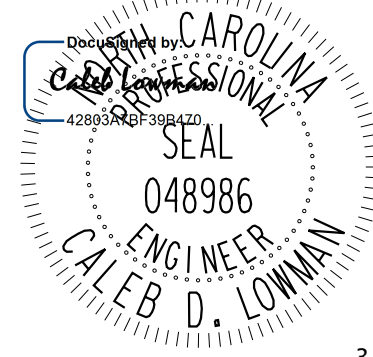

SEAL

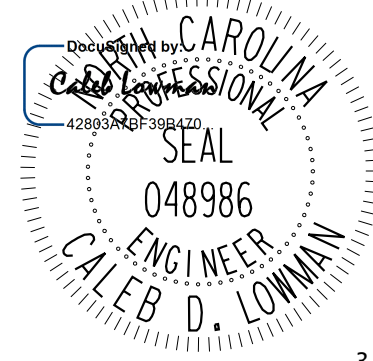

3/20/2025

DOCUMENT NOT CONSIDERED FINAL
UNLESS ALL SIGNATURES COMPLETED

SIGN NUMBER: 301
TYPE: D
QUANTITY: 1
SIGN WIDTH: 5'-6"
HEIGHT: 2'-6"
TOTAL AREA: 13.8 Sq.Ft.
BORDER TYPE: FLUSH
RECESS: 0"
WIDTH: 0.75"
RADII: 3"
NO. Z BARS:
LENGTH:

BACKG COLOR: Green
COPY COLOR: White
SYMBOL
X
Y
WID
HT
AR_Type D 57.1 19.3 6 9
AR_Type D 5.9 4.7 6 9
MAT'L: 0.063" (1.6 mm) ALUMINUM
0.080" (2.0 mm) ALUMINUM
0.125" (3.2 mm) ALUMINUM

DESIGN BY: O. Ndiaye
PROJECT ID: R-5963A
CHECKED BY: C. Lowman
LOCATION: -L- STA 11+98
Nov 12, 2024
DIV: 8

2'-6"

5'-6"

4.7"

6"

9.4"

6"

3.9"

7.5"

51"

7.5"

5.51"

6"

3.12"

0.75"

3.92"

6"

4.7"

BORDER
R=3"
TH=0.75"

Panel Style: guide_con_destination.ssi
M.U.T.C.D.: 2009 Edition

Spacing Factor is 1 unless specified otherwise

USE NOTES: 1 & 2
1. Legend and border (except those that are colored black) shall be direct applied Grade C sheeting.
2. Background shall be Grade C reflective sheeting.

LETTER POSITIONS
Letter spacings are to start of next letter
Series/Size
Text Length
D 2000
30.7
D 2000
27.2
FILENAME: R-5963A8B_GuideSign
NORTH CAROLINA D.O.T. SIGN DETAIL

SIGN NUMBER: 302
TYPE: D
QUANTITY: 1
SIGN WIDTH: 6'-0"
HEIGHT: 2'-6"
TOTAL AREA: 15 Sq.Ft.
BORDER TYPE: FLUSH
RECESS: 0"
WIDTH: 0.75"
RADII: 3"
NO. Z BARS:
LENGTH:

BACKG COLOR: Green
COPY COLOR: White
SYMBOL
X
Y
WID
HT
AR_Type D 8.1 19.3 6 9
AR_Type D 63.5 4.7 6 9
MAT'L: 0.063" (1.6 mm) ALUMINUM
0.080" (2.0 mm) ALUMINUM
0.125" (3.2 mm) ALUMINUM

DESIGN BY: O. NDIAYE
PROJECT ID: R-5963A
CHECKED BY: C. LOWMAN
LOCATION: -Y1- STA 17+27
Nov 12, 2024
DIV: 8

2'-6"

6'-0"

3.1"

9"

7.2"

6"

4.7"

7.5"

57"

7.5"

4.7"

6"

4.02"

0.75"

4.01"

6"

4.52"

BORDER
R=3"
TH=0.75"

Panel Style: guide_con_destination.ssi
M.U.T.C.D.: 2009 Edition

Spacing Factor is 1 unless specified otherwise

USE NOTES: 1 & 2
1. Legend and border (except those that are colored black) shall be direct applied Grade C sheeting.
2. Background shall be Grade C reflective sheeting.

LETTER POSITIONS
Letter spacings are to start of next letter
Series/Size
Text Length
D 2000
30.7
D 2000
40.6
FILENAME: R-5963A8B_GuideSign
NORTH CAROLINA D.O.T. SIGN DETAIL

SIGN NUMBER: 303
TYPE: D
QUANTITY: 1
SIGN WIDTH: 6'-0"
HEIGHT: 3'-6"
TOTAL AREA: 21 Sq.Ft.
BORDER TYPE: FLUSH
RECESS: 0"
WIDTH: 0.75"
RADII: 3"
NO. Z BARS:
LENGTH:

BACKG COLOR: Green
COPY COLOR: White
SYMBOL
X
Y
WID
HT
AR_Type D 9.8 30.2 6 9
AR_FISHOOK 7.9 15.6 9.9 10.8
AR_Type D 55.3 4.3 6 9
MAT'L: 0.063" (1.6 mm) ALUMINUM
0.080" (2.0 mm) ALUMINUM
0.125" (3.2 mm) ALUMINUM

DESIGN BY: O. NDIAYE
PROJECT ID: R-5963A
CHECKED BY: C. LOWMAN
LOCATION: -L- STA 75+12
Nov 12, 2024
DIV: 8

3'-6"

6'-0"

2.8"

9"

3.8"

10.8"

5.4"

6"

4.2"

7.5"

57"

7.5"

4.3"

6"

3.48"

3.49"

6"

3.53"

3.49"

6"

4.25"

BORDER
R=3"
TH=0.75"

Panel Style: guide_con_circular.ssi
M.U.T.C.D.: 2009 Edition

Spacing Factor is 1 unless specified otherwise

USE NOTES: 1 & 2
1. Legend and border (except those that are colored black) shall be direct applied Grade C sheeting.
2. Background shall be Grade C reflective sheeting.

LETTER POSITIONS
Letter spacings are to start of next letter
Series/Size
Text Length
D 2000
40.6
D 2000
30.7
D 2000
30.1
FILENAME: R-5963A8B_GuideSign
NORTH CAROLINA D.O.T. SIGN DETAIL

SIGN NUMBER: 304
TYPE: D
QUANTITY: 1
SIGN WIDTH: 5'-0"
HEIGHT: 1'-6"
TOTAL AREA: 7.5 Sq.Ft.
BORDER TYPE: FLUSH
RECESS: 0"
WIDTH: 0.75"
RADII: 1.5"
NO. Z BARS:
LENGTH:

BACKG COLOR: Green
COPY COLOR: White
SYMBOL
X
Y
WID
HT
AR_Type D 47.9 5.4 6 9
MAT'L: 0.063" (1.6 mm) ALUMINUM
0.080" (2.0 mm) ALUMINUM
0.125" (3.2 mm) ALUMINUM

DESIGN BY: O. NDIAYE
PROJECT ID: R-5963A
CHECKED BY: C. LOWMAN
LOCATION: -Y7- STA 15+64
Nov 12, 2024
DIV: 8

1'-6"

5'-0"

6"

6"

6"

6"

6.5"

47"

6.5"

5.42"

7.15"

5.43"

BORDER
R=1.5"
TH=0.75"

Panel Style: guide_con_destination.ssi
M.U.T.C.D.: 2009 Edition

Spacing Factor is 1 unless specified otherwise

USE NOTES: 1 & 2
1. Legend and border (except those that are colored black) shall be direct applied Grade C sheeting.
2. Background shall be Grade C reflective sheeting.

LETTER POSITIONS
Letter spacings are to start of next letter
Series/Size
Text Length
D 2000
30.1
D 2000
30.1
FILENAME: R-5963A8B_GuideSign
NORTH CAROLINA D.O.T. SIGN DETAIL

[illegible][illegible]

[illegible]

SIGN NUMR: _____ TYPE: F Ground QUANTITY: 1 SIGN WIDTH: 1'-9" HEIGHT: 1'-9" TOTAL AREA: 3.1 Sq.Ft.	BACKG. COLOR: White COPY COLOR: Black	DESIGN BY: _____ PROJECT ID: _____	CHK BY: _____ DIV: _____ STD #: _____ DATE: _____
--	--	---------------------------------------	--

MAT'L: 0.063" ALUMINUM

SYMBOL	X	Y	WID	HT
u arrow	3.7	3.5	12.7	13.9

BORDER R=1.5"
 TH=0.63"
 IN=0.38"

NOTES:

- Legend and border shall be direct applied
Non-reflective sheeting.
- Background shall be Grade C reflective sheeting.

Arrow Details

ARROW DIMENSIONS (INCHES)	F	G	H	M	N	P	Q	R
	2.625	2.625	8.659	5.25	3	5.25	0.375	0.5

Spacing Factor is 1 unless specified otherwise

FILENAME: GSENG


SEAL

Document No. 048986
Carroll County, Maryland
42093 (Rev. 10-20-07)

SEAL
048986
ENGINEER
CALEB D. LOWMAN

3/20/2025

**DOCUMENT NOT CONSIDERED FINAL
UNLESS ALL SIGNATURES COMPLETED**

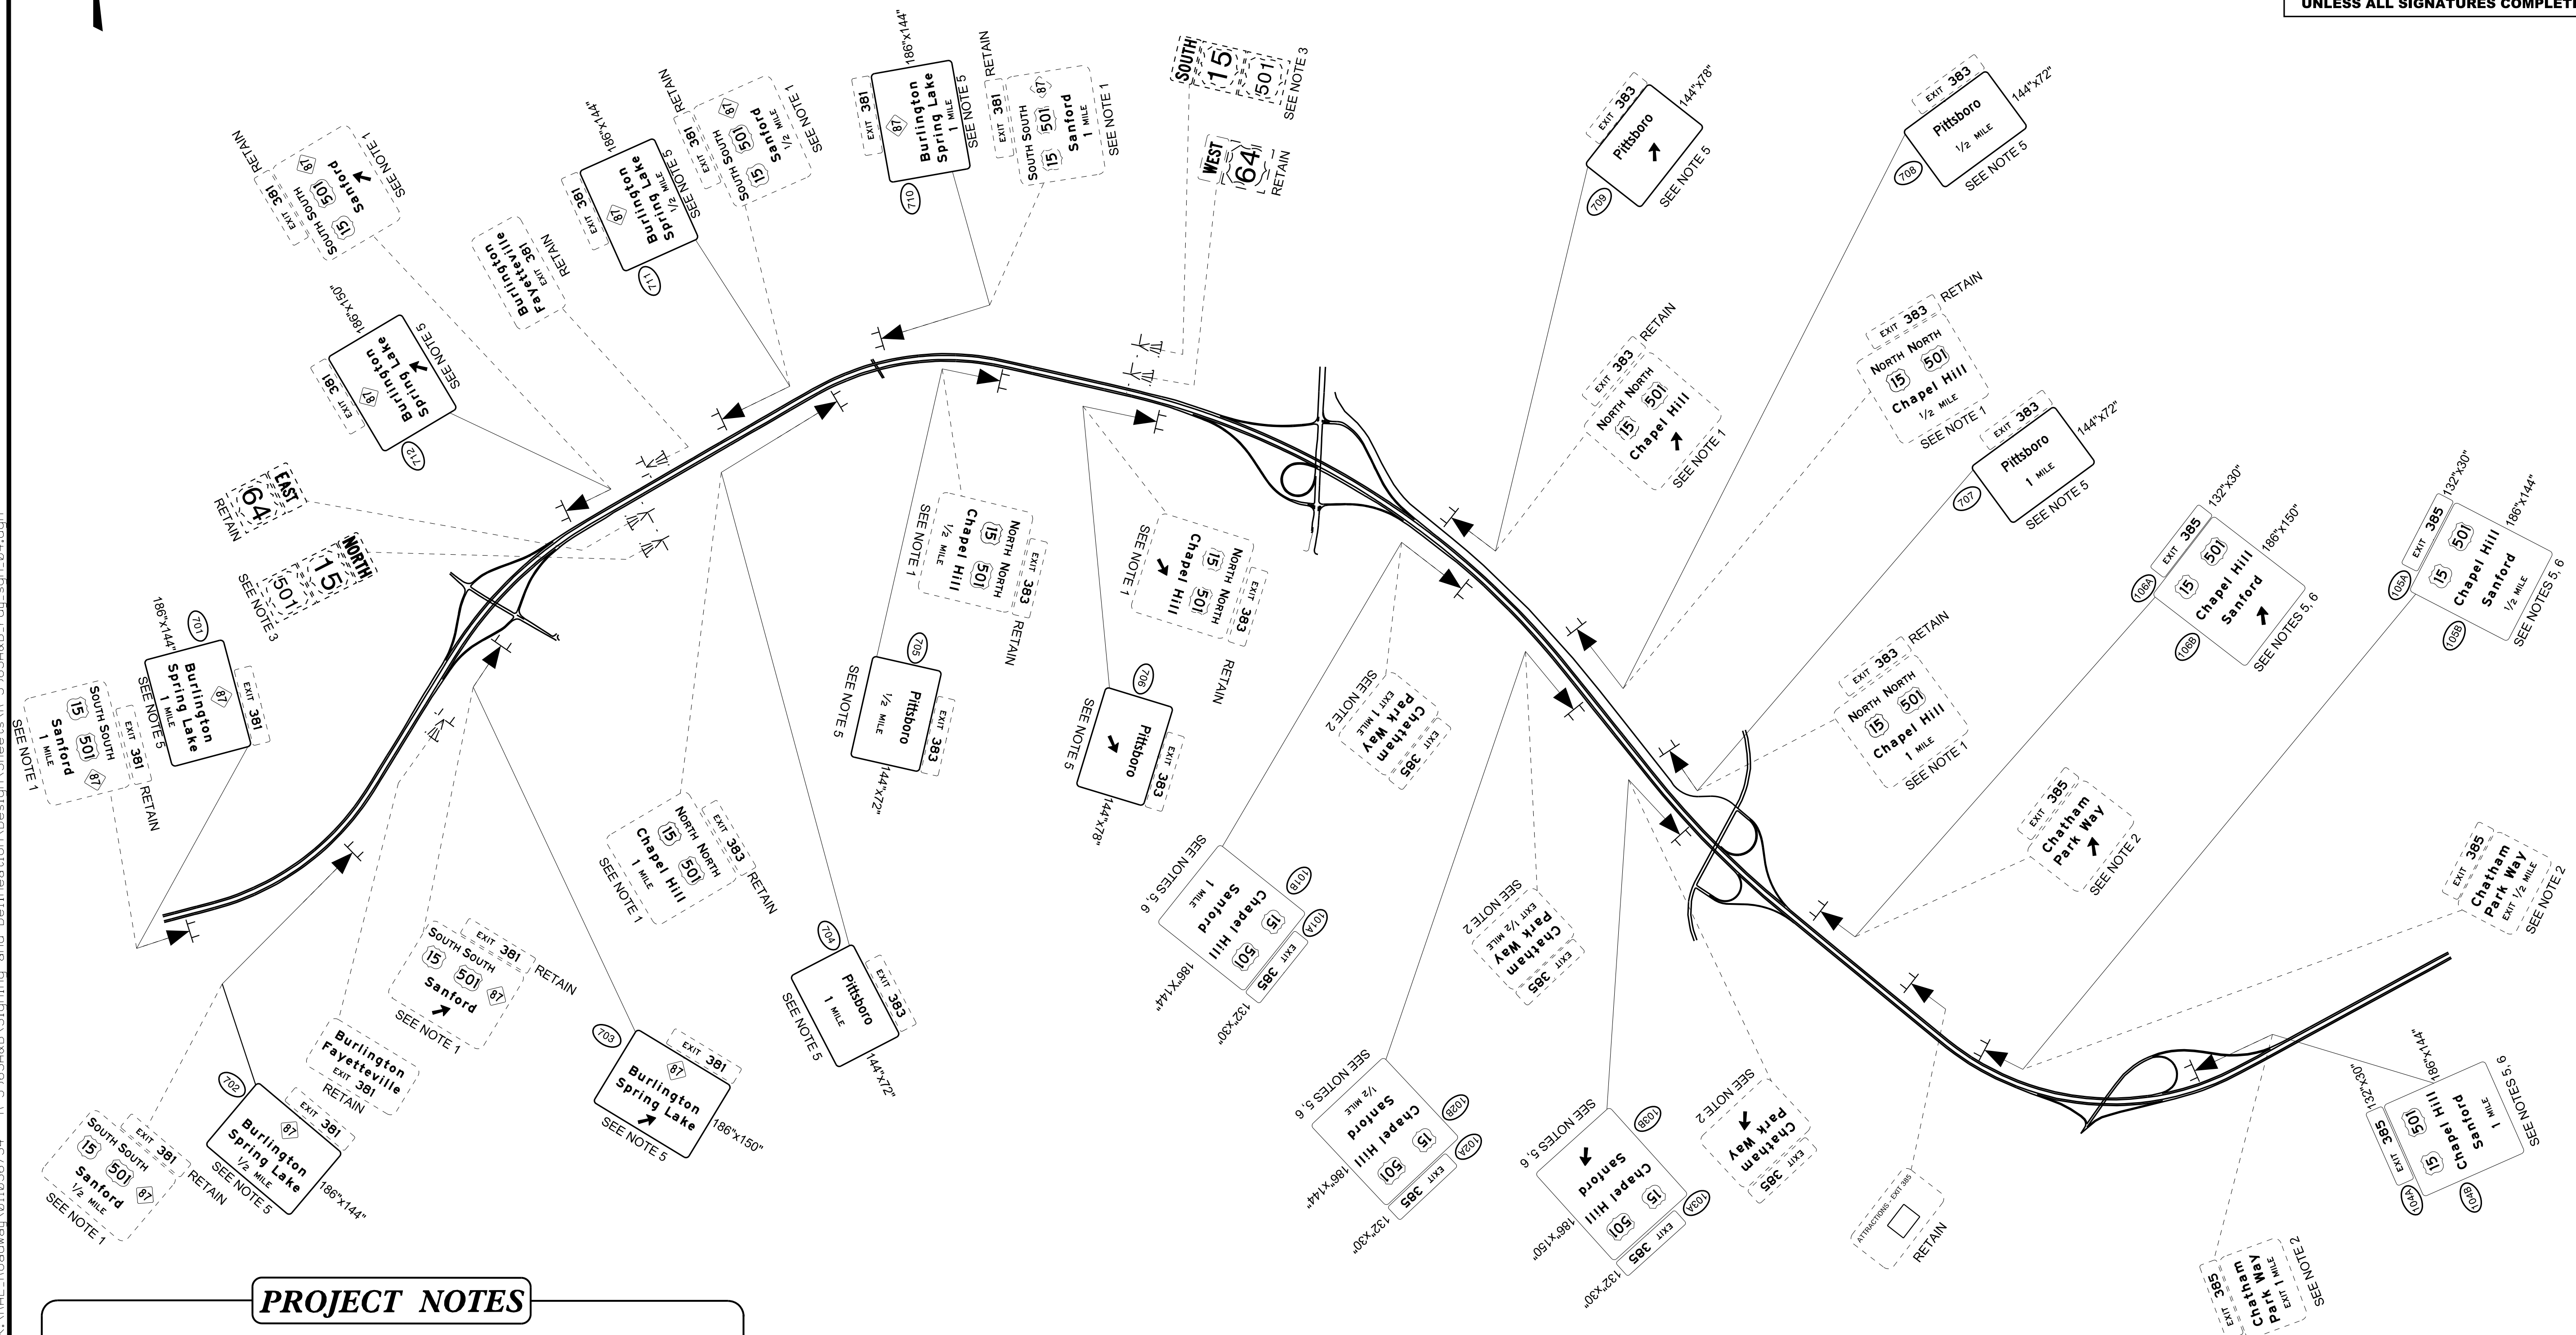

1. DISPOSAL OF SIGN, A (GROUND MOUNTED)
2. DISPOSAL OF SIGN SYSTEM, STEEL BEAM
3. DISPOSAL OF SIGN SYSTEM, U-CHANNEL
4. SIGN ERECTION, RELOCATE TYPE B (GROUND MOUNTED)
5. SIGN ERECTION, TYPE A (GROUND MOUNTED)
6. SIGN ERECTION, TYPE B (GROUND MOUNTED)

SIGNING PLAN SHEETS

TIP NO.
R-5963A

SHEET NO.
SIGN-5


Kimley»Horn

421 FAYETTEVILLE STREET, SUITE 600
RALEIGH, N.C. 27601. NC LICENSE #F-0102

SEAL

Professional Engineer
CALEB D. LOWMAN
048986
3/20/2025

DOCUMENT NOT CONSIDERED FINAL
UNLESS ALL SIGNATURES COMPLETED

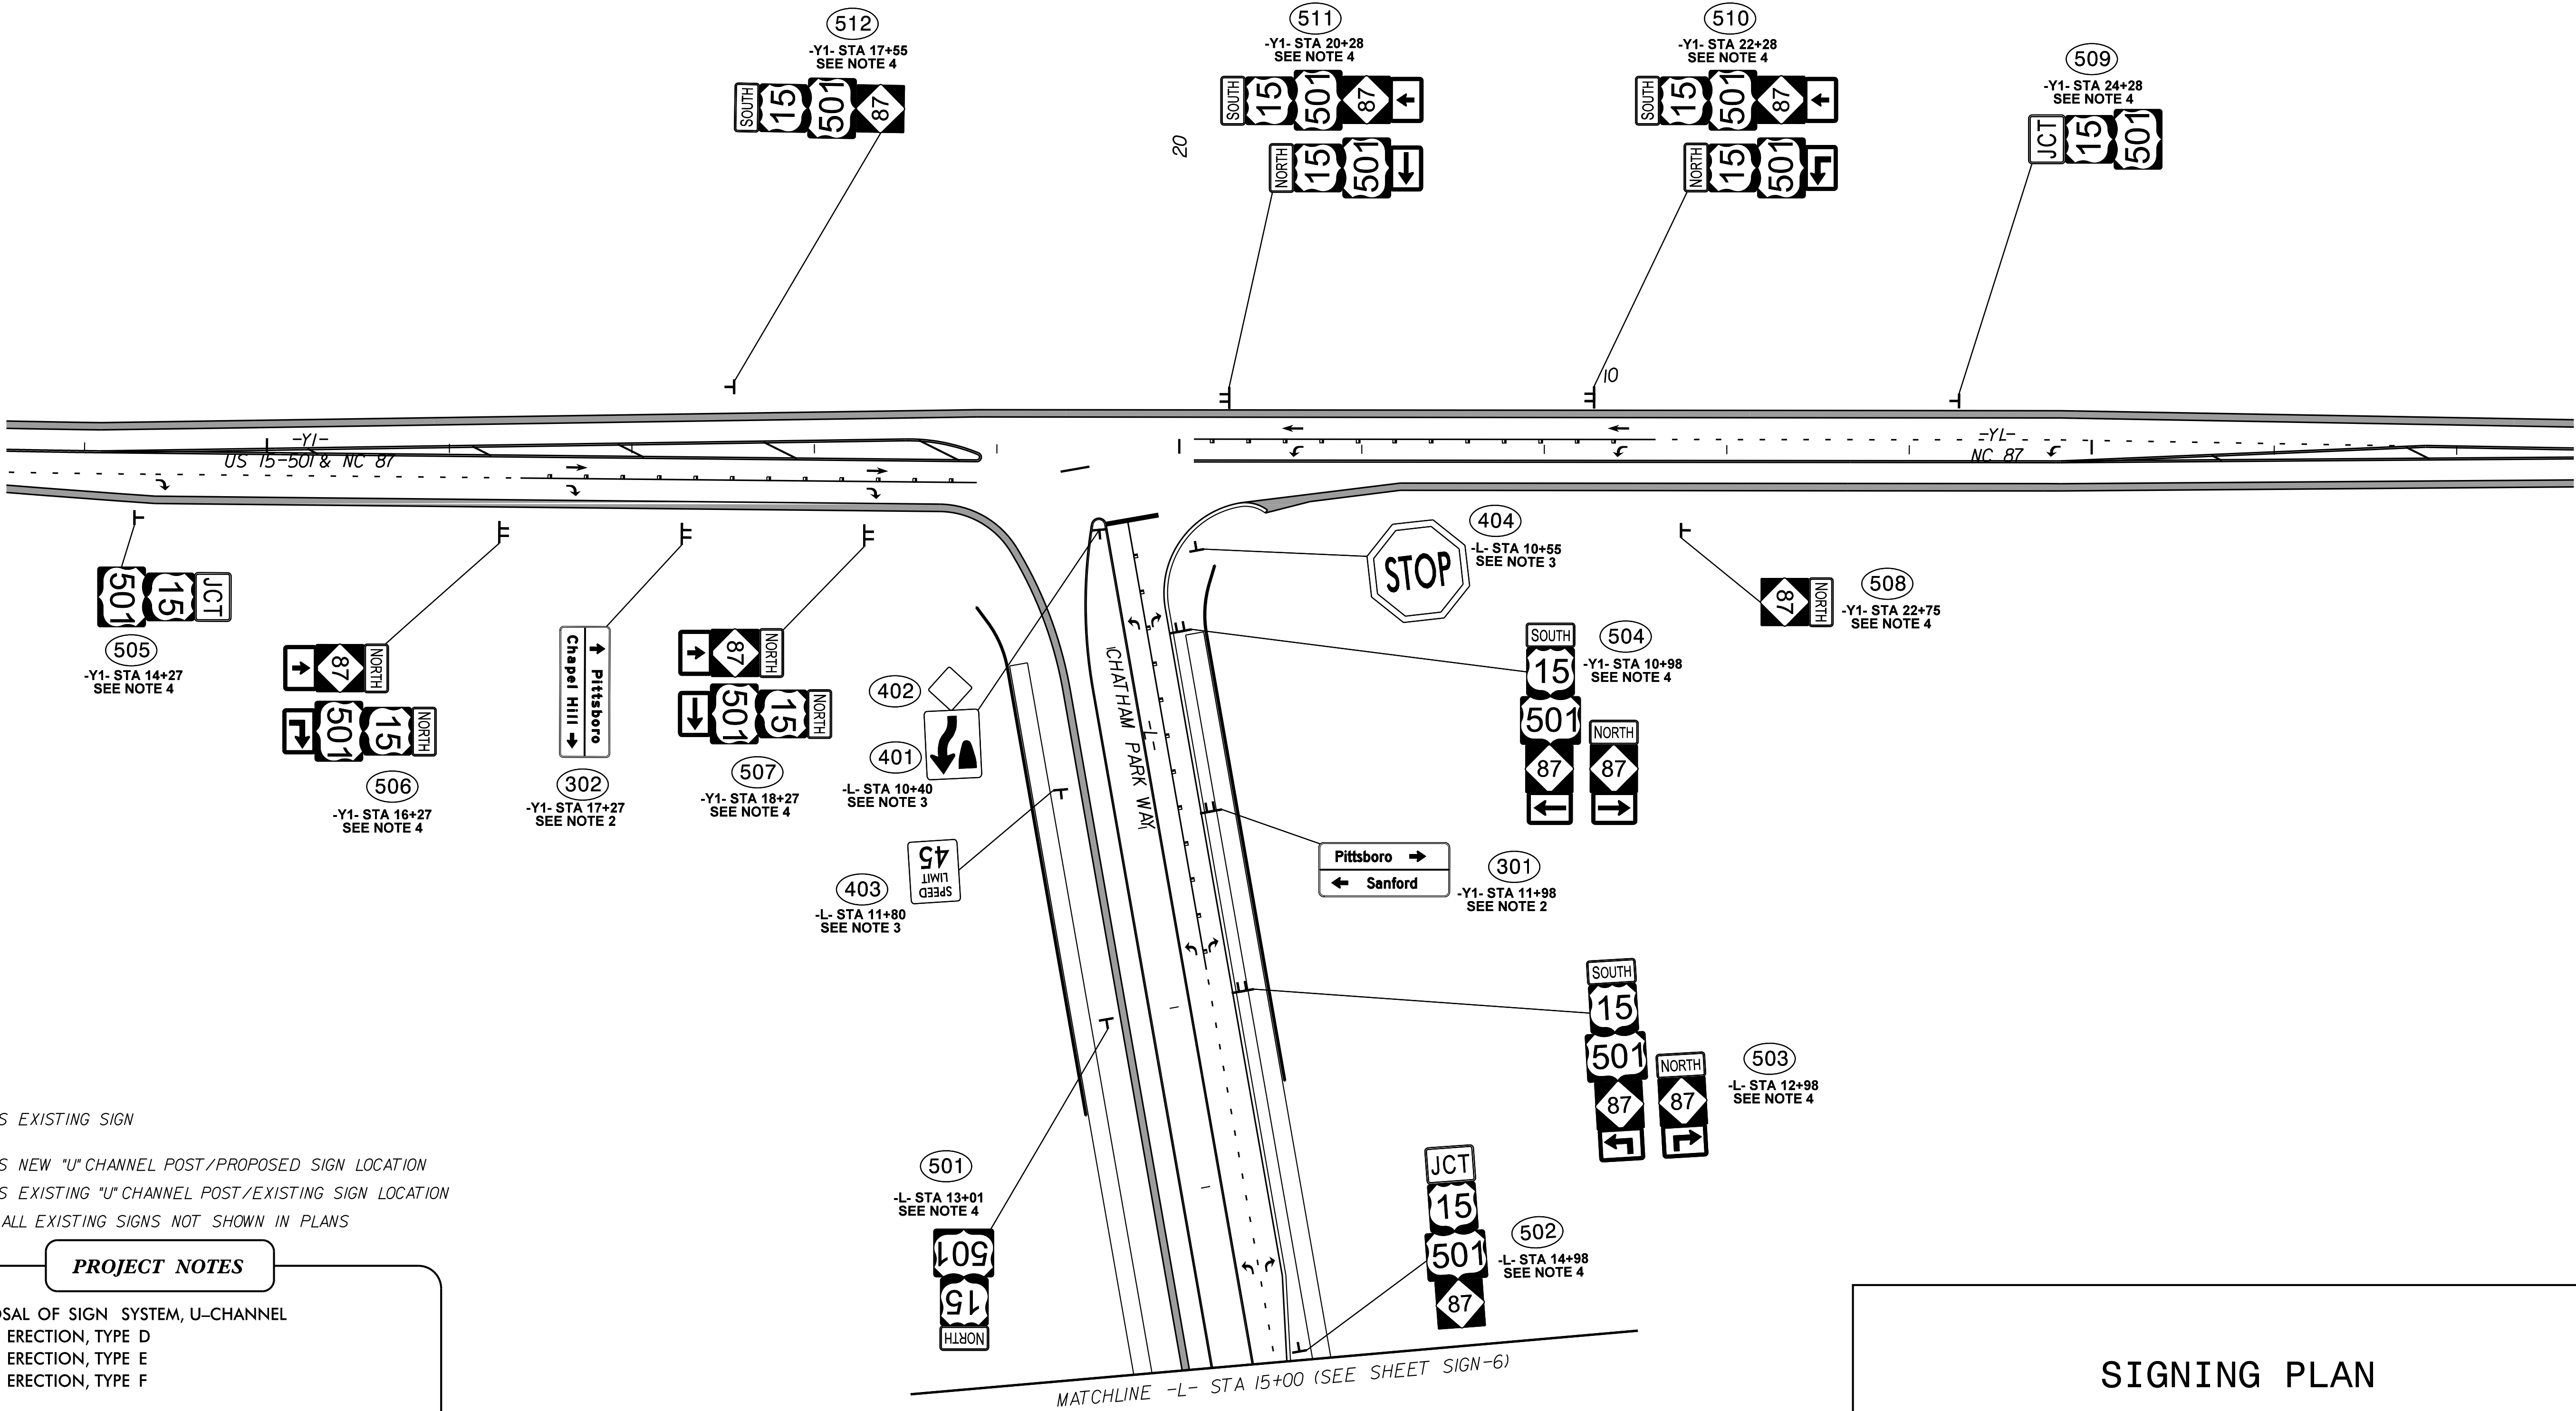

- DENOTES EXISTING SIGN
- DENOTES NEW "U" CHANNEL POST/PROPOSED SIGN LOCATION
- DENOTES EXISTING "U" CHANNEL POST/EXISTING SIGN LOCATION
- RETAIN ALL EXISTING SIGNS NOT SHOWN IN PLANS


PROJECT NOTES	
1	DISPOSAL OF SIGN SYSTEM, U-CHANNEL
2	SIGN ERECTION, TYPE D
3	SIGN ERECTION, TYPE E
4	SIGN ERECTION, TYPE F

SIGNING PLAN

Kimley »Horn

421 FAYETTEVILLE STREET, SUITE 600
RALEIGH, N.C. 27601. NC LICENSE #F-0102


TIP NO. SHEET NO.
R-5963A SIGN-6

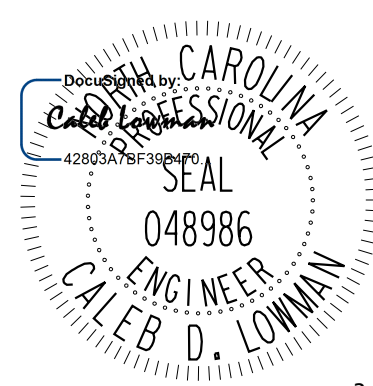

3/20/2025

DOCUMENT NOT CONSIDERED FINAL
UNLESS ALL SIGNATURES COMPLETED

NAD 83 / NA 2011

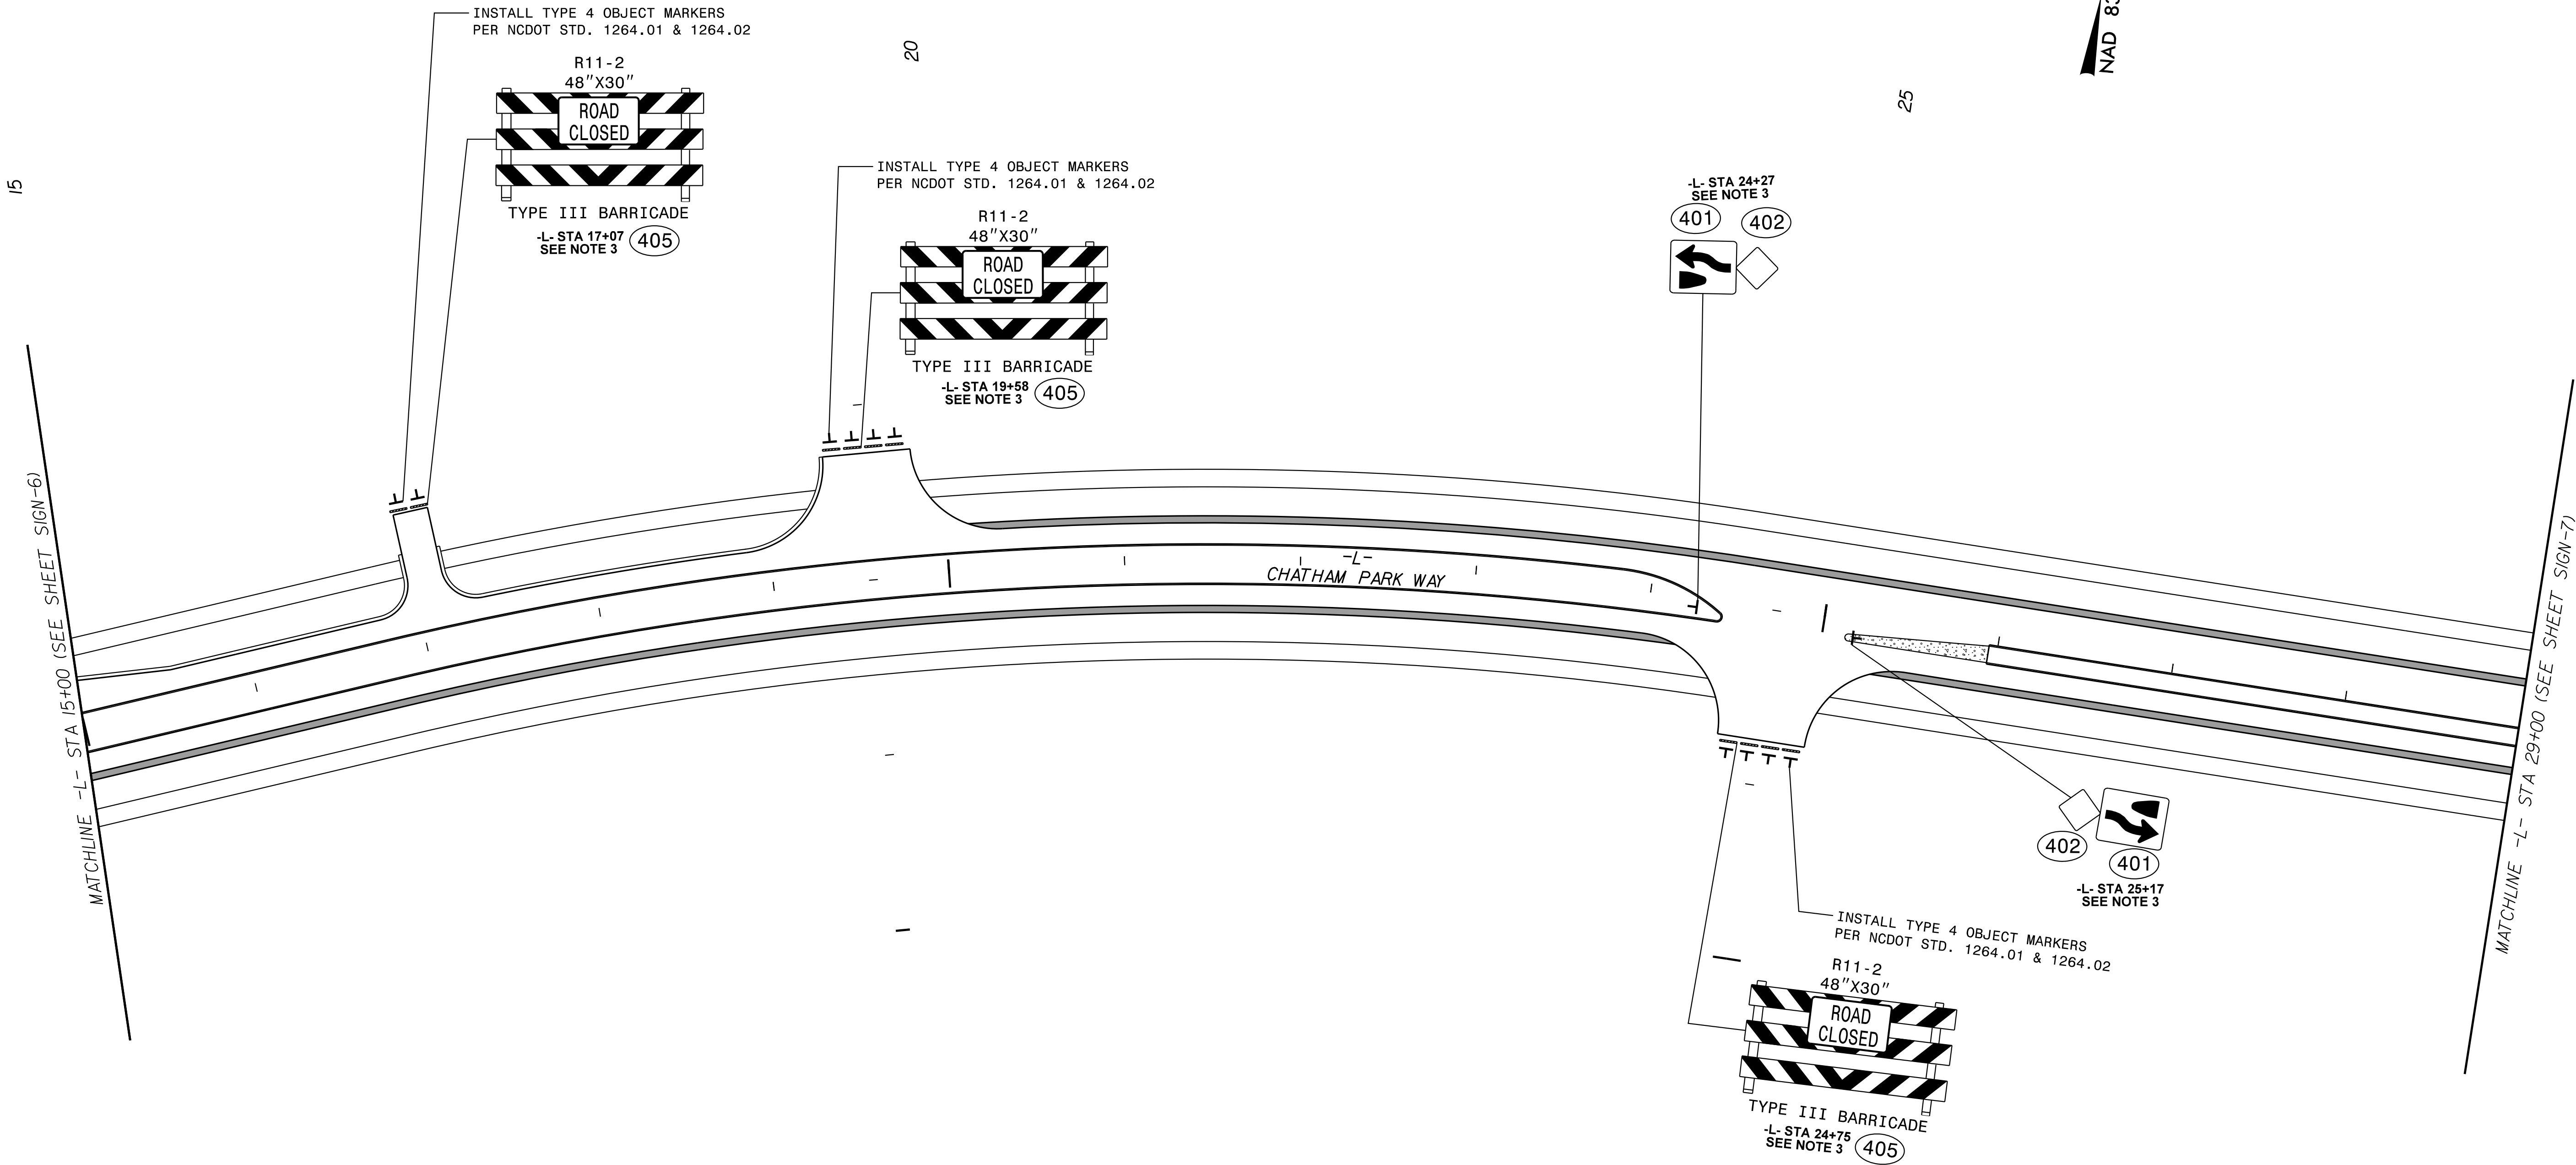

- DENOTES EXISTING SIGN
- DENOTES NEW "U" CHANNEL POST/PROPOSED SIGN LOCATION
- DENOTES EXISTING "U" CHANNEL POST/EXISTING SIGN LOCATION
- RETAIN ALL EXISTING SIGNS NOT SHOWN IN PLANS

PROJECT NOTES

- DISPOSAL OF SIGN SYSTEM, U-CHANNEL
- SIGN ERECTION, TYPE D
- SIGN ERECTION, TYPE E
- SIGN ERECTION, TYPE F

SIGNING PLAN

Kimley »Horn

421 FAYETTEVILLE STREET, SUITE 600
RALEIGH, N.C. 27601. NC LICENSE #F-0102


TIP NO.

R-5963A

SHEET NO.




SIGN-7

SEAL

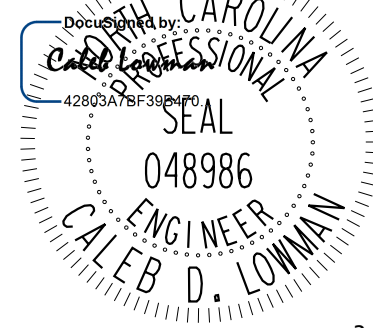

3/20/2025

DOCUMENT NOT CONSIDERED FINAL
UNLESS ALL SIGNATURES COMPLETED

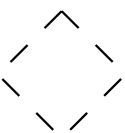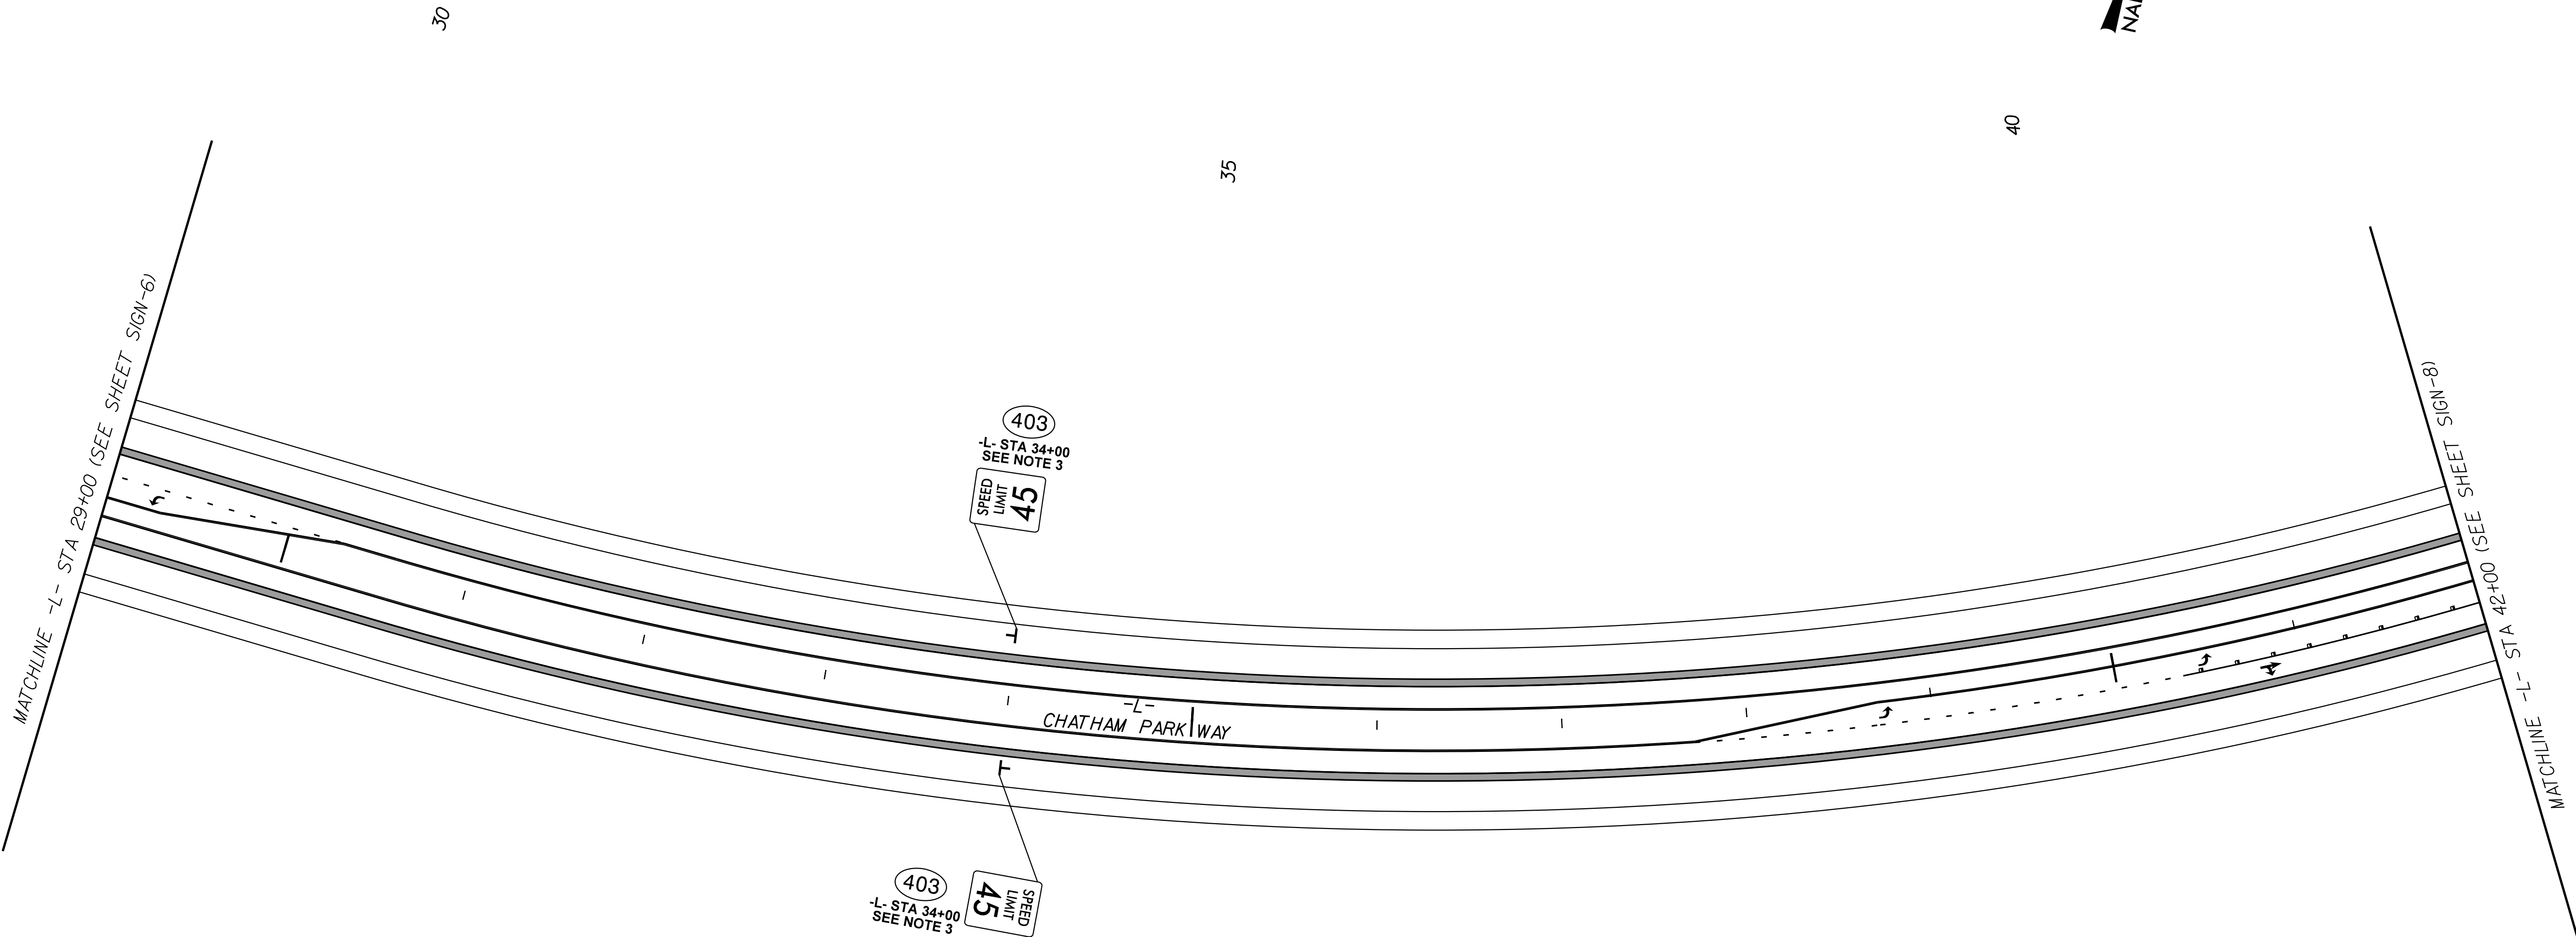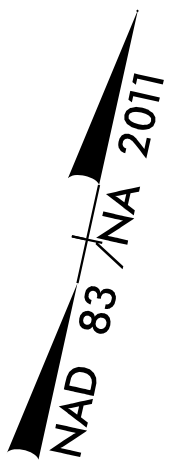

DENOTES EXISTING SIGN



DENOTES NEW "U" CHANNEL POST/PROPOSED SIGN LOCATION



DENOTES EXISTING "U" CHANNEL POST/EXISTING SIGN LOCATION

RETAIN ALL EXISTING SIGNS NOT SHOWN IN PLANS

PROJECT NOTES

- 1 DISPOSAL OF SIGN SYSTEM, U-CHANNEL
- 2 SIGN ERECTION, TYPE D
- 3 SIGN ERECTION, TYPE E
- 4 SIGN ERECTION, TYPE F

SIGNING PLAN

Kimley »Horn

421 FAYETTEVILLE STREET, SUITE 600
RALEIGH, N.C. 27601. NC LICENSE #F-0102


TIP NO.

R-5963A

SHEET NO.



SIGN-8

SEAL

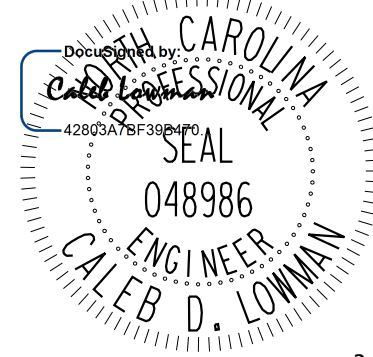

3/20/2025

DOCUMENT NOT CONSIDERED FINAL
UNLESS ALL SIGNATURES COMPLETED

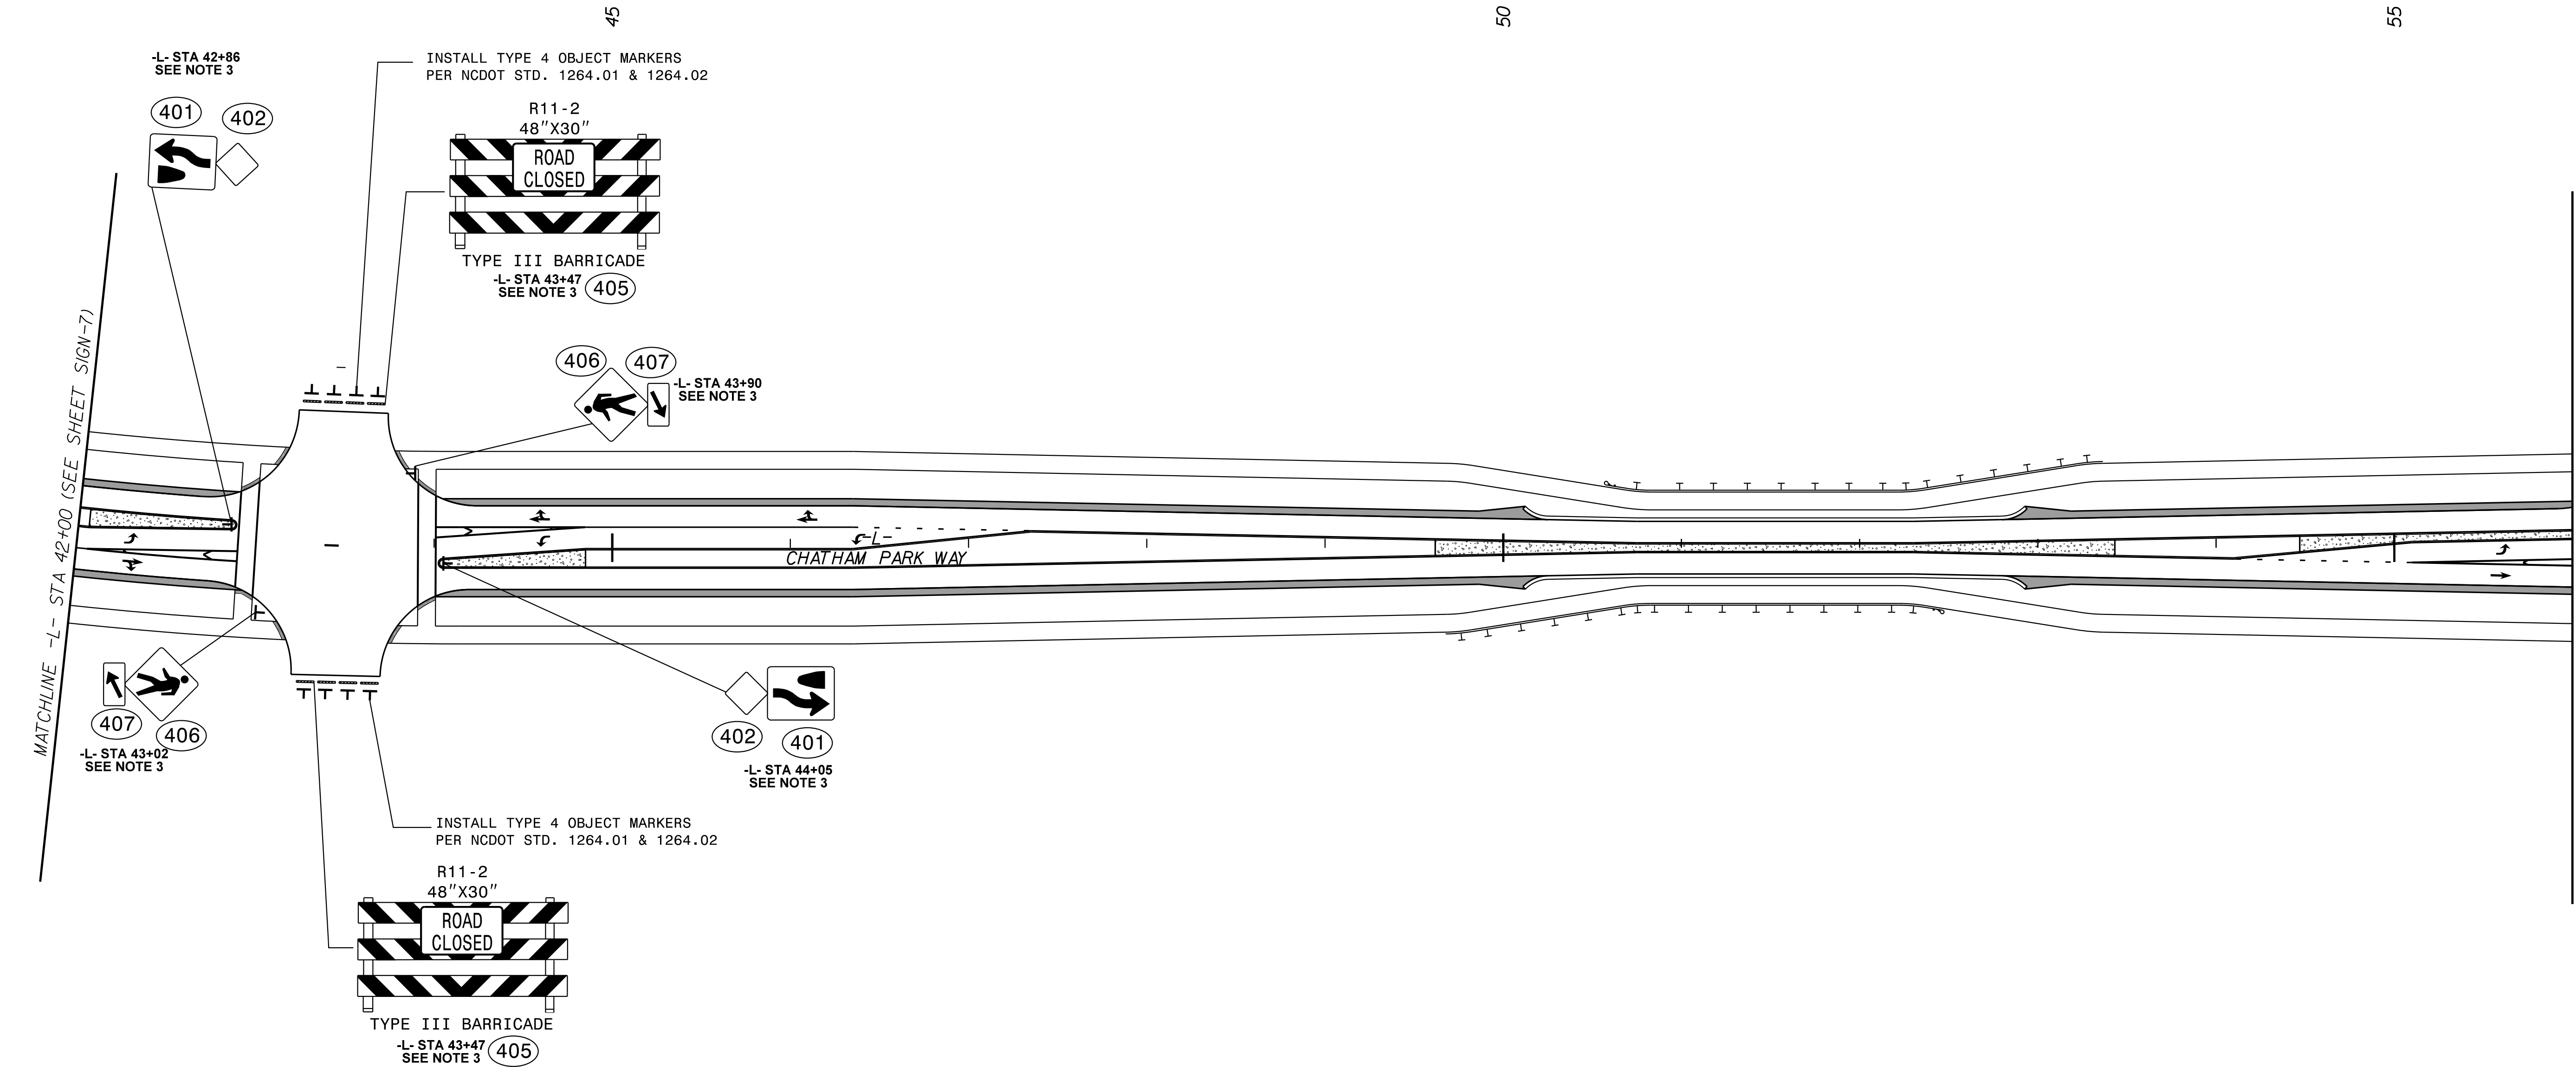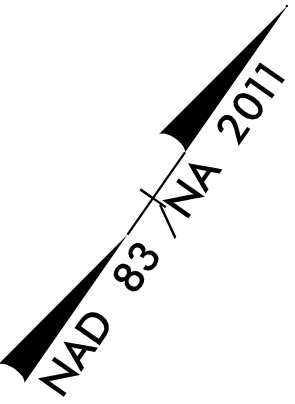

- DENOTES EXISTING SIGN
- DENOTES NEW "U" CHANNEL POST/PROPOSED SIGN LOCATION
- DENOTES EXISTING "U" CHANNEL POST/EXISTING SIGN LOCATION
- RETAIN ALL EXISTING SIGNS NOT SHOWN IN PLANS

PROJECT NOTES

- 1 DISPOSAL OF SIGN SYSTEM, U-CHANNEL
- 2 SIGN ERECTION, TYPE D
- 3 SIGN ERECTION, TYPE E
- 4 SIGN ERECTION, TYPE F

SIGNING PLAN

Kimley »Horn

421 FAYETTEVILLE STREET, SUITE 600
RALEIGH, N.C. 27601. NC LICENSE #F-0102


TIP NO.

R-5963A

SHEET NO.



SIGN-9

SEAL

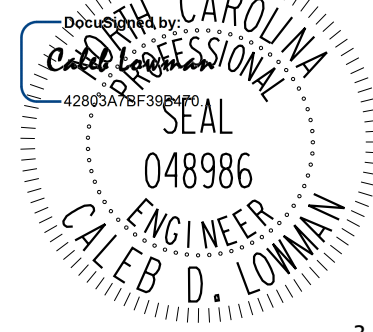

3/20/2025

DOCUMENT NOT CONSIDERED FINAL
UNLESS ALL SIGNATURES COMPLETED

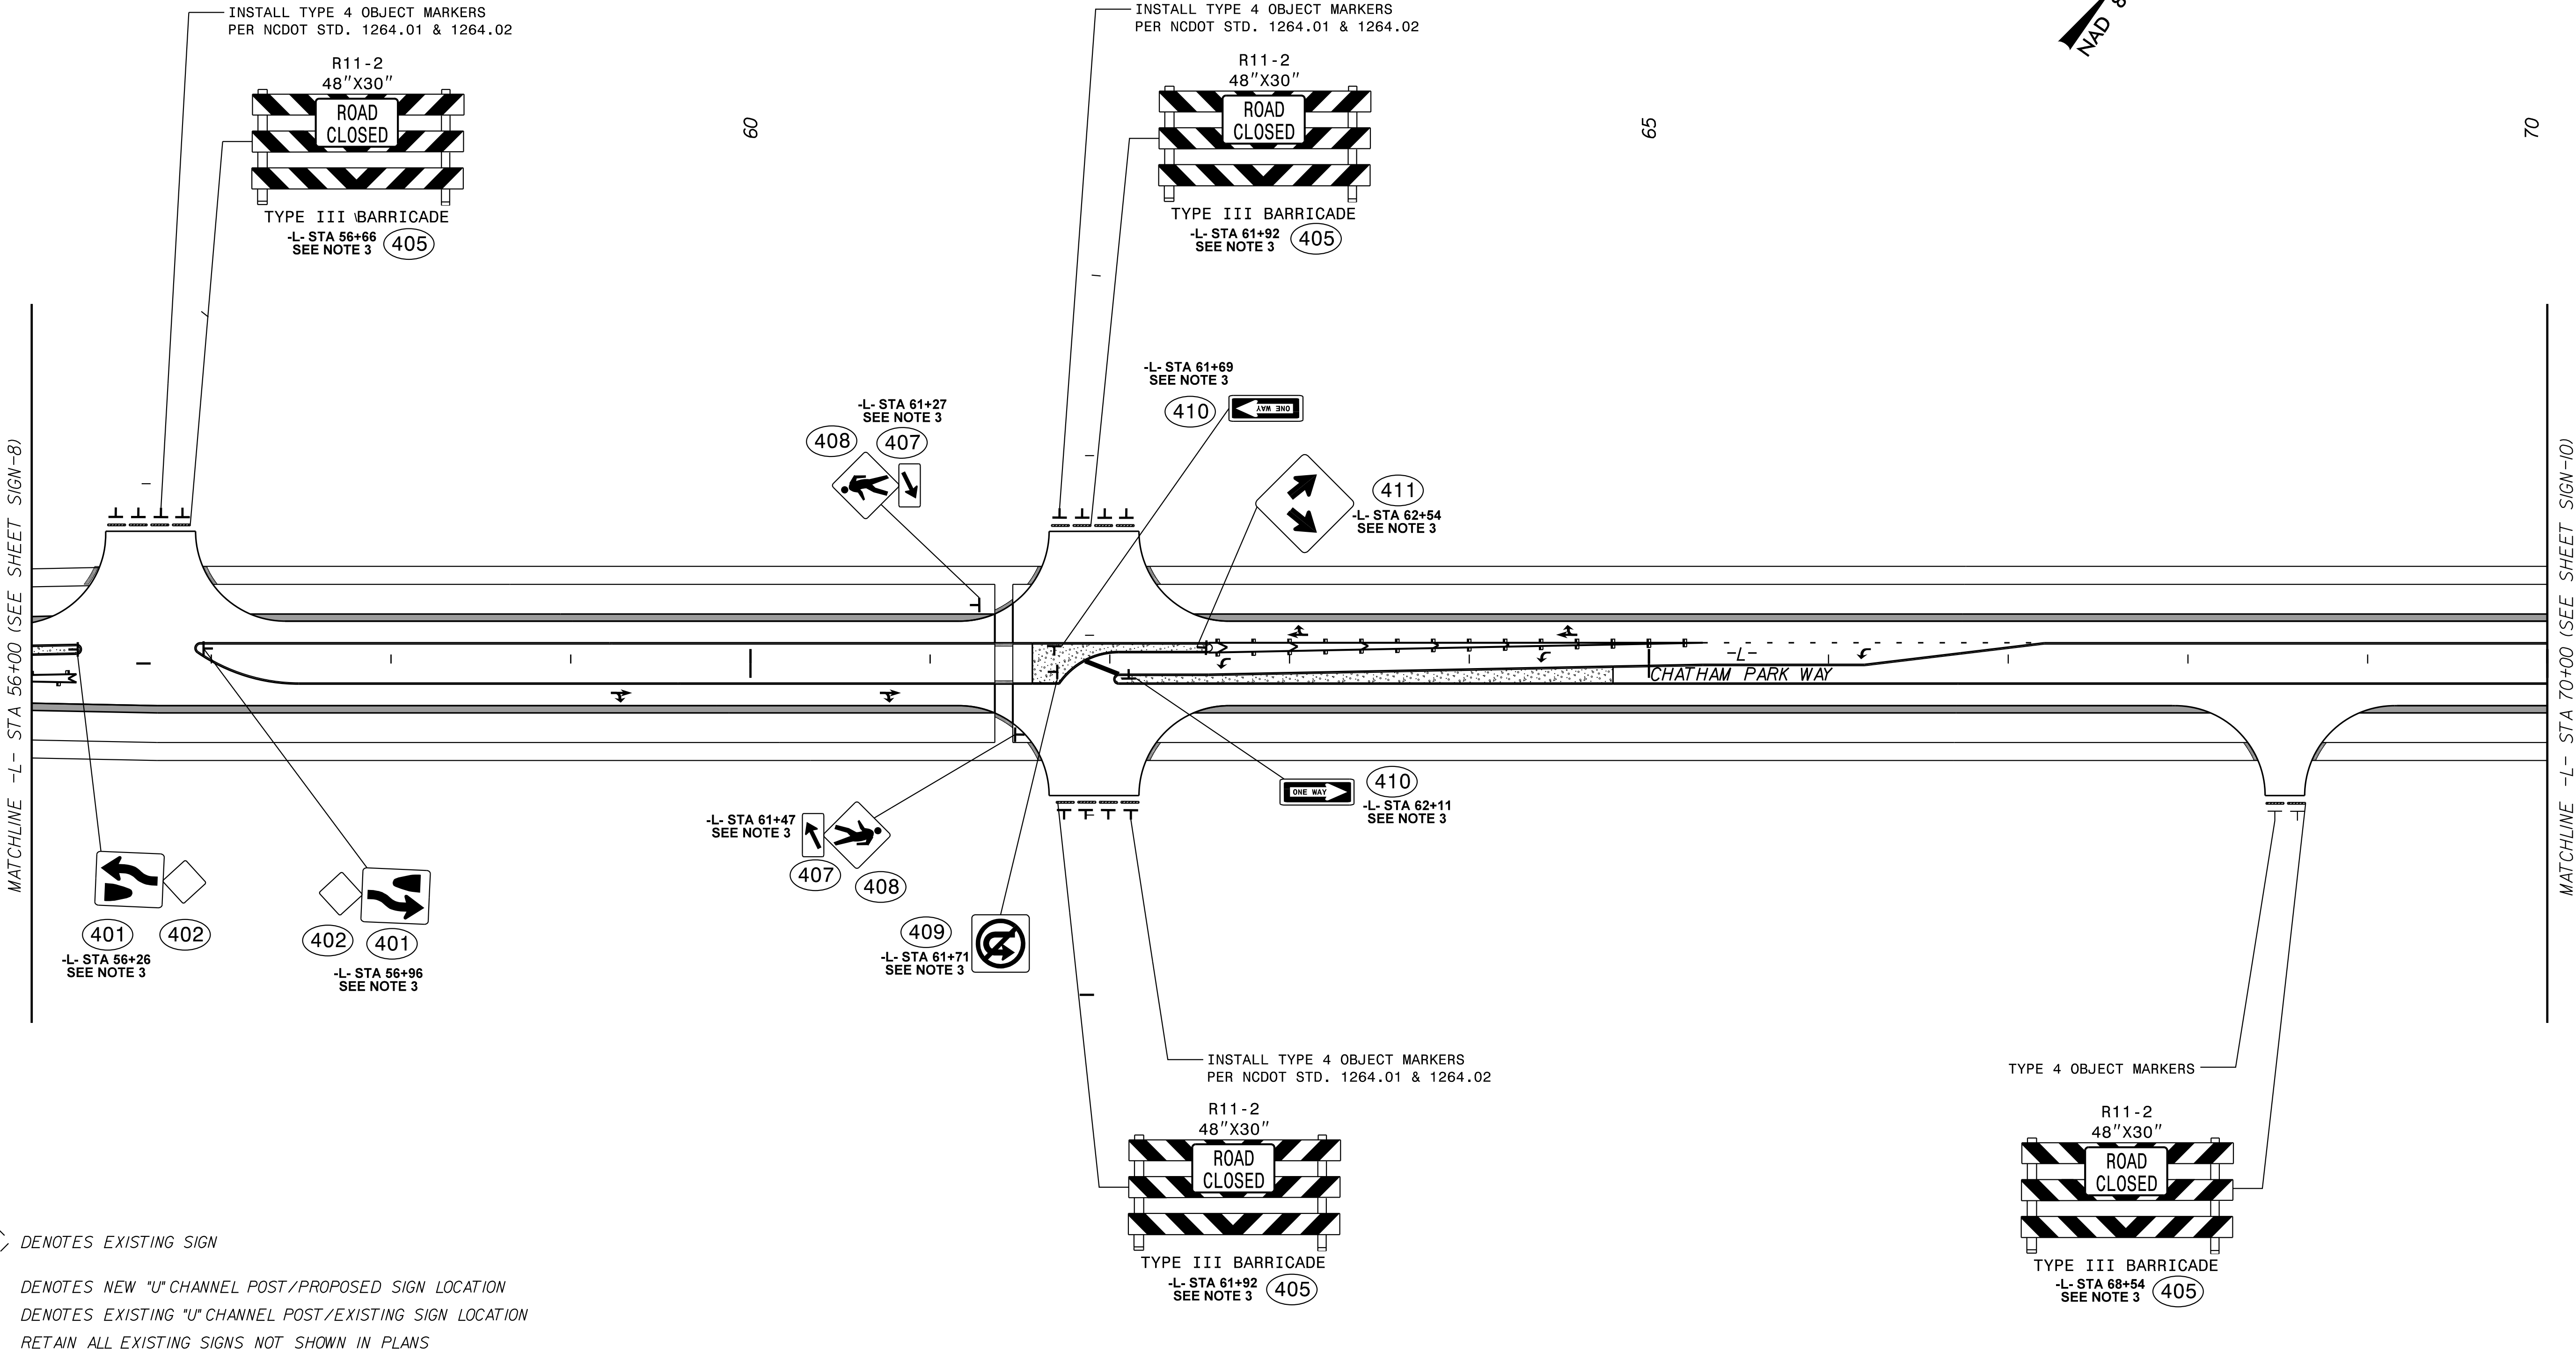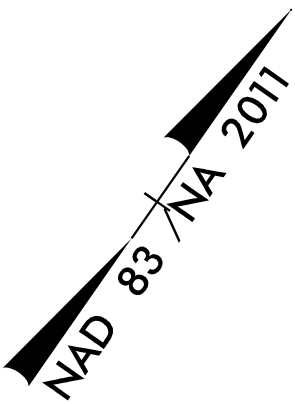


- DENOTES EXISTING SIGN
- DENOTES NEW "U" CHANNEL POST/PROPOSED SIGN LOCATION
- DENOTES EXISTING "U" CHANNEL POST/EXISTING SIGN LOCATION
- RETAIN ALL EXISTING SIGNS NOT SHOWN IN PLANS

PROJECT NOTES

- DISPOSAL OF SIGN SYSTEM, U-CHANNEL
- SIGN ERECTION, TYPE D
- SIGN ERECTION, TYPE E
- SIGN ERECTION, TYPE F


SIGNING PLAN

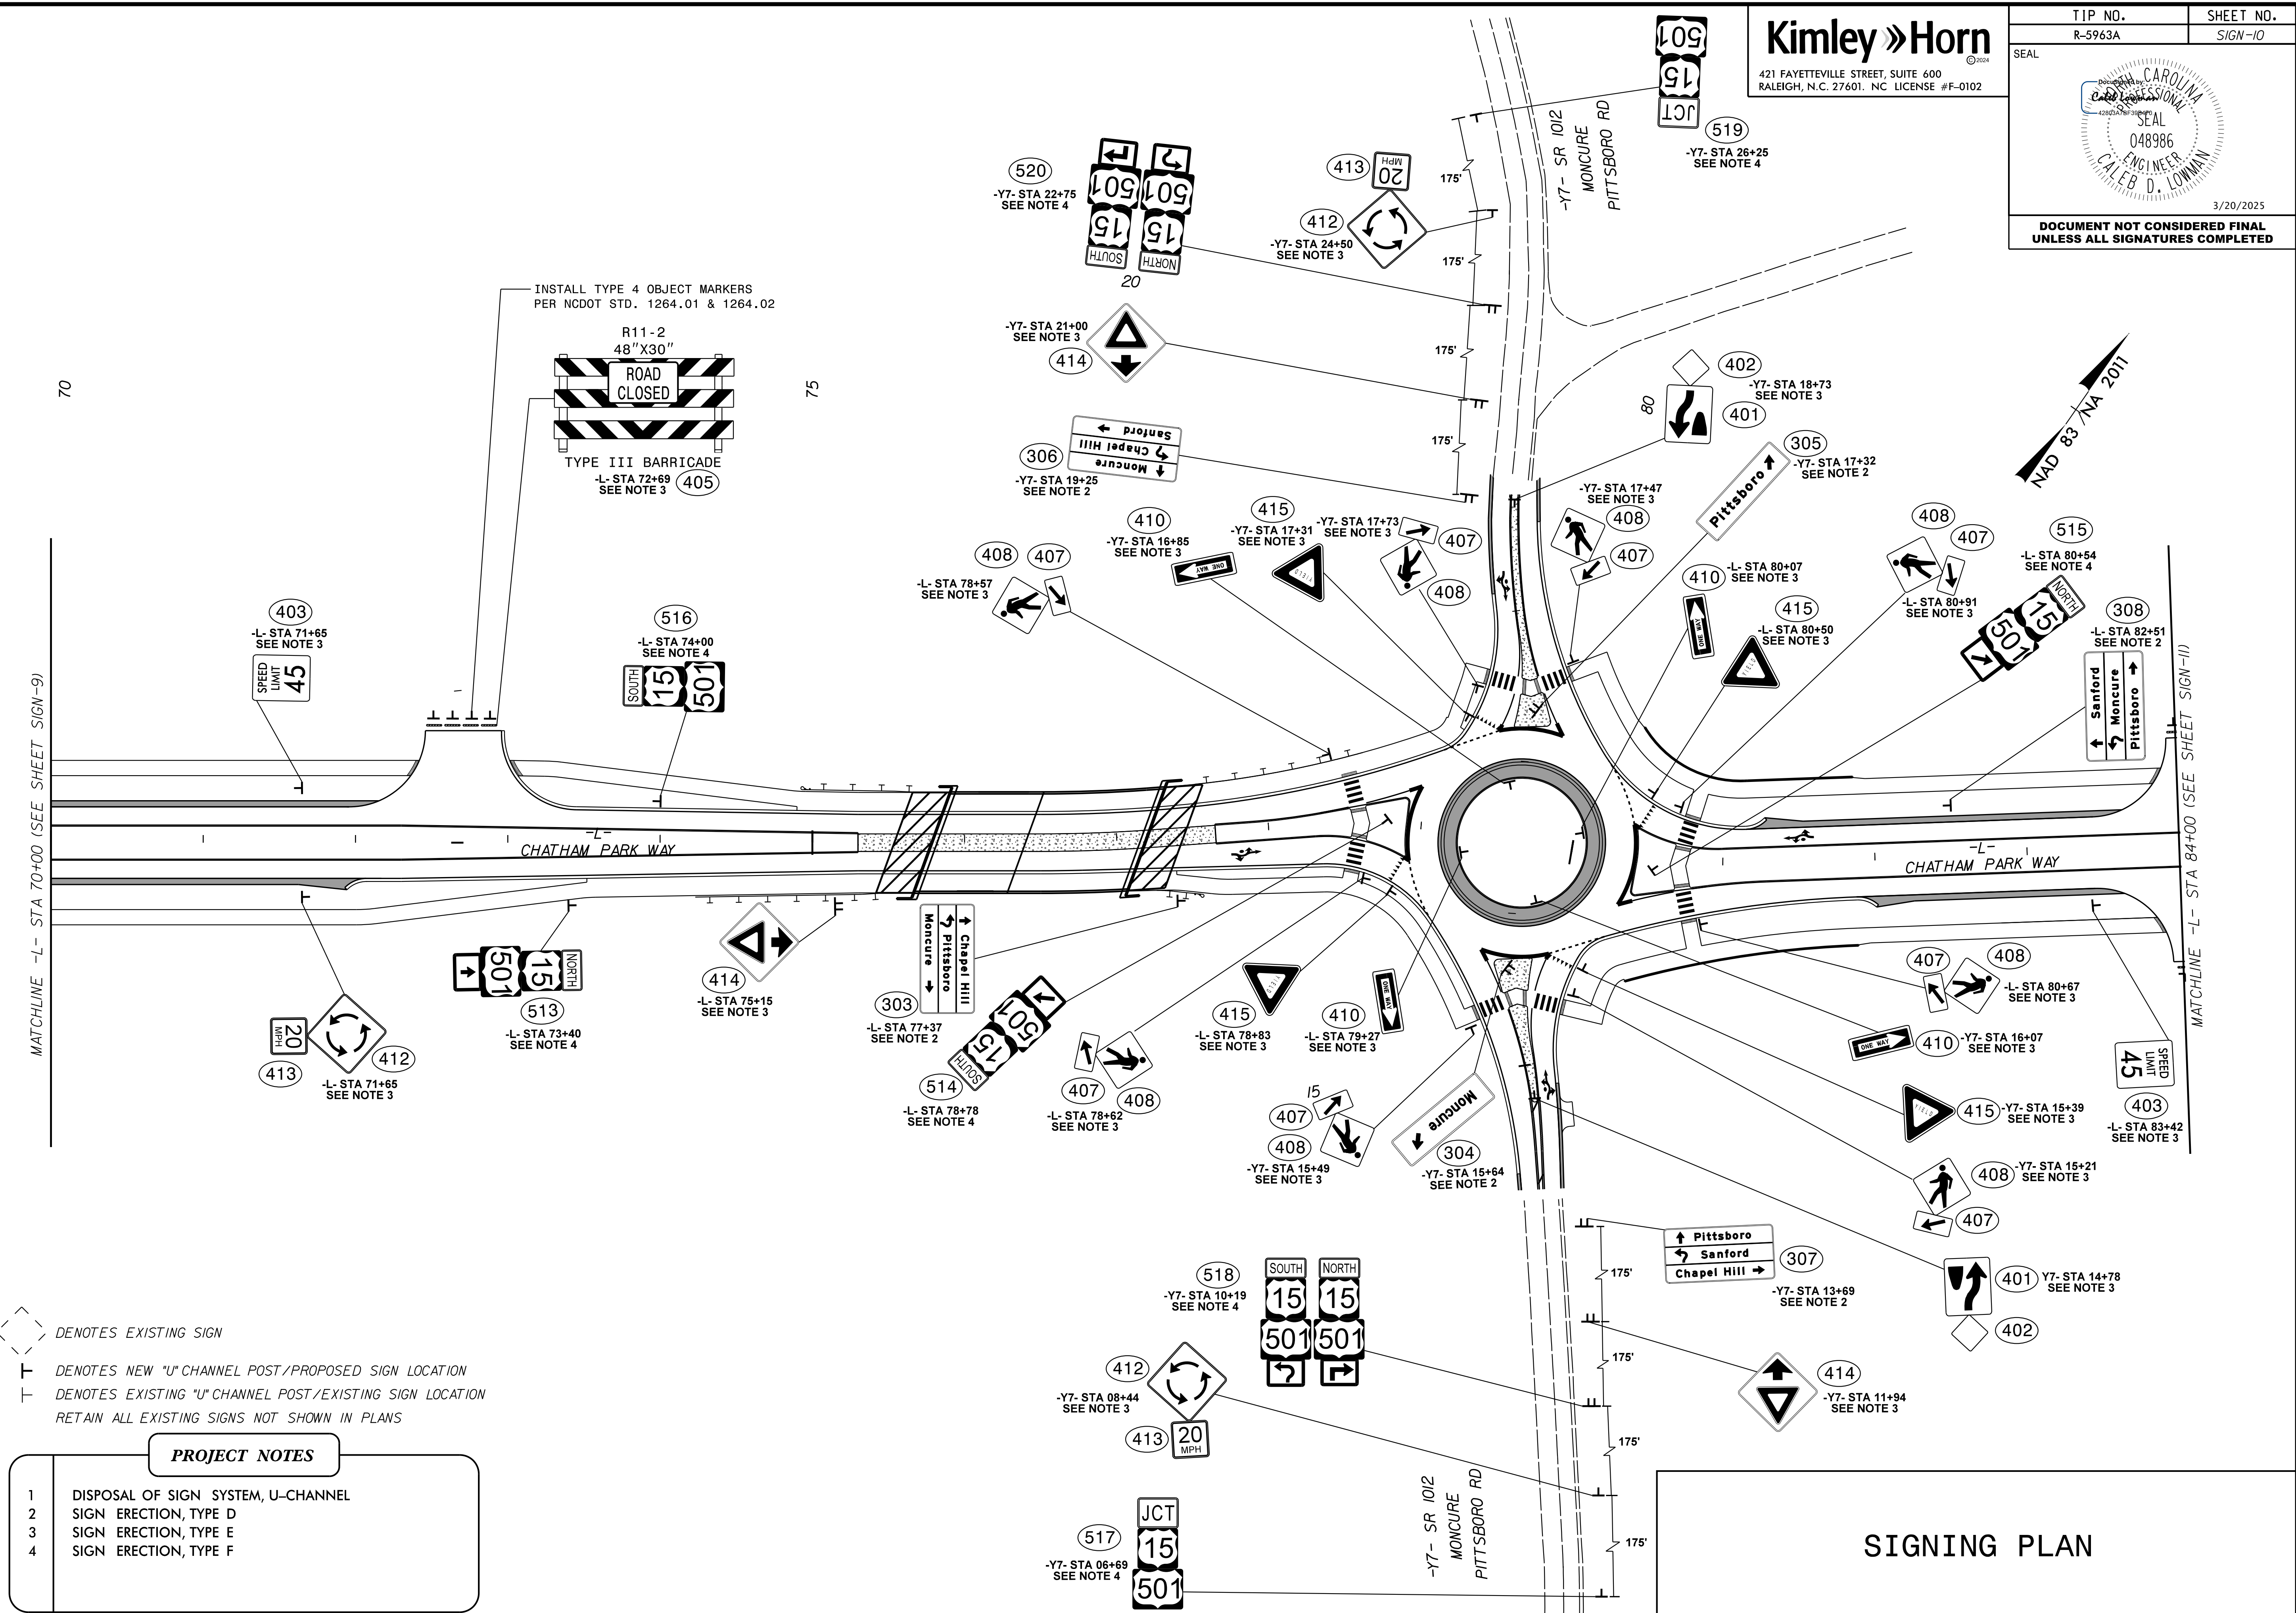

Kimley »Horn


421 FAYETTEVILLE STREET, SUITE 600
RALEIGH, N.C. 27601. NC LICENSE #F-0102

TIP NO. R-5963A SHEET NO. SIGN-12

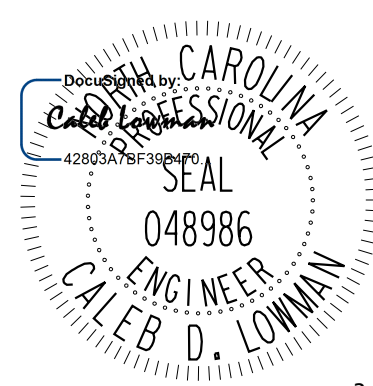

DOCUMENT NOT CONSIDERED FINAL
UNLESS ALL SIGNATURES COMPLETED

NAD 83 / NA 2011

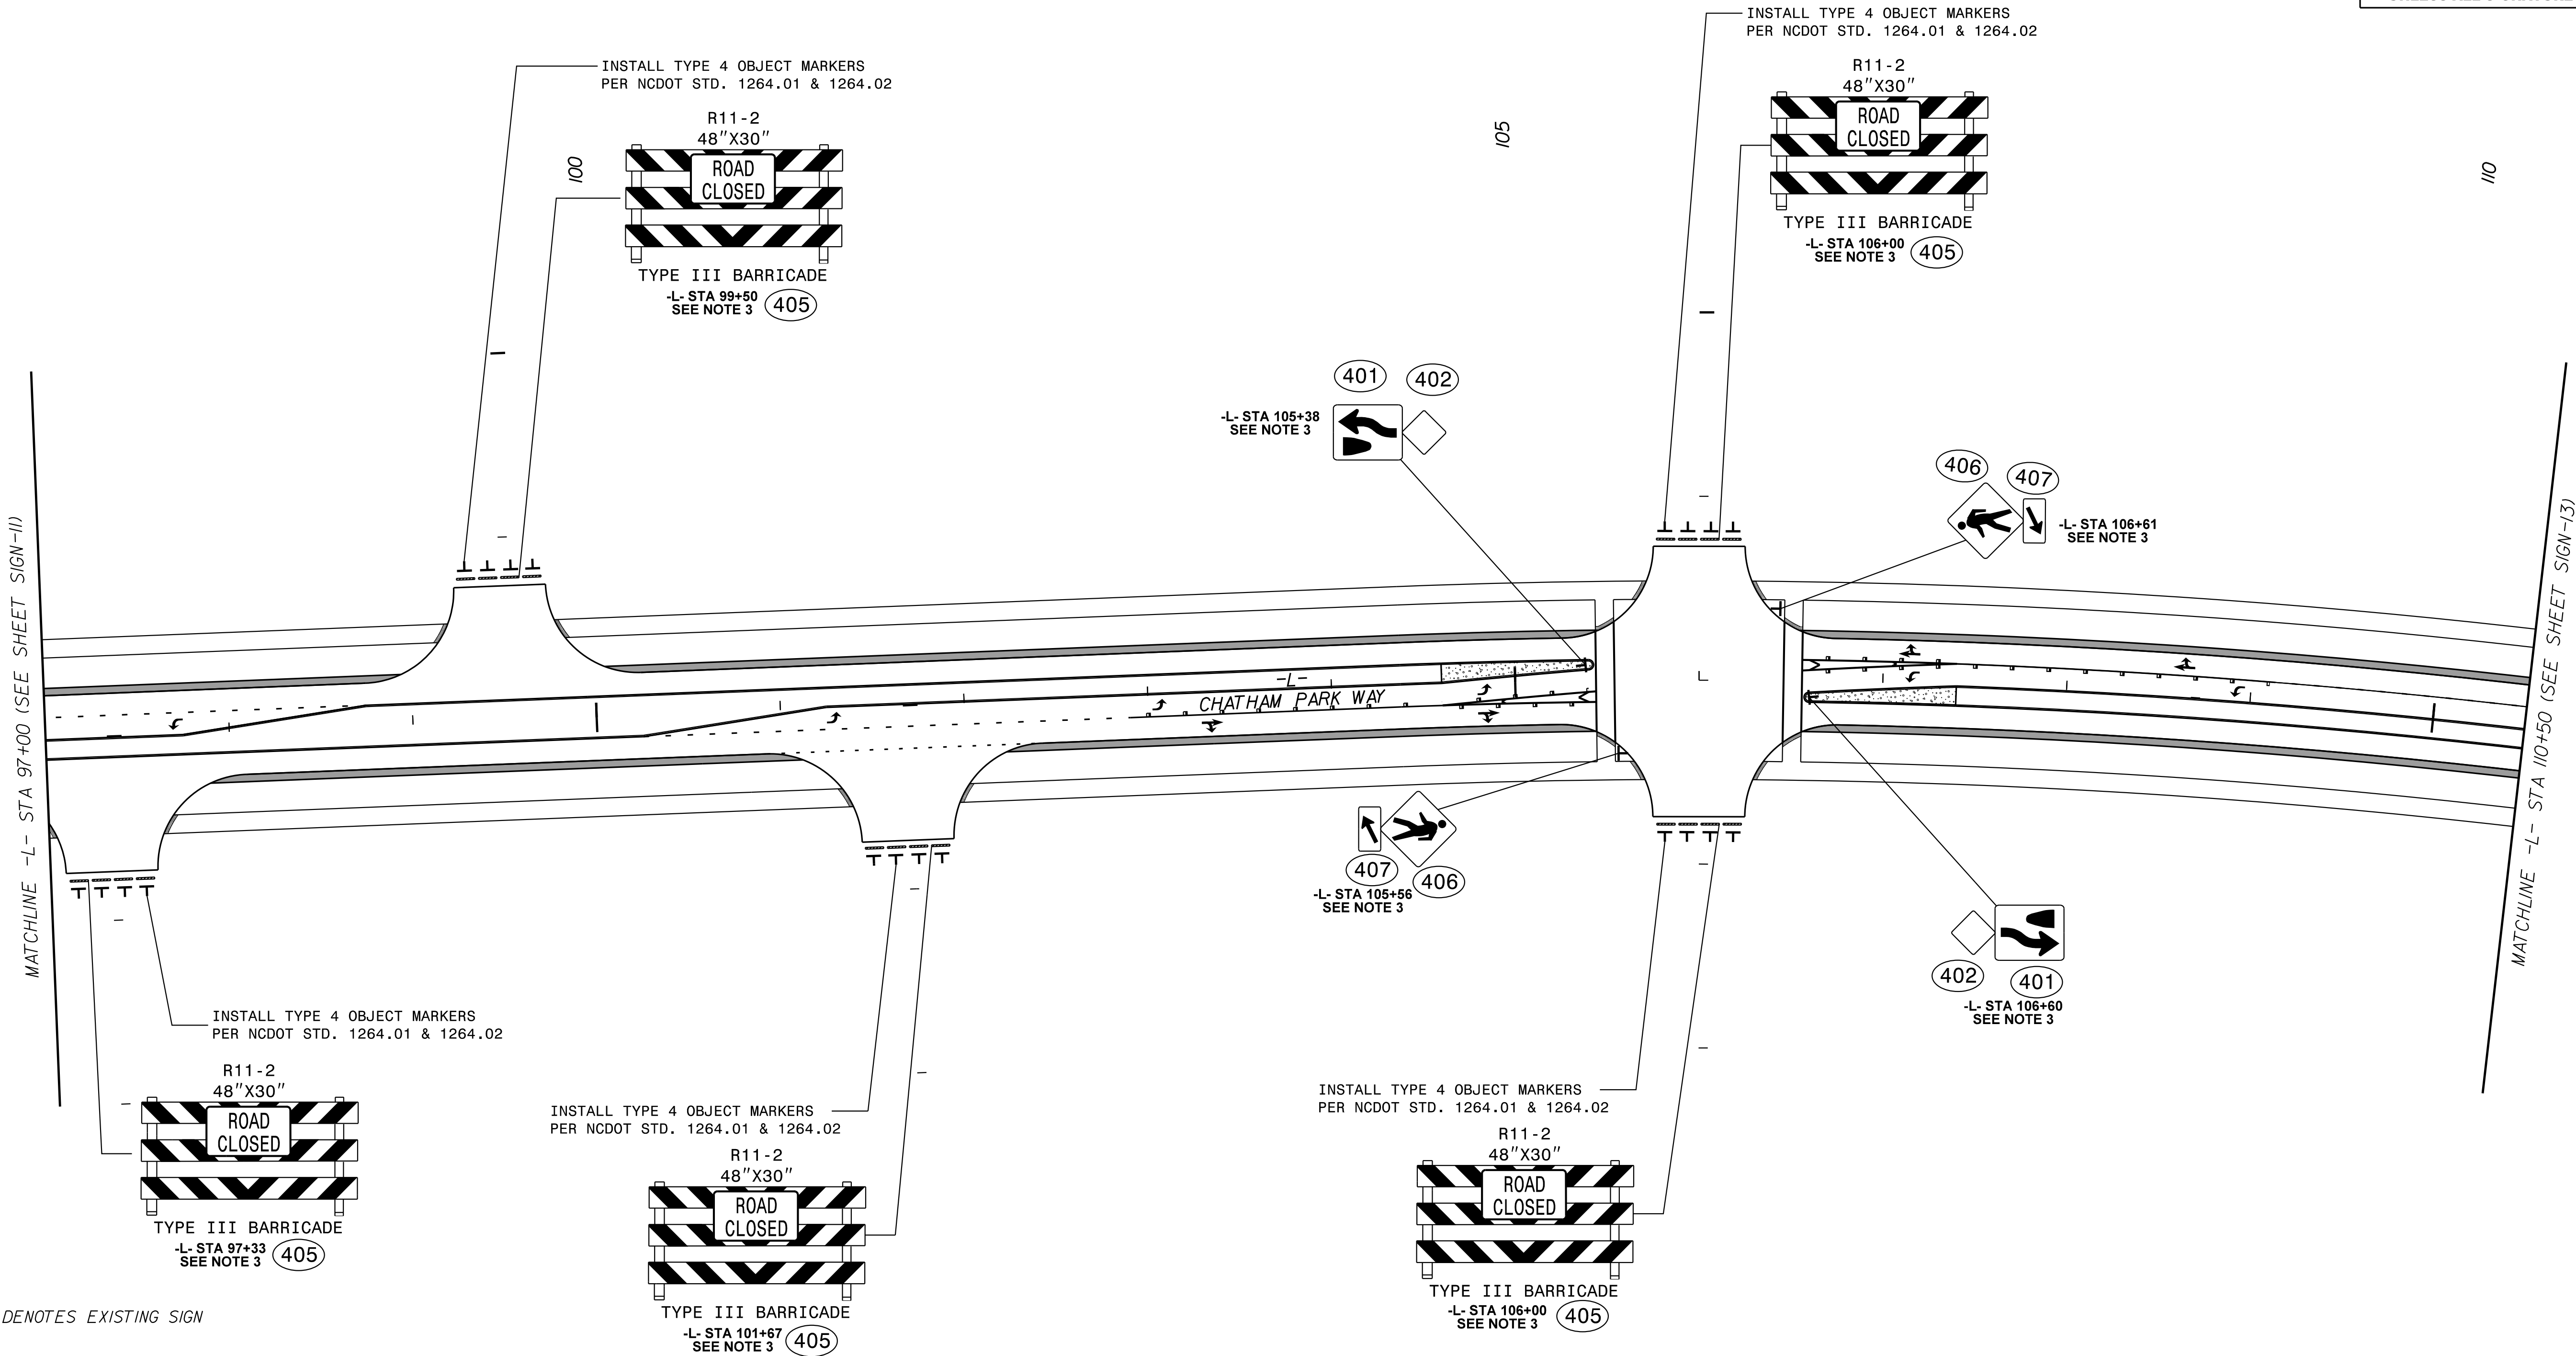

- DENOTES EXISTING SIGN
- DENOTES NEW "U" CHANNEL POST/PROPOSED SIGN LOCATION
- DENOTES EXISTING "U" CHANNEL POST/EXISTING SIGN LOCATION
- RETAIN ALL EXISTING SIGNS NOT SHOWN IN PLANS

PROJECT NOTES


- DISPOSAL OF SIGN SYSTEM, U-CHANNEL
- SIGN ERECTION, TYPE D
- SIGN ERECTION, TYPE E
- SIGN ERECTION, TYPE F

SIGNING PLAN

Kimley »Horn


421 FAYETTEVILLE STREET, SUITE 600
RALEIGH, N.C. 27601. NC LICENSE #F-0102

TIP NO. R-5963A SHEET NO. SIGN-13

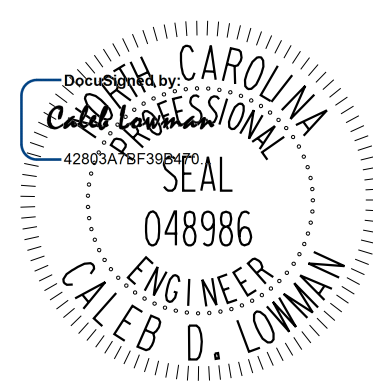

3/20/2025

DOCUMENT NOT CONSIDERED FINAL
UNLESS ALL SIGNATURES COMPLETED

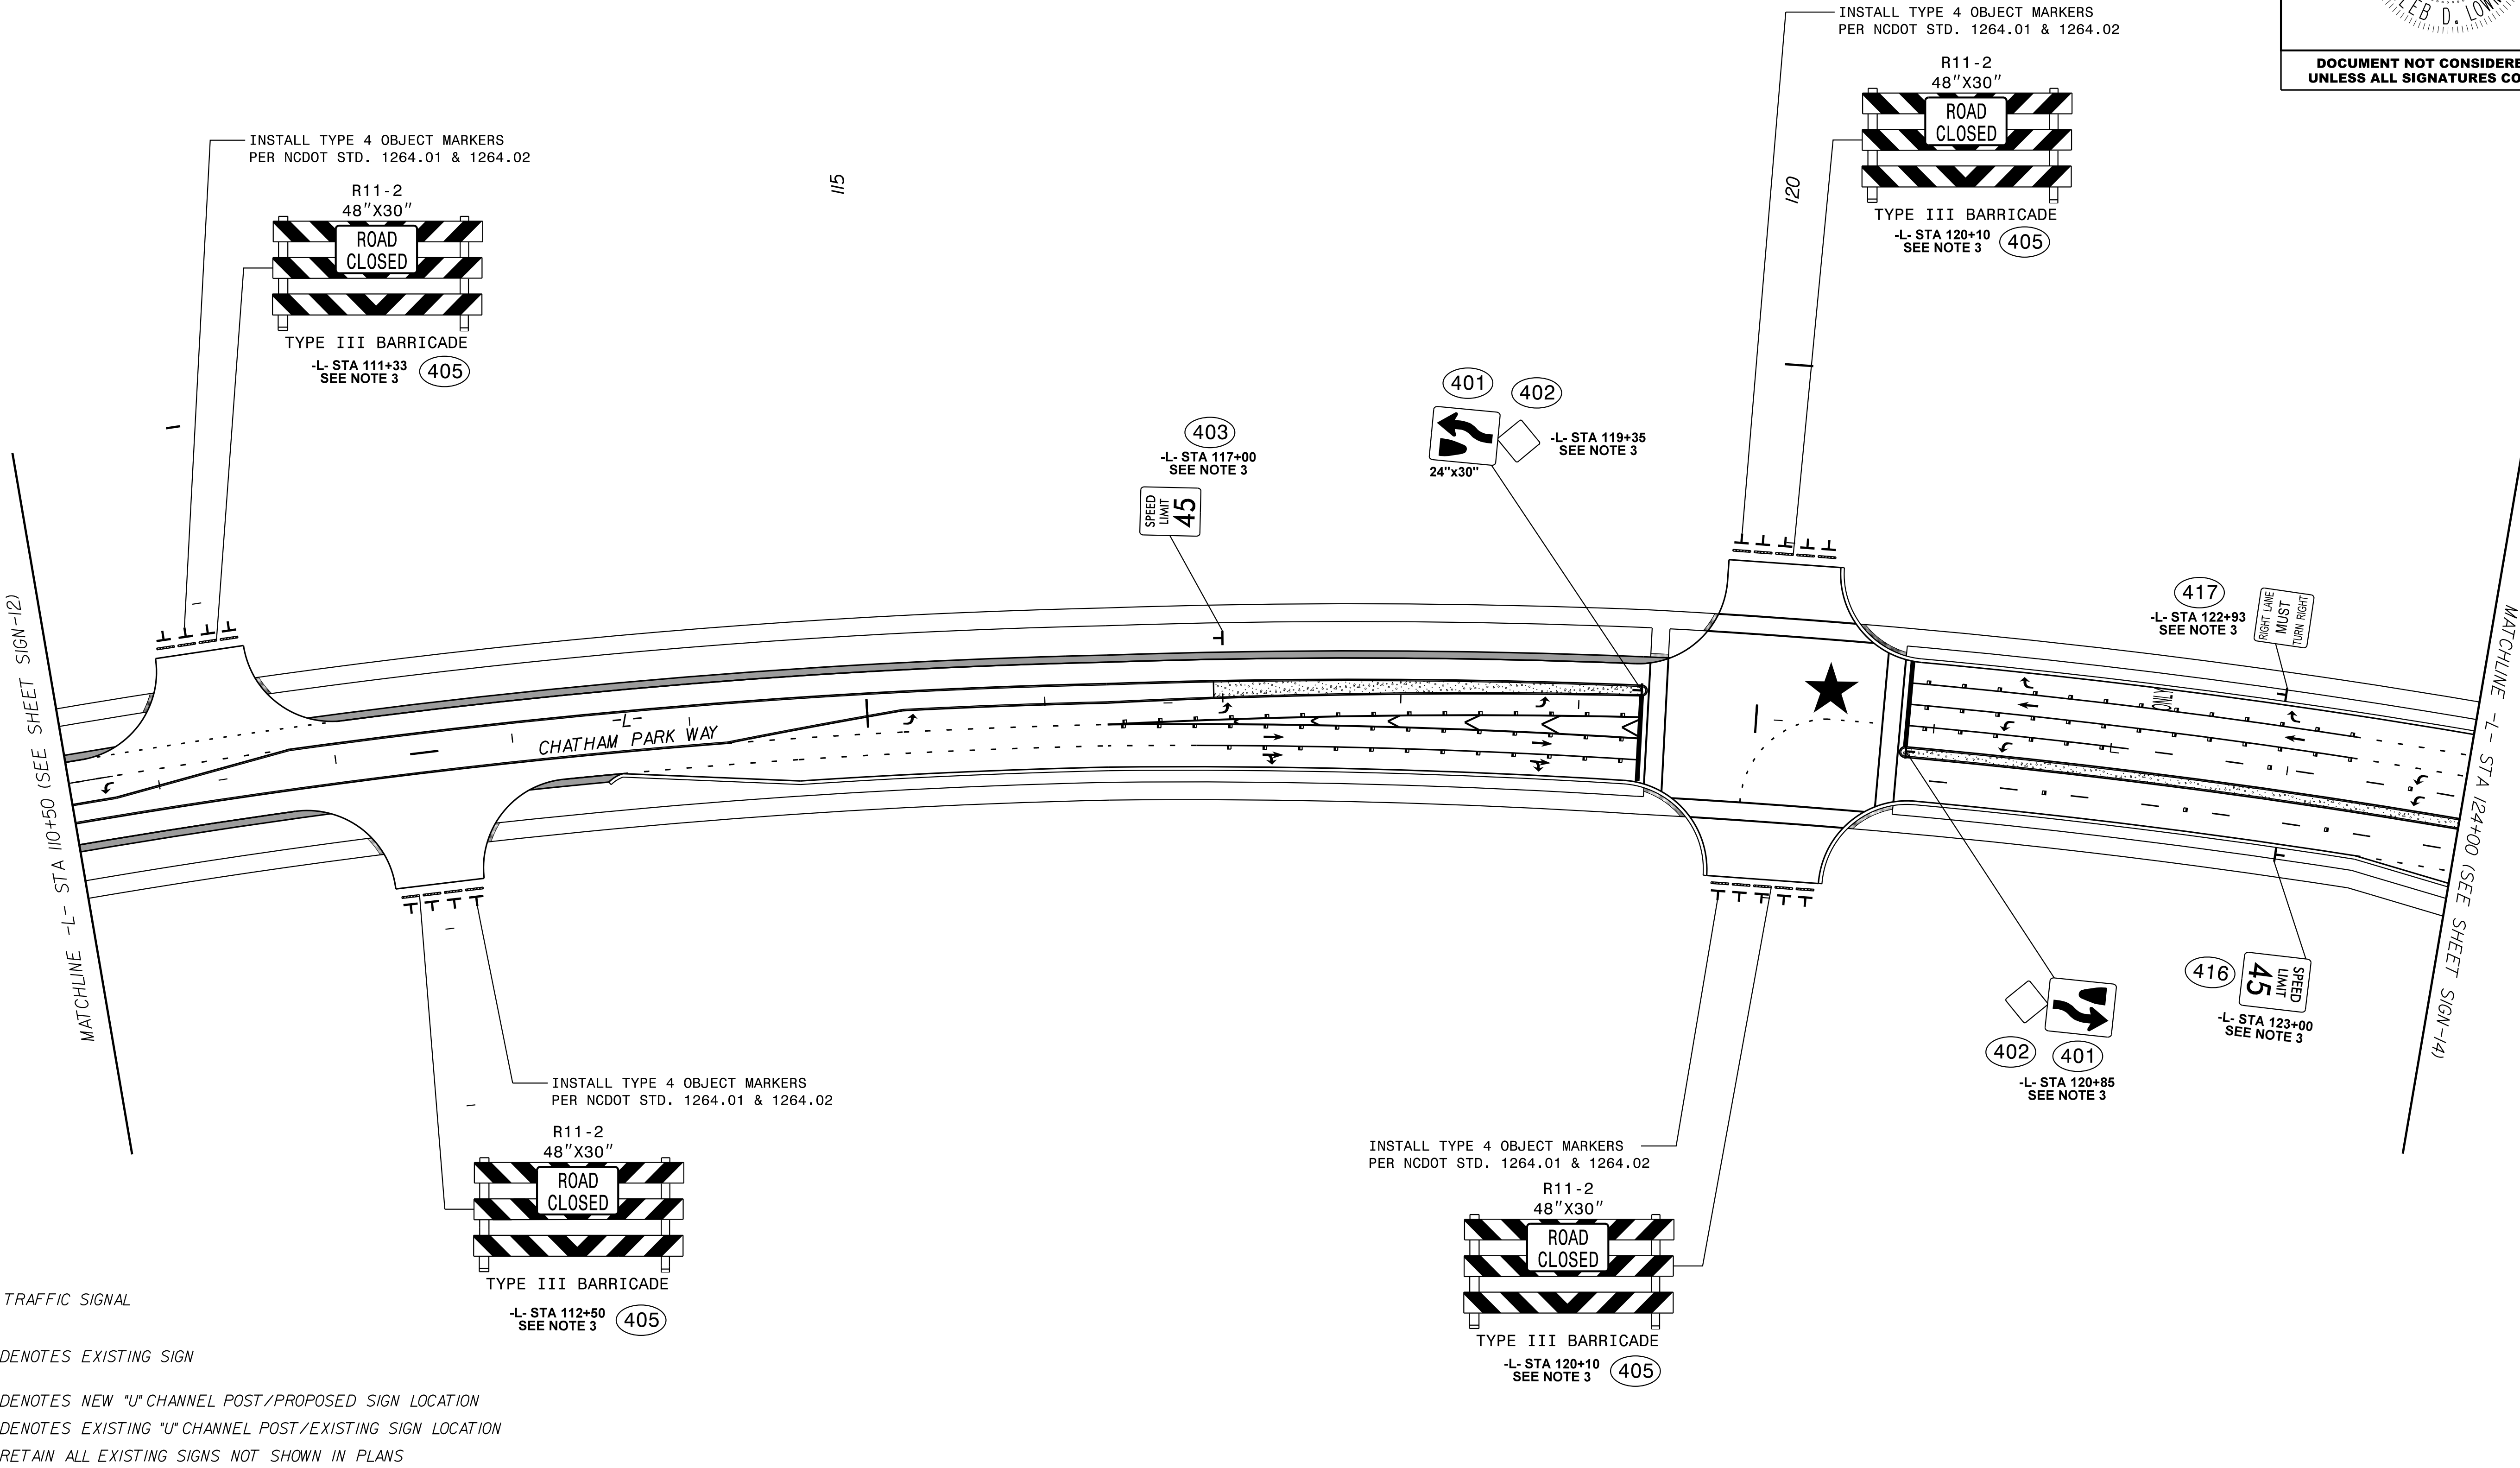

- ★ TRAFFIC SIGNAL
- DENOTES EXISTING SIGN
- T DENOTES NEW "U" CHANNEL POST/PROPOSED SIGN LOCATION
- T DENOTES EXISTING "U" CHANNEL POST/EXISTING SIGN LOCATION
- RETAIN ALL EXISTING SIGNS NOT SHOWN IN PLANS


PROJECT NOTES

- DISPOSAL OF SIGN SYSTEM, U-CHANNEL
- SIGN ERECTION, TYPE D
- SIGN ERECTION, TYPE E
- SIGN ERECTION, TYPE F

SIGNING PLAN

K:\RAL_Roadway\0\036734 - R-5963A&B\Signing and Delineation\Design\Sheets\R-5963A&B_rdy_sgn_14.dgn

1/15/2025

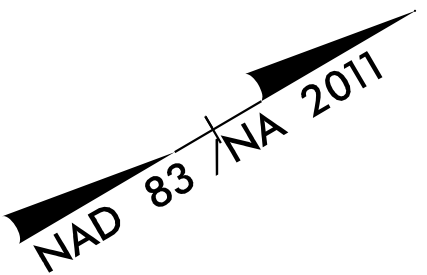


Kimley »Horn

421 FAYETTEVILLE STREET, SUITE 600
RALEIGH, N.C. 27601. NC LICENSE #F-0102


TIP NO.	SHEET NO.
R-5963A	SIGN-14

SEAL

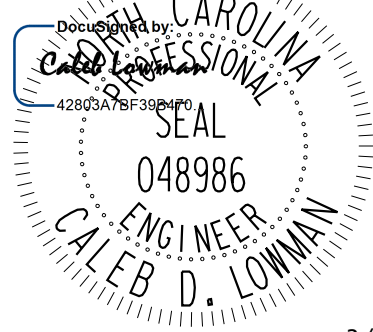

3/20/2025

**DOCUMENT NOT CONSIDERED FINAL
UNLESS ALL SIGNATURES COMPLETED**

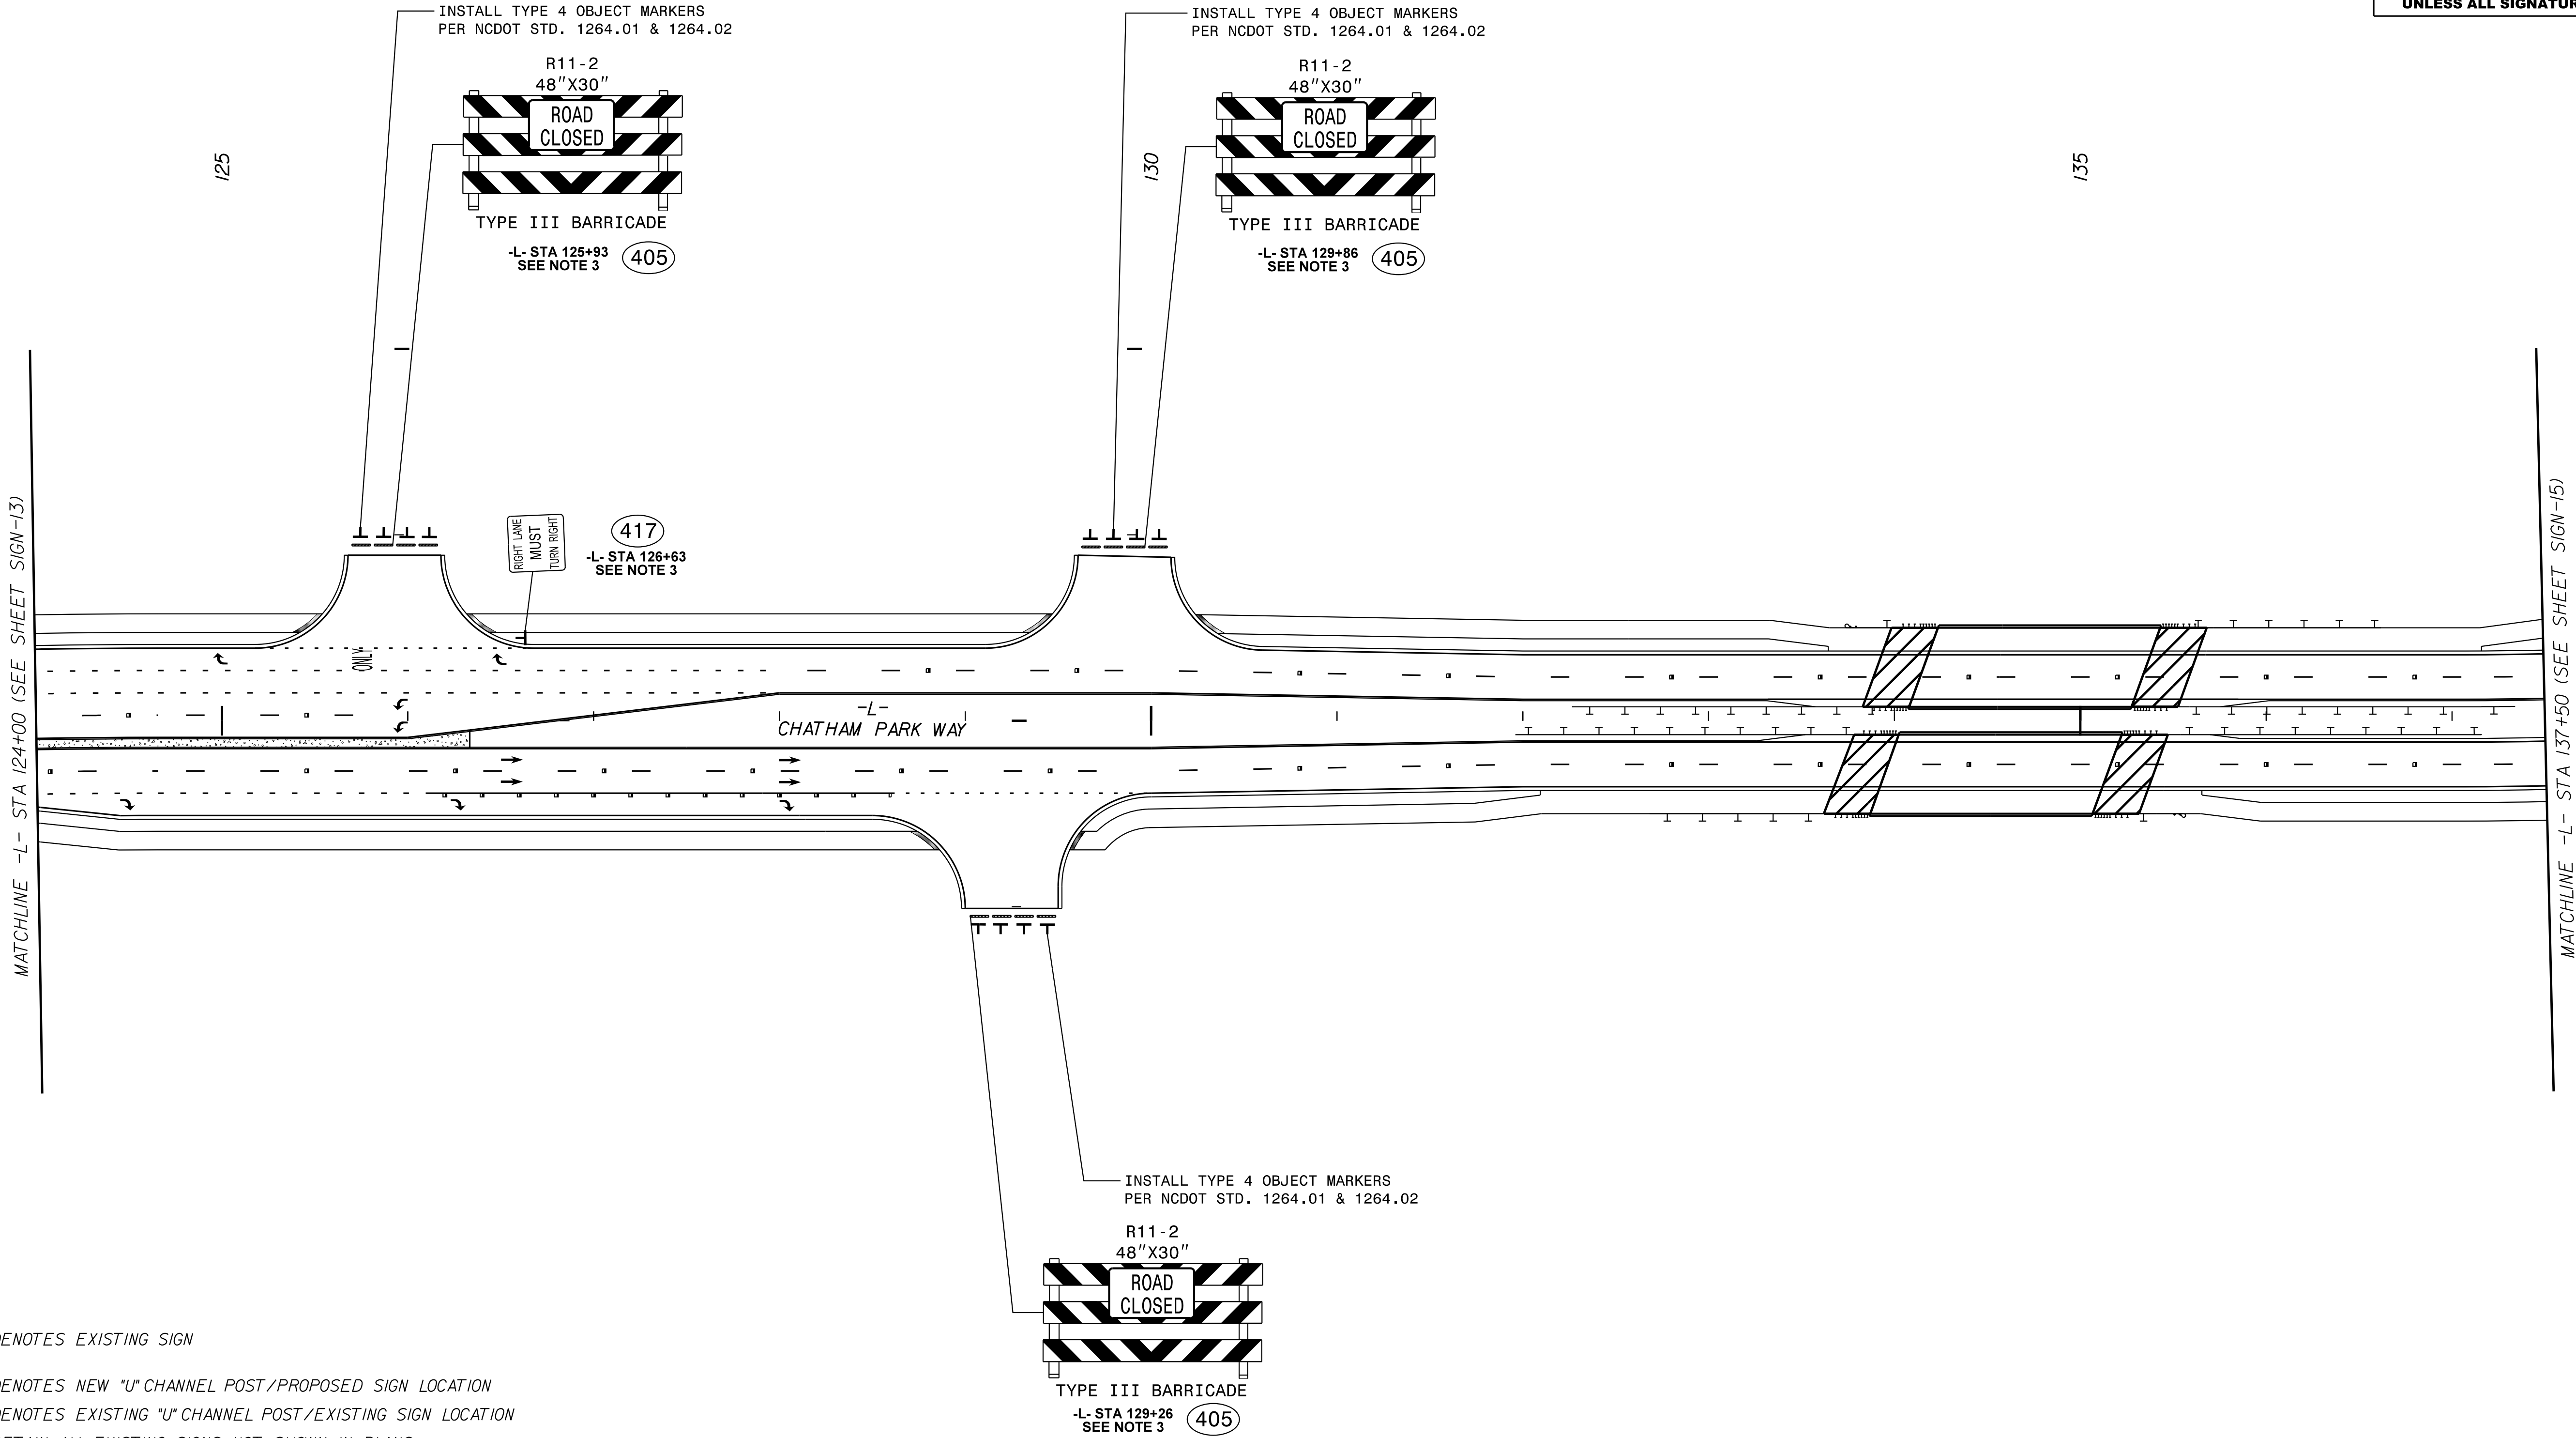

- DENOTES EXISTING SIGN
- DENOTES NEW "U" CHANNEL POST/PROPOSED SIGN LOCATION
- DENOTES EXISTING "U" CHANNEL POST/EXISTING SIGN LOCATION
- RETAIN ALL EXISTING SIGNS NOT SHOWN IN PLANS

PROJECT NOTES

- DISPOSAL OF SIGN SYSTEM, U-CHANNEL
- SIGN ERECTION, TYPE D
- SIGN ERECTION, TYPE E
- SIGN ERECTION, TYPE F

SIGNING PLAN

Kimley »Horn

421 FAYETTEVILLE STREET, SUITE 600
RALEIGH, N.C. 27601. NC LICENSE #F-0102


TIP NO.

R-5963A

SHEET NO.

SIGN-15



SEAL

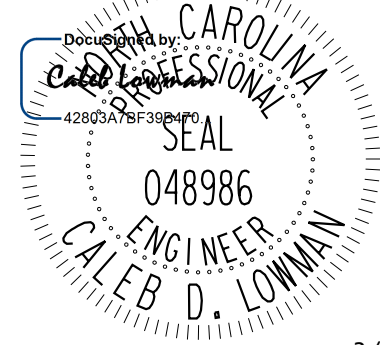

3/20/2025

DOCUMENT NOT CONSIDERED FINAL
UNLESS ALL SIGNATURES COMPLETED

NAD 83 /NA 2011

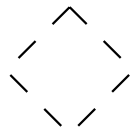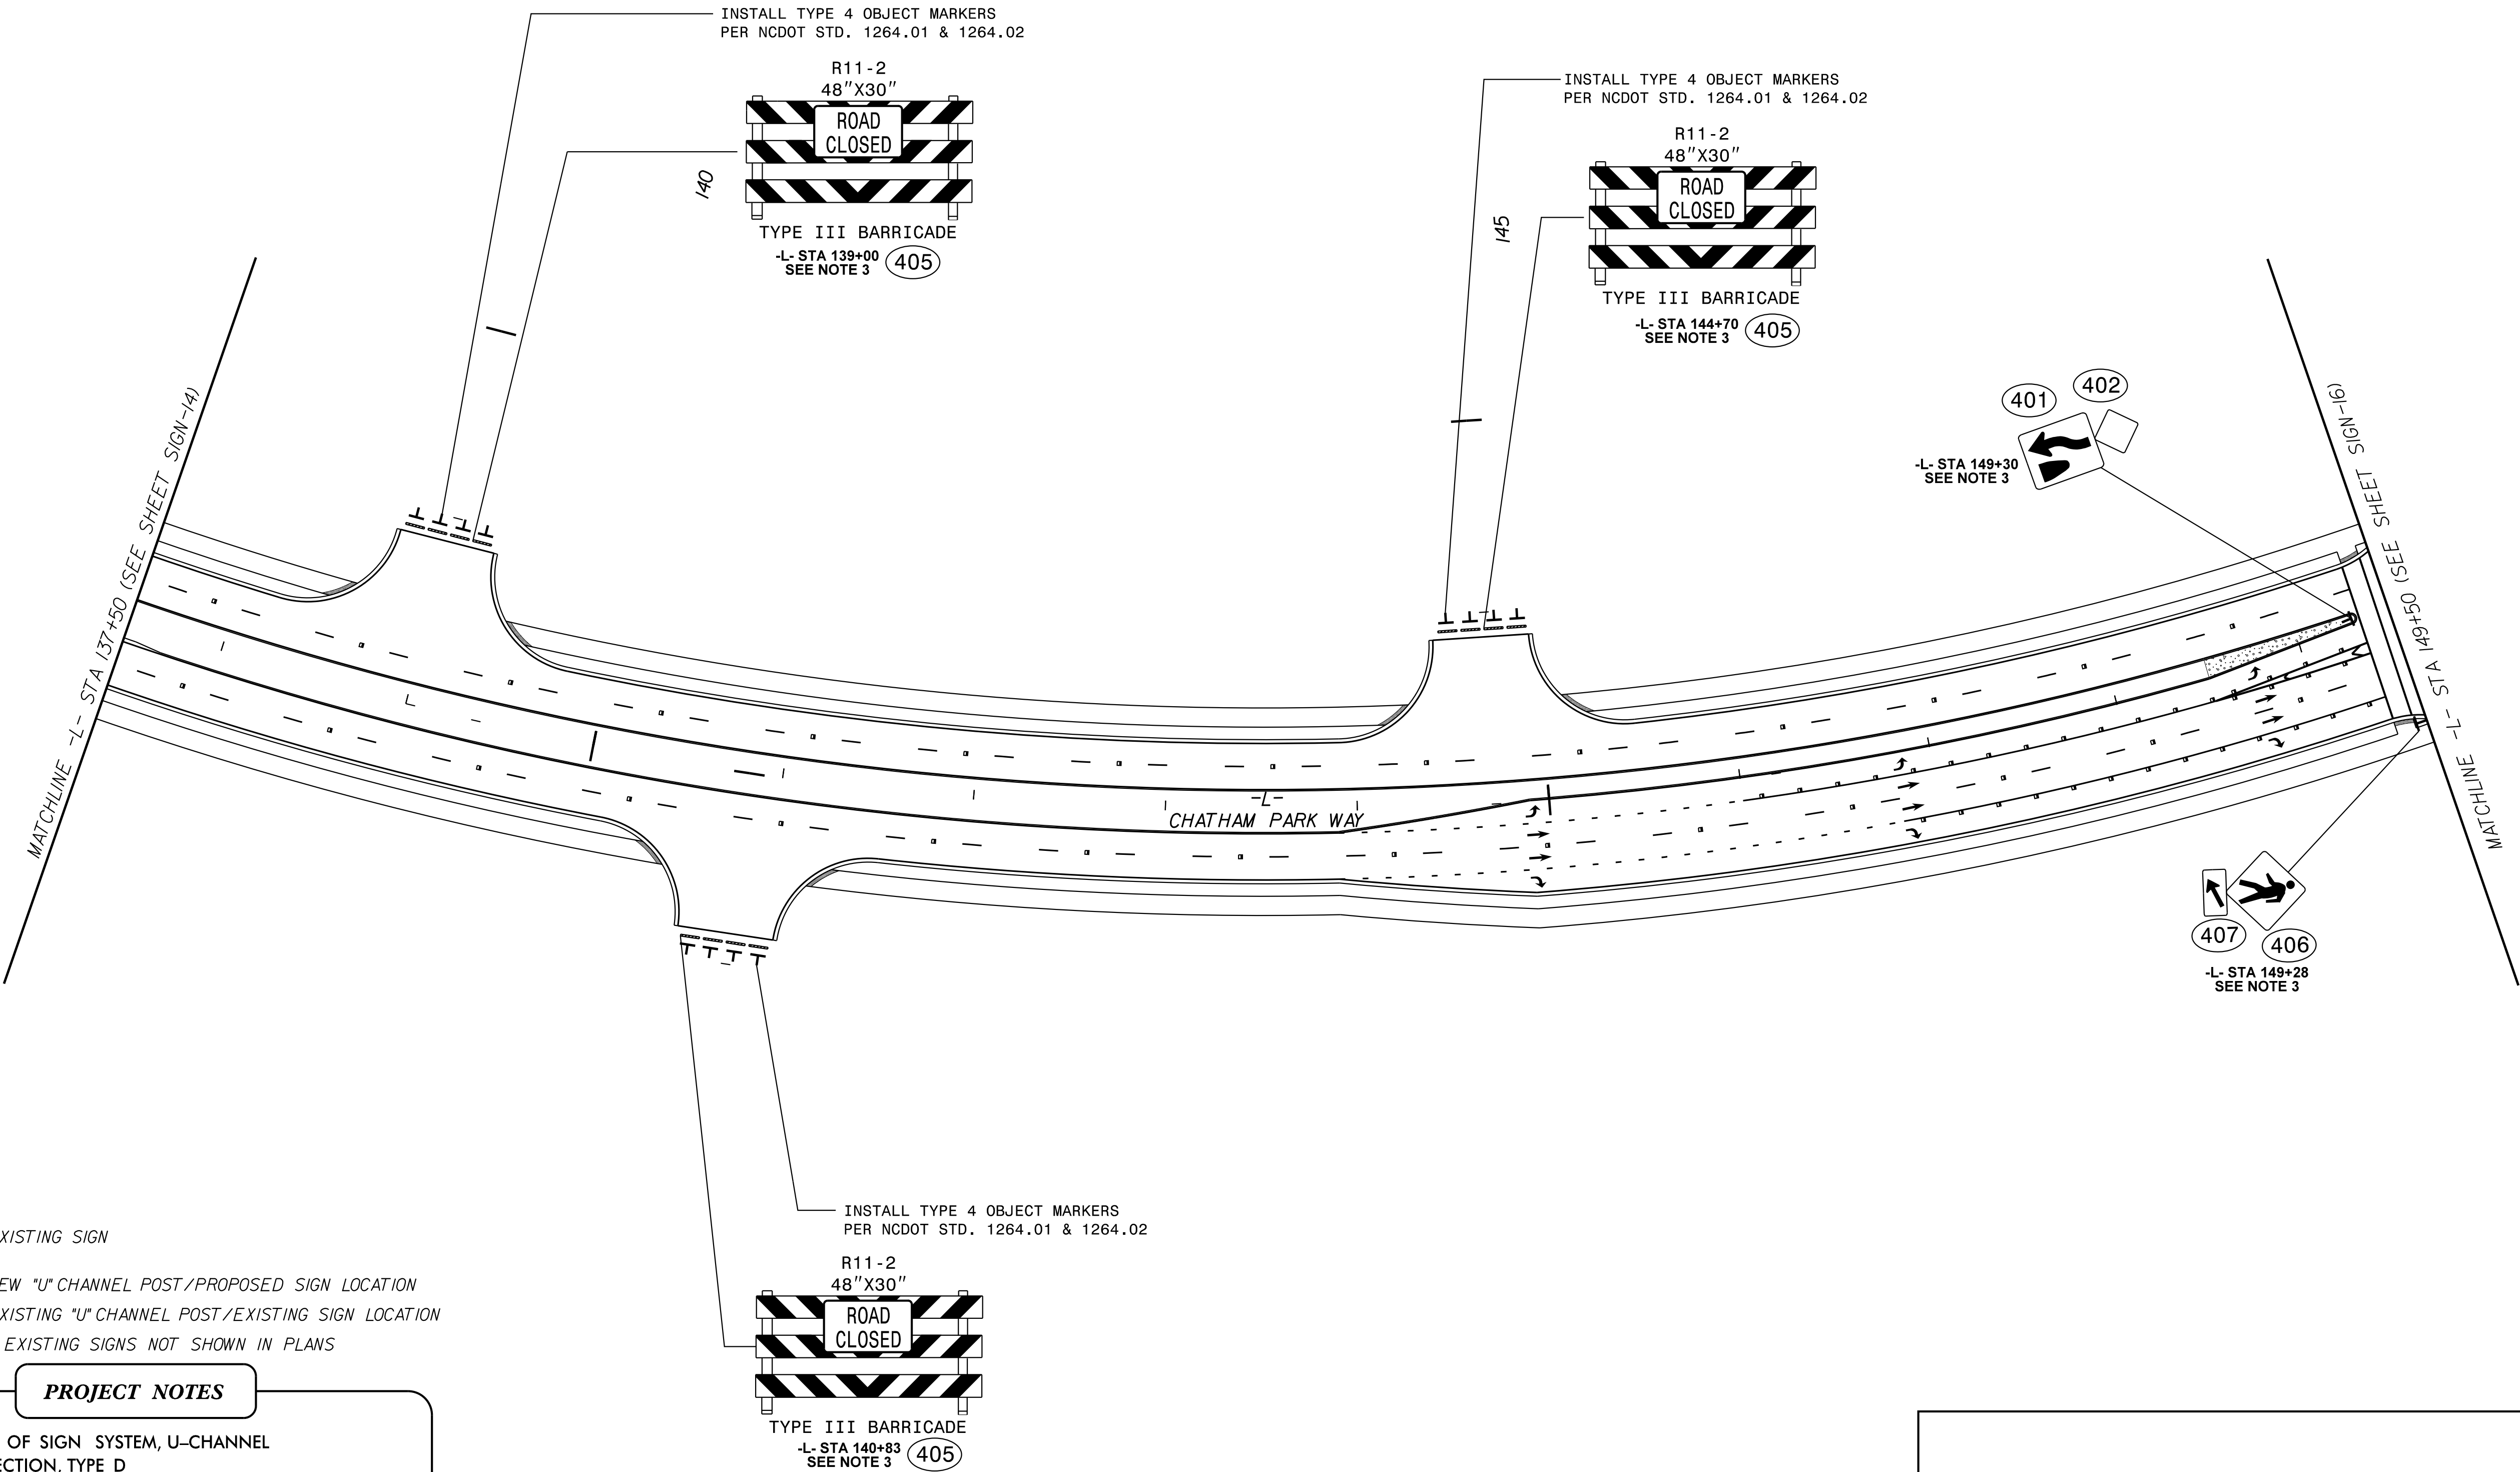

DENOTES EXISTING SIGN

T

DENOTES NEW "U" CHANNEL POST/PROPOSED SIGN LOCATION

T

DENOTES EXISTING "U" CHANNEL POST/EXISTING SIGN LOCATION

RETAIN ALL EXISTING SIGNS NOT SHOWN IN PLANS


PROJECT NOTES

- 1 DISPOSAL OF SIGN SYSTEM, U-CHANNEL
- 2 SIGN ERECTION, TYPE D
- 3 SIGN ERECTION, TYPE E
- 4 SIGN ERECTION, TYPE F


SIGNING PLAN

Kimley »Horn

421 FAYETTEVILLE STREET, SUITE 600
RALEIGH, N.C. 27601. NC LICENSE #F-0102

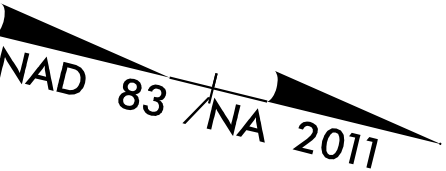

TIP NO.	SHEET NO.
R-5963A	SIGN-16
SEAL	
DOCUMENT NOT CONSIDERED FINAL UNLESS ALL SIGNATURES COMPLETED	

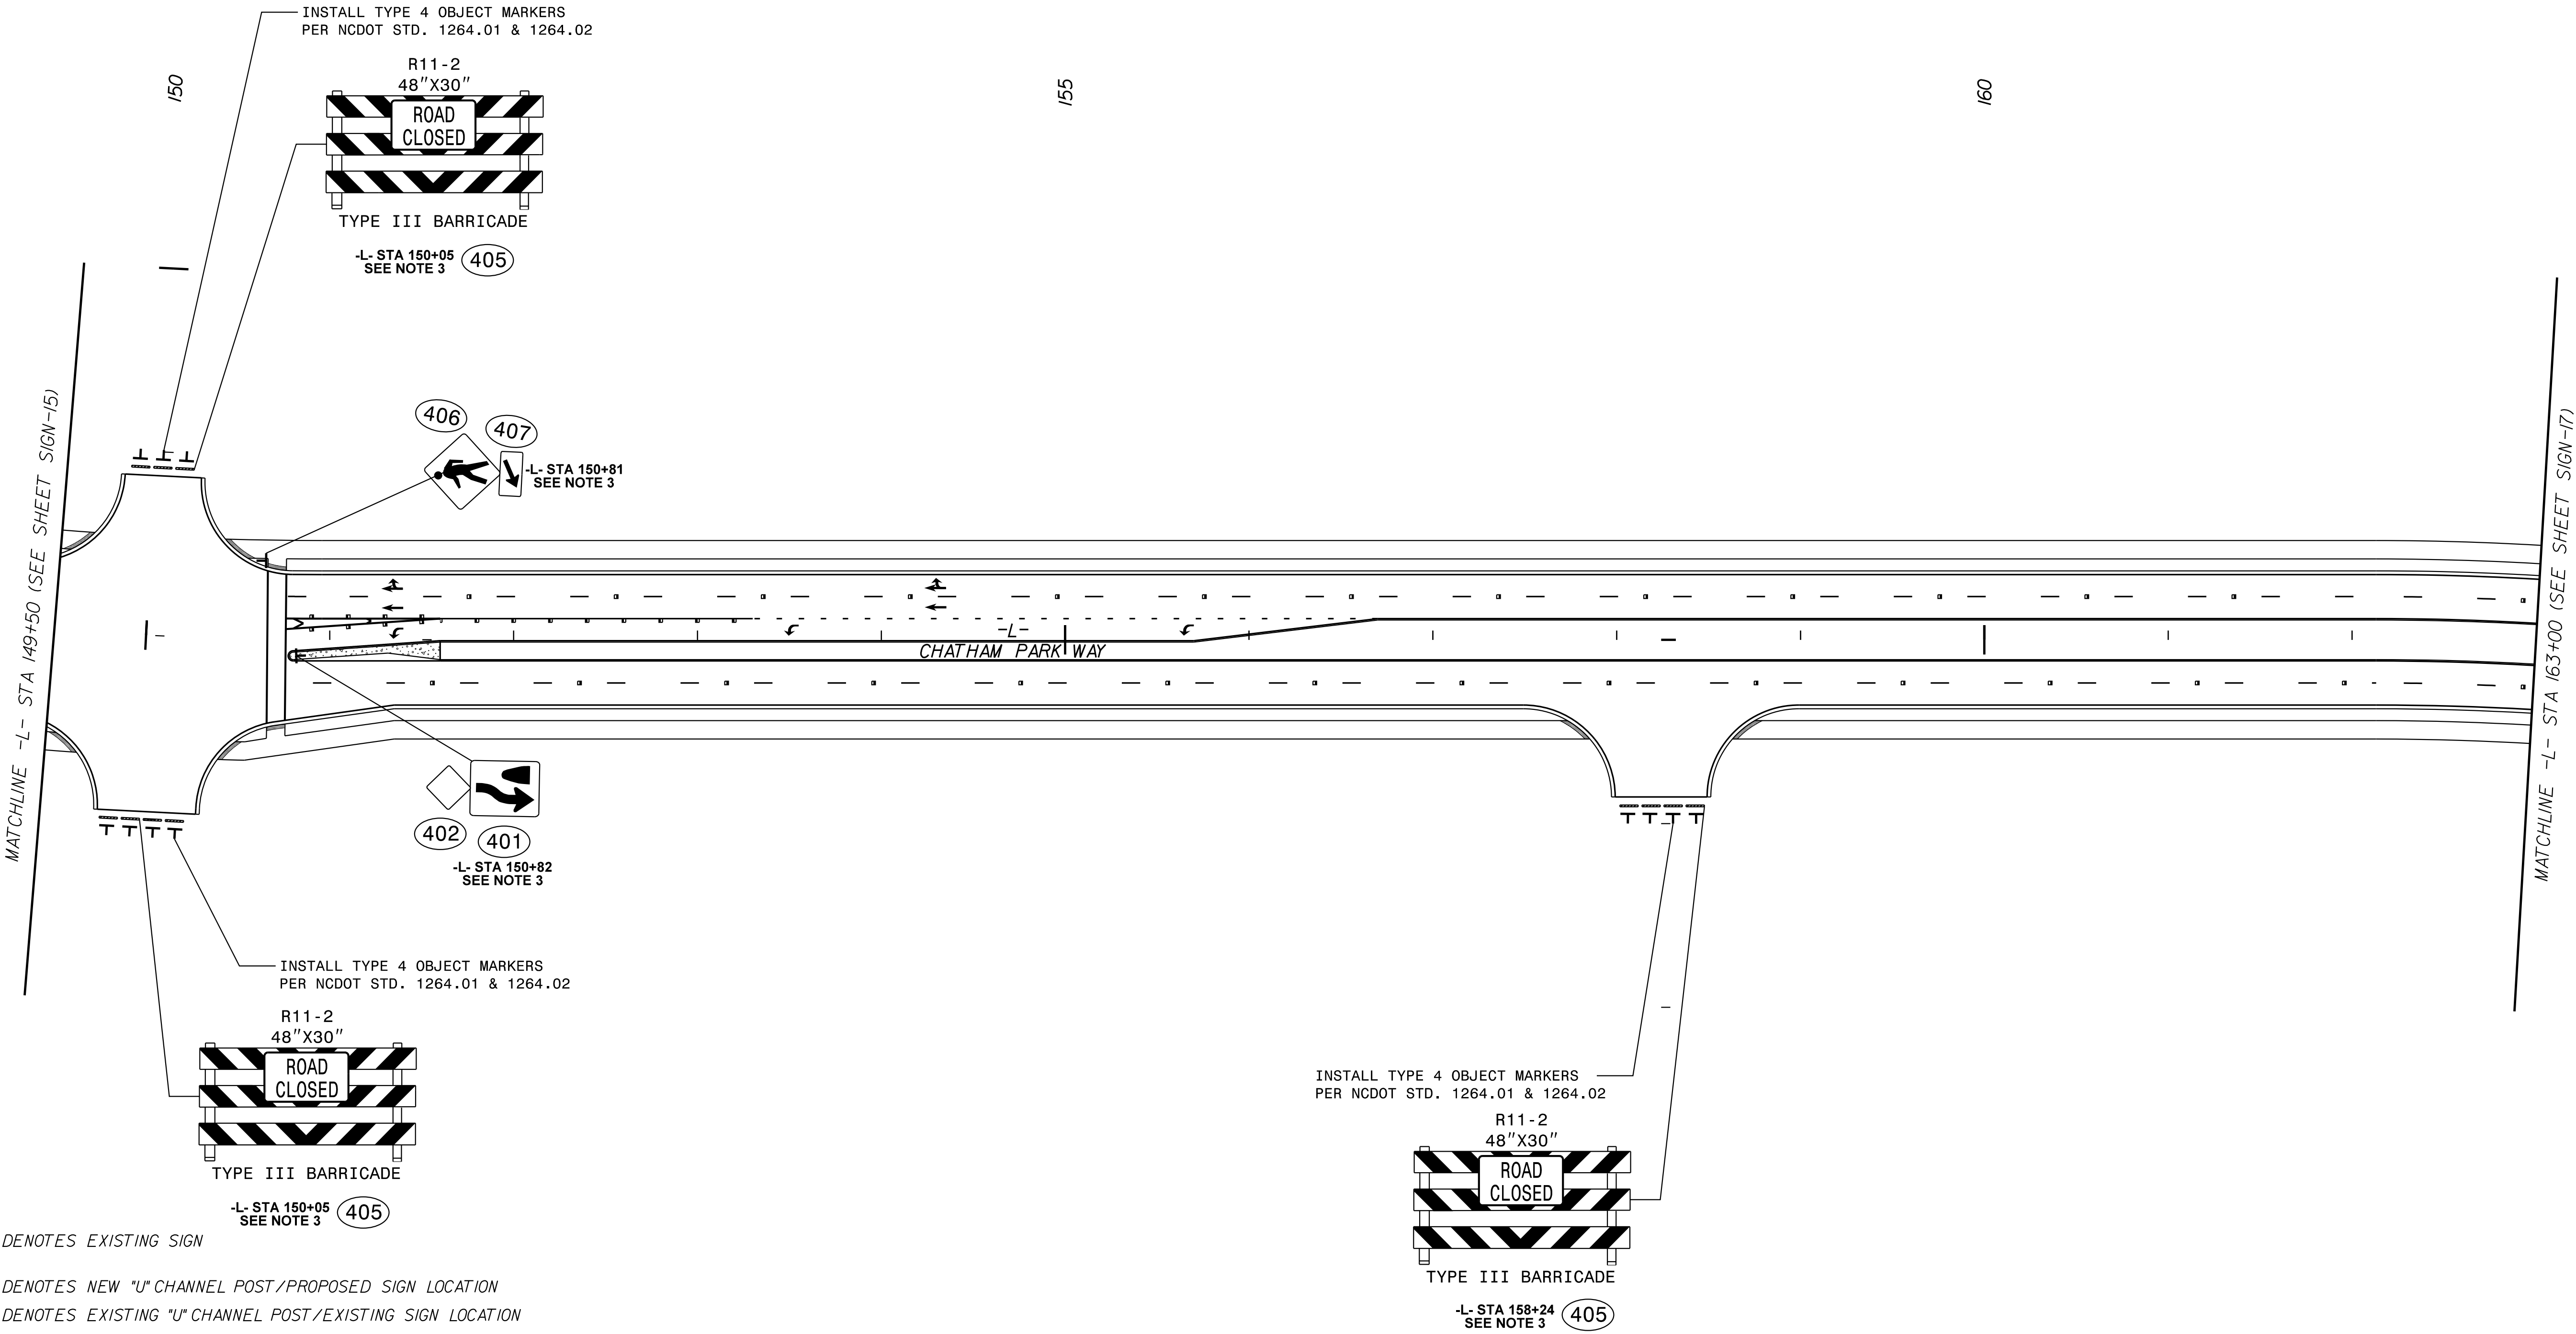

- DENOTES EXISTING SIGN
- DENOTES NEW "U" CHANNEL POST/PROPOSED SIGN LOCATION
- DENOTES EXISTING "U" CHANNEL POST/EXISTING SIGN LOCATION
- RETAIN ALL EXISTING SIGNS NOT SHOWN IN PLANS

PROJECT NOTES


- DISPOSAL OF SIGN SYSTEM, U-CHANNEL
- SIGN ERECTION, TYPE D
- SIGN ERECTION, TYPE E
- SIGN ERECTION, TYPE F

SIGNING PLAN

Kimley»Horn

421 FAYETTEVILLE STREET, SUITE 600
RALEIGH, N.C. 27601. NC LICENSE #F-0102

TIP NO. SHEET NO.
R-5963A SIGN-17

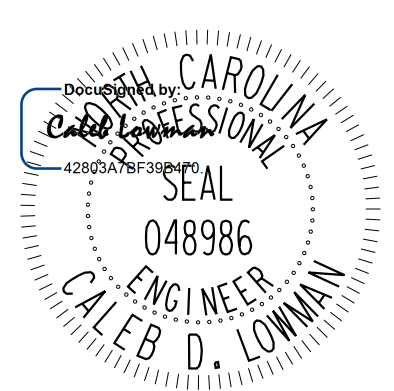

DOCUMENT NOT CONSIDERED FINAL
UNLESS ALL SIGNATURES COMPLETED

NAD 83 / N A 2011


K:\RAL_Roadway\01036734 - R-5963A&B\Signing and Delineation\Design\Sheets\R-5963A&B_rdy_sgn_17.dgn


- DENOTES EXISTING SIGN
- DENOTES NEW "U" CHANNEL POST/PROPOSED SIGN LOCATION
- DENOTES EXISTING "U" CHANNEL POST/EXISTING SIGN LOCATION
- RETAIN ALL EXISTING SIGNS NOT SHOWN IN PLANS

PROJECT NOTES

- DISPOSAL OF SIGN SYSTEM, U-CHANNEL
- SIGN ERECTION, TYPE D
- SIGN ERECTION, TYPE E
- SIGN ERECTION, TYPE F

SIGNING PLAN

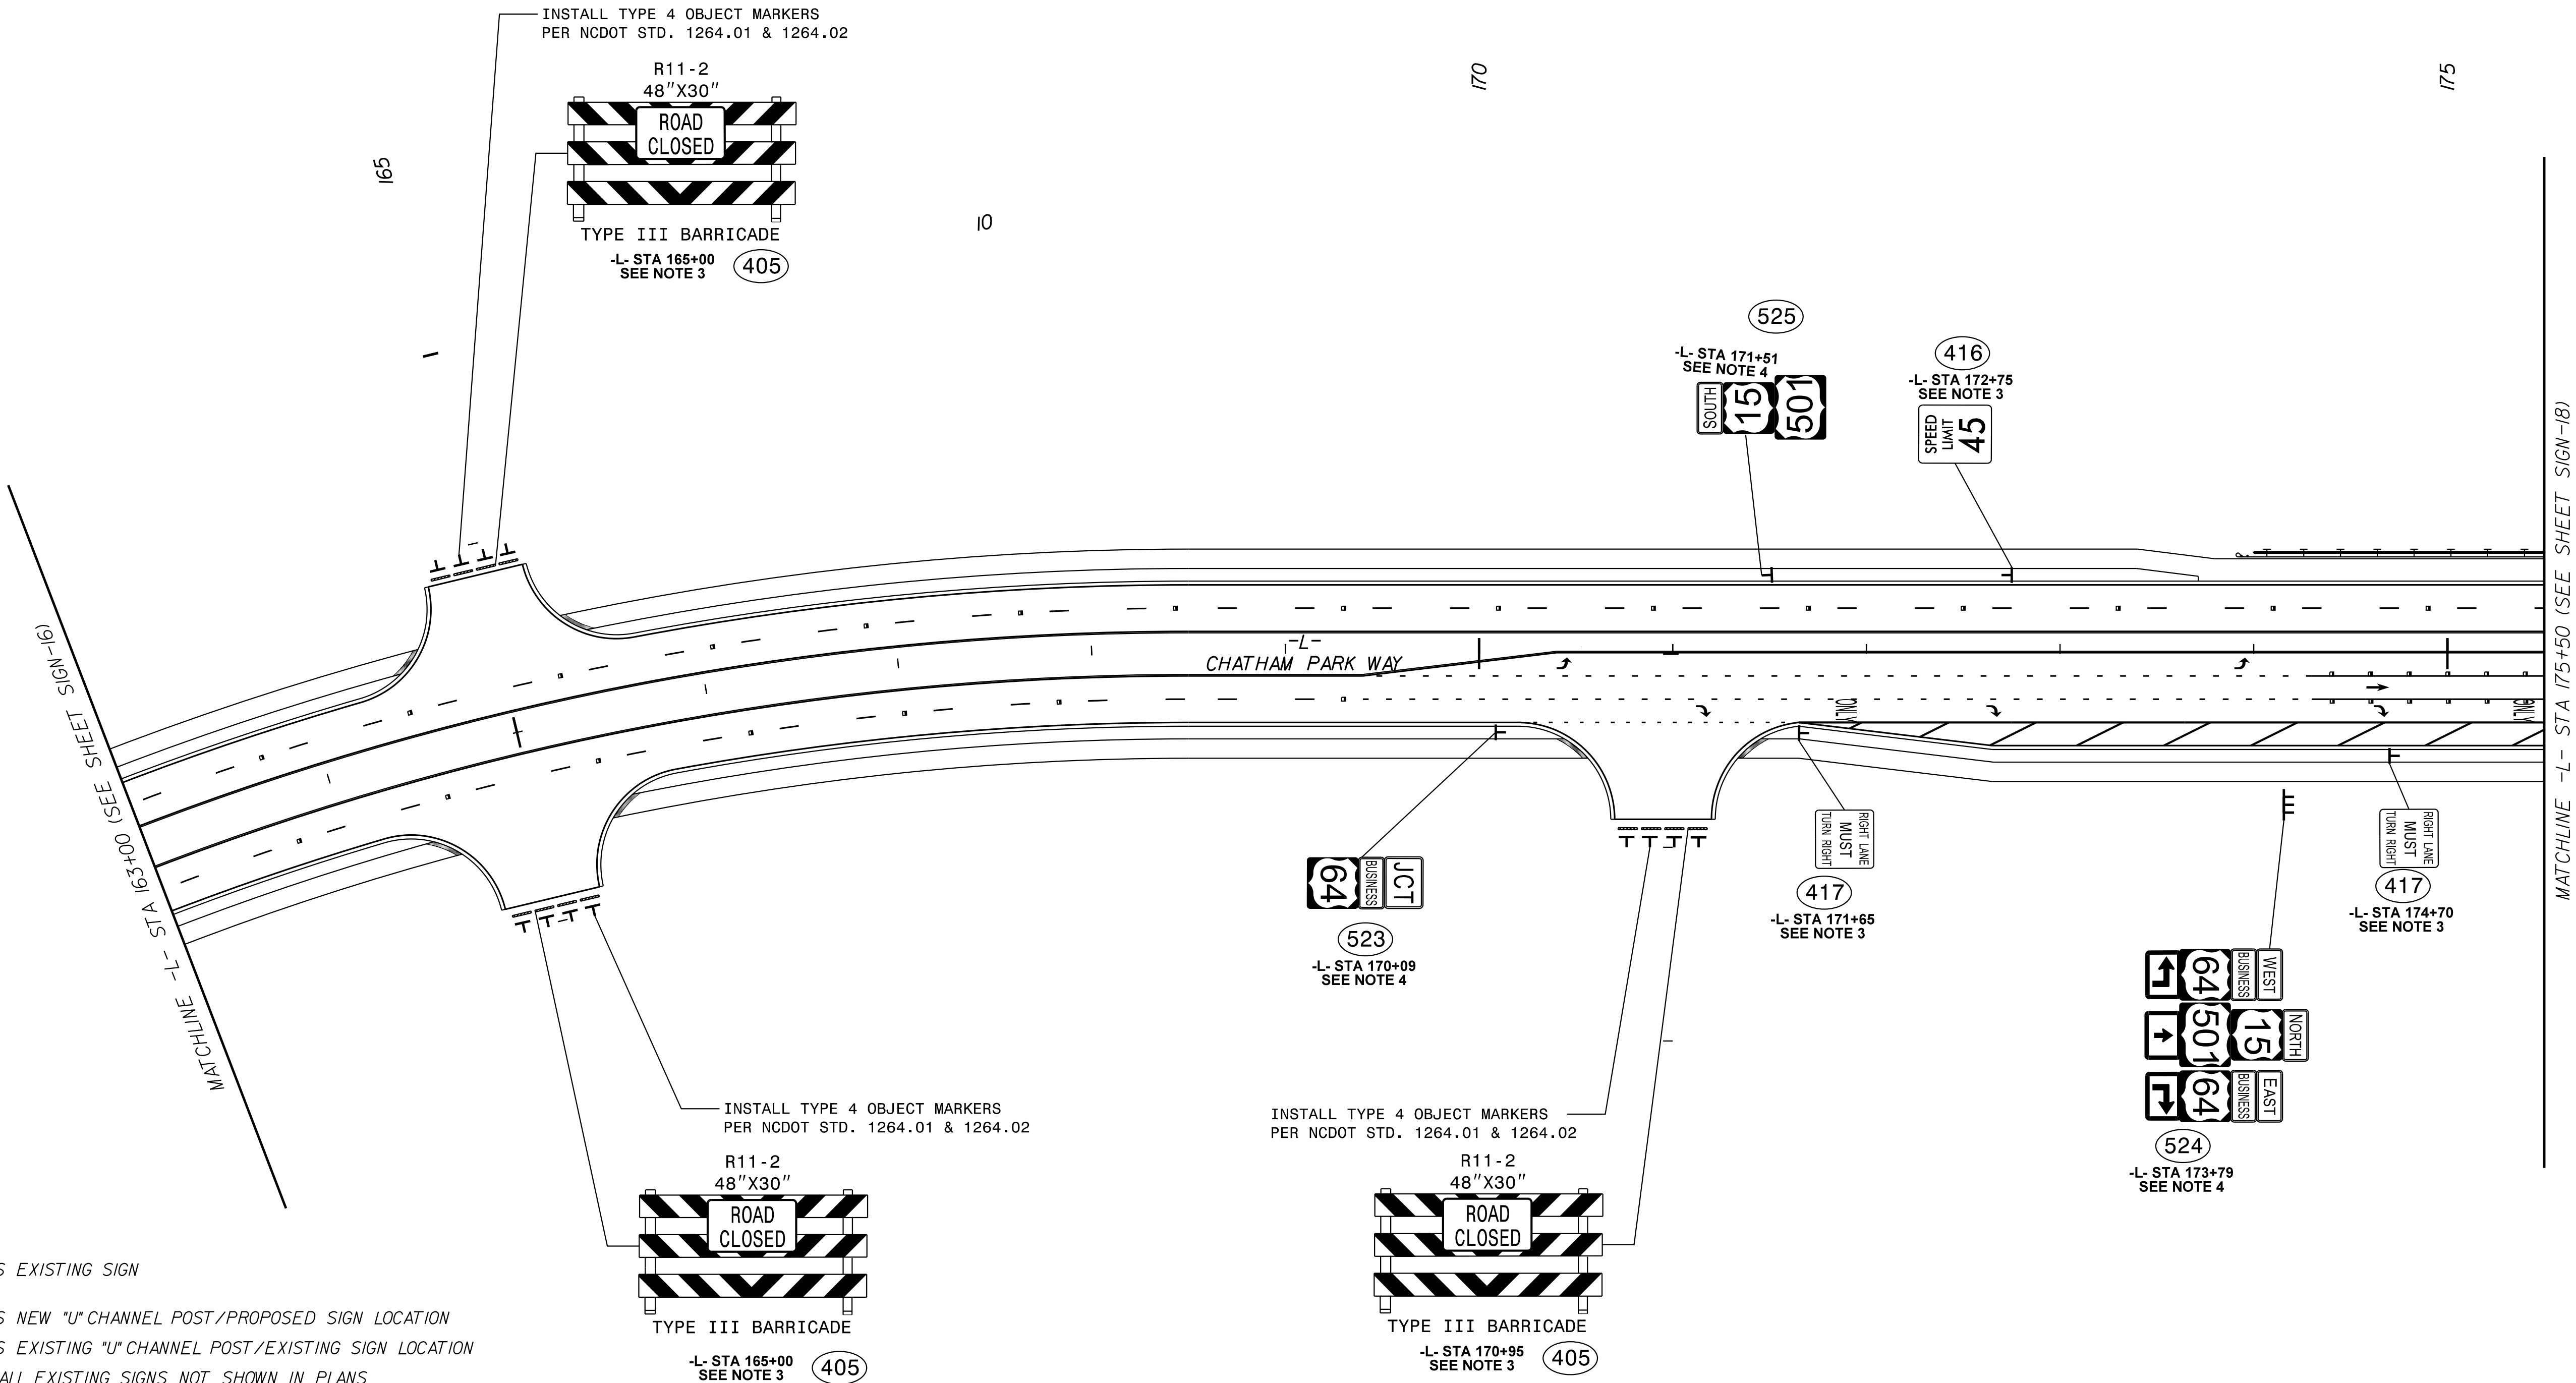

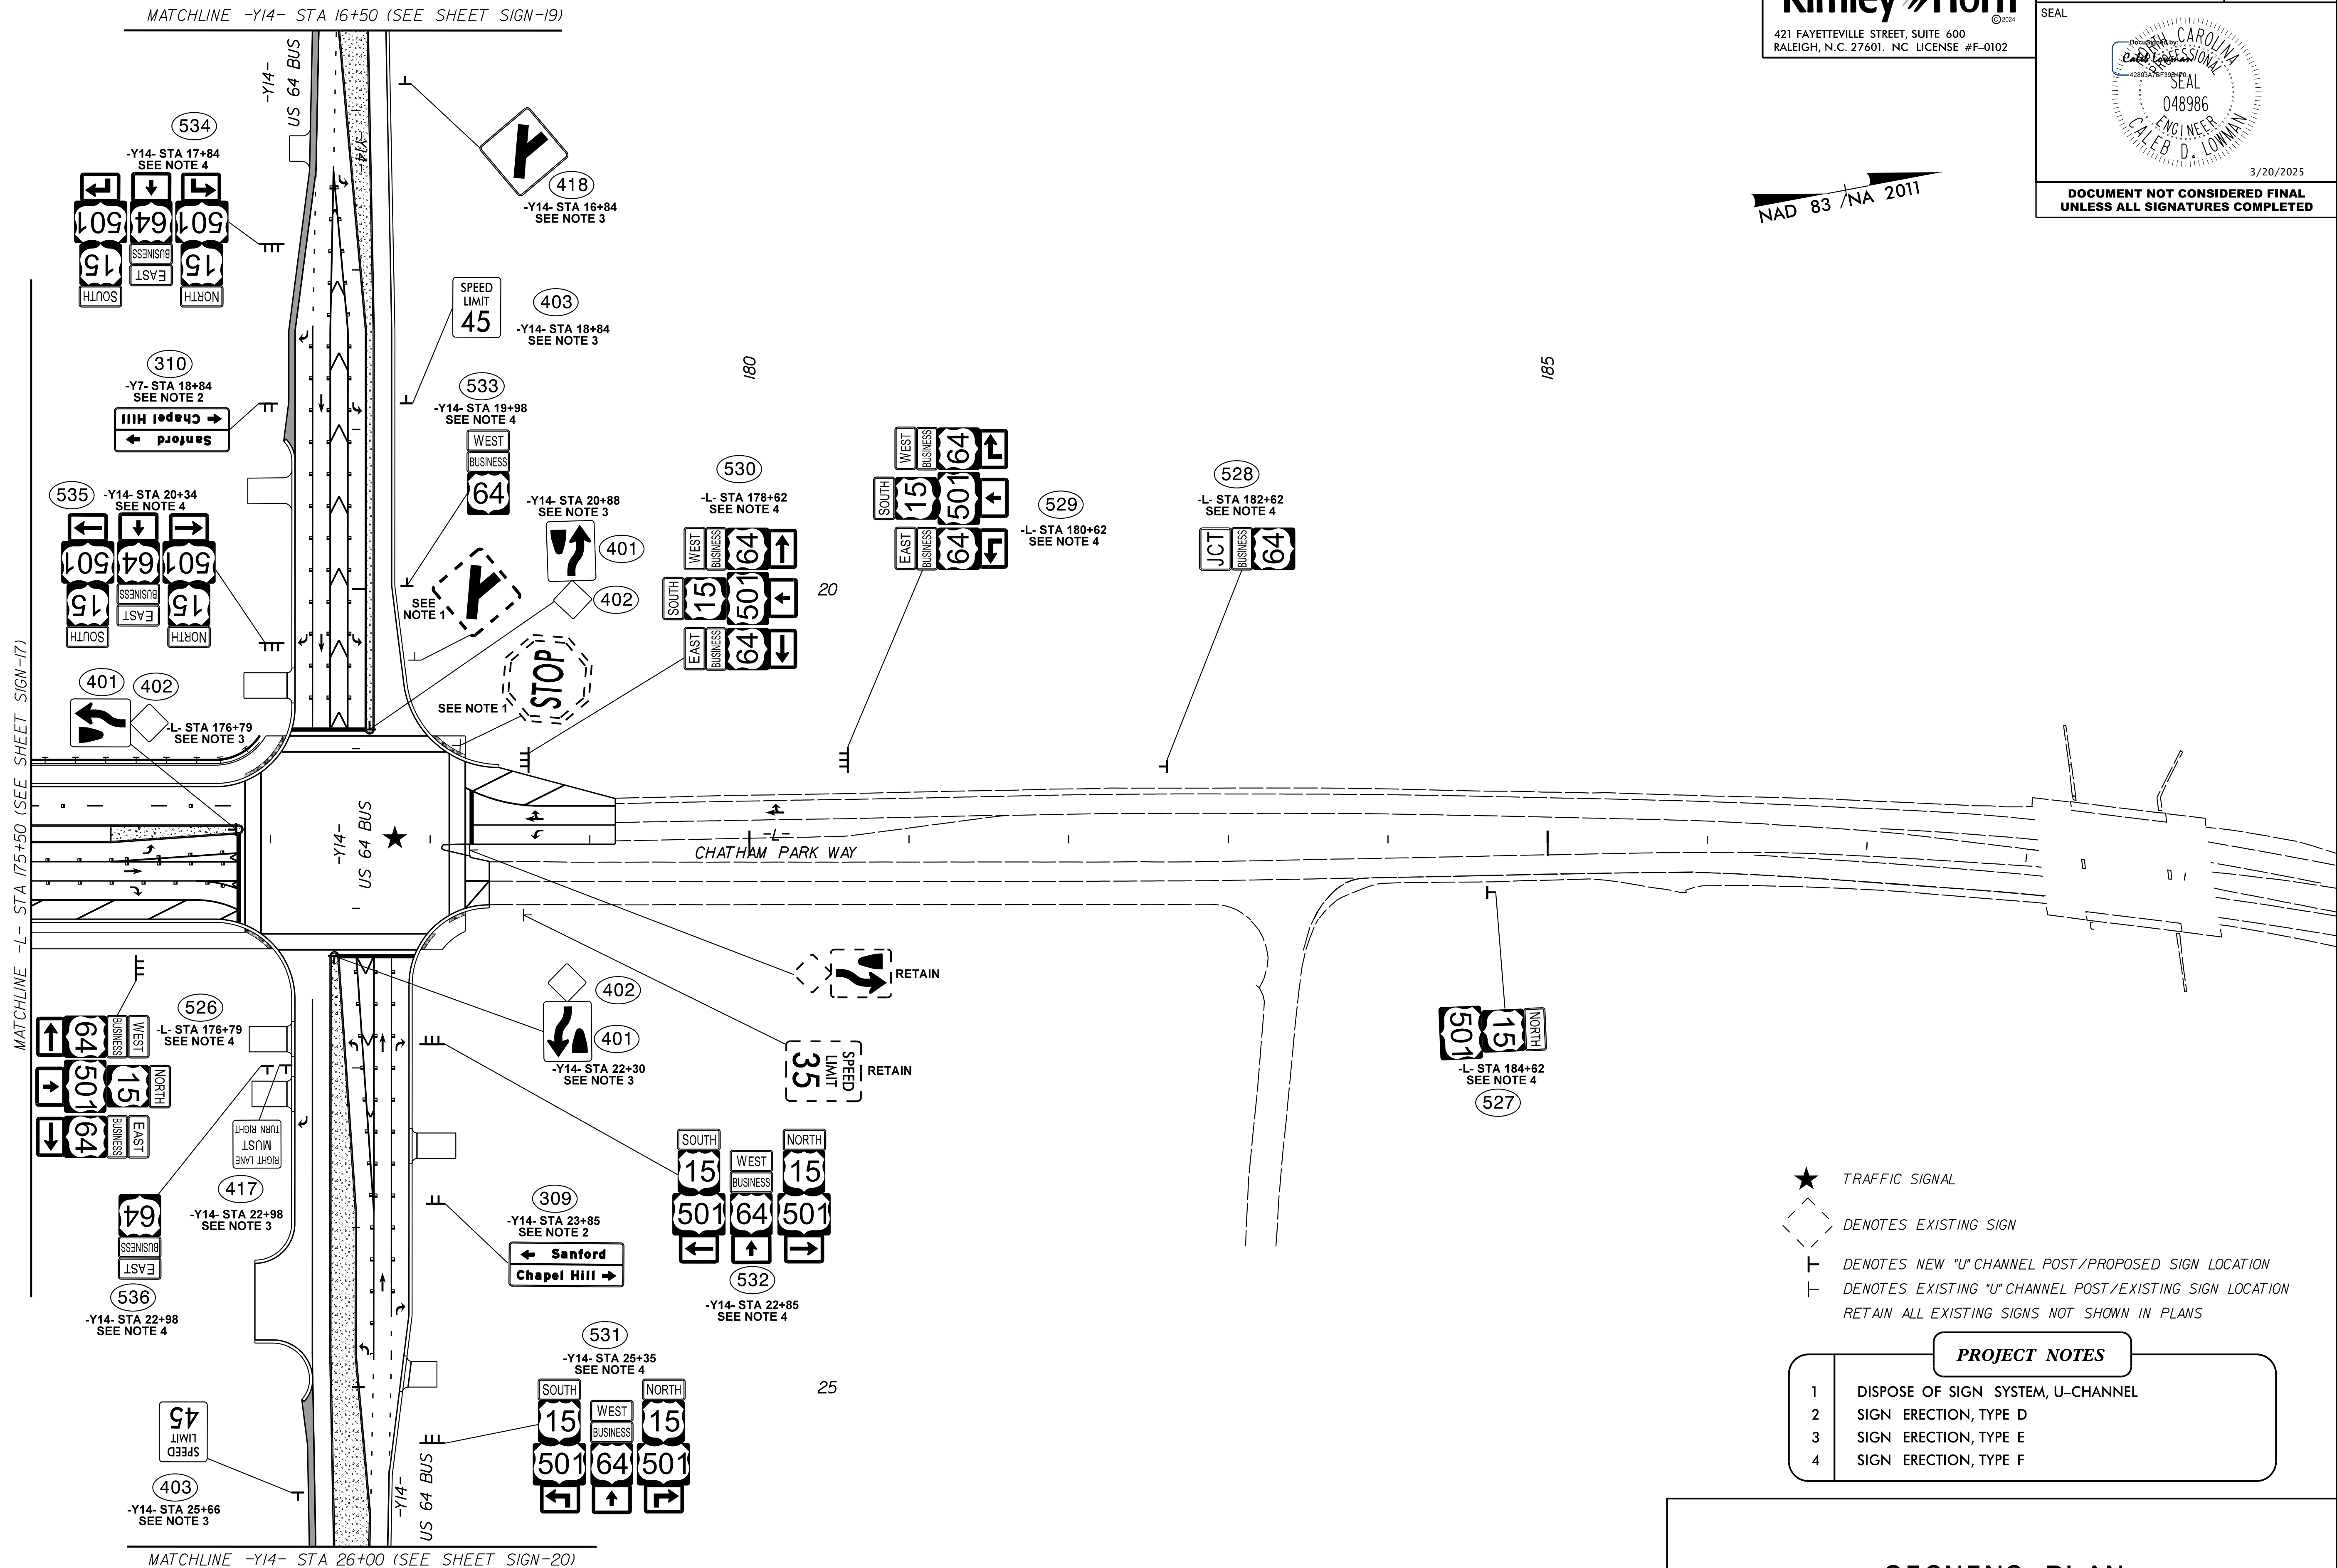

K:\RAL_Roadway\01036734 - R-5963A&B\Signing and Delineation\Design\Sheets\R-5963A&B_rdy_sgn_18.dgn

1/15/2025

Kimley »Horn

421 FAYETTEVILLE STREET, SUITE 600
RALEIGH, N.C. 27601. NC LICENSE #F-0102

© 2024

Professional Engineer
048986
CALEB D. LOWMAN

TIP NO.
R-5963A

SHEET NO.
SIGN-19

SEAL

3/20/2025

DOCUMENT NOT CONSIDERED FINAL
UNLESS ALL SIGNATURES COMPLETED

DENOTES EXISTING SIGN

DENOTES NEW "U" CHANNEL POST/PROPOSED SIGN LOCATION

DENOTES EXISTING "U" CHANNEL POST/EXISTING SIGN LOCATION

RETAIN ALL EXISTING SIGNS NOT SHOWN IN PLANS

PROJECT NOTES	
1	DISPOSAL OF SIGN SYSTEM, U-CHANNEL
2	SIGN ERECTION, TYPE D
3	SIGN ERECTION, TYPE E
4	SIGN ERECTION, TYPE F

SIGNING PLAN

Kimley»Horn

421 FAYETTEVILLE STREET, SUITE 600
RALEIGH, N.C. 27601. NC LICENSE #F-0102


TIP NO.

R-5963A

SHEET NO.

SIGN-20


SEAL

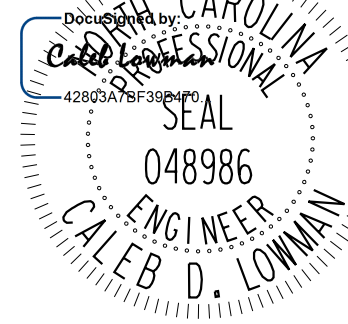

3/20/2025

DOCUMENT NOT CONSIDERED FINAL
UNLESS ALL SIGNATURES COMPLETED

NAD 83 / NA 2011

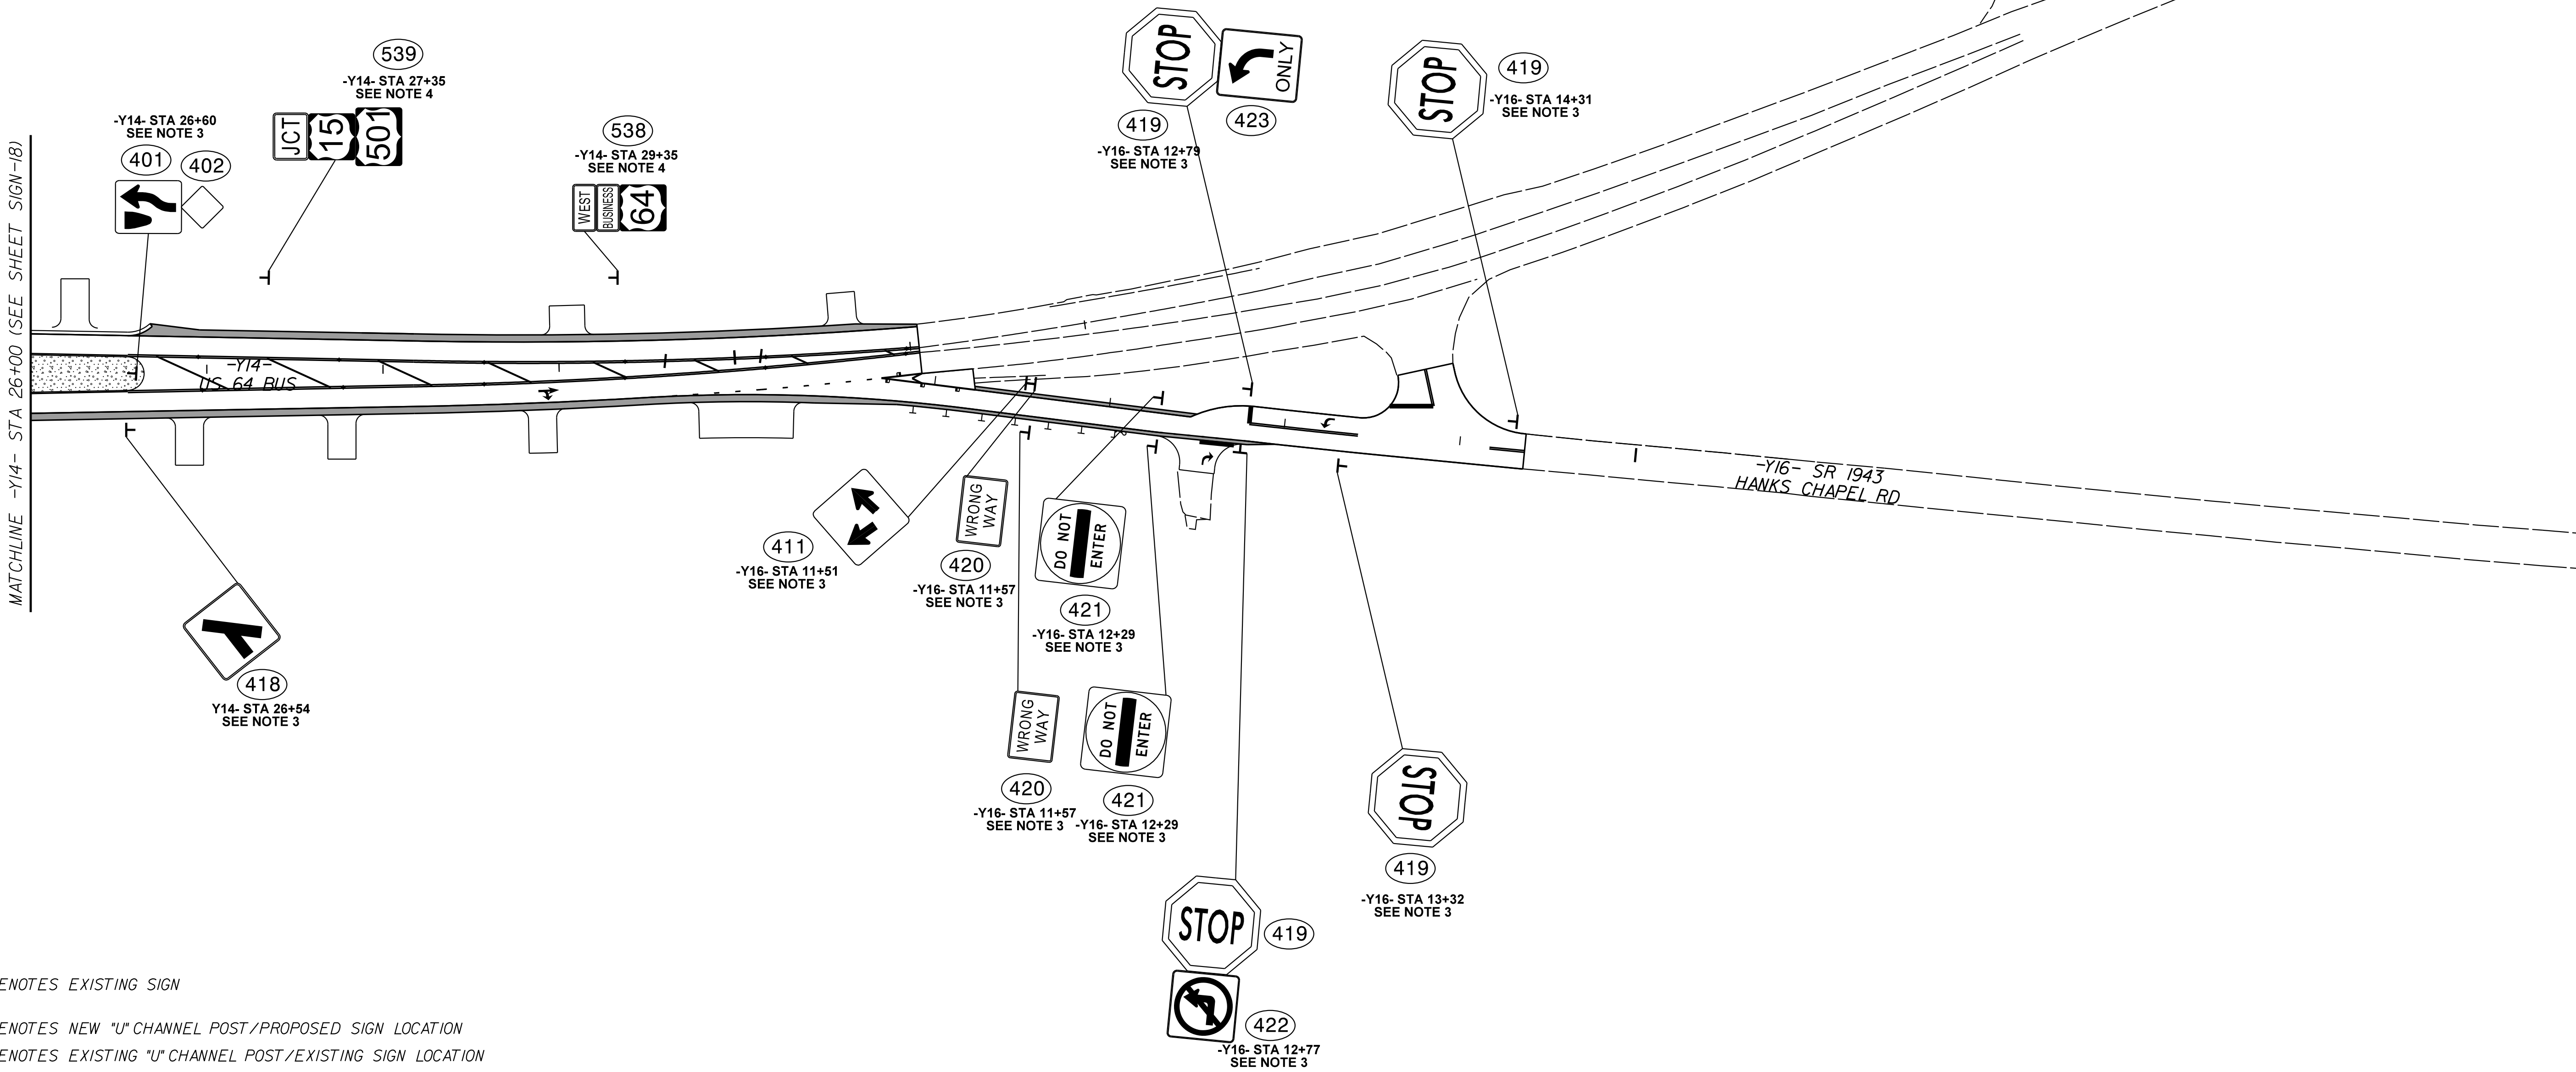

DENOTES EXISTING SIGN

DENOTES NEW "U" CHANNEL POST/PROPOSED SIGN LOCATION

DENOTES EXISTING "U" CHANNEL POST/EXISTING SIGN LOCATION

RETAIN ALL EXISTING SIGNS NOT SHOWN IN PLANS


PROJECT NOTES

- 1 DISPOSAL OF SIGN SYSTEM, U-CHANNEL
- 2 SIGN ERECTION, TYPE D
- 3 SIGN ERECTION, TYPE E
- 4 SIGN ERECTION, TYPE F

SIGNING PLAN

K:\RAL_Roadway\01036734 - R-5963A&B\Signing and Delineation\Design\Sheets\R-5963A&B_rdy_sgn_21.dgn

1/15/2025

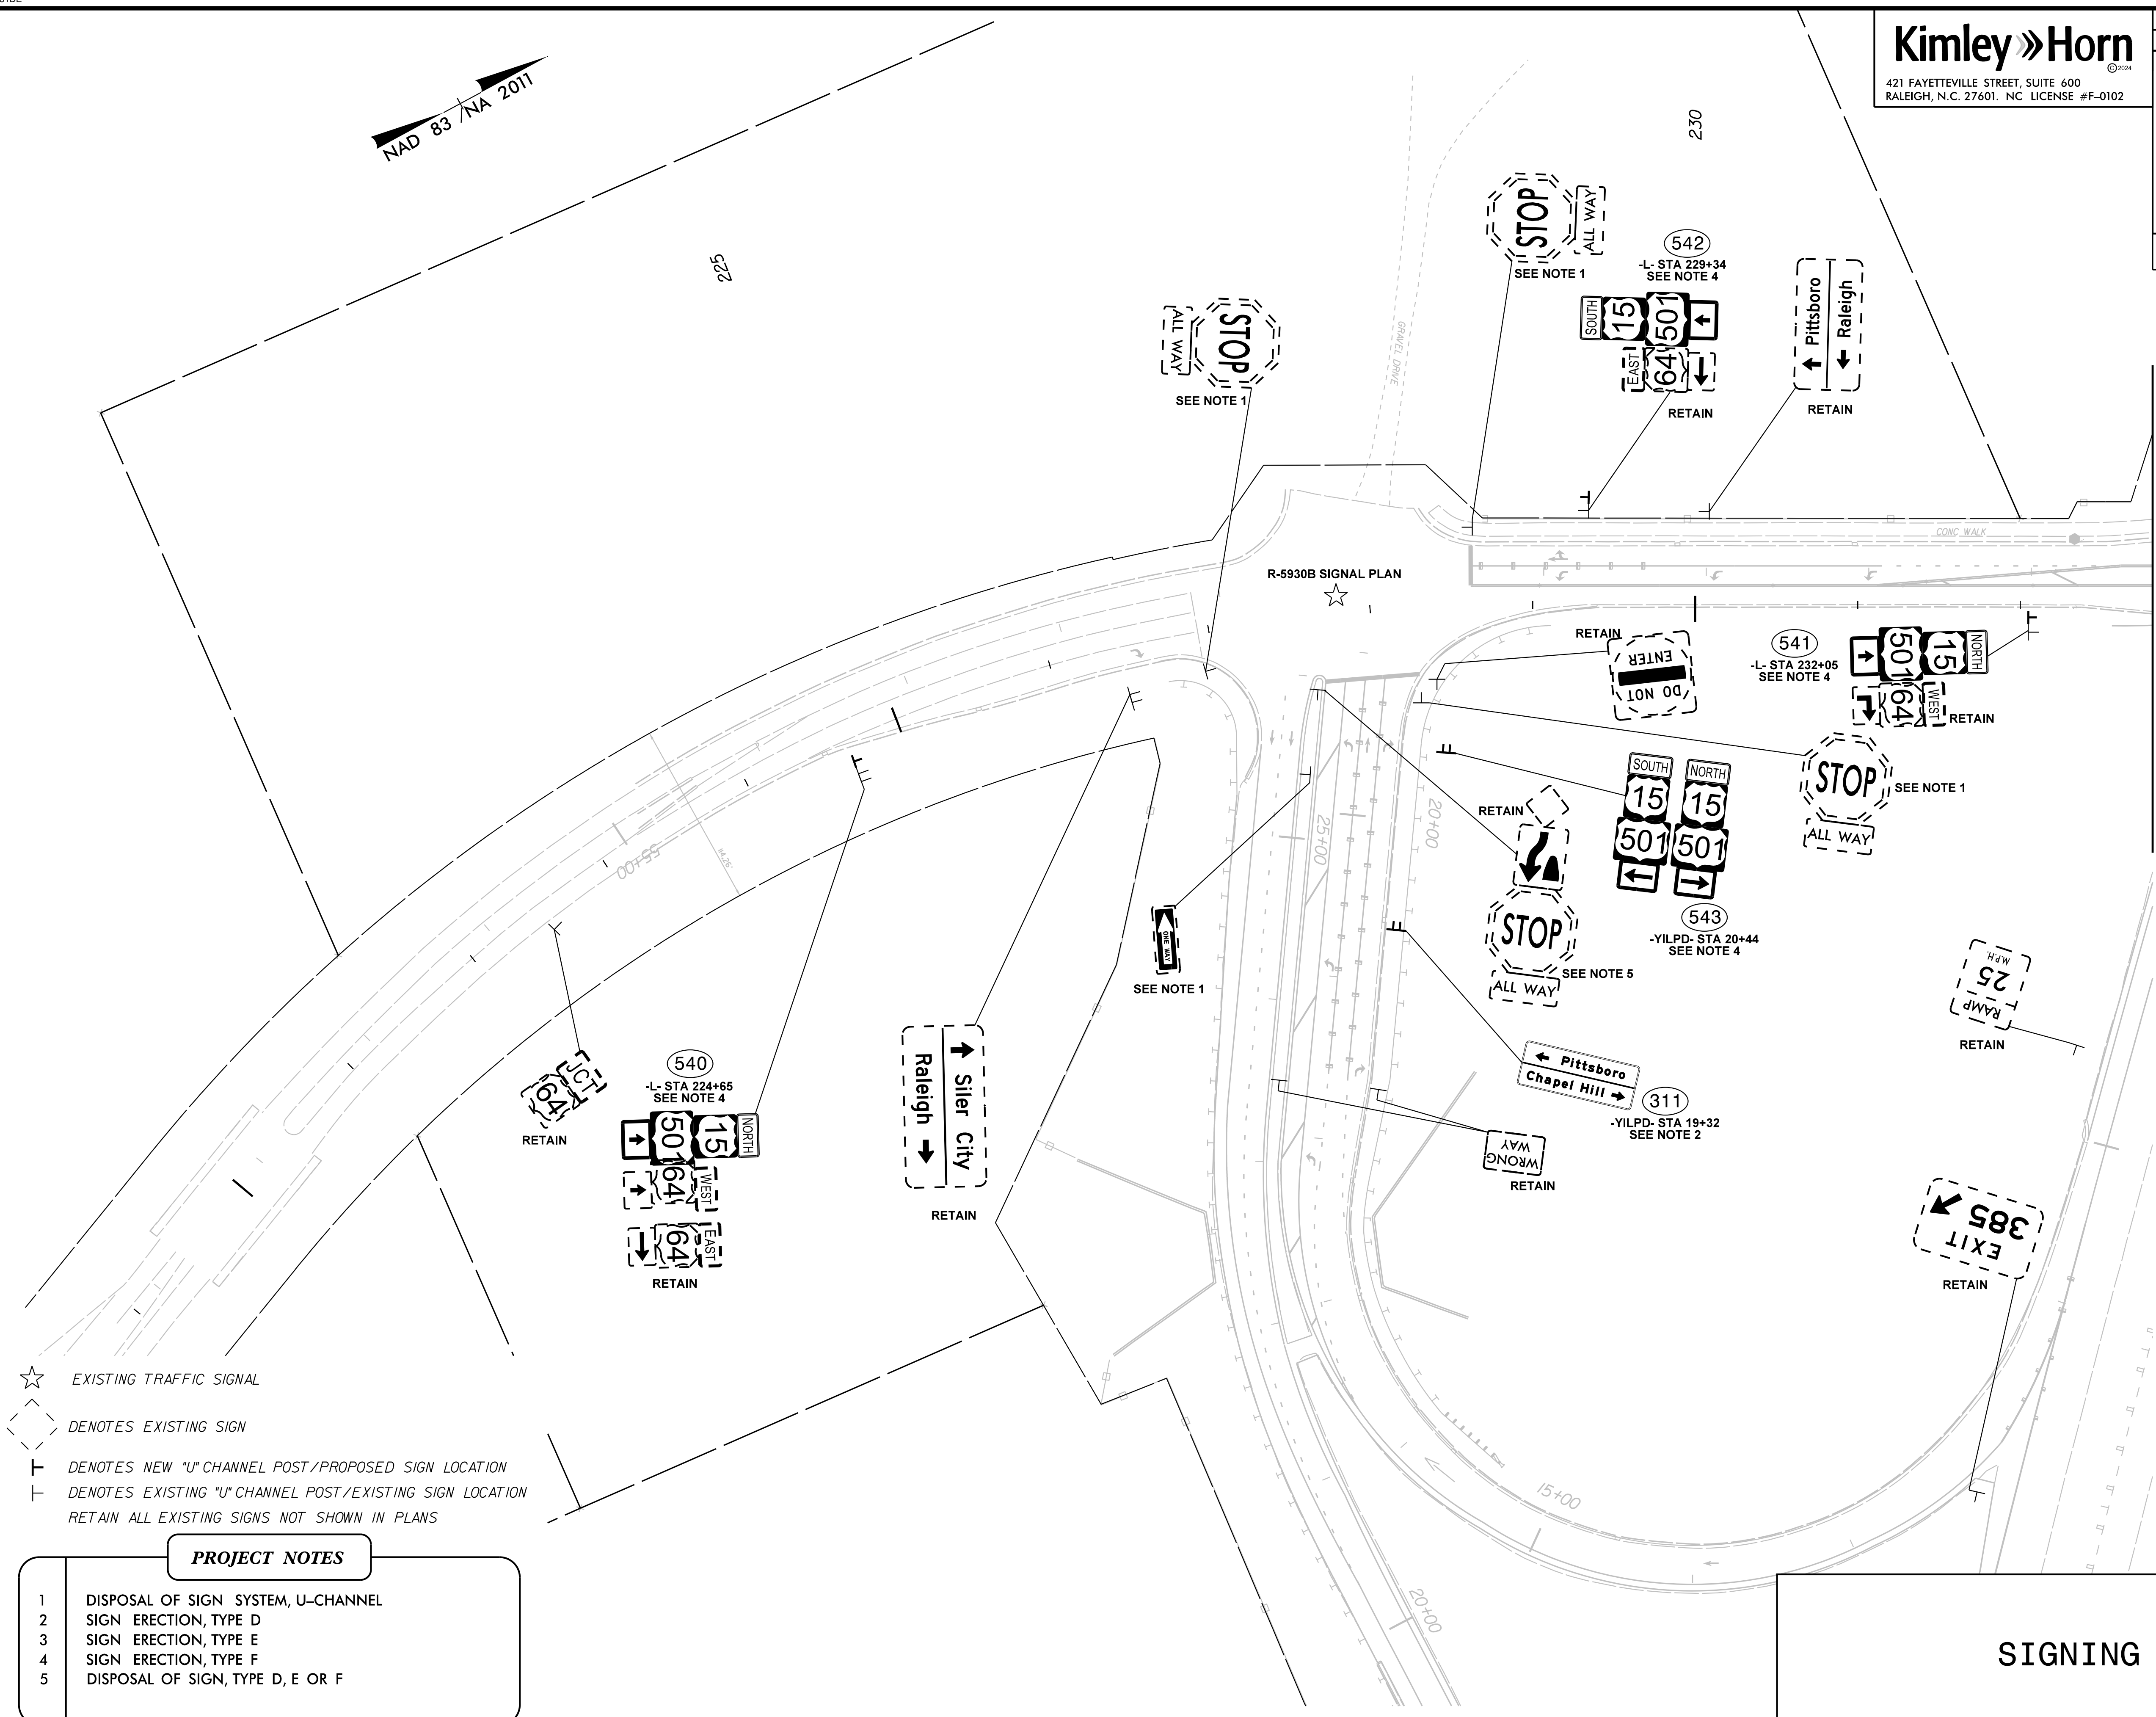

- ☆ EXISTING TRAFFIC SIGNAL
- - - DENOTES EXISTING SIGN
- T DENOTES NEW "U" CHANNEL POST/PROPOSED SIGN LOCATION
- T DENOTES EXISTING "U" CHANNEL POST/EXISTING SIGN LOCATION
- RETAIN ALL EXISTING SIGNS NOT SHOWN IN PLANS

PROJECT NOTES

- 1 DISPOSAL OF SIGN SYSTEM, U-CHANNEL
- 2 SIGN ERECTION, TYPE D
- 3 SIGN ERECTION, TYPE E
- 4 SIGN ERECTION, TYPE F
- 5 DISPOSAL OF SIGN, TYPE D, E OR F

Kimley»Horn
421 FAYETTEVILLE STREET, SUITE 600
RALEIGH, N.C. 27601. NC LICENSE #F-0102

Professional Engineer
048986
CALEB D. LOWMAN

3/20/2025

TIP NO.
R-5963A


SHEET NO.
SIGN-21

DOCUMENT NOT CONSIDERED FINAL
UNLESS ALL SIGNATURES COMPLETED

SIGNING PLAN

K:\PAL_Roadway\01036734 - R-5963A&B\Signing and Delineation\Design\Sheets\R-5963A&B_rdy_sgn_22.dgn

1/15/2025

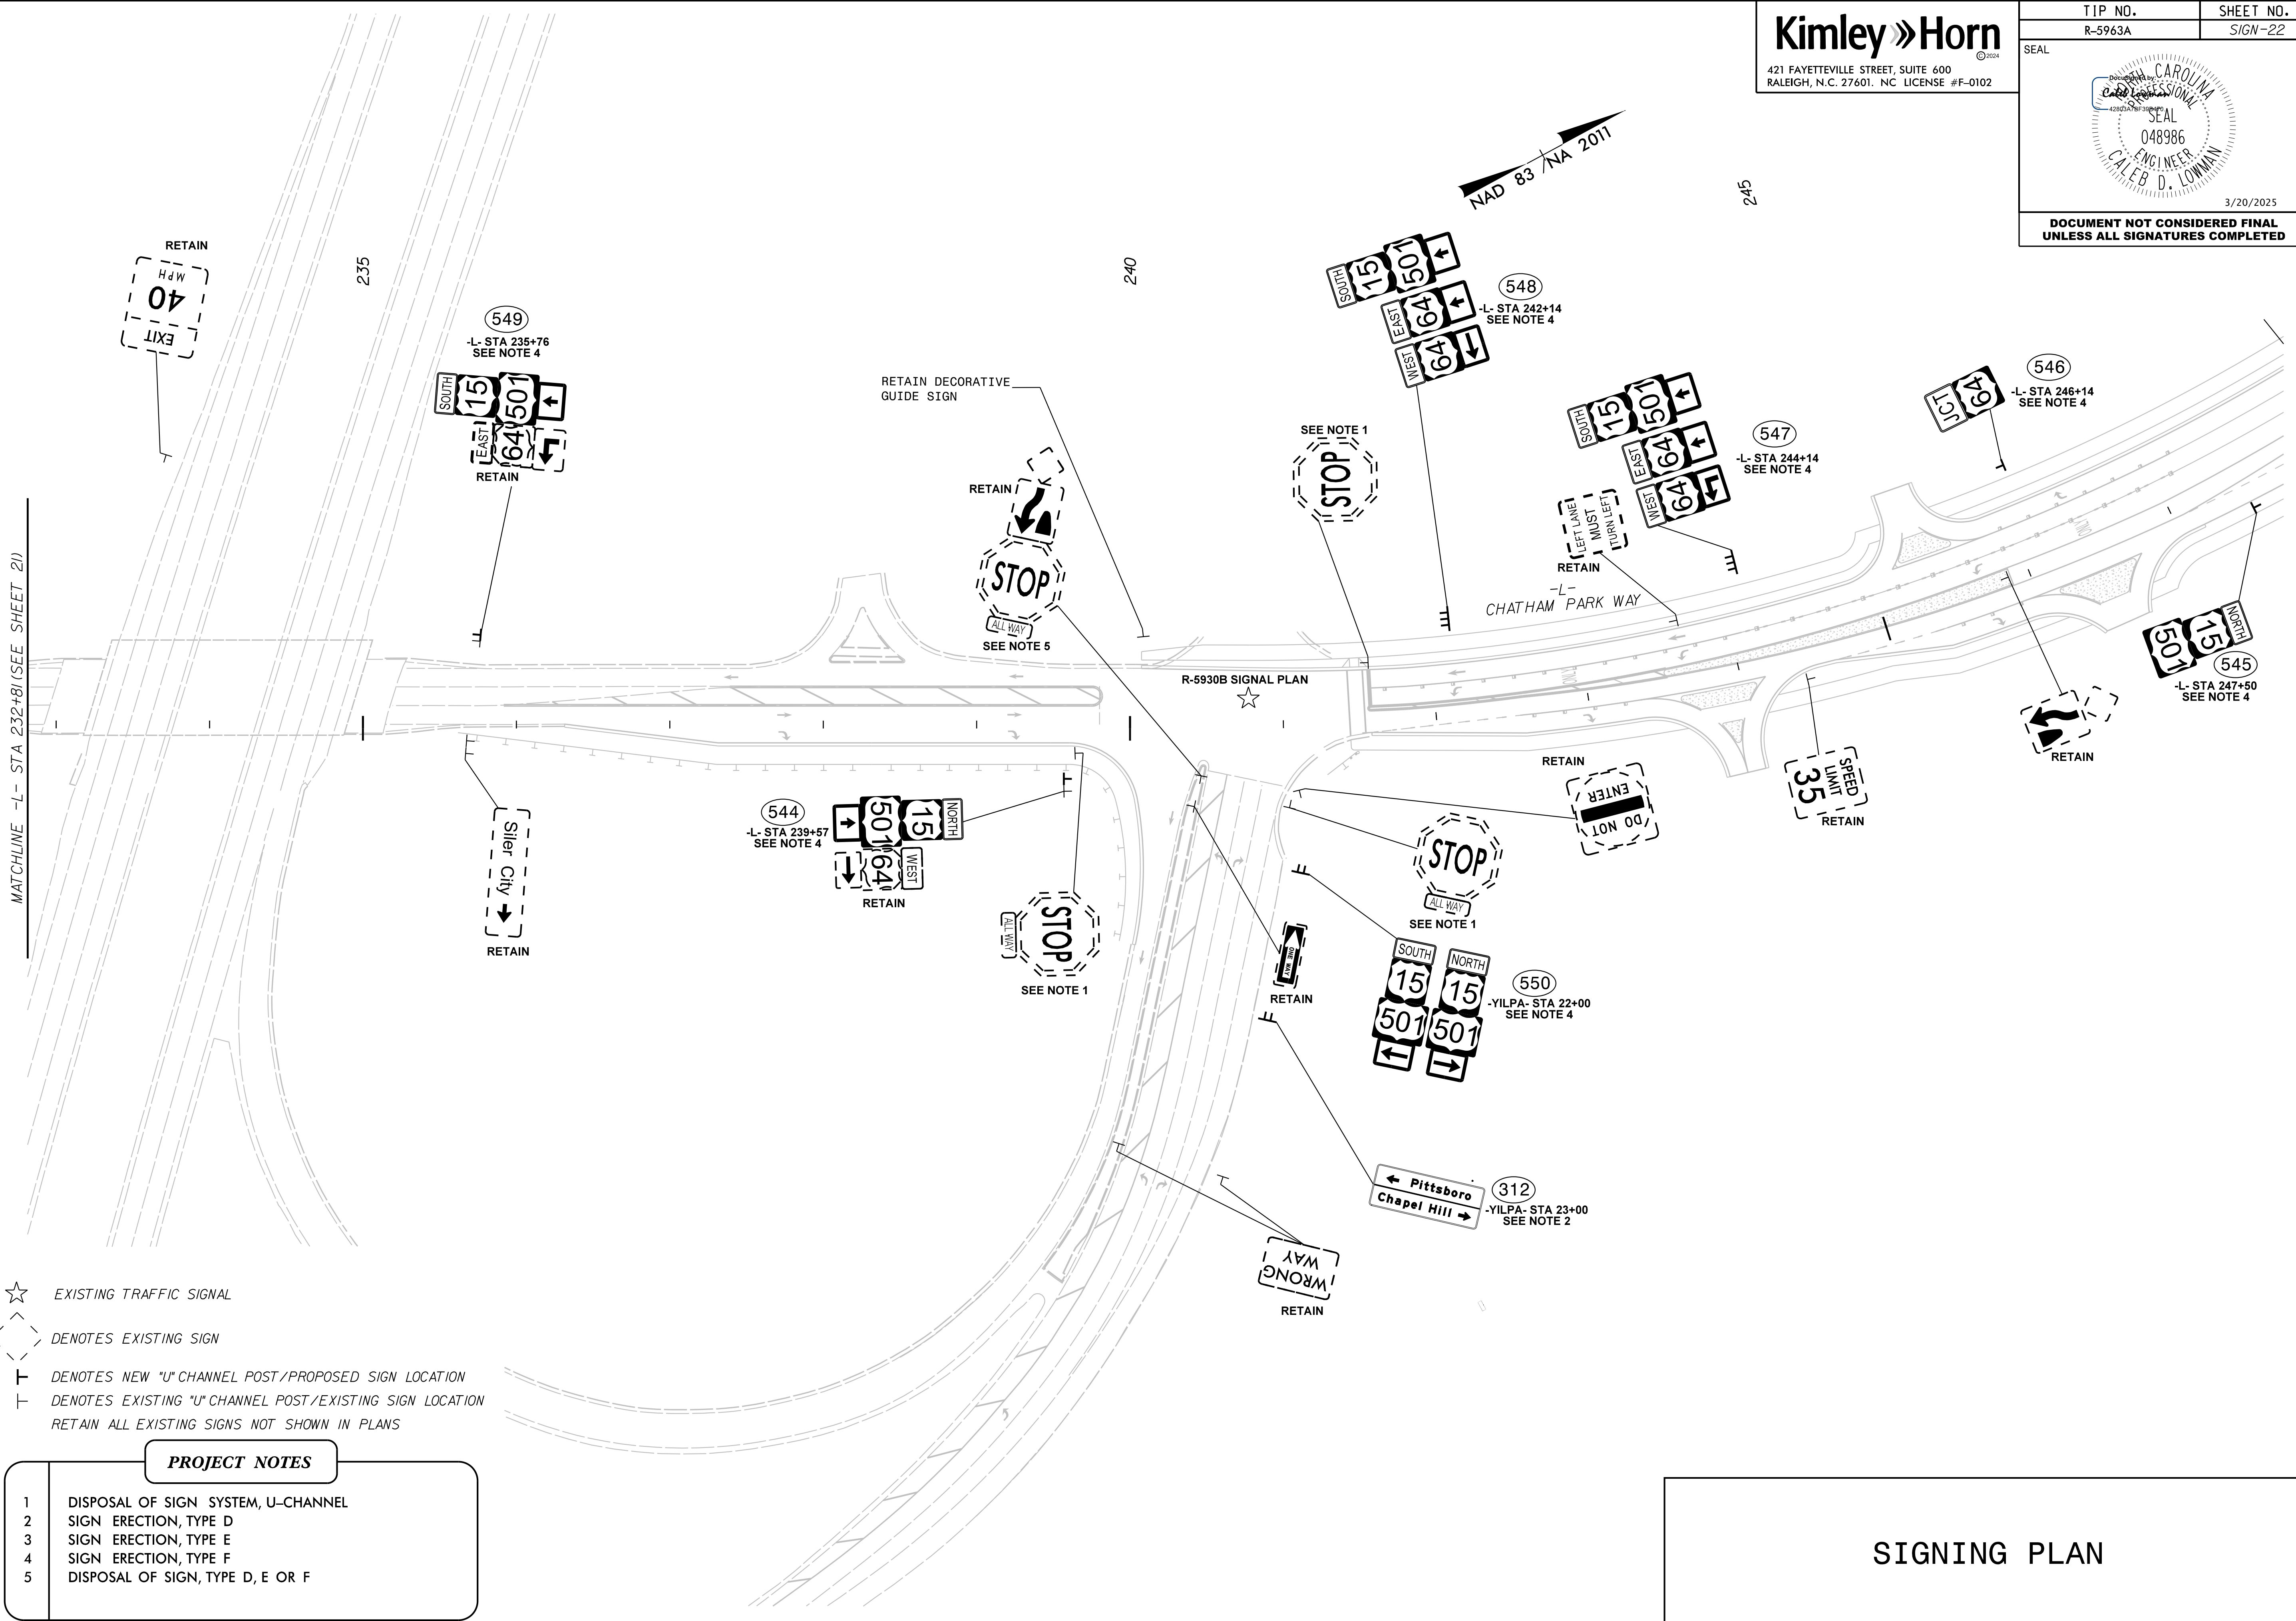

- ☆ EXISTING TRAFFIC SIGNAL
- - - DENOTES EXISTING SIGN
- T DENOTES NEW "U" CHANNEL POST/PROPOSED SIGN LOCATION
- T DENOTES EXISTING "U" CHANNEL POST/EXISTING SIGN LOCATION
- RETAIN ALL EXISTING SIGNS NOT SHOWN IN PLANS

PROJECT NOTES


- 1 DISPOSAL OF SIGN SYSTEM, U-CHANNEL
- 2 SIGN ERECTION, TYPE D
- 3 SIGN ERECTION, TYPE E
- 4 SIGN ERECTION, TYPE F
- 5 DISPOSAL OF SIGN, TYPE D, E OR F

Kimley»Horn

421 FAYETTEVILLE STREET, SUITE 600
RALEIGH, N.C. 27601. NC LICENSE #F-0102

TIP NO. SHEET NO.
R-5963A SIGN-22

SEAL

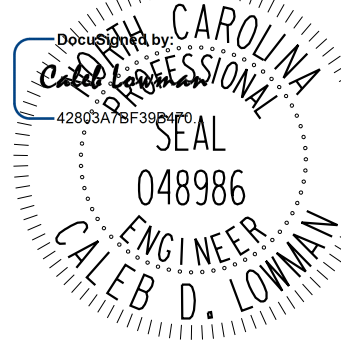

3/20/2025

DOCUMENT NOT CONSIDERED FINAL
UNLESS ALL SIGNATURES COMPLETED

SIGNING PLAN

K:\RAL_Roadway\01036734 - R-5963A&B\Signing and Delineation\Design\Sheets\R-5963A&B_rdy_sgn_23.dgn

1/15/2025

Kimley »Horn



421 FAYETTEVILLE STREET, SUITE 600
RALEIGH, N.C. 27601. NC LICENSE #F-0102

TIP NO.	SHEET NO.
R-5963A	SIGN-23

SEAL

Professional Engineer
CALEB D. LOWMAN
048986
3/20/2025

**DOCUMENT NOT CONSIDERED FINAL
UNLESS ALL SIGNATURES COMPLETED**

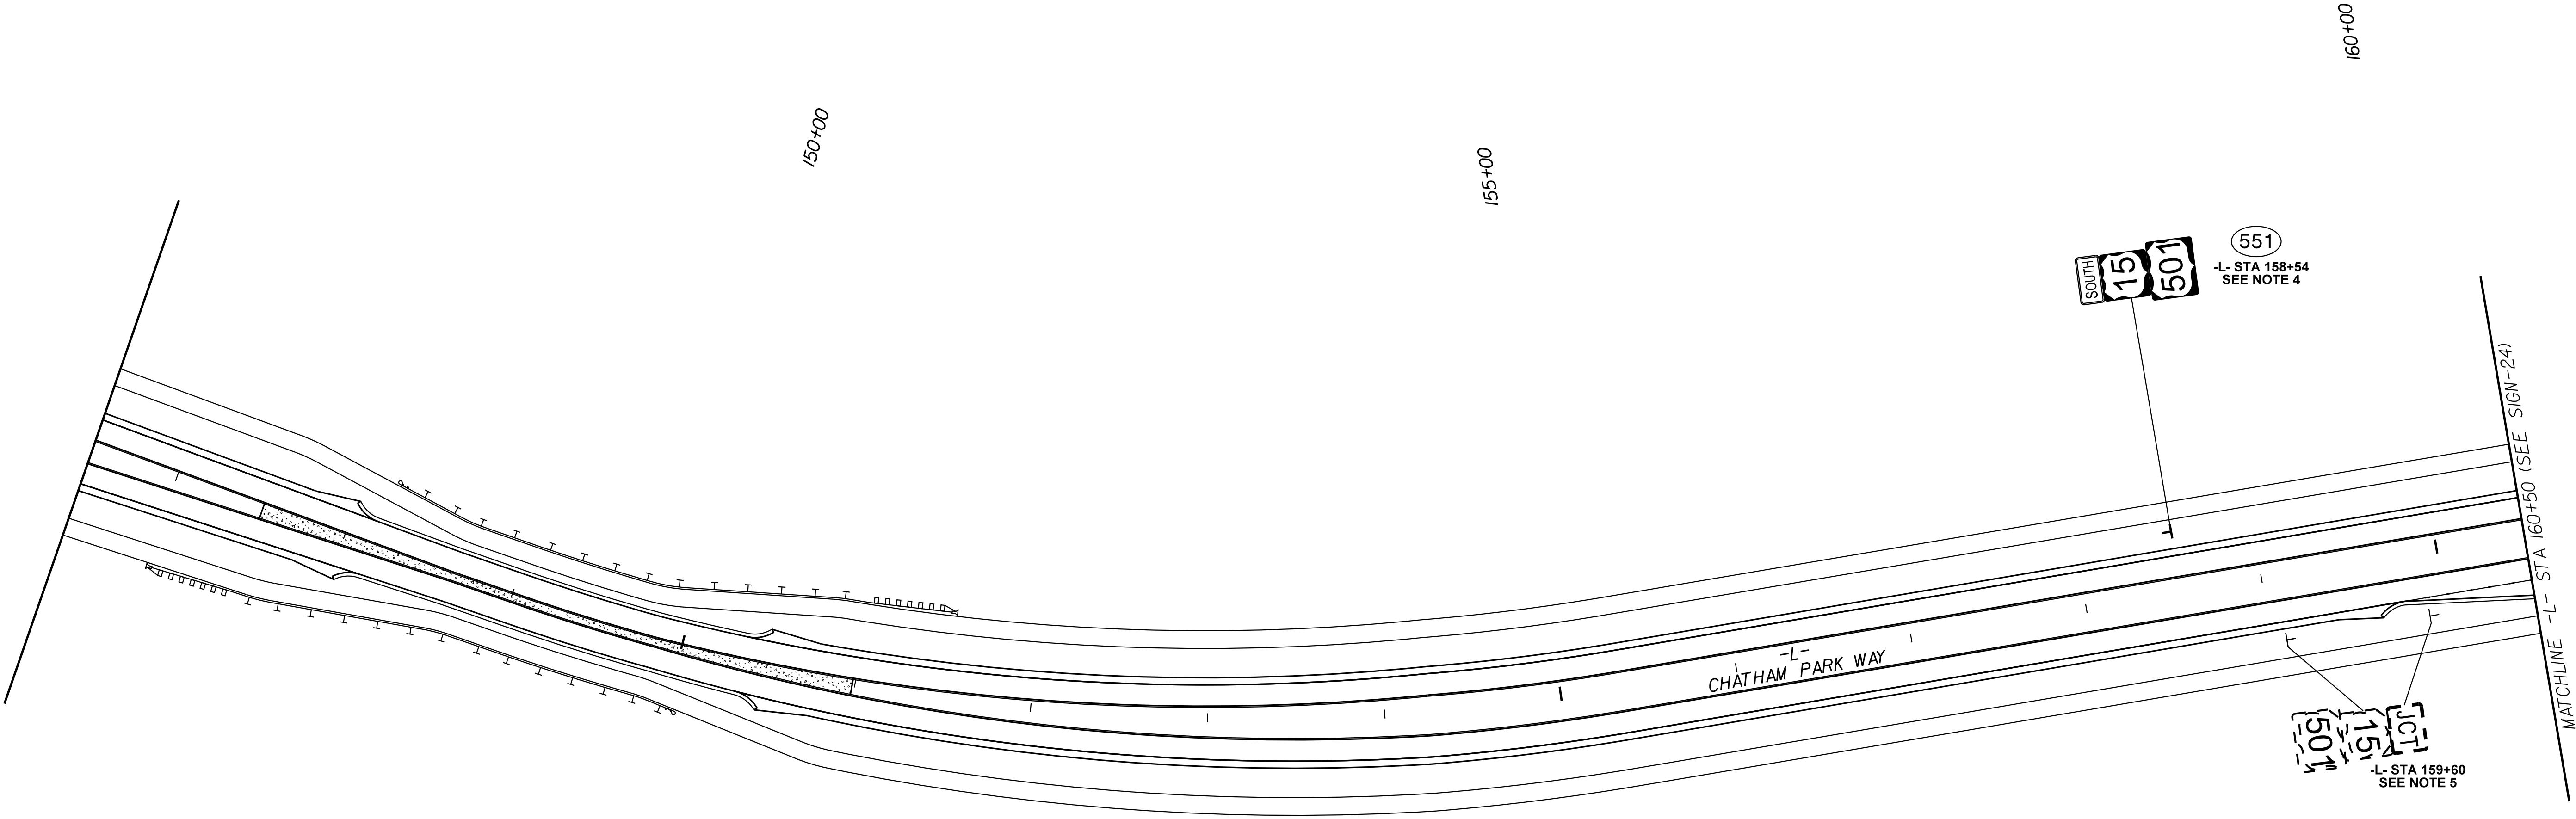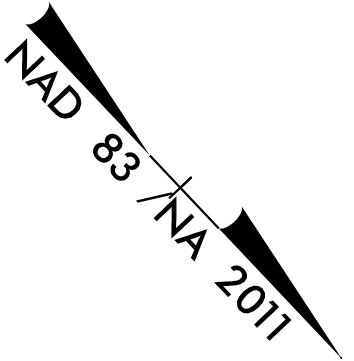

- DENOTES EXISTING SIGN
- DENOTES NEW "U" CHANNEL POST/PROPOSED SIGN LOCATION
- DENOTES EXISTING "U" CHANNEL POST/EXISTING SIGN LOCATION
- RETAIN ALL EXISTING SIGNS NOT SHOWN IN PLANS

PROJECT NOTES

- DISPOSAL OF SIGN SYSTEM, U-CHANNEL
- SIGN ERECTION, TYPE D
- SIGN ERECTION, TYPE E
- SIGN ERECTION, TYPE F
- SIGN ERECTION, RELOCATE TYPE F (GROUND MOUNTED)

SIGNING PLAN

TIP NO.
R-5963A

SHEET NO.
SIGN-24

SEAL

Professional Engineer
CALEB D. LOWMAN
048986
3/20/2025

DOCUMENT NOT CONSIDERED FINAL
UNLESS ALL SIGNATURES COMPLETED

Kimley » Horn

421 FAYETTEVILLE STREET, SUITE 600
RALEIGH, N.C. 27601. NC LICENSE #F-0102

Seal

Professional Engineer
CALEB D. LOWMAN
048986
3/20/2025

The main diagram illustrates the signing plan for a road project. It shows a horizontal road with stationing from 25+00 to 35+00. Key features include:

- SR 1520 RUSSELL CHAPEL CHURCH ROAD** intersecting from the top left.
- CHATHAM PARK WAY** intersecting from the bottom left.
- US 15-501** running horizontally.
- Signs:** Various signs are shown, including speed limit 45, directional signs for Sanford, and junction signs for SR 1520 and Chatham Park Way. Some signs are marked 'RETAIN' and others 'NEW'.
- Notes:** Several notes are present, such as '107 -Y11- STA 29+20 SEE NOTE 6', '555 -Y11- STA 31+20 SEE NOTE 4', '554 -Y11- STA 33+20 SEE NOTE 4', '552 -L- STA 161+90 SEE NOTE 4', '313 -L- STA 160+90 SEE NOTE 2', '553 -Y11- STA 23+25 SEE NOTE 4', and '556 -Y11- STA 39+50 SEE NOTE 4'.
- Matchlines:** Indicated at both ends of the plan.

--- DENOTES EXISTING SIGN
T DENOTES NEW "U" CHANNEL POST/PROPOSED SIGN LOCATION
T DENOTES EXISTING "U" CHANNEL POST/EXISTING SIGN LOCATION
RETAIN ALL EXISTING SIGNS NOT SHOWN IN PLANS

PROJECT NOTES

- DISPOSAL OF SIGN SYSTEM, U-CHANNEL
- SIGN ERECTION, TYPE D
- SIGN ERECTION, TYPE E
- SIGN ERECTION, TYPE F
- SIGN ERECTION, RELOCATE TYPE F (GROUND MOUNTED)
- SIGN ERECTION, TYPE A (GROUND MOUNTED)


Inset A provides a detailed view of a road intersection. It shows a 'WRONG WAY' sign, a 'DO NOT ENTER' sign, and a 'STOP' sign. The inset also includes stationing and a matchline reference to the main plan.

SIGNING PLAN


Kimley »Horn

421 FAYETTEVILLE STREET, SUITE 600
RALEIGH, N.C. 27601. NC LICENSE #F-0102

TIP NO. SHEET NO.
R-5963A SIGN-25

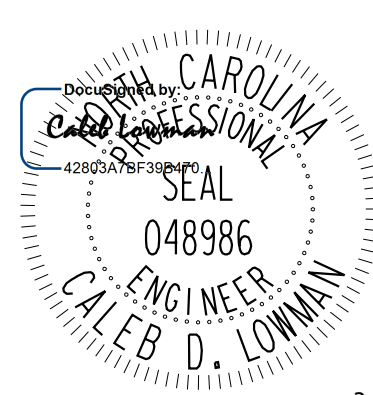

DOCUMENT NOT CONSIDERED FINAL
UNLESS ALL SIGNATURES COMPLETED

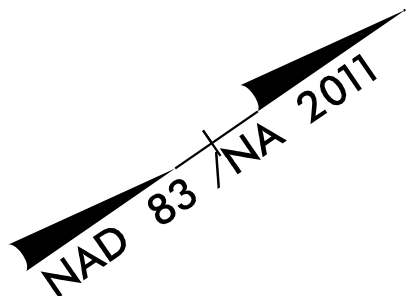

K:\RAL_Roadway\0\036734 - R-5963A&B\Signing and Delineation\Design\Sheets\R-5963A&B_rdy_sgn_25.dgn


1/15/2025

- DENOTES EXISTING SIGN
- DENOTES NEW "U" CHANNEL POST/PROPOSED SIGN LOCATION
- DENOTES EXISTING "U" CHANNEL POST/EXISTING SIGN LOCATION
- RETAIN ALL EXISTING SIGNS NOT SHOWN IN PLANS


PROJECT NOTES

- DISPOSAL OF SIGN SYSTEM, U-CHANNEL
- SIGN ERECTION, TYPE D
- SIGN ERECTION, TYPE E
- SIGN ERECTION, TYPE F
- SIGN ERECTION, TYPE A (GROUND MOUNTED)

SIGNING PLAN

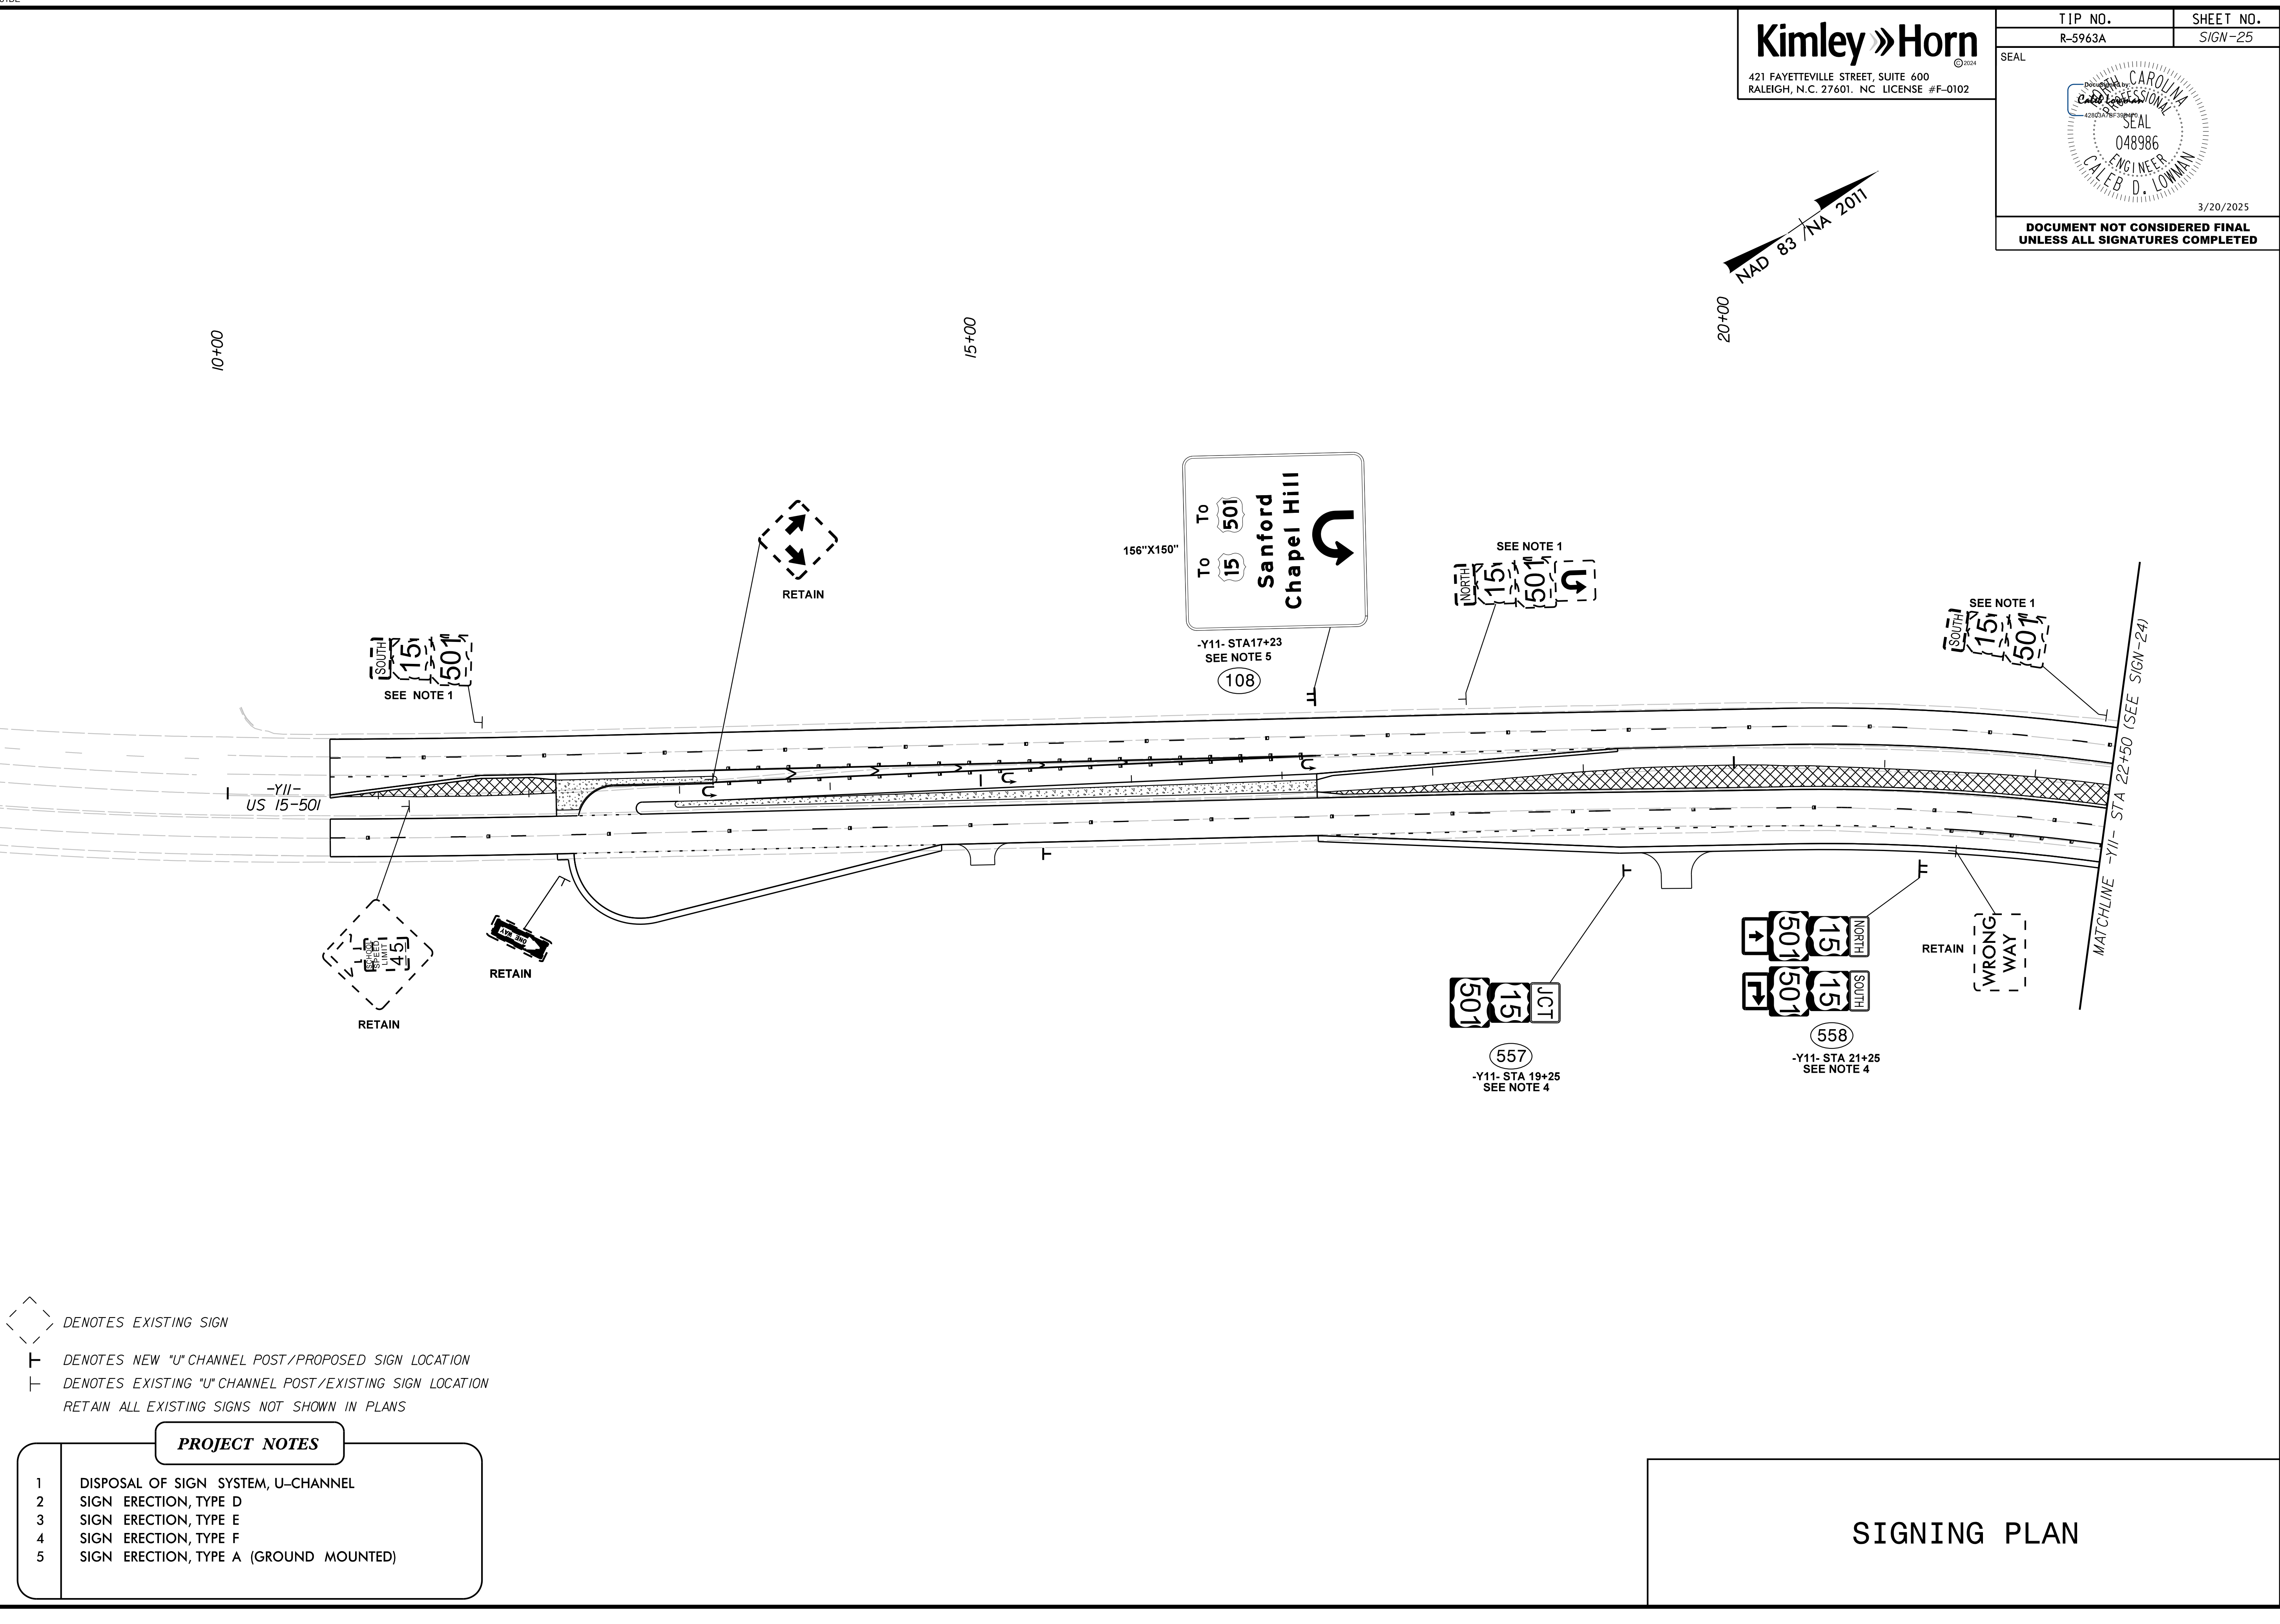


SEAL

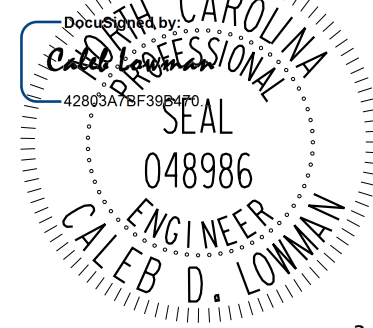

3/20/2025

DOCUMENT NOT CONSIDERED FINAL
UNLESS ALL SIGNATURES COMPLETED

SECTION A

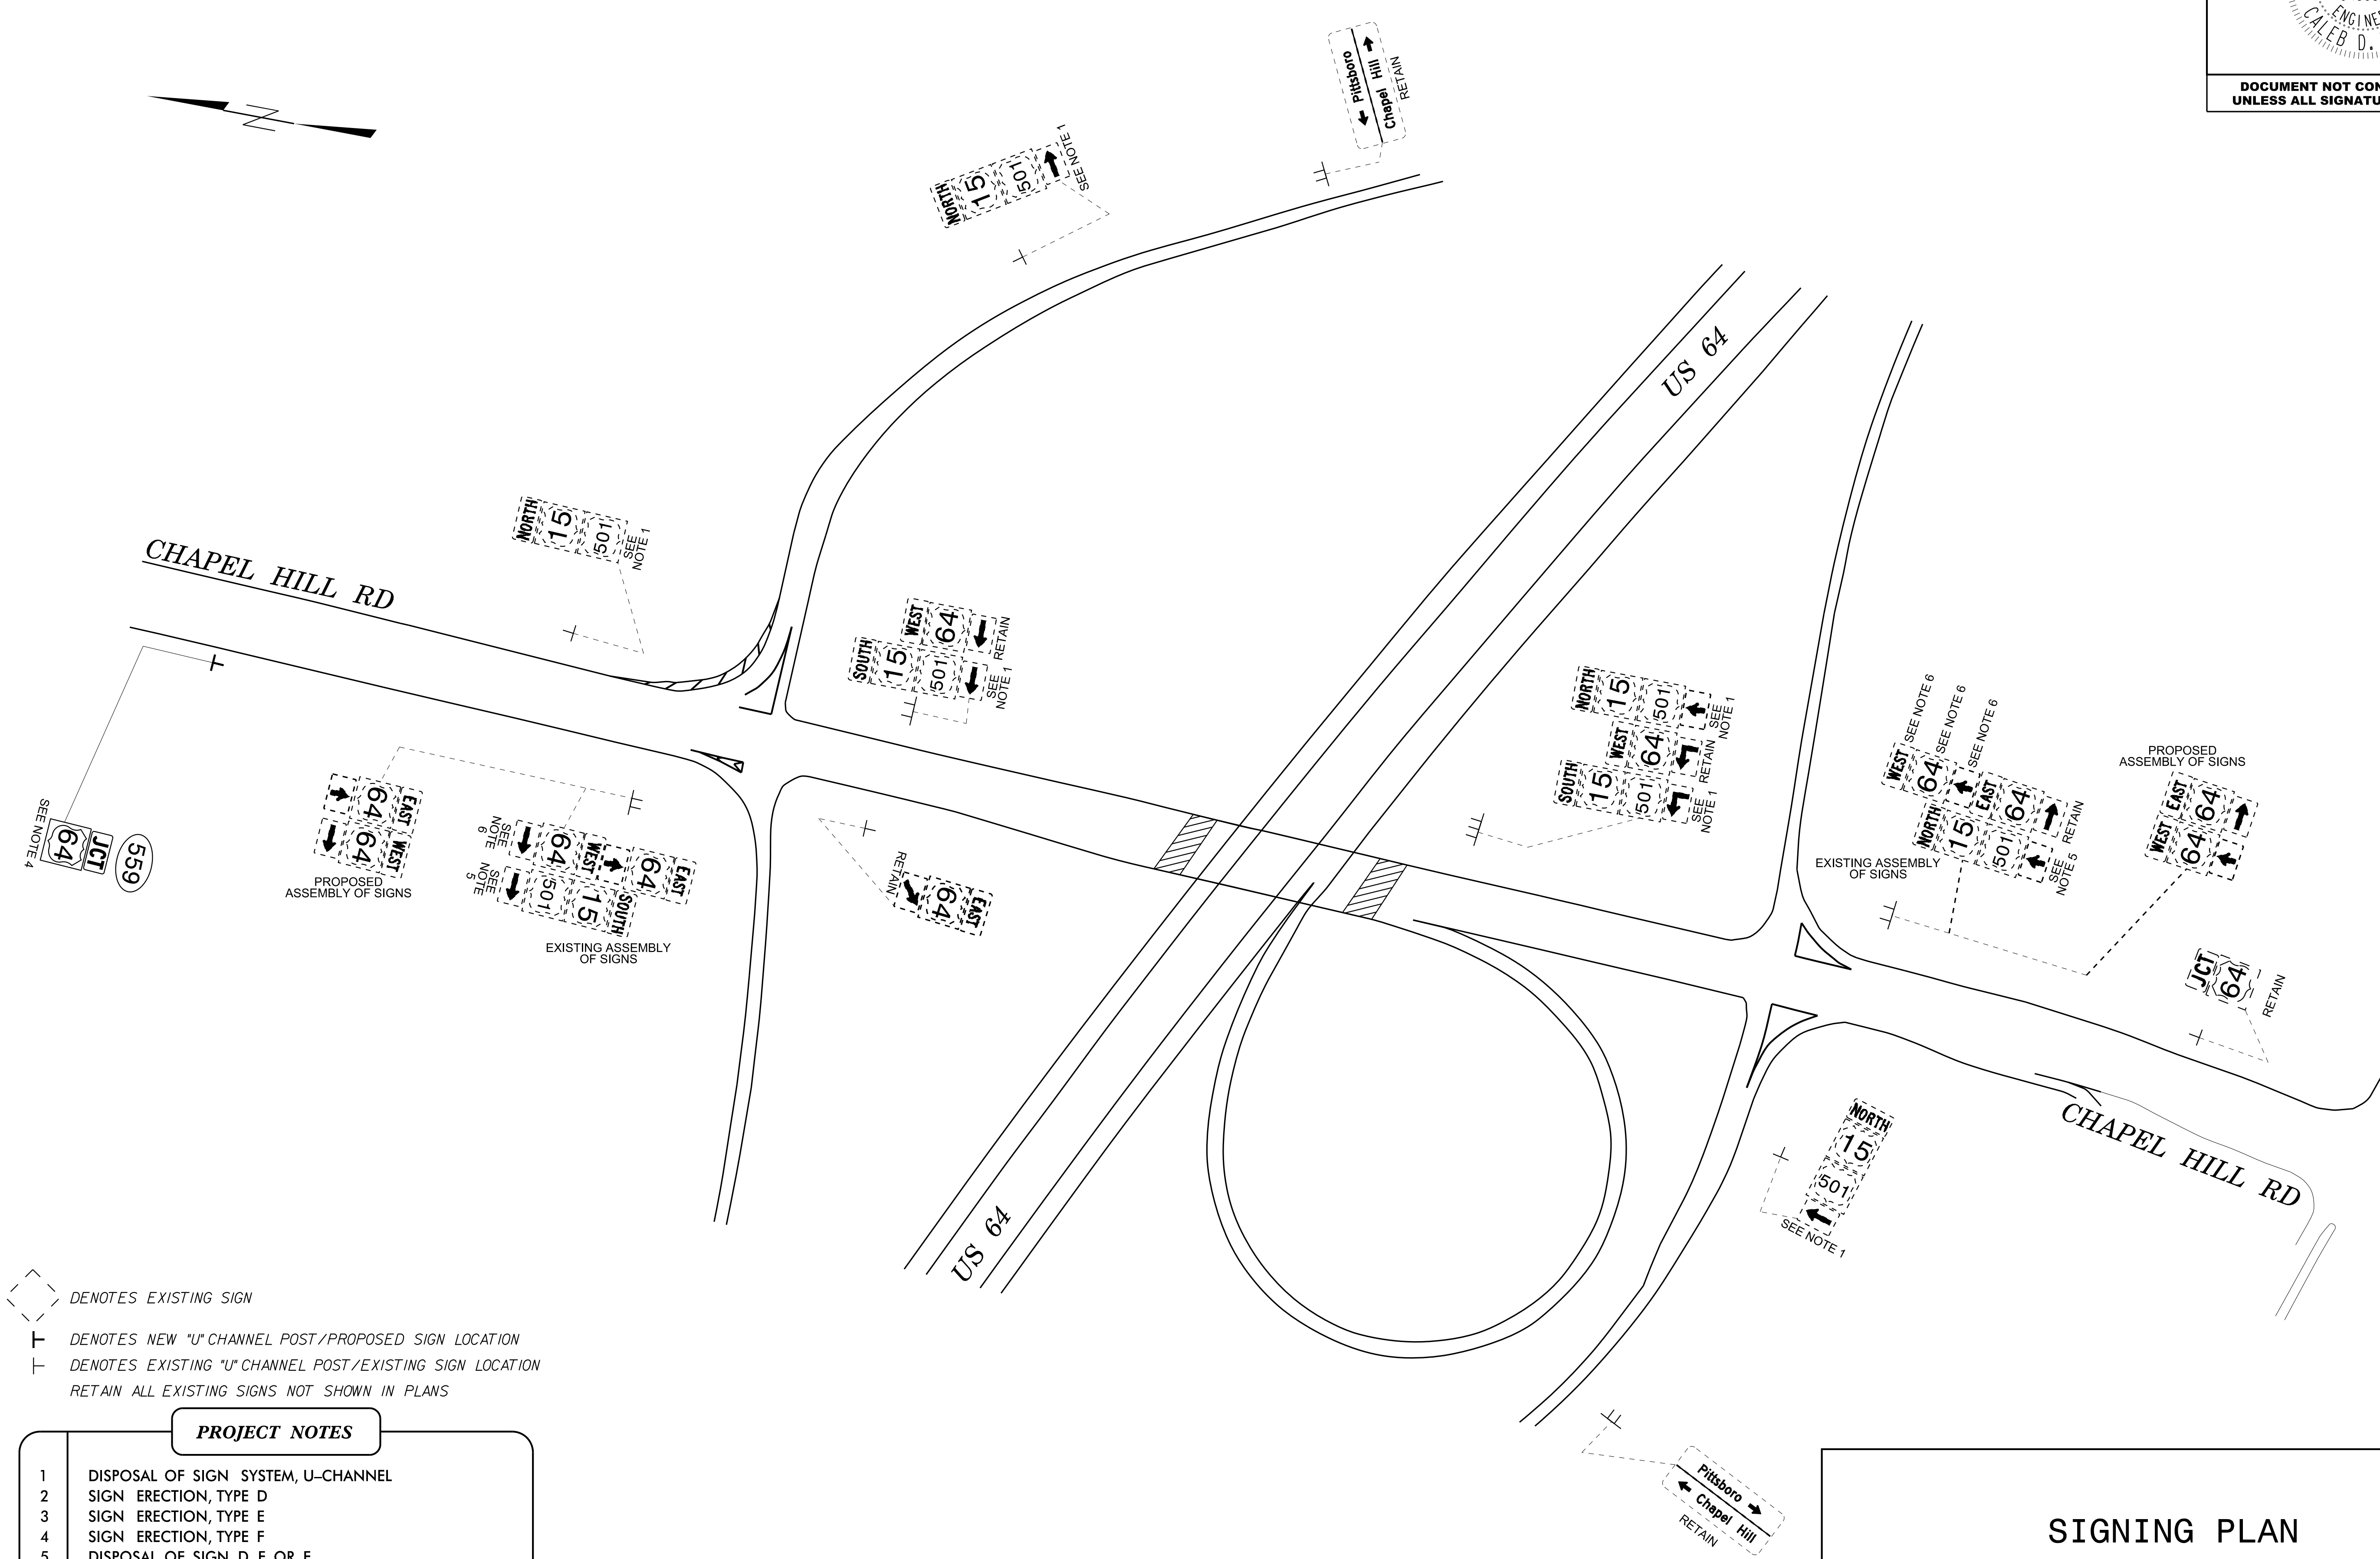

SIGNING PLAN

K:\RAL_Roadway\01036734 - R-5963A&B\Signing and Delineation\Design\Sheets\R-5963A&B_rdy_sgn_Section Adgn

1/15/2025

Kimley»Horn

421 FAYETTEVILLE STREET, SUITE 600
RALEIGH, N.C. 27601. NC LICENSE #F-0102


TIP NO.

R-5963A

SHEET NO.

SIGN-27


SEAL

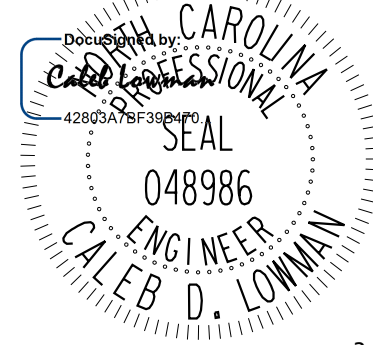

3/20/2025

DOCUMENT NOT CONSIDERED FINAL
UNLESS ALL SIGNATURES COMPLETED

SECTION B

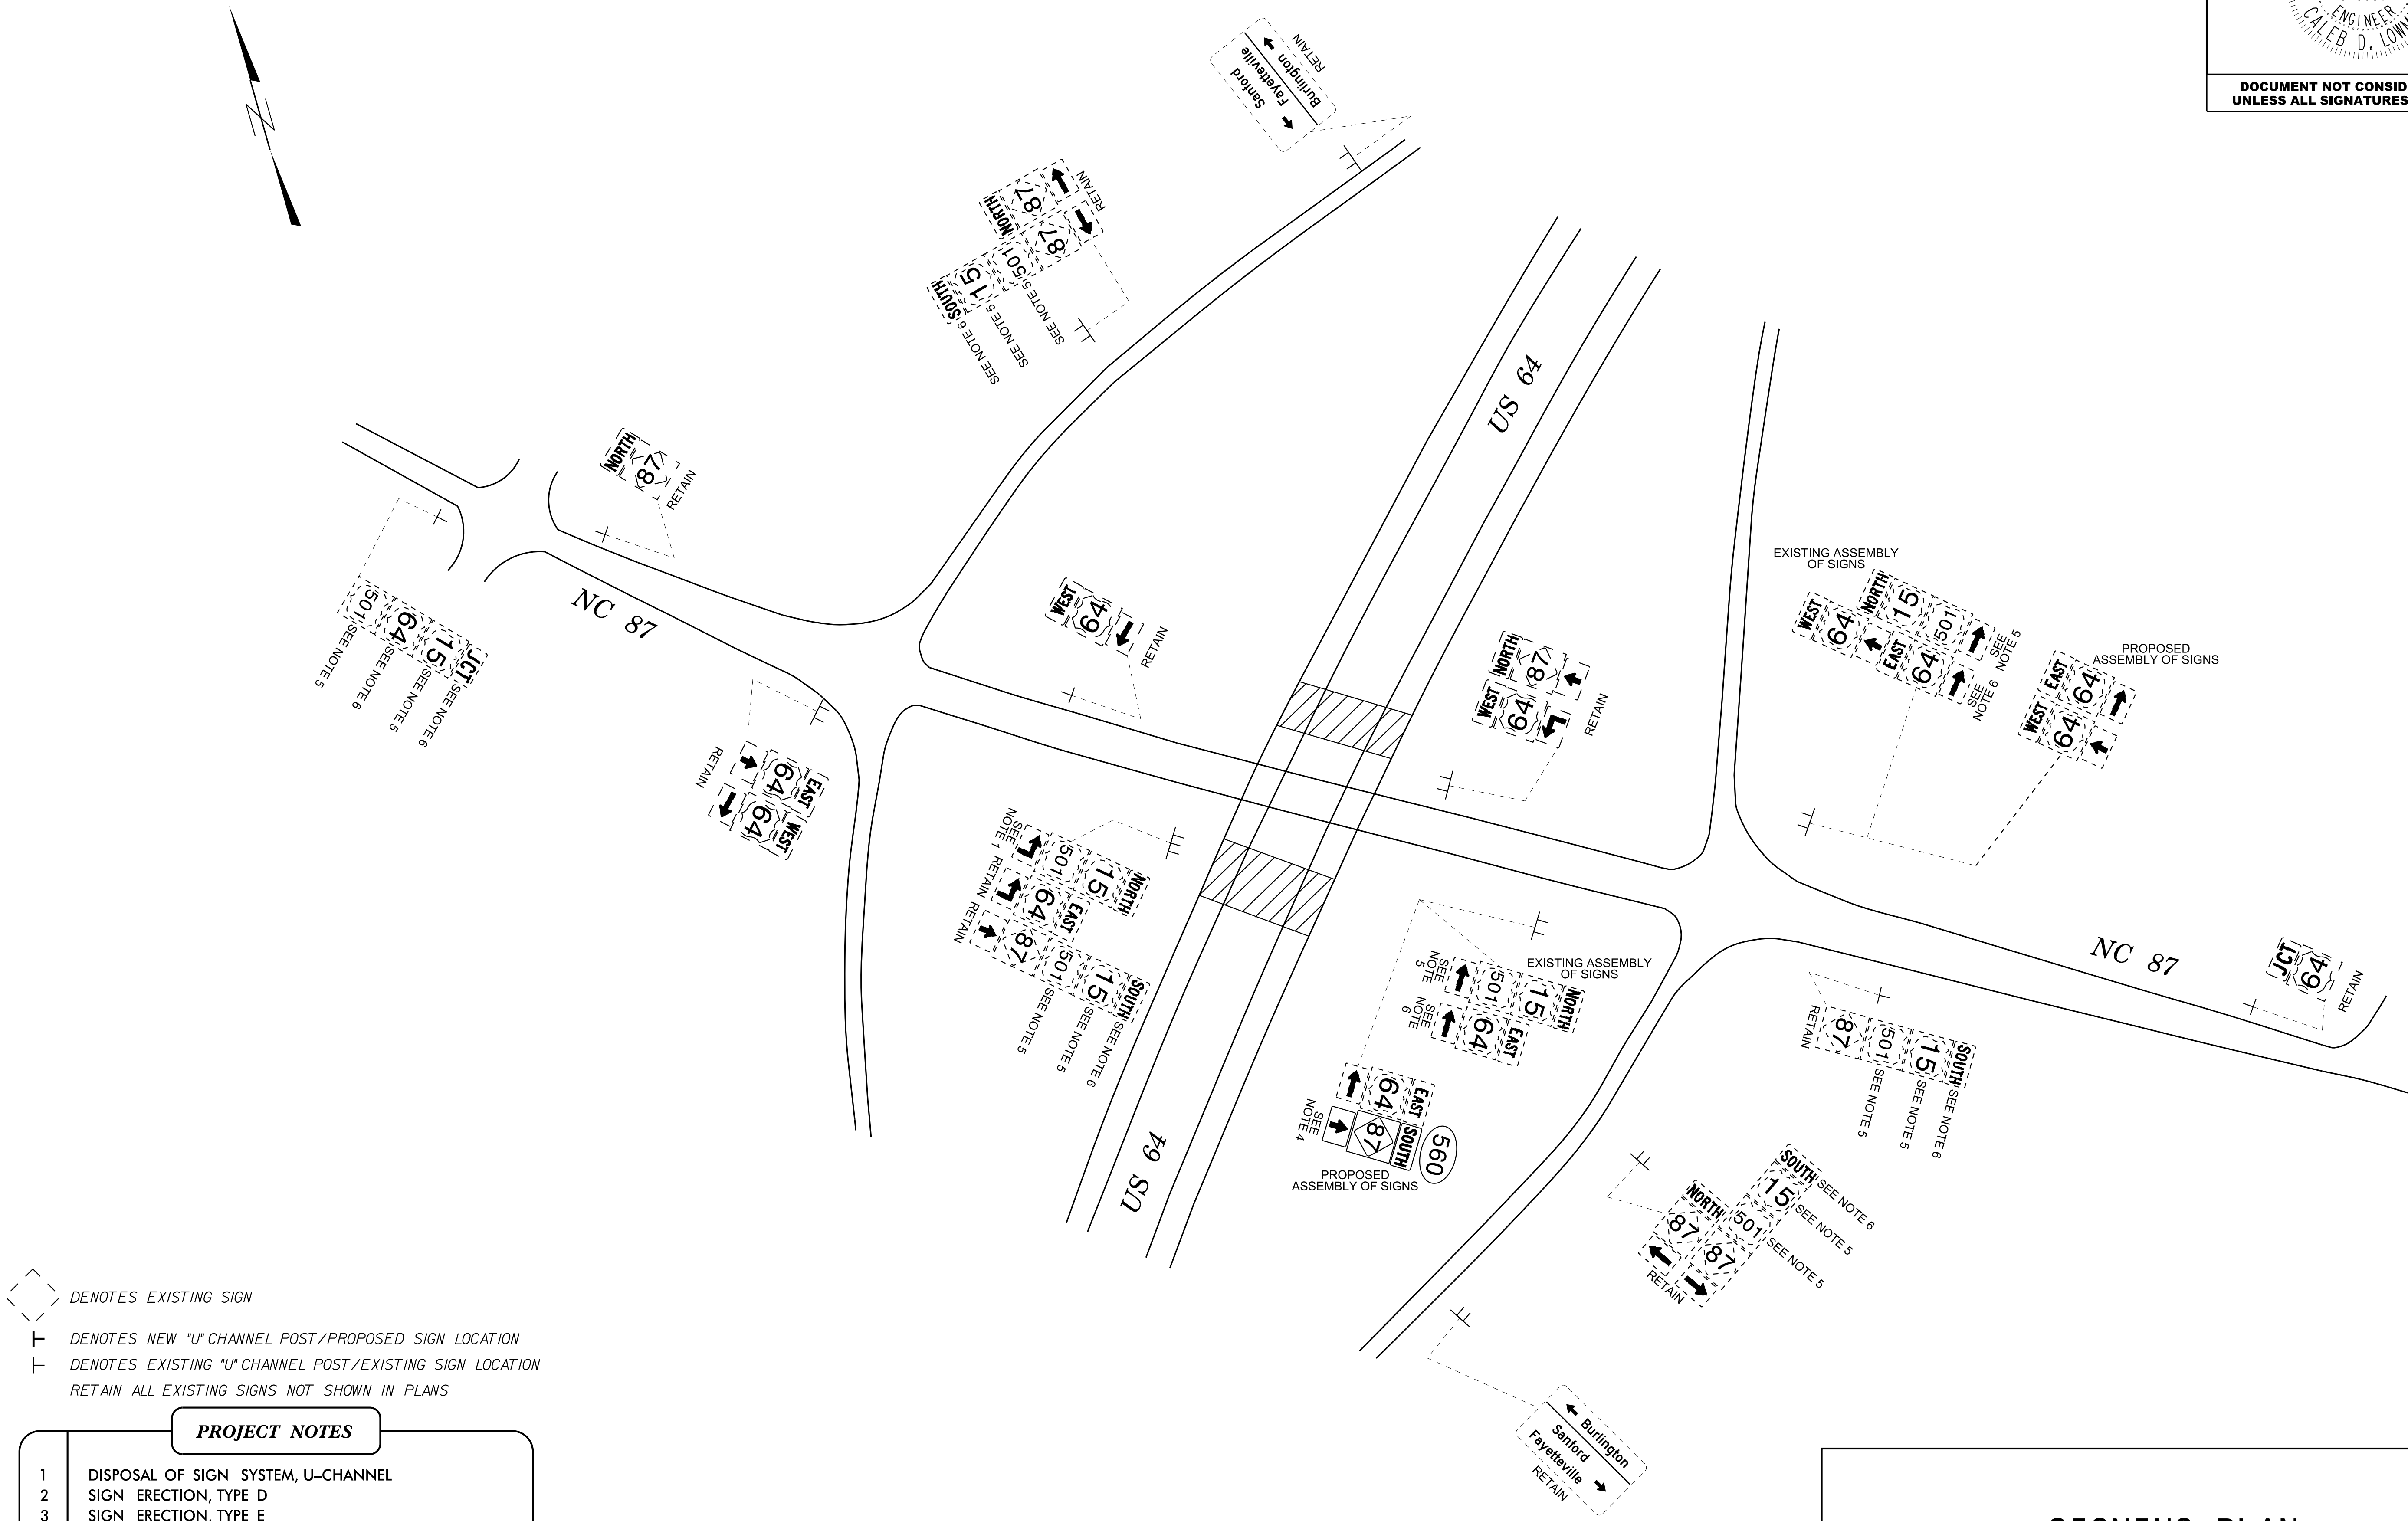


- DENOTES EXISTING SIGN
- DENOTES NEW "U" CHANNEL POST/PROPOSED SIGN LOCATION
- DENOTES EXISTING "U" CHANNEL POST/EXISTING SIGN LOCATION
- RETAIN ALL EXISTING SIGNS NOT SHOWN IN PLANS

PROJECT NOTES

- 1 DISPOSAL OF SIGN SYSTEM, U-CHANNEL
- 2 SIGN ERECTION, TYPE D
- 3 SIGN ERECTION, TYPE E
- 4 SIGN ERECTION, TYPE F
- 5 DISPOSAL OF SIGN, D, E OR F
- 6 SIGN ERECTION, RELOCATE TYPE F


SIGNING PLAN

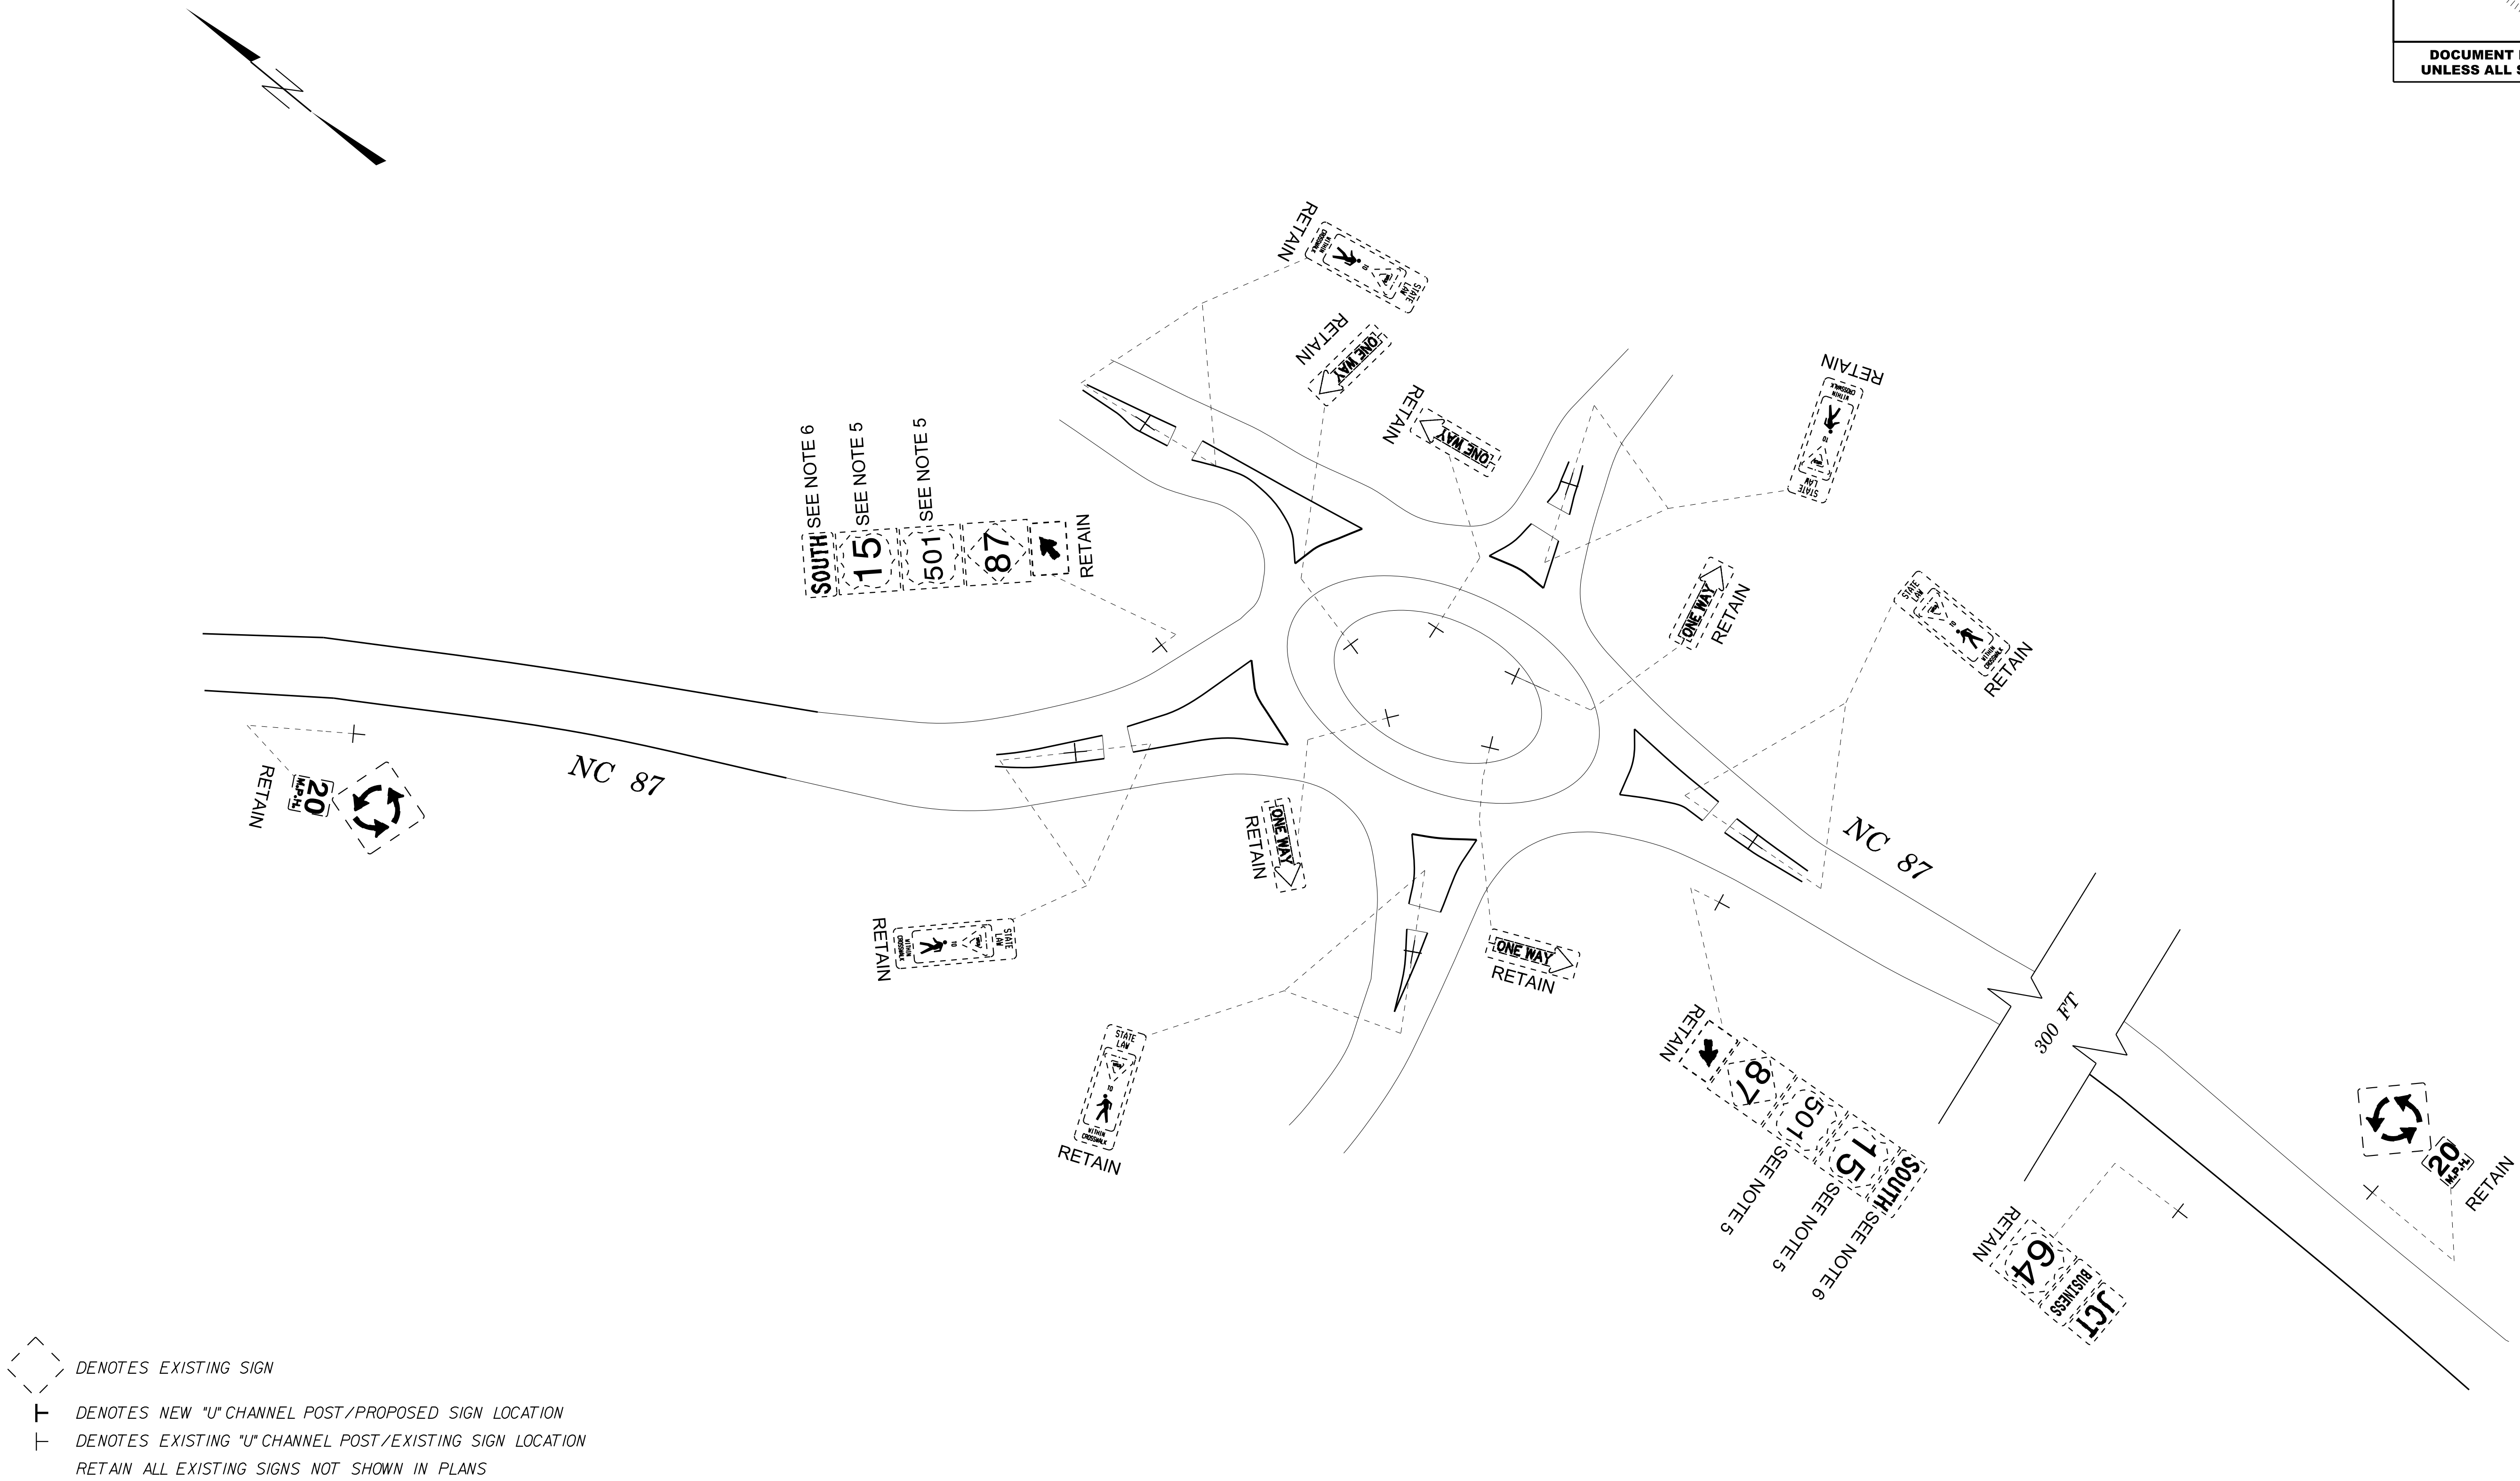

- | PROJECT NOTES | |
|---------------|------------------------------------|
| 1 | DISPOSAL OF SIGN SYSTEM, U-CHANNEL |
| 2 | SIGN ERECTION, TYPE D |
| 3 | SIGN ERECTION, TYPE E |
| 4 | SIGN ERECTION, TYPE F |
| 5 | DISPOSAL OF SIGN, D, E OR F |
| 6 | SIGN ERECTION, RELOCATE TYPE F |


SIGNING PLAN

SIGNING PLAN

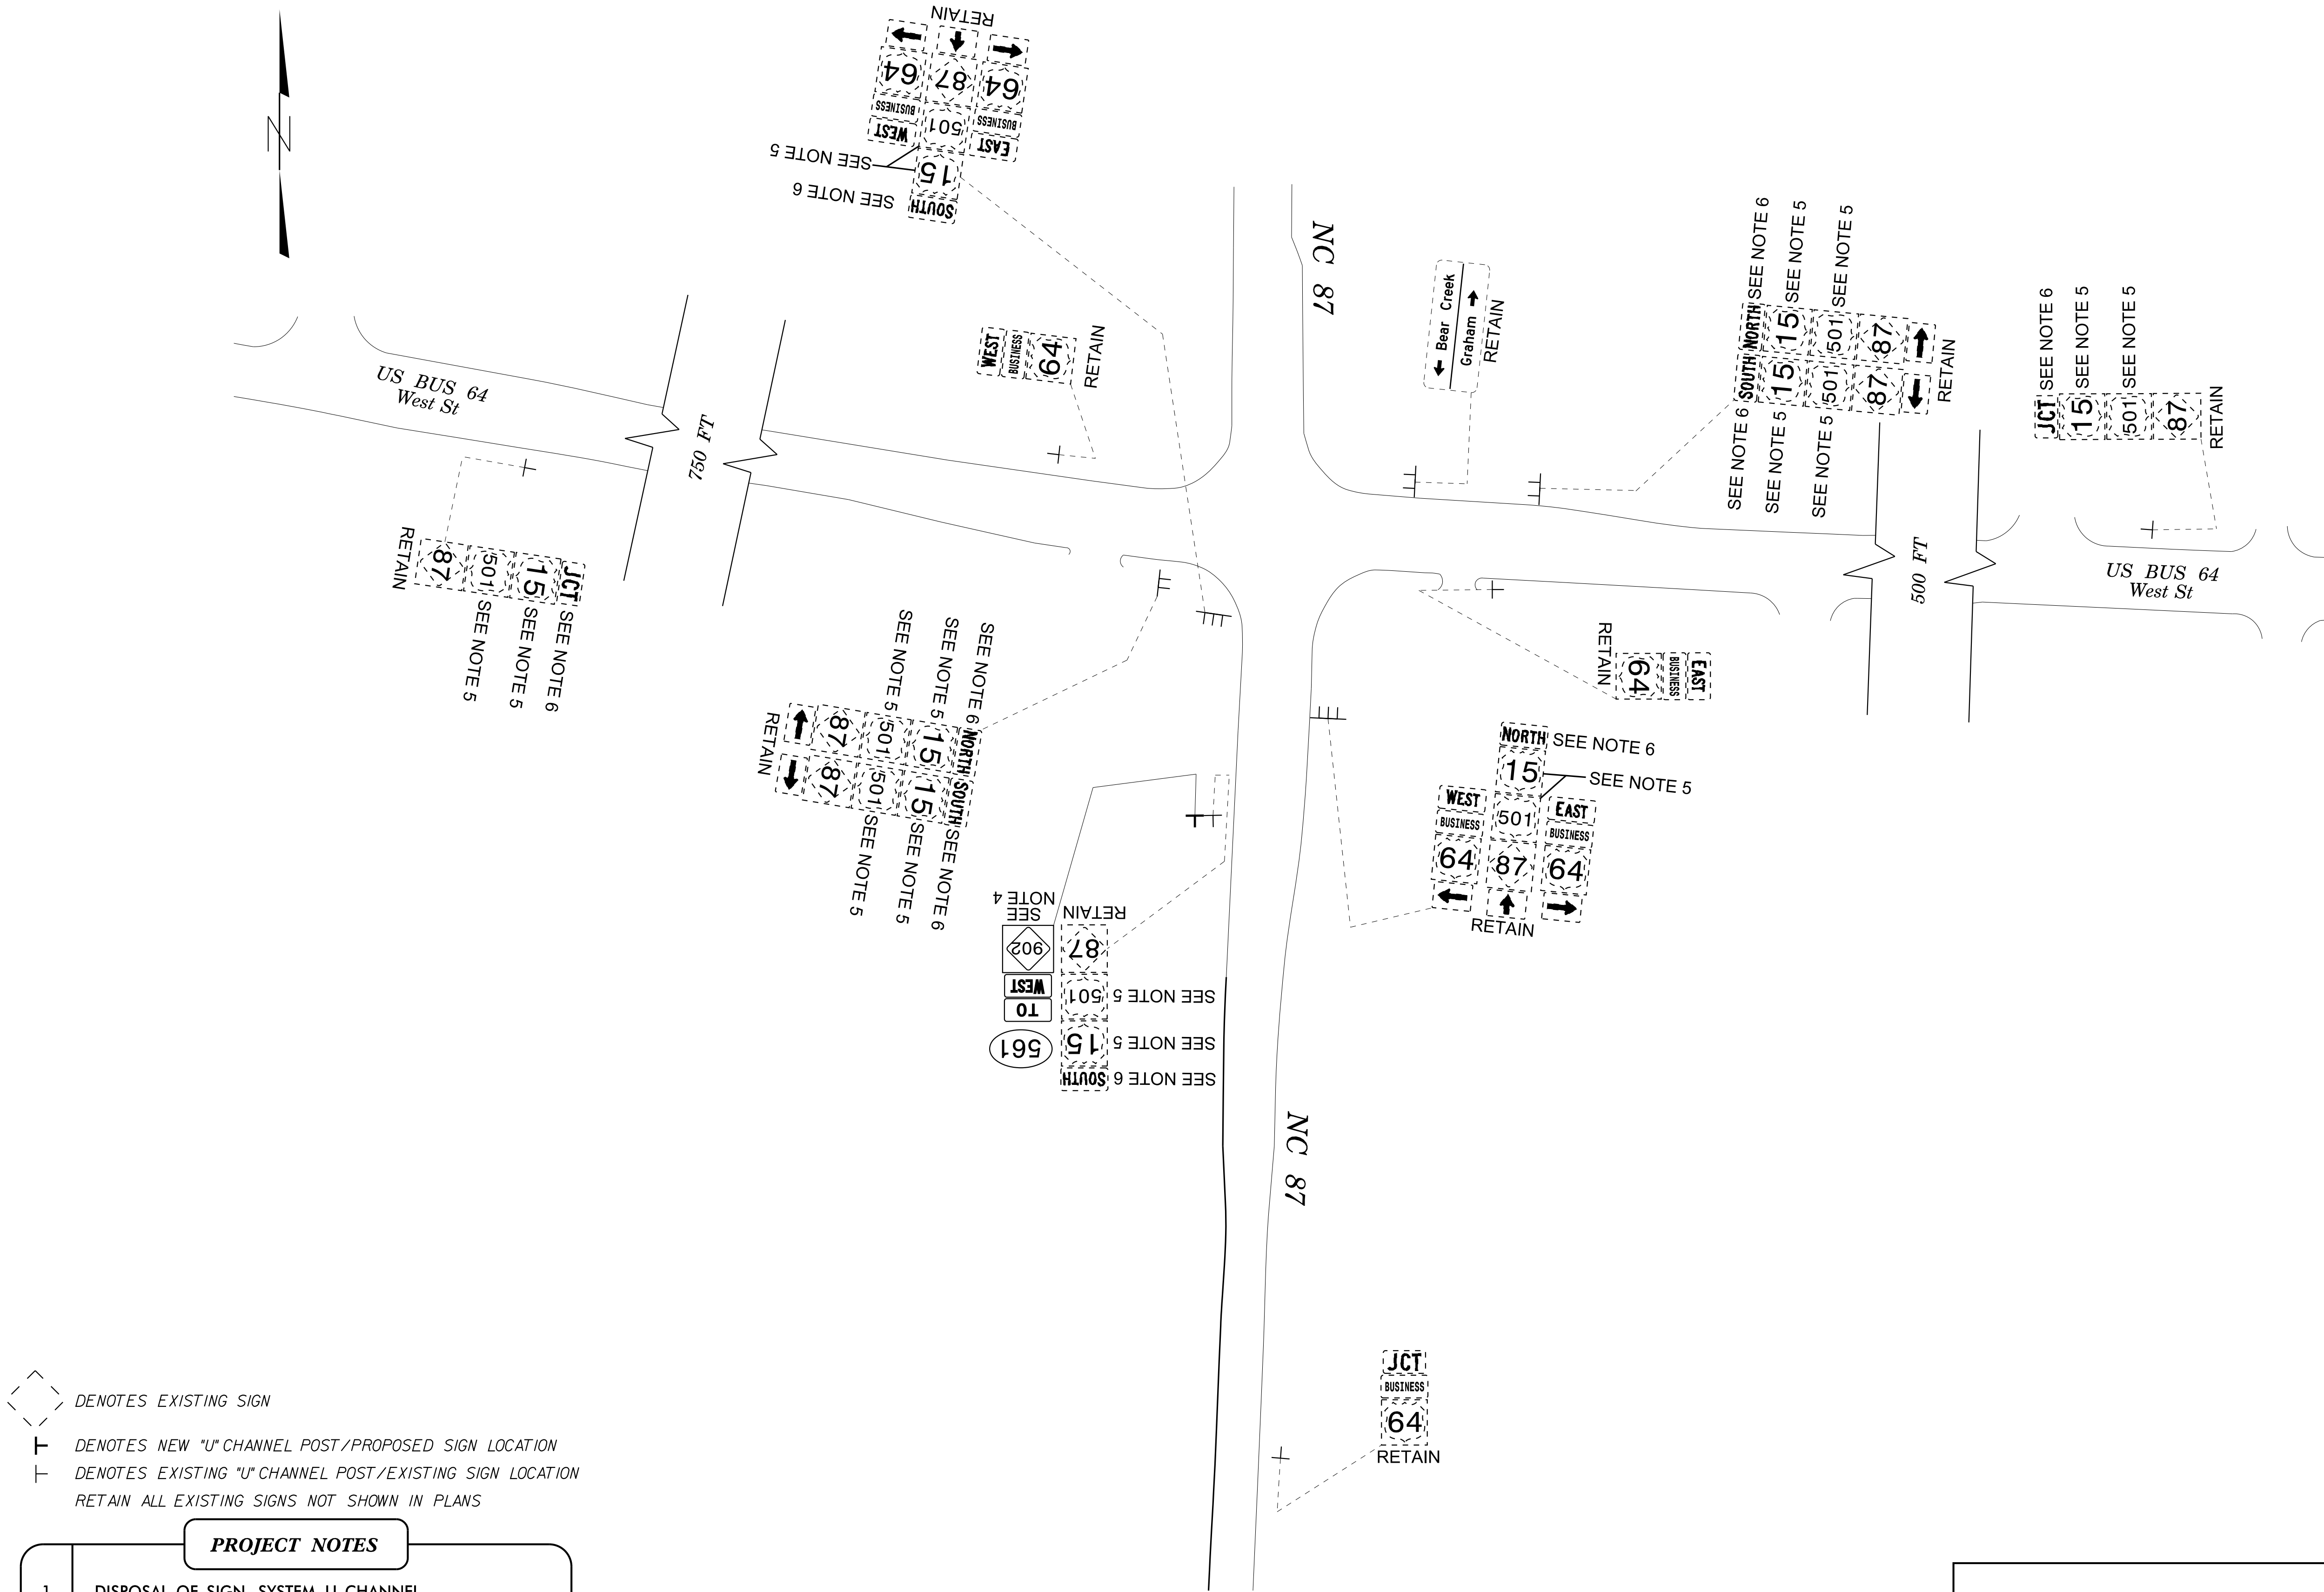

- | | |
|---|------------------------------------|
| 1 | DISPOSAL OF SIGN SYSTEM, U-CHANNEL |
| 2 | SIGN ERECTION, TYPE D |
| 3 | SIGN ERECTION, TYPE E |
| 4 | SIGN ERECTION, TYPE F |
| 5 | DISPOSAL OF SIGN, D, E OR F |
| 6 | SIGN ERECTION, RELOCATE TYPE F |


SEAL

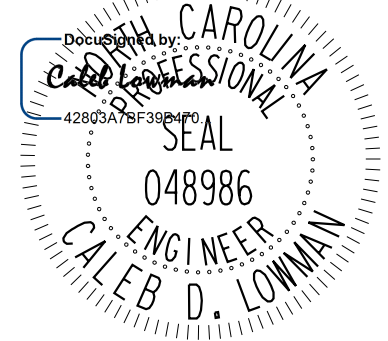

3/20/2025

DOCUMENT NOT CONSIDERED FINAL
UNLESS ALL SIGNATURES COMPLETED

SECTION E

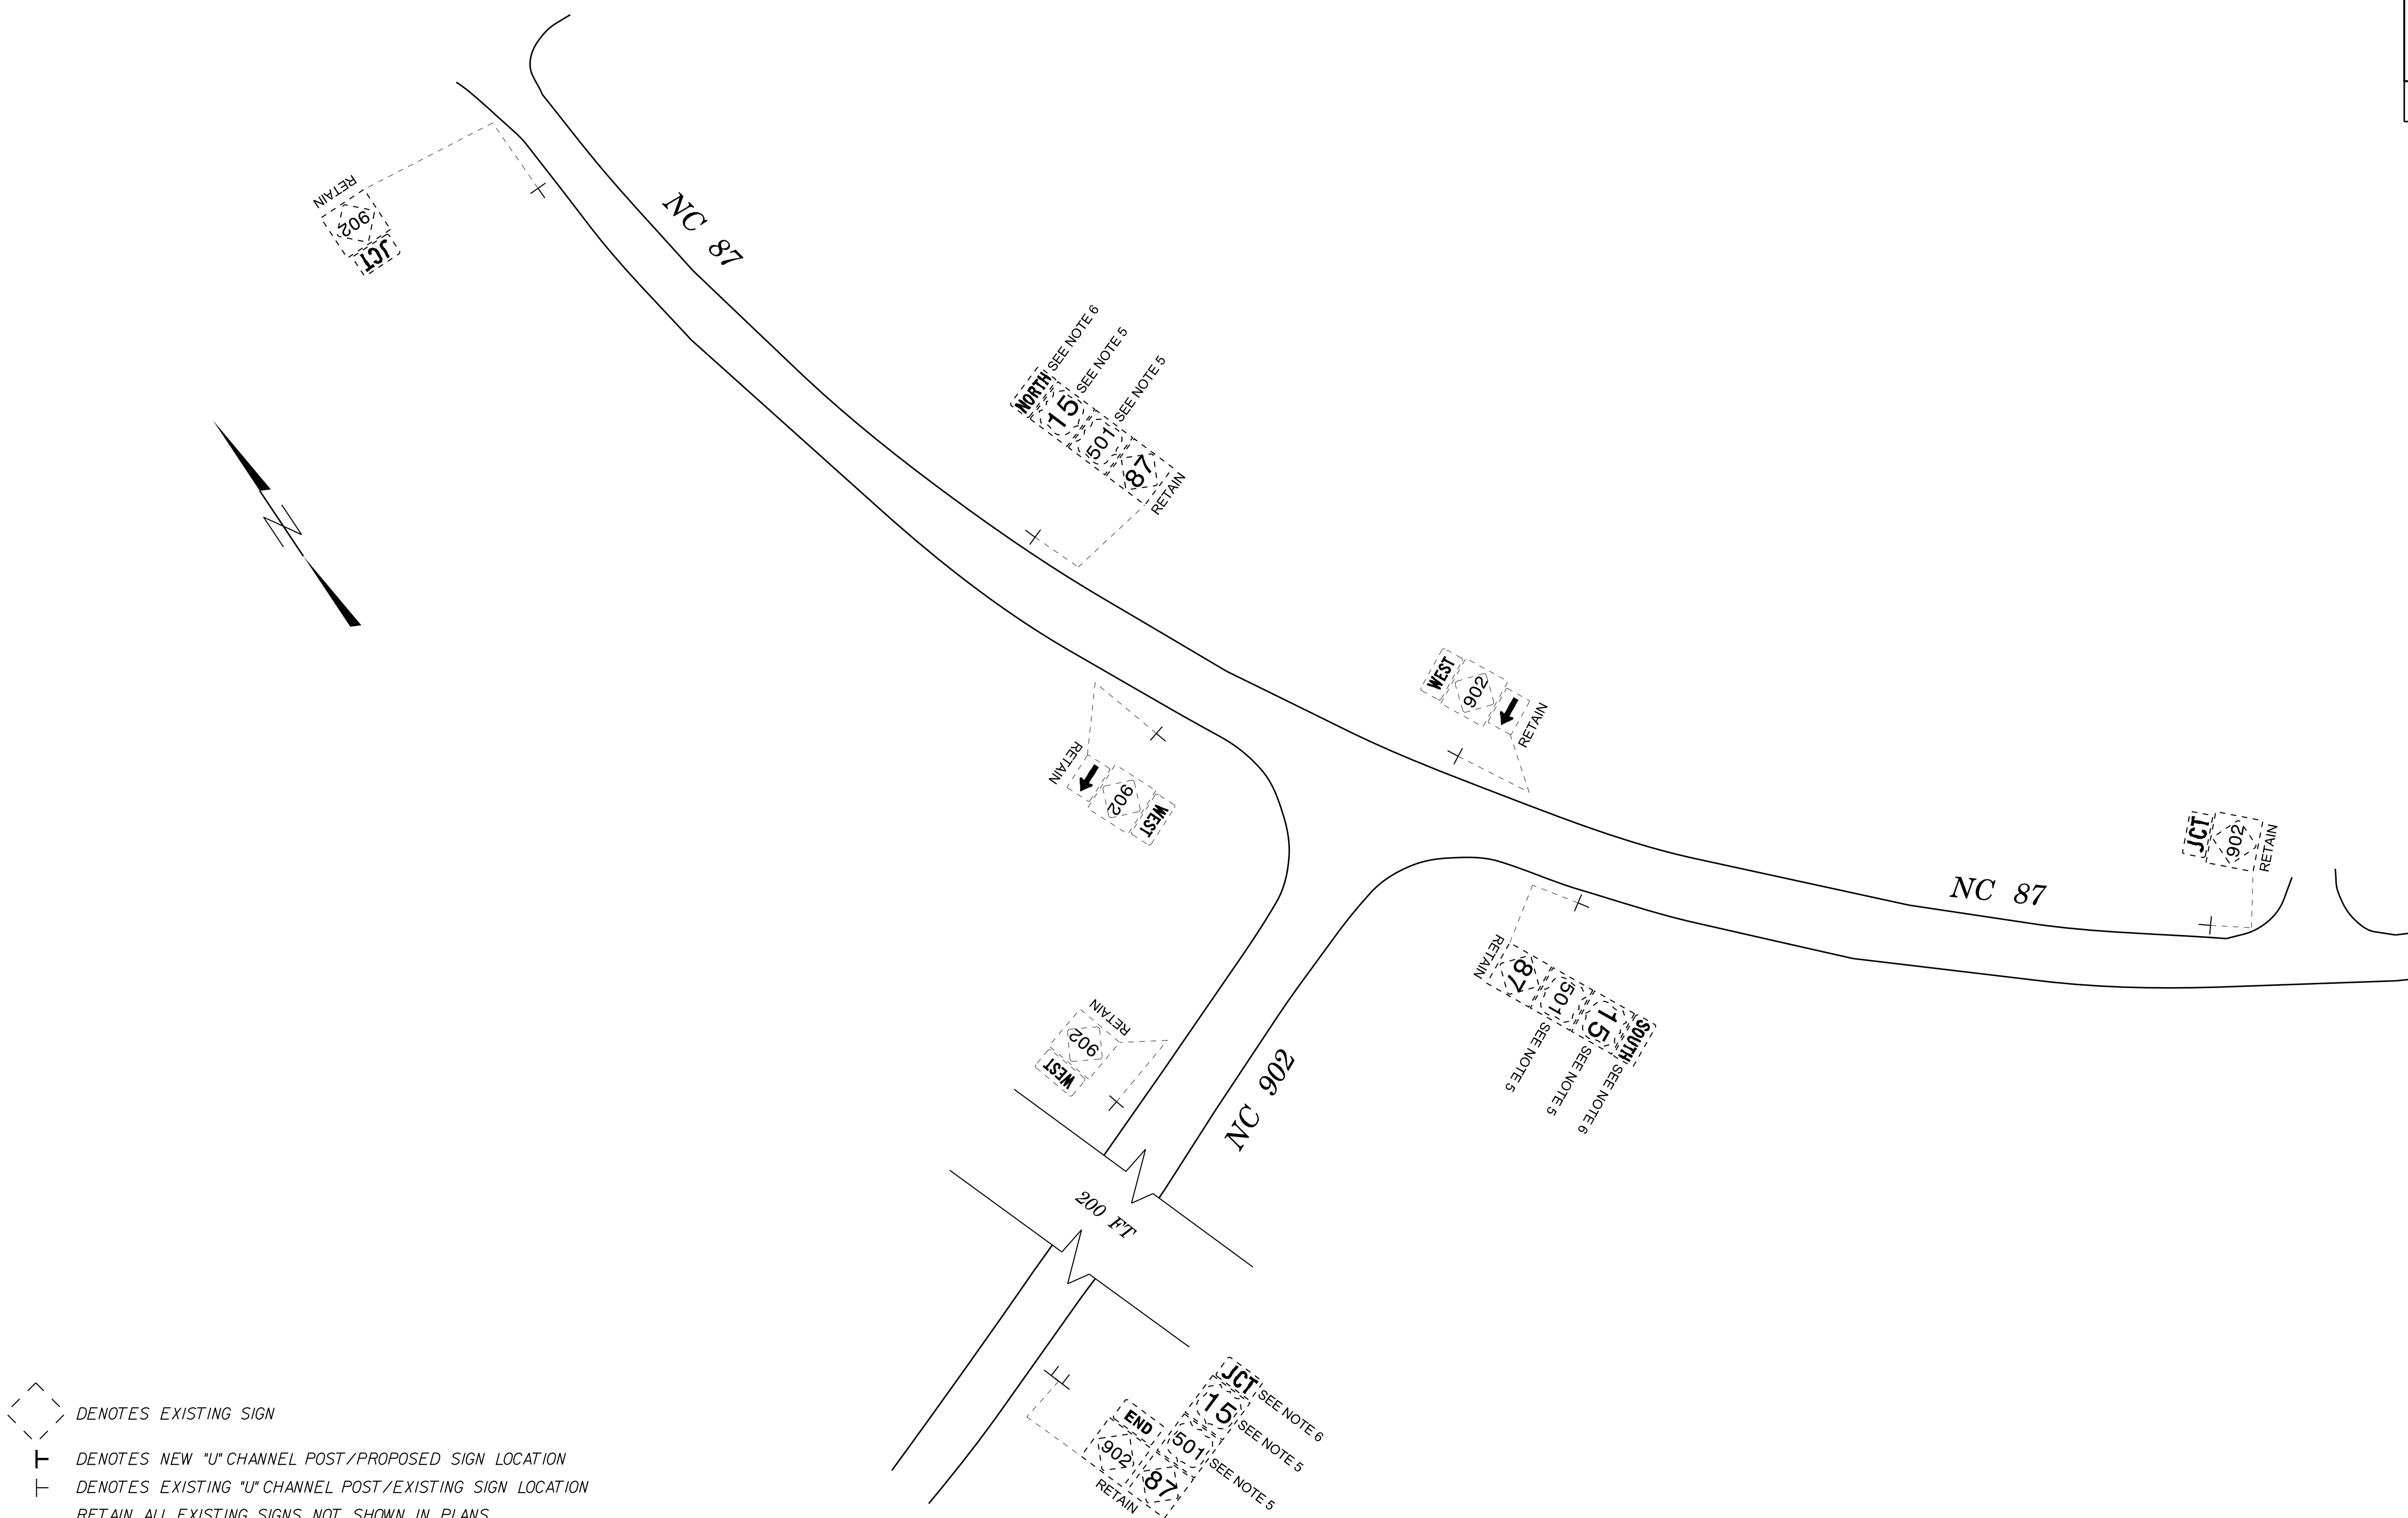

- DENOTES EXISTING SIGN
- DENOTES NEW "U" CHANNEL POST/PROPOSED SIGN LOCATION
- DENOTES EXISTING "U" CHANNEL POST/EXISTING SIGN LOCATION
- RETAIN ALL EXISTING SIGNS NOT SHOWN IN PLANS

PROJECT NOTES

- 1 DISPOSAL OF SIGN SYSTEM, U-CHANNEL
- 2 SIGN ERECTION, TYPE D
- 3 SIGN ERECTION, TYPE E
- 4 SIGN ERECTION, TYPE F
- 5 DISPOSE OF SIGN, D, E OR F
- 6 SIGN ERECTION, RELOCATE TYPE F

SIGNING PLAN

K:\RAL_Roadway\01036734 - R-5963A&B\Signing and Delineation\Design\Sheets\R-5963A&B_rdy_sgn_Section E.dgn

1/15/2025

K:\RAL_Roadway\0\036734 - R-5963A&B\Signing and Delineation\Design\Sheets\R-5963A&B_rdy_sgn_Section F.dgn

1/15/2025

DENOTES EXISTING SIGN

DENOTES NEW "U" CHANNEL POST/PROPOSED SIGN LOCATION

DENOTES EXISTING "U" CHANNEL POST/EXISTING SIGN LOCATION

RETAIN ALL EXISTING SIGNS NOT SHOWN IN PLANS

PROJECT NOTES

1

DISPOSAL OF SIGN SYSTEM, U-CHANNEL

2

SIGN ERECTION, TYPE D

3

SIGN ERECTION, TYPE E

4


SIGN ERECTION, TYPE F

5

DISPOSE OF SIGN, D, E OR F

6

SIGN ERECTION, RELOCATE TYPE F

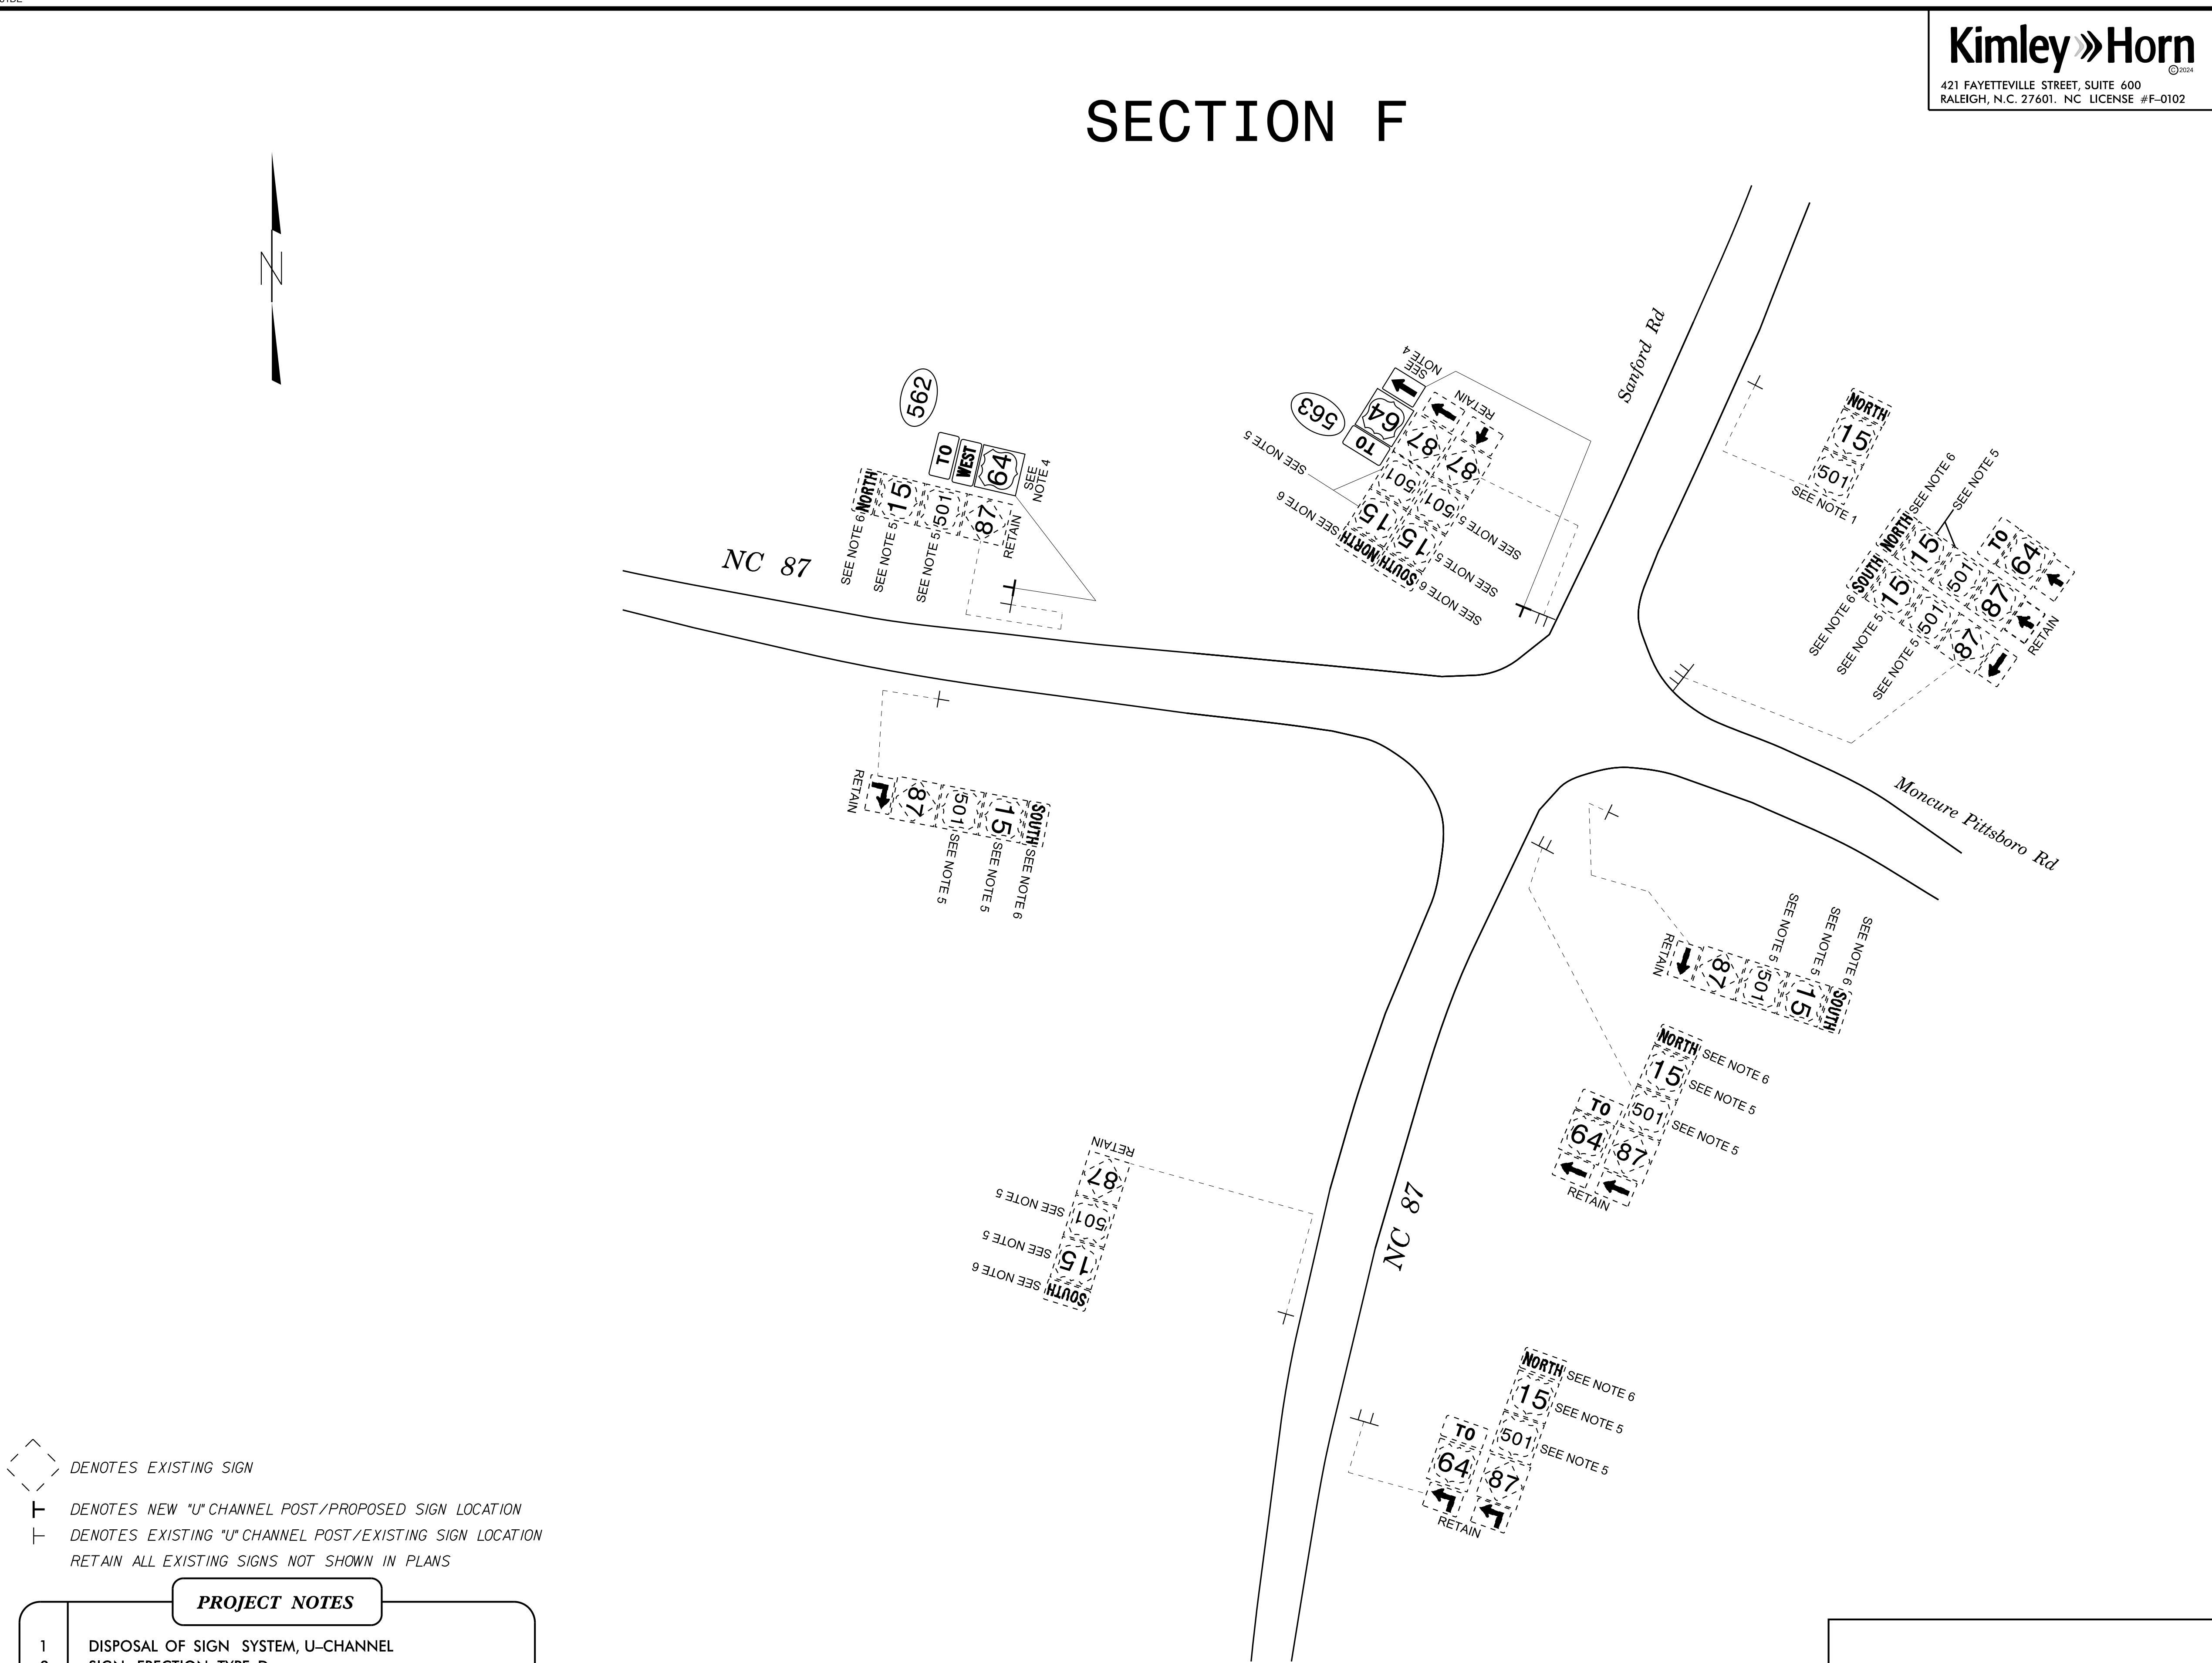

Kimley»Horn

421 FAYETTEVILLE STREET, SUITE 600
RALEIGH, N.C. 27601. NC LICENSE #F-0102

TIP NO.

R-5963A

SHEET NO.

SIGN-31

SEAL

Professional Engineer
048986
CALEB D. LOWMAN

3/20/2025

DOCUMENT NOT CONSIDERED FINAL
UNLESS ALL SIGNATURES COMPLETED

SIGNING PLAN

K:\RAL_Roadway\0\036734 - R-5963A&B\Signing and Delineation\Design\Sheets\R-5963A&B_rdy_sgn_Section G.dgn

1/15/2025

SECTION G

Kimley»Horn

421 FAYETTEVILLE STREET, SUITE 600
RALEIGH, N.C. 27601. NC LICENSE #F-0102

TIP NO.	SHEET NO.
R-5963A	SIGN-32
SEAL	
DESIGNED BY DATE CHECKED BY DATE APPROVED BY DATE PROFESSIONAL SEAL 048986 ENGINEER CALEB D. LOWMAN 3/20/2025	
DOCUMENT NOT CONSIDERED FINAL UNLESS ALL SIGNATURES COMPLETED	

- DENOTES EXISTING SIGN
- DENOTES NEW "U" CHANNEL POST/PROPOSED SIGN LOCATION
- DENOTES EXISTING "U" CHANNEL POST/EXISTING SIGN LOCATION
- RETAIN ALL EXISTING SIGNS NOT SHOWN IN PLANS

PROJECT NOTES

- 1

DISPOSAL OF SIGN SYSTEM, U-CHANNEL
- 2

SIGN ERECTION, TYPE D
- 3

SIGN ERECTION, TYPE E
- 4

SIGN ERECTION, TYPE F


SIGNING PLAN

K:\RAL_Roadway\01036734 - R-5963A&B\Signing and Delineation\Design\Sheets\R-5963A&B_rdy_sgn_Section H.dgn

1/15/2025



SECTION H

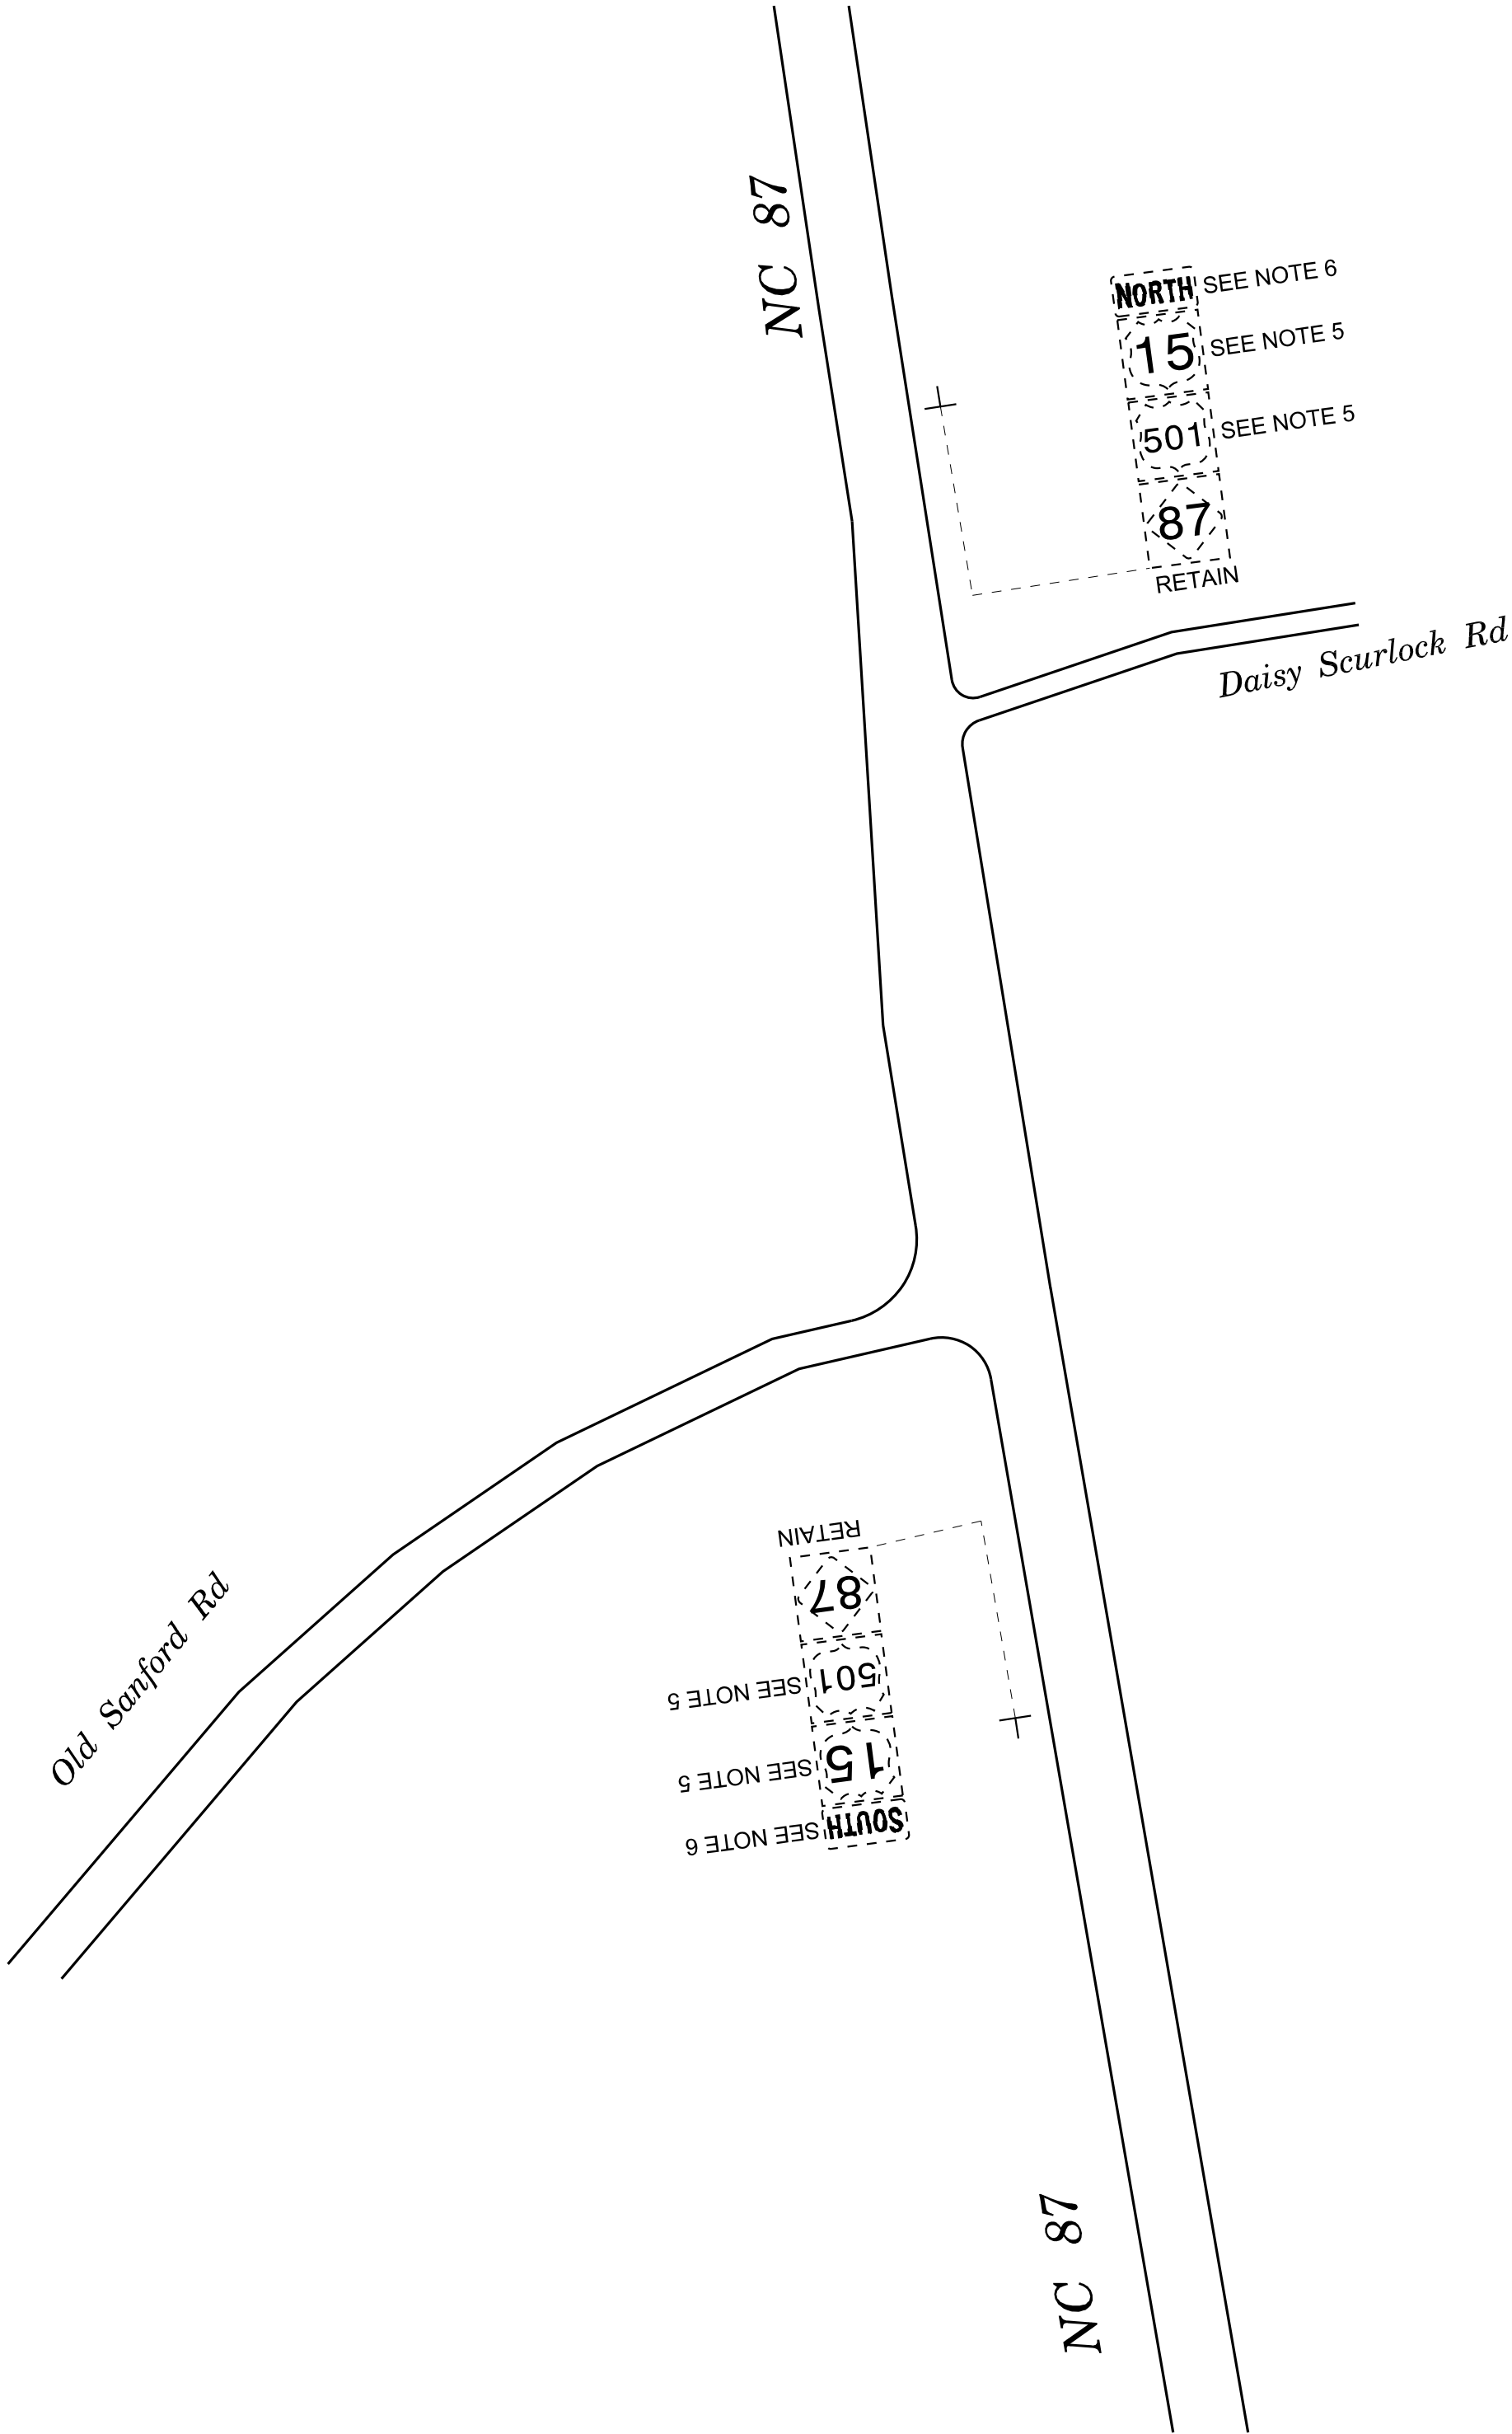

- DENOTES EXISTING SIGN
- DENOTES NEW "U" CHANNEL POST/PROPOSED SIGN LOCATION
- DENOTES EXISTING "U" CHANNEL POST/EXISTING SIGN LOCATION
- RETAIN ALL EXISTING SIGNS NOT SHOWN IN PLANS

PROJECT NOTES

- | | |
|---|------------------------------------|
| 1 | DISPOSAL OF SIGN SYSTEM, U-CHANNEL |
| 2 | SIGN ERECTION, TYPE D |
| 3 | SIGN ERECTION, TYPE E |
| 4 | SIGN ERECTION, TYPE F |
| 5 | DISPOSE OF SIGN, D, E OR F |
| 6 | SIGN ERECTION, RELOCATE TYPE F |

Kimley » Horn

421 FAYETTEVILLE STREET, SUITE 600
RALEIGH, N.C. 27601. NC LICENSE #F-0102


TIP NO.

R-5963A

SHEET NO.

SIGN-33

SEAL

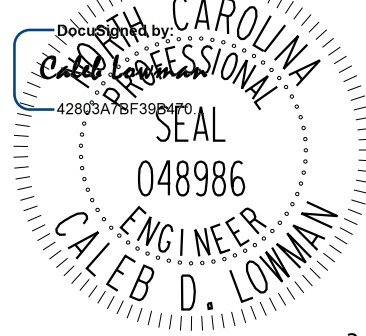

3/20/2025

**DOCUMENT NOT CONSIDERED FINAL
UNLESS ALL SIGNATURES COMPLETED**

SIGNING PLAN