




TIP PROJECT: R-4463A

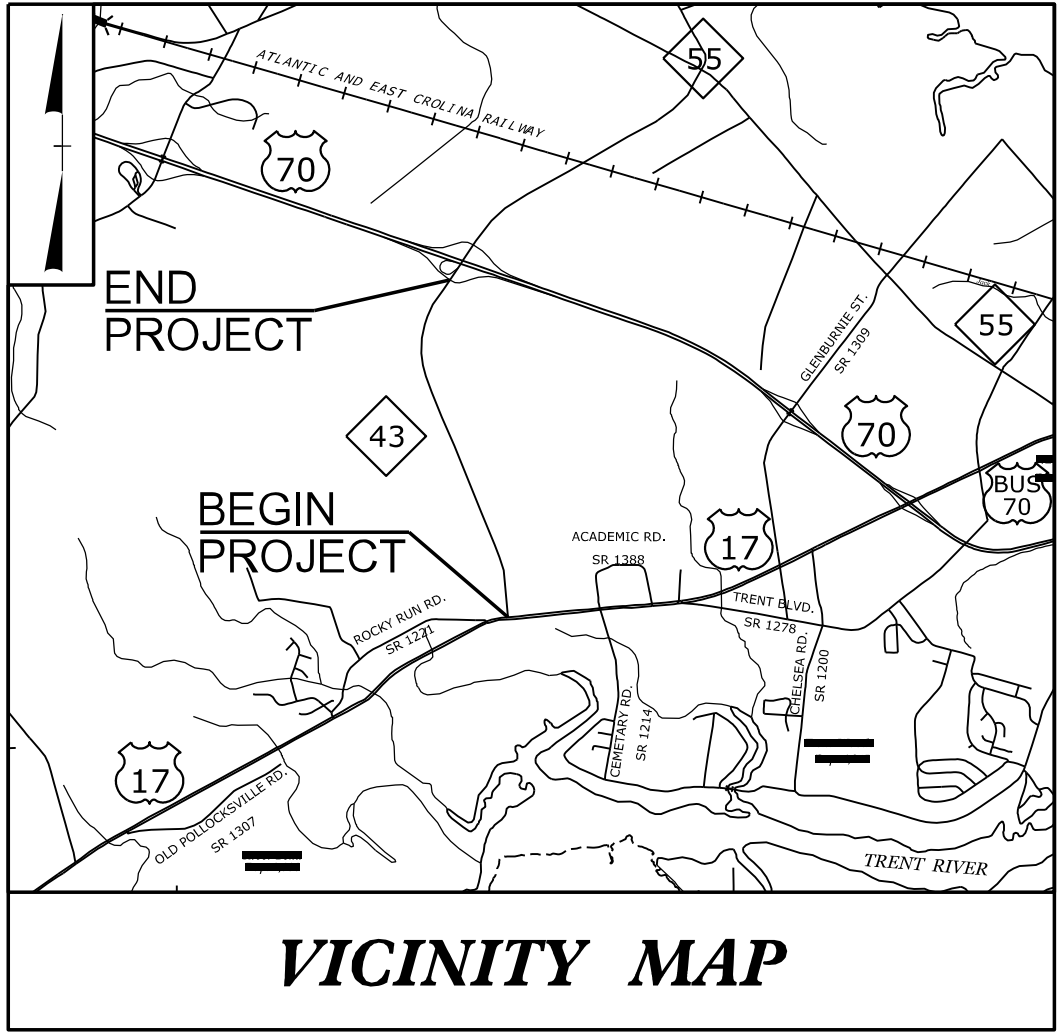



STATE OF NORTH CAROLINA
DIVISION OF HIGHWAYS

CRAVEN COUNTY

 LOCATION: NC 43 CONNECTOR FROM
US 70 TO US 17 BUSINESS
TYPE OF WORK: TRAFFIC SIGNAL AND
COMMUNICATION DESIGN

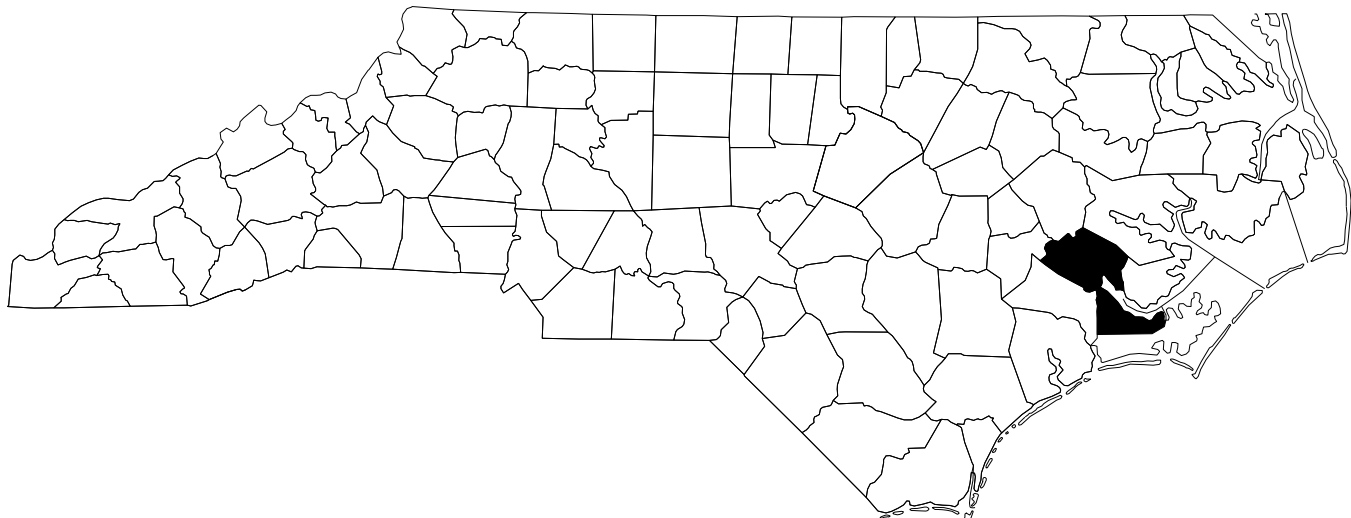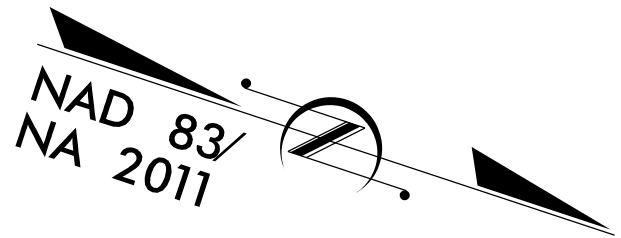

PROJECT REFERENCE NO.	SHEET NO.
R-4463A	Sig-1.0
APPROVED:  DATE: 4/14/2025	
SEAL 	
DOCUMENT NOT CONSIDERED FINAL UNLESS ALL SIGNATURES COMPLETED	

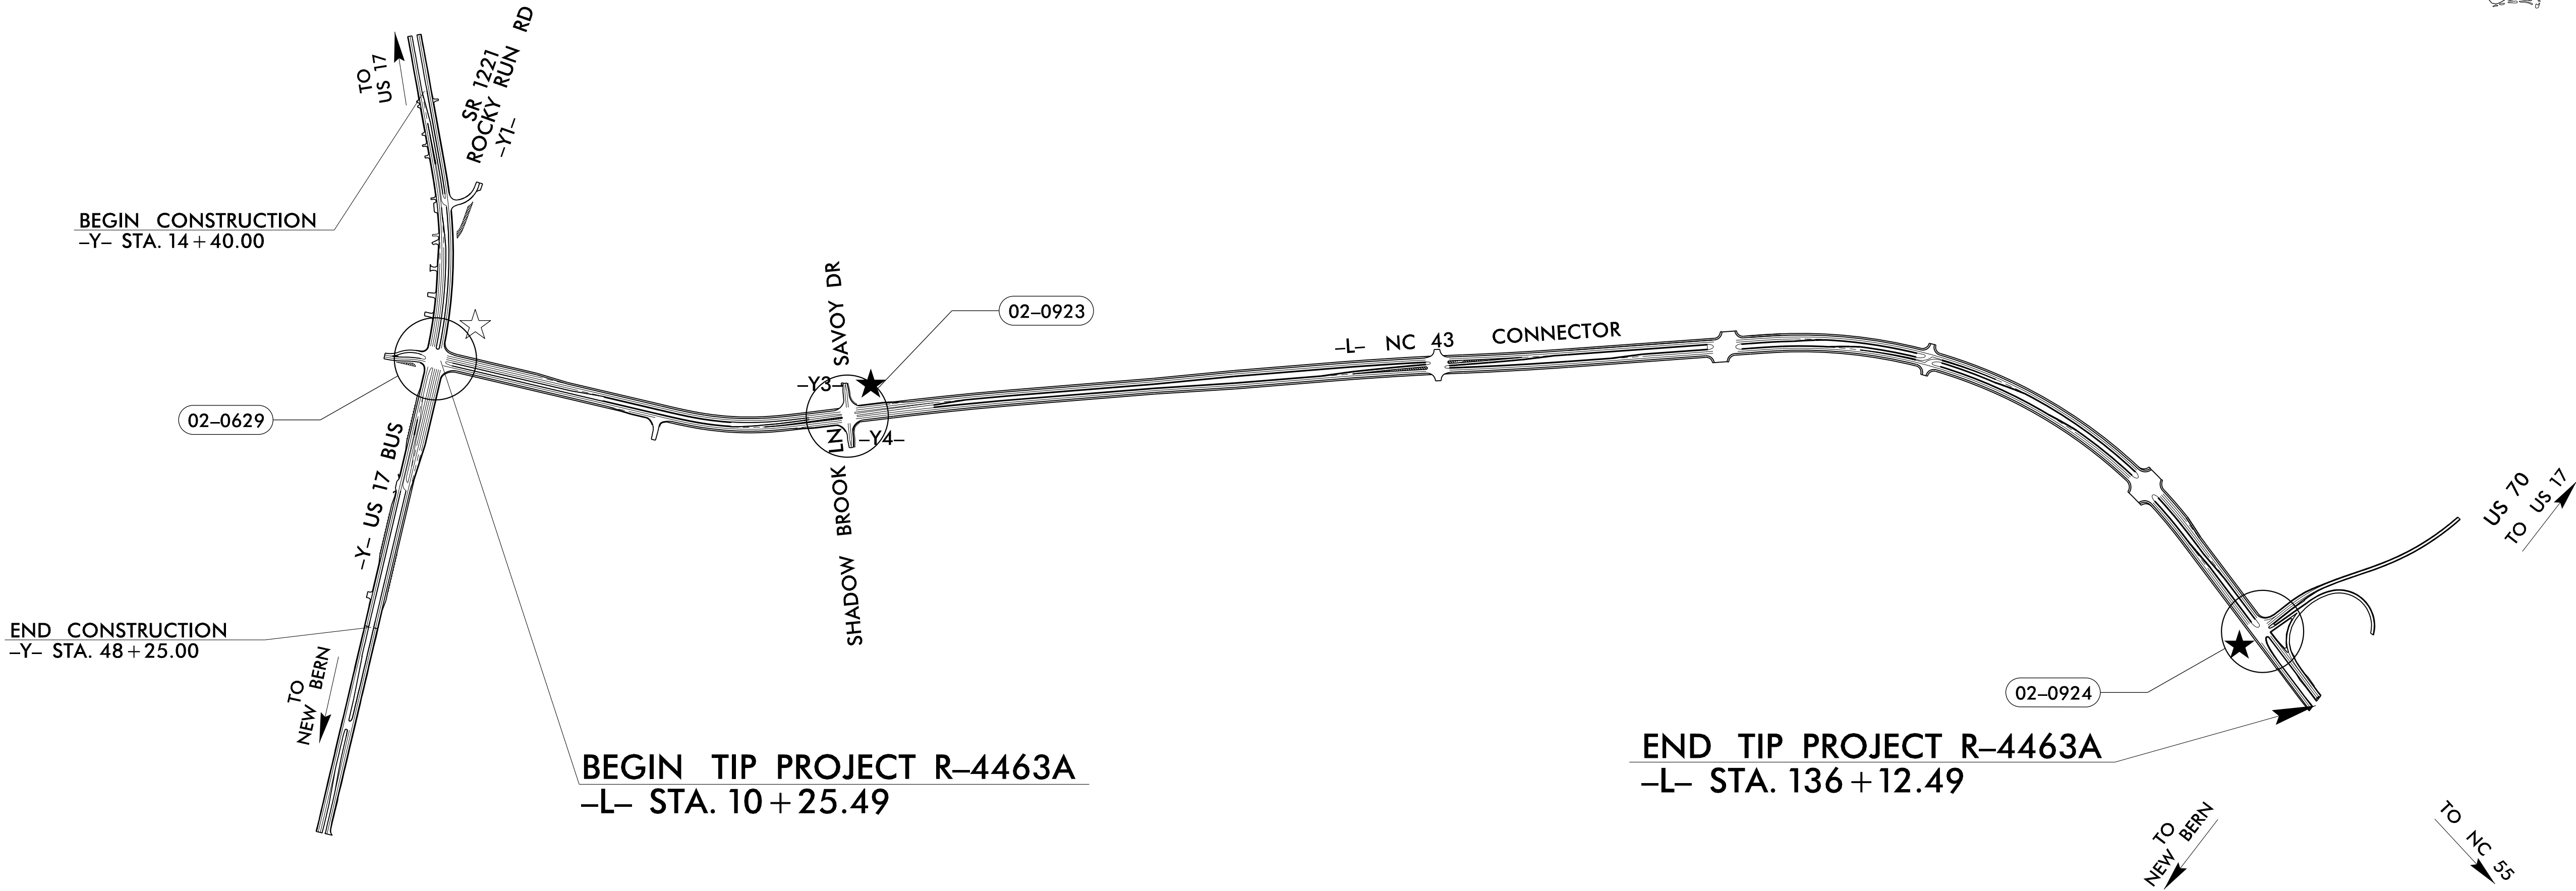

- ★ PROPOSED TRAFFIC SIGNAL
- ☆ EXISTING TRAFFIC SIGNAL

PLANS PREPARED BY:

Brittany N. Groome, P.E., PTOE, RSPI – Project Engineer

Darren J. White – Design Engineer

Dana-Simone Griffith – Design Engineer

INDEX OF PLANS

Sheet Number	SIN	Location/Description
Sig. 1.0	-	Title Sheet
Sig. 2.0-2.3	02-0629T1	US 17 Bus. (Dr. M. L. King, Jr. Blvd.) at NC 43/Ben D. Quinn Elementary
Sig. 3.0	02-0629T2	US 17 Bus. (Dr. M. L. King, Jr. Blvd.) at NC 43/Ben D. Quinn Elementary
Sig. 4.0	02-0629T3	US 17 Bus. (Dr. M. L. King, Jr. Blvd.) at NC 43/Ben D. Quinn Elementary
Sig. 5.0	02-0629T4	US 17 Bus. (Dr. M. L. King, Jr. Blvd.) at NC 43/Ben D. Quinn Elementary
Sig. 6.0-6.6	02-0629	US 17 Bus. (Dr. M. L. King, Jr. Blvd.) at NC 43/Ben D. Quinn Elementary
Sig. 7.0-7.4	02-0923	NC 43 at Savoy Dr/Shadow Brook Ln
Sig. 8.0-8.4	02-0924	NC 43 at US 17 NB-US 70 EB Ramps
SCP 1-16	-	Signal Communication Plans

Refer to "Roadway Standard Drawings
NCDOT" dated January 2024 and
"Standard Specifications for Roads
and Structures" dated January 2024.

Plans Prepared By:

DRMP, Inc.
8210 University Executive Park Dr., Suite 220
Charlotte, NC 28226
NC License No. F-1524 (704) 549-4260

LEGEND

SIGNAL INVENTORY NUMBER

INTELLIGENT TRANSPORTATION
AND SIGNALS UNIT

Contacts:

Zachary Little, P.E. – Eastern Region Signal Project Engineer

Gregg Green – Signal Communications Project Engineer

D. Todd Joyce, P.E. – Signal Equipment Design Review Engineer