


c:\pwworking\jmt\0562675\U-6005_Title Sheet.dgn

TIP PROJECT: U-6005

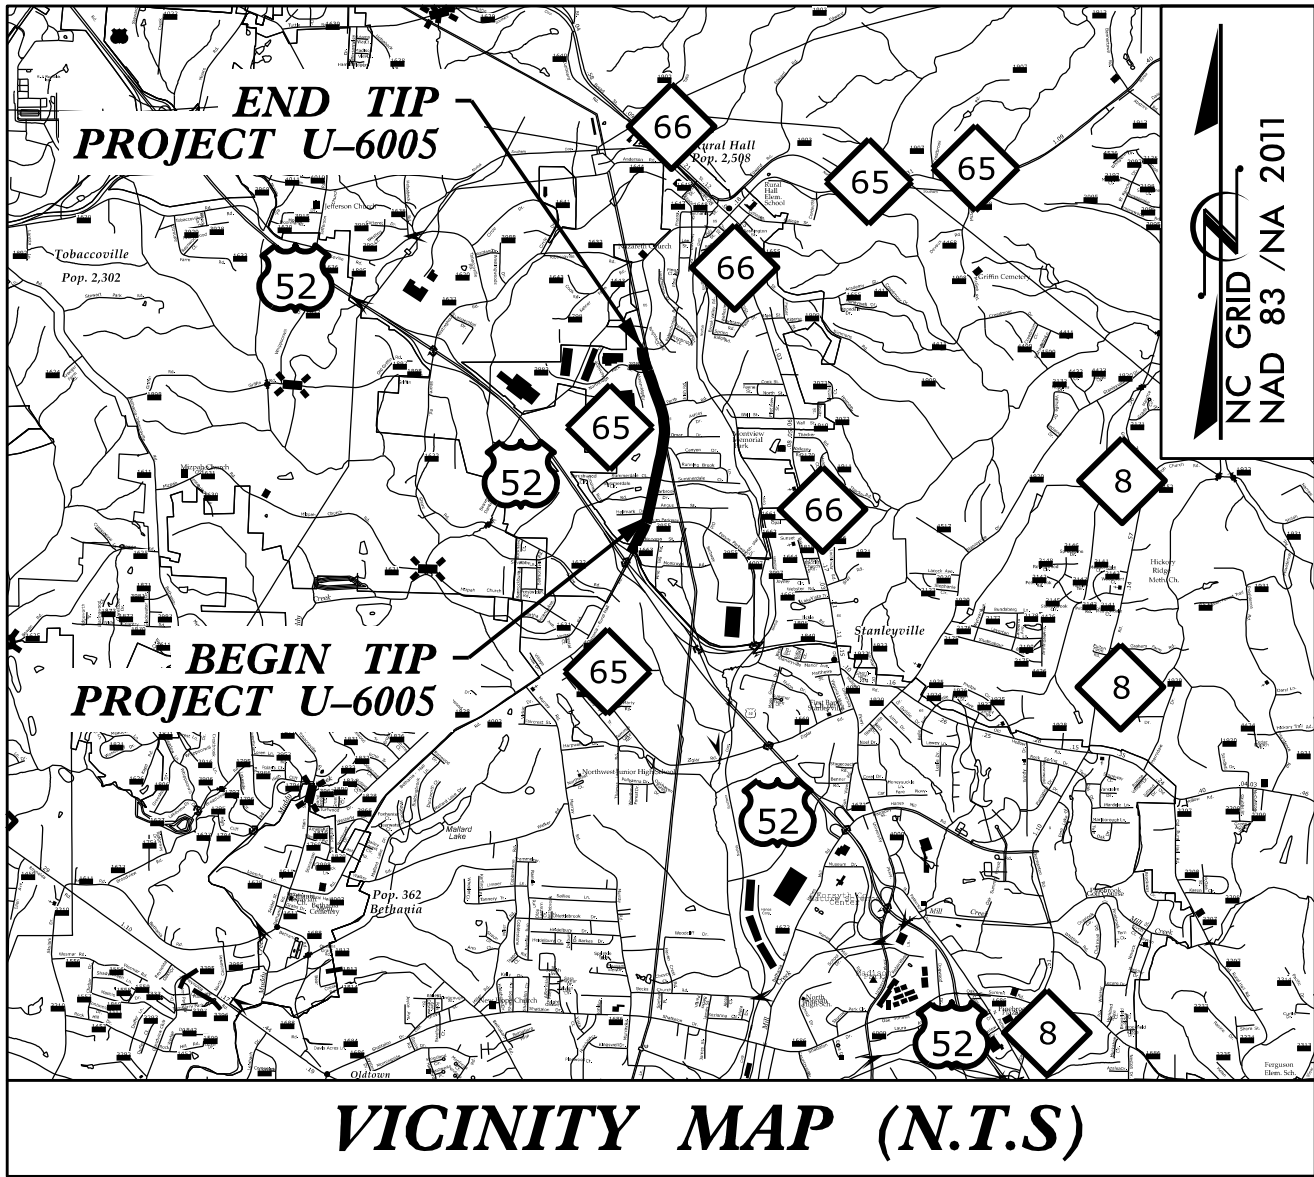


VICINITY MAP (N.T.S)

STATE OF NORTH CAROLINA
DIVISION OF HIGHWAYS


UTILITIES CONSTRUCTION PLANS
FORSYTH COUNTY

LOCATION: NC 65 FROM ANGUS STREET TO
NORTHBRIDGE PARK DRIVE
TYPE OF WORK: WATER AND SEWER
RELOCATION PLANS

T.I.P. NO.	SHEET NO.
U-6005	UC-1

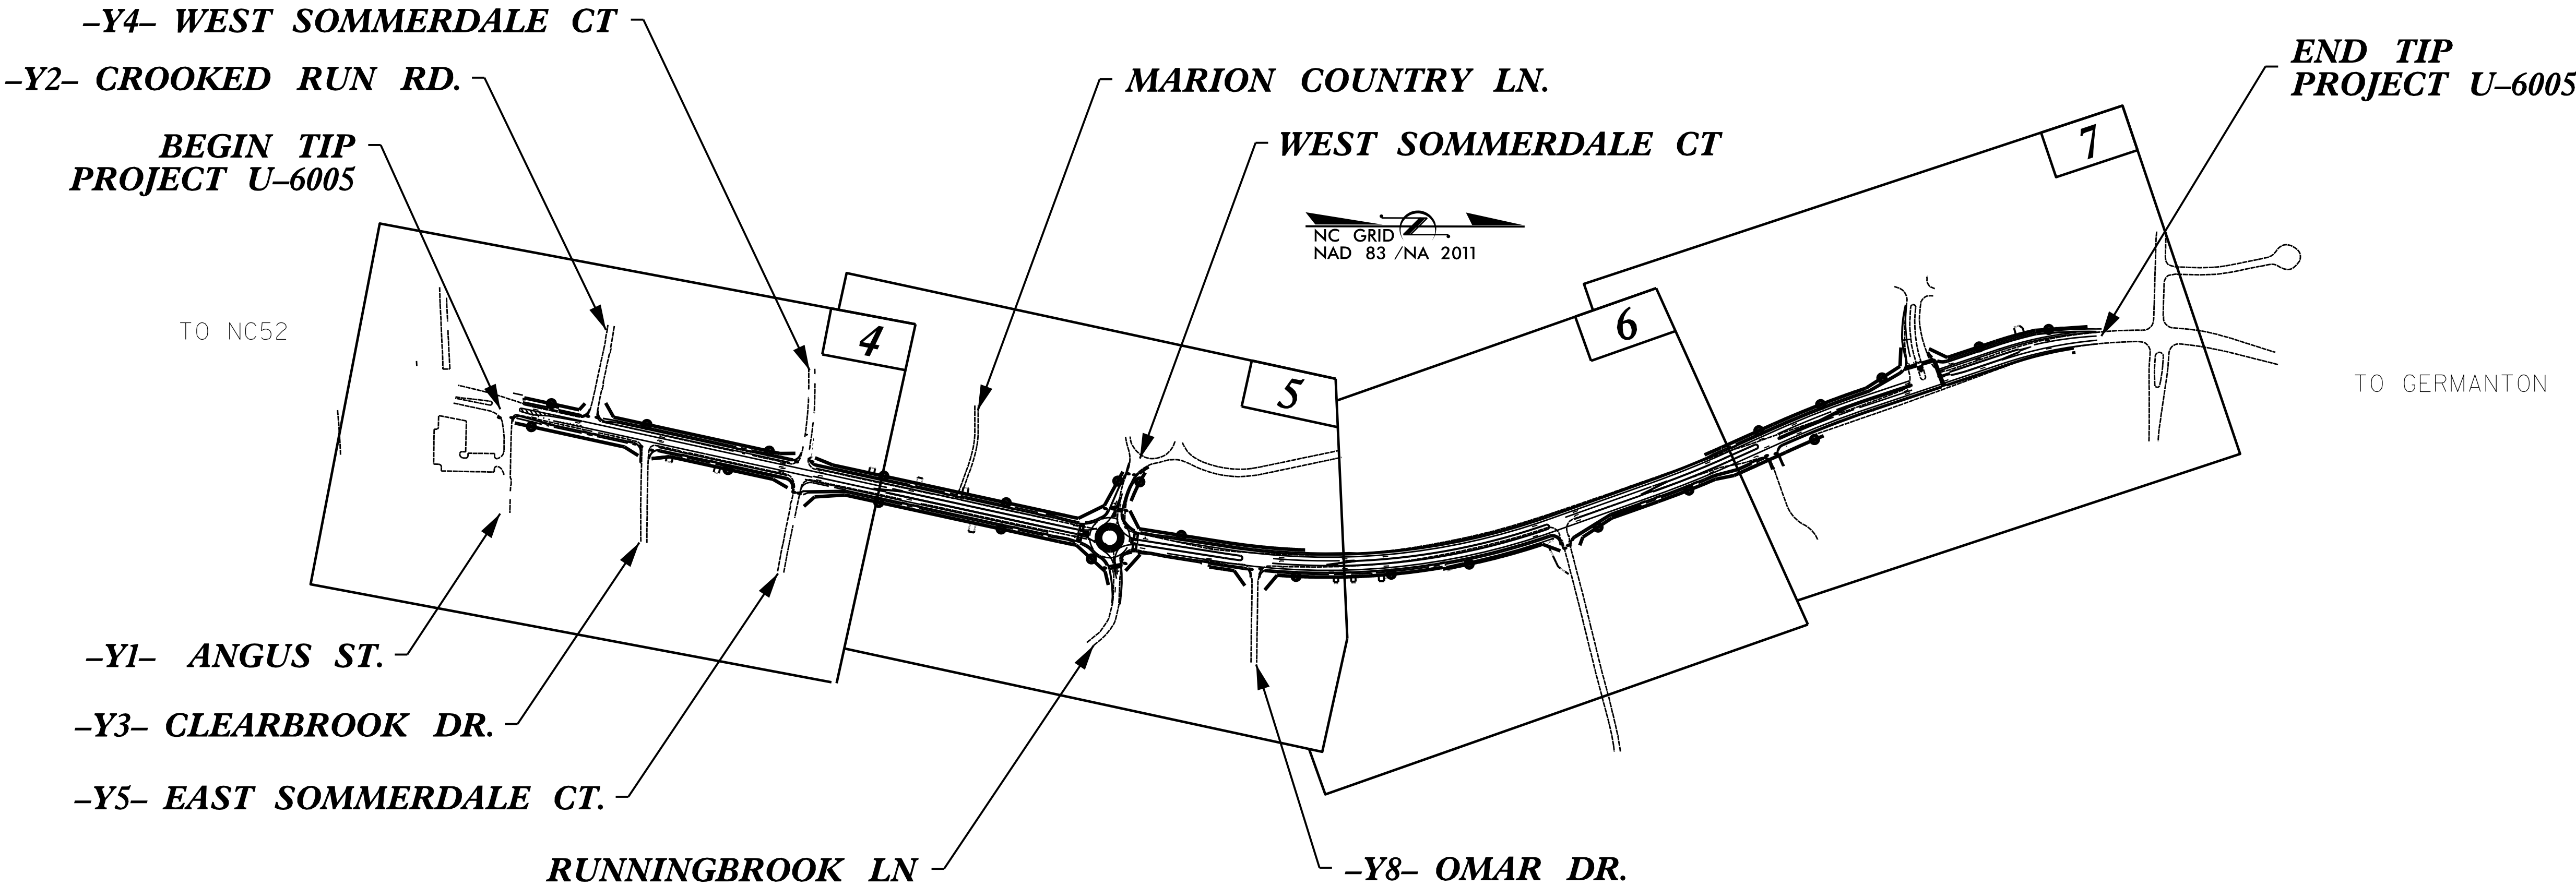

GRAPHIC SCALES

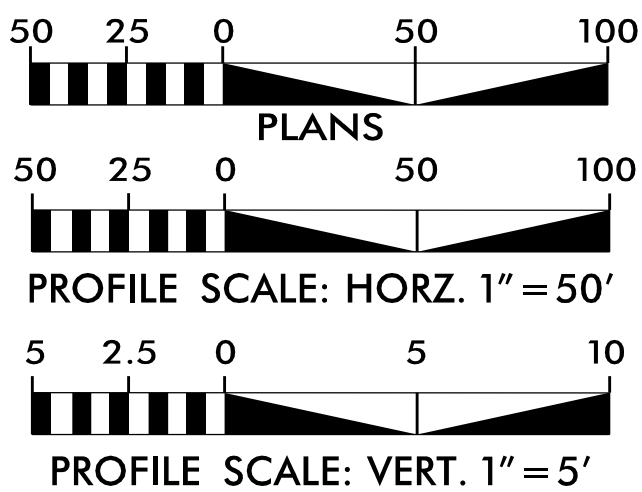

INDEX OF SHEETS

<u>SHEET NO.:</u>	<u>DESCRIPTION:</u>
UC-1	TITLE SHEET
UC-2	UTILITY SYMBOLOGY
UC-3 THRU UC-3M	NOTES & DETAILS
UC-4 THRU UC-7A	UTILITY PLANS & PROFILES

UTILITY OWNERS


(A) WATER & SEWER - WINSTON-SALEM /
FORSYTH COUNTY

PREPARED IN THE OFFICE OF:



<u>Marie Peedin, P.E.</u>	UTILITY PROJECT ENGINEER
<u>Nick Asaro</u>	PROJECT UTILITY COORDINATOR
<u>Emily Morris, E.I.</u>	PROJECT UTILITY DESIGNER

SEAL:

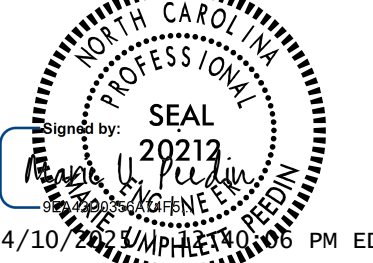

DIVISION OF HIGHWAYS
UTILITIES UNIT
1555 MAIL SERVICES CENTER
RALEIGH, NC 27699-1555
PHONE (919) 707-6690
FAX (919) 250-4151

<u>Ryan Newcomb</u>	DIVISION PROJECT ENGINEER
<u>Low Porter</u>	DIVISION UTILITIES COORDINATOR
<u>Josh McMahan</u>	SR. DIVISION UTILITIES COORDINATOR