

USE FOR LIGHTING CONSTRUCTION ONLY


 
PROJECT REFERENCE NO.	SHEET NO.
1-5880	E-2



DocuSigned by:
Nathan Dominick
4C80B584A58434

DOCUMENT NOT CONSIDERED FINAL
UNLESS ALL SIGNATURES COMPLETED

SEE SHEET "E-1" FOR
LEGEND & △ NOTES

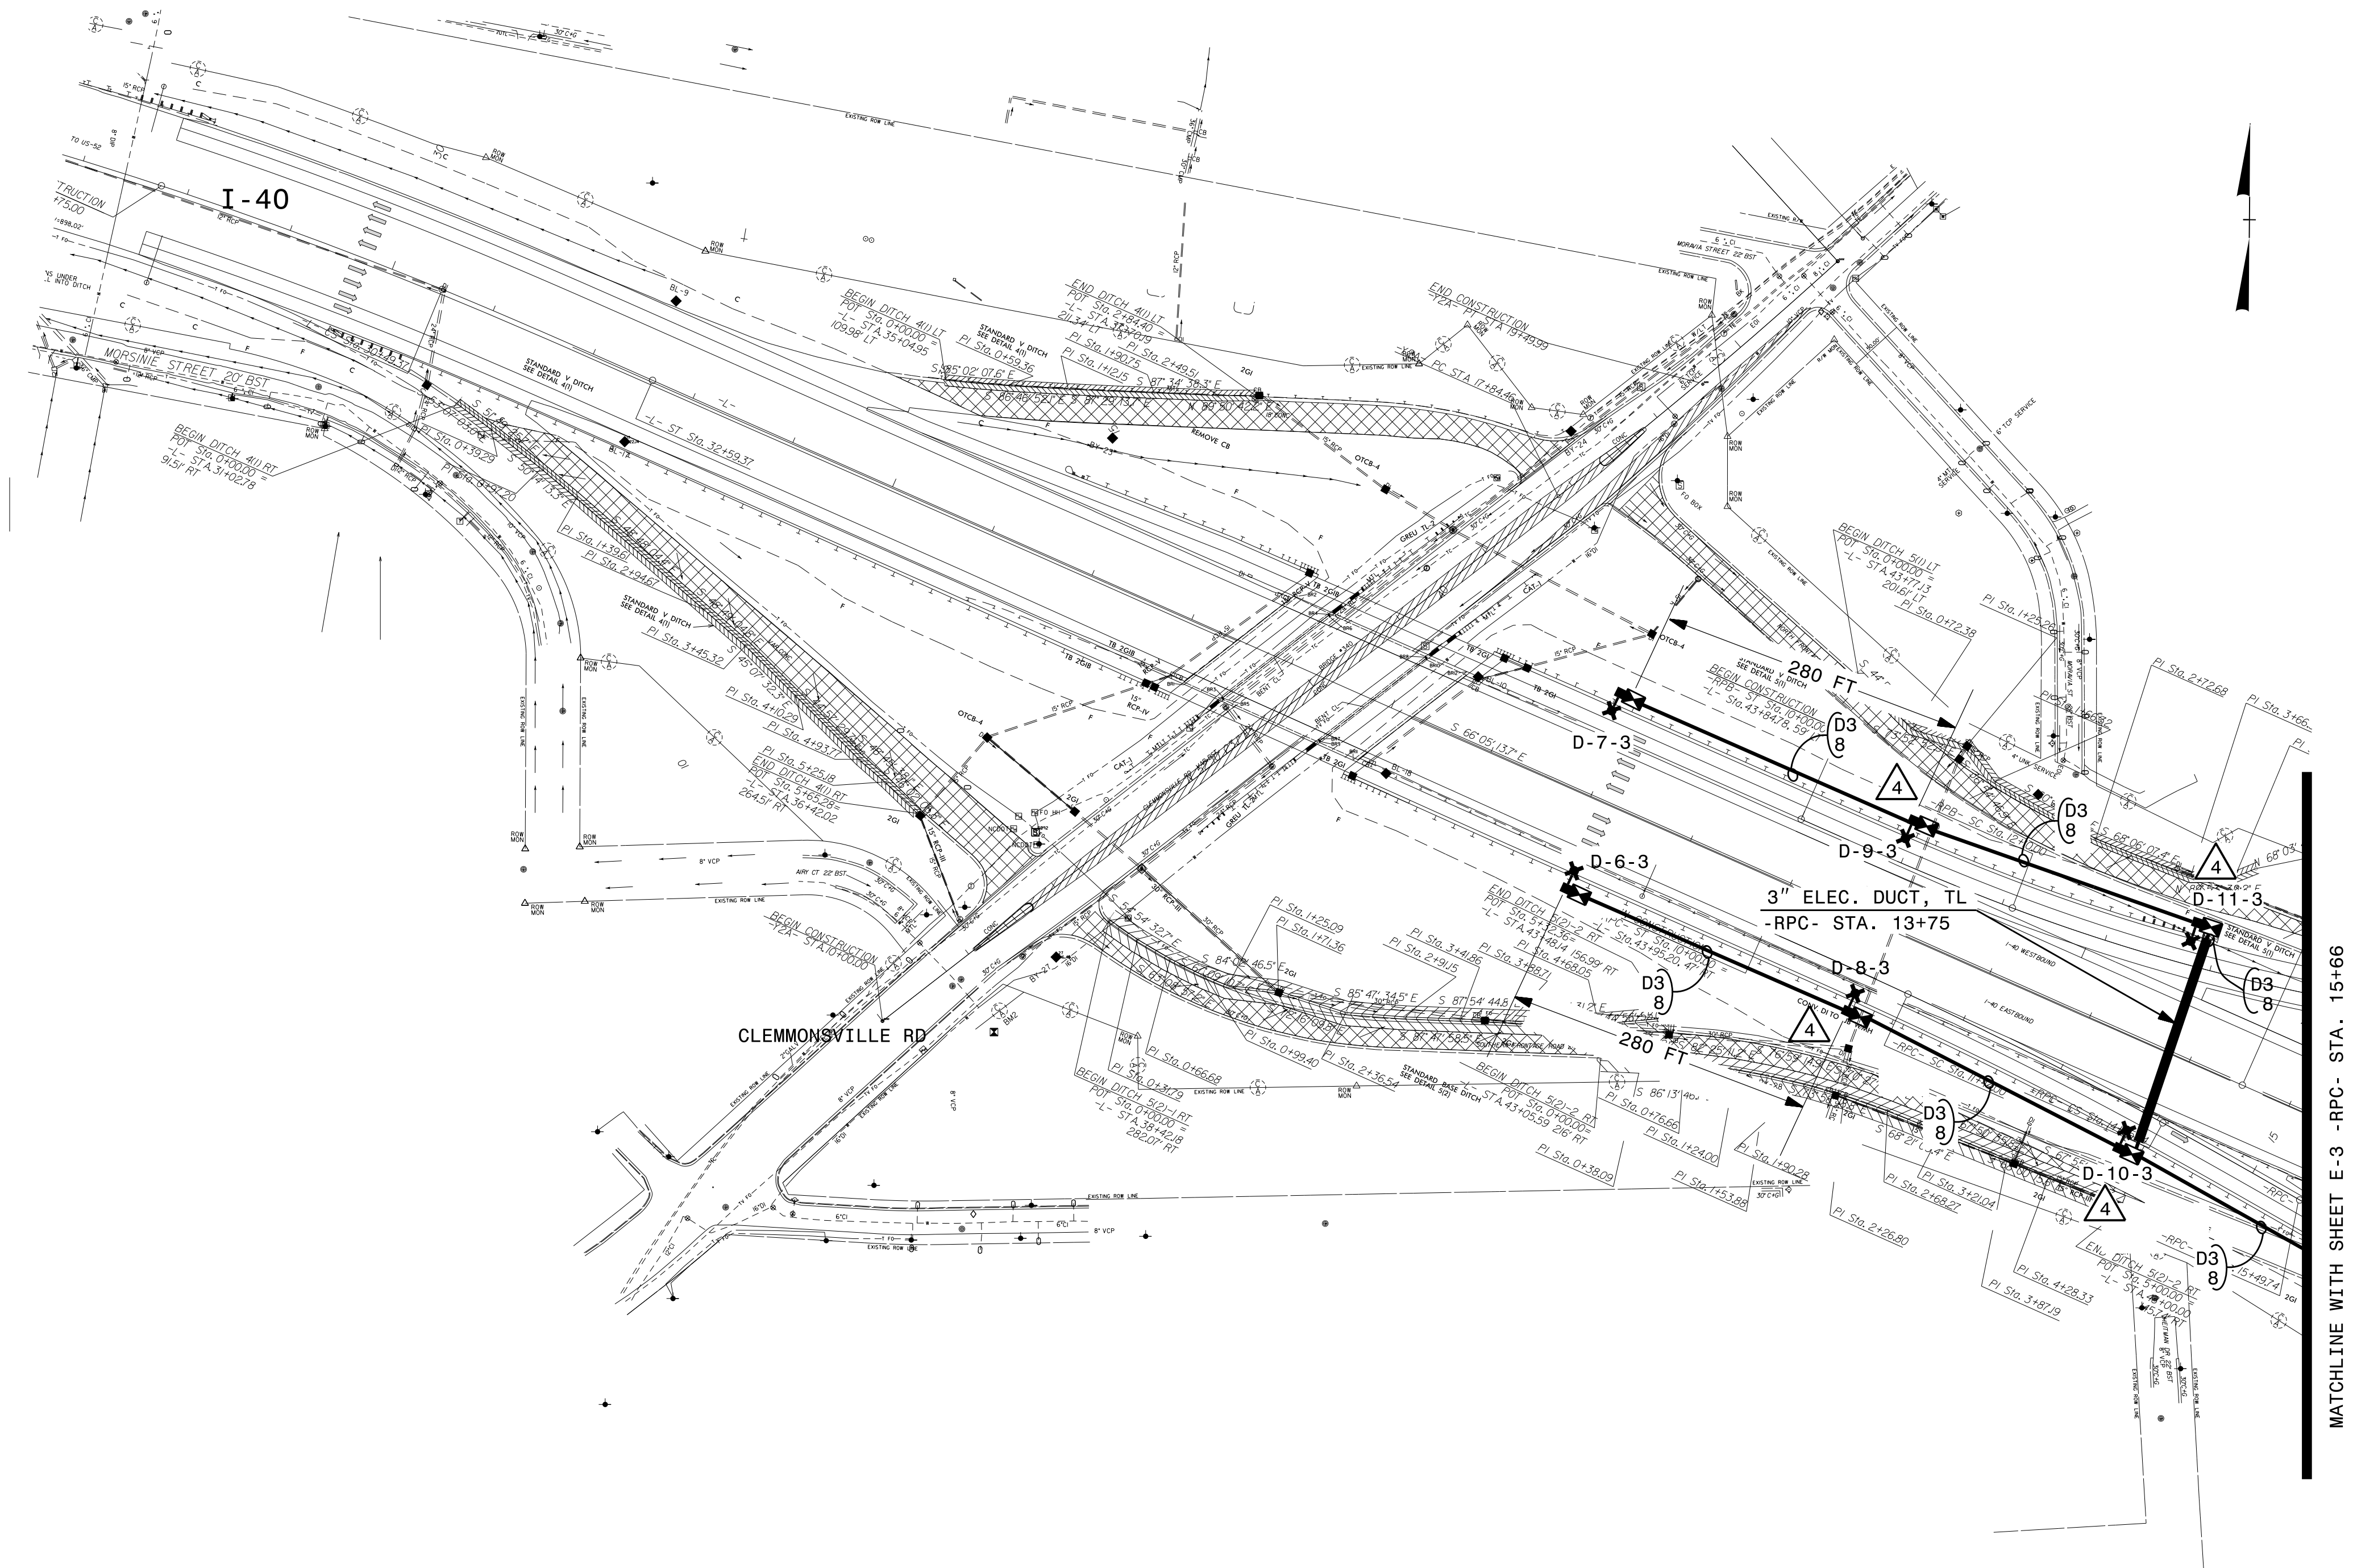

MATCHLINE WITH SHEET E-3 -RPC- STA. 15+86

2			
1			
Rev.	Date	Description	Approved
NORTH CAROLINA DEPARTMENT OF TRANSPORTATION ROADWAY DESIGN LIGHTING/ELECTRICAL SECTION			
LIGHTING LAYOUT I-40/THOMASVILLE RD INTERCHANGE			
FORSYTH COUNTY			
Drawn By: AB	Approved By: RGH	Dwg No.:	

I6-DEC-2024 09:22
R:\Lighting\Lighting Design\Files\15880.1&e.psh.e2.dgn
1abr-own1 RT RD-328855L