

GENERAL NOTES

- CIRCUIT AND JUNCTION BOX LOCATIONS MAY BE FIELD ADJUSTED AS REQUIRED TO STAY WITHIN THE LIMITS OF CONSTRUCTION, WITHIN RIGHT-OF-WAY, OUT OF DITCH LINES, AWAY FROM FENCE POSTS, GUARDRAILS AND CABLE GUIDERAILS, AND TO CLEAR OBSTRUCTIONS. ADJUSTMENTS RESULTING IN AN OVERALL INCREASE OF 3% OR MORE TO ANY CIRCUIT LENGTH REQUIRES APPROVAL FROM THE ENGINEER.
- LOCATE ALL JUNCTION BOXES OUTSIDE CLEAR ZONE AND IN AN AREA UNLIKELY TO BE USED BY TRAFFIC.
- ALL IN GROUND JUNCTION BOXES DEPTHS SHALL BE 18" UNLESS OTHERWISE NOTED. SEE DETAIL SHEETS FOR FORMED OPENING DEPTHS.
- CONTRACTOR SHALL RECORD THE GPS COORDINATES OF EACH JUNCTION BOX WITHIN 3' ACCURACY, IN THE JUNCTION BOX SUMMARY, TABLE "C". PROVIDE A COPY OF THE JUNCTION BOX SUMMARY WITH THESE COORDINATES TO THE LIGHTING ENGINEER DURING PROJECT INSPECTION. COORDINATES ARE NOT REQUIRED FOR FORMED OPENINGS.
- JUNCTION BOXES SHOWN NEAR LIGHT STANDARDS (LSJB & HMJB) ARE SHOWN FOR CLARITY. THESE JUNCTION BOXES ARE TO BE USED AS A TEE POINT FOR CIRCUITRY TO THE STANDARD, AND SHALL BE INSTALLED FOR BEST ALIGNMENT OF CIRCUITRY WHILE MAINTAINING THE OFFSETS SHOWN IN TABLE "C". SEE STANDARD DRAWINGS 1401.01 AND 1406.01 FOR INSTALLATION DETAILS.
- INSTALL ALL BORE PITS OUTSIDE THE CLEAR ZONE, AS DEFINED BY THE 2011 AASHTO ROADSIDE DESIGN GUIDE OR AS DIRECTED BY THE ENGINEER.
- INSTALL RIGID GALVANIZED CONDUIT (RGC) ABOVE GROUND, AND POLYVINYL CHLORIDE (PVC) SCHEDULE 40 CONDUIT UNDERGROUND, EXCEPT AS MODIFIED ON THESE PLANSHEETS OR IN APPLICABLE SECTIONS OF THE ROADWAY STANDARD DRAWINGS FOR THIS PROJECT.
- POLE NUMBERING CONVENTION: CONTROL SYSTEM-POLE #-CKT # (A-3-2).
- SERVICE POLE SHALL NOT BE INSTALLED PRIOR TO COORDINATION WITH THE LOCAL UTILITY. PROVIDE PROOF OF COORDINATION AND PROOF OF NEED TO THE ENGINEER AFTER CONSULTING WITH THE LOCAL UTILITY. THE SERVICE POLE MAY BE DELETED FROM THE CONTRACT IF NOT REQUIRED. REFER TO ARTICLE 1407-3 OF THE 2024 NCDOT STANDARD SPECIFICATIONS FOR ROADS AND BRIDGES.
- WHERE A CURRENT TRANSFORMER (CT) CABINET IS REQUIRED, THE CT CABINET AND ASSOCIATED HARDWARE ARE INCIDENTAL TO THE PAY ITEM FOR THE LIGHTING CONTROL PANEL.
- WHEN FIELD ADJUSTMENT TO CONTROL PANEL LOCATION IS REQUIRED, THE CONTRACTOR SHALL LOCATE THE PROPOSED CONTROL SYSTEM IN AN AREA ACCESSIBLE FOR MAINTENANCE VEHICLES AND OUTSIDE OF CLEAR ZONE AS DEFINED BY THE 2011 AASHTO ROADSIDE DESIGN GUIDE.

NOTES

- AT THESE LOCATIONS, PROVIDE A COMMON GROUND PER NEC REQUIREMENTS FOR ALL ELECTRICAL CIRCUITS WITHIN THE RACEWAY. RACEWAY SHALL BE INSTALLED WITHIN A PROTECTIVE SLEEVE UNDER THE ROADWAY. SEE TABLE "B" FOR ESTIMATED LENGTHS.
- LOCATE FOR BEST ALIGNMENT OF CIRCUITRY.
- HIGH MAST D-4-4 SHALL BE MOUNTED 50 FEET FROM EDGE-OF-TRAVEL FOR BOTH I-40 AND RAMP A.
- REFER TO TABLE D FOR LIGHT STANDARD STATIONS.
- CLEAR AND GRUB 25 FEET AROUND HIGH MAST D-5-5 FOUNDATION.
- AT THESE LOCATIONS, THERE IS LIMITED ROOM BETWEEN THE BACK OF CURB AND THE RIGHT OF WAY LINE. DUE TO SYMBOLOGY SIZING, THE PLANS APPEARS SHOW LIGHTING EQUIPMENT OUTSIDE OF THE RIGHT OF WAY. THE CONTRACTOR SHALL INSTALL ALL LIGHTING EQUIPMENT WITHIN THE RIGHT OF WAY.

PLANS AND DETAILS FOR PROPOSED LIGHTING /ELECTRICAL CONSTRUCTION

SCOPE OF WORK

PLACE ROADWAY LIGHTING SYSTEM INTO SERVICE BY PROVIDING AND INSTALLING LIGHT STANDARDS WITH LIGHT EMITTING DIODE LUMINAIRES, UNDERGROUND CIRCUITRY, CONTROL SYSTEM AND JUNCTION BOXES.

DESIGN CRITERIA

0.8 AVERAGE FOOTCANDLE ON TRAVEL LANES
4:1 AVERAGE TO MINIMUM UNIFORMITY RATIO ON TRAVEL LANES
2018 AASHTO ROADWAY LIGHTING DESIGN GUIDE
2020 NATIONAL ELECTRICAL CODE
2011 AASHTO ROADSIDE DESIGN GUIDE
2013 AASHTO STANDARD SPECIFICATIONS FOR STRUCTURAL SUPPORTS FOR HIGHWAY SIGNS, LUMINAIRES, AND TRAFFIC SIGNALS, 6TH EDITION AND LATEST INTERIM SPECIFICATIONS VALID AT THE TIME OF LETTING (HANDHOLE SHAFT DIAMETER REQUIREMENT AND HANDHOLE PLACEMENT REQUIREMENT WAIVED)
FATIGUE CATEGORY II SHALL BE USED IN DESIGN
DESIGN LIGHT STANDARD SUPPORT FOR BASIC WIND SPEED OF 70 MPH
DESIGN HIGH MOUNT SUPPORT FOR BASIC WIND SPEED OF 90 MPH
DESIGN HIGH MOUNT STANDARD FOUNDATION FOR BASIC WIND SPEED OF 110 MPH. ANY CONTRACTOR-DESIGNED SITE SPECIFIC FOUNDATION DESIGN SHALL BE DESIGNED FOR THE SAME WIND SPEED

ROADWAY STANDARDS

THE FOLLOWING ROADWAY ENGLISH STANDARDS AS APPEAR IN "NCDOT ROADWAY STANDARD DRAWINGS", ROADWAY DESIGN UNIT-N.C. DEPARTMENT OF TRANSPORTATION RALEIGH, N.C., DATED JANUARY 2024 ARE APPLICABLE TO THIS PROJECT AND BY REFERENCE HEREBY ARE CONSIDERED A PART OF THESE PLANS:

STD NO.	TITLE
1401.01	HIGH MOUNT STANDARD
1402.01	HIGH MOUNT FOUNDATION
1403.01	HIGH MOUNT LED LUMINAIRES
1404.01	LIGHT STANDARDS
1405.01	STANDARD FOUNDATION
1406.01	LIGHT STANDARD LUMINAIRES
1407.01	ELECTRIC SERVICE POLE AND LATERAL
1408.01	LIGHT CONTROL SYSTEM
1409.01	ELECTRICAL DUCT
1410.01	FEEDER CIRCUITS
1411.01	ELECTRICAL JUNCTION BOXES

ALL WORK SHALL BE IN CONFORMANCE WITH DIVISION 14 OF THE STANDARD SPECIFICATIONS FOR ROADS AND STRUCTURES, DATED JANUARY 2024.


PROJECT REFERENCE NO.

I-5880

SHEET NO.

E-1

DOCUMENT NOT CONSIDERED FINAL
UNLESS ALL SIGNATURES COMPLETED

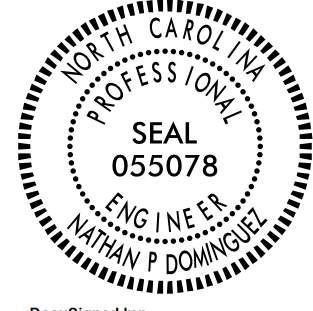

DocuSigned by
Nathan P. Domingue
05/12/2025
4C8B8B58A08434

LEGEND

- PROPOSED 60' HIGH MAST STANDARD W/ HM FOUNDATION, JUNCTION BOX & 4 HM LED LUMINAIRES. 335W MAX, 27,000 MIN. MAINTAINED DELIVERED LUMENS, TYPE V. MAXIMUM BUG RATING 5-0-5.
- PROPOSED 80' HIGH MAST STANDARD W/ HM FOUNDATION, JUNCTION BOX & 8 HM LED LUMINAIRES. 335W MAX, 27,000 MIN. MAINTAINED DELIVERED LUMENS, TYPE V. MAXIMUM BUG RATING 5-0-5.
- PROPOSED LIGHT STANDARD TYPE MTLT 45' WITH 15' SINGLE ARM. INCLUDES STANDARD FOUNDATION TYPE R1 OR R2, JUNCTION BOX & 285W MAX LED ROADWAY LUMINAIRE. IES DISTRIBUTION:TYPE II OR III AS REQUIRED. MAXIMUM BUG RATING 3-0-3.
- PROPOSED CONTROL SYSTEM WITH JUNCTION BOX. SEE PLANS FOR BREAKER SIZES.
- PROPOSED ELECTRICAL JUNCTION BOX. SEE TABLE C FOR DETAILS AND TYPE.
- REFERENCE TO CORRESPONDING DELTA NOTE AS NUMBERED.
- PROPOSED FEEDER CIRCUIT. CONTROL SYSTEM (A), CIRCUIT NUMBER (1) PLAN SYMBOL (6). SEE TABLE A, THIS SHEET.
- PROPOSED 30' CLASS 4 SERVICE POLE AND LATERAL 3 #1/0 USE CONDUCTORS 2" CONDUIT
- PROPOSED ELECTRICAL DUCT SIZE 2", 3" OR 4" TYPE (TL) OR (BD) LOCATION: SEE TABLE B.
2", 3" OR 4" ELEC. DUCT TL & BD

ABBREVIATIONS

BD	BURIED	PVC	PVC SCHEDULE 40 CONDUIT
LT	LIGHT	RGC	RIGID GALVANIZED STEEL CONDUIT
TL	TRENCHLESS	C	CONDUIT
MH	MOUNTING HEIGHT	CKT	CIRCUIT
Ø	PHASE	N	NEUTRAL
SER LAT	SERVICE LATERAL	G	GROUND
IGJB	IN GROUND JUNCTION BOX	HM	HIGH MAST
LED	LIGHT EMITTING DIODE	LSJB	LIGHT STANDARD JUNCTION BOX
HMJB	HIGH MAST JUNCTION BOX	CSJB	CONTROL SYSTEM JUNCTION BOX

COMPUTED BY: AB DATE: 12/9/2024
CHECKED BY: RGH DATE:

TABLE "A" CIRCUITRY CONDUCTOR CONDUIT TYPE & SIZE			
PLAN SYMBOL	DESCRIPTION		CONTRACT ITEM
8	2 #8 Ø 1 #10G 1.5" P	2 AWG SIZE 8 CONDUCTOR (BK & RD) 1 AWG SIZE 10 GROUNDING CONDUCTOR 1.5" PVC CONDUIT	2 - 8 W/G FEEDER CIRCUIT IN 1.5" CONDUIT
*8	2 #8 Ø 1 #10G	2 AWG SIZE 8 CONDUCTOR (BK & RD) 1 AWG SIZE 10 GROUNDING CONDUCTOR	2 - 8 W/G FEEDER CIRCUIT
6	2 #6 Ø 1 #8G 1.5" P	2 AWG SIZE 6 CONDUCTOR (BK & RD) 1 AWG SIZE 8 GROUNDING CONDUCTOR 1.5" PVC CONDUIT	2 - 6 W/G FEEDER CIRCUIT IN 1.5" CONDUIT
*6	2 #6 Ø 1 #10G	2 AWG SIZE 6 CONDUCTOR (BK & RD) 1 AWG SIZE 8 GROUNDING CONDUCTOR	2 - 6 W/G FEEDER CIRCUIT
4	2 #4 Ø 1 #6G 1.5" P	2 AWG SIZE 4 CONDUCTOR (BK & RD) 1 AWG SIZE 6 GROUNDING CONDUCTOR 1.5" PVC CONDUIT	2 - 4 W/G FEEDER CIRCUIT IN 1.5" CONDUIT
*4	2 #4 Ø 1 #6G	2 AWG SIZE 4 CONDUCTOR (BK & RD) 1 AWG SIZE 6 GROUNDING CONDUCTOR	2 - 4 W/G FEEDER CIRCUIT
2	2 #2 Ø 1 #4G 1.5" P	2 AWG SIZE 2 CONDUCTOR (BK & RD) 1 AWG SIZE 4 GROUNDING CONDUCTOR 1.5" PVC CONDUIT	2 - 2 W/G FEEDER CIRCUIT IN 1.5" CONDUIT
*2	2 #2 Ø 1 #4G	2 AWG SIZE 2 CONDUCTOR (BK & RD) 1 AWG SIZE 4 GROUNDING CONDUCTOR	2 - 2 W/G FEEDER CIRCUIT

02/03/98

I6-DEC-2024 14:10
R:\Lighting\Electrical\Lighting Design\Lighting Files\I5880-11&e-psh-el.dgn
labrown1 At RD-328855

TABLE "C" JUNCTION BOX AND FORMED OPENING SUMMARY (SEE GENERAL NOTE 5)													
CONTROL SYSTEM "D"													
SHEET	LABEL	LOCATION AND OFFSET	TYPE, PAY ITEM & SIZE								GPS LOCATION (SEE GENERAL NOTE 4)		
			JUNCTION BOXES							FORMED OPENINGS		LAT/LONG (TO BE COMPLETED BY CONTRACTOR)	
			IN GROUND		LIGHT STANDARD		HIGH MAST		CONTROL SYSTEM	BRIDGE RAIL	MEDIAN BARRIER		
			IG18 18"X12"	IG36 36"X24"	LS18 18"X12"	LS36 36"X24"	HM18 18"X12"	HM36 36"X24"	CS36 36"X24"	F010 10"X12"	F018 18"X12"		
E-3	HM D-1JB	10' FROM HM D-1-1					X						
E-3	HM D-2JB	10' FROM HM D-2-2					X						
E-3	HM D-3JB	10' FROM HM D-3-2					X						
E-3	HM D-4JB	10' FROM HM D-4-4					X						
E-3	HM D-5JB	10' FROM HM D-5-5					X						
E-2	SA D-6JB	5' FROM SA D-6-3			X								
E-2	SA D-7JB	5' FROM SA D-7-3			X								
E-2	SA D-8JB	5' FROM SA D-8-3			X								
E-2	SA D-9JB	5' FROM SA D-9-3			X								
E-2	SA D-10JB	5' FROM SA D-10-3			X								
E-2	SA D-11JB	5' FROM SA D-11-3			X								
E-3	SA D-12JB	5' FROM SA D-12-3			X								
E-3	SA D-13JB	5' FROM SA D-13-3			X								
E-3	SA D-14JB	5' FROM SA D-14-4			X								
E-3	SA D-15JB	5' FROM SA D-15-4			X								
E-3	SA D-16JB	5' FROM SA D-16-5			X								
E-3	SA D-17JB	5' FROM SA D-17-5			X								
E-3	SA D-18JB	5' FROM SA D-18-5			X								
E-3	SA D-19JB	5' FROM SA D-19-5			X								
E-3	SA D-20JB	5' FROM SA D-20-5			X								
E-3	SA D-21JB	5' FROM SA D-21-5			X								
E-3	SA D-22JB	5' FROM SA D-22-1			X								
E-3	SA D-23JB	5' FROM SA D-23-1			X								
E-3	SA D-24JB	5' FROM SA D-24-5			X								
E-3	JBD1	-RPC- STA. 26+46 40' RT		X									
E-3	JBD2	-RPC- STA. 26+46 31' LT	X										
E-3	JBD3	SEE DELTA NOTE 2	X										
E-3	JBD4	SEE DELTA NOTE 2	X										
E-3	JBD5	-Y1- STA. 23+48, 48' LT	X										
E-3	JBD6	-RPA- STA. 16+28 39' RT	X										
E-3	JBD7	-RPB- STA. 19+10 27' RT	X										
E-3	JBD8	-RPC- STA. 23+64 39' RT	X										
E-3	JBD9	-Y1- STA. 31+50 64' LT	X										
E-3	JBD10	-RPD- STA. 15+14 47' LT	X										
E-3	JBD11	-RPD- STA. 18+52 23' RT	X										
E-3	JBD12	SEE DELTA NOTE 2	X										
E-3	JBD13	-RPB- STA. 19+10 45' LT	X										
E-3	CSDJB	2' FROM CS"D"						X					
CS"D" TOTALS			12	1	19		5		1				

TABLE "B" ELECTRICAL DUCT SUMMARY (ESTIMATED LENGTH IN FEET)								
			TYPE					
			TRENCHLESS (TL) FEET			BURIED (BD) FEET		
LOCATION	RACEWAY 	SHEET	SIZE 2"	SIZE 3"	SIZE 4"	SIZE 2"	SIZE 3"	SIZE 4"
-RPC- STA. 26+46	JBD1 TO JBD2	E-3			50	70		
-Y1- STA. 31+22	D-14JB TO JBD9	E-3			145	165		
-RPD- STA. 18+52	D-24JB TO JBD11	E-3			50	70		
-RPD- STA. 12+00		E-3		205				
JBD3 TO JBD4	JBD3 TO JBD4	E-3			145	165		
-Y1- STA. 23+48		E-3		120				
-RPA- STA. 16+28		E-3		75				
-RPC- STA. 13+75		E-2		240				
JBD12 TO HM D-4JB		E-3		145				
-RPB- STA. 19+10		E-3		75				
CS"D" TOTALS				860	390	470		

LIGHT STANDARDS - TABLE D		
SHEET	LABEL	LOCATION AND OFFSET
E-3	D-1-1	-Y1- STA. 23+48 75' RT
E-3	D-2-2	-RPB- STA. 17+18 70' RT
E-3	D-3-2	-Y1- STA. 27+30 75' RT
E-3	D-4-4	SEE PLANS AND REFER TO DELTA NOTE E3.
E-3	D-5-5	-RPD- STA. 15+35 44' RT
E-2	D-6-3	REFER TO PLANS, 280 FROM SA D-8
E-2	D-7-3	REFER TO PLANS, 280' FROM SA D-9
E-2	D-8-3	-RPC- STA. 11+00
E-2	D-9-3	-RPB- STA. 10+90
E-2	D-10-3	-RPC-STA. 13+80
E-2	D-11-3	-RPB- STA. 13+70
E-3	D-12-3	-RPC- STA. 17+05
E-3	D-13-3	-RPC- STA. 20+30
E-3	D-14-4	-Y1- STA. 30+74
E-3	D-15-4	-Y1- STA. 33+65
E-3	D-16-5	-RPD- STA. 12+00
E-3	D-17-5	REFER TO PLANS, DIRECTLY ACROSS FROM SA D-16
E-3	D-18-5	REFER TO PLANS, 280' FROM SA D-16
E-3	D-19-5	REFER TO PLANS, 280' FROM SA D-17
E-3	D-20-5	REFER TO PLANS, 280' FROM SA D-18
E-3	D-21-5	REFER TO PLANS, 280' FROM SA D-19
E-3	D-22-1	-Y1- STA. 19+08
E-3	D-23-1	-RPA- STA. 13+42
E-3	D-24-5	-RPD- STA. 18+52

SEE SHEET "E-1" FOR
LEGEND & △ NOTES


COMPUTED BY: AB

CHECKED BY: RGH

DATE: 12/9/2024

DATE:

DOCUMENT NOT CONSIDERED FINAL
UNLESS ALL SIGNATURES COMPLETED

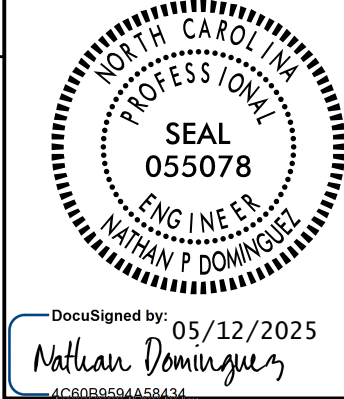

USE FOR LIGHTING CONSTRUCTION ONLY



PROJECT REFERENCE NO.	SHEET NO.
1-5880	E-2



DocuSigned by:
Nathan Dominick
4C80B5D4A58434

DOCUMENT NOT CONSIDERED FINAL
UNLESS ALL SIGNATURES COMPLETED

 SEE SHEET "E-1" FOR
LEGEND & △ NOTES

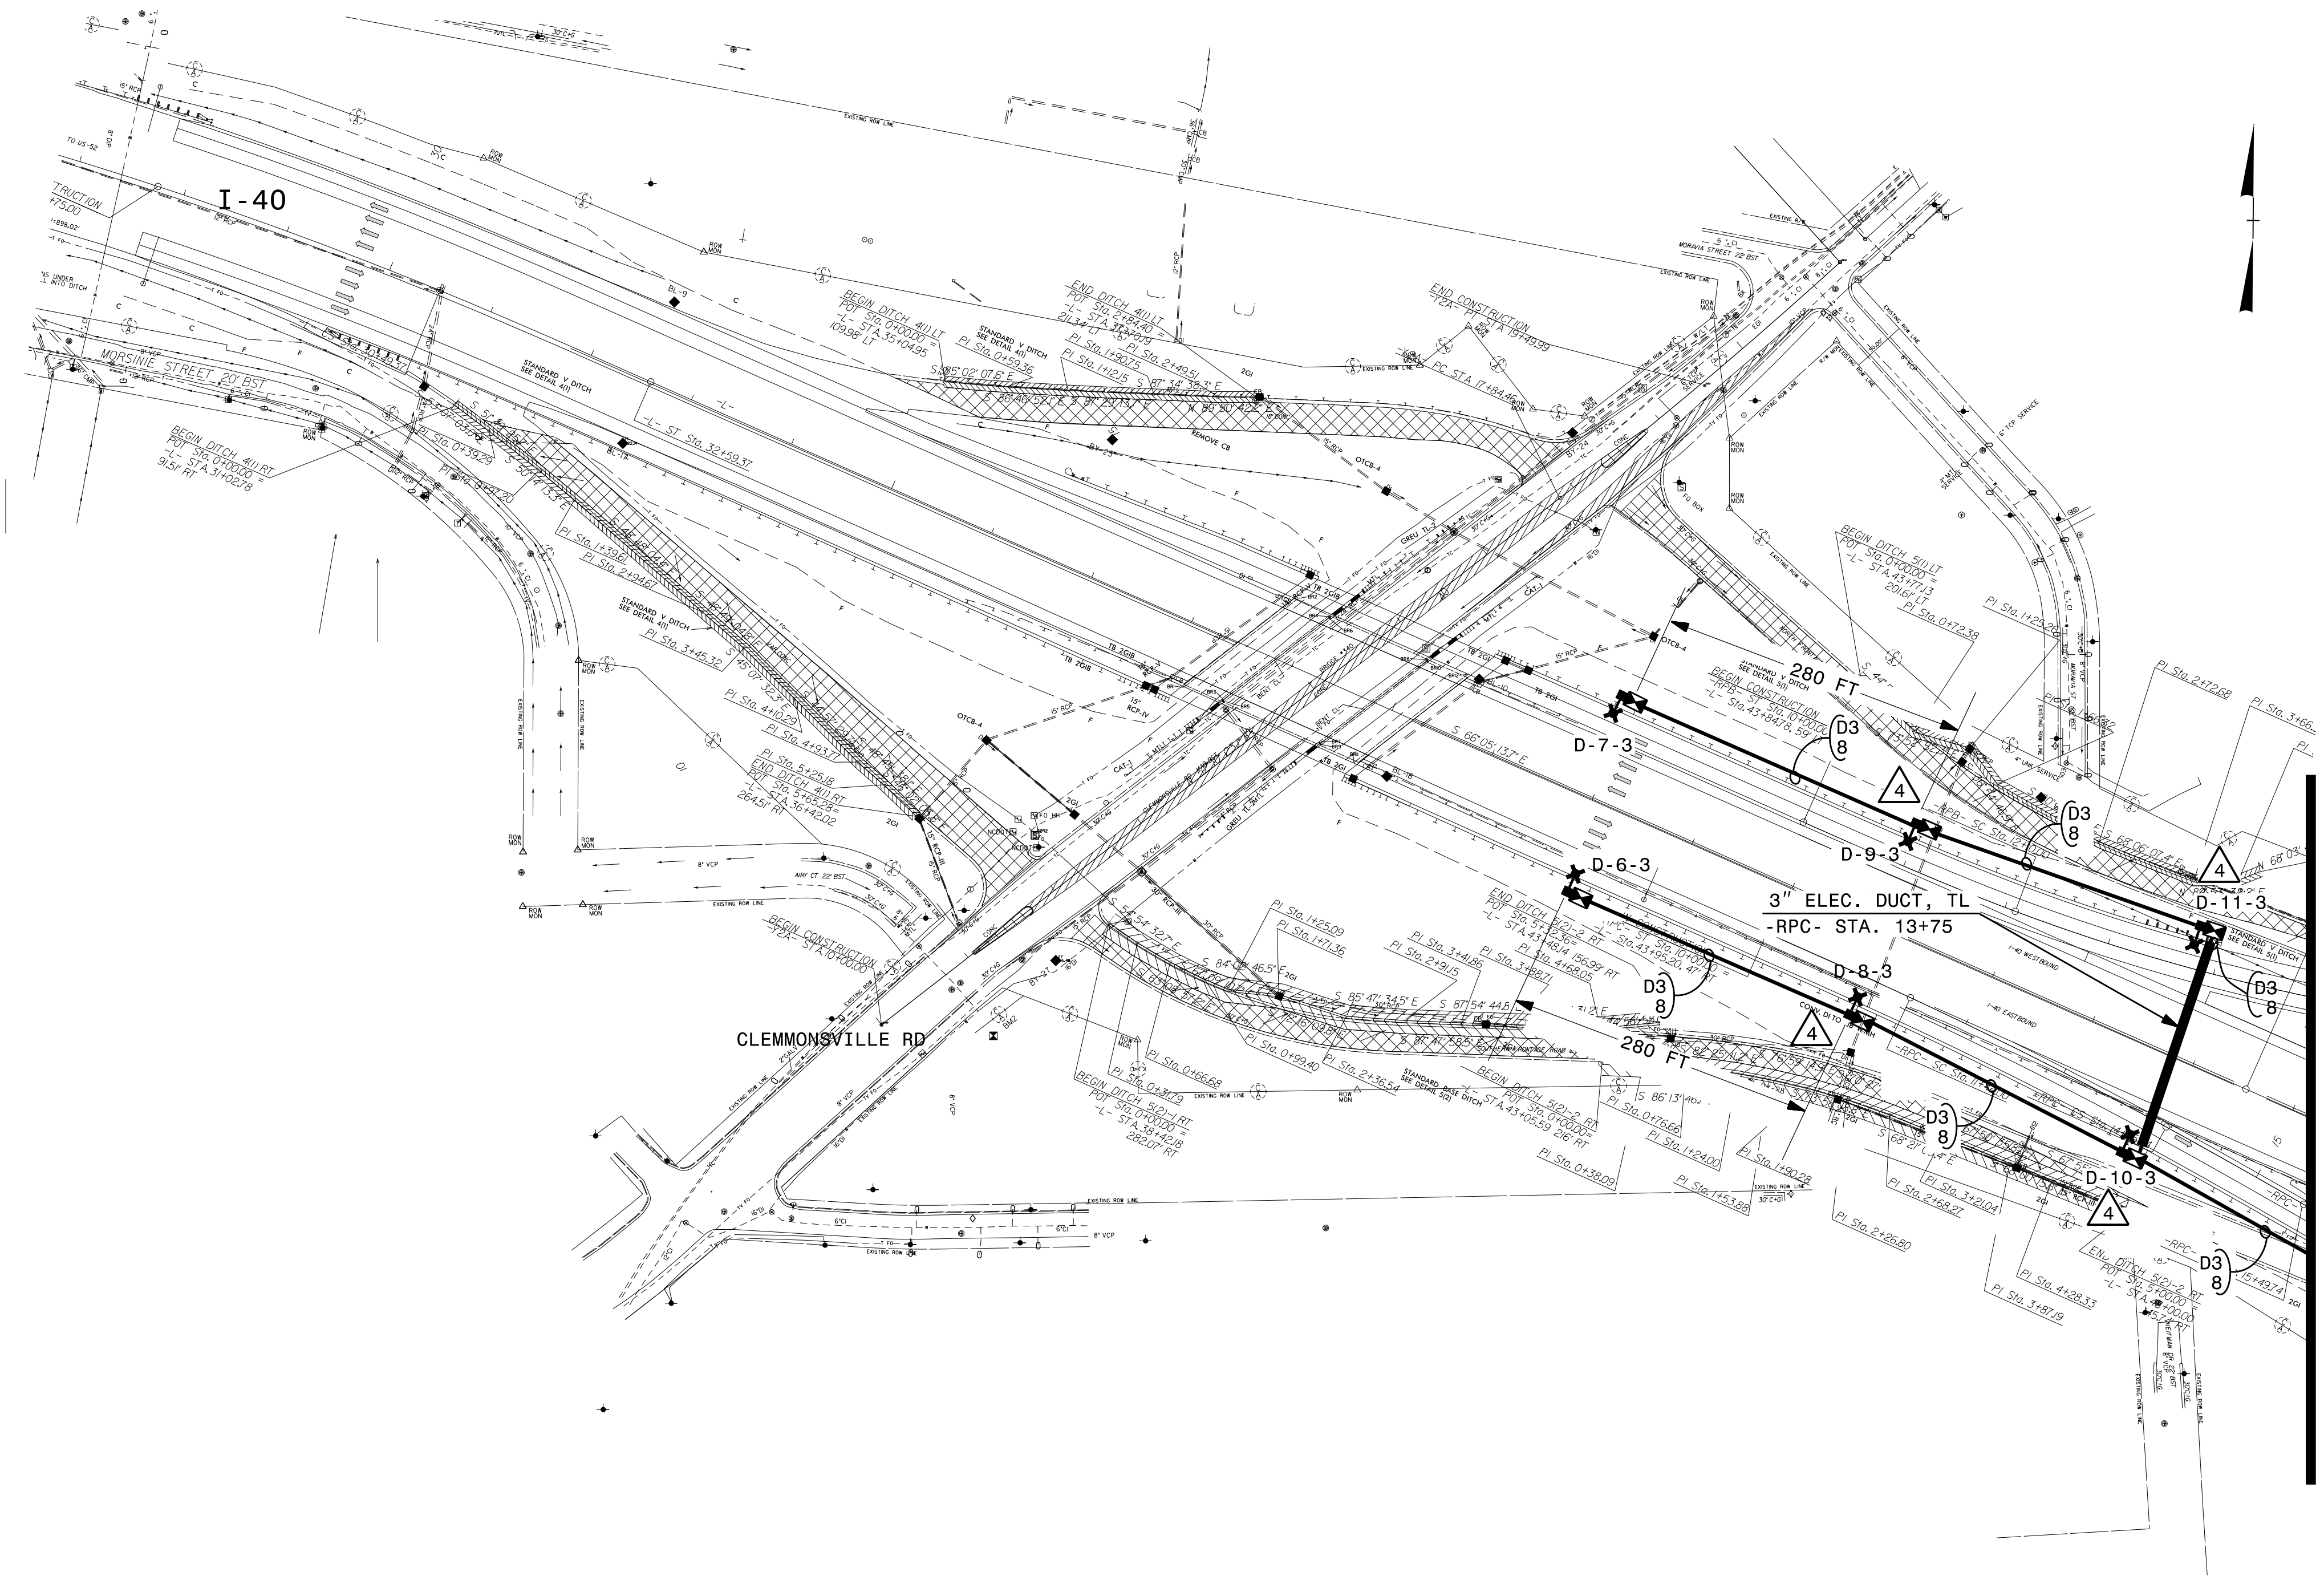

MATCHLINE WITH SHEET E-3 -RPC- STA. 15+86

2			
1			
Rev.	Date	Description	Approved
NORTH CAROLINA DEPARTMENT OF TRANSPORTATION ROADWAY DESIGN LIGHTING/ELECTRICAL SECTION			
LIGHTING LAYOUT I-40/THOMASVILLE RD INTERCHANGE			
FORSYTH COUNTY			
Drawn By: AB	Approved By: RGH	Dwg No.:	

I6-DEC-2024 09:22
R:\Lighting\Lighting Design\Files\15880.1&e.psh.e2.dgn
1abr-own1 RT RD-328855L


USE FOR LIGHTING CONSTRUCTION ONLY



DocuSigned by:
Nathan Dominguez
05/12/2025

DOCUMENT NOT CONSIDERED FINAL
UNLESS ALL SIGNATURES COMPLETED

SEE SHEET "E-1" FOR
LEGEND & △ NOTES

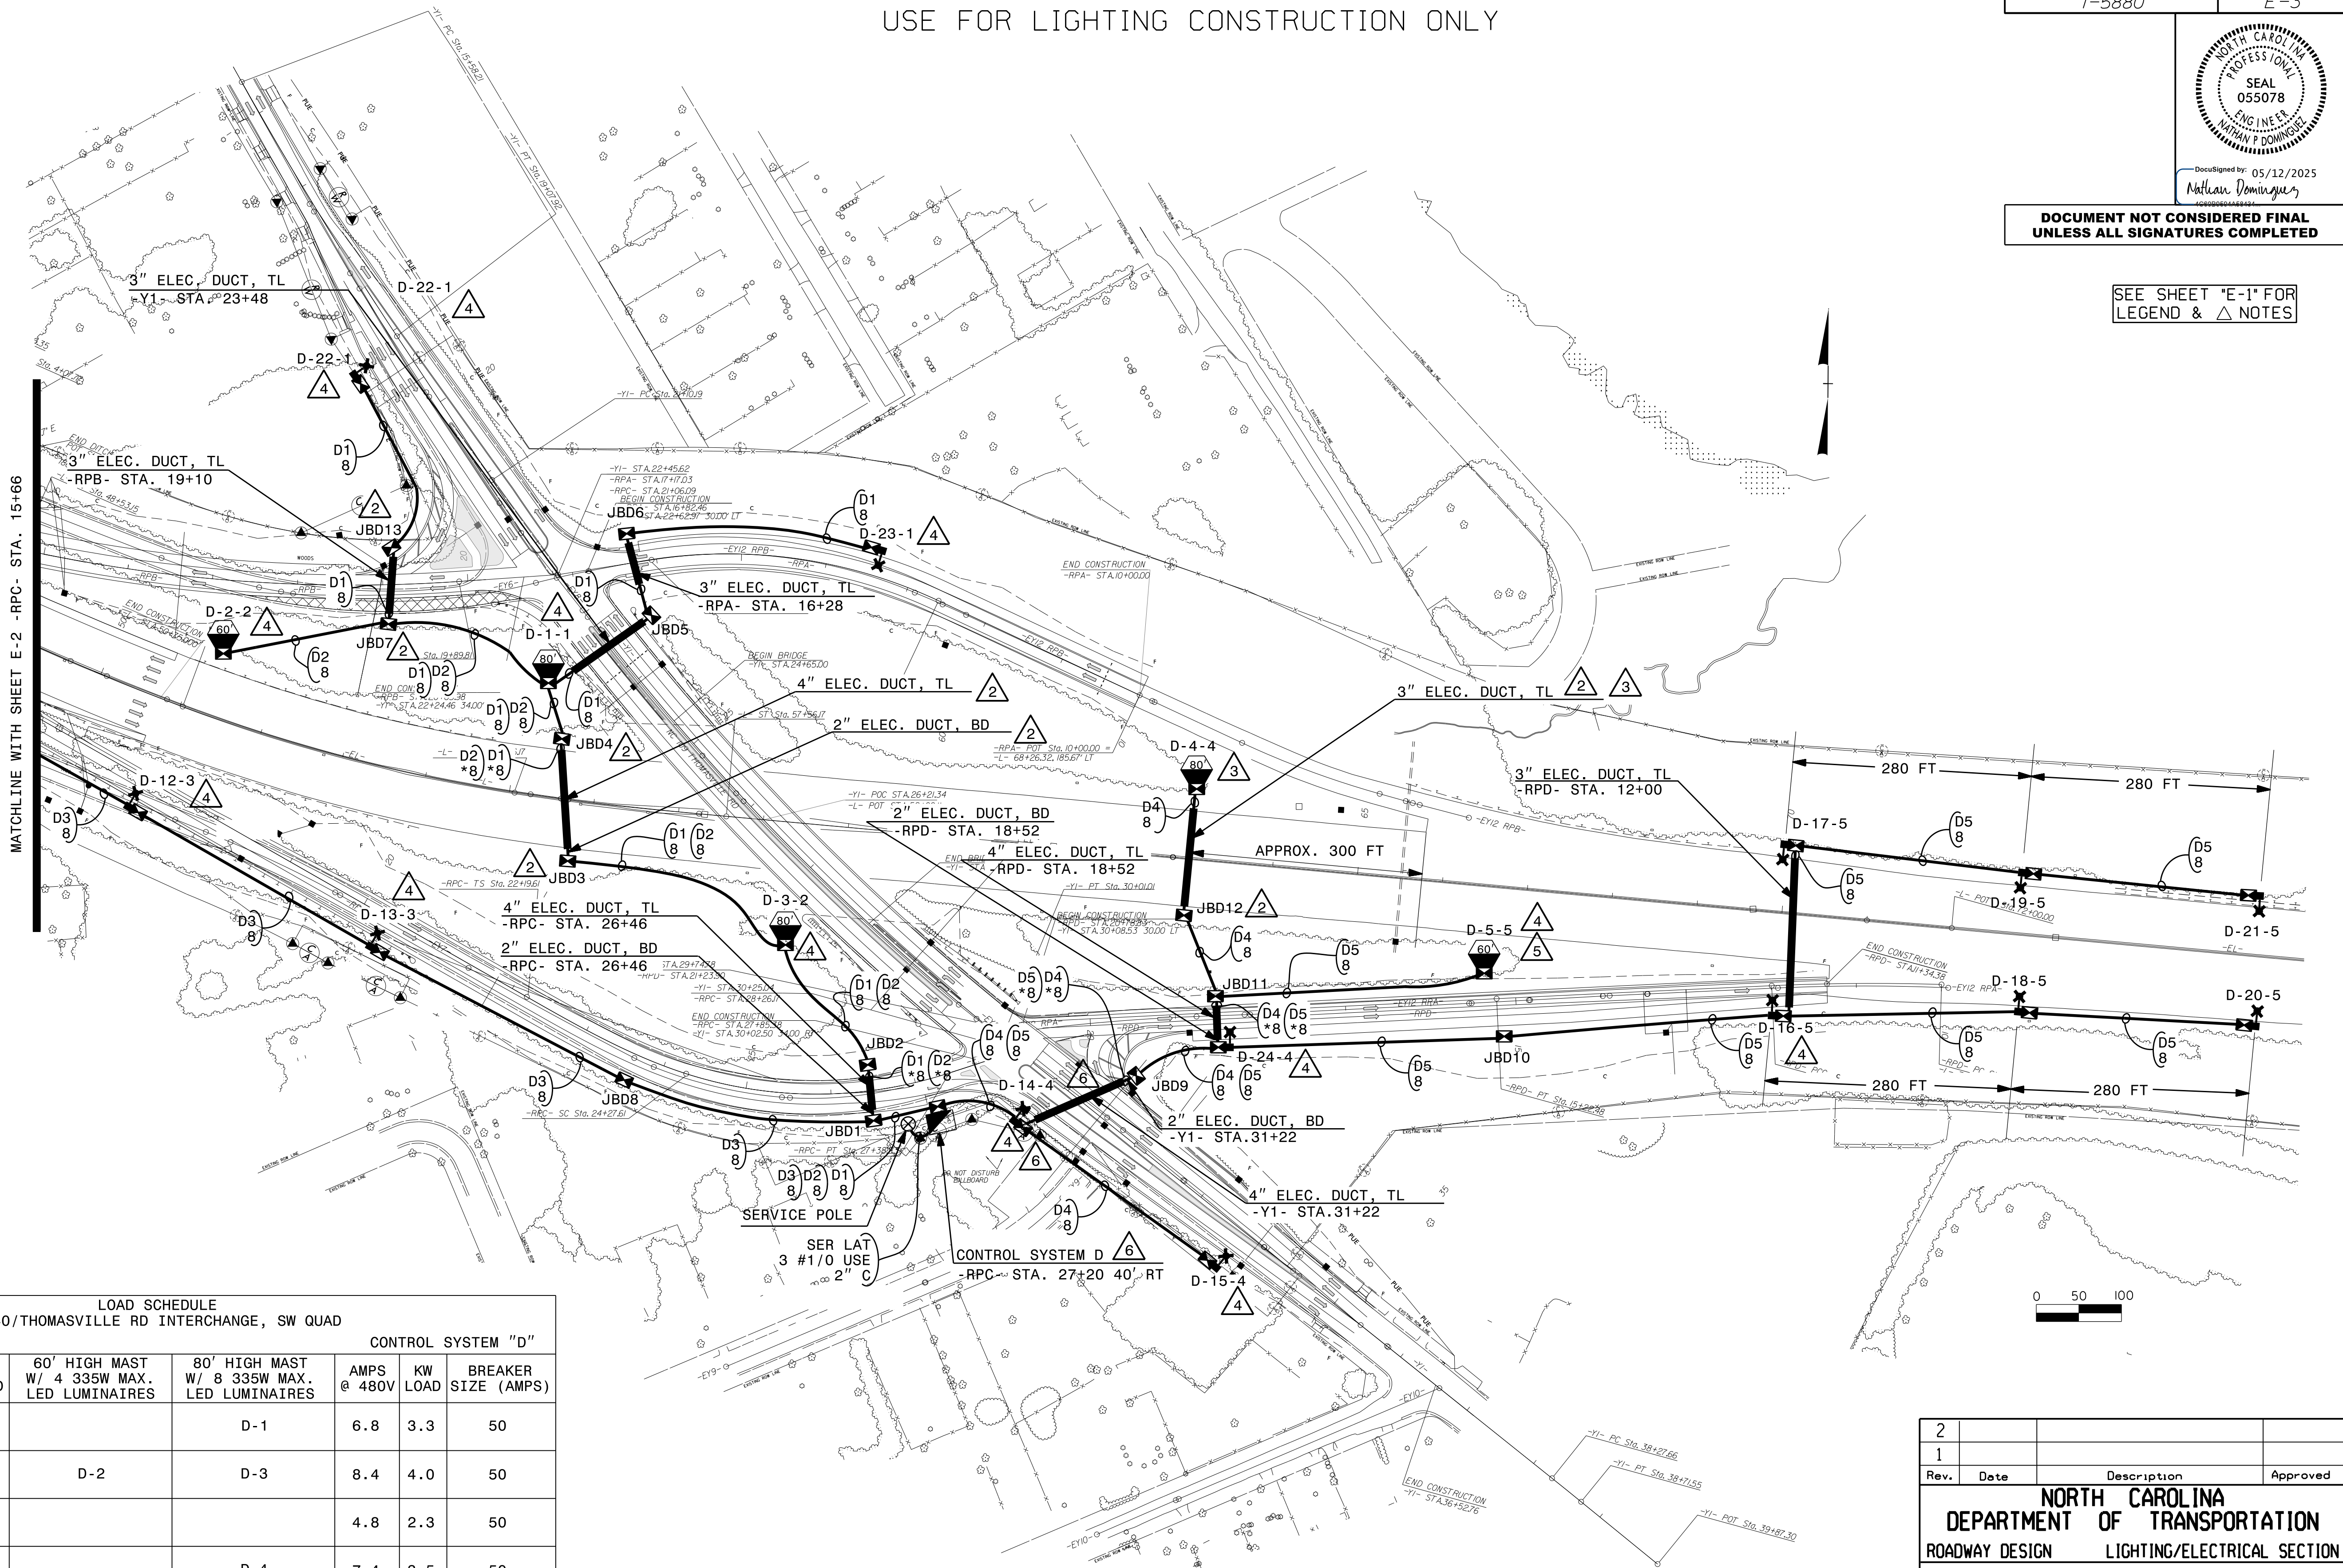

LOAD SCHEDULE I-40/THOMASVILLE RD INTERCHANGE, SW QUAD						
1Ø, 3W, 240/480 VAC						
CIRCUIT ID	SINGLE ARM 1 @ 285W MAX. LED	60' HIGH MAST W/ 4 335W MAX. LED LUMINAIRES	80' HIGH MAST W/ 8 335W MAX. LED LUMINAIRES	CONTROL SYSTEM "D"		
				AMPS @ 480V	KW LOAD	BREAKER SIZE (AMPS)
D1	D-22, D-23		D-1	6.8	3.3	50
D2		D-2	D-3	8.4	4.0	50
D3	D-6, D-7, D-8 D-9, D-10, D-11 D-12, D-13			4.8	2.3	50
D4	D-14, D-15 D-24		D-4	7.4	3.5	50
D5	D-16, D-17, D-18 D-19, D-20, D-21	D-5		6.4	3.1	50
SPARE						50
TOTAL	19 ON 19 POLES	8 ON 2 POLES	24 ON 3 POLES	33.8	16.2	

2			
1			
Rev.	Date	Description	Approved
NORTH CAROLINA DEPARTMENT OF TRANSPORTATION ROADWAY DESIGN LIGHTING/ELECTRICAL SECTION			
LIGHTING LAYOUT I - 40 / THOMASVILLE RD INTERCHANGE			
FORSYTH COUNTY			
Drawn By: AB		Approved By: RGH	Dwg No.:

I6-DEC-2024 09:27
R:\Lighting\Lighting Design\Lighting Files\I5880.1&e.psh.e3.dgn
labrown1 AT 60-328855L