

Project: U-5789



Contract: C205040

STATE OF NORTH CAROLINA
DIVISION OF HIGHWAYS


Project No.	Sheet No.
U-5789	Sig. A

Onslow County

LOCATION: NC 53 (WESTERN BOULEVARD) AT
GATEWAY SOUTH TO
NC 53 (WESTERN BOULEVARD) AT
SR 2714 (JACKSONVILLE PARKWAY)/GATEWAY NORTH
TYPE OF WORK: TRAFFIC SIGNALS AND SIGNAL COMMUNICATIONS

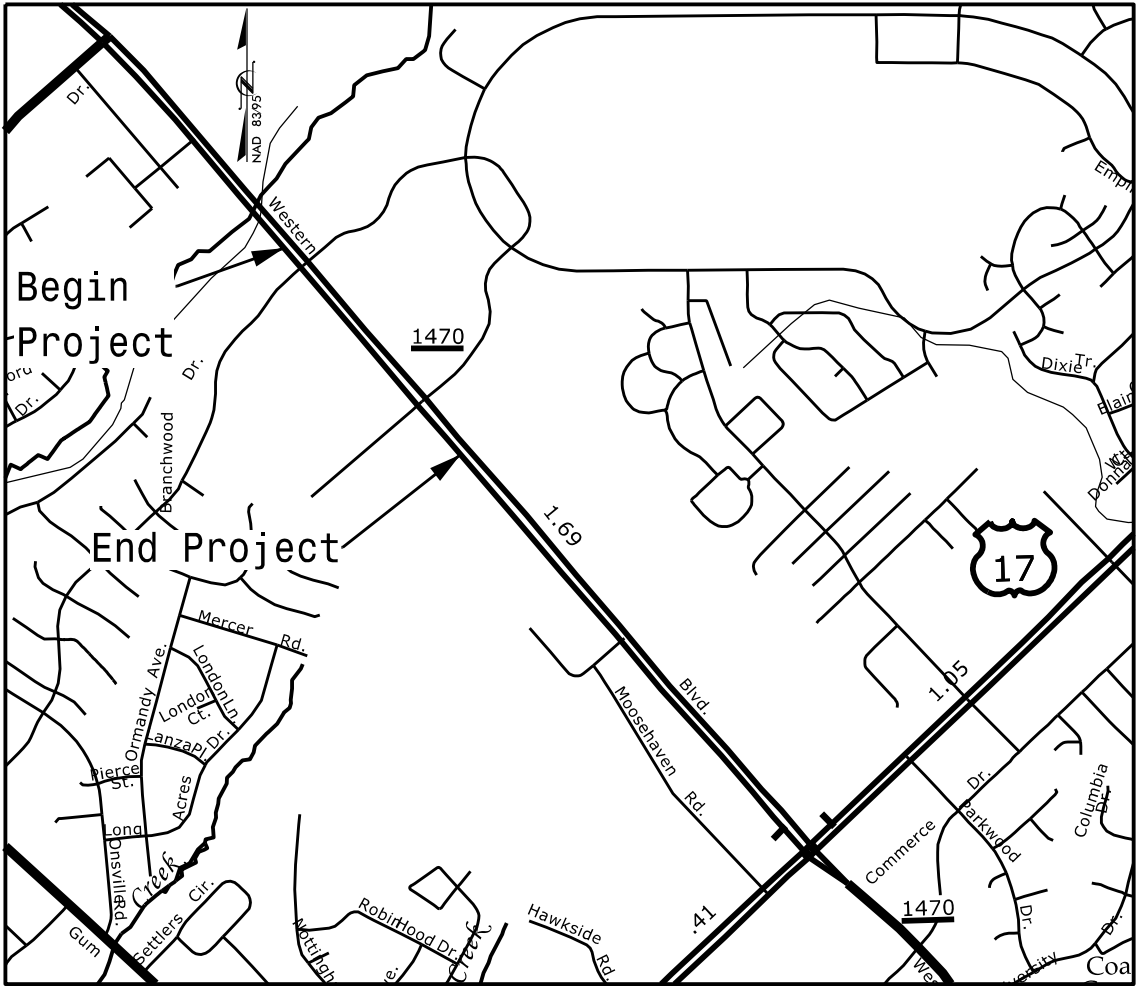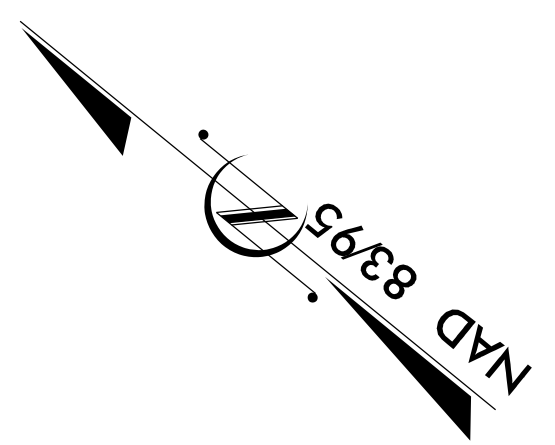

VICINITY MAP

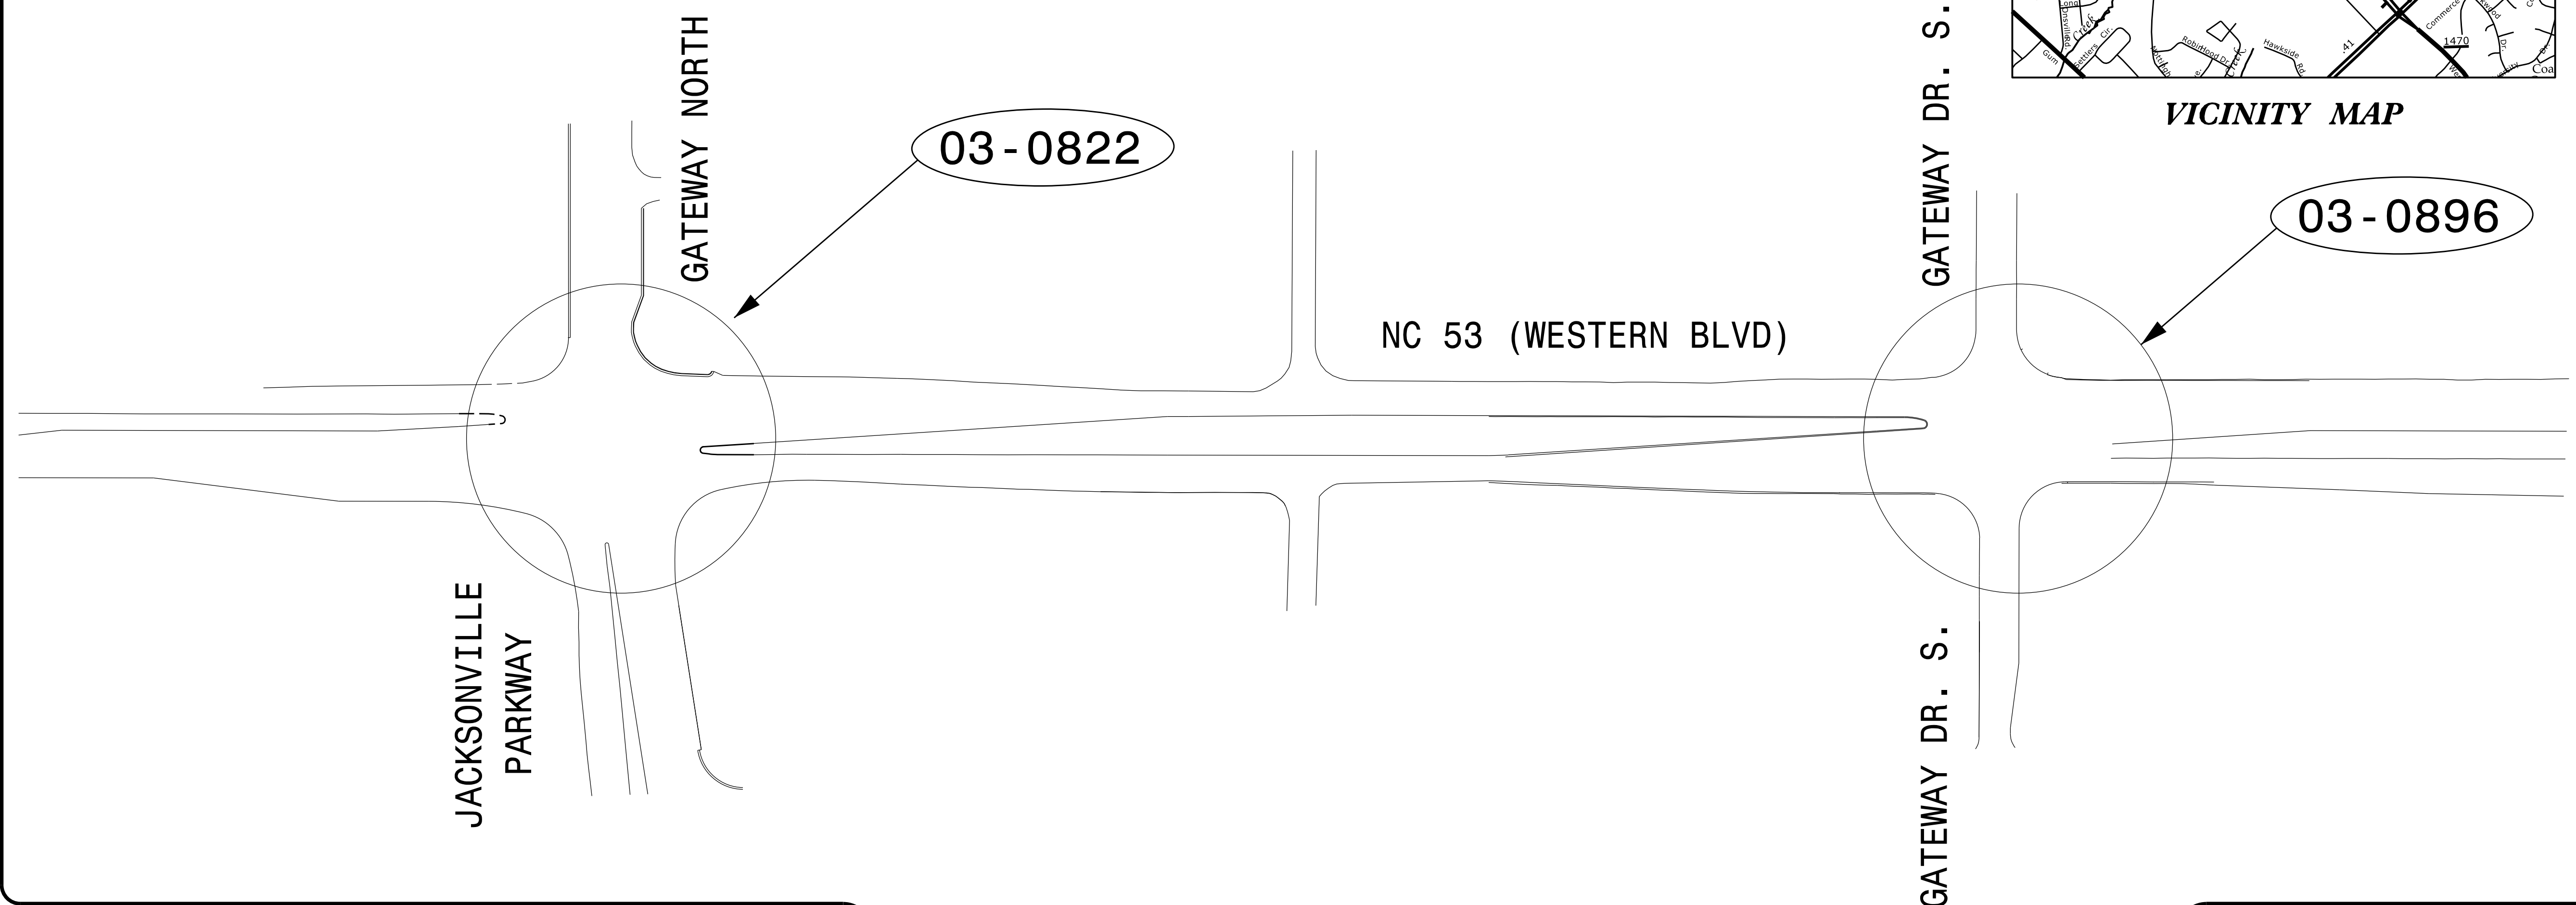

DAVENPORT

HOME OFFICE:
119 BROOKSTOWN AVENUE, SUITE PH1
WINSTON-SALEM, NC 27101
336.744.1636 www.davenportworld.com
NCBELS FIRM LICENSE NO. C-2522

03-XXXX Modified Signal

Refer to "Roadway Standard Drawings
NCDOT" dated January 2024 and
"Standard Specifications for Roads
and Structures" dated January 2024.

Index of Plans		
Sheet #	Reference #	Location/Description
Sig. A		
Sig. 1.0-2.7	03-0822	Title Sheet
Sig. 3.0 - 4.8	03-0896	NC 53 (Western Boulevard) at SR 2714 (Jacksonville Parkway)/Gateway North
SCP-1 - SCP-5	-----	NC 53 (Western Boulevard) at Gateway South
		Communications Plan

TRANSPORTATION SYSTEMS MANAGEMENT &
OPERATIONS UNIT

Zachary Little, PE - Eastern Region Signals Engineer

Sarah G. Kirkpatrick, PE - Signal Equipment Design Engineer

Gregory A. Green - Signal Communications Project Engineer

Prepared for:

DIVISION OF HIGHWAYS
TRANSPORTATION MOBILITY AND SAFETY
DIVISION

750 N. Greenfield Parkway, Garner, NC 27529
Telephone: (919) 773-2800