


INPUT PAGE 2 ASSIGNMENT PROGRAMMING DETAIL FOR ALTERNATE PHASING - LOOP 5A

PROJECT REFERENCE NO.	SHEET NO.
U-5789	Sig. 4.5

(program controller as shown below)

- NOTES: 1. THIS PROGRAMMING APPLIES FOR INPUT PAGE 2 ONLY. INPUT PAGE 1 WILL USE STANDARD DEFAULT SETTINGS. THIS PROGRAMMING IS NECESSARY FOR PROPER DETECTOR OPERATION DURING ALTERNATE PHASING OPERATION.
2. THE FIRST TASK THIS PROGRAMMING ACCOMPLISHES IS THE DISABLING OF INPUT #9 (DETECTOR 22) SO THAT A VEHICLE CALL WILL NOT BE PLACED TO PHASE 2 DURING ALTERNATE PHASING OPERATION. THE SECOND TASK THIS PROGRAMMING ACCOMPLISHES IS THAT IT REASSIGNS DETECTOR 55 TO INPUT #17 SO THAT THE DELAY ON LOOP 5A CAN BE REDUCED FROM 15 SECONDS TO 0 SECONDS.


FROM MAIN MENU PRESS '5' (INPUTS). THEN PRESS 'NEXT' TO GET TO INPUT PAGE '2'. PRESS THE '+' KEY UNTIL INPUT 9 IS REACHED.

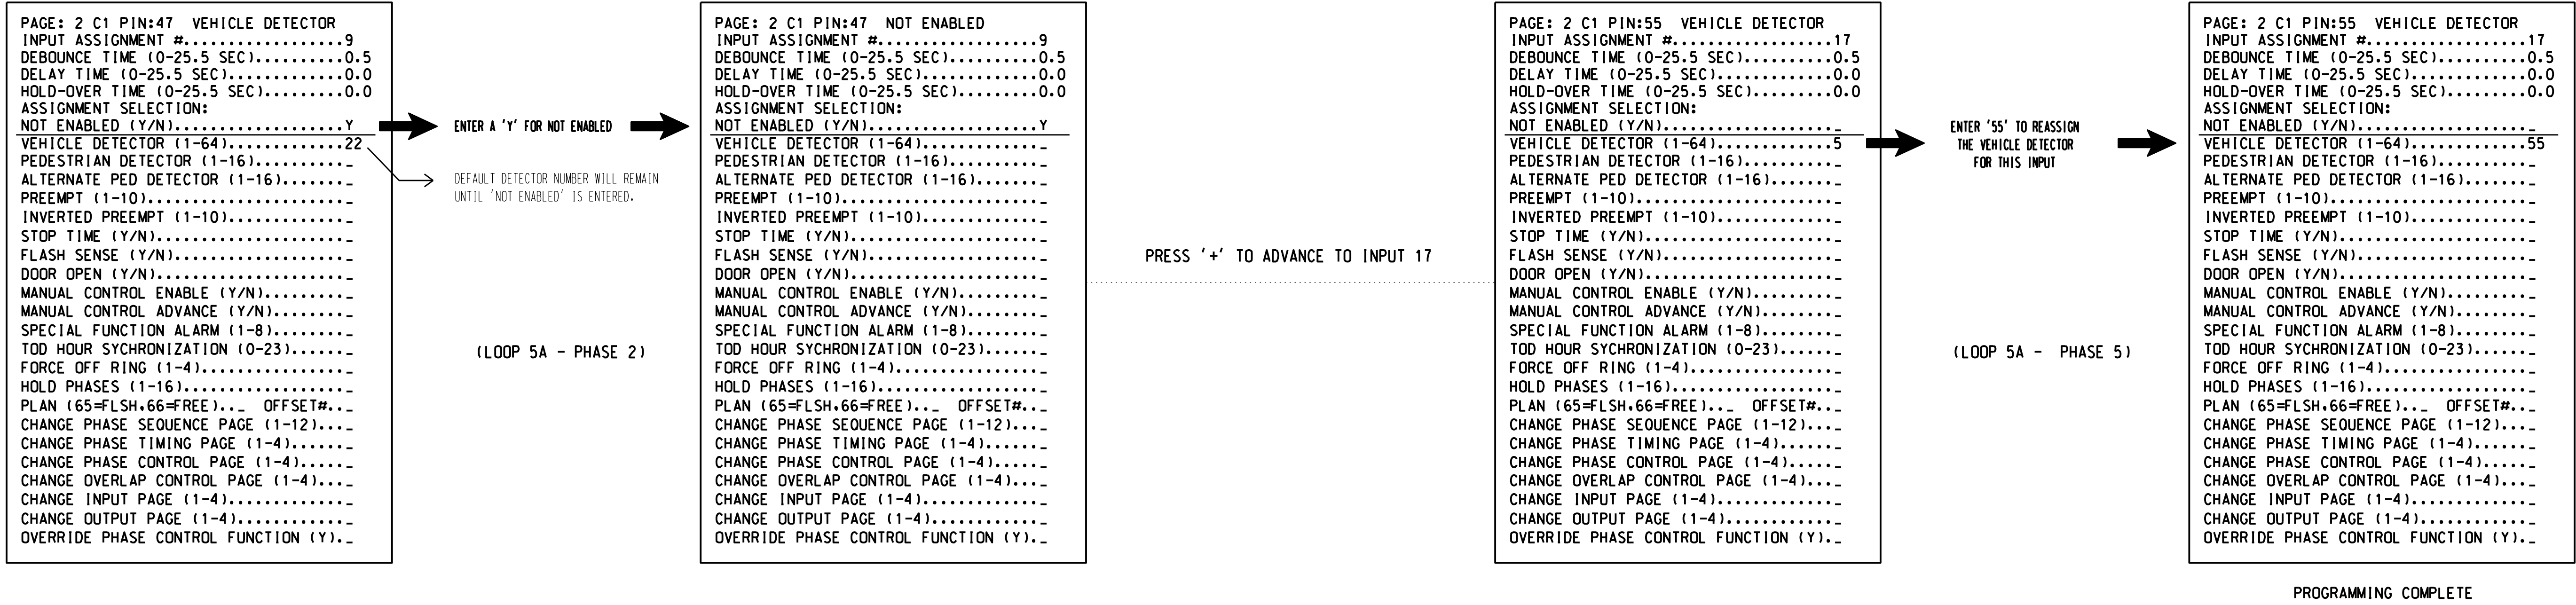

SPECIAL DETECTOR PROGRAMMING DETAIL - LOOP 5A (ALT.)

(program controller as shown below)

FROM MAIN MENU PRESS '7' (DETECTORS). THEN PRESS '1' FOR VEHICLE DETECTORS. PRESS THE '-' KEY TO GET TO VEHICLE DETECTOR #55.

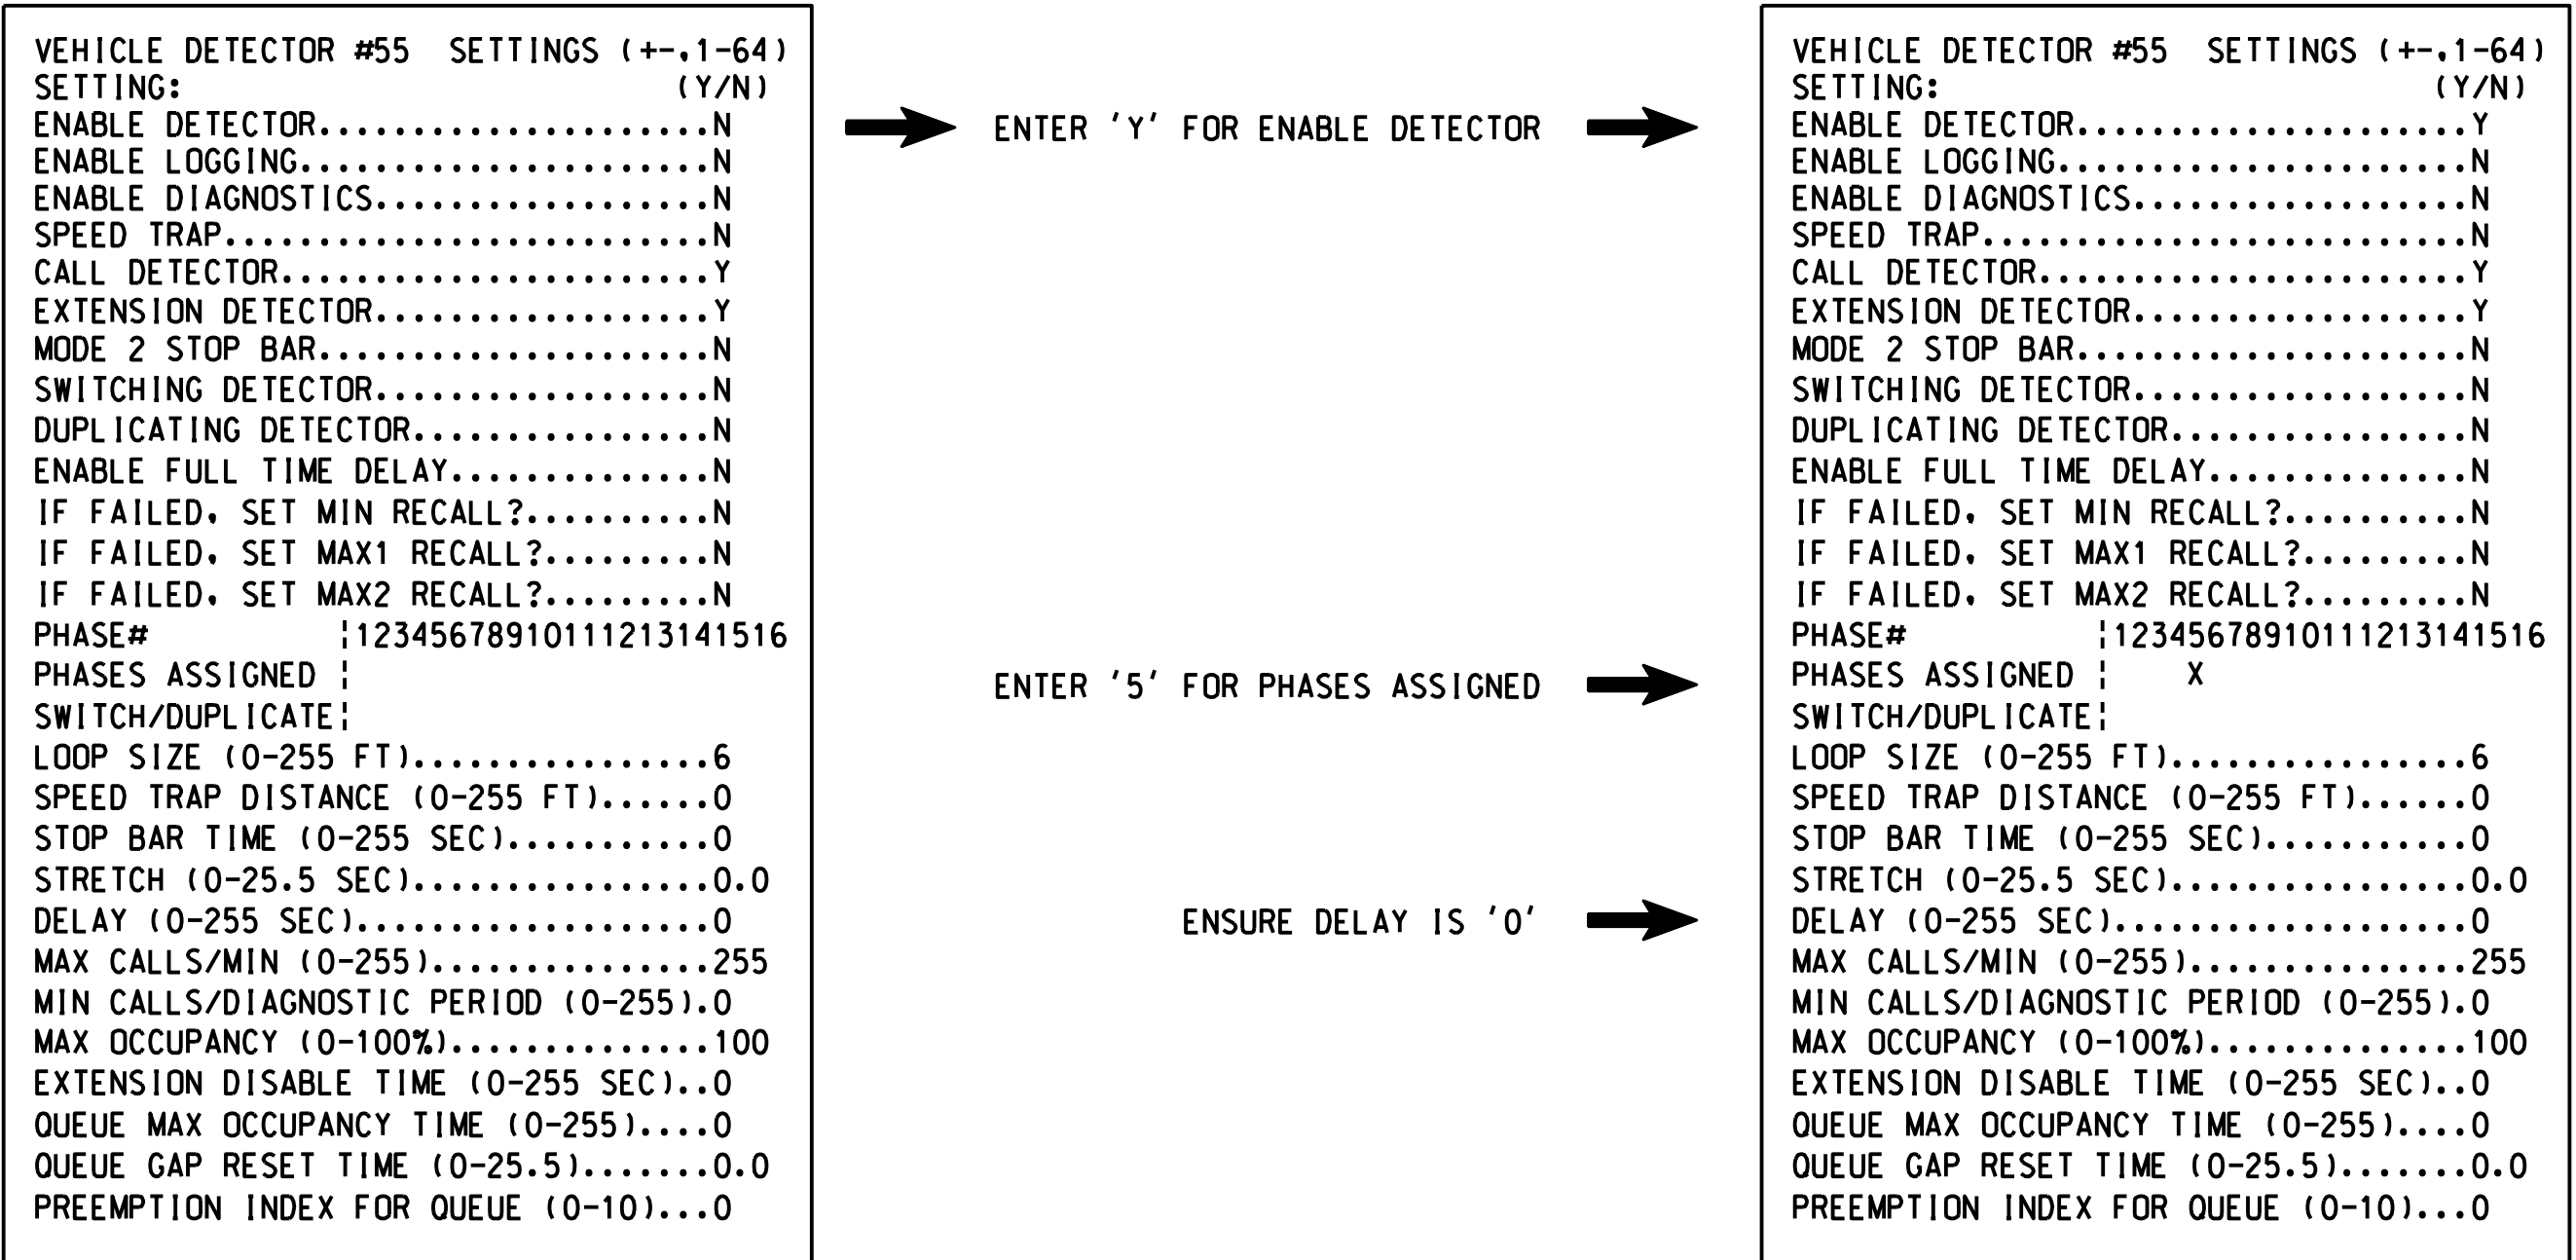

NOTE: DETECTOR IS PROGRAMMED PER THE INPUT FILE CONNECTION AND PROGRAMMING CHART SHOWN ON SHEET 1.

DETECTOR PROGRAMMING COMPLETE

Project #: 230907

DAVENPORT

HOME OFFICE:
119 BROOKSTOWN AVE, SUITE PH1
WINSTON-SALEM, NC 27101
336.744.1636 www.davenportnc.com
NCBELS FIRM LICENSE NO. C-2522


THIS ELECTRICAL DETAIL IS FOR THE SIGNAL DESIGN: 03-0896

DESIGNED: May 2025

SEALED: 7/2/2025

REVISED: N/A

Electrical Details
Final Design - Sheet 4 of 7

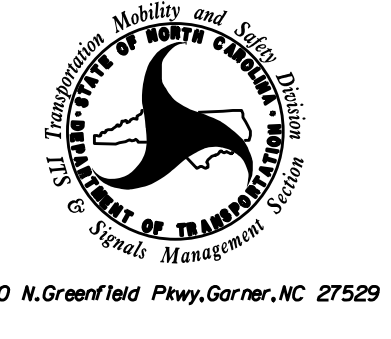ELECTRICAL AND PROGRAMMING DETAILS FOR:	NC 53 (Western Boulevard) at Gateway South	DOCUMENT NOT CONSIDERED FINAL UNLESS ALL SIGNATURES COMPLETED	
		SEAL	
	Division 3 Onslow County Jacksonville	7/2/2025	
	PLAN DATE: May 2025	REVIEWED BY: D. Bennett	SIGNATURE DATE
PREPARED BY: B. Dowell	REVIEWED BY:	SIC. INVENTORY NO. 03-0896	
REVISIONS		INIT.	DATE
.....			
.....			
.....			