


PROJECT: U-4700CC

CONTRACT:


Vicinity Map

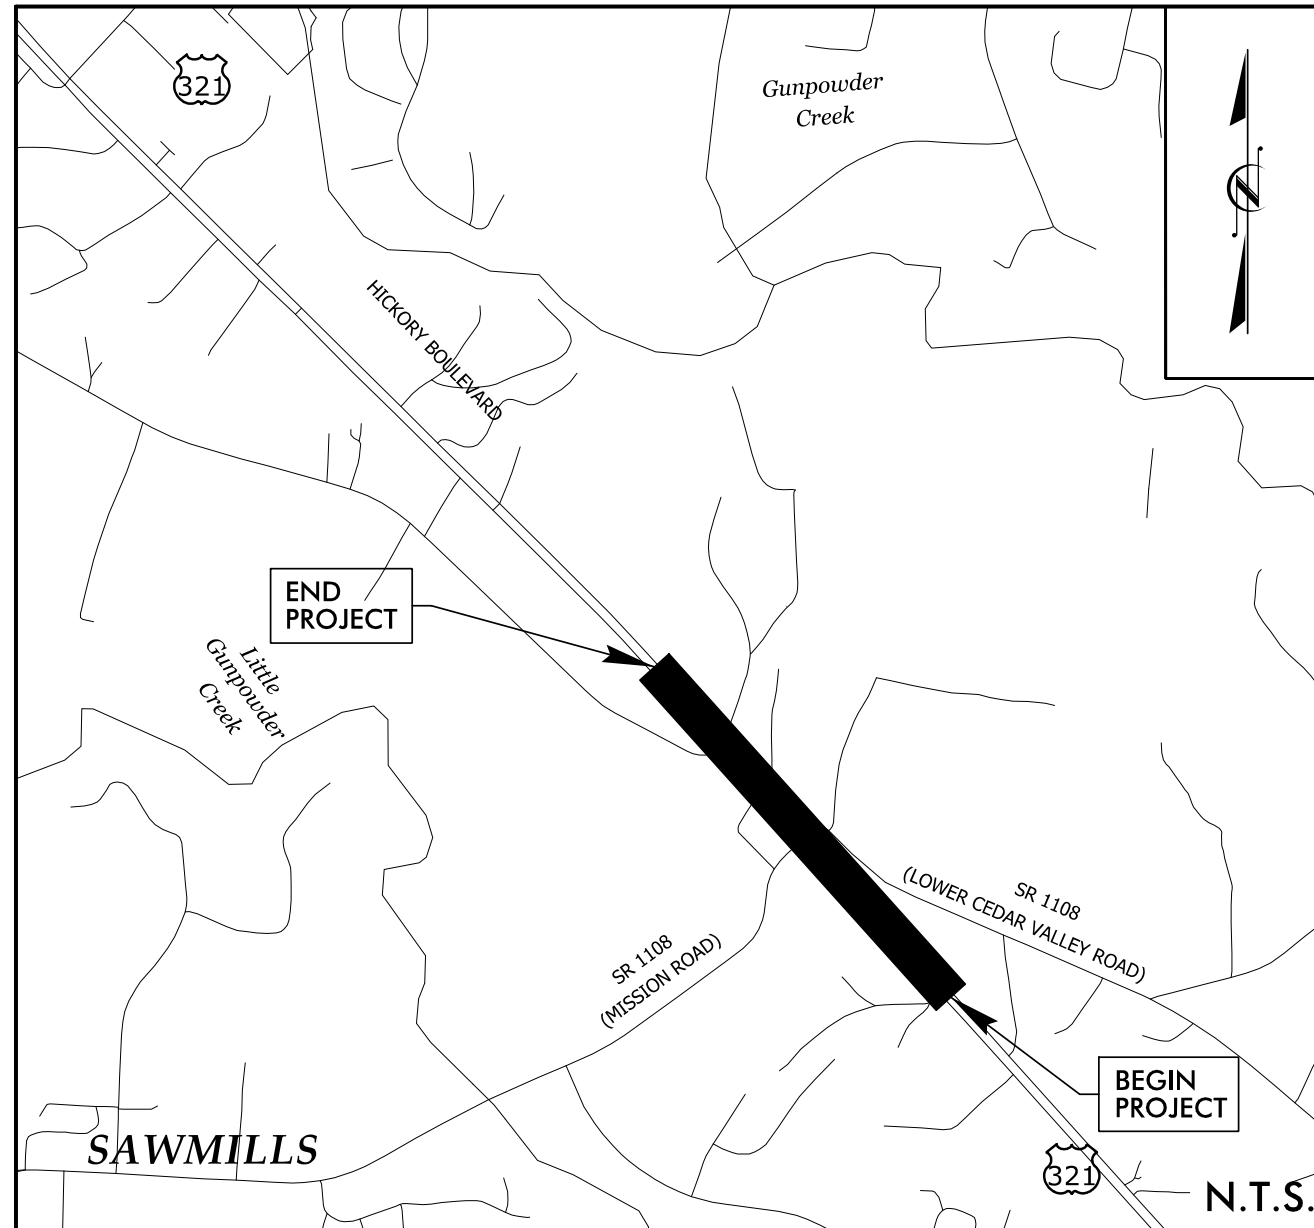

STATE OF NORTH CAROLINA  
DIVISION OF HIGHWAYS

CALDWELL COUNTY

LOCATION: INTERSECTION OF US 321 (HICKORY BOULEVARD) AND  
SR 1108 (MISSION ROAD) /(LOWER CEDAR VALLEY ROAD)  
TYPE OF WORK: TRAFFIC SIGNALS AND TRAFFIC SIGNAL COMMUNICATIONS

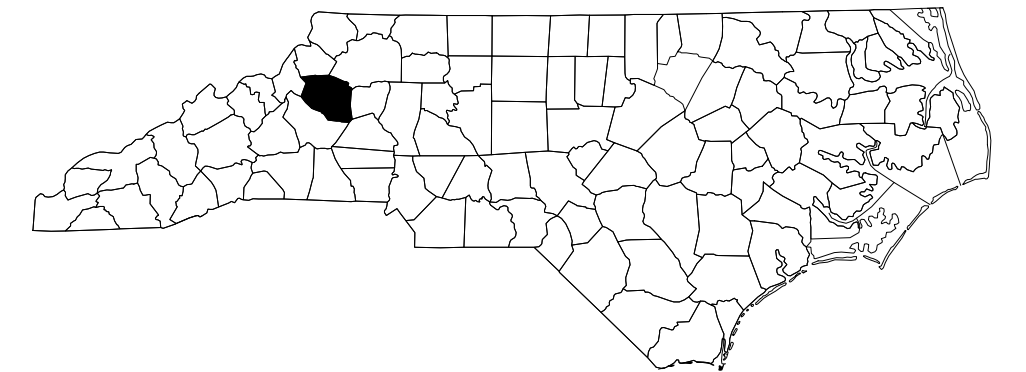

Project No.



U-4700CC

Sheet No.

Sig. 1.0

★ PROPOSED SIGNAL

XX-XXXX SIGNAL ID NUMBER

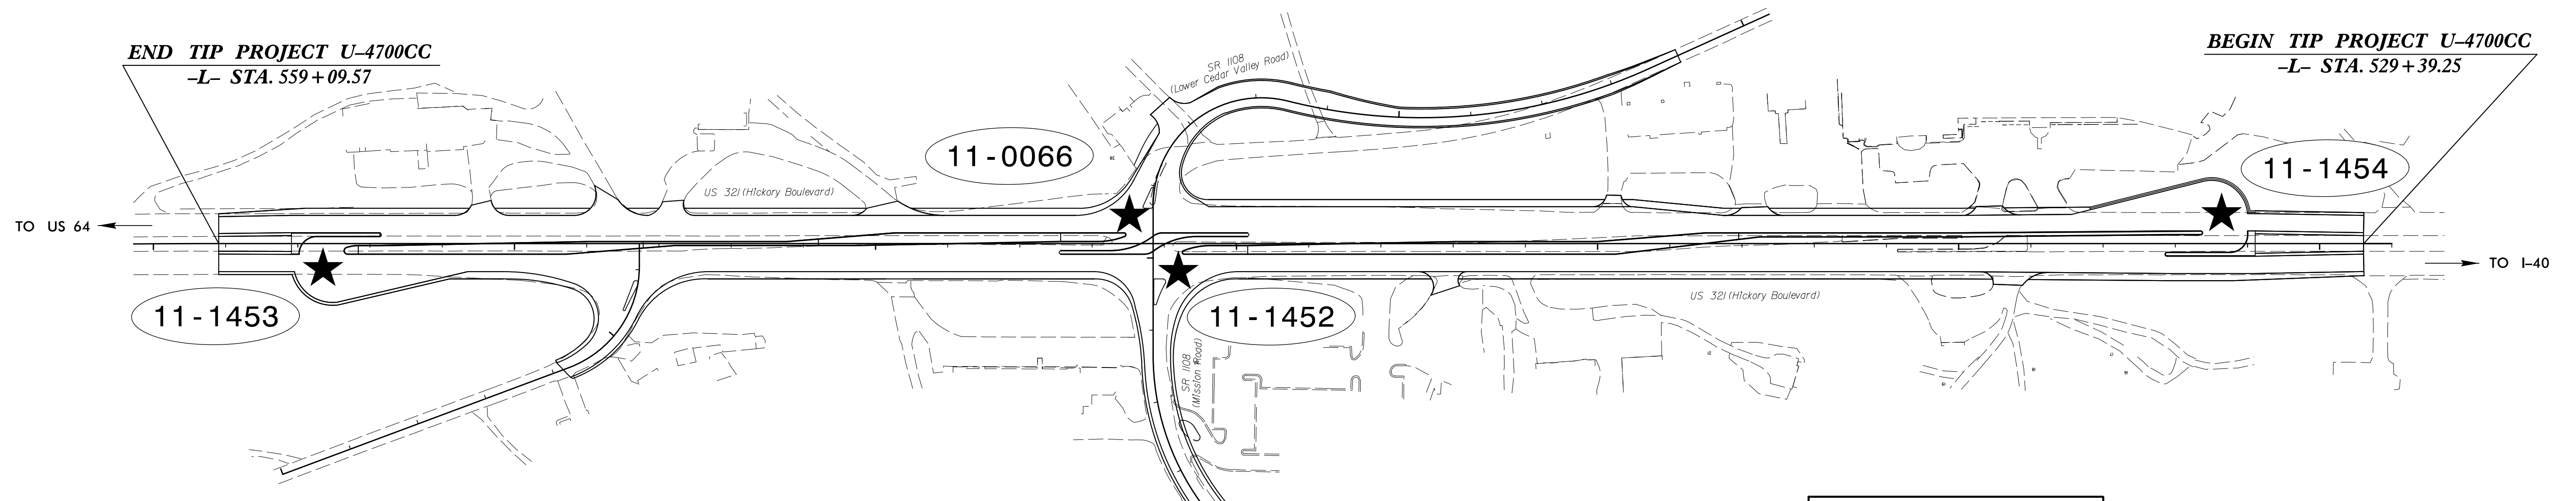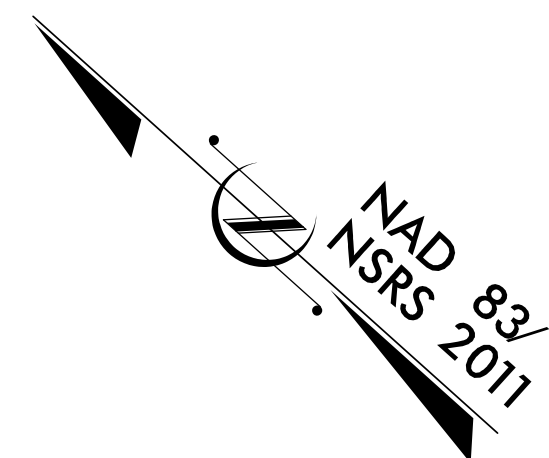

stv

STV Engineers, Inc.  
900 West Trade St., Suite 715  
Charlotte, NC 28202  
(704) 372-1885  
NC License Number F-0991

Refer to "Roadway Standard Drawings  
NCDOT" dated January 2024 and  
"Standard Specifications for Roads  
and Structures" dated January 2024.

Index of Plans		
Sheet #	Reference #	Location/Description
Sig. 1.0	-----	Project Title Sheet
Sig. 2.0-2.4	11-1453	US 321 (Hickory Boulevard) SB at U-Turn North of SR 1108 (Mission-Lower Cedar Valley Road)
Sig. 3.0-5.4	11-0066	US 321 (Hickory Boulevard) NB at SR 1108 (Mission-Lower Cedar Valley Road)
Sig. 6.0-7.4	11-1452	US 321 (Hickory Boulevard) SB at SR 1108 (Mission-Lower Cedar Valley Road)
Sig. 8.0-8.2	11-1454	US 321 (Hickory Boulevard) NB at U-Turn South of SR 1108 (Mission-Lower Cedar Valley Road)
Sig. M1-M9	N/A	2024 Standard Metal Pole Sheets
SCP-1	Sig. Comm.	Signal Communication Plans

NCDOT TRANSPORTATION SYSTEMS  
MANAGEMENT & OPERATIONS UNIT

Contacts:


R. Nicholas Zinser, P.E. – Western Region Signals Engineer  
Keith M. Mims, P.E. – State Signal Equipment Engineer  
Gregory A. Green – Signal Communications Project Engineer

STV, Inc.

Contacts:

Trent M. Moody, P.E. – Senior Associate Engineering Director  
Donald J. Darity, P.E. – Senior Traffic Signal Manager

Prepared for the Offices of:  
DIVISION OF HIGHWAYS  
TRANSPORTATION MOBILITY AND SAFETY  
DIVISION

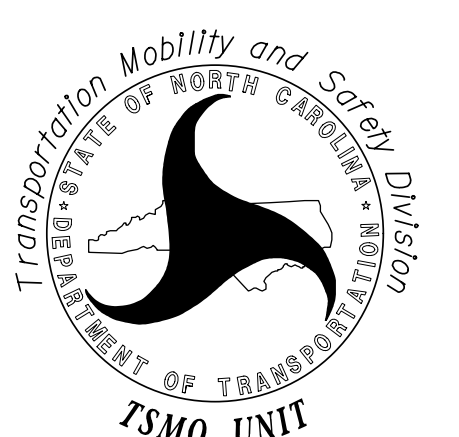

750 N. Greenfield Parkway, Garner, NC 27529