

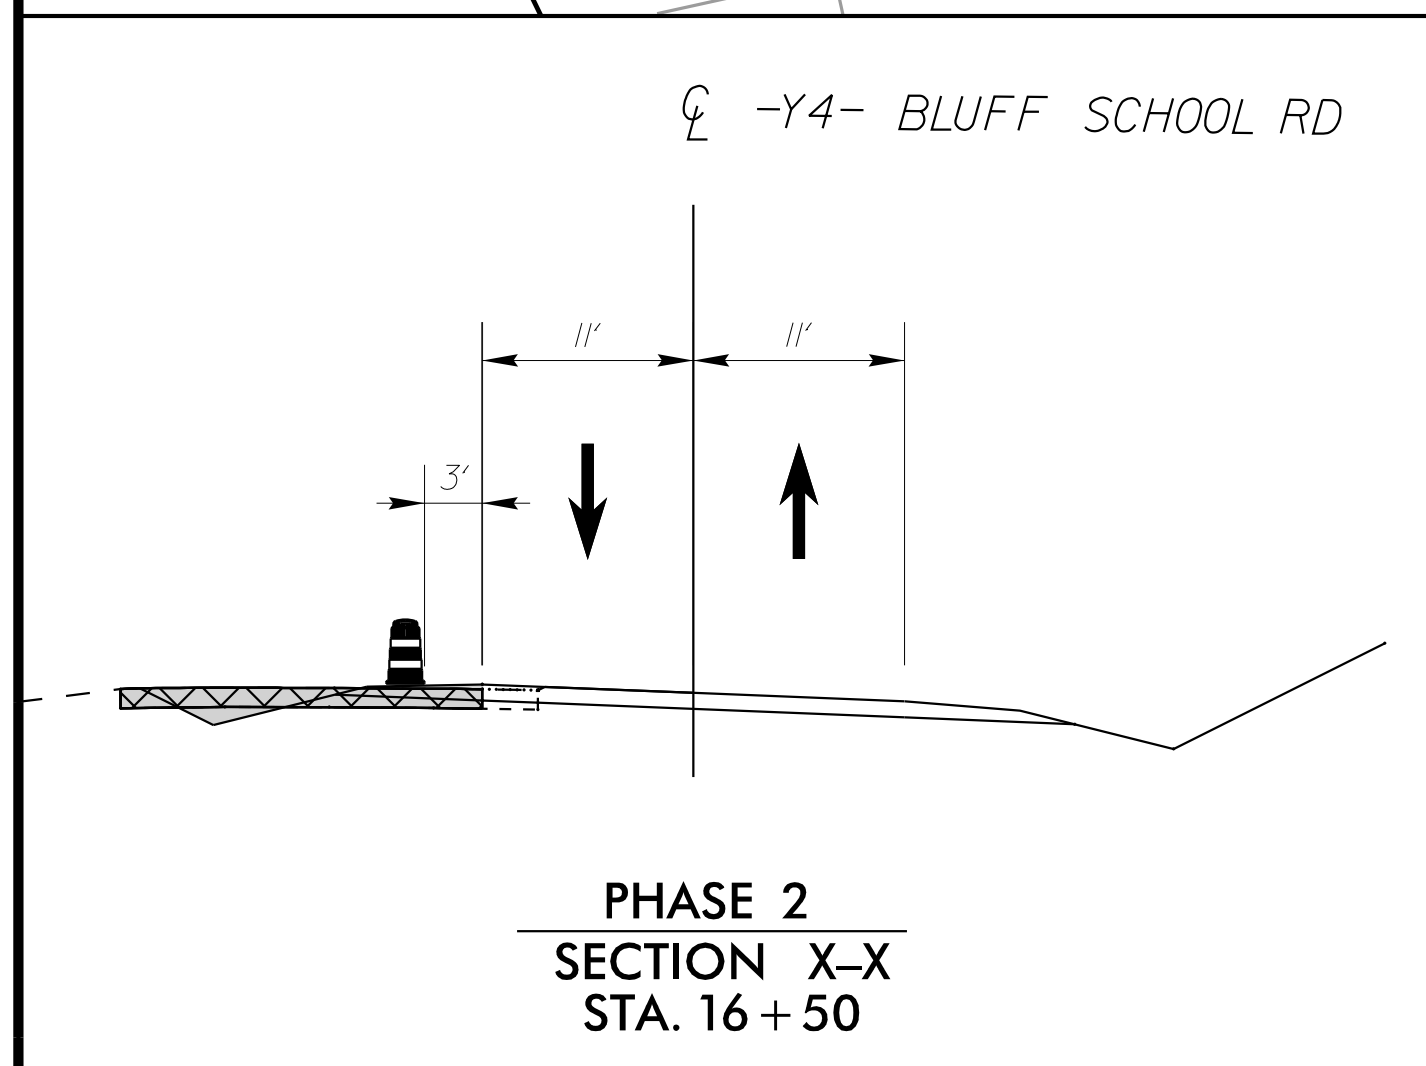
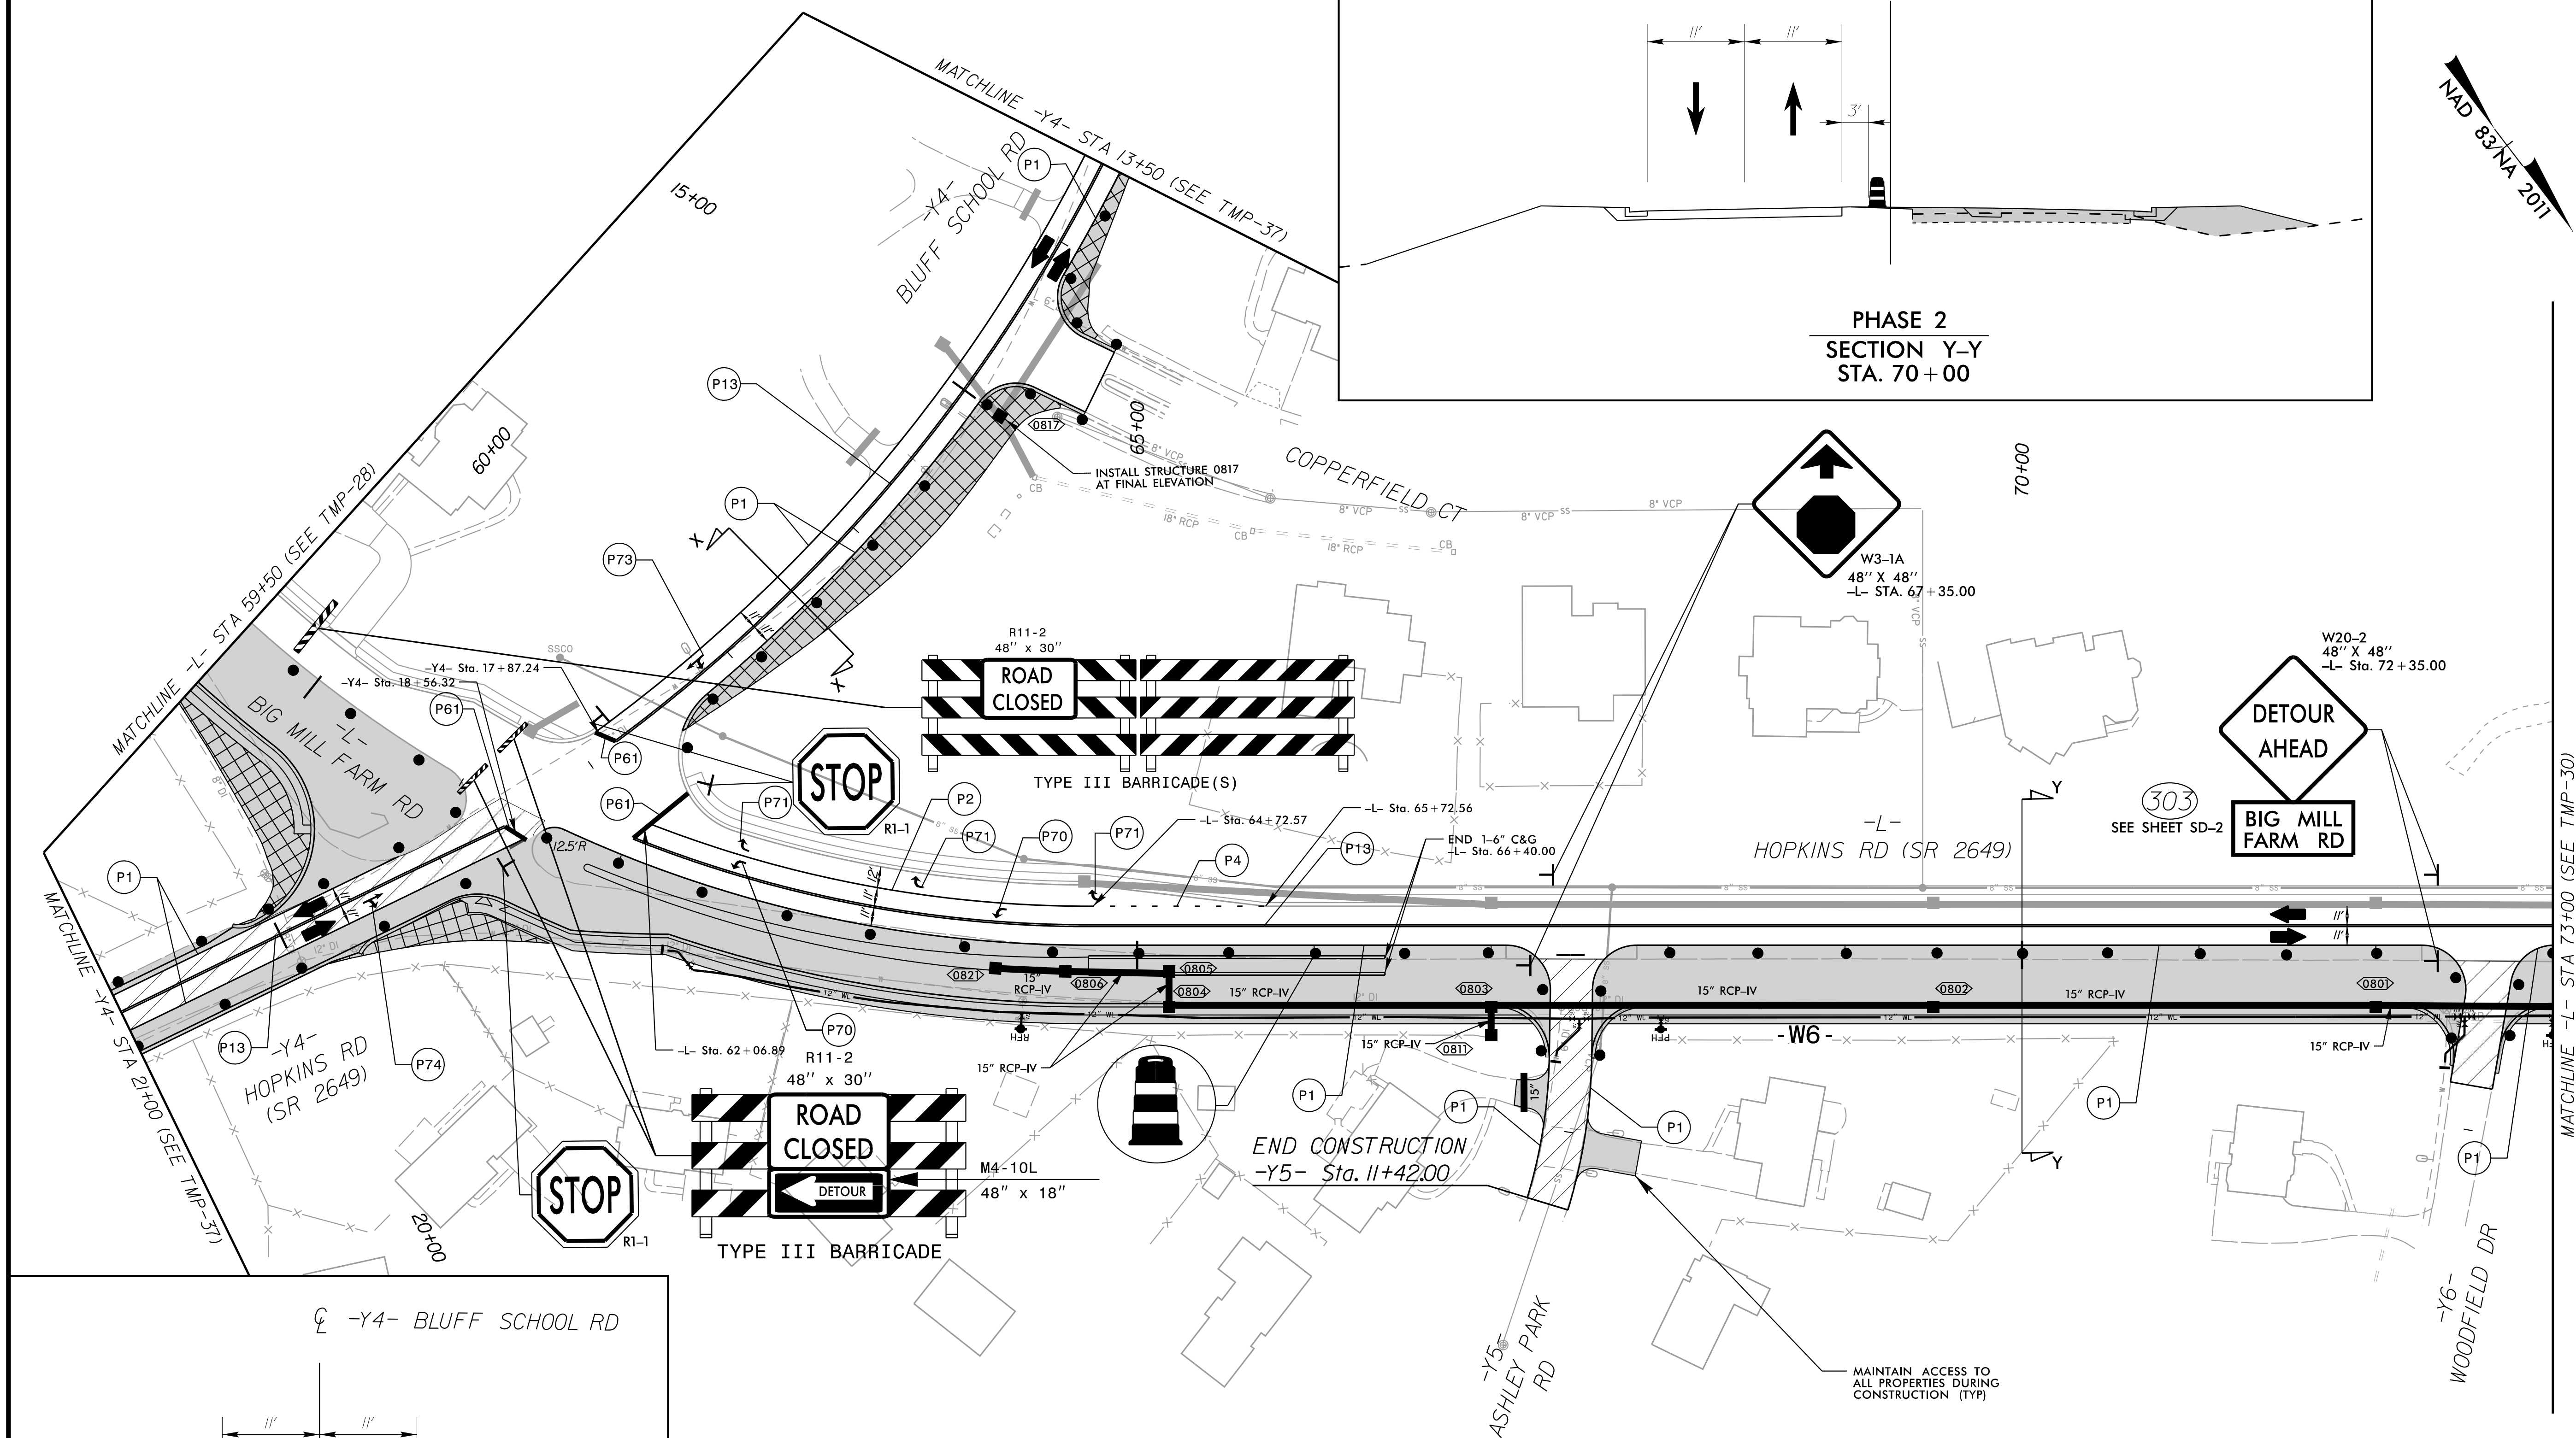


PROJ. REFERENCE NO.	SHEET NO.
U-5760	TMP-29

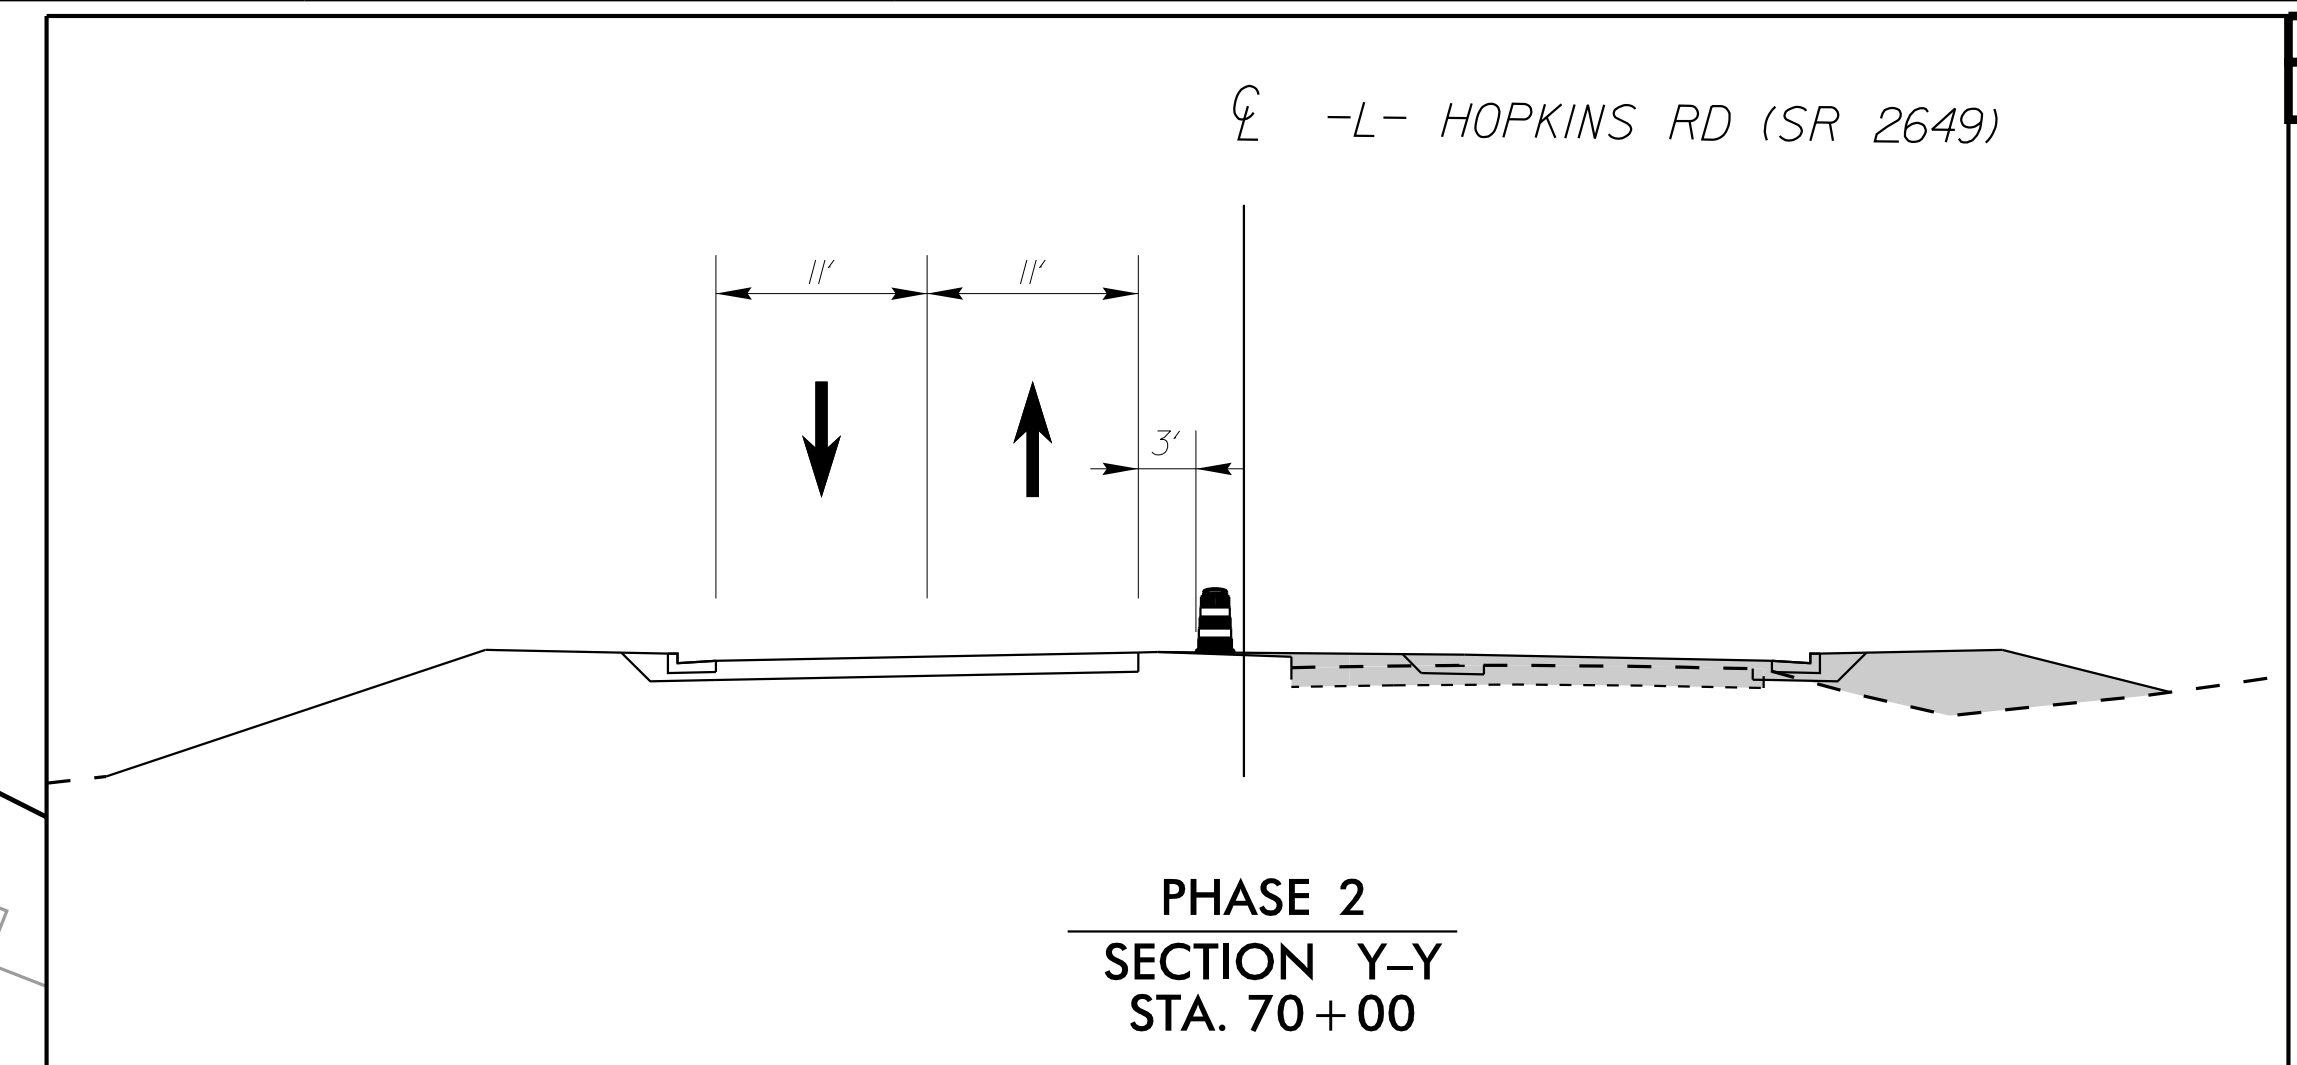


-  WORK AREA
 WEDGING
 PAVEMENT REMOVAL

APPROVED: _____ DATE: _____

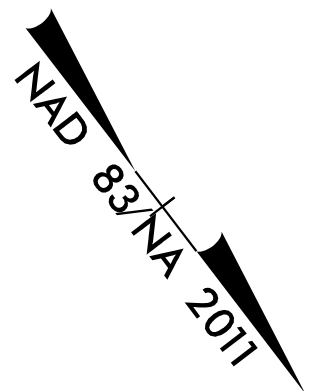



9/12/2025

**DOCUMENT NOT CONSIDERED FINAL
UNLESS ALL SIGNATURES COMPLETED**

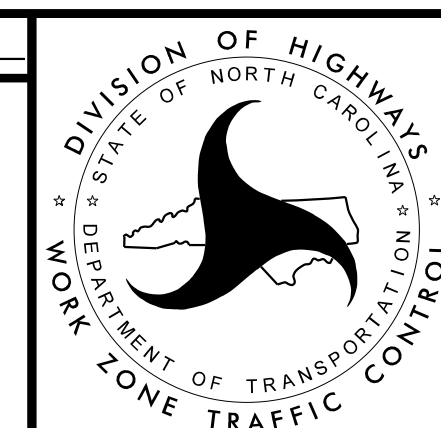

Kimley»»Horn

AREA 2
TRAFFIC CONTROL
PHASE II

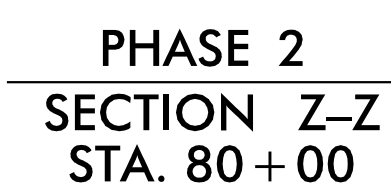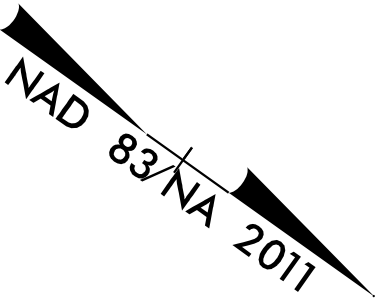


APPROVED: _____ DATE: _____



9/12/2025

**DOCUMENT NOT CONSIDERED FINAL
UNLESS ALL SIGNATURES COMPLETED**

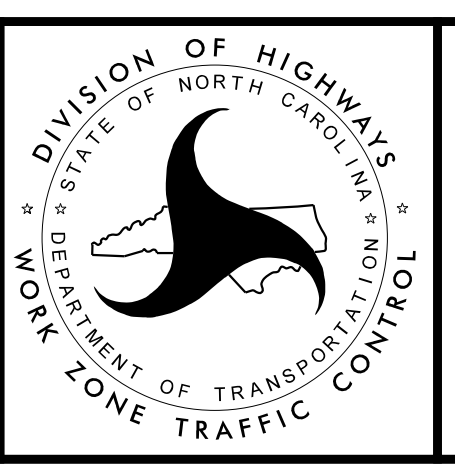






600

Kimley»»Horn

AREA 2
TRAFFIC CONTROL
PHASE II

NC LICENSE #F-0102
421 FAYETTEVILLE STREET, SUITE 600
RALEIGH, NORTH CAROLINA 27601
PHONE: (919) 677-2000

PROJ. REFERENCE NO.	SHEET NO.
U-5760	TMP-31

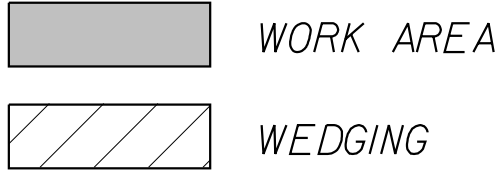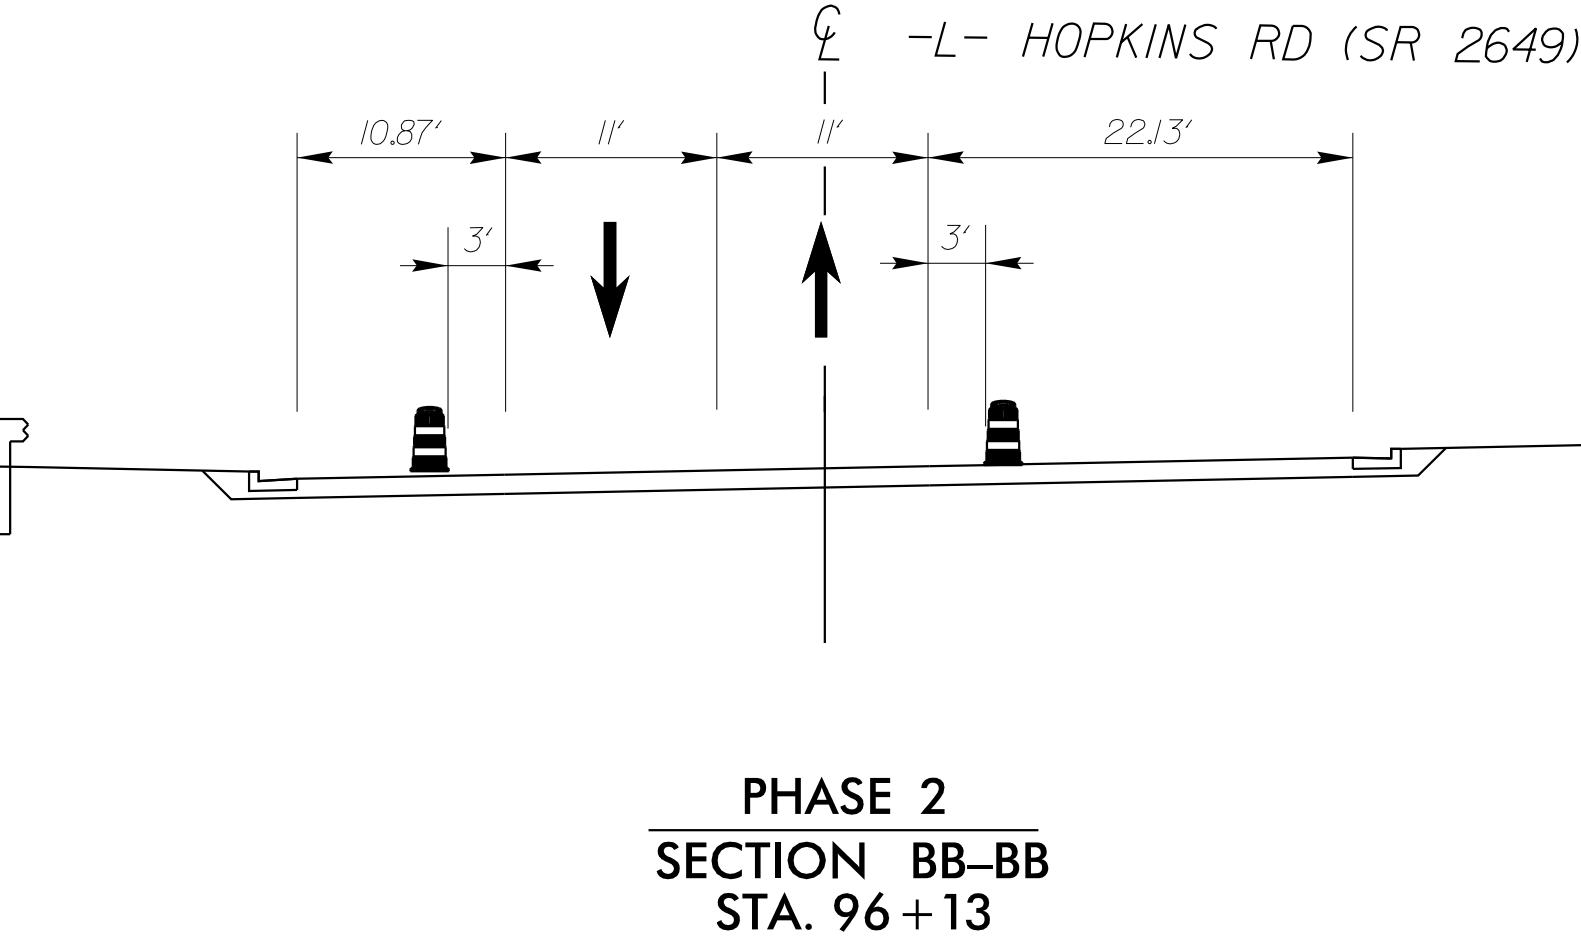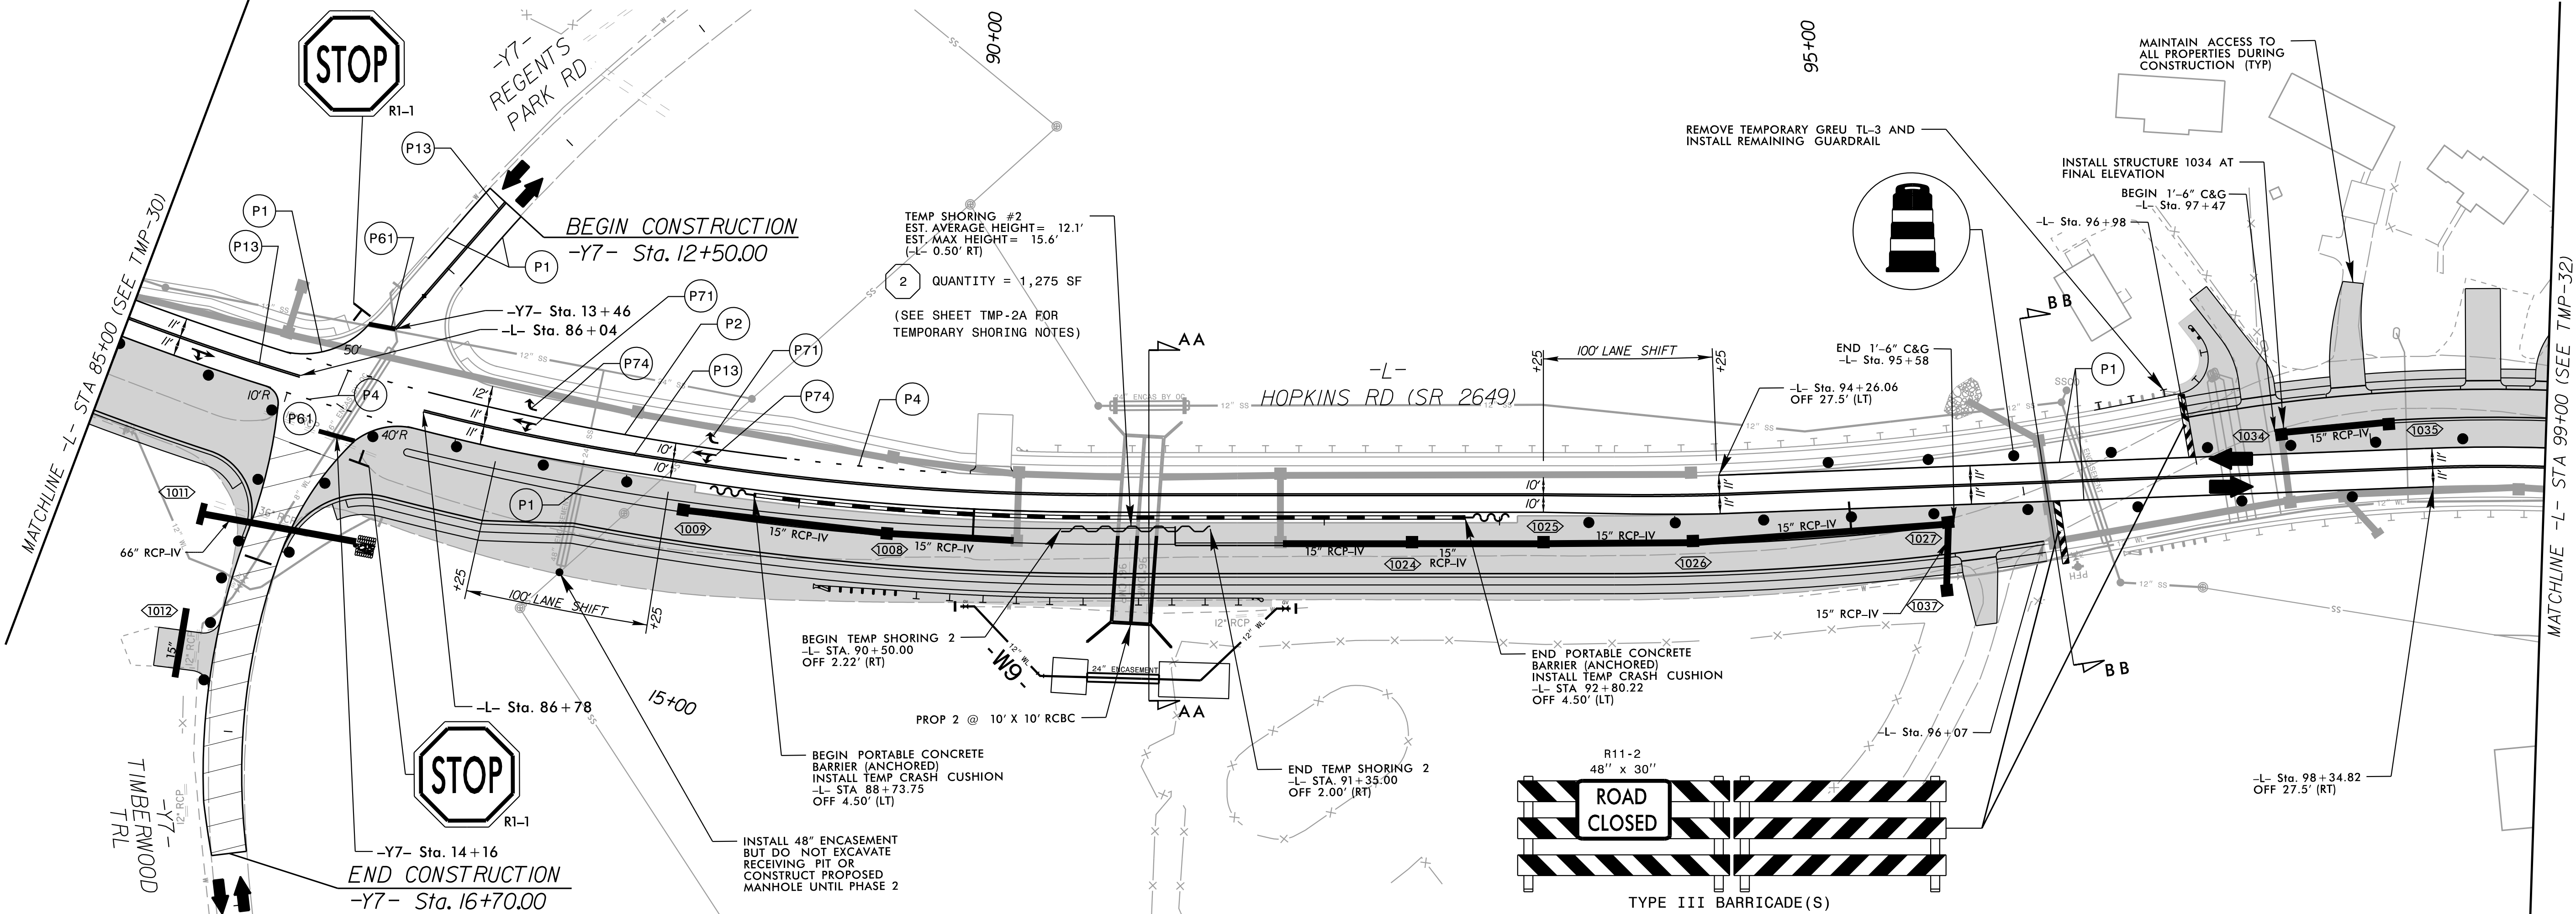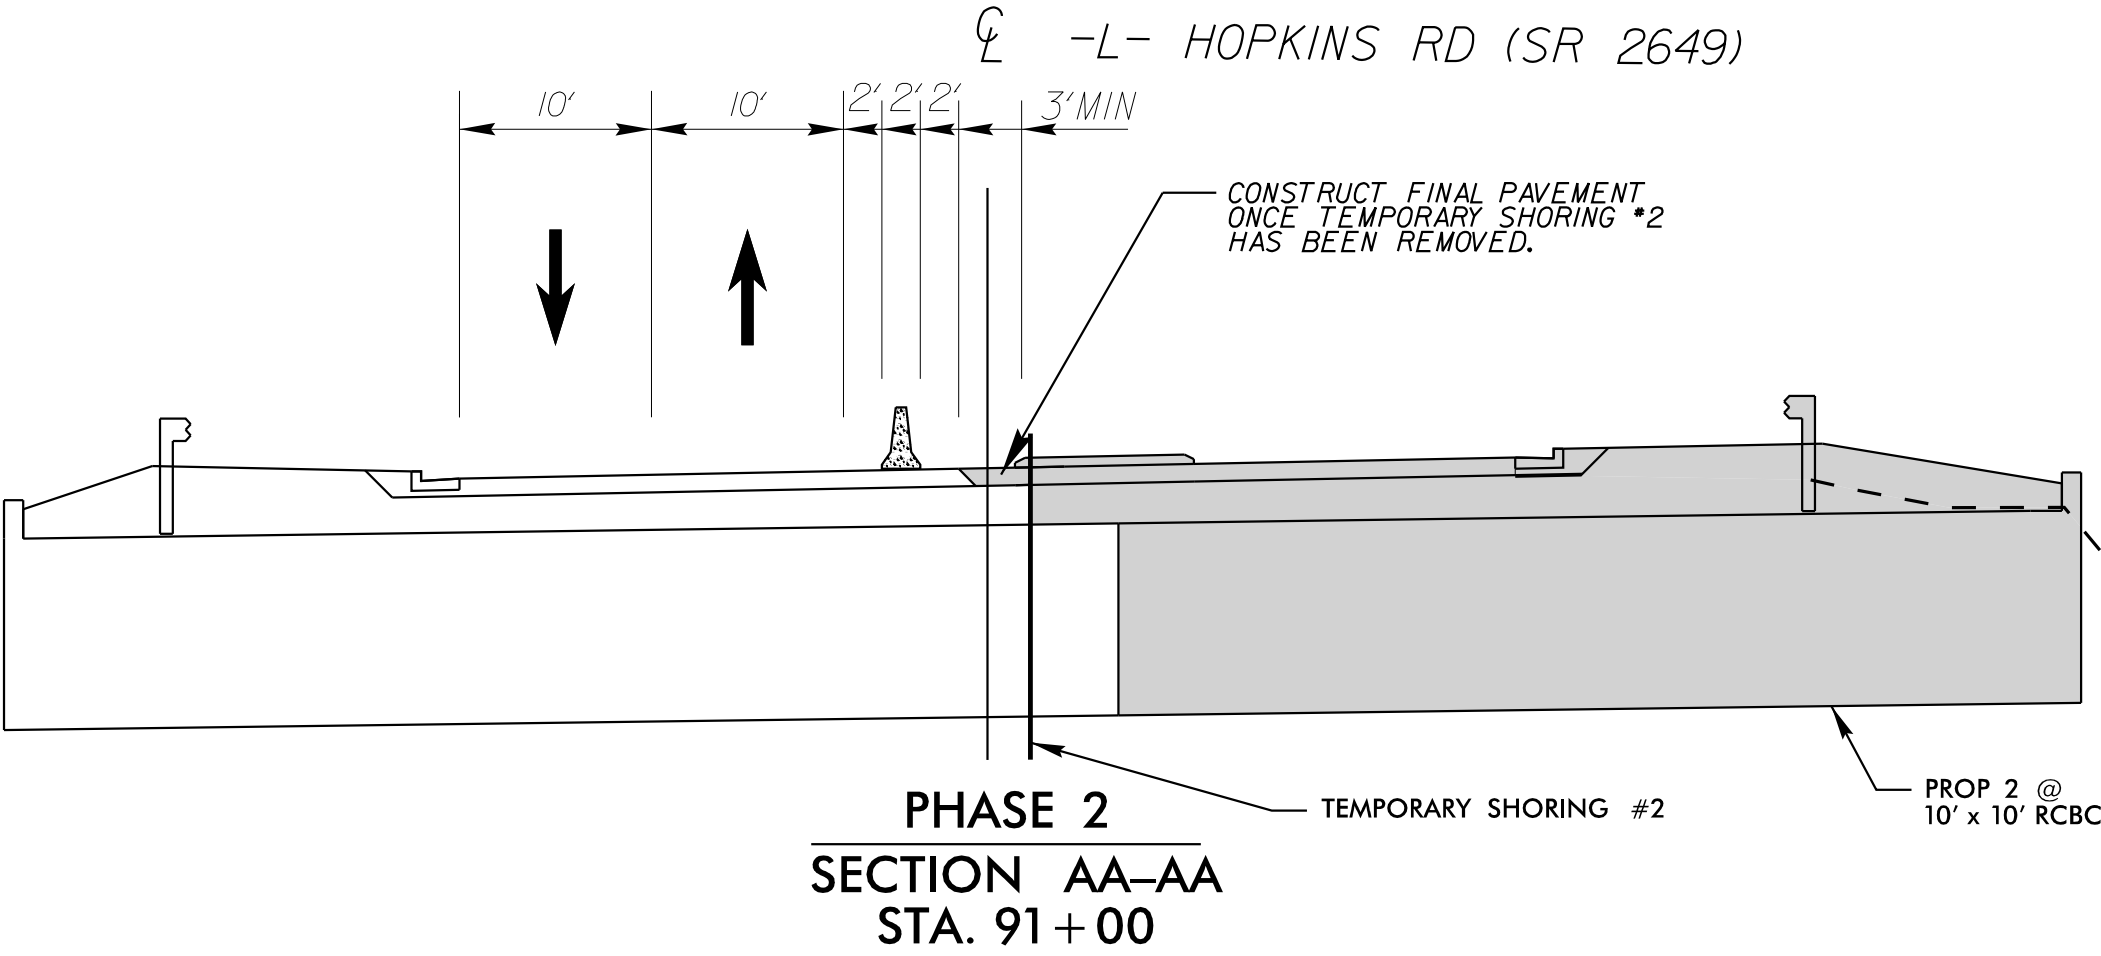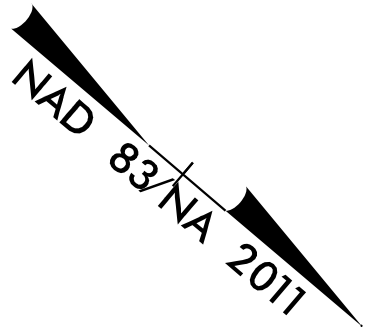

APPROVED: _____ DATE: _____

9/12/2025

DOCUMENT NOT CONSIDERED FINAL
UNLESS ALL SIGNATURES COMPLETED






Kimley-Horn

AREA 2
TRAFFIC CONTROL
PHASE II

K:\RAL_Roadway\01036312 - U-5760 Big Mill Farm RoadTrafficControl\TCS\Sheets\Phase 2\U5760_Tcp_psh31.dgn 8/5/2025

PROJ. REFERENCE NO.	SHEET NO.
U-5760	TMP-32

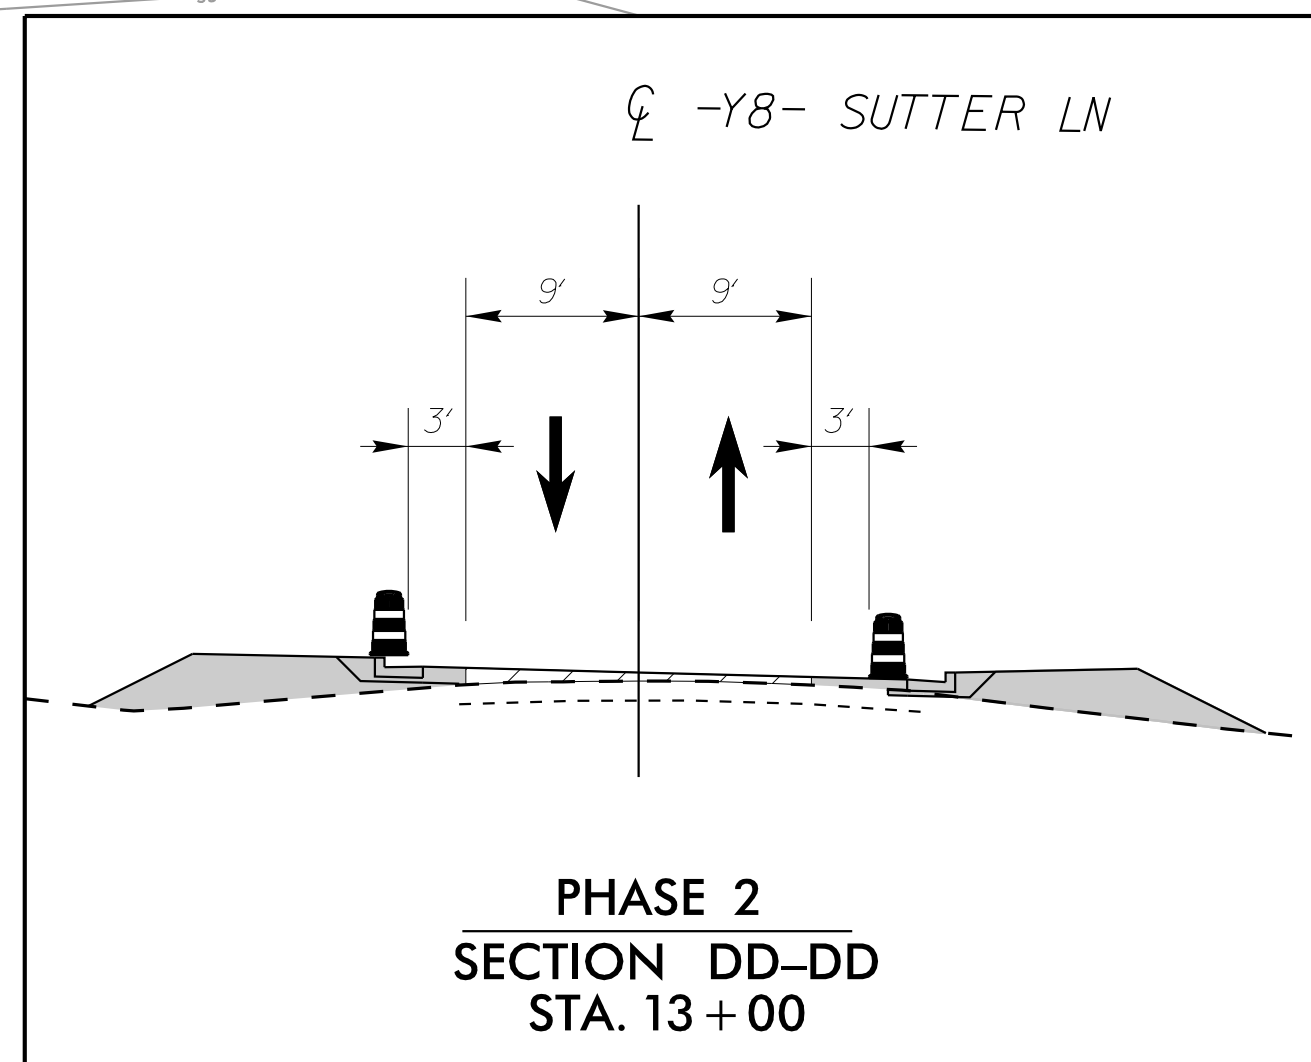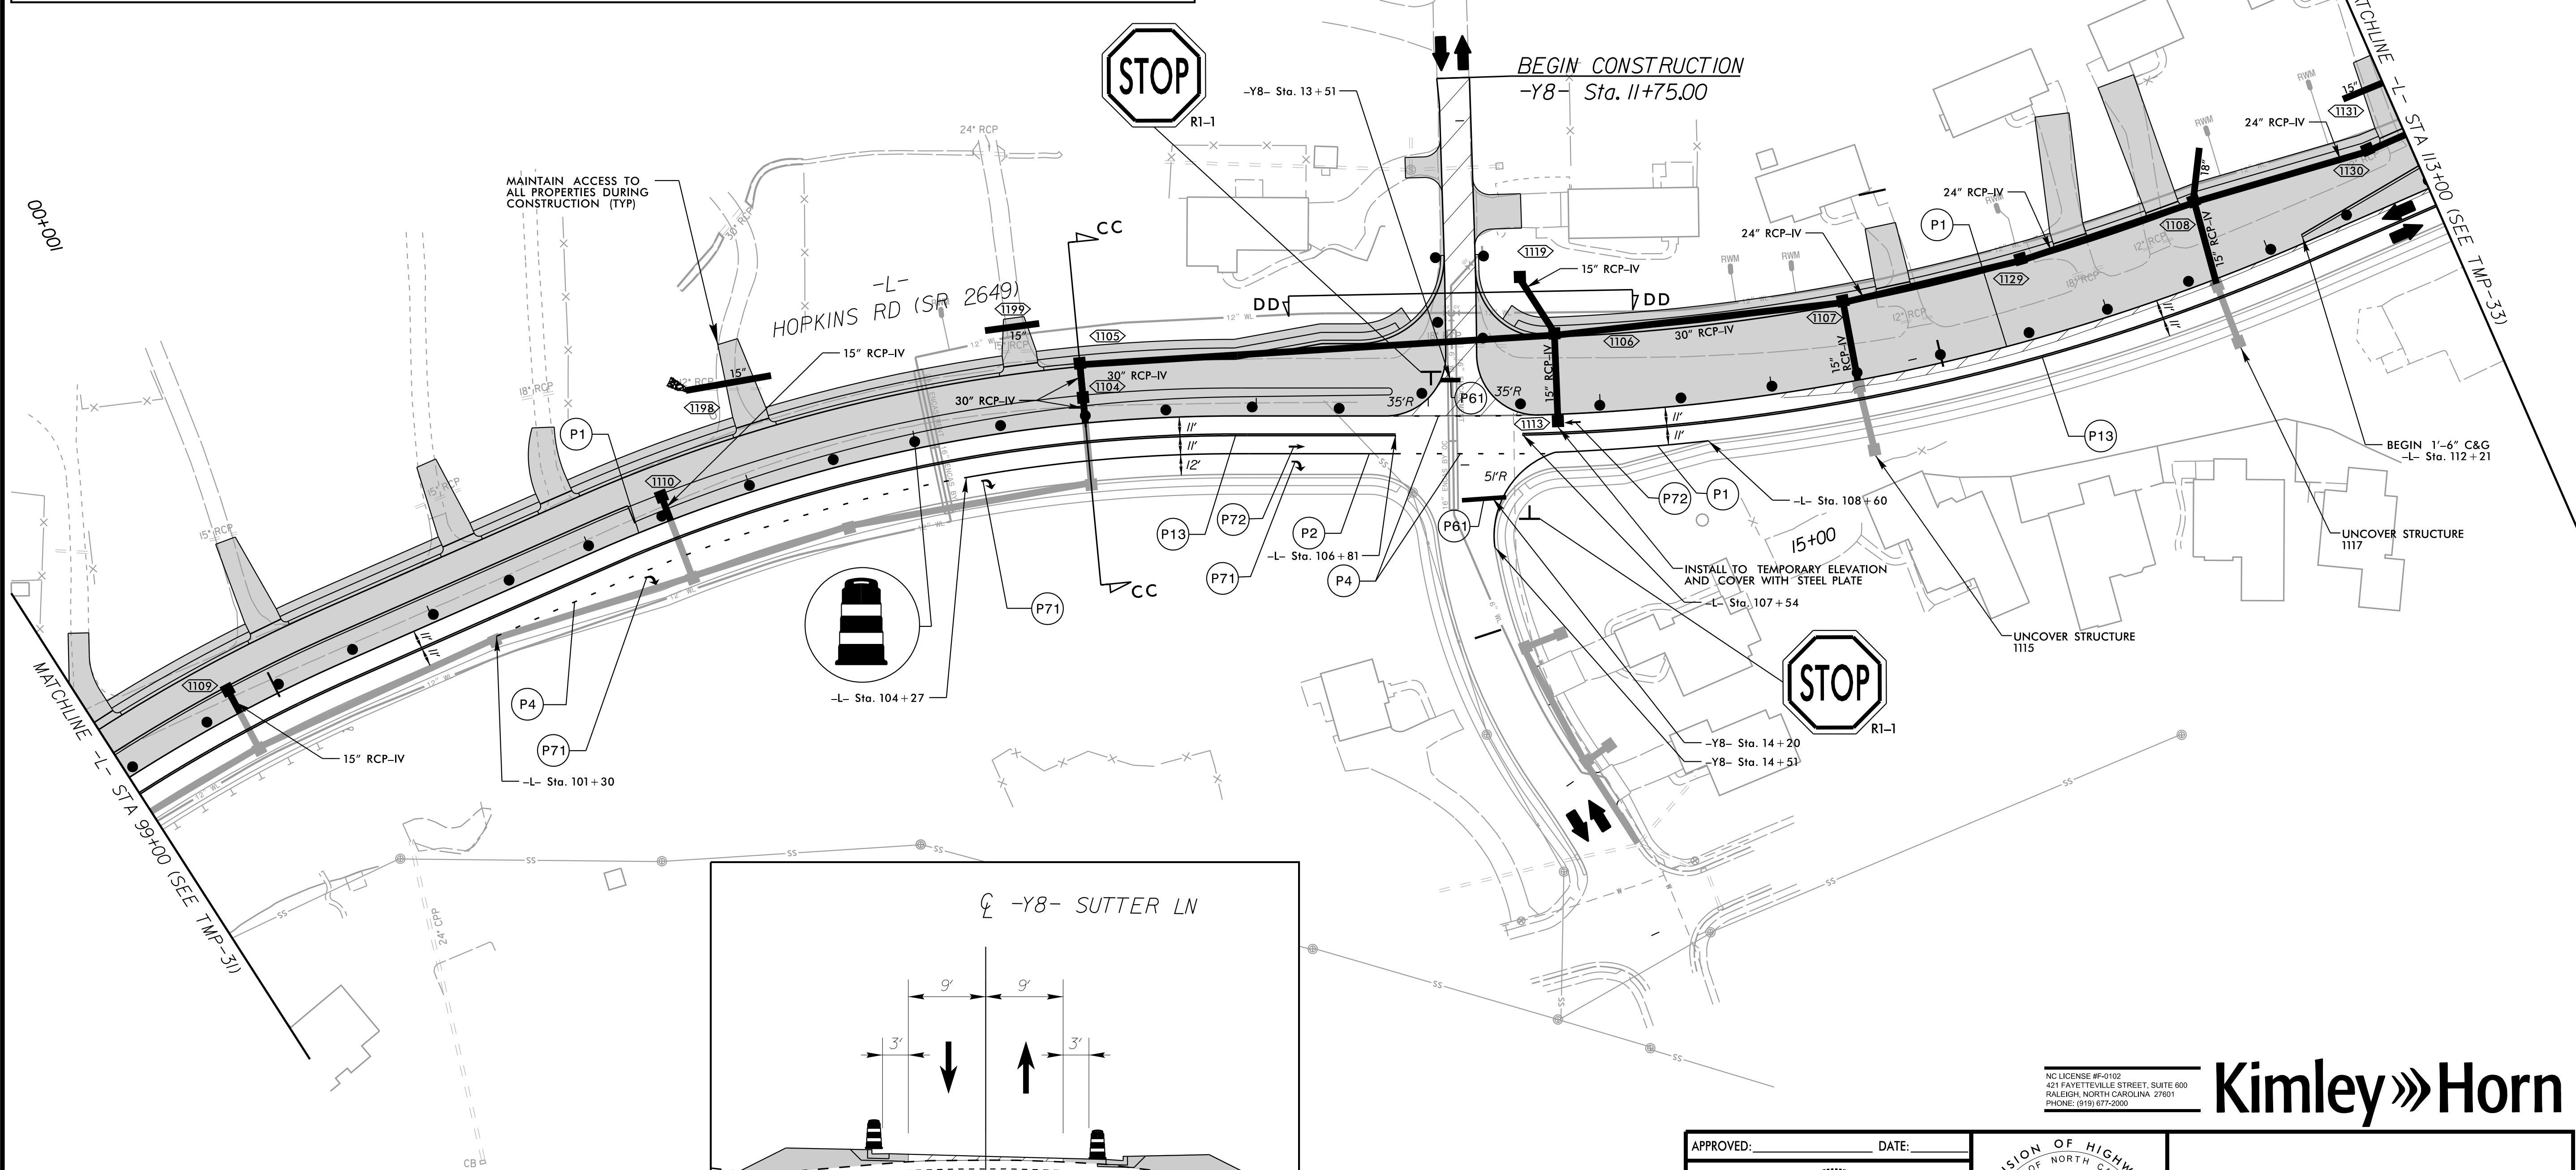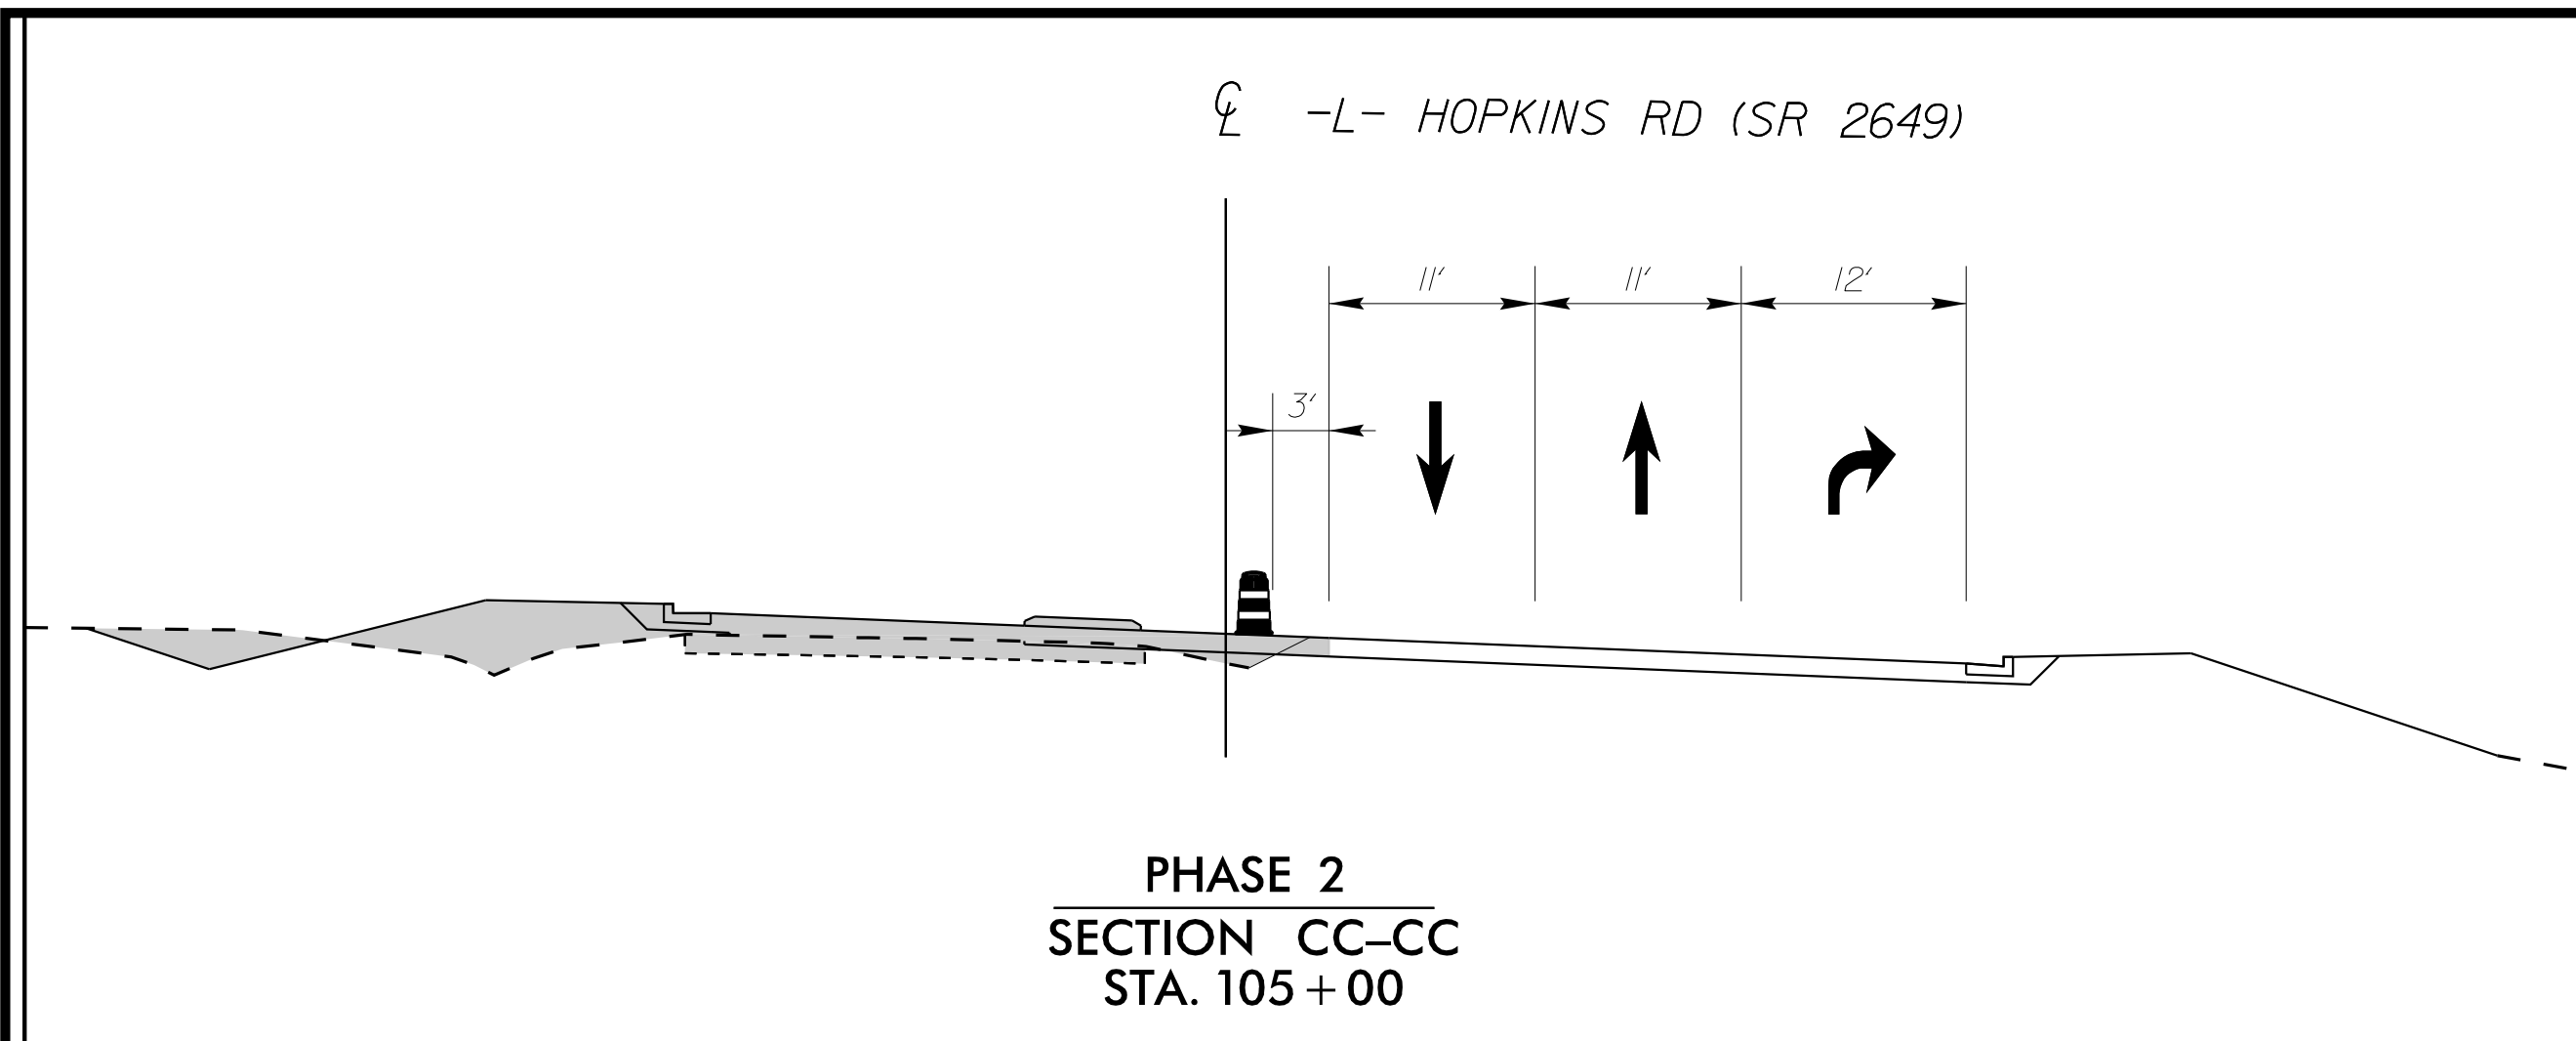

 WORK AREA


 WEDGING

APPROVED: _____ DATE: _____



9/12/2025


**DOCUMENT NOT CONSIDERED FINAL
UNLESS ALL SIGNATURES COMPLETED**

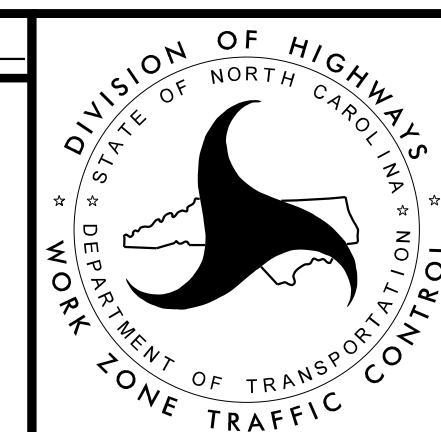


NC LICENSE #F-0102
421 FAYETTEVILLE STREET, SUITE 600
RALEIGH, NORTH CAROLINA 27601
PHONE: (919) 677-2000

Kimley»»Horn

AREA 2
TRAFFIC CONTROL
PHASE II

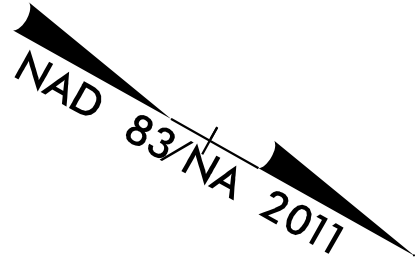

OLD HOLLOW RD (NC 66)

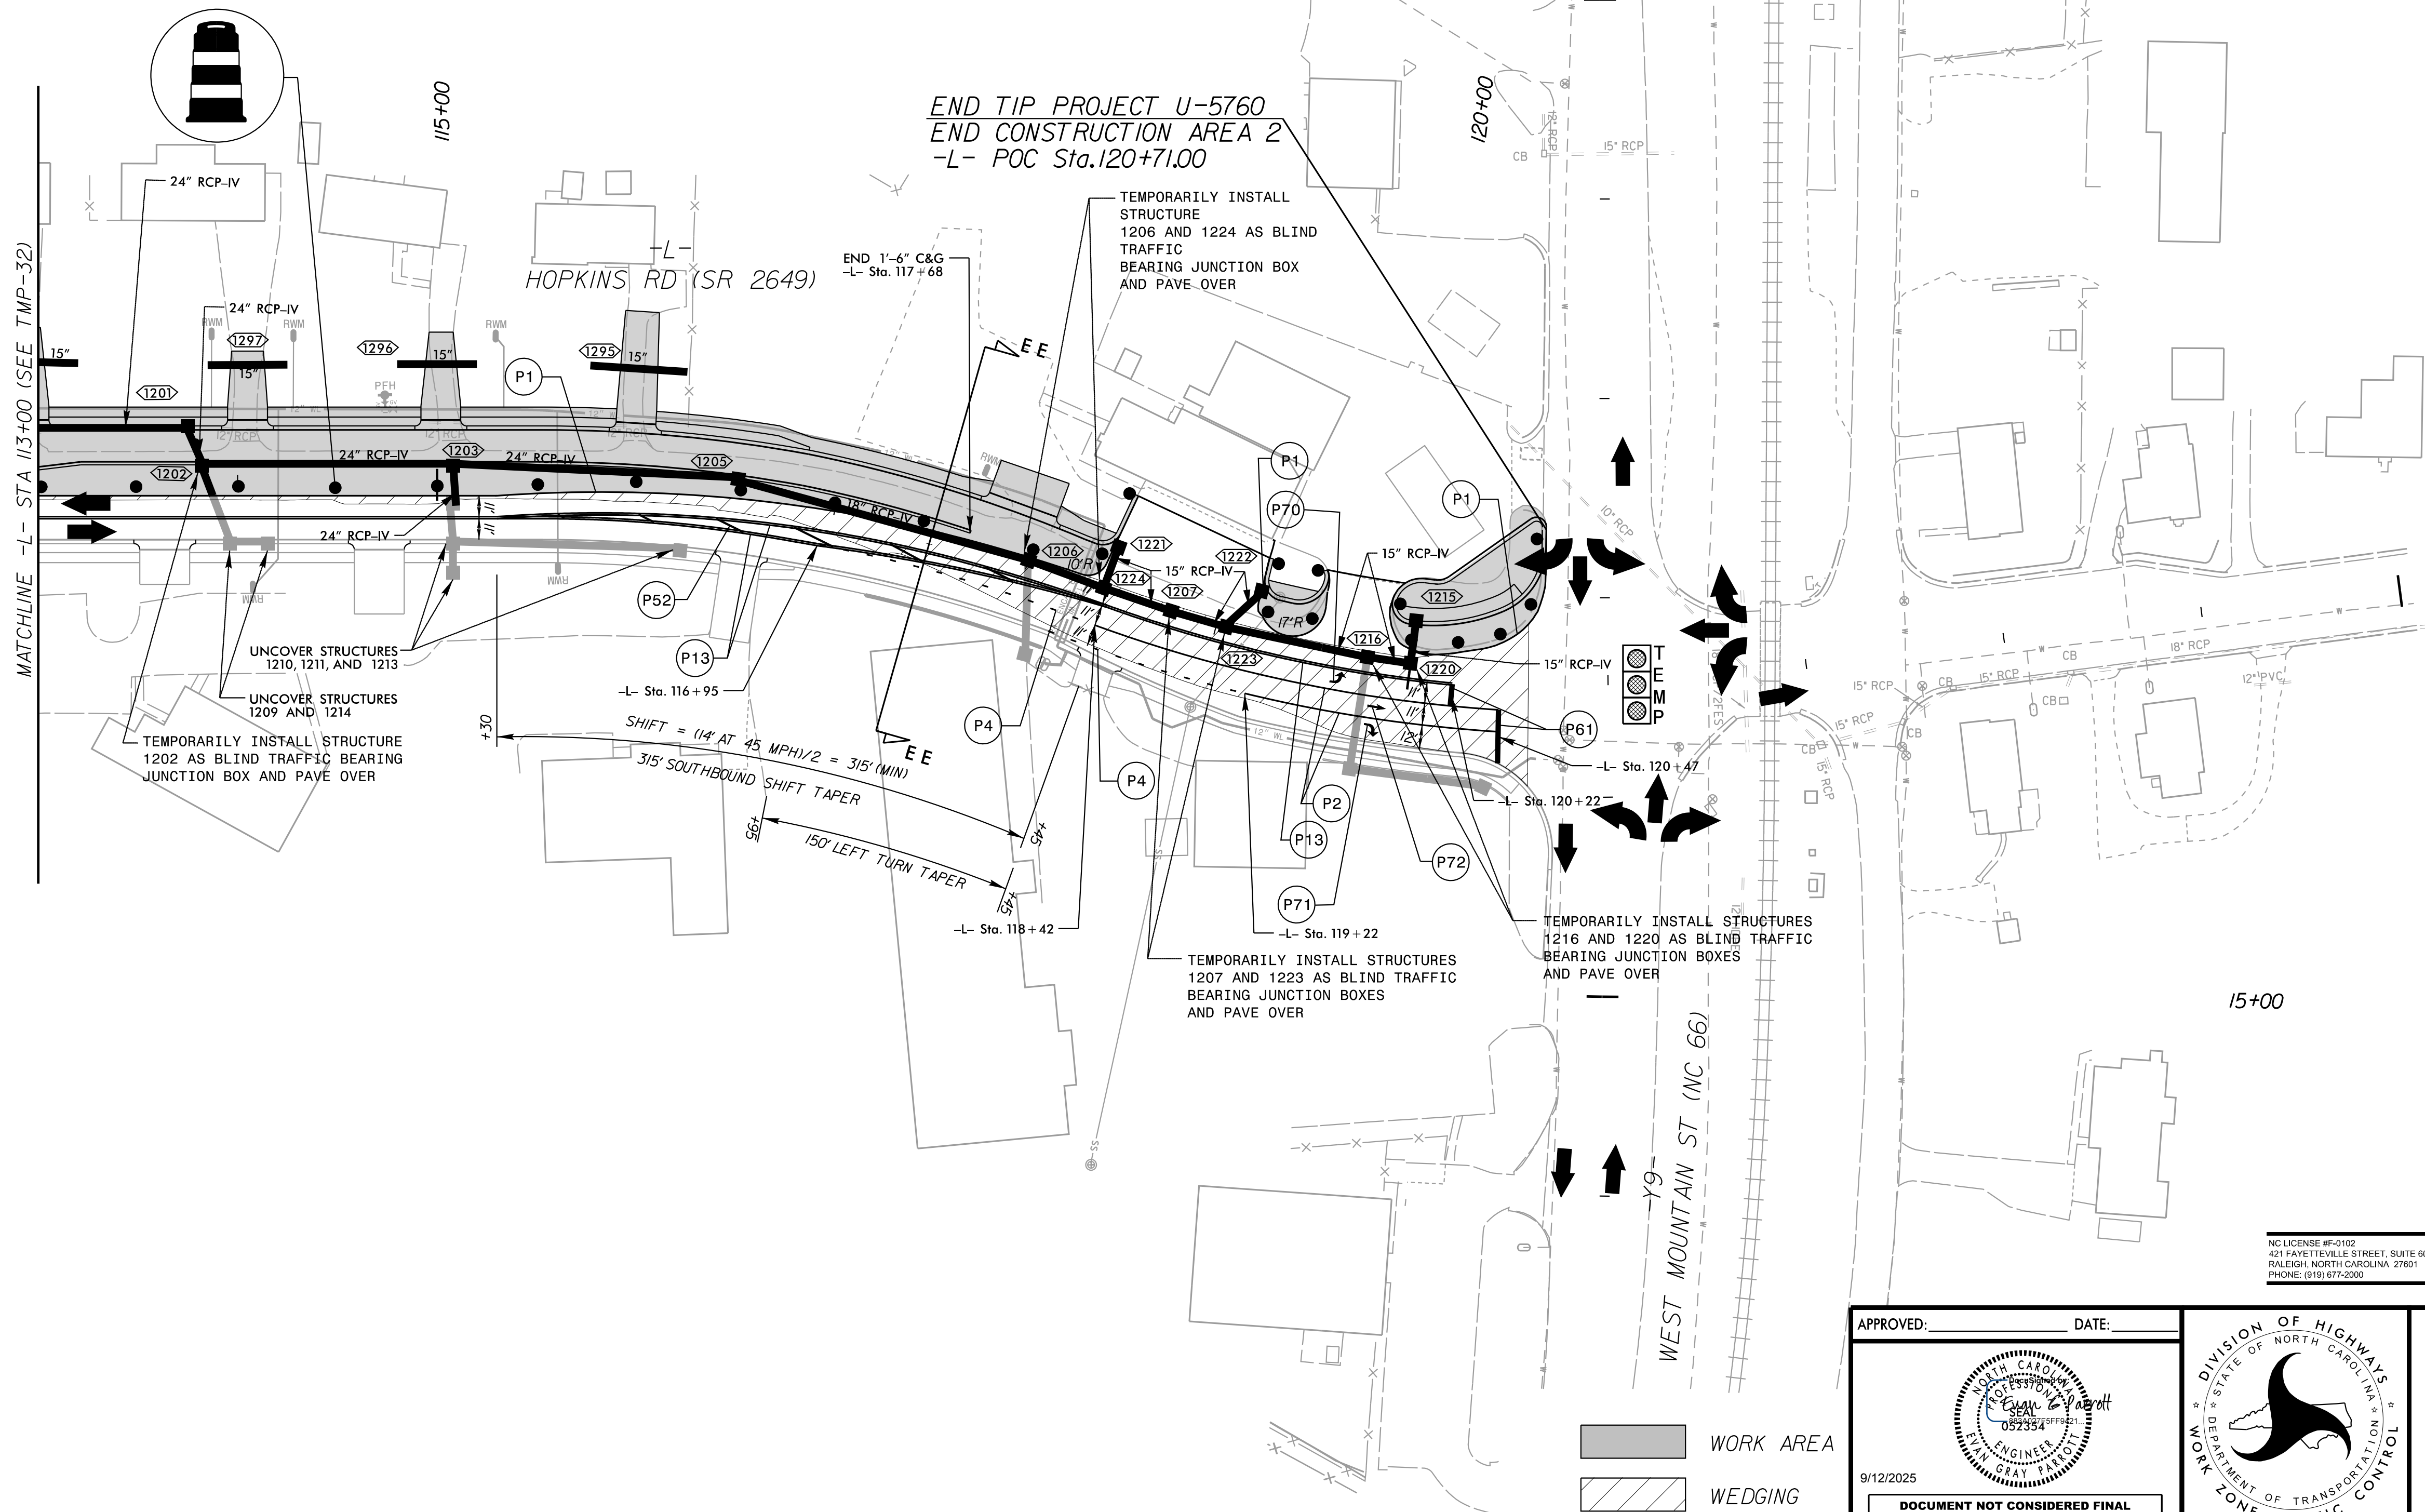

K:\RAL_Roadway\01036312 - U-5760 Big Mill Farm Road\Traffic\TrafficControl\TCPSheets\Phase 2\U5760_top_psh33.dgn

8/5/2025

NC LICENSE #F-0102
421 FAYETTEVILLE STREET, SUITE 600
RALEIGH, NORTH CAROLINA 27601
PHONE: (919) 677-2000

Kimley»Horn

AREA 2
TRAFFIC CONTROL
PHASE II

APPROVED: _____ DATE: _____




9/12/2025

**DOCUMENT NOT CONSIDERED FINAL
UNLESS ALL SIGNATURES COMPLETED**



PROJ. REFERENCE NO.	SHEET NO.
U-5760	TMP-34

NAD 83/NA 2011

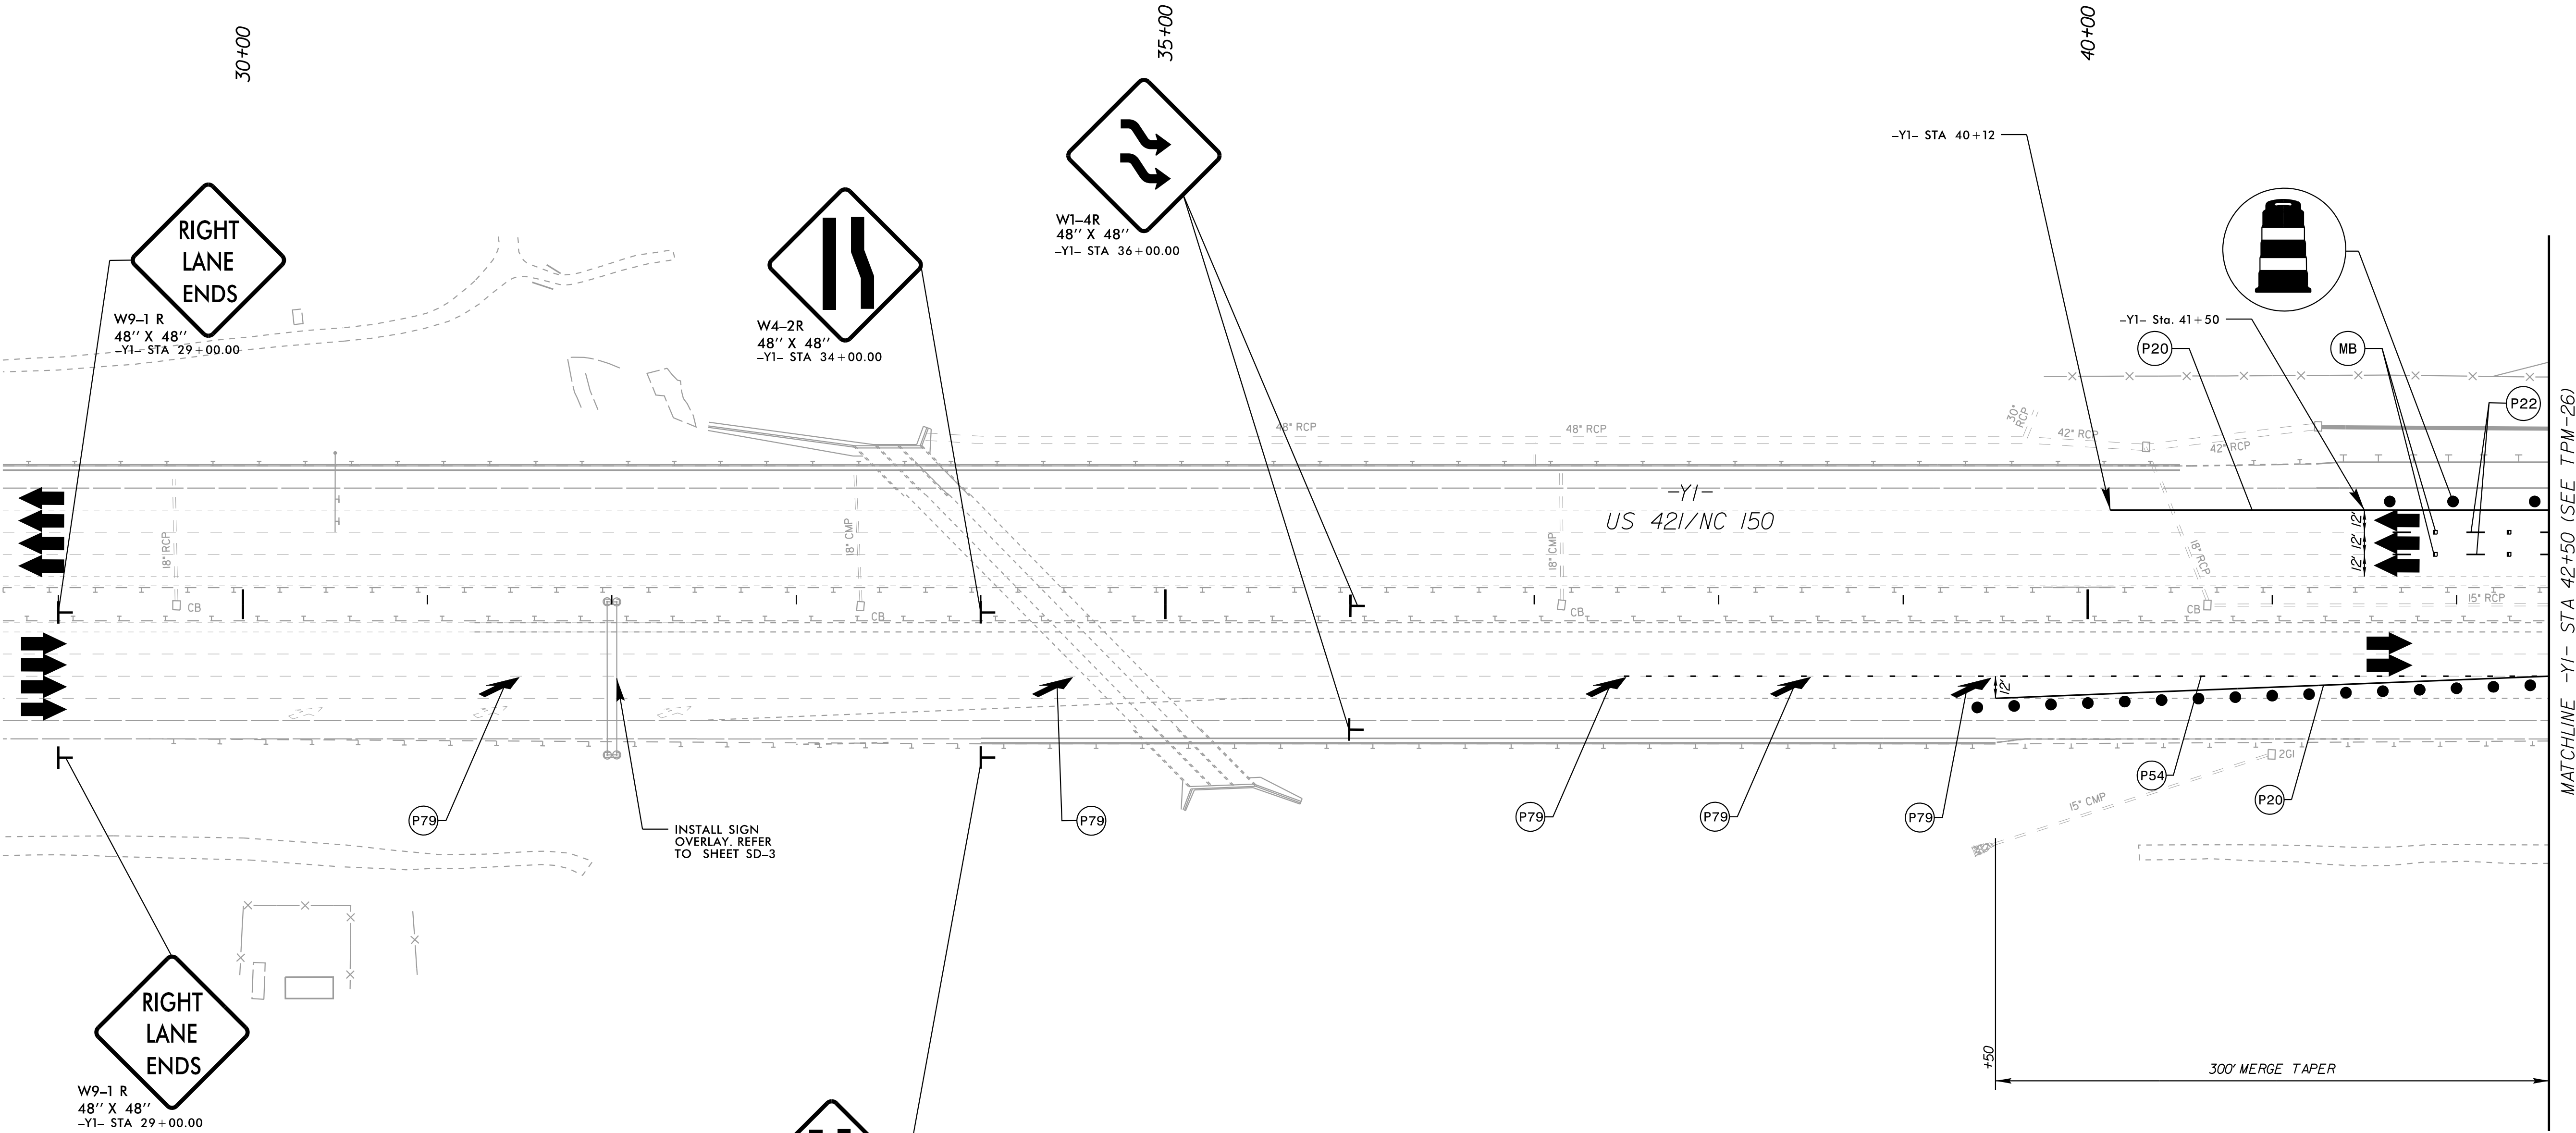

K:\RAL_Roadway\011036312 - U-5760 Big Mill Farm RoadTrafficControl\Phase 2\U5760_top_psh34.dgn

8/5/2025

WORK AREA
WEDGING

APPROVED: DATE:

9/12/2025

DOCUMENT NOT CONSIDERED FINAL
UNLESS ALL SIGNATURES COMPLETED


NC LICENSE #P-0102
421 FAYETTEVILLE STREET, SUITE 600
RALEIGH, NORTH CAROLINA, 27601
PHONE: (919) 877-2000

AREA 1
TRAFFIC CONTROL
PHASE II

PROJ. REFERENCE NO.	SHEET NO.
U-5760	TMP-35



PHASE 2
SECTION FF-FF
STA. 80+00

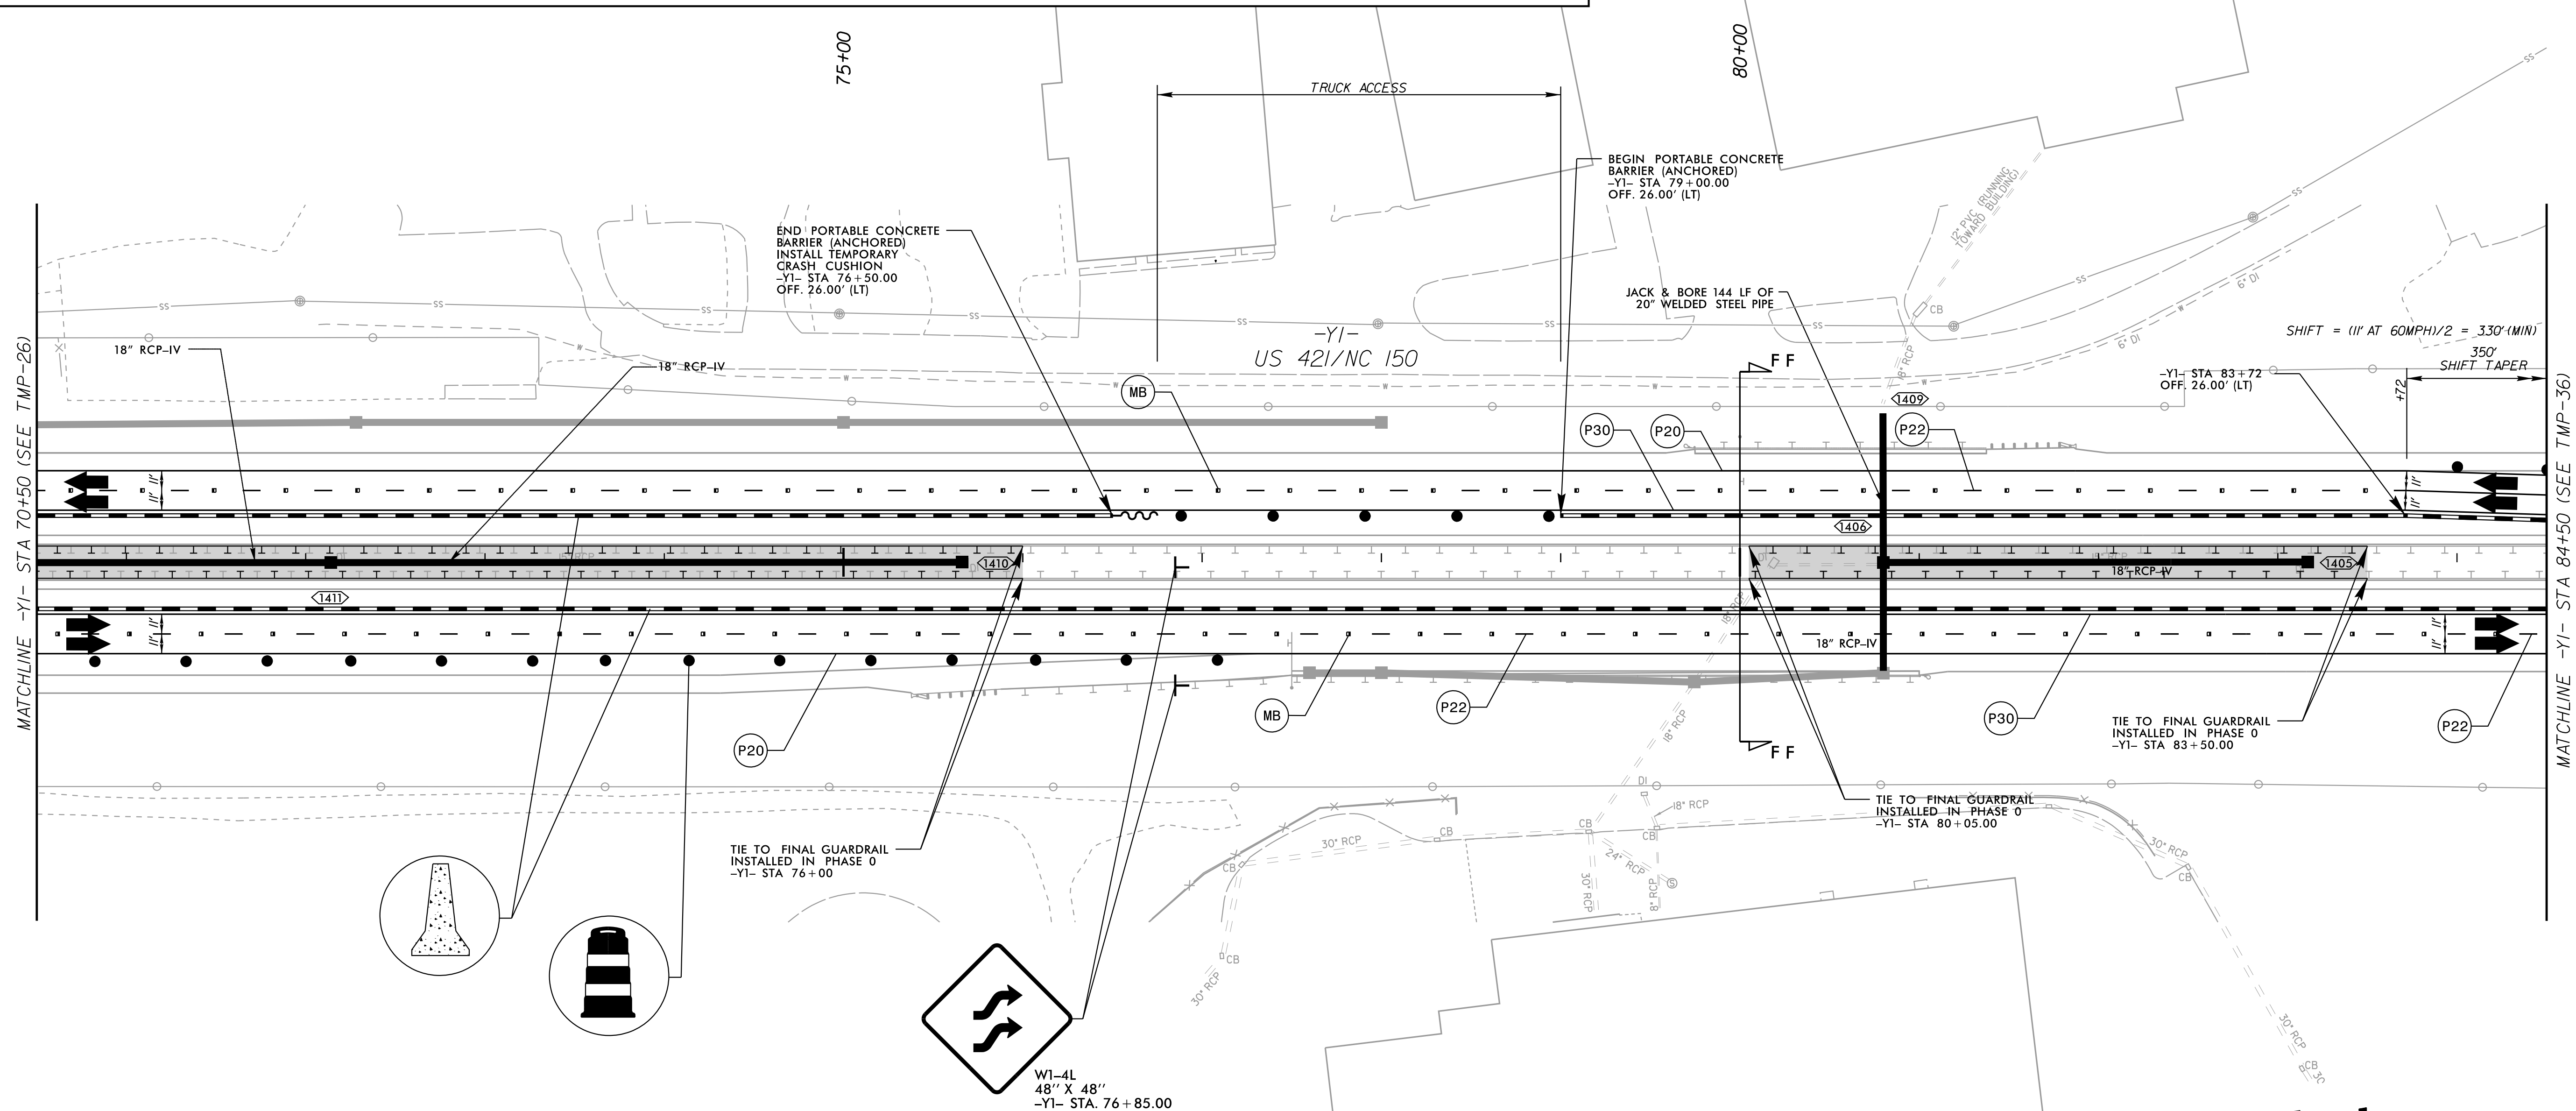

NC LICENSE #F-0102
421 FAYETTEVILLE STREET, SUITE 600
RALEIGH, NORTH CAROLINA 27601
PHONE: (919) 677-2000

Kimley»»Horn

AREA 1
TRAFFIC CONTROL
PHASE II

 WORK AREA


 WEDGING

APPROVED: _____ DATE: _____




9/12/2025

**DOCUMENT NOT CONSIDERED FINAL
UNLESS ALL SIGNATURES COMPLETED**

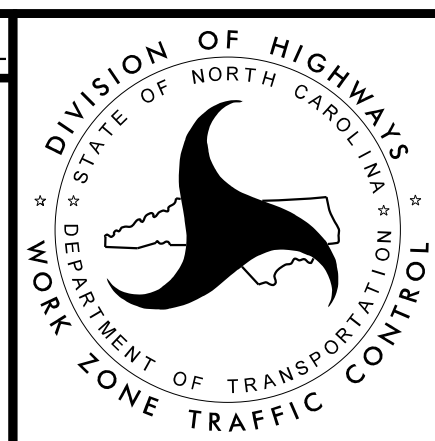


K:\RAL_Roadway\01036312 - U-5760 Big Mill Farm Road\TrafficControl\TCS\Phase 2\U5760_Tcp_psh36.dgn

8/5/2025


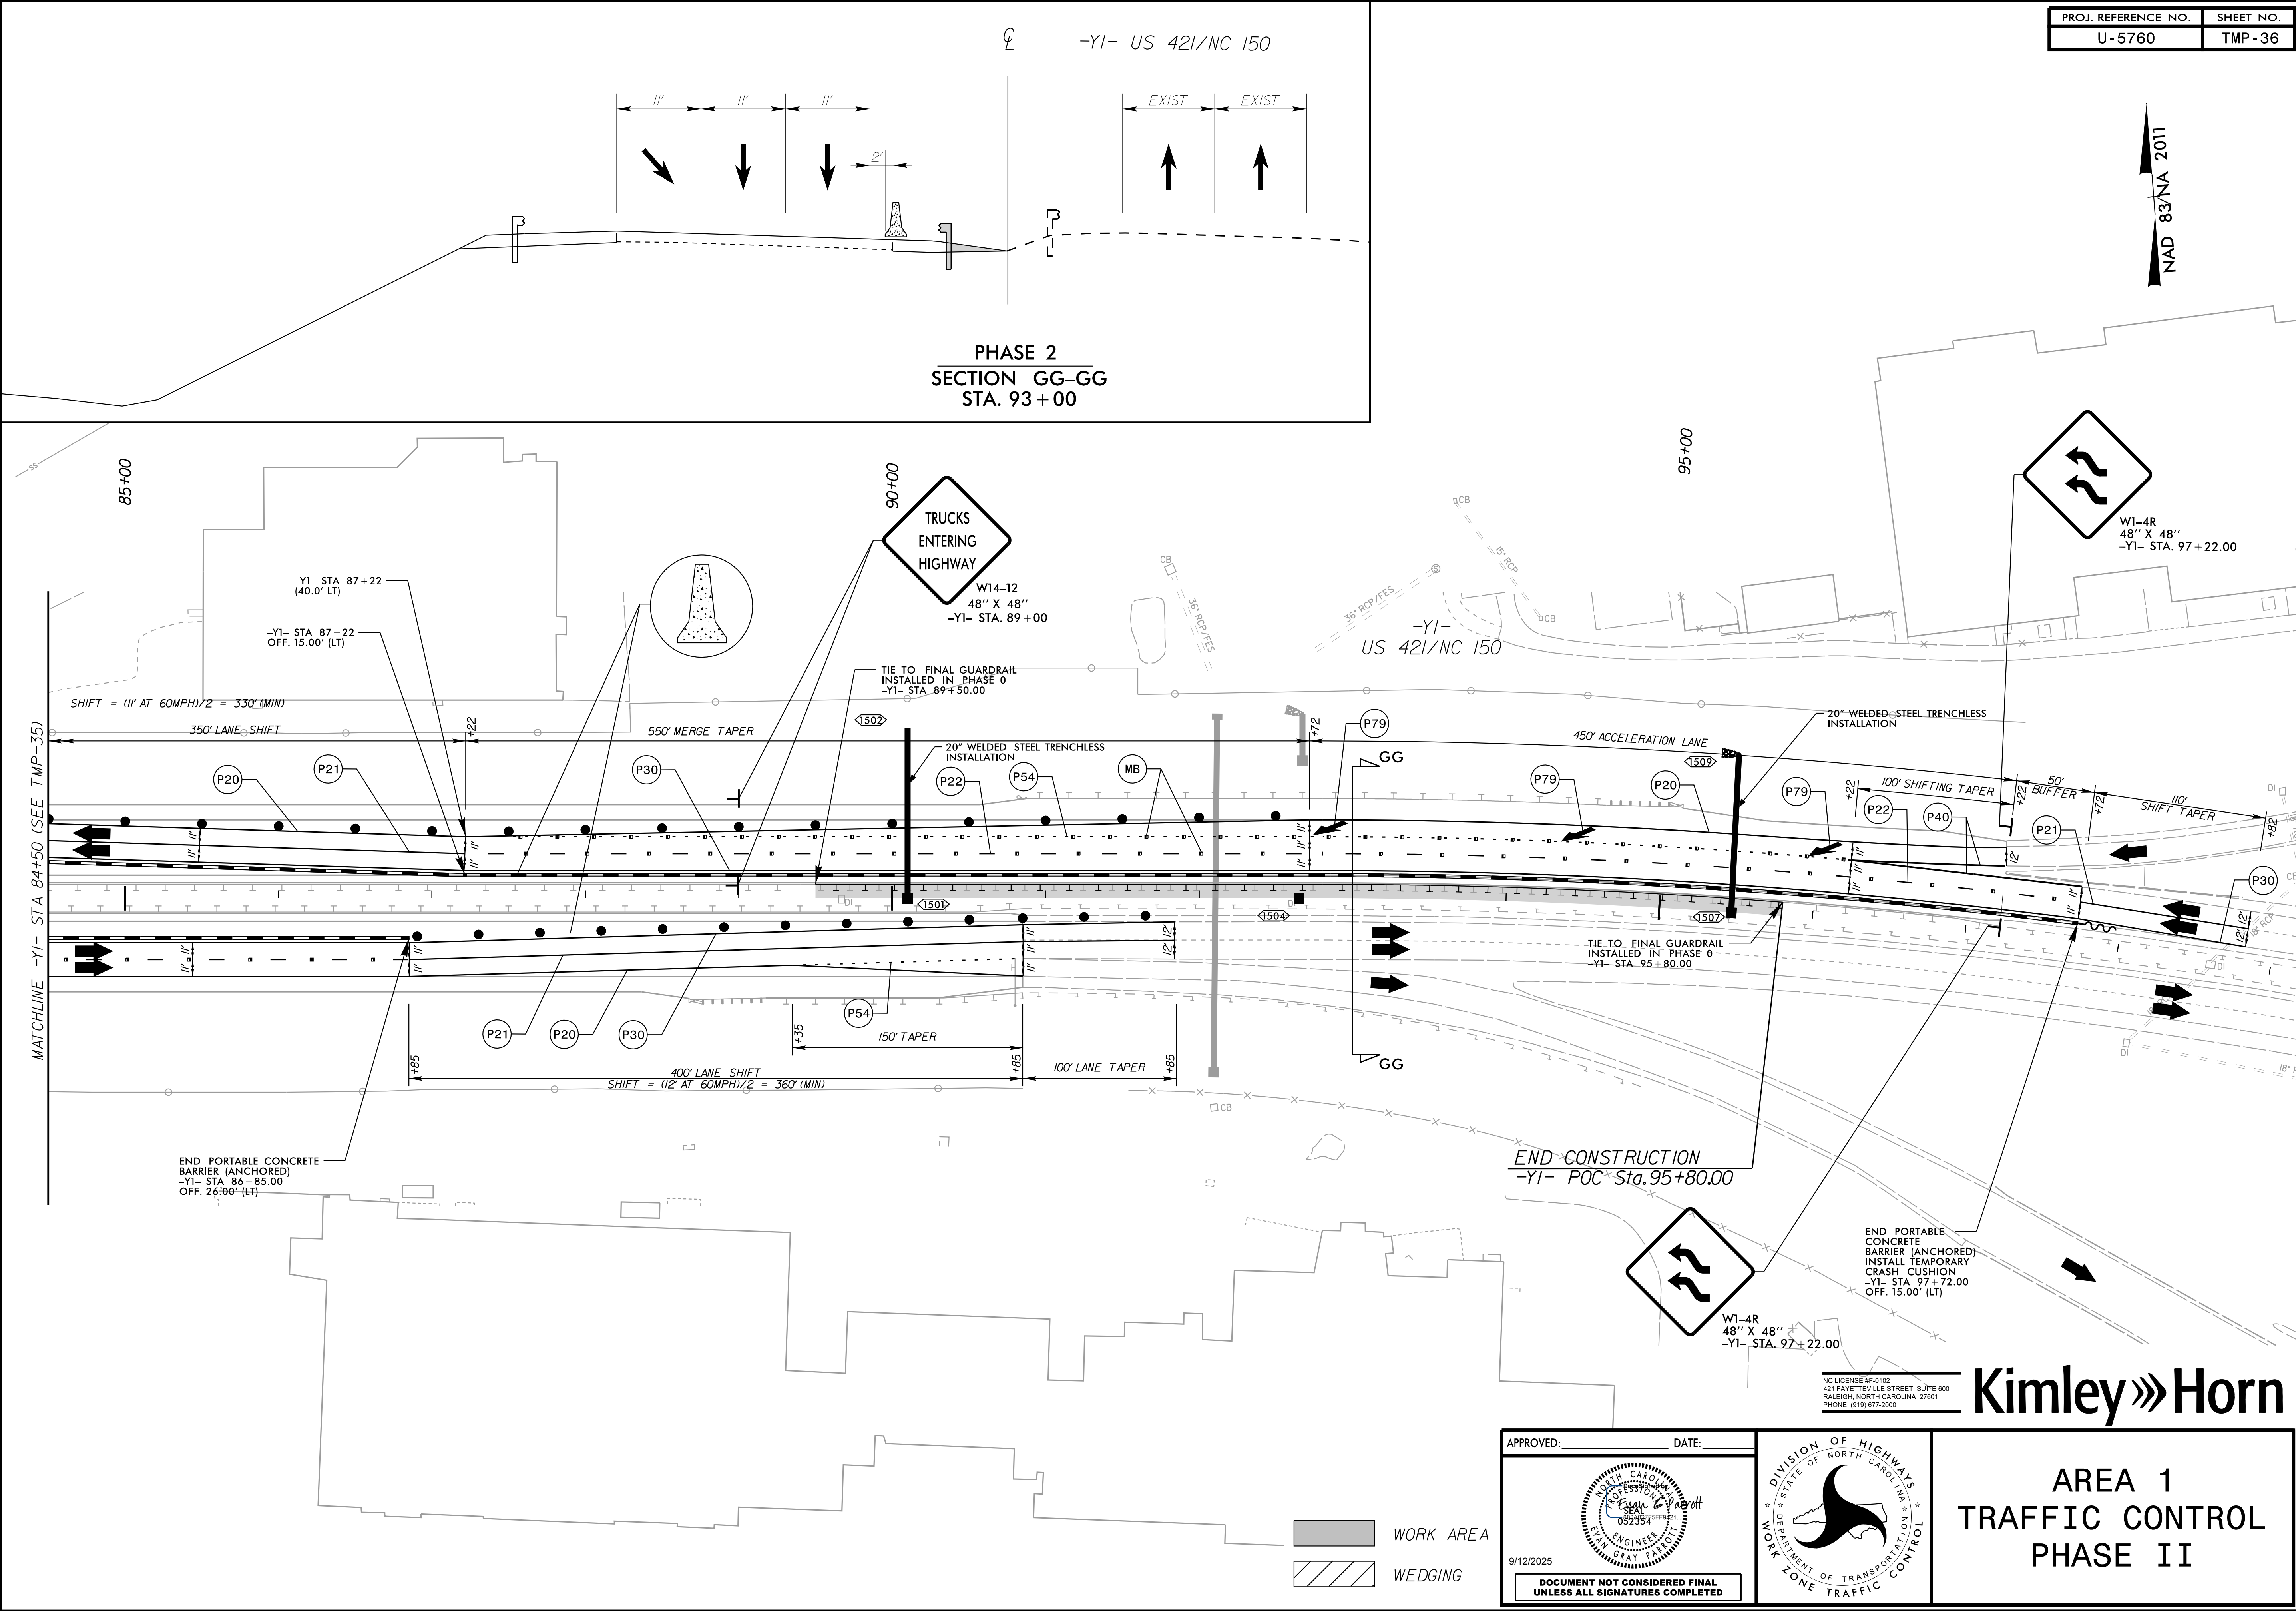


K:\RAL_Roadway\01036312 - U-5760 Big Mill Farm Road\TrafficControl\Phase 2\U5760_top_psh37.dgn

8/5/2025

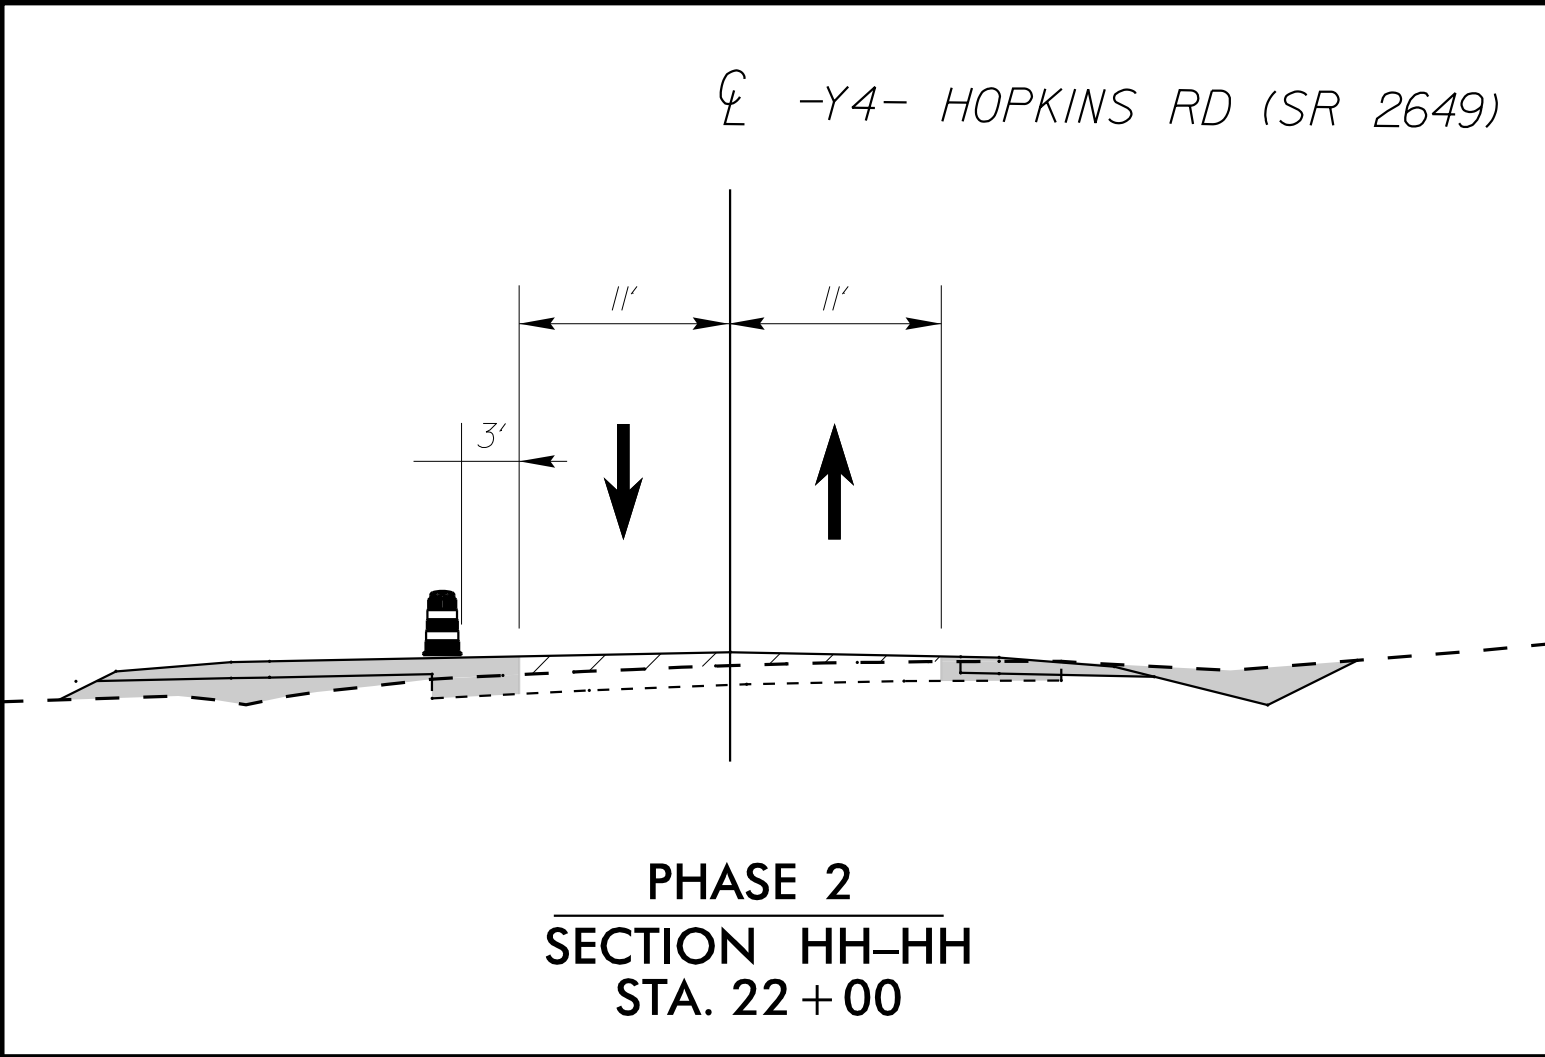

NAD 83/NA 2011

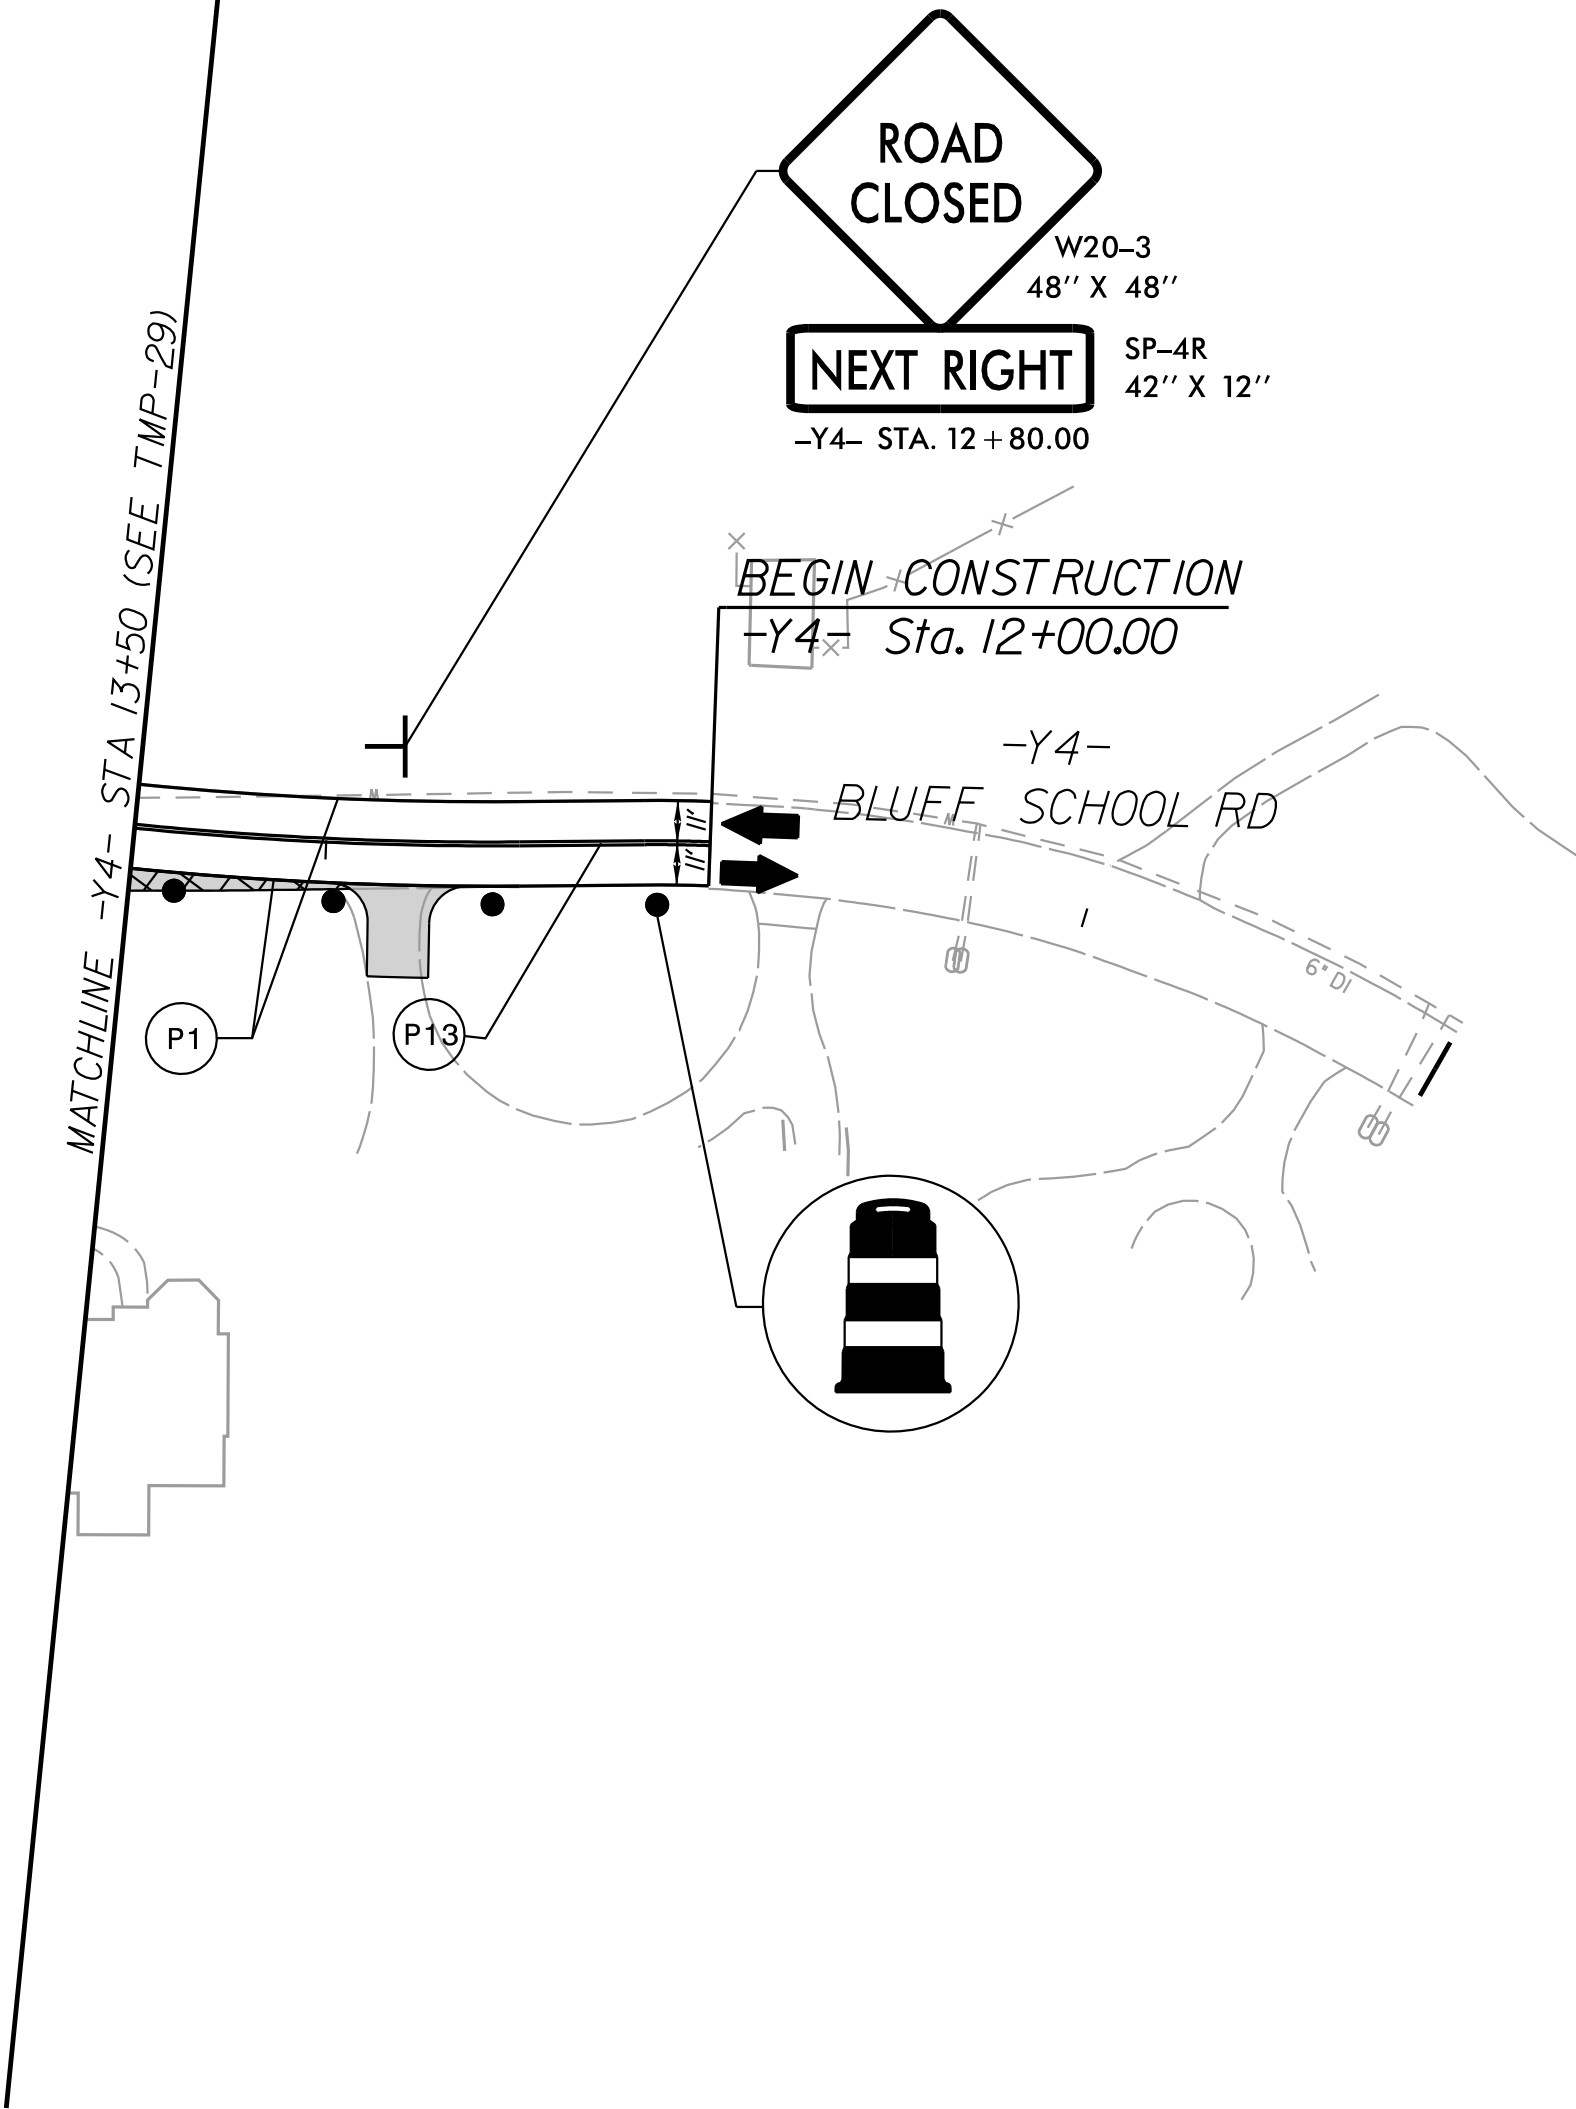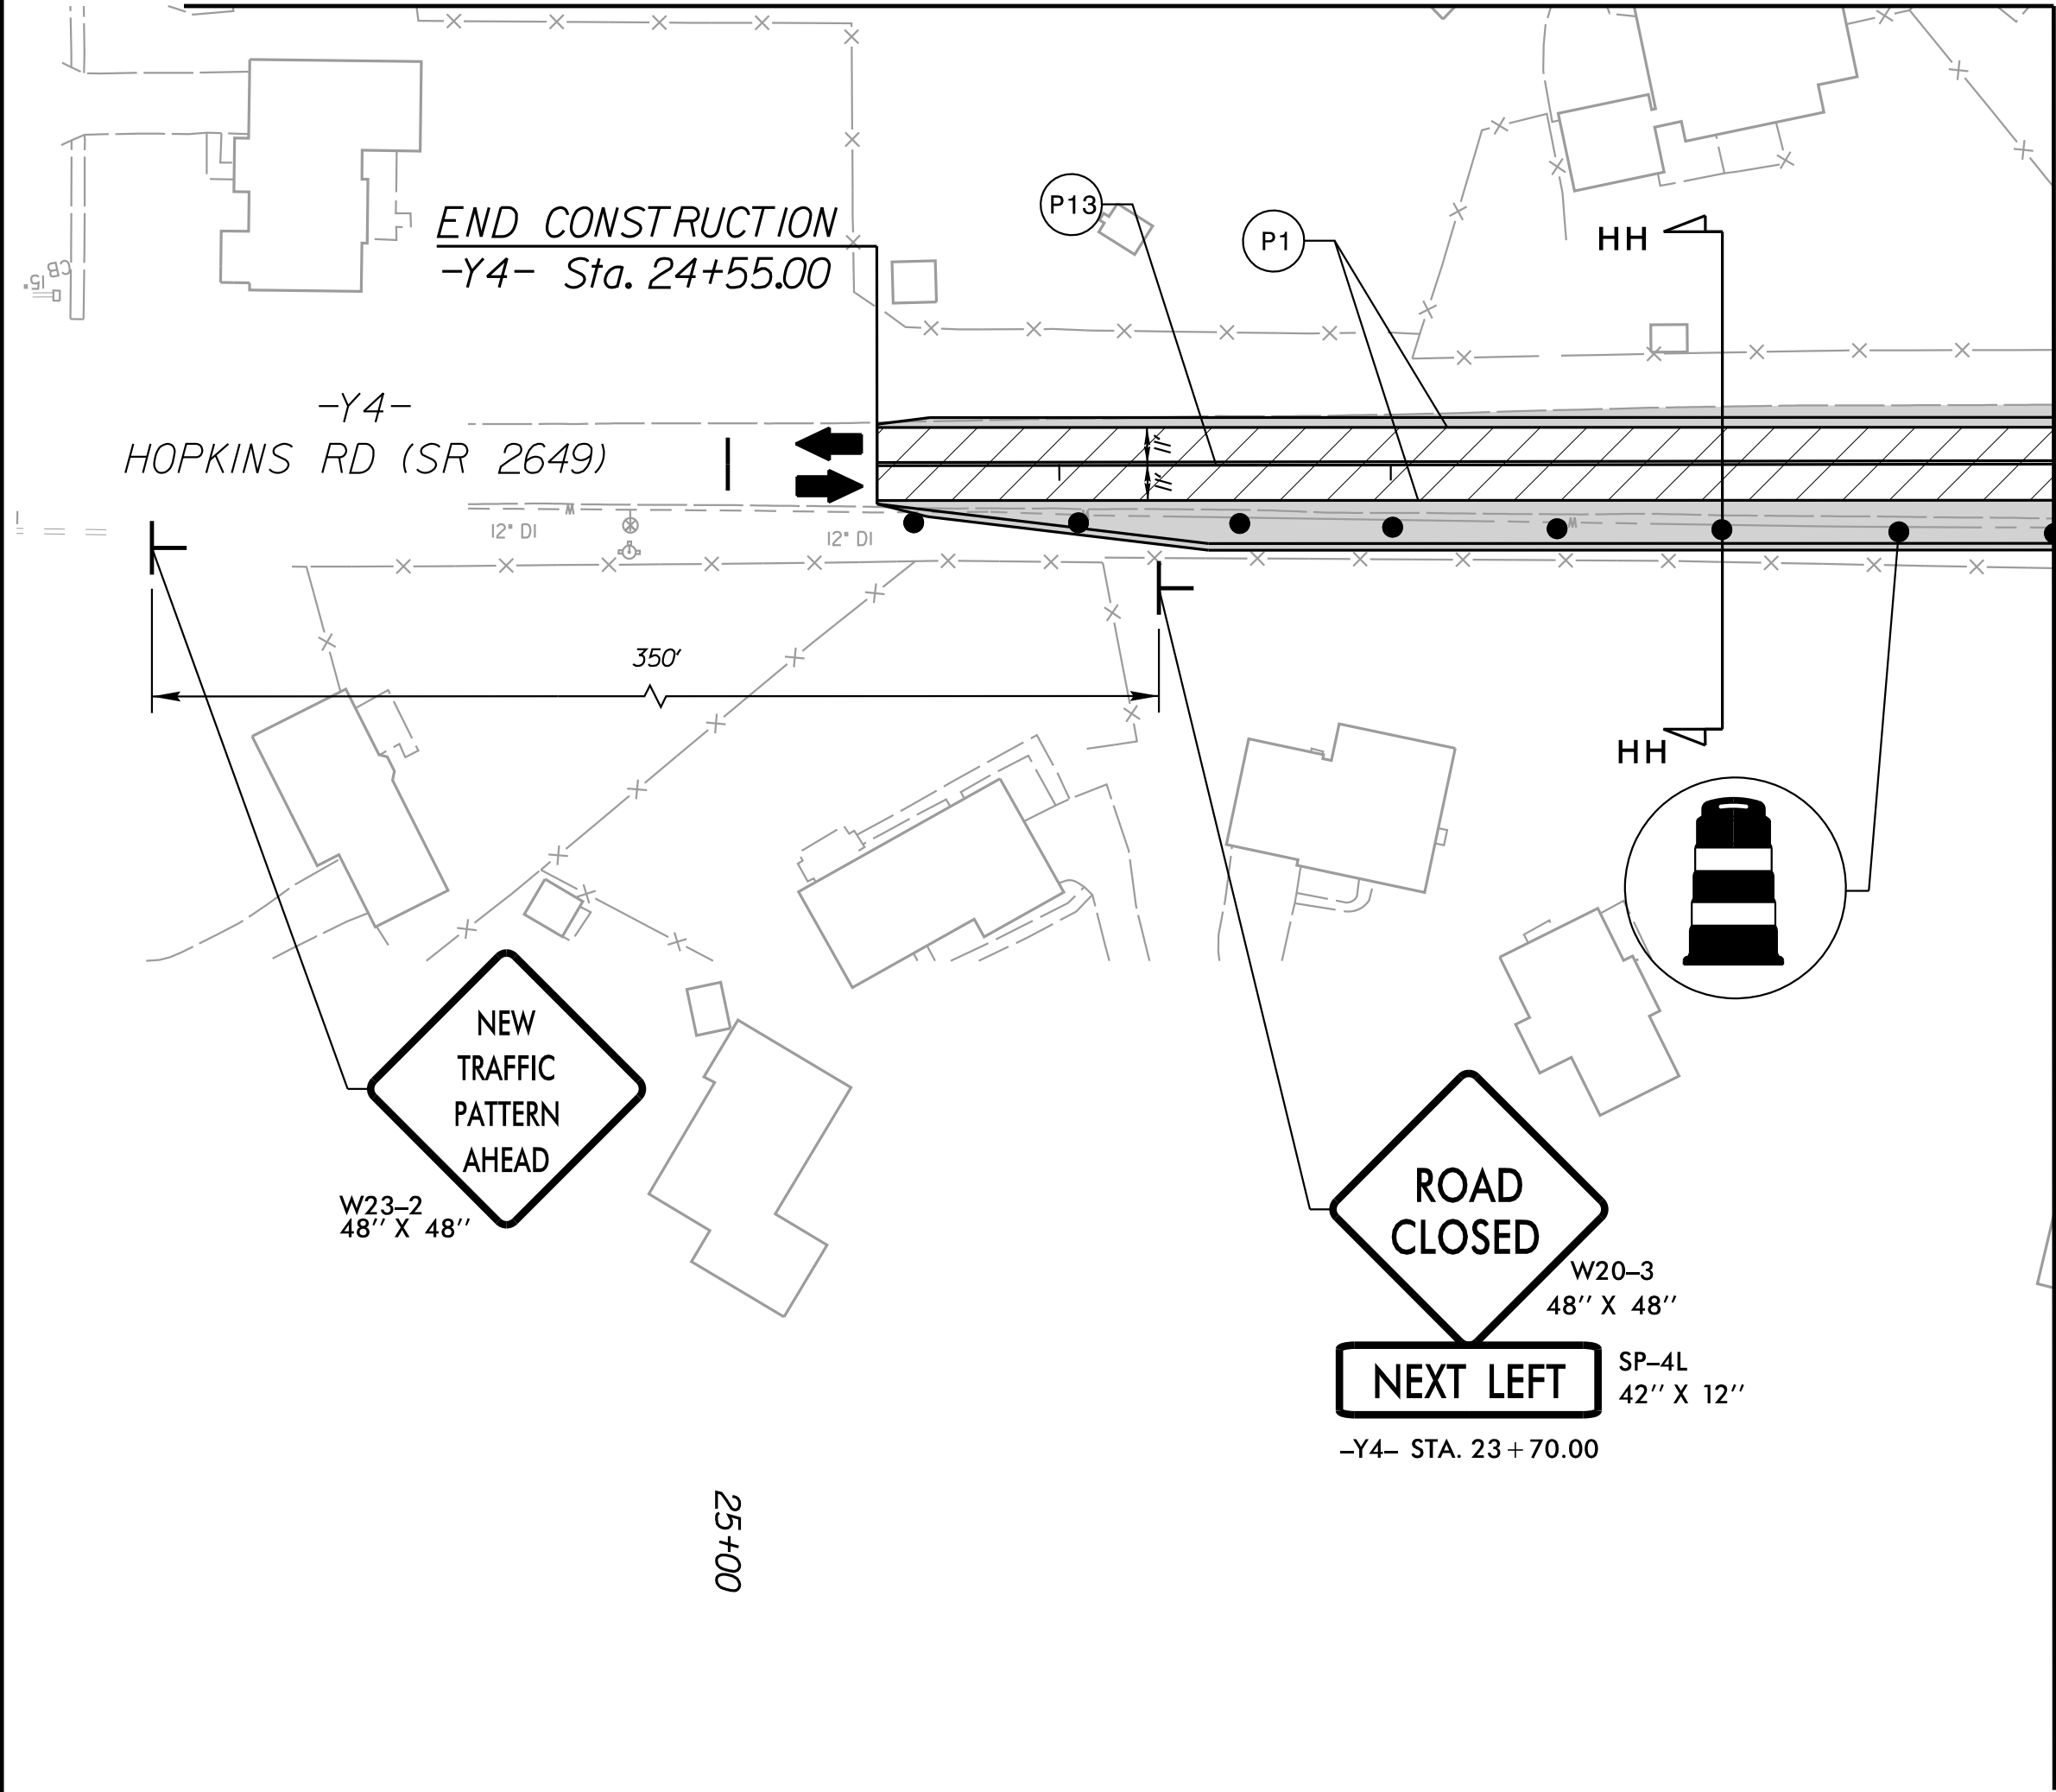

NAD 83/NA 2011

- PAVEMENT REMOVAL
- WORK AREA
- WEDGING

APPROVED: _____ DATE: _____



9/12/2025


DOCUMENT NOT CONSIDERED FINAL
UNLESS ALL SIGNATURES COMPLETED



Kimley»Horn

AREA 2
TRAFFIC CONTROL
PHASE II

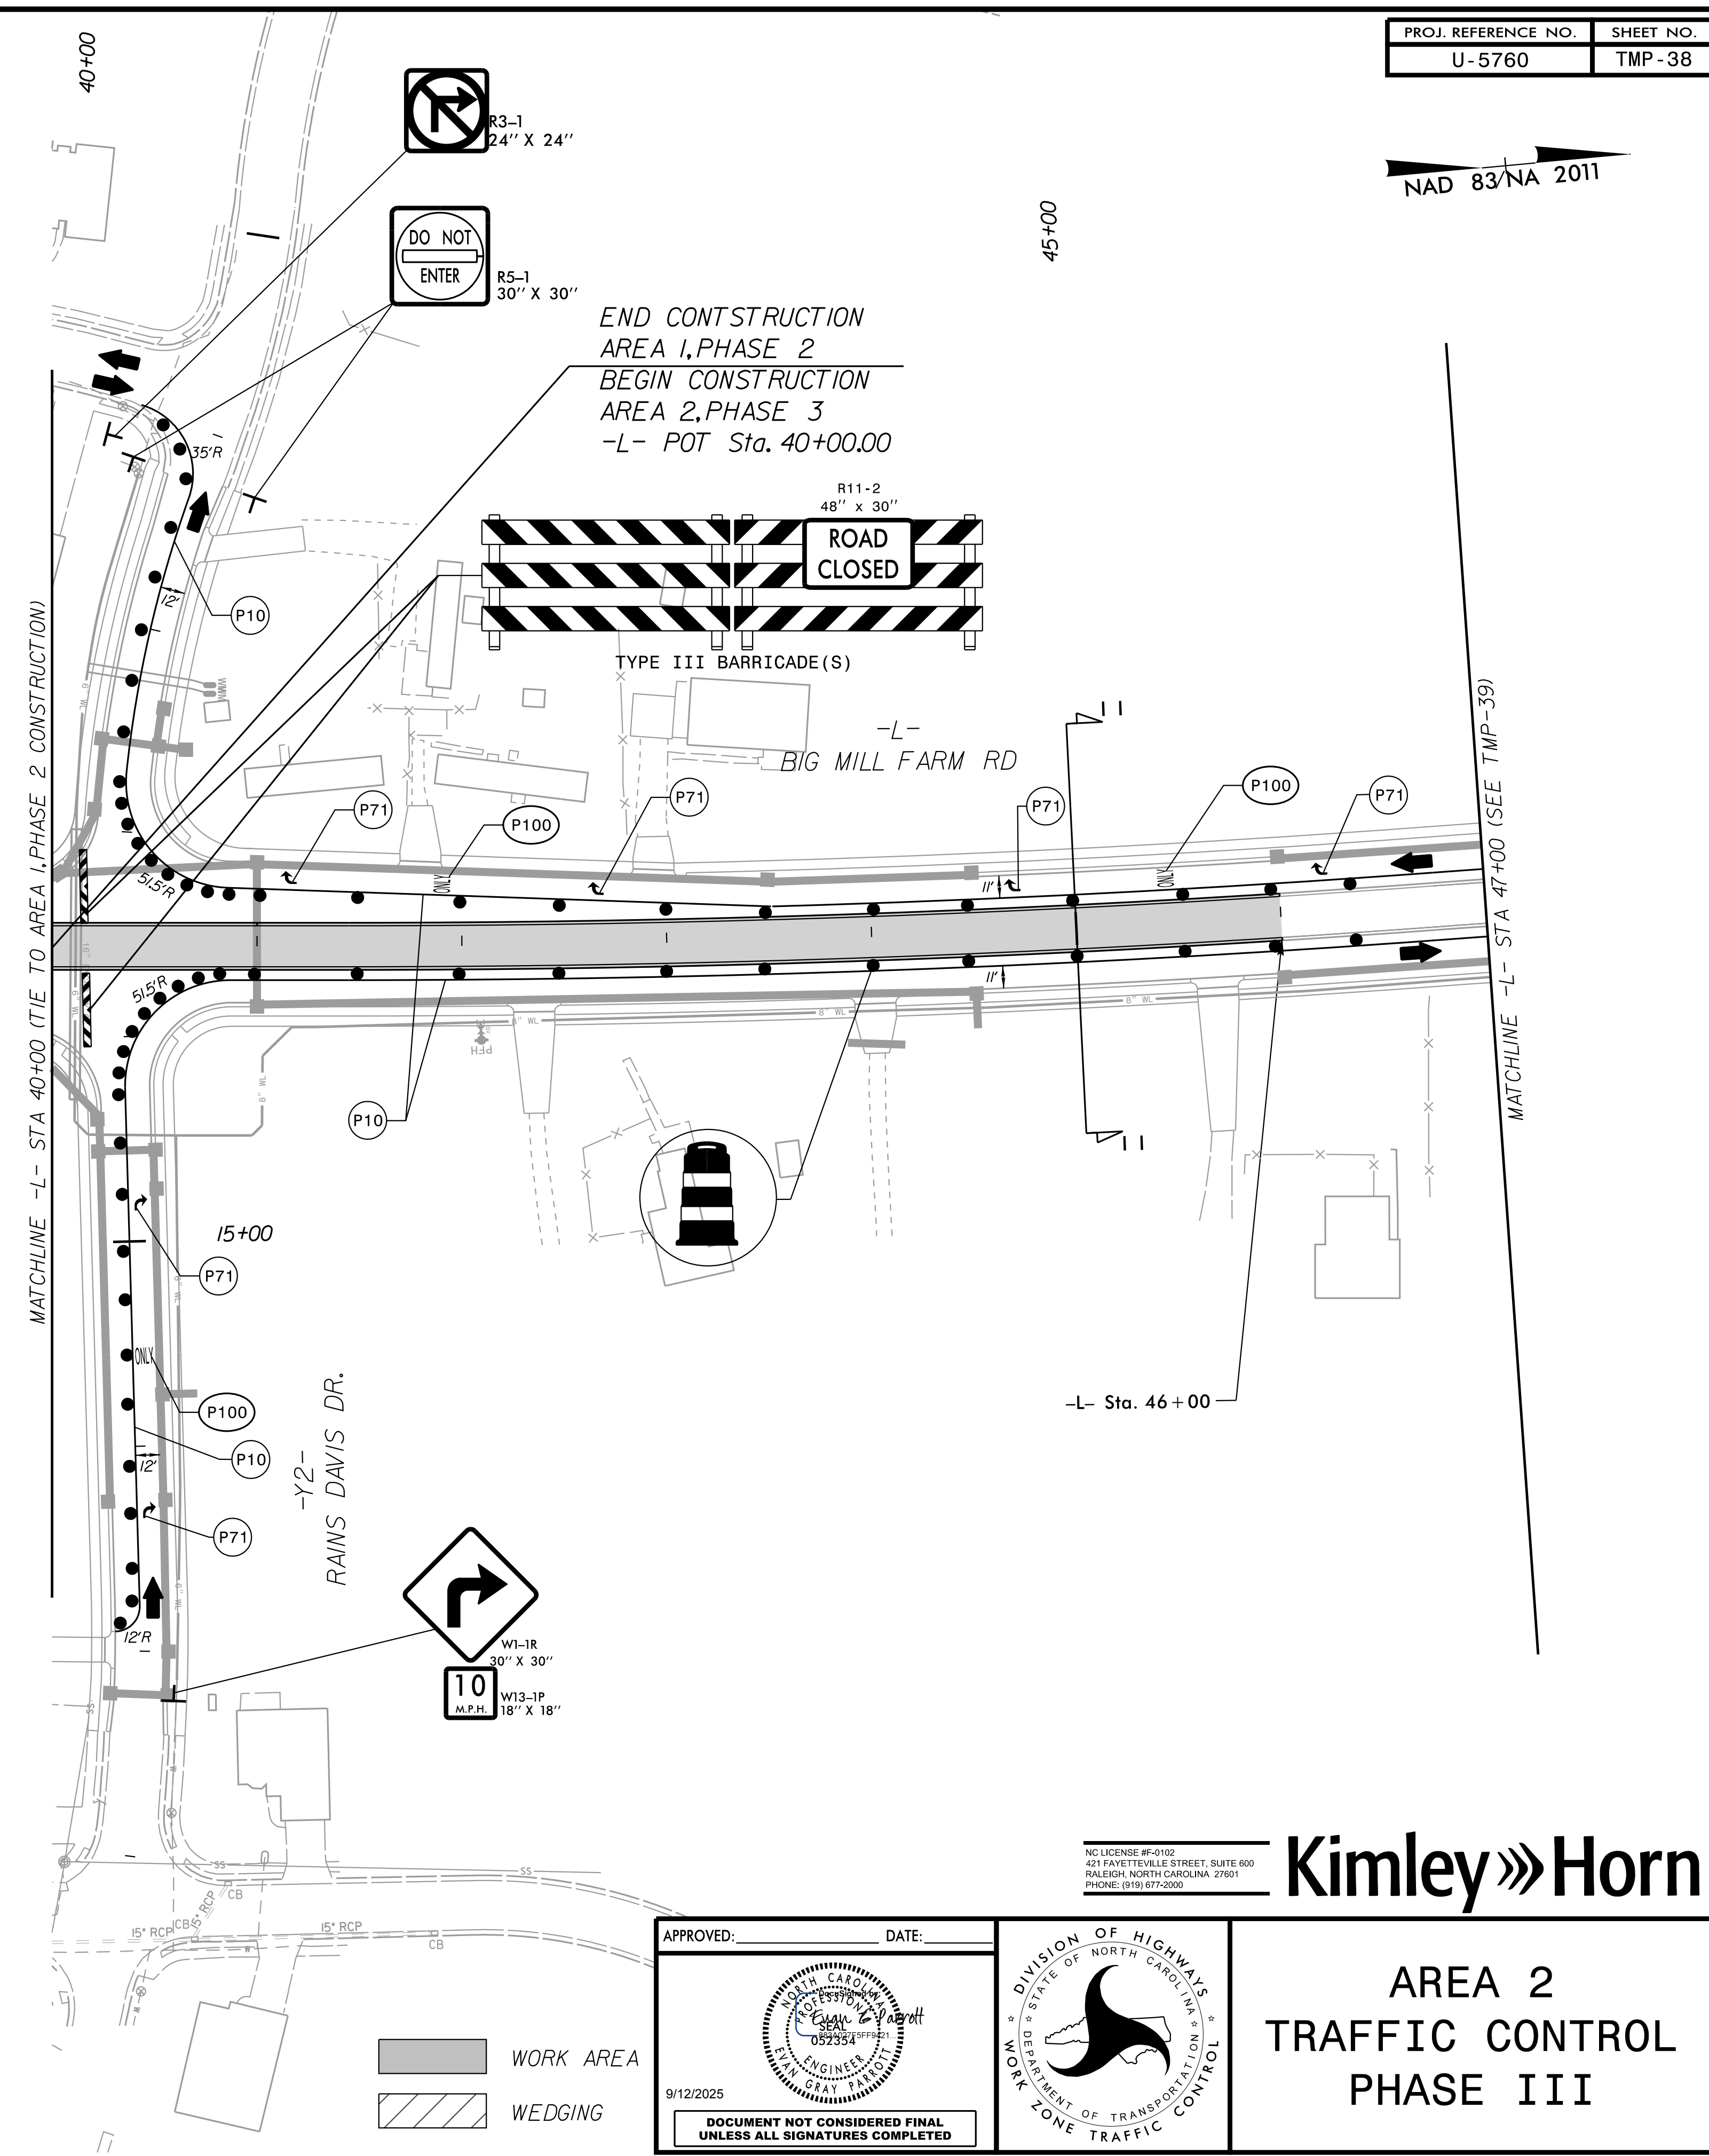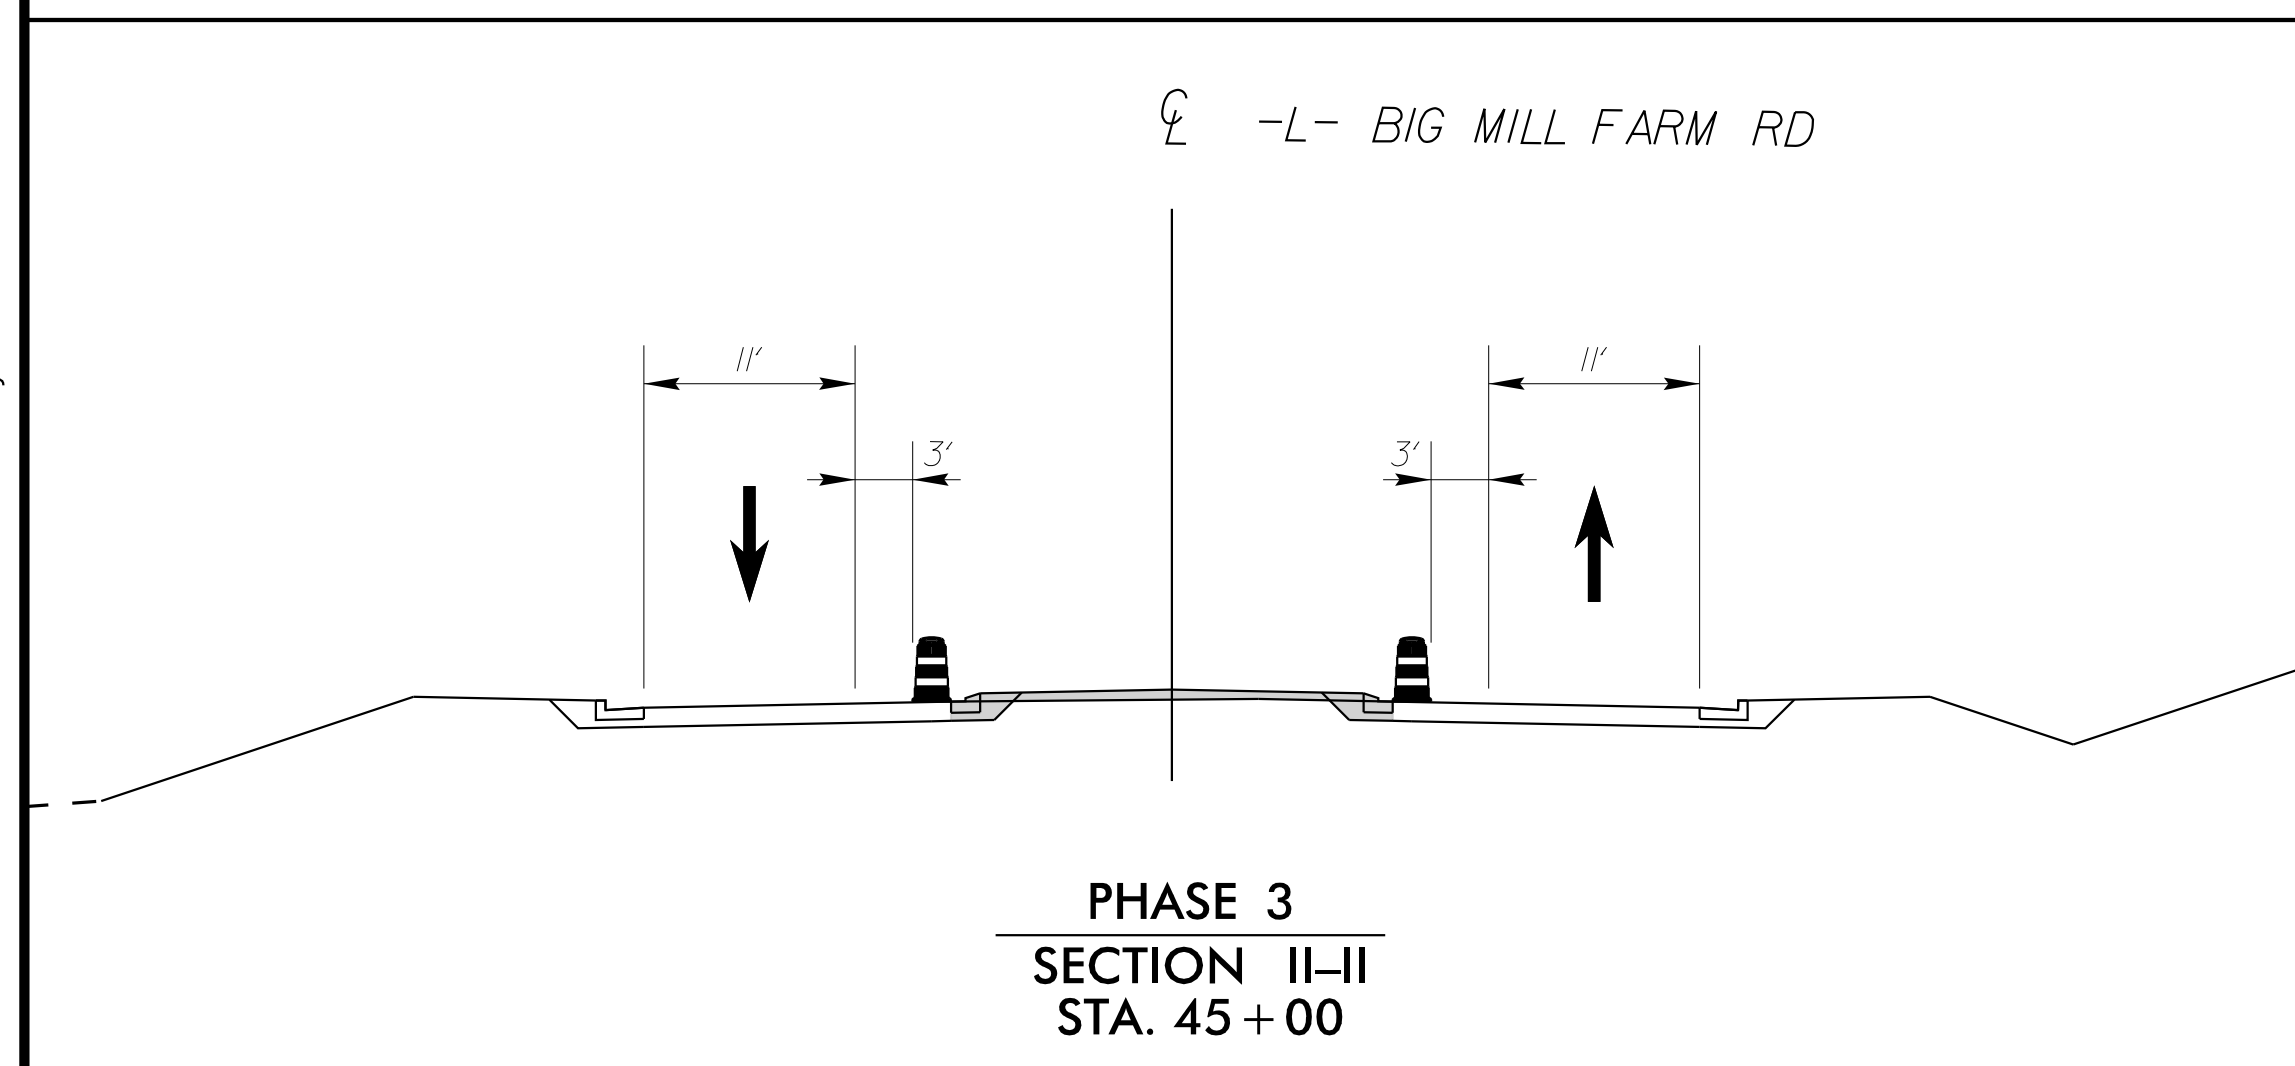

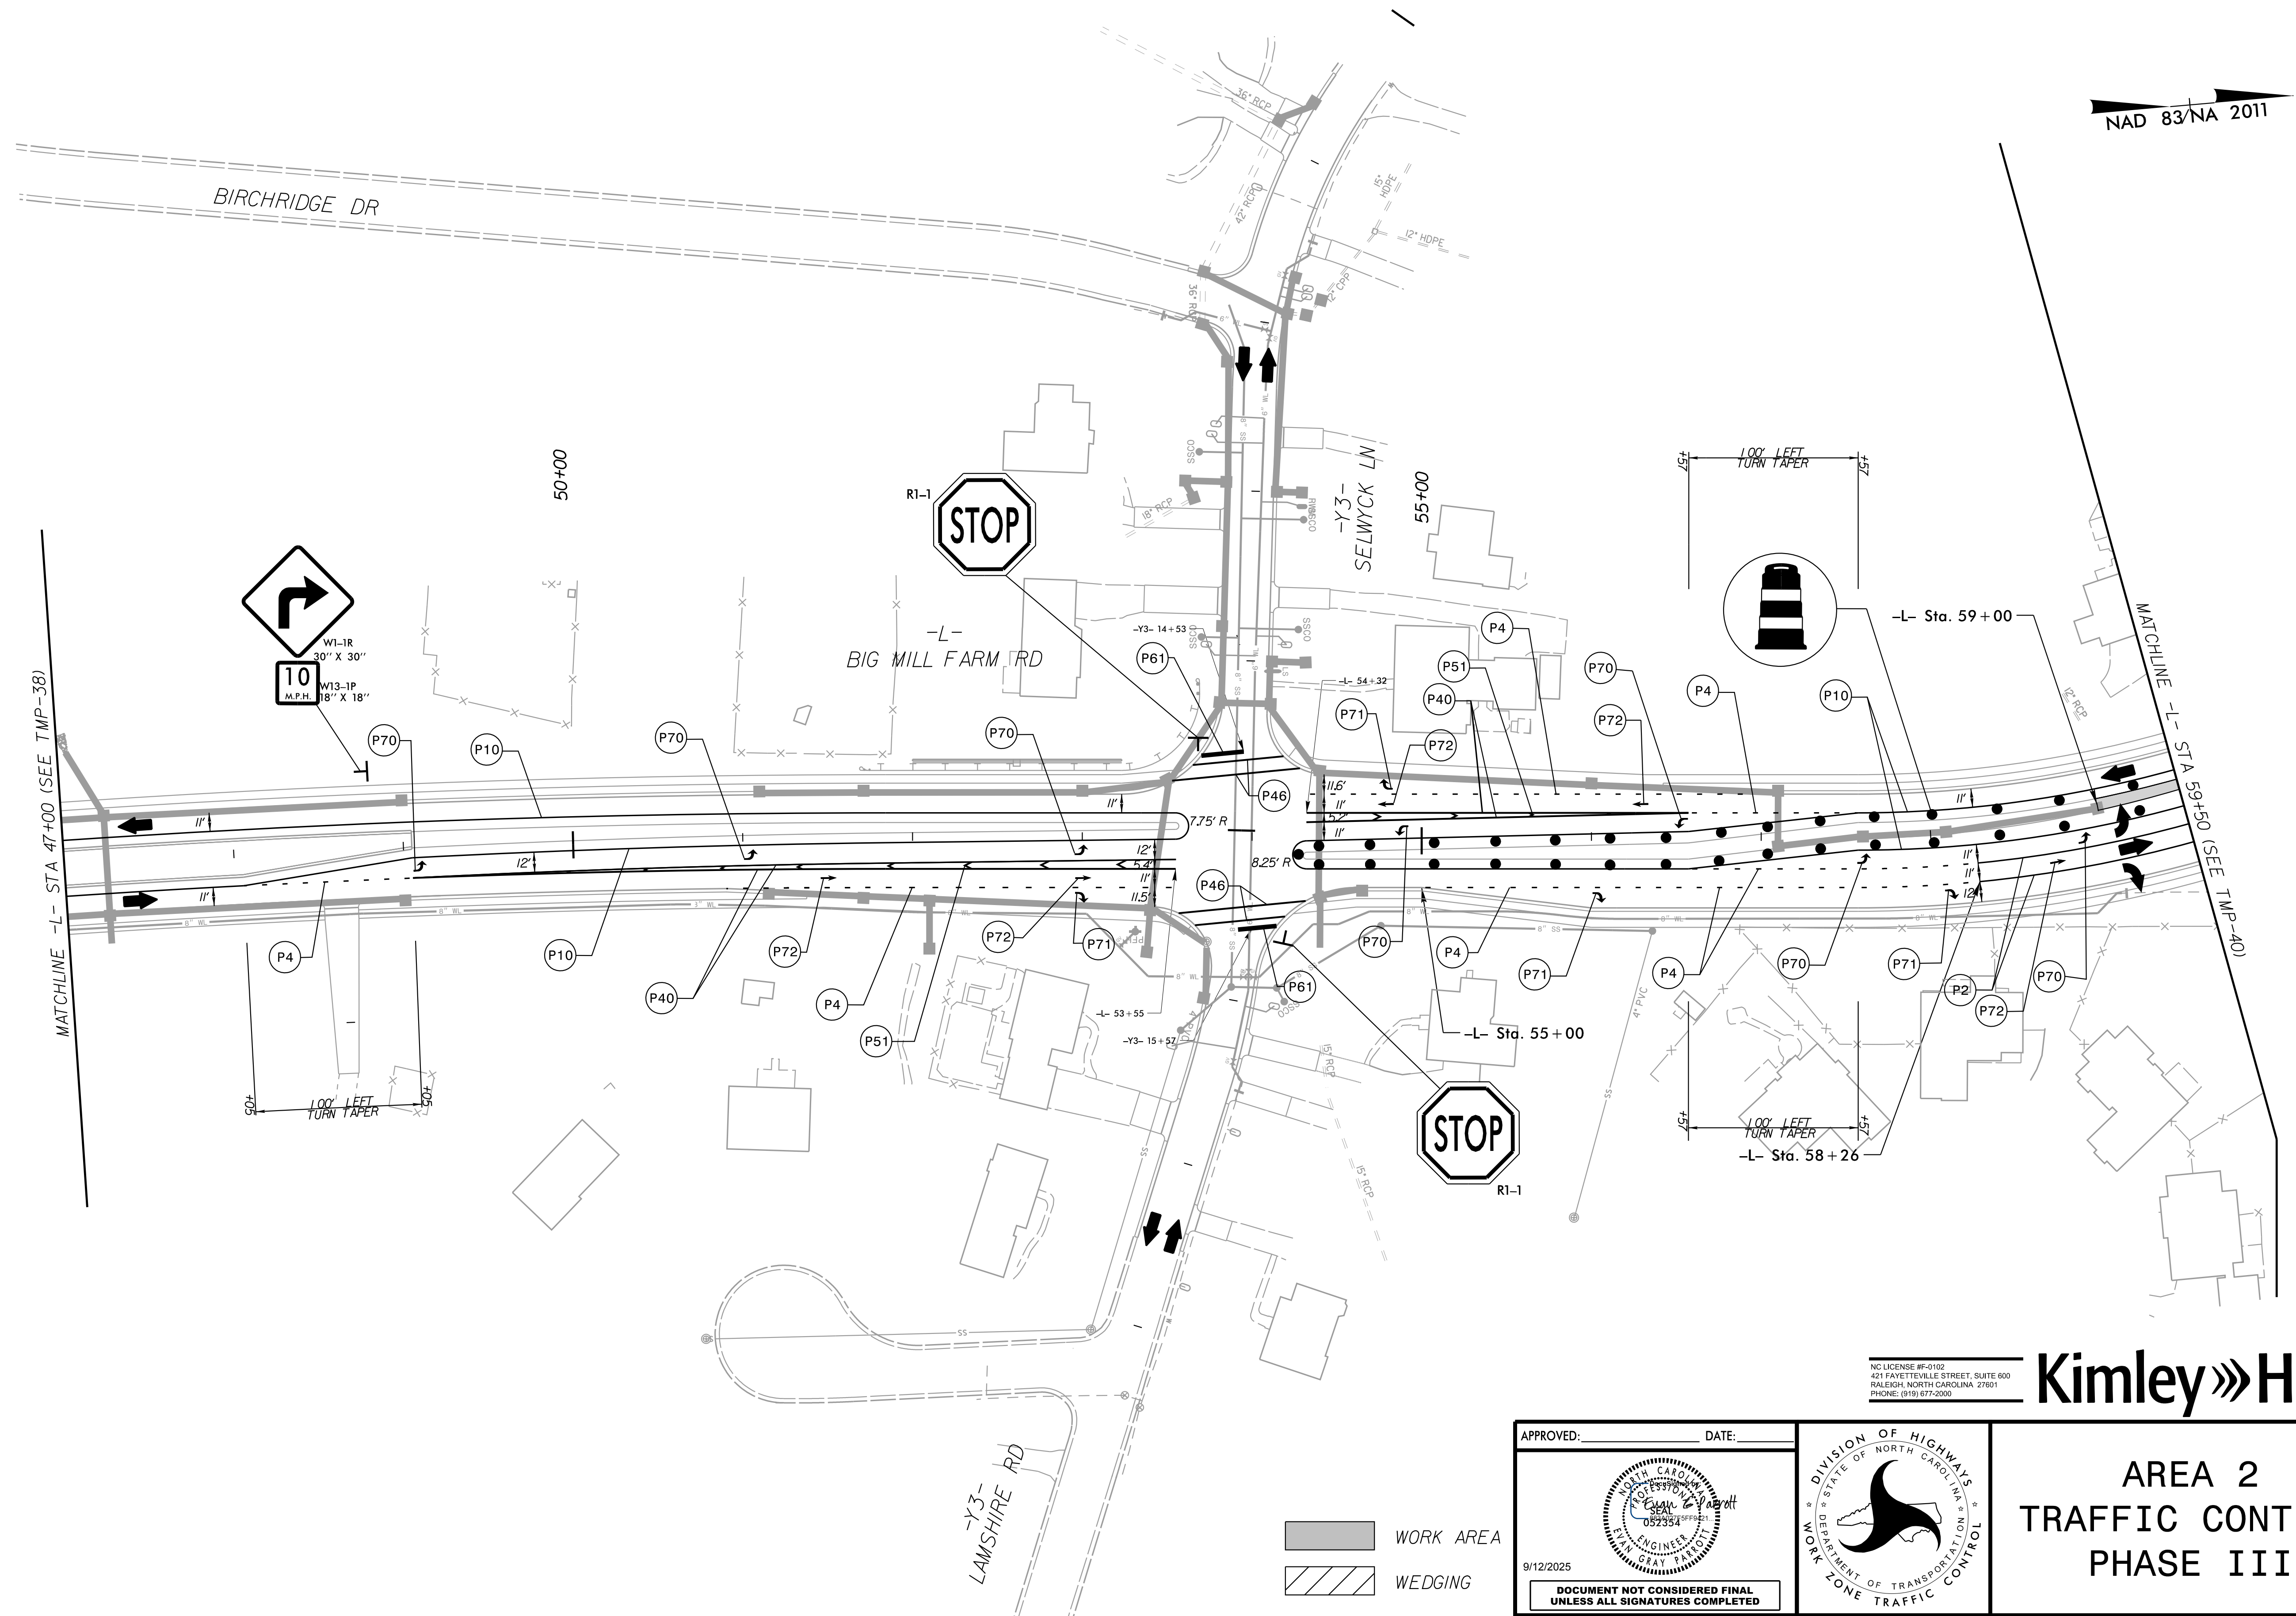

K:\RAL_Roadway\01036312 - U-5760 Big Mill Farm Road\Traffic\TrafficControl\CP\Sheets\Phase 3\U5760_top_psh39.dgn

8/5/2025

NC LICENSE #F-0102
421 FAYETTEVILLE STREET, SUITE 600
RALEIGH, NORTH CAROLINA 27601
PHONE: (919) 677-2000

Kimley»»Horn


AREA 2
TRAFFIC CONTROL
PHASE III


APPROVED: _____ DATE: _____



9/12/2025

**DOCUMENT NOT CONSIDERED FINAL
UNLESS ALL SIGNATURES COMPLETED**

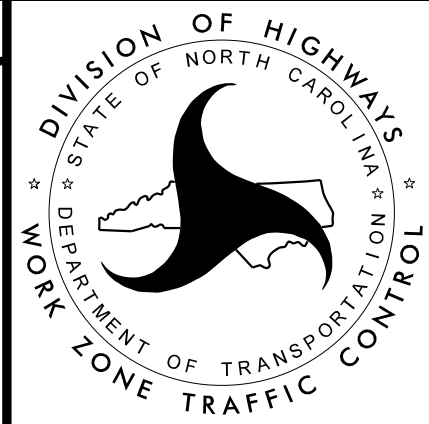

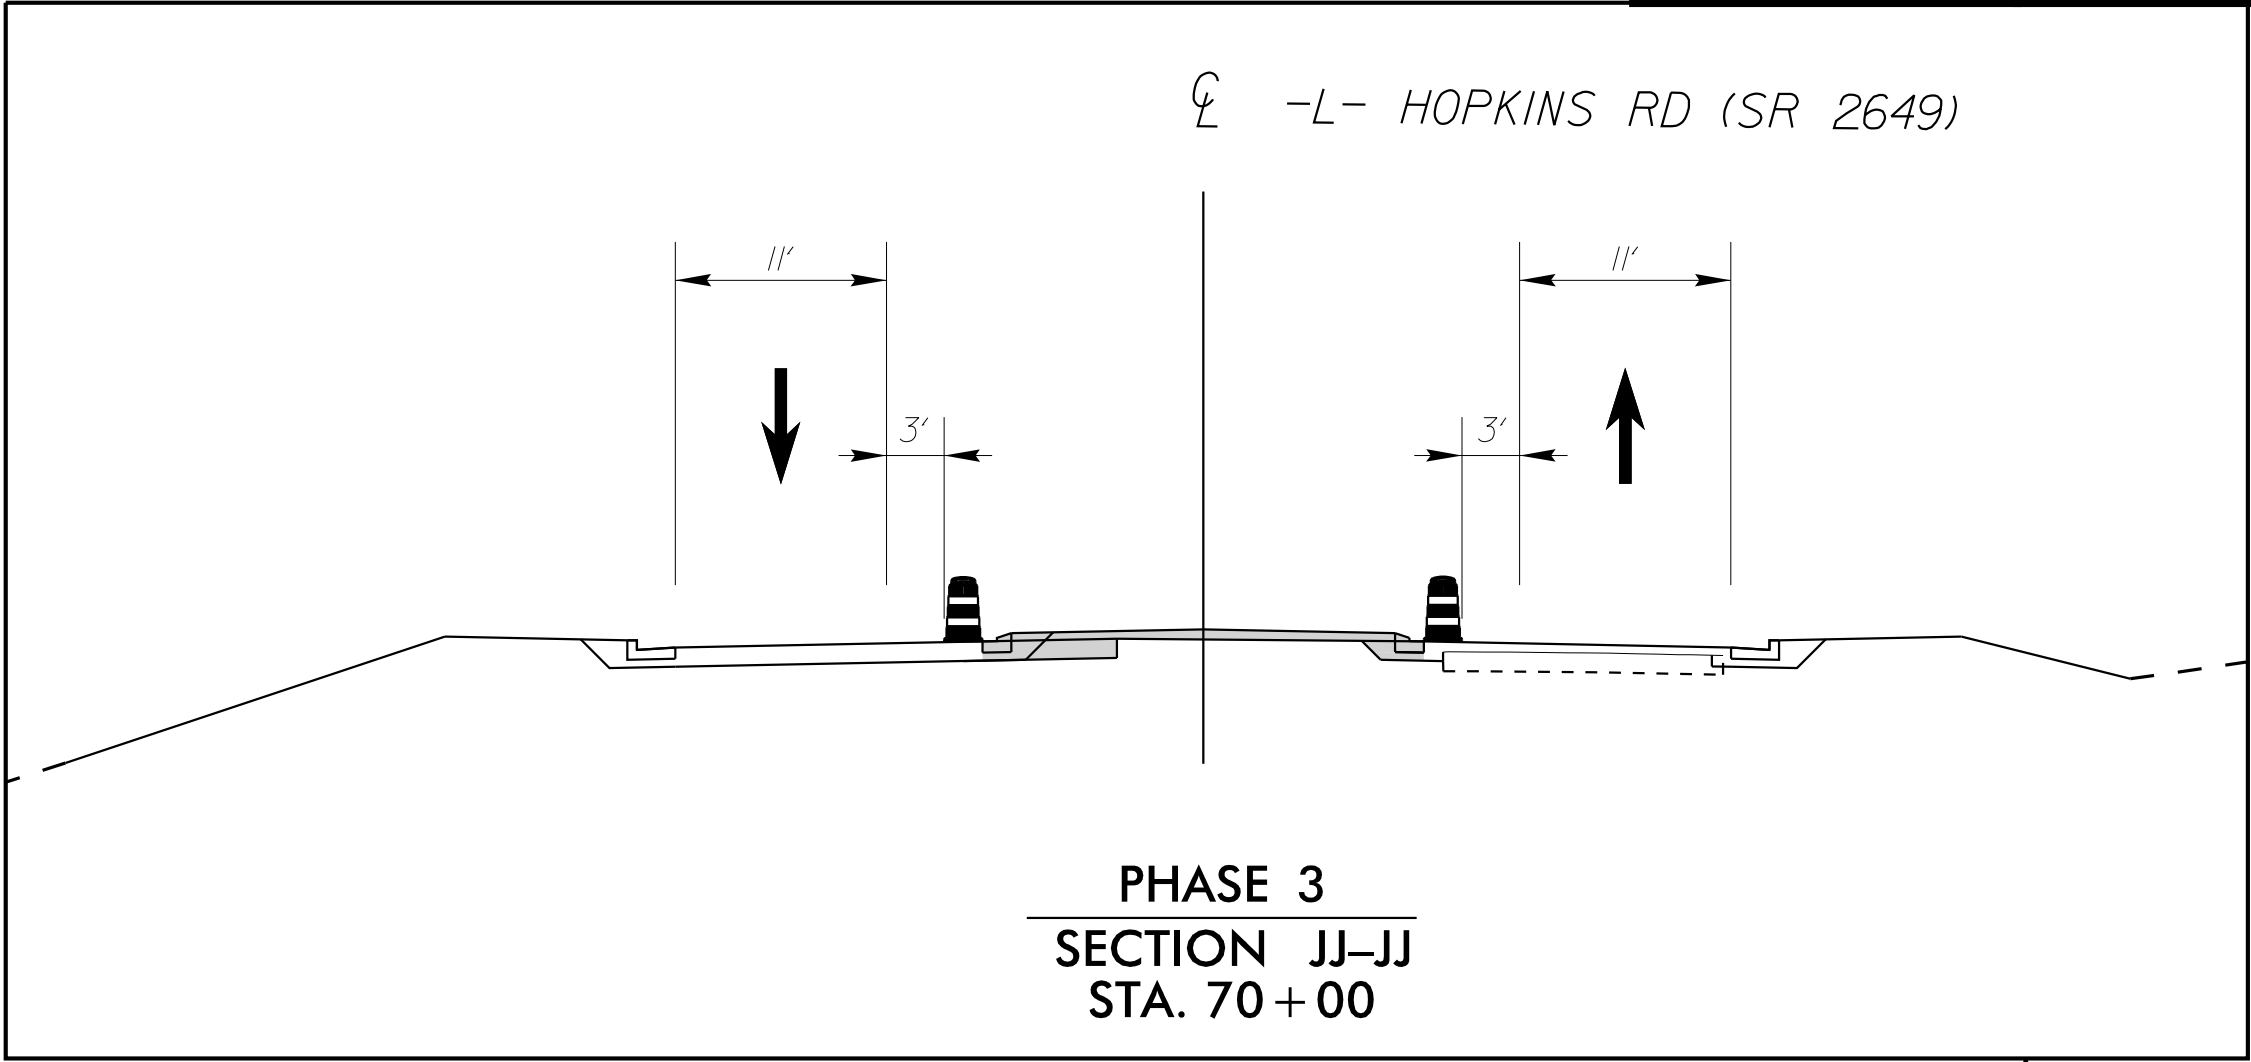

8/5/2025

UPON COMPLETION OF PROPOSED MONOLITHIC ISLAND AND REQUIRED CONCRETE CURE TIME, INSTALL PAINT VERSION OF FINAL CROSSWALKS AND OPEN TO PEDESTRIANS

NC LICENSE #F-0102
421 FAYETTEVILLE STREET, SUITE 600
RALEIGH, NORTH CAROLINA 27601
PHONE: (919) 677-2000

Kimley»»Horn


AREA 2
TRAFFIC CONTROL
PHASE III

APPROVED: _____ DATE: _____



9/12/2025




**DOCUMENT NOT CONSIDERED FINAL
UNLESS ALL SIGNATURES COMPLETED**

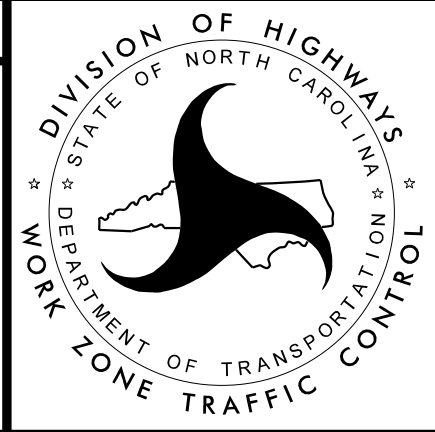

 WORK AREA

 WEDGING

PROJ. REFERENCE NO.	SHEET NO.
U-5760	TMP-41

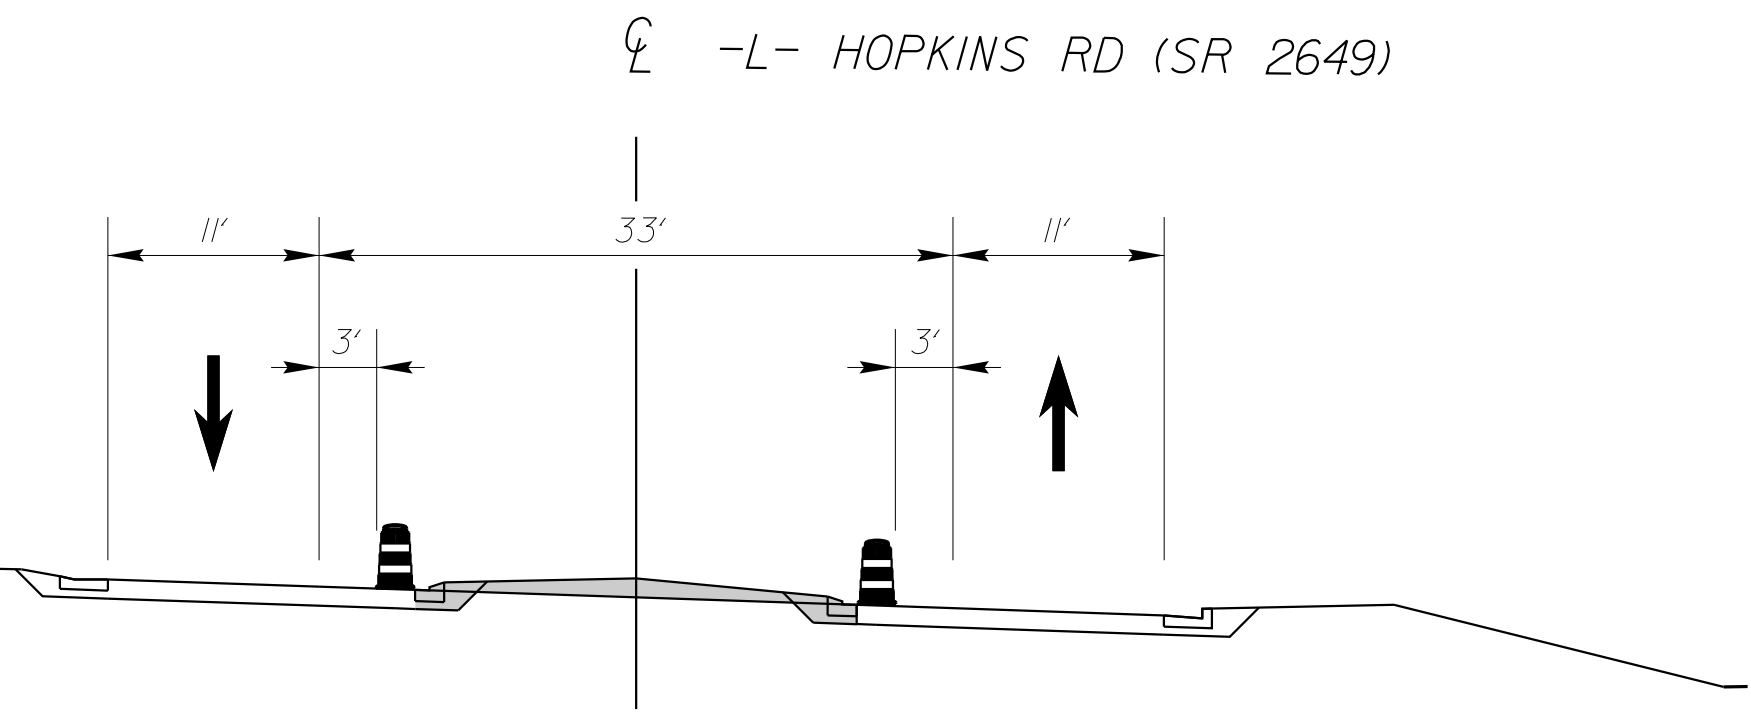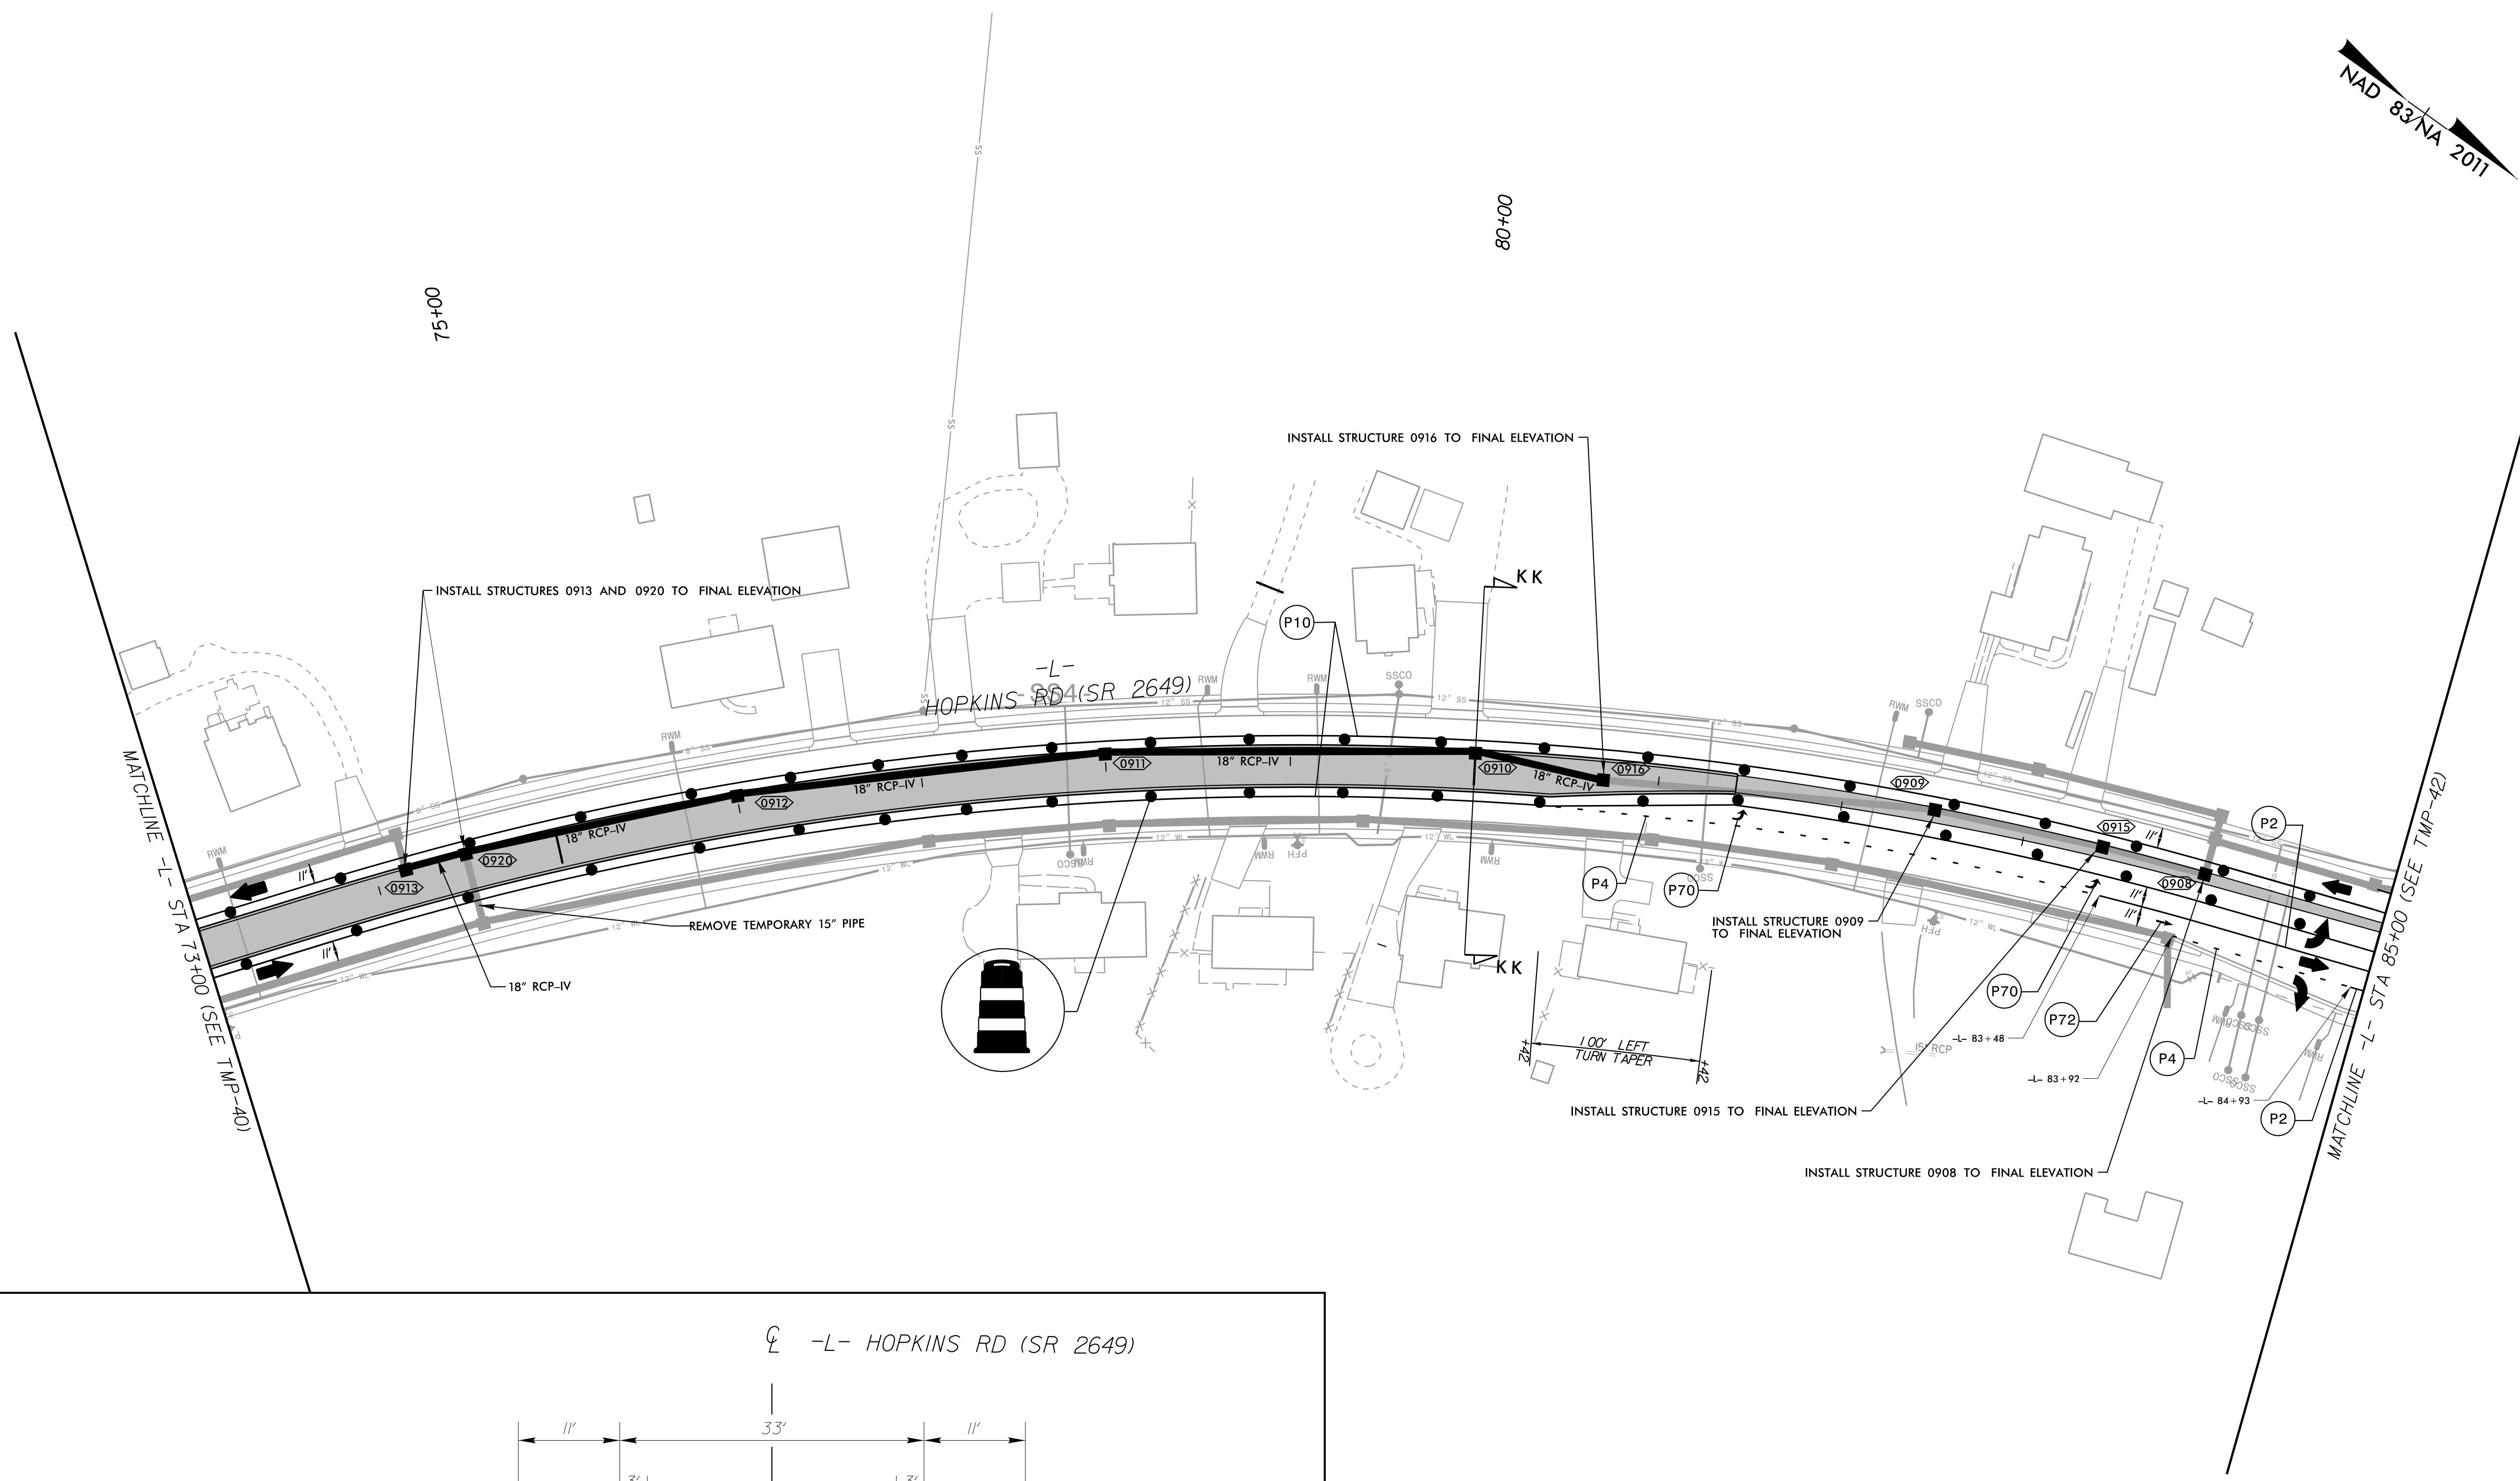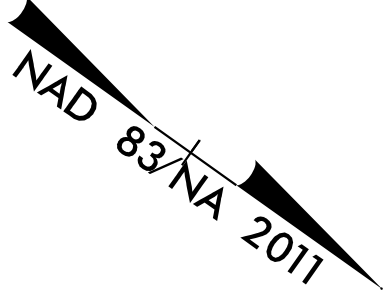


PHASE 3
SECTION KK-KK
STA. 80+00

- WORK AREA
- WEDGING

APPROVED: _____ DATE: _____

9/12/2025


DOCUMENT NOT CONSIDERED FINAL
UNLESS ALL SIGNATURES COMPLETED

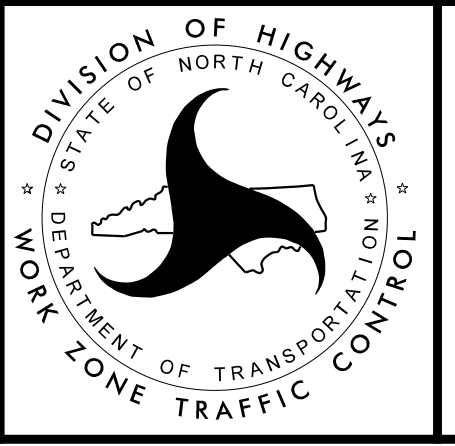

Kimley»Horn



AREA 2
TRAFFIC CONTROL
PHASE III

PROJ. REFERENCE NO.	SHEET NO.
U-5760	TMP-42

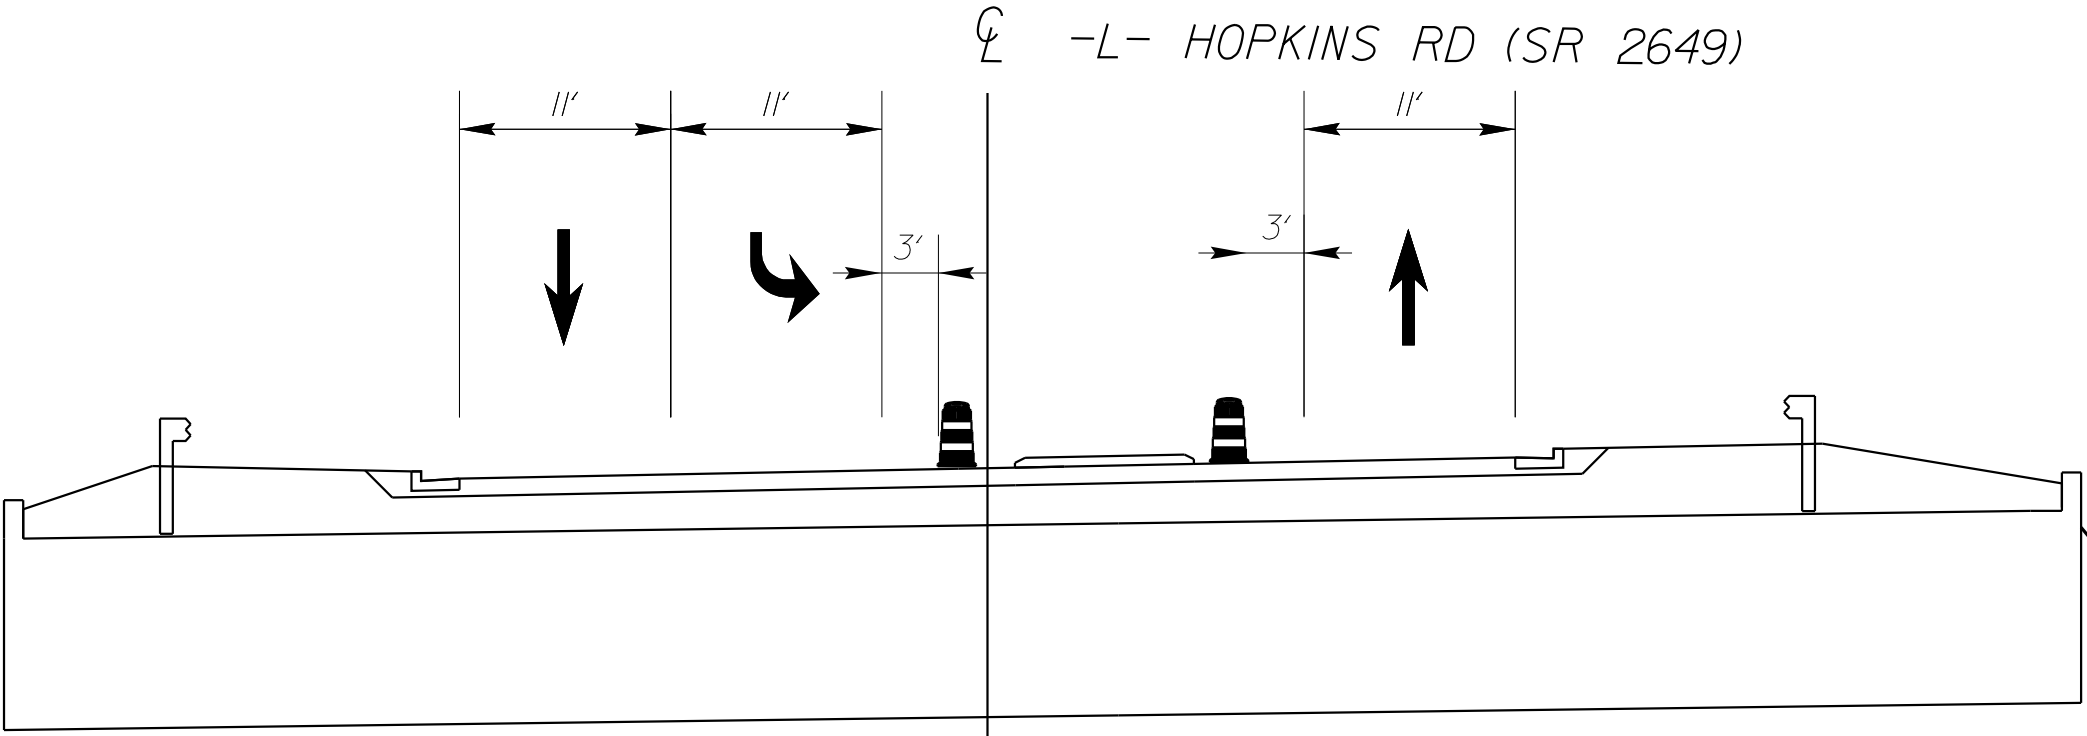


PHASE 3
SECTION LL-LL
STA. 91+00

95+00

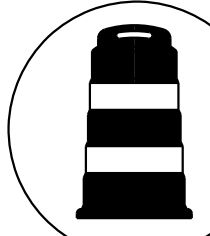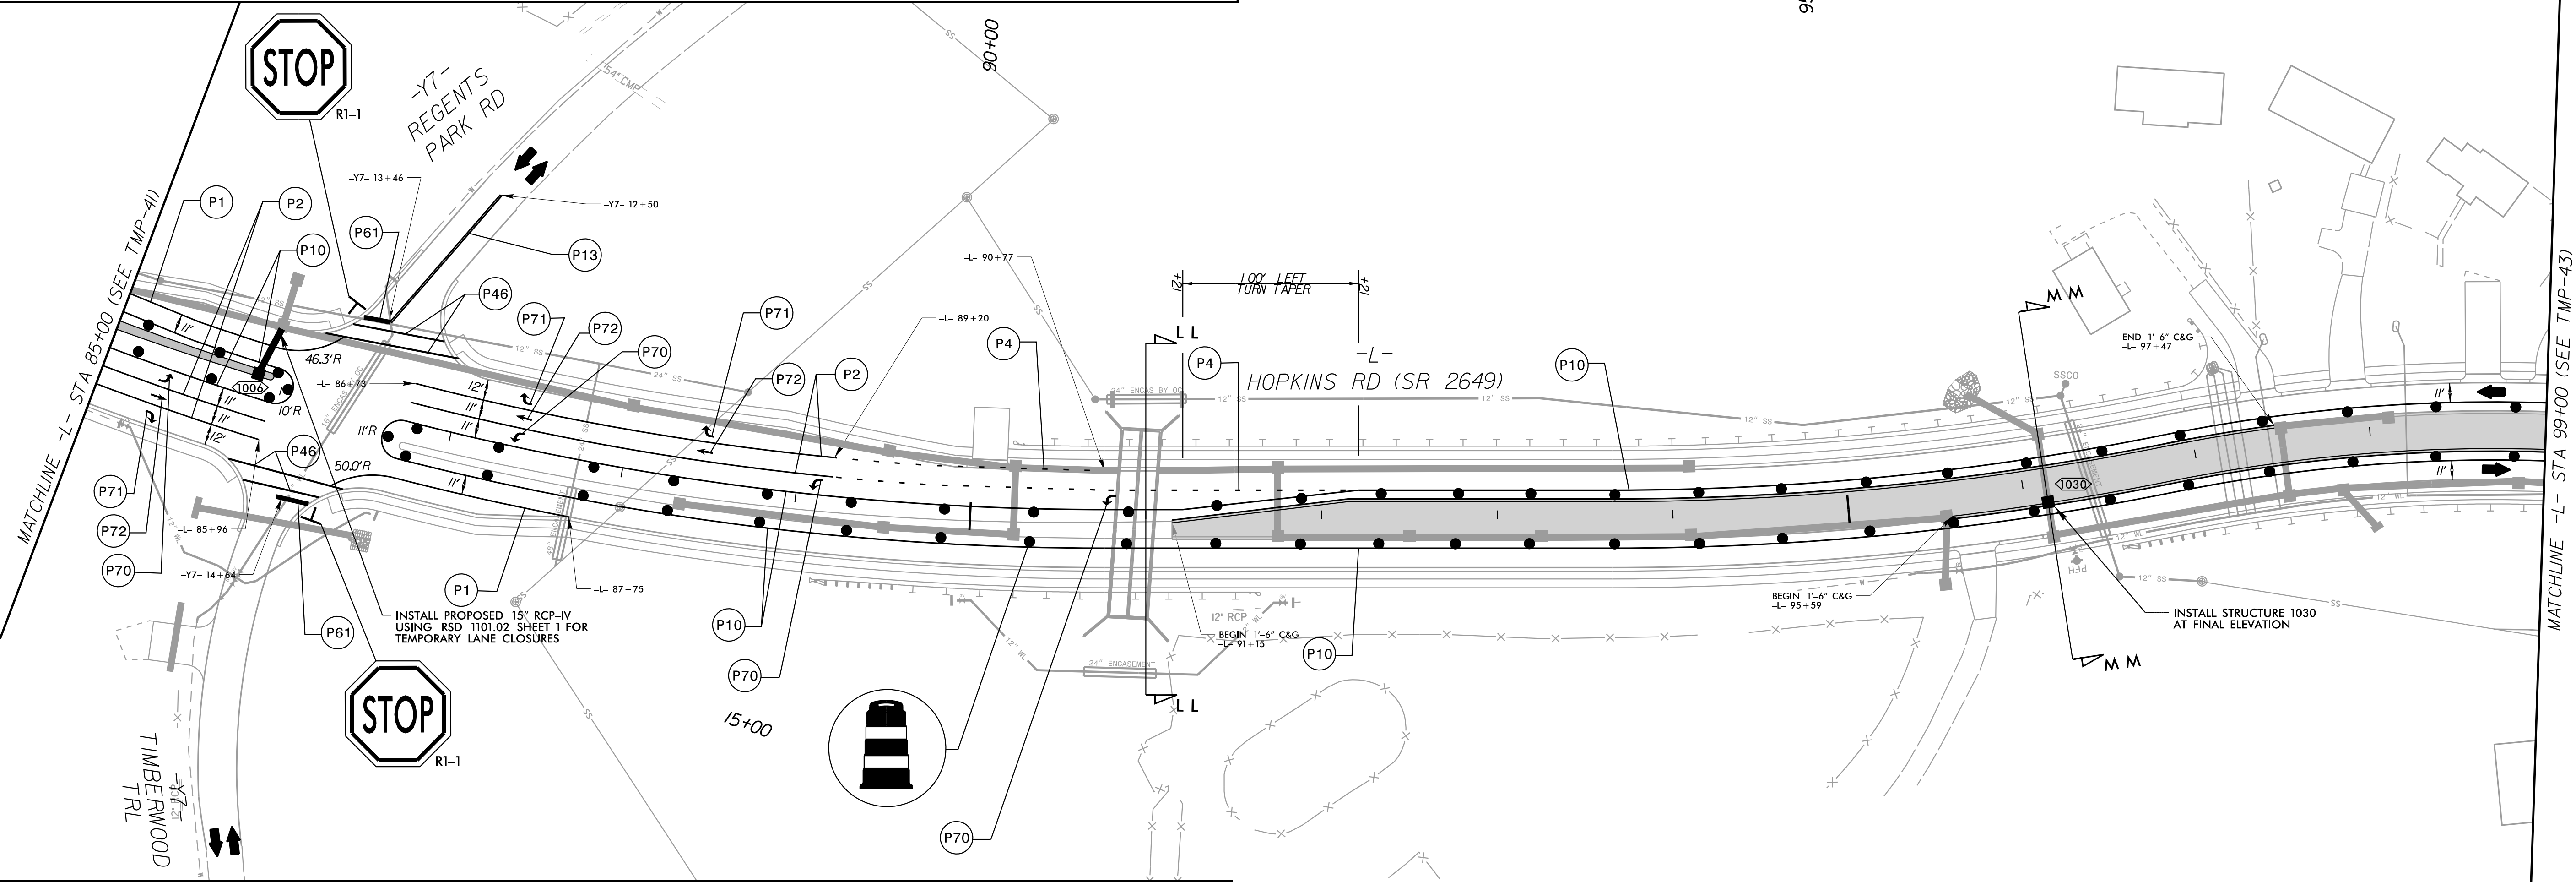

-L- HOPKINS RD (SR 2649)

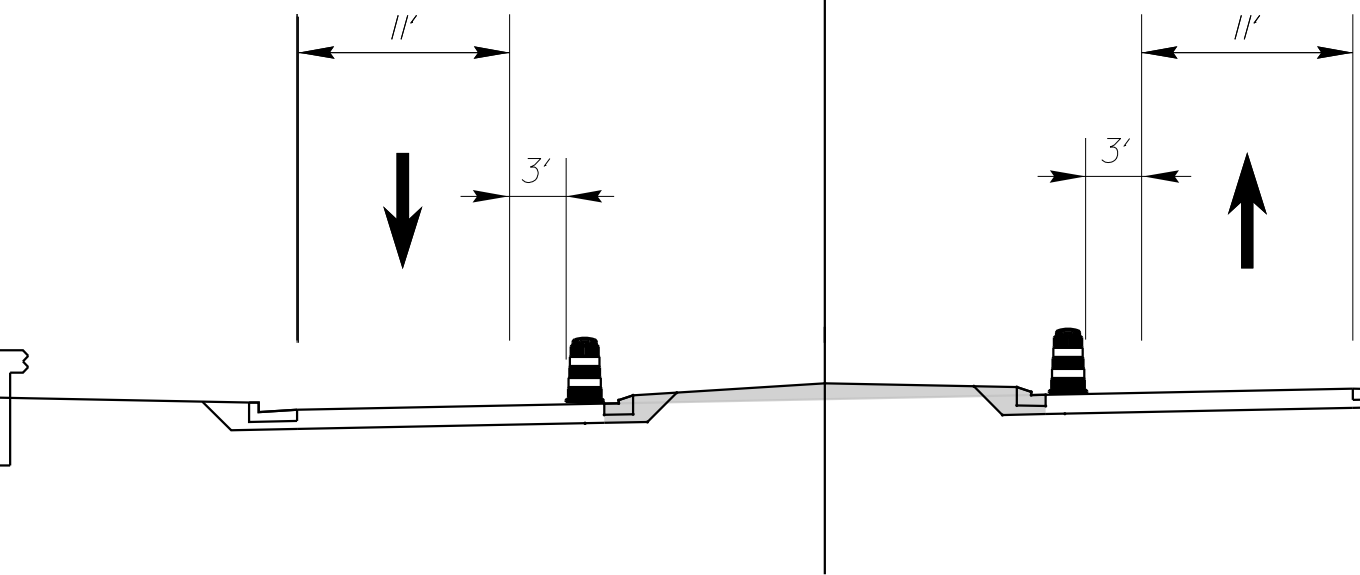


PHASE 3
SECTION MM-MM
STA. 96+13

- WORK AREA
- WEDGING

APPROVED: _____ DATE: _____

9/12/2025

DOCUMENT NOT CONSIDERED FINAL
UNLESS ALL SIGNATURES COMPLETED

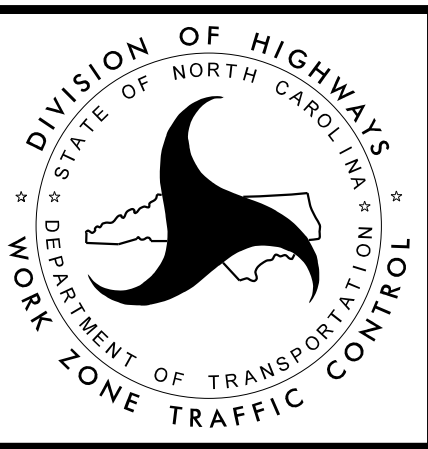


Kimley»Horn

AREA 2
TRAFFIC CONTROL
PHASE III


NC LICENSE #P-0102
421 FAYETTEVILLE STREET, SUITE 600
RALEIGH, NORTH CAROLINA, 27601
PHONE: (919) 877-2000

K:\RAL_Roadway\011036312 - U-5760 Big Mill Farm Road\TrafficControl\TCP\Steels\Phase 3\U5760_top_psm42.dgn

8/5/2025

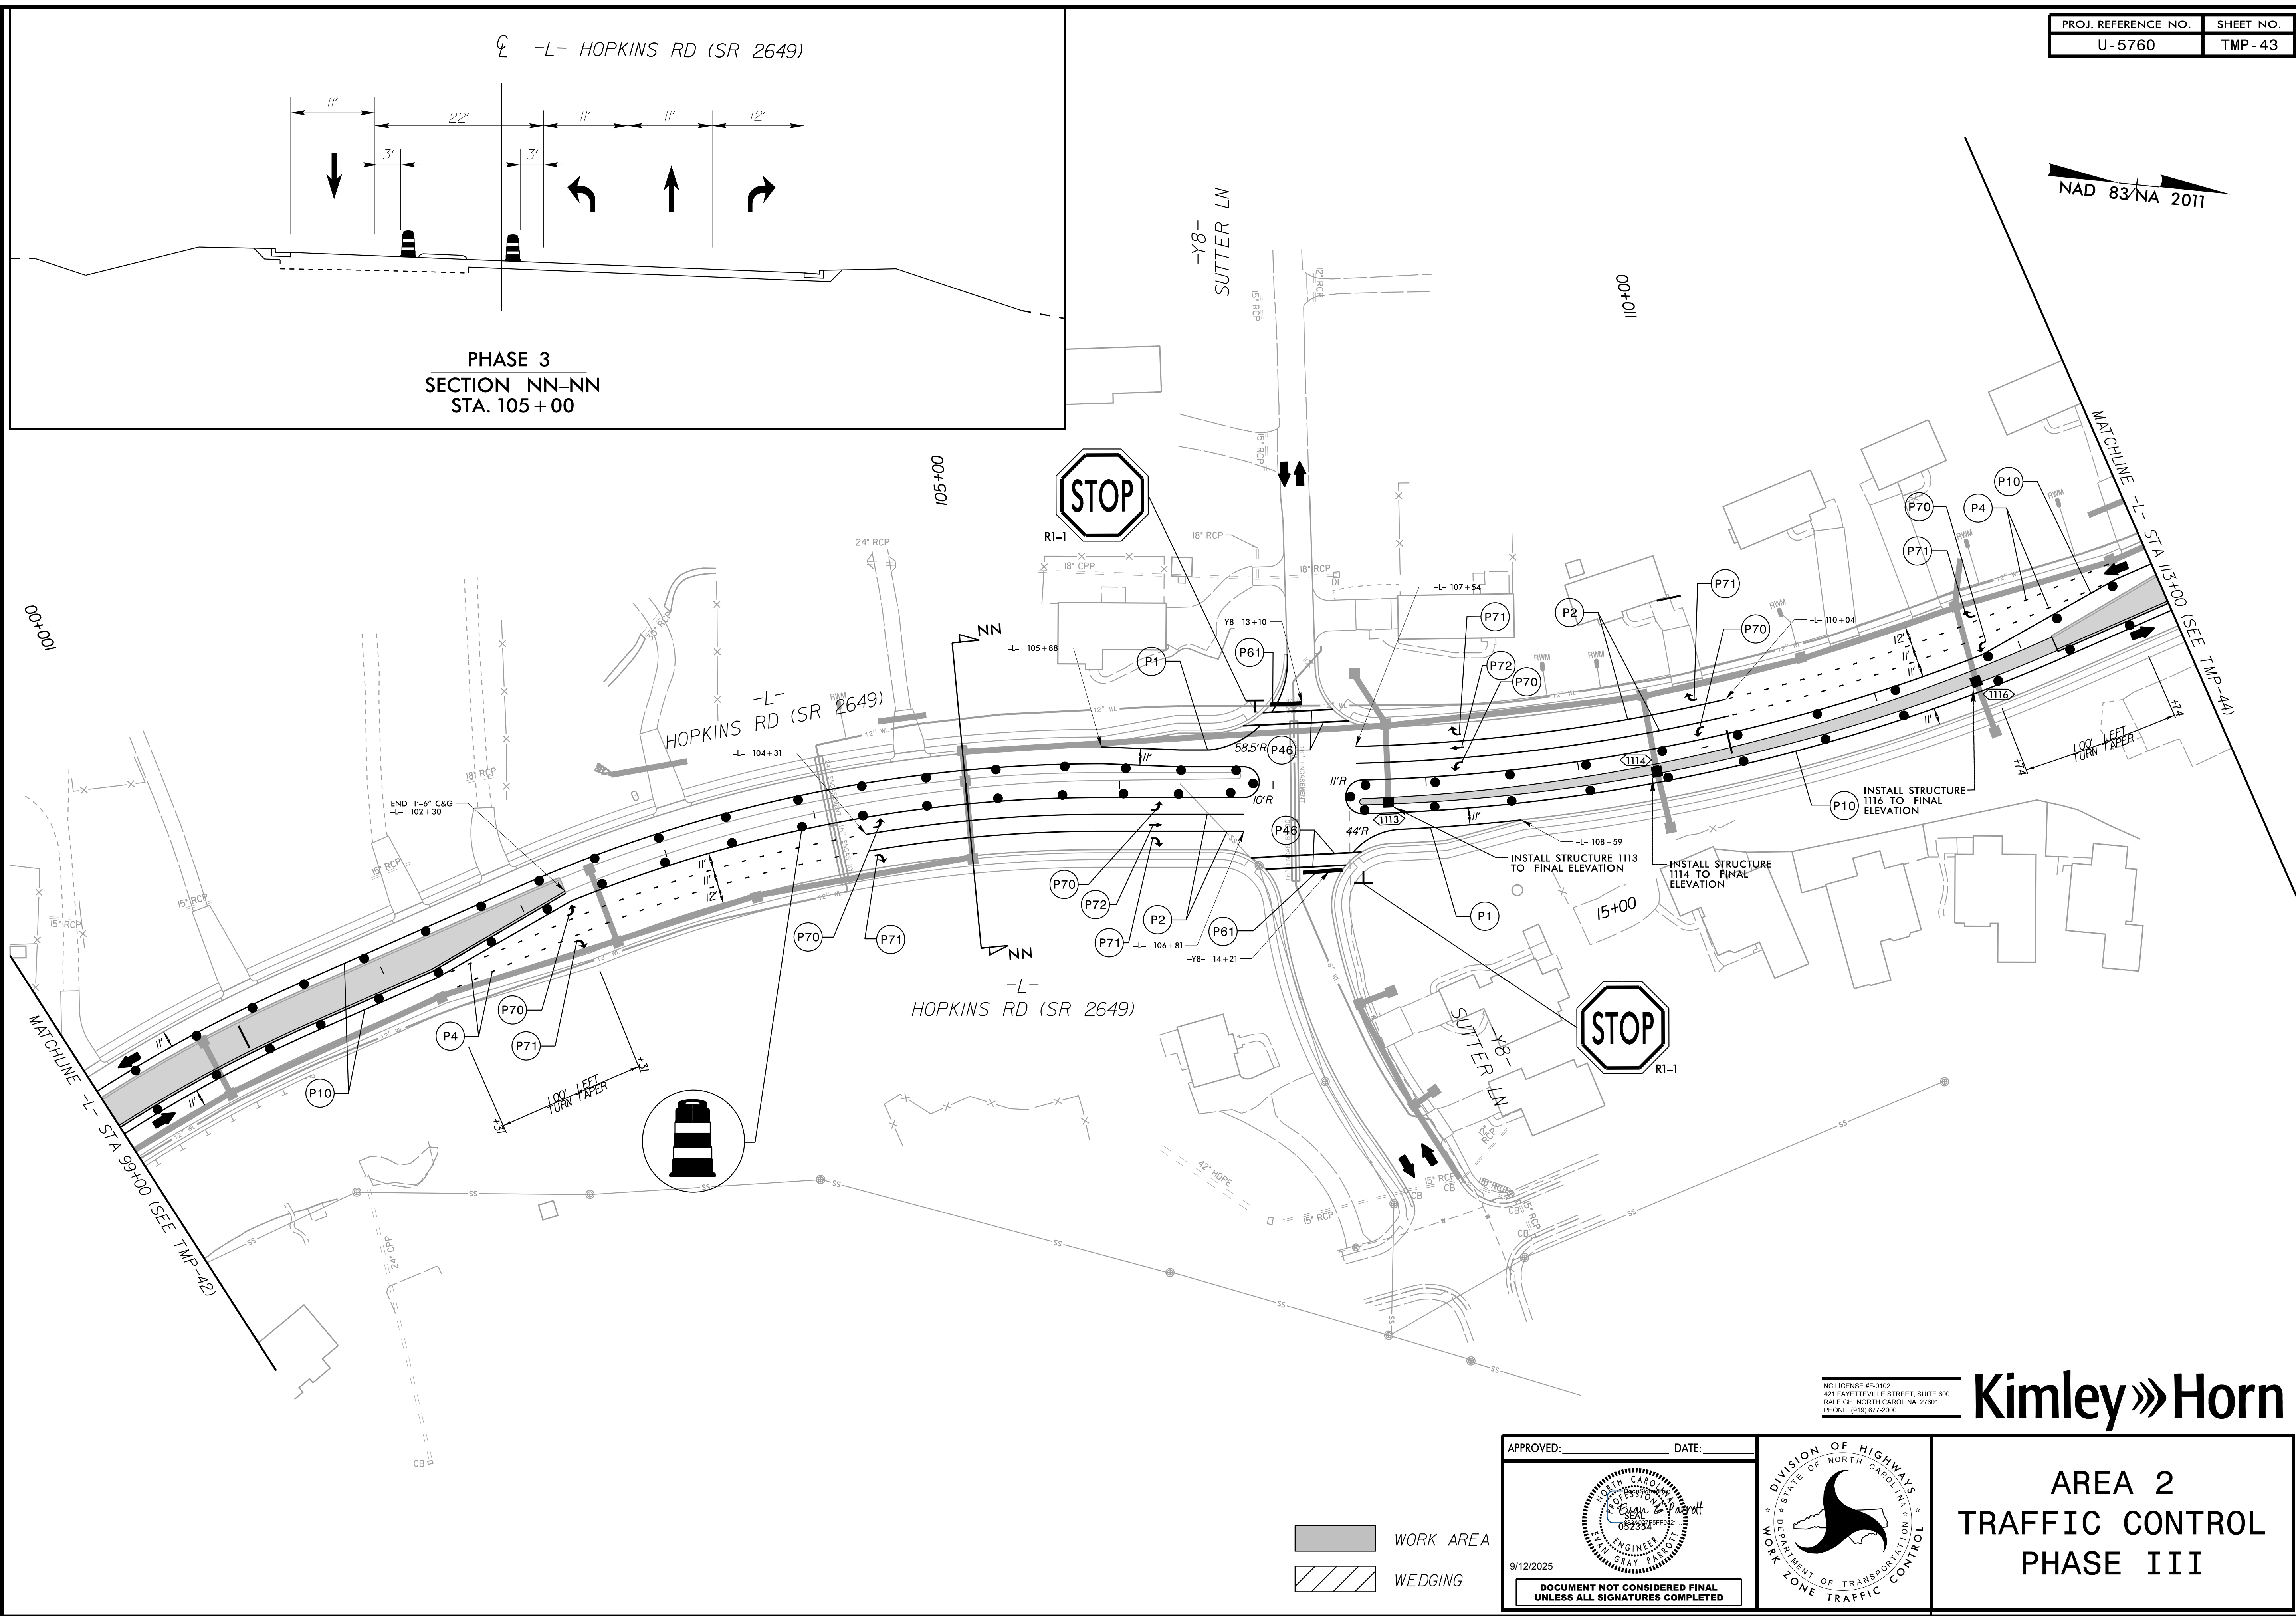

NAD 83/NA 2011

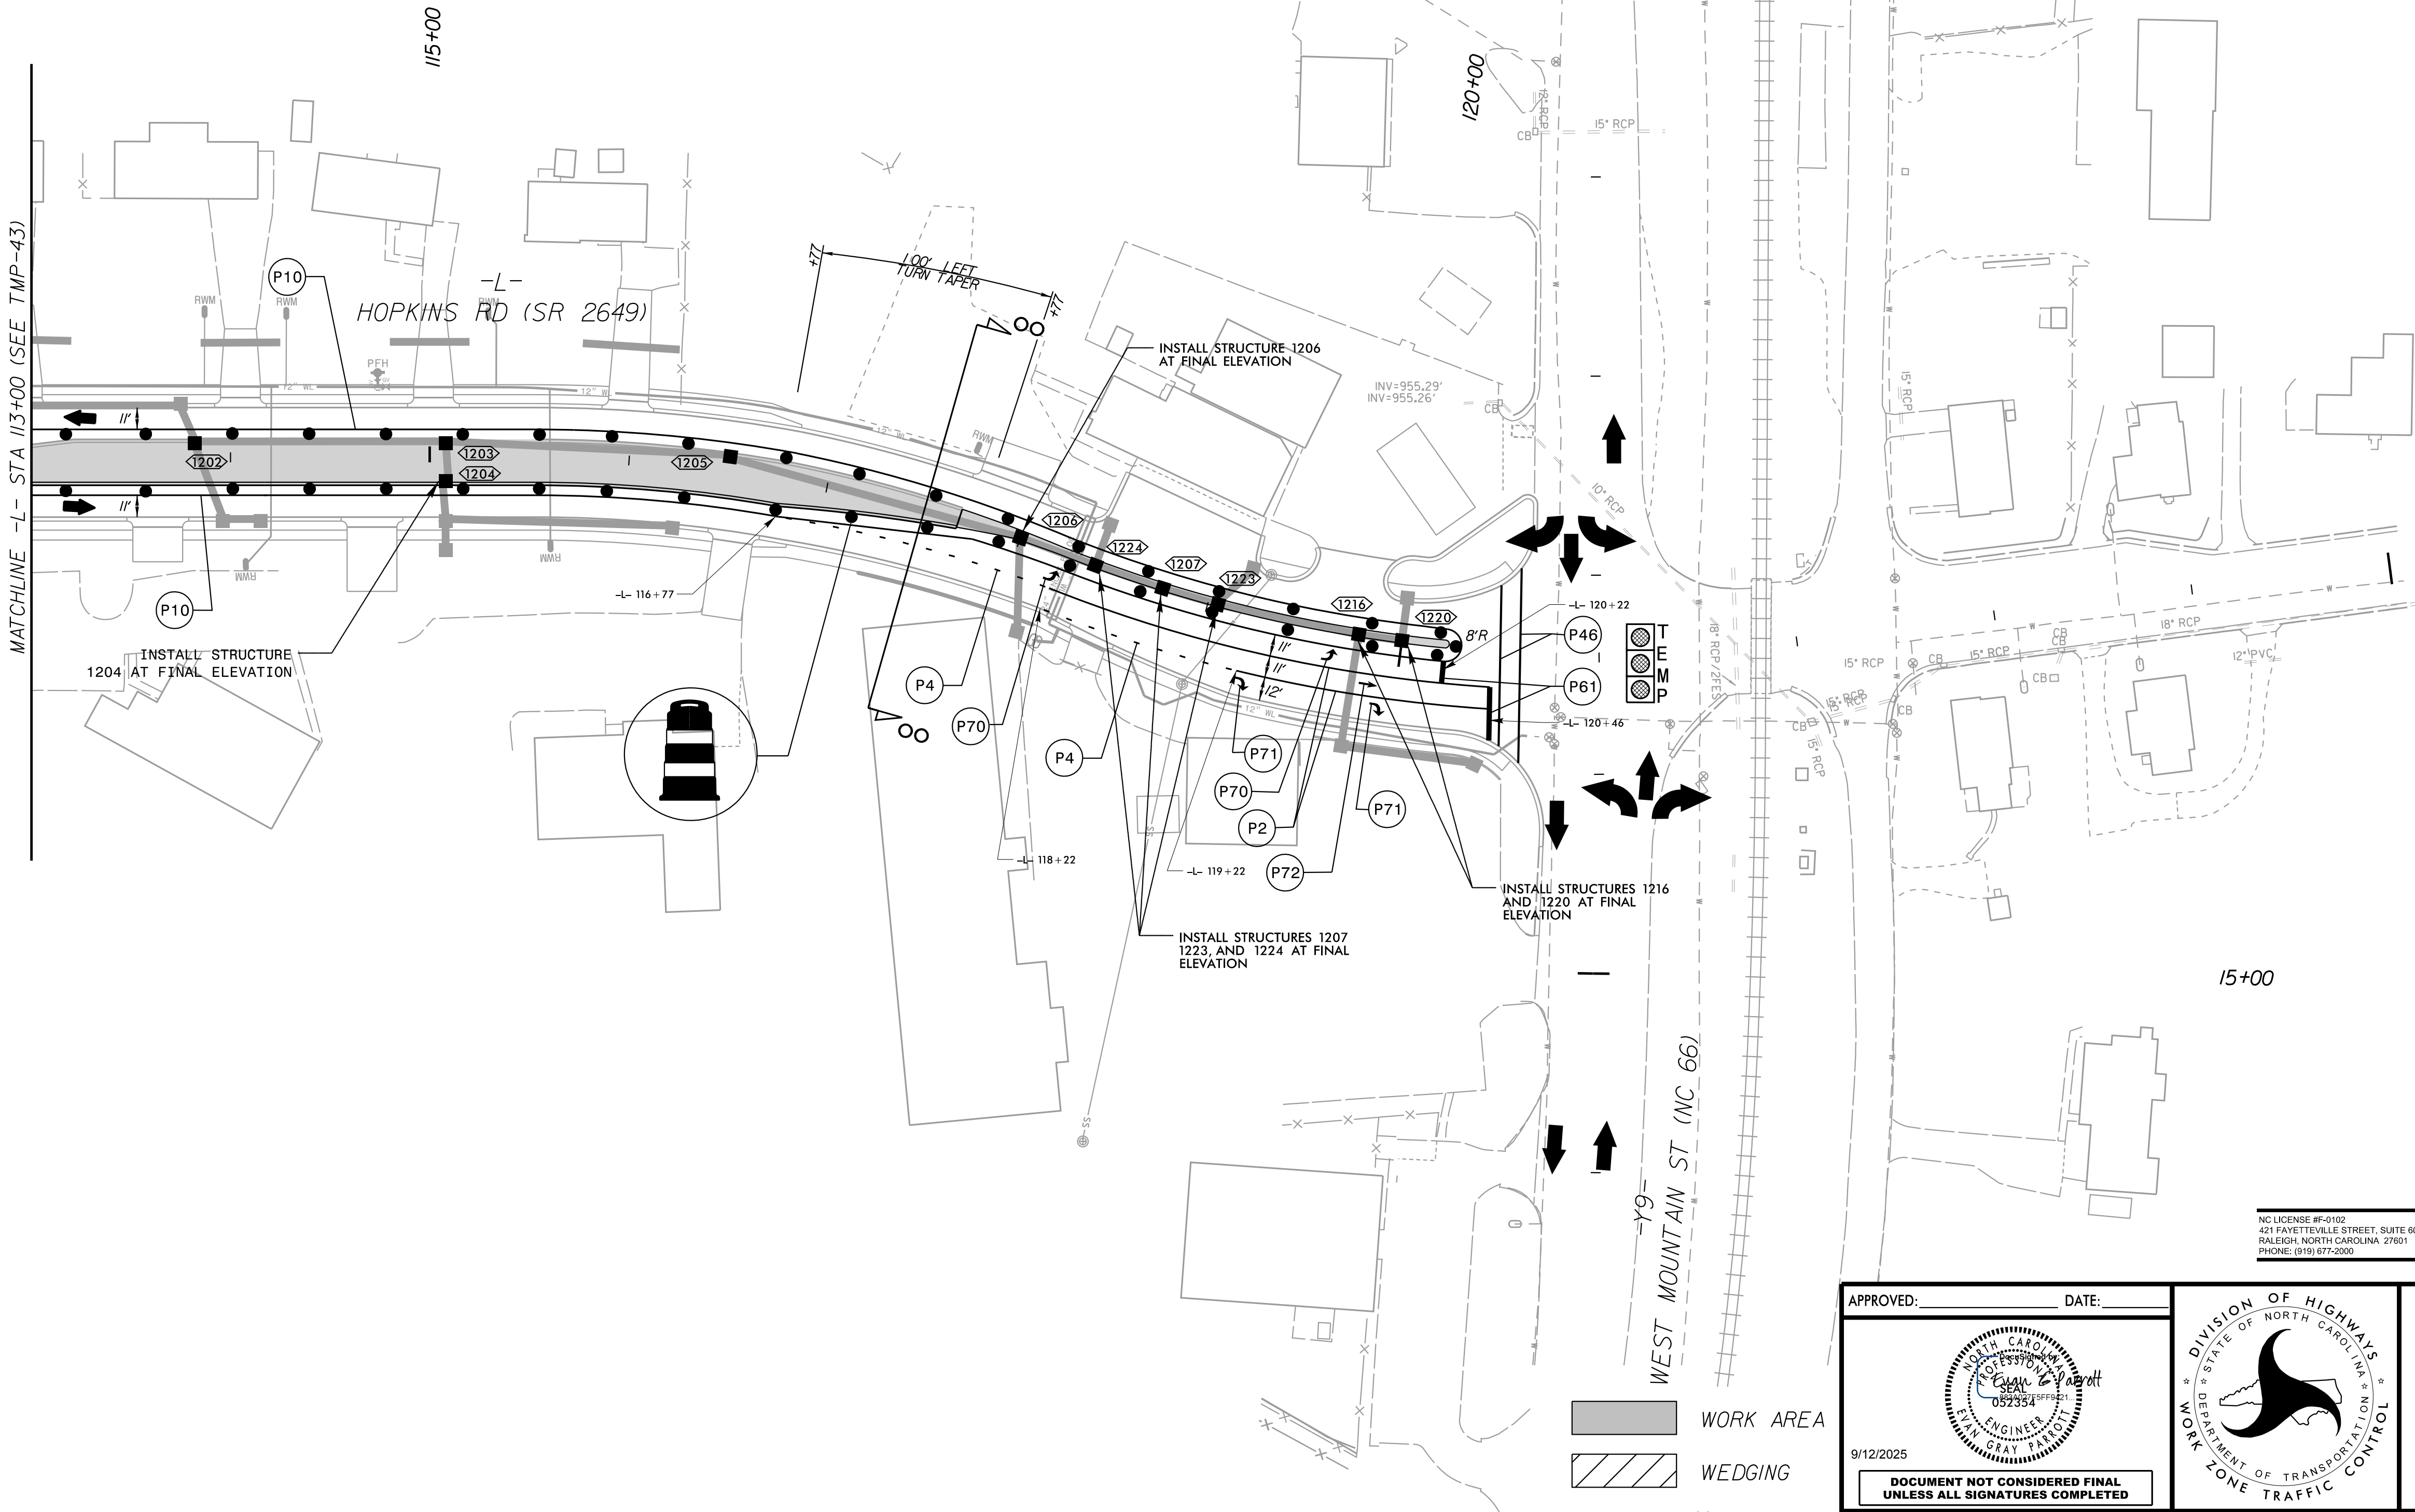

OLD HOLLOW RD (NC 66)

NC LICENSE #F-0102
421 FAYETTEVILLE STREET, SUITE 600
RALEIGH, NORTH CAROLINA 27601
PHONE: (919) 677-2000

Kimley»»Horn

AREA 2
TRAFFIC CONTROL
PHASE III

APPROVED: _____ DATE: _____

 *Evan Gray Barbee*


9/12/2025

**DOCUMENT NOT CONSIDERED FINAL
UNLESS ALL SIGNATURES COMPLETED**



K:\RAL_Roadway\01036312 - U-5760 Big Mill Farm Road\TrafficControl\TCP\Sheets\Phase 3\U5760_top_psm45.dgn

8/5/2025

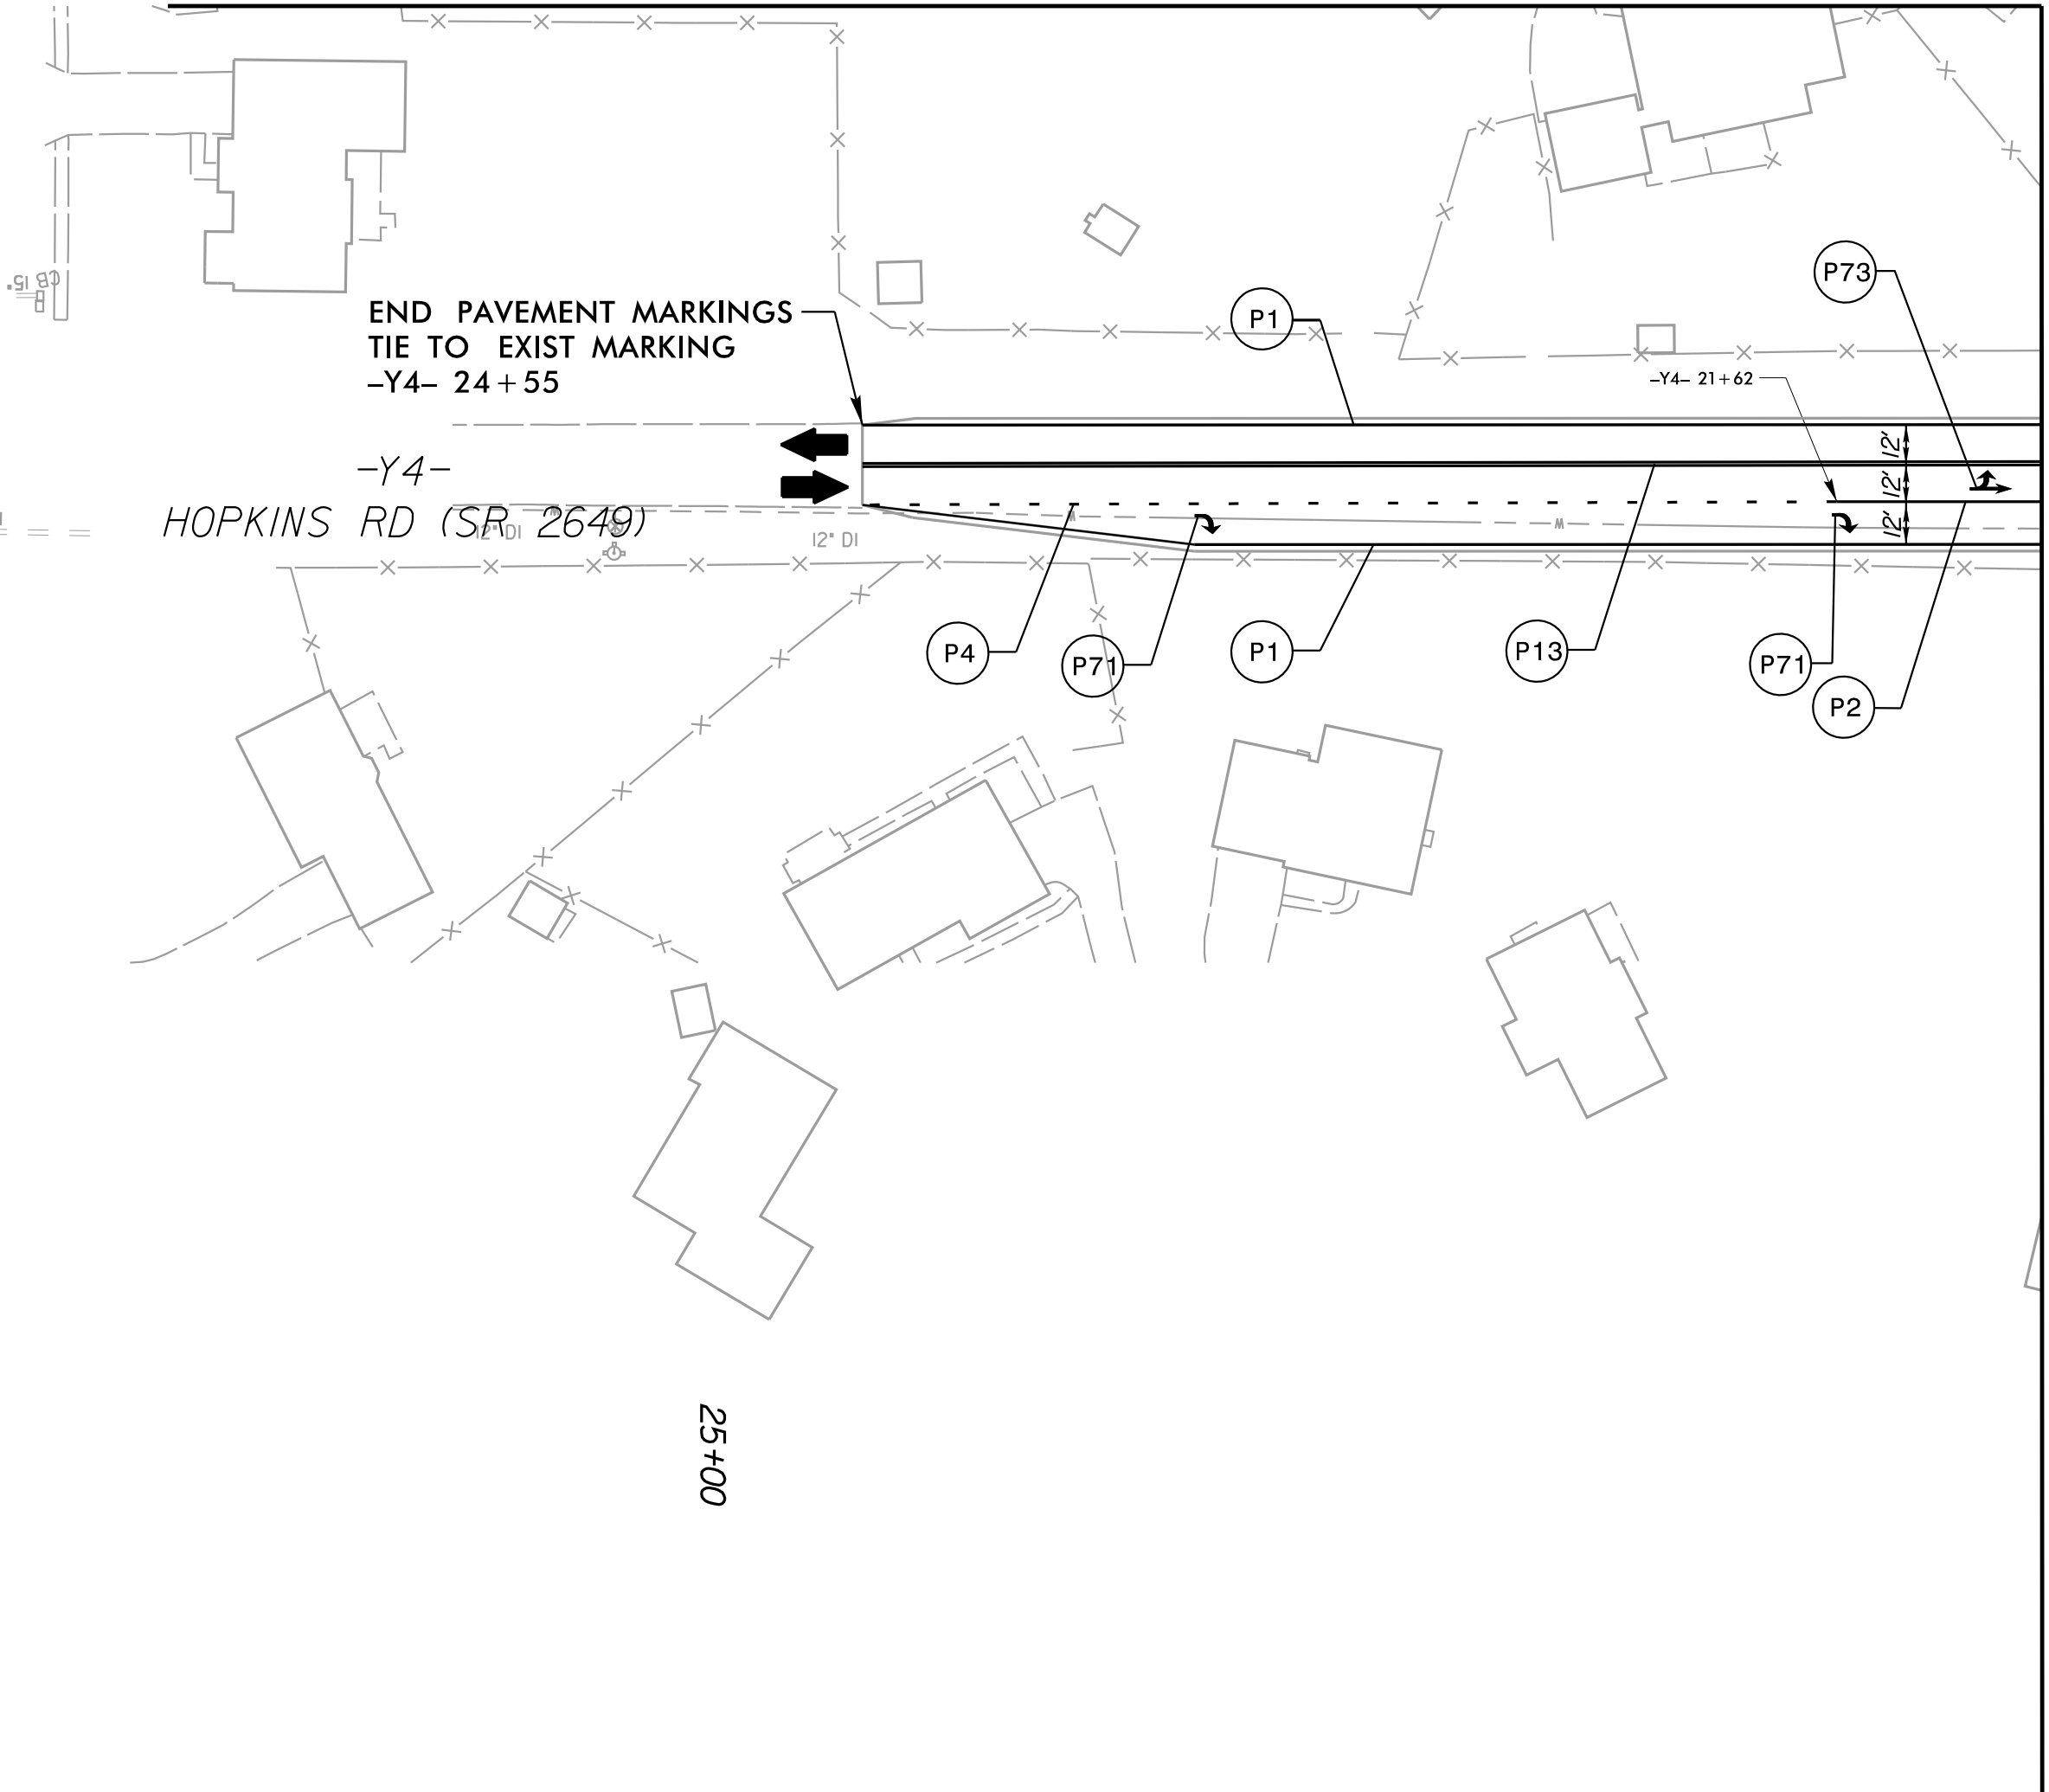

NAD 83/NA 2011


MATCHLINE -Y4- STA 21+00 (SEE TMP-40)

WORK AREA
WEDGING

APPROVED: DATE: 9/12/2025

Kimley-Horn
Professional Engineer
052353
NORTH CAROLINA
VIA GRAY PLOT

DOCUMENT NOT CONSIDERED FINAL
UNLESS ALL SIGNATURES COMPLETED

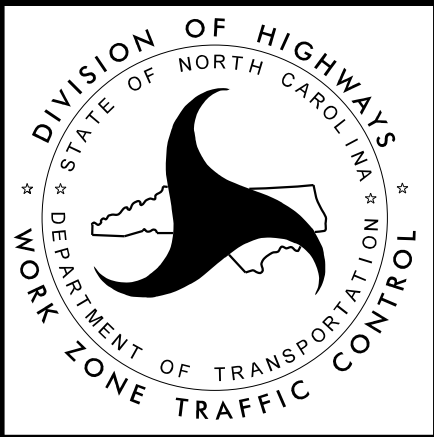


Kimley»Horn

AREA 2
TRAFFIC CONTROL
PHASE III

PROJ. REFERENCE NO.	SHEET NO.
U-5760	TMP-45

NAD 83/NA 2011

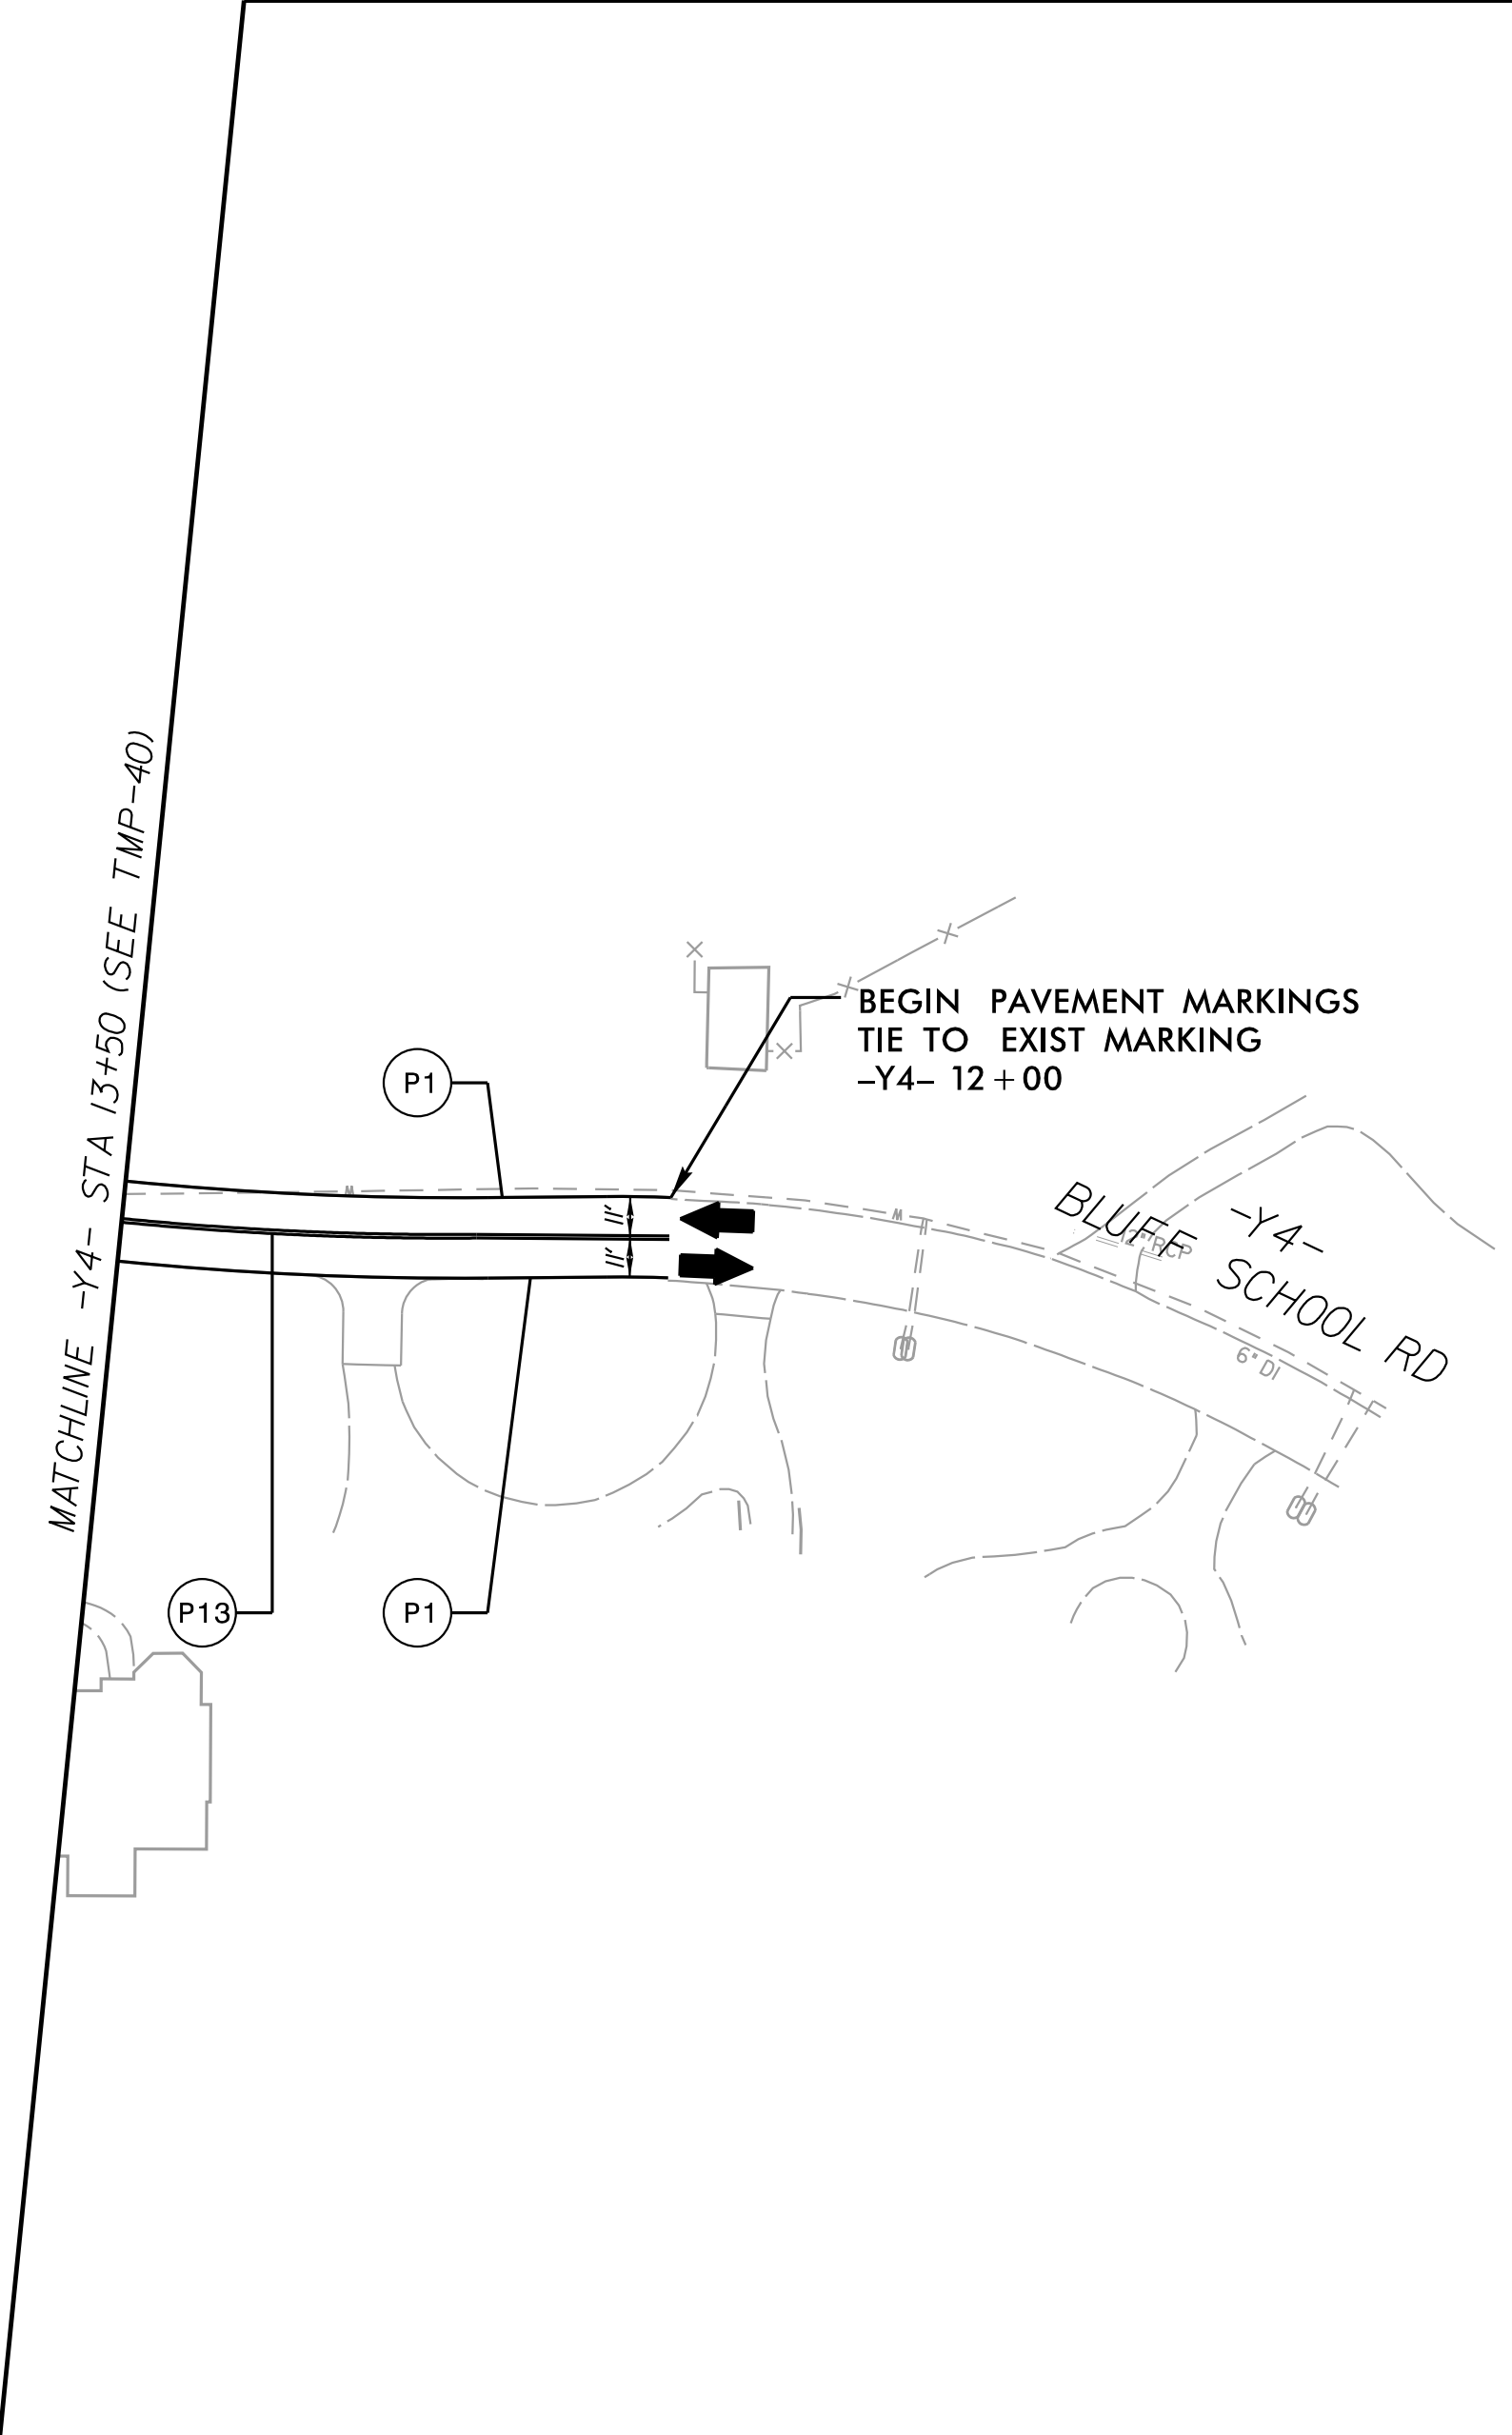

MATCHLINE -Y4- STA 13+50 (SEE TMP-40)

BEGIN PAVEMENT MARKINGS
TIE TO EXIST MARKING
-Y4- 12+00

APPROVED: _____	DATE: _____			SPECIAL SIGN DESIGNS
DOCUMENT NOT CONSIDERED FINAL UNLESS ALL SIGNATURES COMPLETED				

SPECIAL SIGN DESIGNS

APPROVED: _____	DATE: _____			SPECIAL SIGN DESIGNS
DOCUMENT NOT CONSIDERED FINAL UNLESS ALL SIGNATURES COMPLETED				

SIGN NUMBER: 104	BACKG COLOR: Fluorescent Orange	DESIGN BY: NER	CHECKED BY: JGP	Jul 09, 2025
TYPE: STATIONARY	COPY COLOR: Black	PROJECT ID: U-5760	LOCATION:	DIV: 9

QUANTITY: SEE PLANS	SYMBOL	X	Y	WID	HT

SIGN WIDTH: 3'-6"
HEIGHT: 2'-0"
TOTAL AREA: 7.0 Sq.Ft.

BORDER TYPE: INSET
RECESS: 0.38"
WIDTH: 0.63"
RADII: 1.5"

NO. Z BARS:
LENGTH:

MAT'L: 0.080" (2.0 mm) ALUMINUM

USE NOTES: 1,2

- Legend and border shall be direct applied black non-reflective sheeting.
- Background shall be NC GRADE B fluorescent orange retroreflective sheeting.

BORDER
R=1.5"
TH=0.63"
IN=0.38"

Panel Style: construction_guide.ssi
M.U.T.C.D.: 2009 Edition

Spacing Factor is 1 unless specified otherwise


LETTER POSITIONS

Letter spacings are to start of next letter																				Series/Size Text Length
T	I	M	B	E	R	W	O	O	D											C 2000 34.8
3.6	3.3	1.8	4.4	3.7	3.4	3.2	4.4	3.9	3.9	2.8	3.6									
T	R	L																		C 2000 9.5
16.3	3.3	3.7	2.6	16.3																

FILENAME: U5760_tcp_guidesign_design

NORTH CAROLINA D.O.T. SIGN DETAIL

 [illegible]

APPROVED: _____	DATE: _____			SPECIAL SIGN DESIGNS
DOCUMENT NOT CONSIDERED FINAL UNLESS ALL SIGNATURES COMPLETED				