


TIP PROJECT: R-5600

CONTRACT:

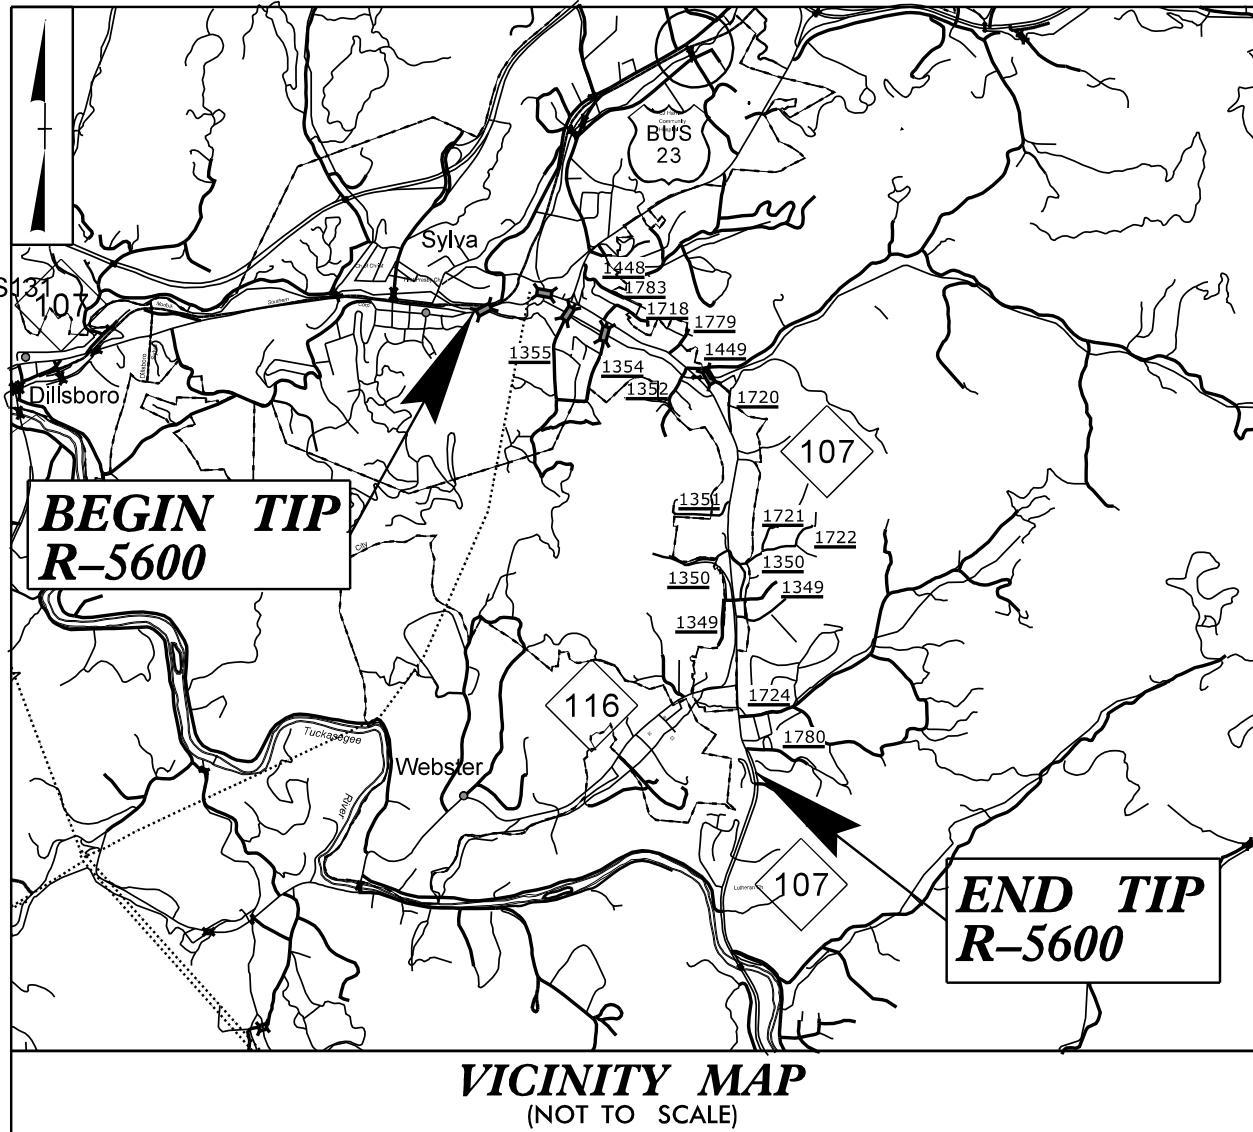

VICINITY MAP
(NOT TO SCALE)

STATE OF NORTH CAROLINA
DIVISION OF HIGHWAYS

UTILITY CONSTRUCTION PLANS
JACKSON COUNTY



LOCATION: SYLVA - N.C.107 FROM WEST OF U.S. 23 BUSINESS
(ASHEVILLE HIGHWAY) TO SOUTH OF N.C. 116
(WEBSTER ROAD) AND U.S. 23 BUSINESS FROM
SKYLAND DRIVE TO WEST OF MUNICIPAL DRIVE

TYPE OF WORK: WATER AND SEWER CONSTRUCTION


T.I.P. NO.	SHEET NO.
R-5600	UC-1

100% UTILITY CONST. PLANS

UTILITY CONST. PLANS
DATE: JULY 3, 2025

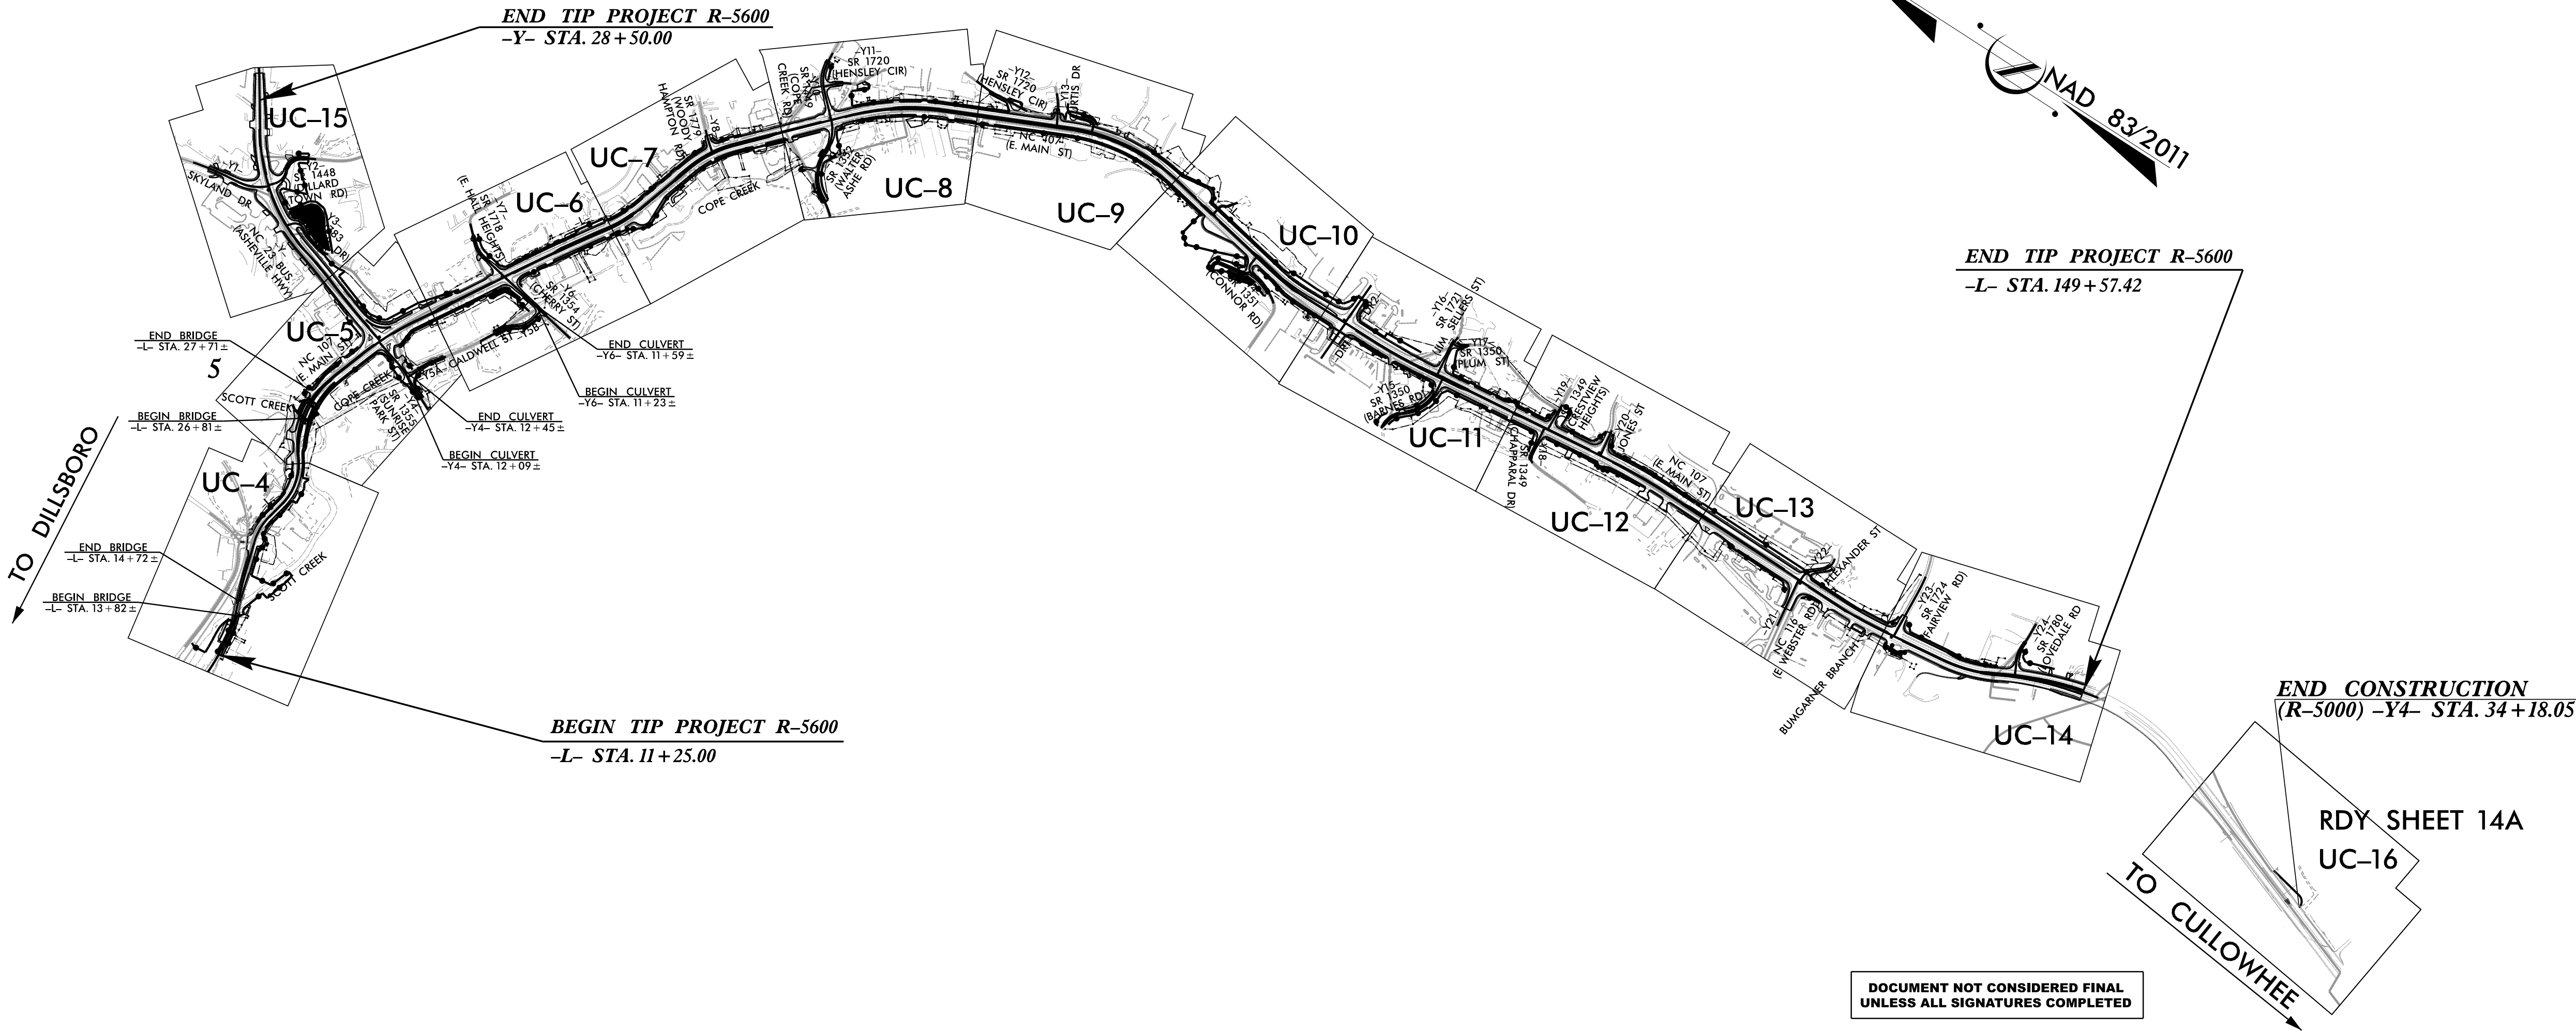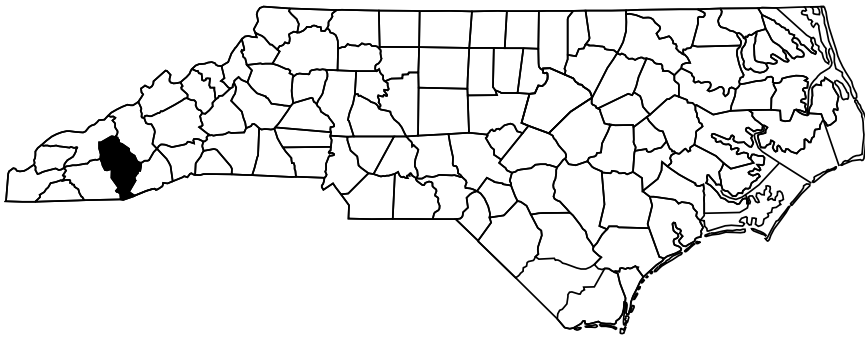

DOCUMENT NOT CONSIDERED FINAL
UNLESS ALL SIGNATURES COMPLETED

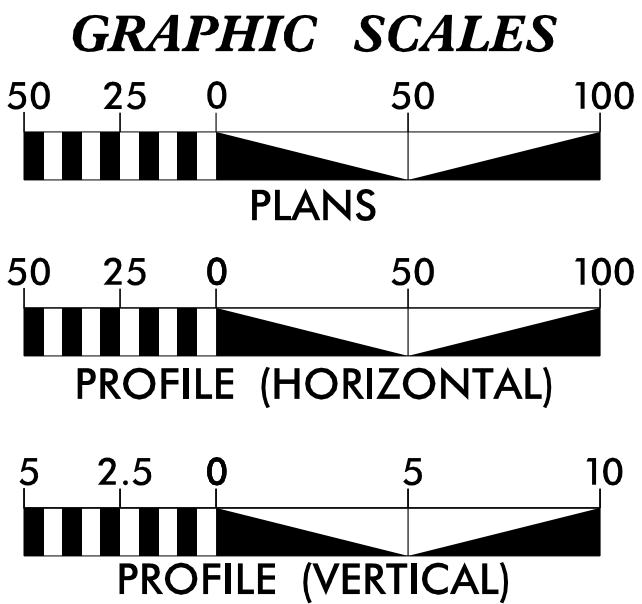

SHEET NO.	DESCRIPTION
UC-1	TITLE SHEET
UC-2	UTILITY SYMBOLOGY
UC-3	NOTES
UC-3A - UC-3E	DETAILS
UC-3F - UC-3H	SERVICES TABLE
UC-4 - UC-16	UTILITY PLANS & PROFILES

PUBLIC UTILITY OWNERS
ON PROJECT

(1) WATER & SEWER - TUCKASEIGEE WATER AND
SEWER AUTHORITY (TWSA)


PREPARED IN THE OFFICE OF:



SEAL:



Marie Peedin, P.E.	UTILITY PROJECT MANAGER
James Montgomery	PROJECT UTILITY COORDINATOR
Emily Morris, E.I.	PROJECT UTILITY DESIGNER

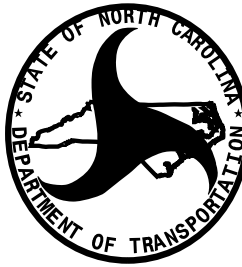

DIVISION OF HIGHWAYS
UTILITIES UNIT
1555 MAIL SERVICES CENTER
RALEIGH, NC 27699-1555
PHONE (919) 707-6690
FAX (919) 250-4151

Alireza Kouchehi, P.E. UTILITIES REGIONAL ENGINEER
Bob Golding DIVISION UTILITIES ENGINEER