

6-AUG-2025 13:31 \\p01ncdot\proj\01\Documents\NCDOT_TSM0\Signal Design Section\Division_05\05-1662\Signal Design\2024-07_HL-00081\TSH_sig_dsn_20250715.dgn

Project: HL-00081


CONTRACT: C205038

Project No.	Sheet No.
HL-00081	Sig. 1.0


STATE OF NORTH CAROLINA
DIVISION OF HIGHWAYS

WAKE COUNTY

LOCATION: SR 1006 (OLD STAGE ROAD) FROM
SR 2736 (ROCK SERVICE STATION ROAD) TO
SR 3884 (ROLLING MEADOWS DRIVE)
TYPE OF WORK: SIGNALS AND SIGNAL COMMUNICATIONS

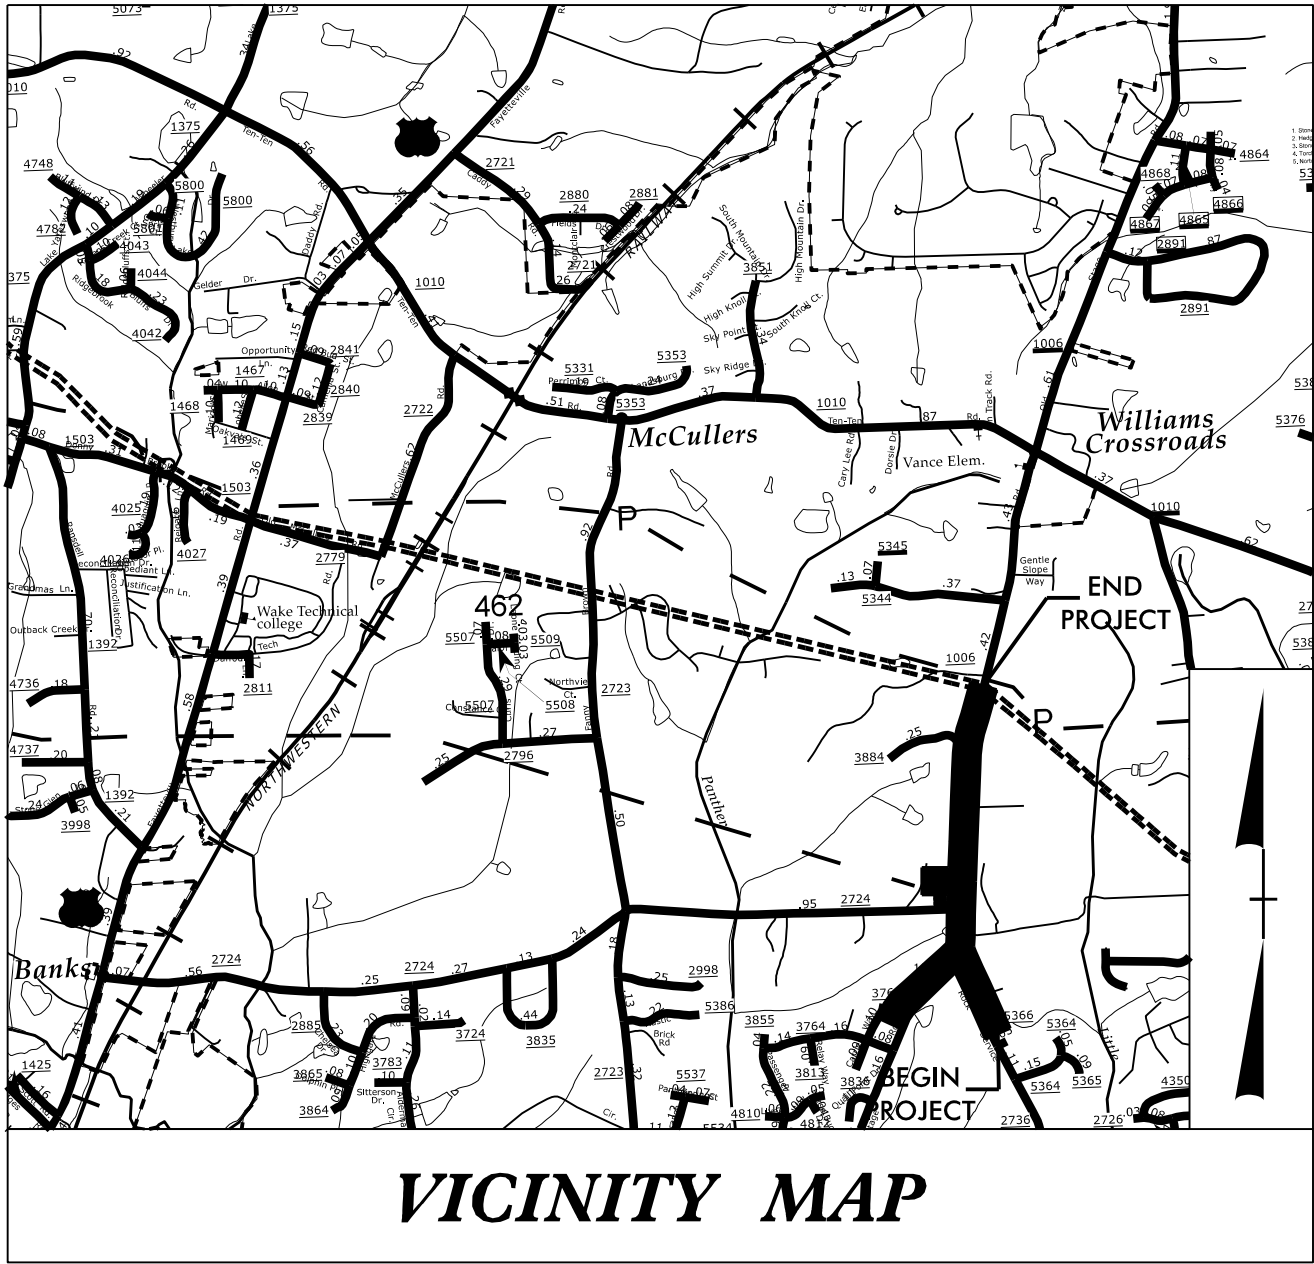

VICINITY MAP

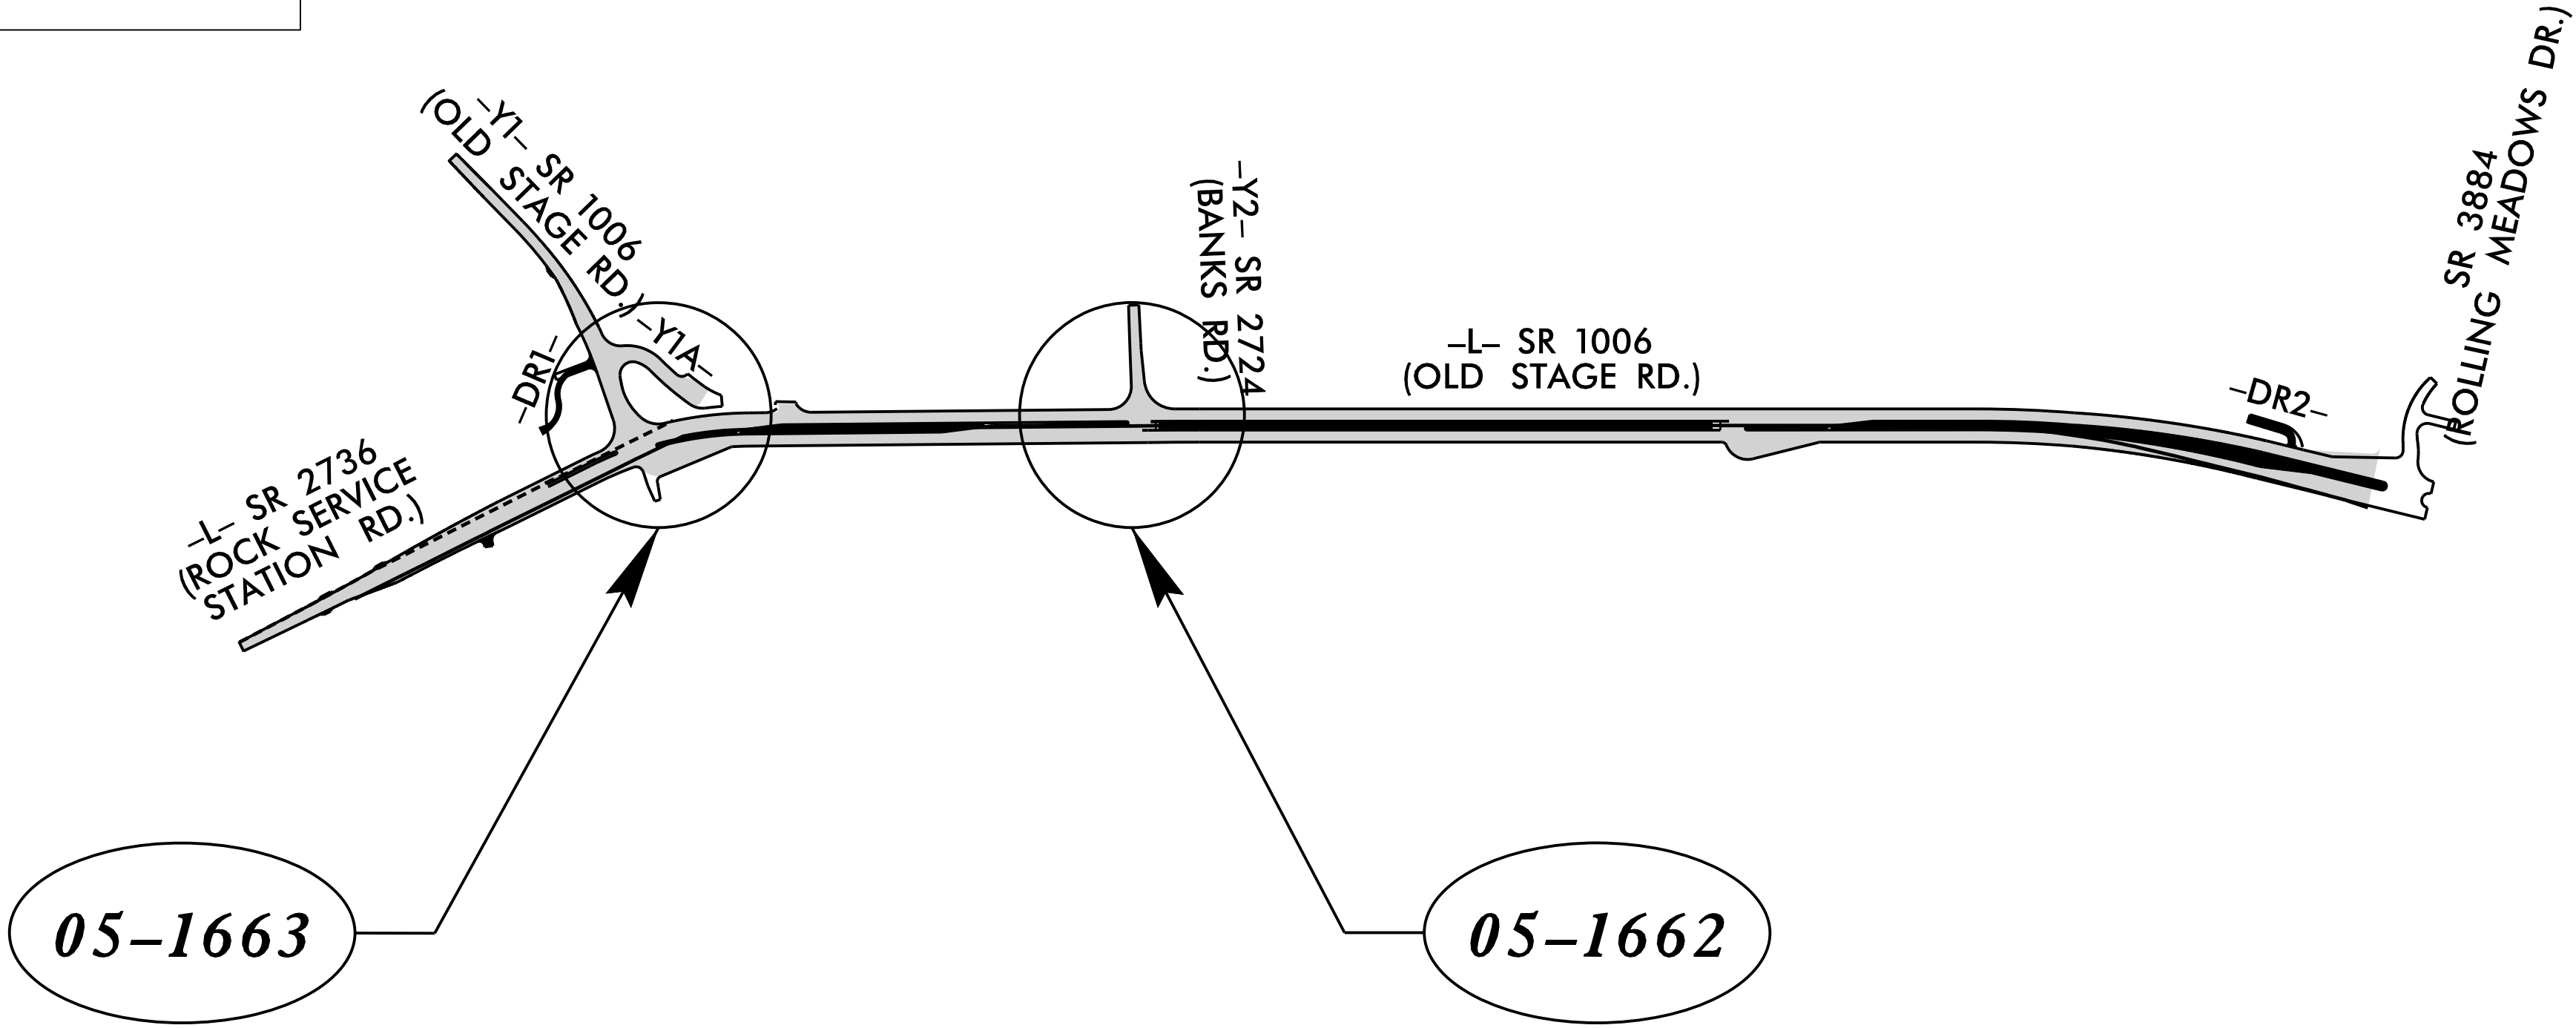

Refer to "Roadway Standard Drawings
NCDOT" dated January 2024 and
"Standard Specifications for Roads
and Structures" dated January 2024.

Index of Plans
Location/Description

Sheet #	Reference #
Sig. 1.0	N/A
Sig. 2.0 - 4.3	05-1663
Sig. 5.0 - 5.4	05-1662
MIA-M9	-----
SCP 1 - 8	-----

Title Sheet
SR 1006 (Old-Stage Road) at SR 2736 (Rock Service Station Road) And Back Field Road
SR 1006 (Old-Stage Road) at SR 2724 (Banks Road)
Standard Metal Pole Sheets
Signal Communication Plans

TRANSPORTATION SYSTEMS
MANAGEMENT & OPERATIONS UNIT

Contacts:

Robert J. Ziemba, PE, CPM - Central Region Signals Engineer
Ryan W. Hough, PE - Signal Equipment Design Engineer
Gregory A. Green - Signal Communication Project Engineer

Prepared In the Office of:
DIVISION OF HIGHWAYS
TRANSPORTATION MOBILITY & SAFETY DIVISION

